


SITE PLAN

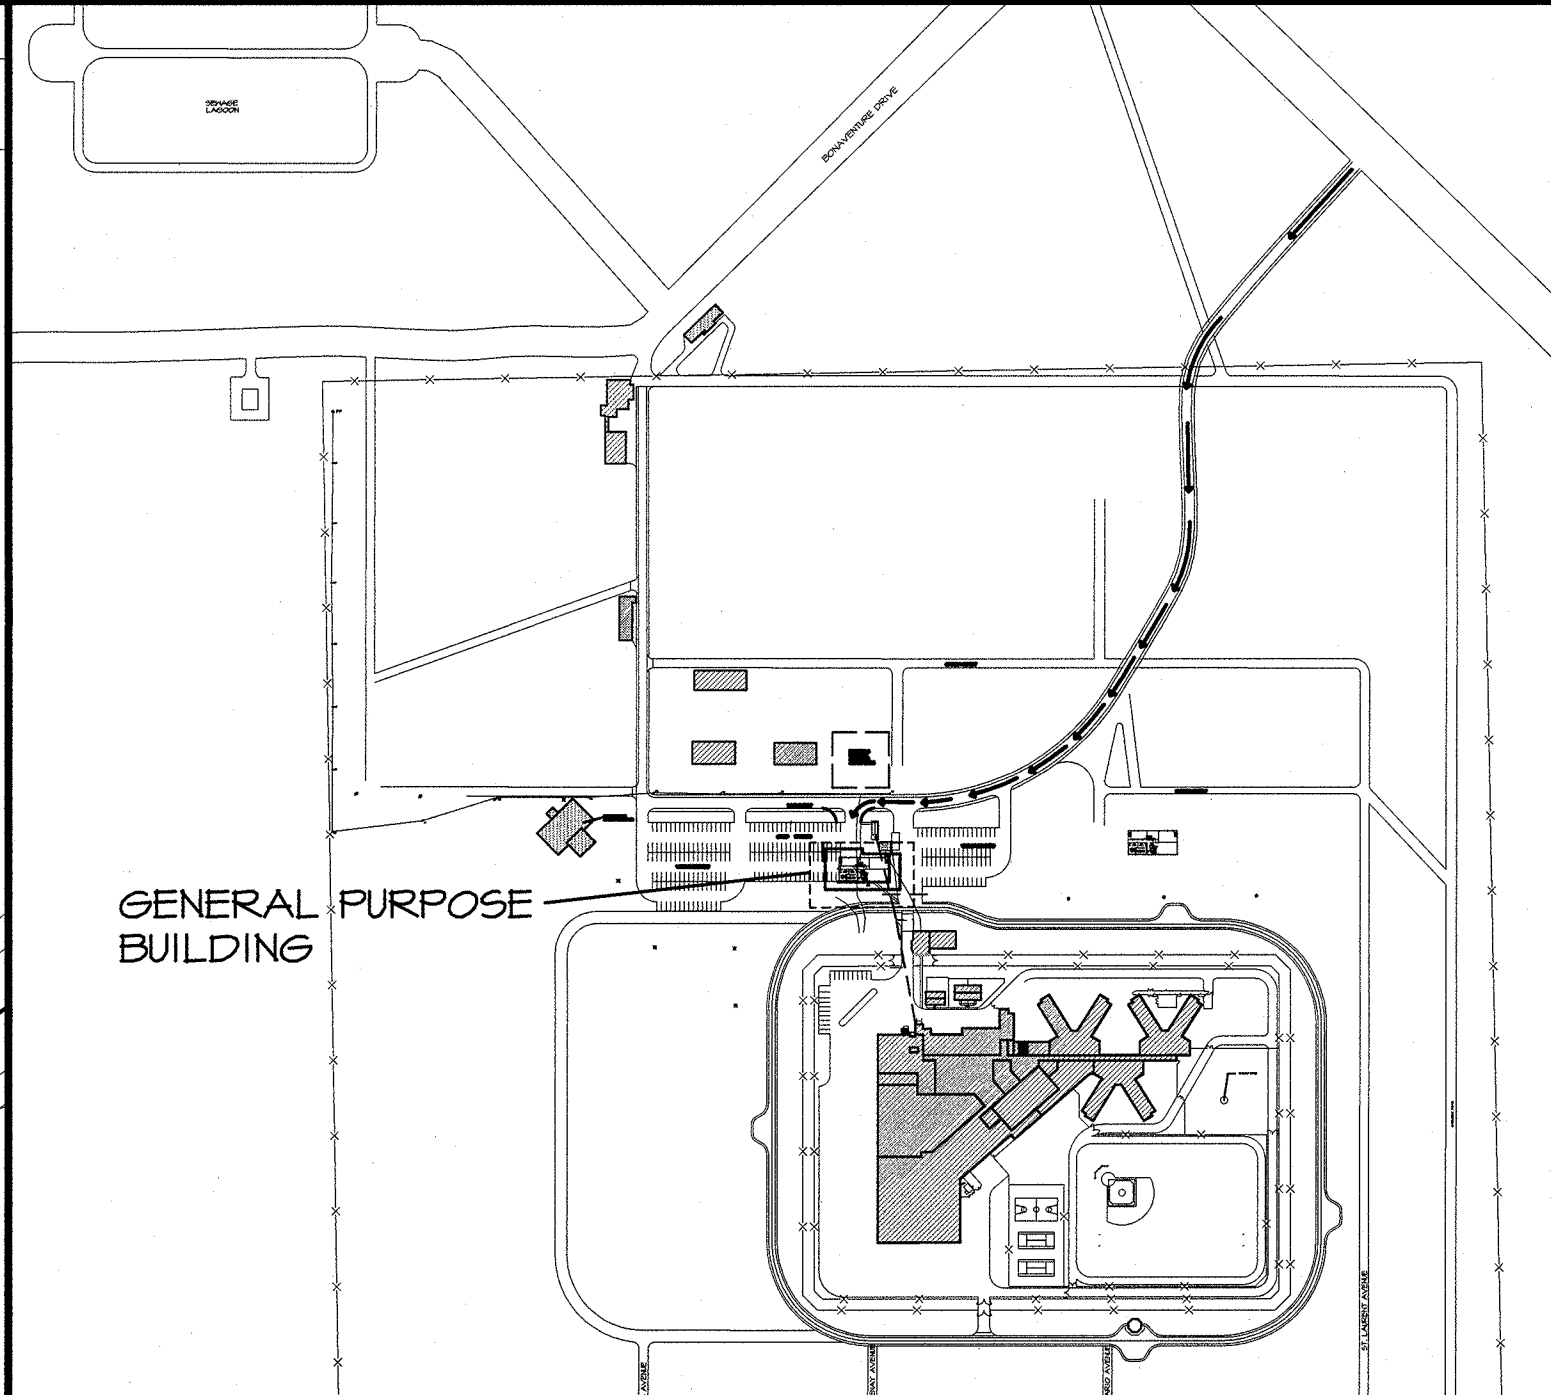

LOCATION PLAN

- KEYNOTE LEGEND:**
- (A) -BUILDING ENERGY MANAGEMENT SYSTEM, CONNECT TO RESERVOIR.
 - (B) -PROVIDE 1.5m X 1.5m CONCRETE PAD AT ALL PERSONNEL DOORS, PROVIDE 1.5m X 60m CONCRETE SIDEWALK. CONFIRM LAYOUT WITH DEPARTMENTAL REPRESENTATIVE.
 - (C) -TEMPORARY FENCE AROUND SITE AND LAYDOWN AREA PER SPECIFICATIONS.
 - (D) -TIE INTO EXISTING WATER SERVICE
 - (E) -TIE INTO EXISTING FIRE SERVICE
 - (F) -TIE INTO EXISTING SEWER SERVICE
 - (G) -THE PROPOSED SITE AREA IS CURRENTLY SERVICED BY SLOPING GRADE TOWARDS DRAINAGE DITCHES. PROPONENT TO ADDRESS DRAINAGE ACCORDINGLY.
 - (H) -ELECTRICAL HOOK UP, PERMANENT AND OR TEMPORARY TO OVERHEAD LINE.
 - (I) -COMMUNICATION, TIE INTO EXISTING VOICE ROOM BIH AT PRINCIPAL ENTRANCE. DATA (IT) OFFICE ROOM A40B AT MAIN BUILDING.
 - (J) -PROPANE LINE TO BE DIVERTED OR RELOCATED ACCORDINGLY.
 - (K) -FIRE ALARM TO PRINCIPAL ENTRANCE.
 - (L) -SECURITY CONDUIT FROM G.O. LAN ROOM TO PRINCIPAL ENTRANCE BUILDING.
 - (M) -TURNAROUND TO BE PROVIDED DURING EXCAVATION OF PIDS ROAD.
 - (N) PA SYSTEM TO MAIN BUILDING AT MCCP.
 - (O) CONTRACTOR TO PROVIDE TEMPORARY GRAVEL WALKWAY FOR STAFF DURING CONSTRUCTION.
- NOTES:**
- PAVING TO BE PROVIDED BY CONTRACTOR.
 - PROPONENT TO ADDRESS SEEDING AND SODDING.
 - HEATING SOURCE TO BE GEOTHERMAL.

KEYNOTE LEGEND

0		
revisions		date
project	GENERAL PURPOSE BUILDING OUTSIDE ATLANTIC INSTITUTION RENOUS, NB	
drawing		dessin
LOCATION PLAN		
designed	PWGSC	conçu
drawn	PWGSC	dessiné
date	APRIL 5, 2012	
approved		approuvé
date		
Tender		Soumission
PWGSC Project Manager	Administrateur de projets TPWSC	
project number	R.043958.001	no. du projet
drawing no.	G.O.	no. du dessin