


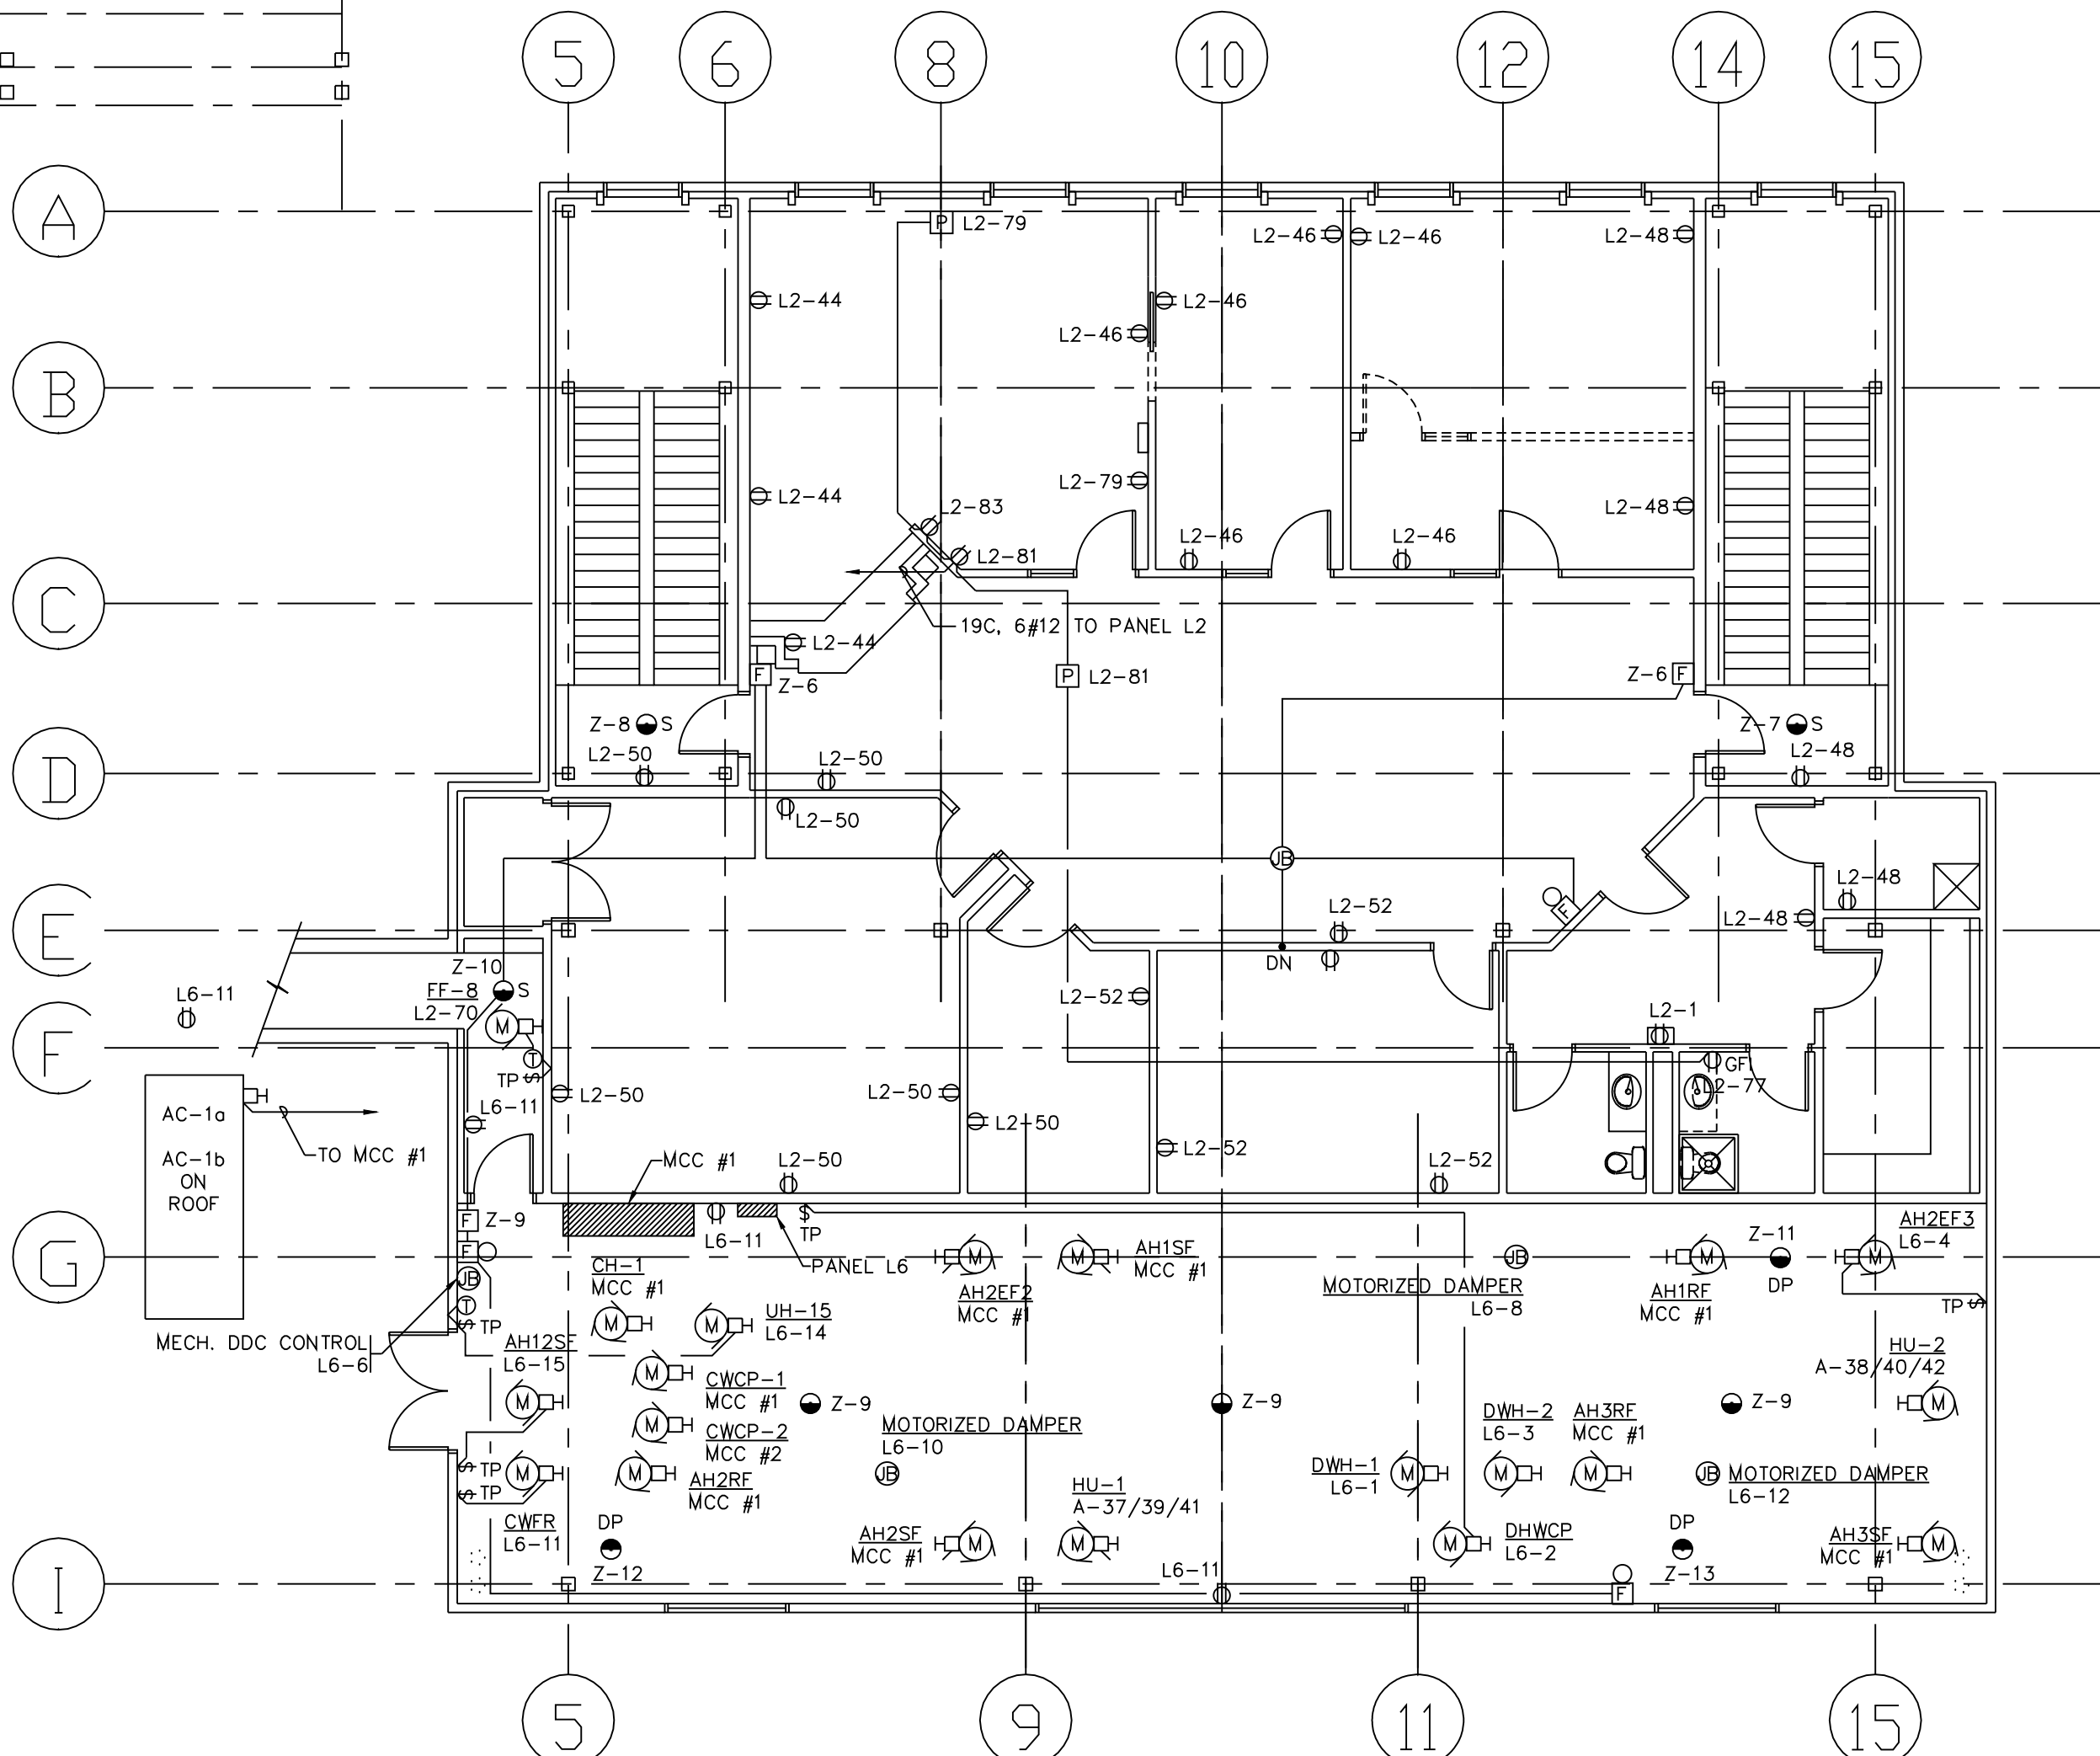

MAIN FLOOR PLAN  
SCALE 1:100



UPPER FLOOR PLAN  
SCALE 1:100




National  
Défense



Canada

Headquarters  
Quartier général

LOCATION

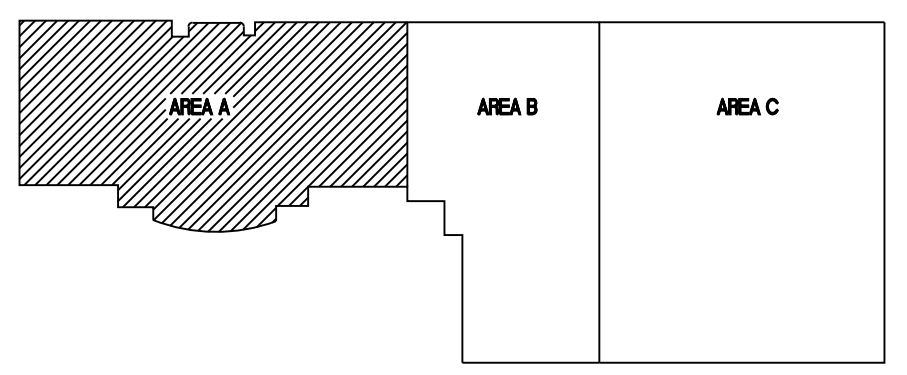

ENGINEER OF RECORD  
M. E. SHEWCHUK


PERMIT TO PRACTICE  
CHERITON ENGINEERING

PERMIT NUMBER: P 223

DATED 02/21/96

DATED 02/21/96

NO.	DATE	REVISION	REVISION	APPR.



Cheriton  
Engineering Inc.

SCALE - ÉCHELLE  
1:100

PROJECT - PROJET  
CFB EDMONTON, ALBERTA

RELOCATION OF 1 FIELD AMBULANCE

TRADE - MÉTIER	DATE
ELECTRICAL	1996-02

SUBJECT - SUJET

FLOOR PLAN AREA 'A'  
POWER AND FIRE ALARM

PRODUCTION	CONCURRENCE - ASSENTIMENT
DESIGNED ÉTUDE MES	DES OFF AGENT CONCEPT
DRAWN DESSINE NS	SECT HD CHEF SECT
CHECKED VÉRIFIE MES	DES MGR GEST CONCEPT
COORDINATION	REVIEWED - REVU

DWG NO. - DESSIN No.  
H - N2 - 0501/1-509

Canada