

| | | |
|----------|----------------|------------|
| 04 | | |
| 03 | ISSUED FOR BID | 2013.05.17 |
| 02 | ISSUED FOR BID | 2013.04.12 |
| 01 | FOR REVIEW | 2013.03.01 |
| revision | | date |

Do not scale drawings.
Verify all dimensions and conditions on site and immediately
notify the Departmental Representative of all discrepancies.




project title
titre du projet
Rooftop Chiller Enclosure
Government of Canada Building
11 Station Street
Belleville, Ontario

drawing title
titre du dessin

WALL SECTIONS

| | |
|--------------------------------|---------------------------------------|
| drawn by dessiné par | SA |
| designed by conçue par | RN |
| approved by approuvé par | JA |
| bid offre | IA |
| project date date du projet | 2012-06-08 |
| project no. no. du projet | DIALOG NO. 09769T0100 R.049400.003 |
| drawing no. dessine no. | A4.01 |

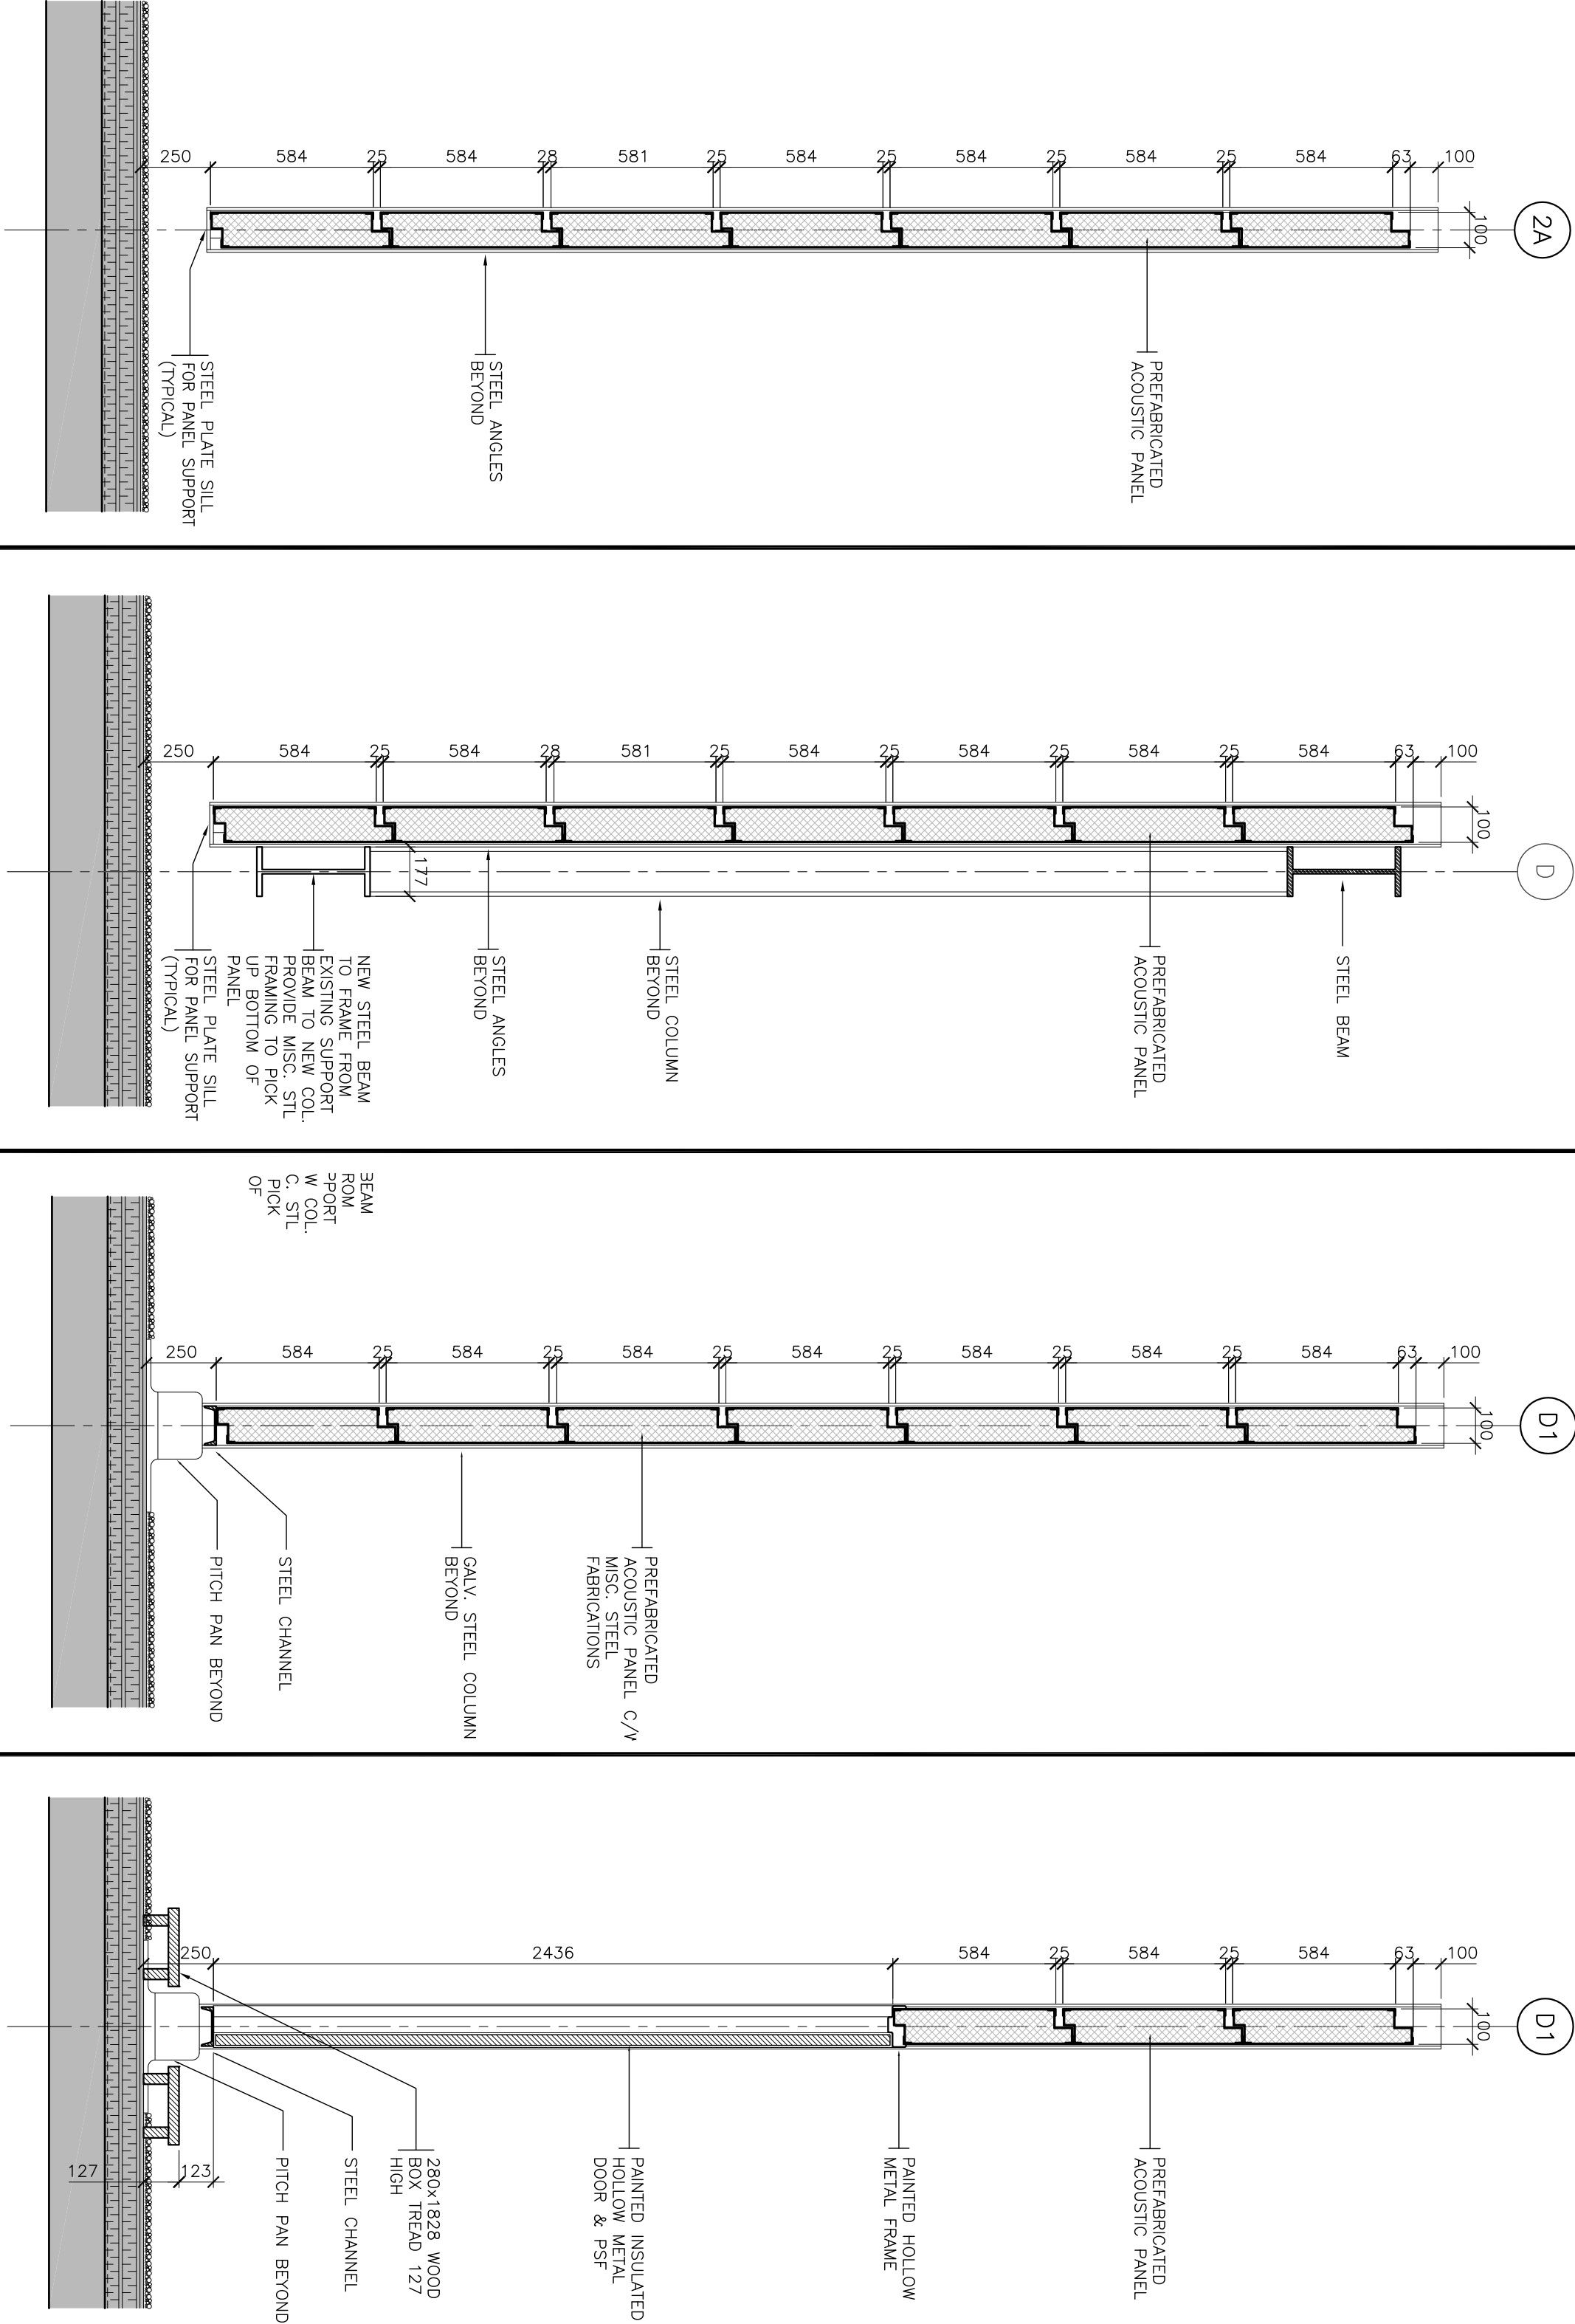

4 WALL SECTION
A2.01/A4.01 SCALE: 1:20

3 WALL SECTION
A2.01/A4.01 SCALE: 1:20

2 WALL SECTION
A2.01/A4.01 SCALE: 1:20

1 WALL SECTION
A2.01/A4.01 SCALE: 1:20