

AS BUILT	970110
ISSUED FOR PACKAGE 2 TENDER	940520
ISSUED FOR TENDER	940408
ISSUED FOR 90% REVIEW	940325
ISSUED FOR 30% DESIGN REPORT	940318

- NOTES:
- FOR GENERAL NOTES, LEGEND AND KEY PLAN SEE DWG. C-1.
 - ALL DIMENSIONS SHOWN ARE IN METRES.
 - FOR INSTALLATION AND MATERIALS SPECIFICATIONS SEE DWG. C-14.

SCALE: 1:250

LEGEND
ABANDONED HEATING PIPE /

revisions	date
-----------	------

A C	A detail no. no. du detail	A B C	B location drawing no. sur dessin no.
			C drawing no. dessin no.

project projet

MATSQUI COMPLEX
HEATING SYSTEM
UPGRADE

drawing dessin

DETAILED
PIPING LAYOUT
CENTRAL HEATING PLAN
SHEET 2 of 3

designed H. DOMBROWSKY conçu

date 940209

drawn J. COX/C. YEUNG dessiné

date 940209

reviewed M. CHAPMAN examiné

date 940411

approved S. FLECK/C.T. LUMB approuvé


date 940411

Tender STUART LESLIE Soumission

PWC Project Manager

project number 761637 no. du projet

drawing no. C-9 no. du dessin

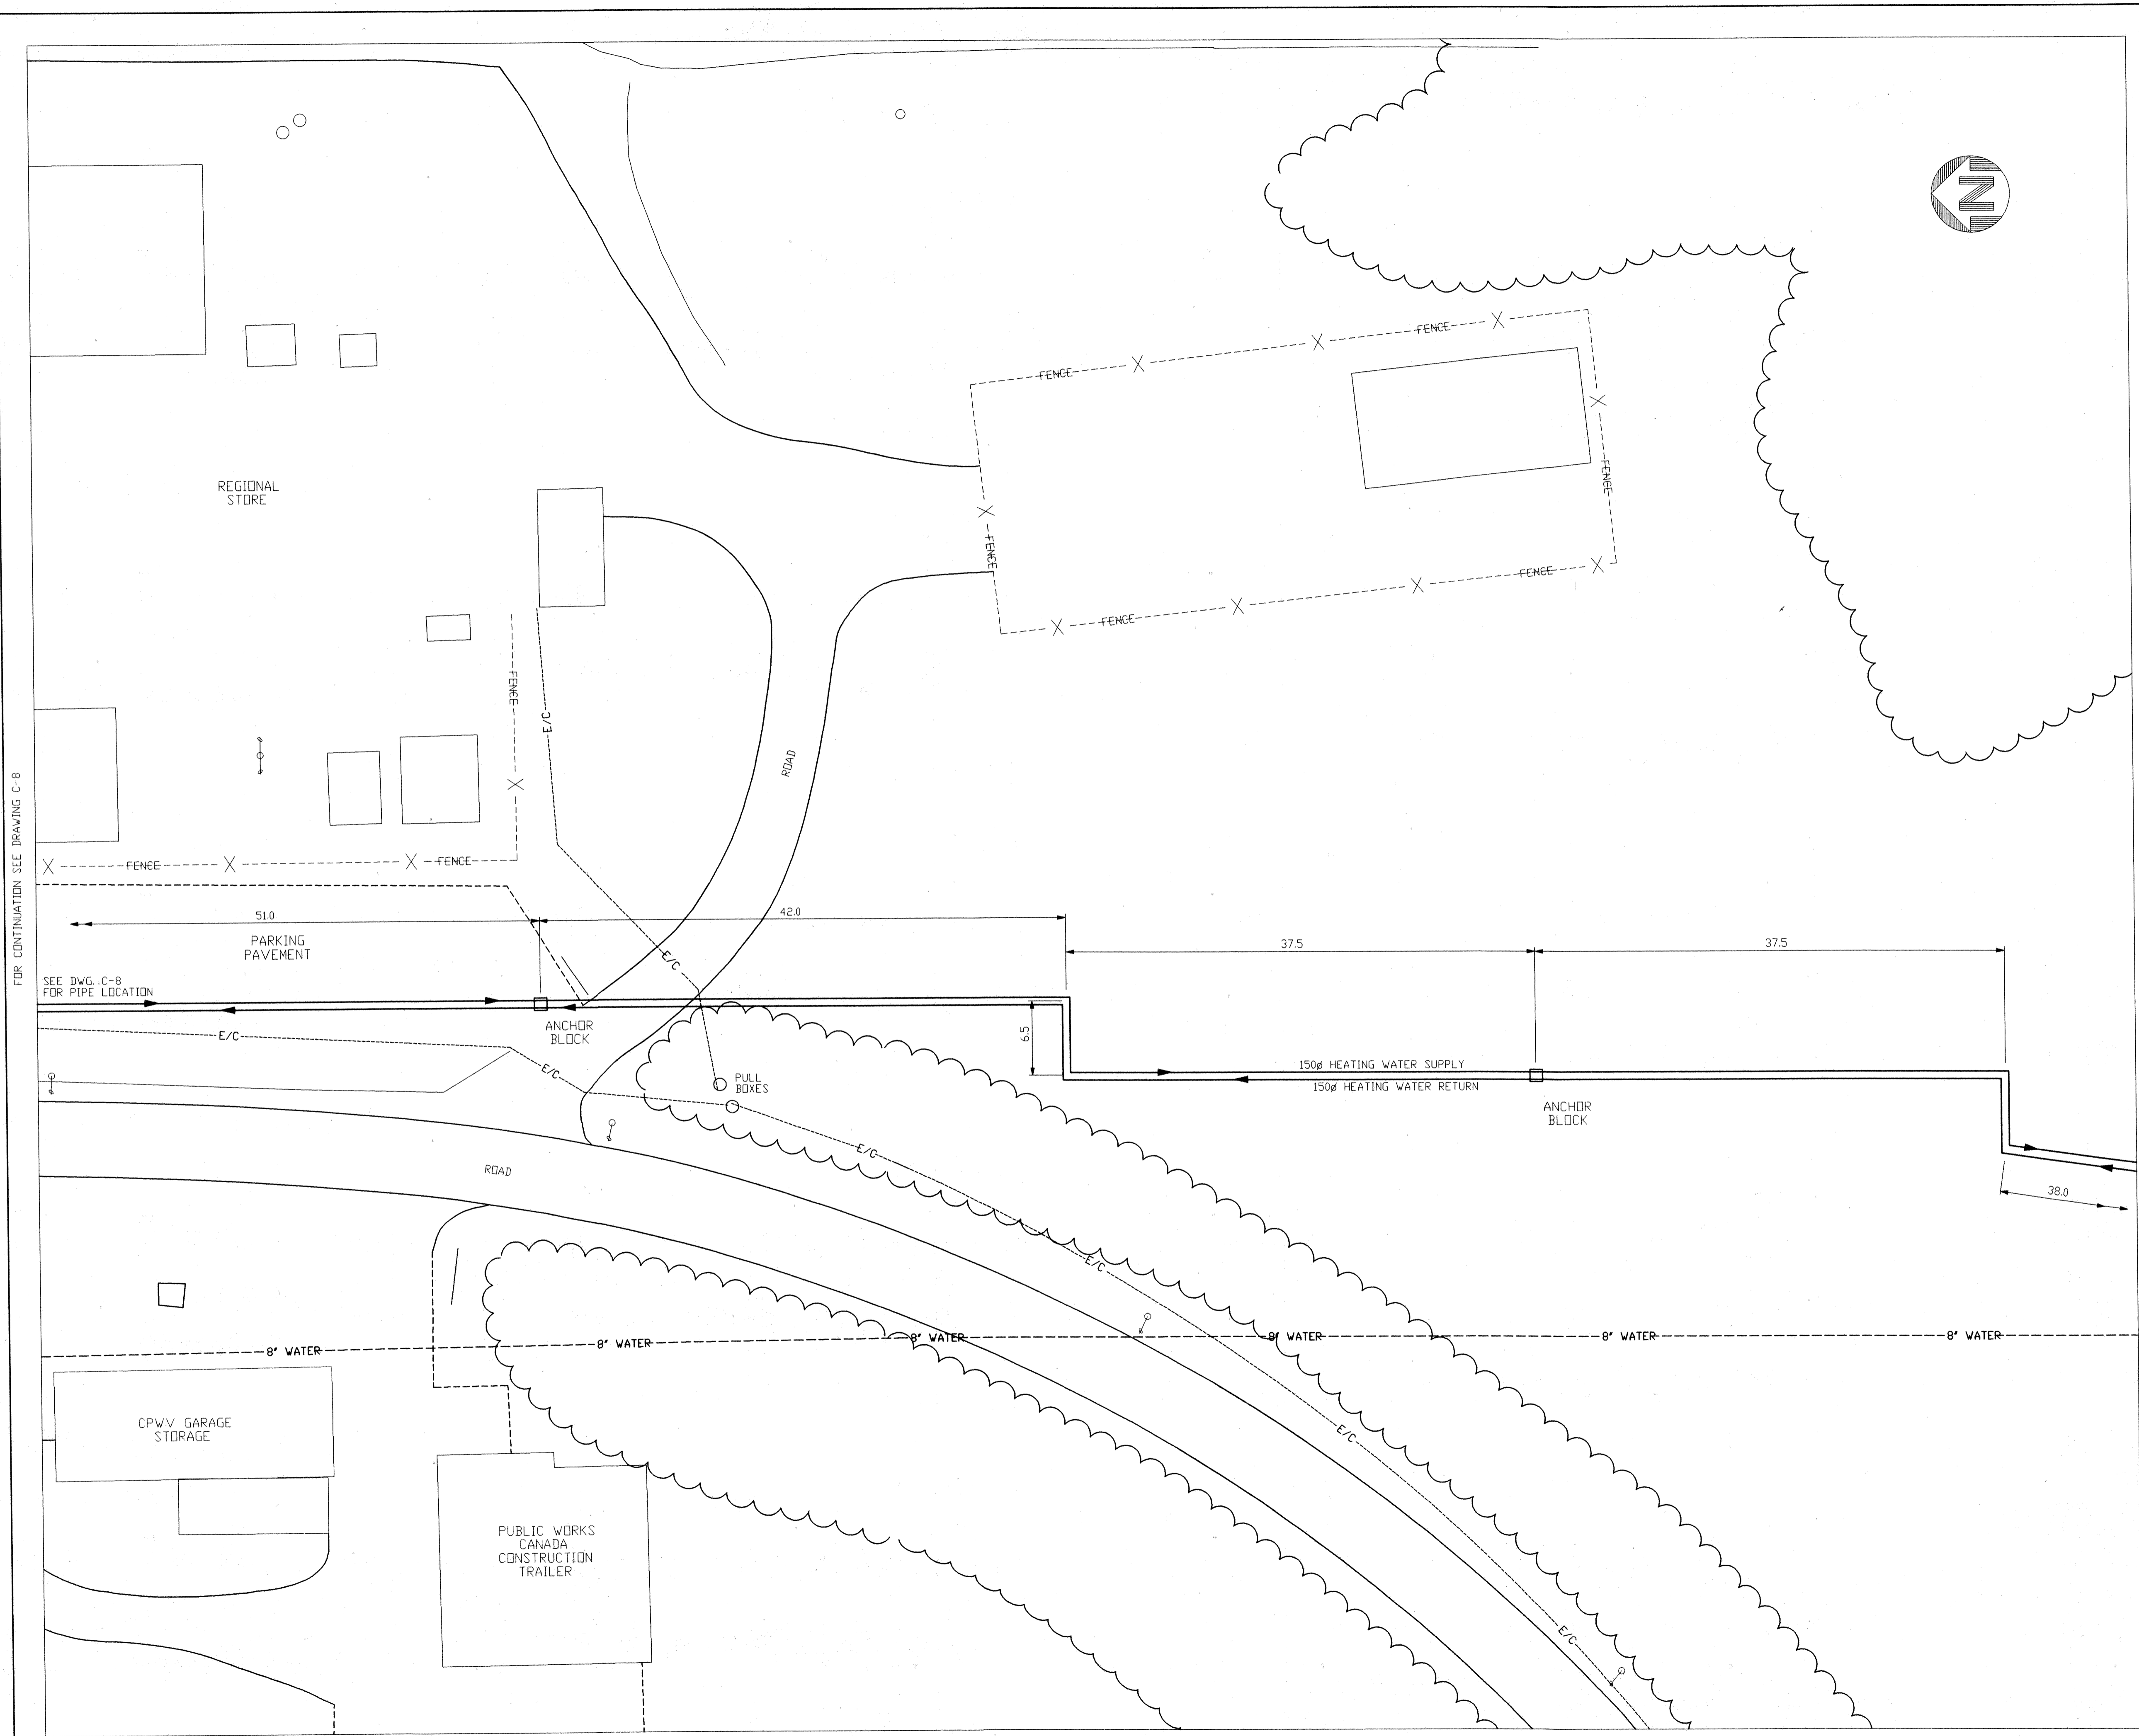

FOR CONTINUATION SEE DRAWING C-8

FOR CONTINUATION SEE DRAWING C-10

SIMONS H. A. SIMONS LTD.
CONSULTING ENGINEERS
VANCOUVER, CANADA
CRIPPEN HAS PROJ. 4944C
FILE AI-4944-01-9-937

AS BUILT 970110
ISSUED FOR PACKAGE 2 TENDER 940520
ISSUED FOR TENDER 940408
ISSUED FOR 90% REVIEW 940325
ISSUED FOR 30% DESIGN REPORT 940318

- NOTES:
1. FOR GENERAL NOTES, LEGEND AND KEY PLAN SEE DWG. C-1.
 2. ALL DIMENSIONS SHOWN ARE IN METRES.
 3. FOR INSTALLATION AND MATERIALS SPECIFICATIONS SEE DWG. C-14.

SCALE: 1:250

LEGEND
ABANDONED HEATING PIPE /- /RICWIL

revisions	date
A detail no. no. du detail	A
B location drawing no. sur dessin no.	B/C
C drawing no. dessin no.	


project project

MATSQUI COMPLEX
HEATING SYSTEM
UPGRADE

drawing dessin

DETAILED
PIPING LAYOUT
CENTRAL HEATING PLANT
SHEET 3 of 3

designed H. DOMBROWSKY	conçu
date 940209	
drawn J. COX/C. YEUNG	dessiné
date 940209	
reviewed M. CHAPMAN	examiné
date 940411	
approved S. FLECK/C.T. LUMB	approuvé
date 940411	
Tender STUART LESLIE	Soumission
PWC Project Manager	
project number 761637	no. du projet
drawing no. C-10	no. du dessin

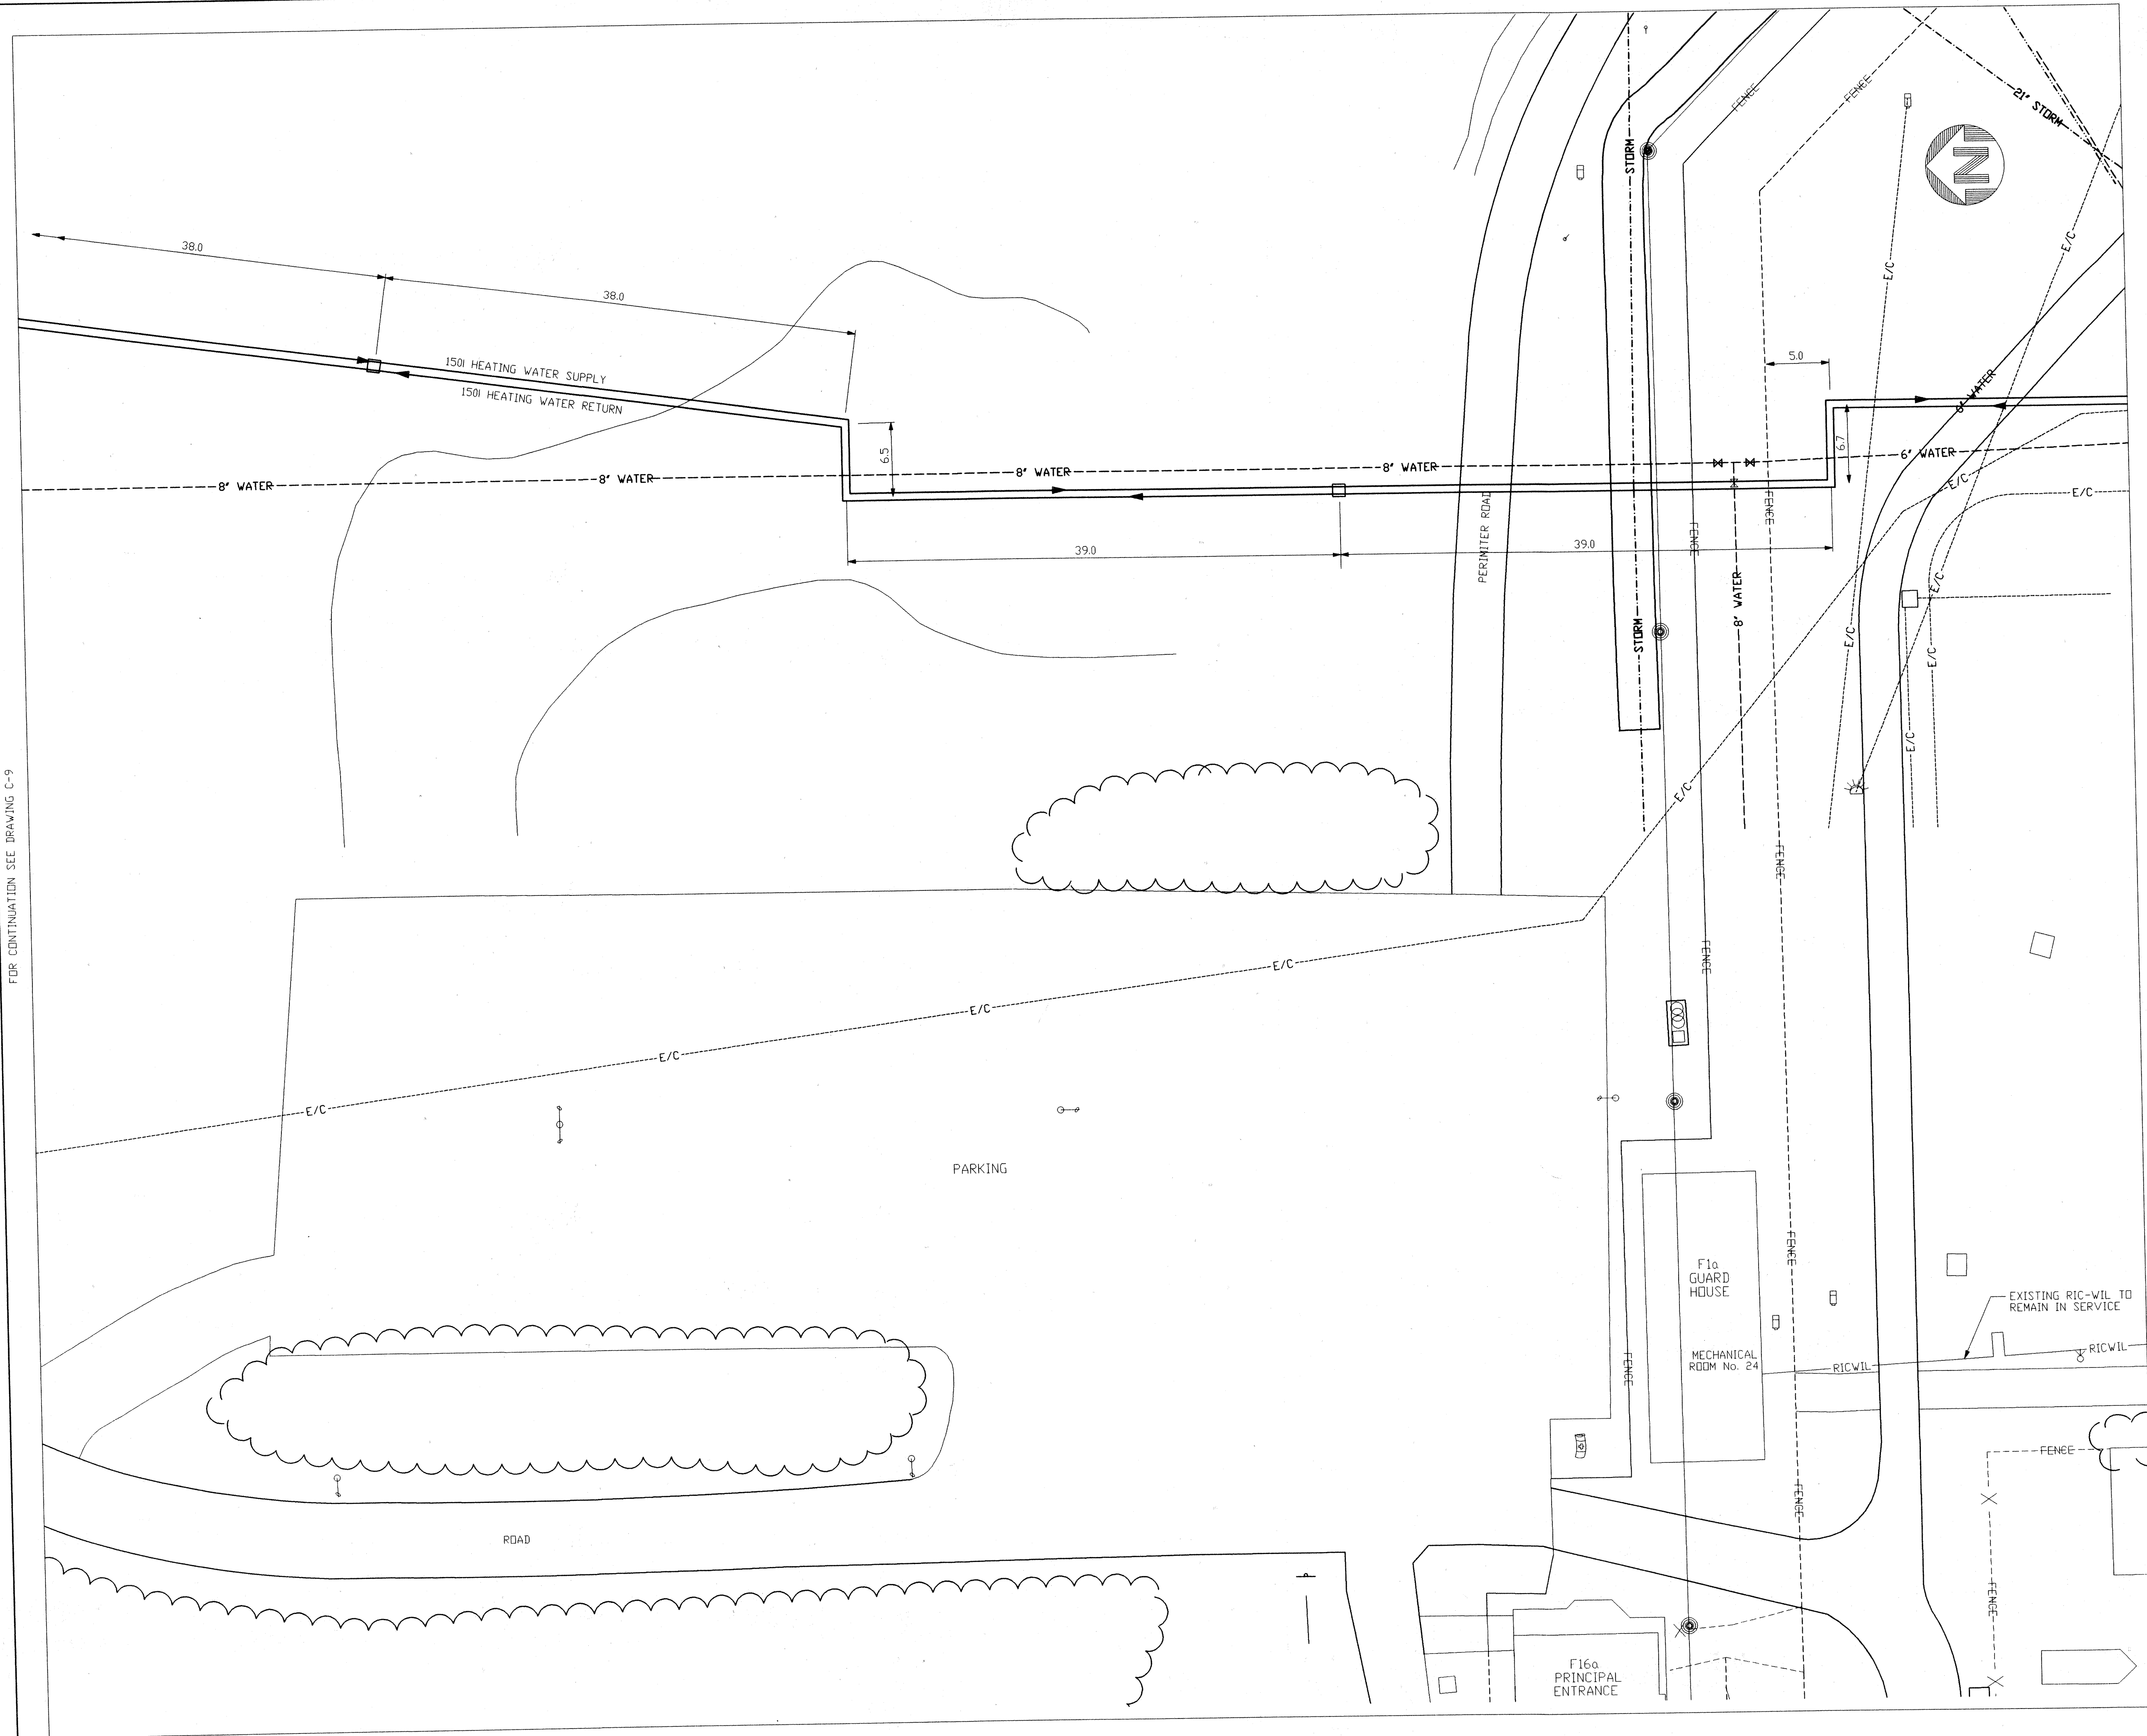

FOR CONTINUATION SEE DRAWING C-9

FOR CONTINUATION SEE DRAWING C-11