

1	100% COMPLETE	03/09/23
2	100% CONSTRUCTION	03/09/23
3	SUBMITTAL FOR REVIEW	02/05/23
4	90% SUBMITTAL NOT FOR CONSTRUCTION	03/21/21
5	ISSUED FOR BIDDING	03/29/20
6	PRELIMINARY	04/02/19
7	CONCEPT	04/02/19

Project Title/Titre du projet

POLICE BUILDING,
100 MILE HOUSE B.C.


MEZZANINE FLOOR PLAN

SCALE 1 = 50

Consultant Approval Date Day	
S. VALLÉ	
Designed by/Conçu par	K. DEB
Drawn by/Dessiné par	K. DEB
Checked by/Vérifié par	K. DEB
Drawn Title/Titre du dessin	

MEZZANINE FLOOR PLAN

HVAC

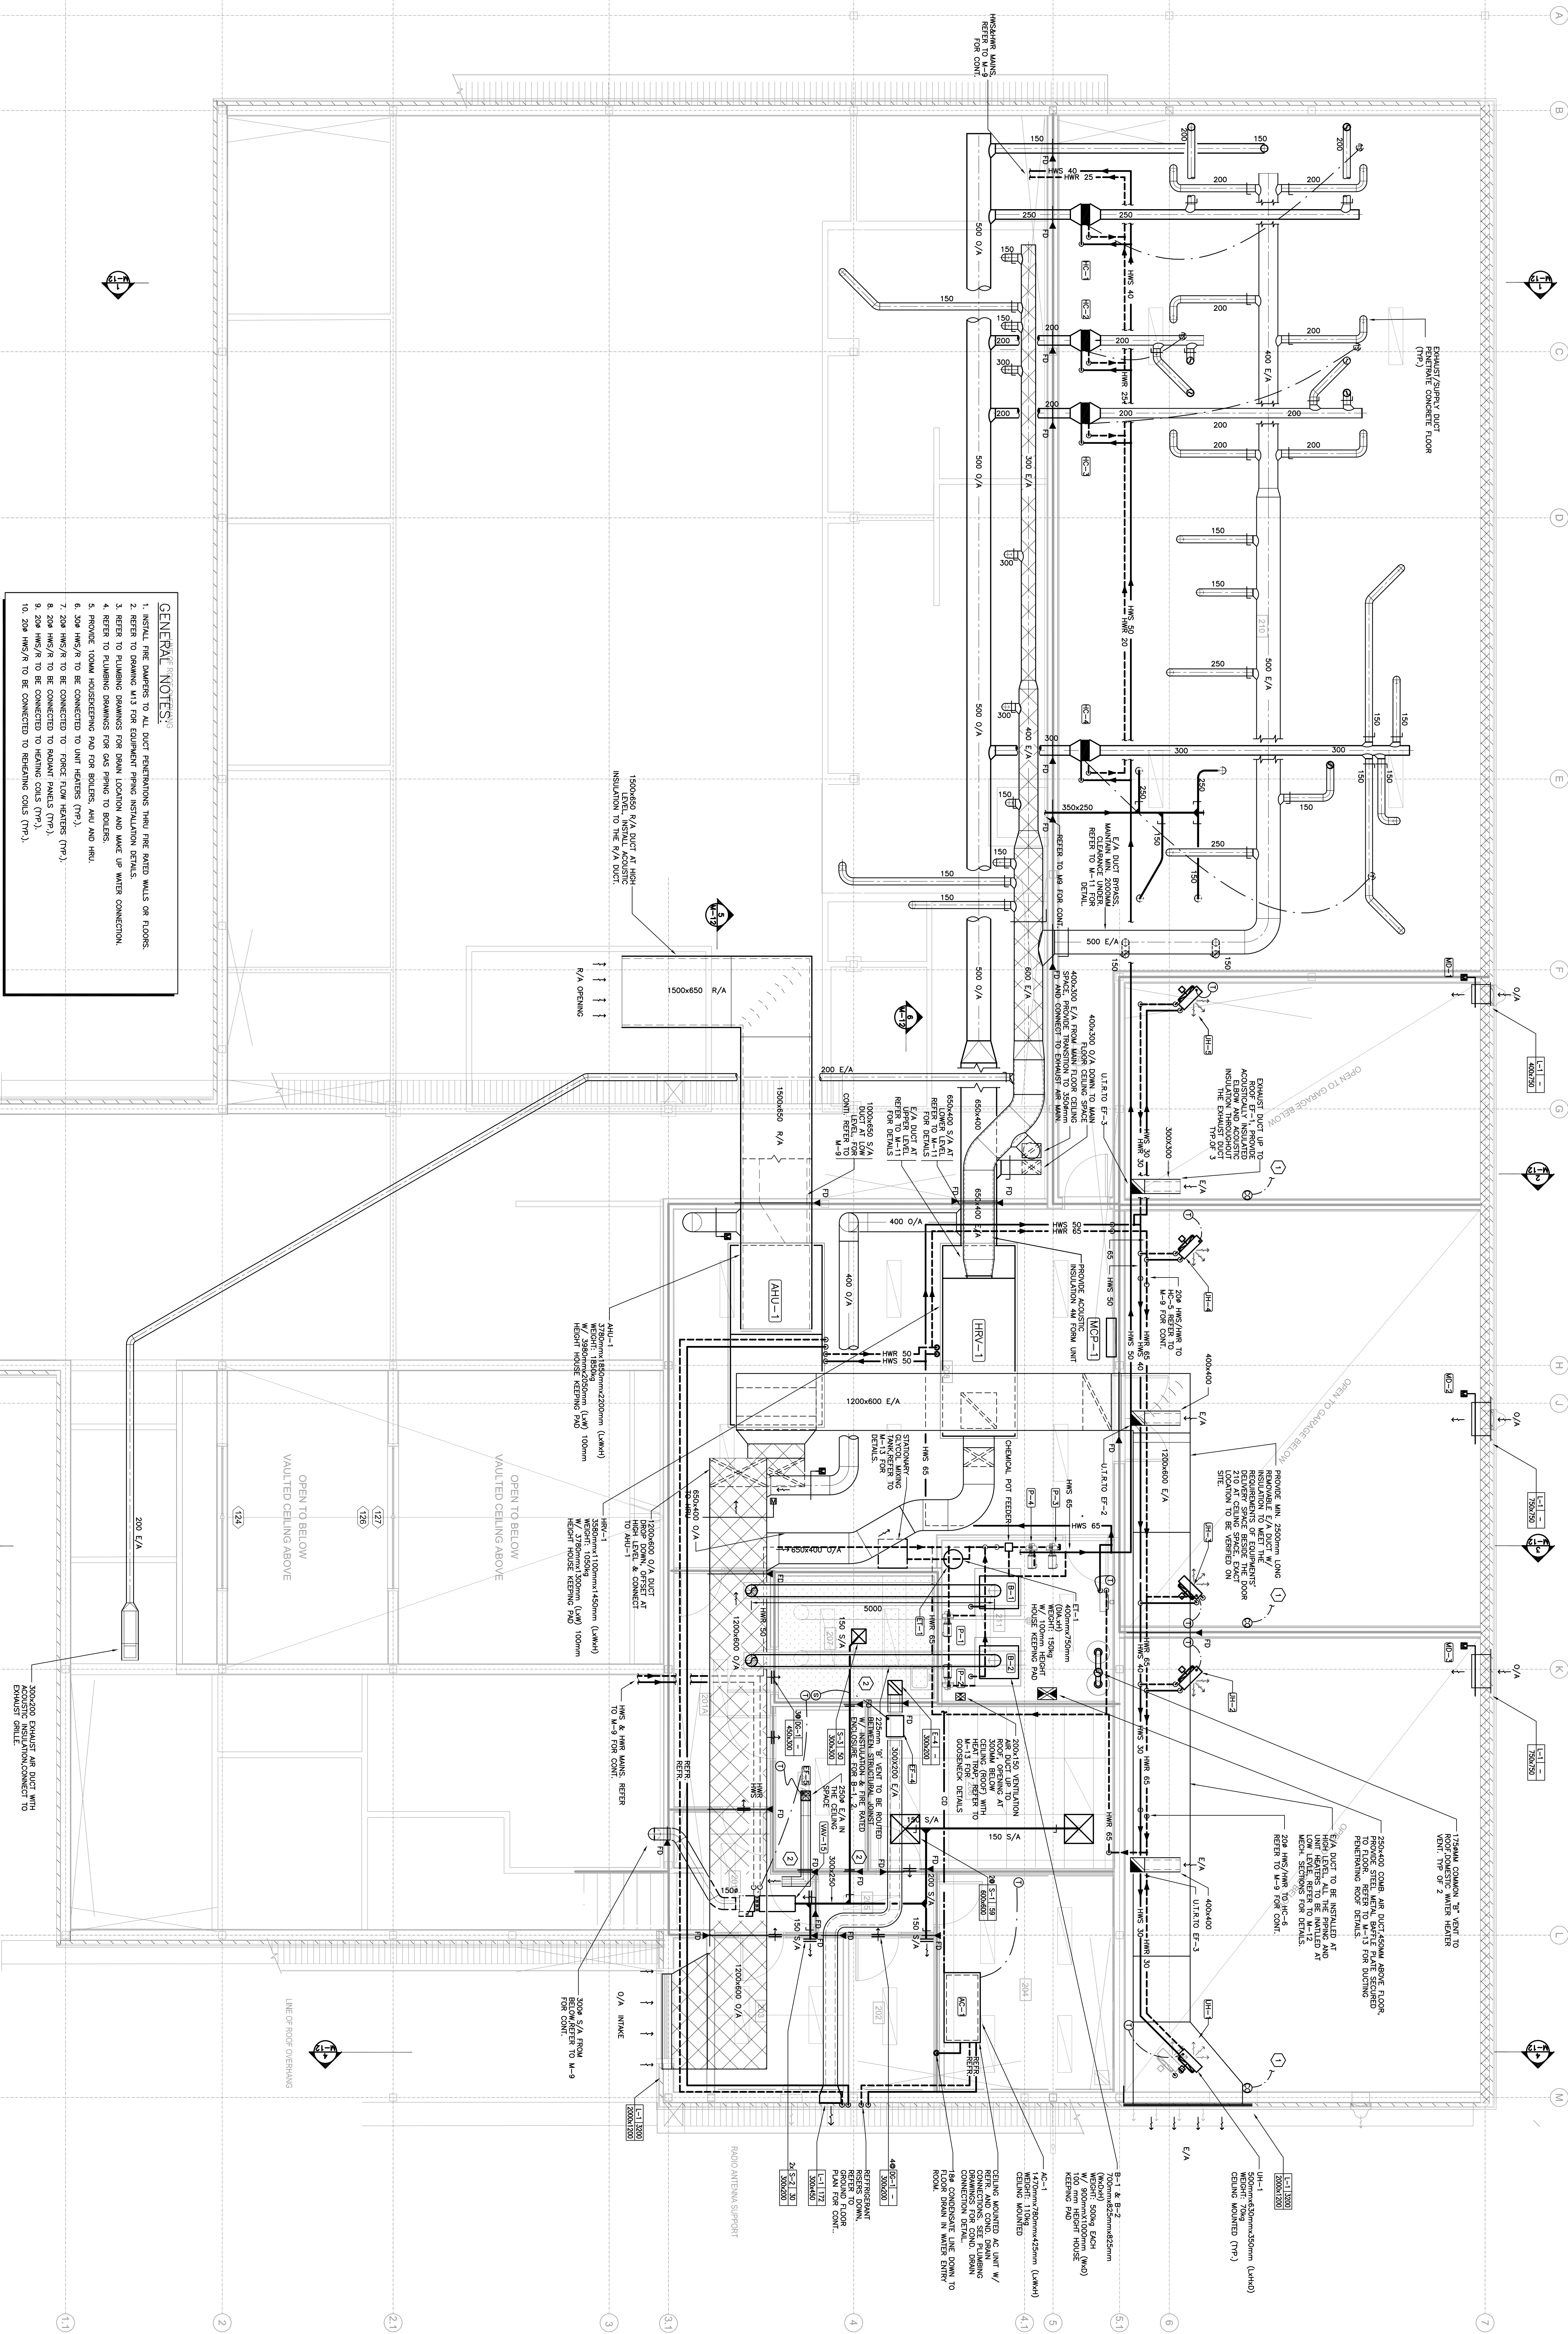

- GENERAL NOTES:**
- INSTALL FIRE DAMPERS TO ALL DUCT PENETRATIONS THRU FIRE RATED WALLS OR FLOORS.
 - REFER TO DRAWING M-13 FOR EQUIPMENT PIPING INSTALLATION DETAILS.
 - REFER TO PLUMBING DRAWINGS FOR DRAIN LOCATION AND MAKE UP WATER CONNECTION.
 - REFER TO PLUMBING DRAWINGS FOR GAS PIPING TO BOILERS.
 - PROVIDE 100MM HOUSING/ENCLOSURE PAD FOR BOILERS, AHU AND HRV.
 - 300A HWS/R TO BE CONNECTED TO UNIT HEATERS (TYP).
 - 200A HWS/R TO BE CONNECTED TO FORCE FLOW HEATERS (TYP).
 - 200A HWS/R TO BE CONNECTED TO HEATING COILS (TYP).
 - 200A HWS/R TO BE CONNECTED TO HEATING COILS (TYP).
 - 200A HWS/R TO BE CONNECTED TO HEATING COILS (TYP).
 - 200A HWS/R TO BE CONNECTED TO HEATING COILS (TYP).

- KEY NOTES:**
- STANDARD CO. SENSE EXISTING BY AMENDMENT TO CONTROL THE EXHAUST FAN ON THE ROOF (TYP). SEE MANUFACTURER'S MANUAL FOR INSTALLATION AND DETAILS.
 - PROVIDE SCREED DASH AT THE DUCT OPENING PENETRATION THE WALL. SEE ARCH. DRAWINGS FOR DETAILS (TYP).