



## HVAC SYMBOLS

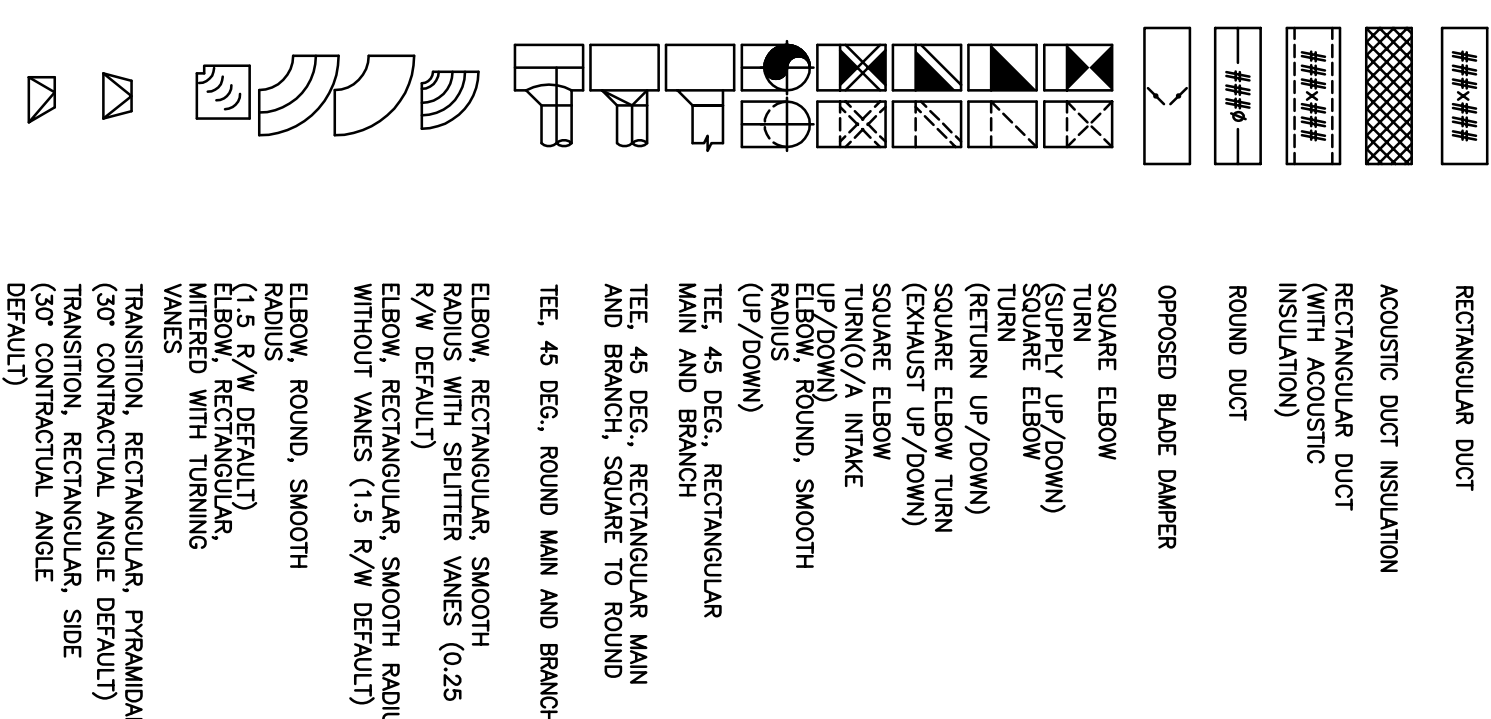

## PIPING IDENTIFICATION AND SYMBOLS

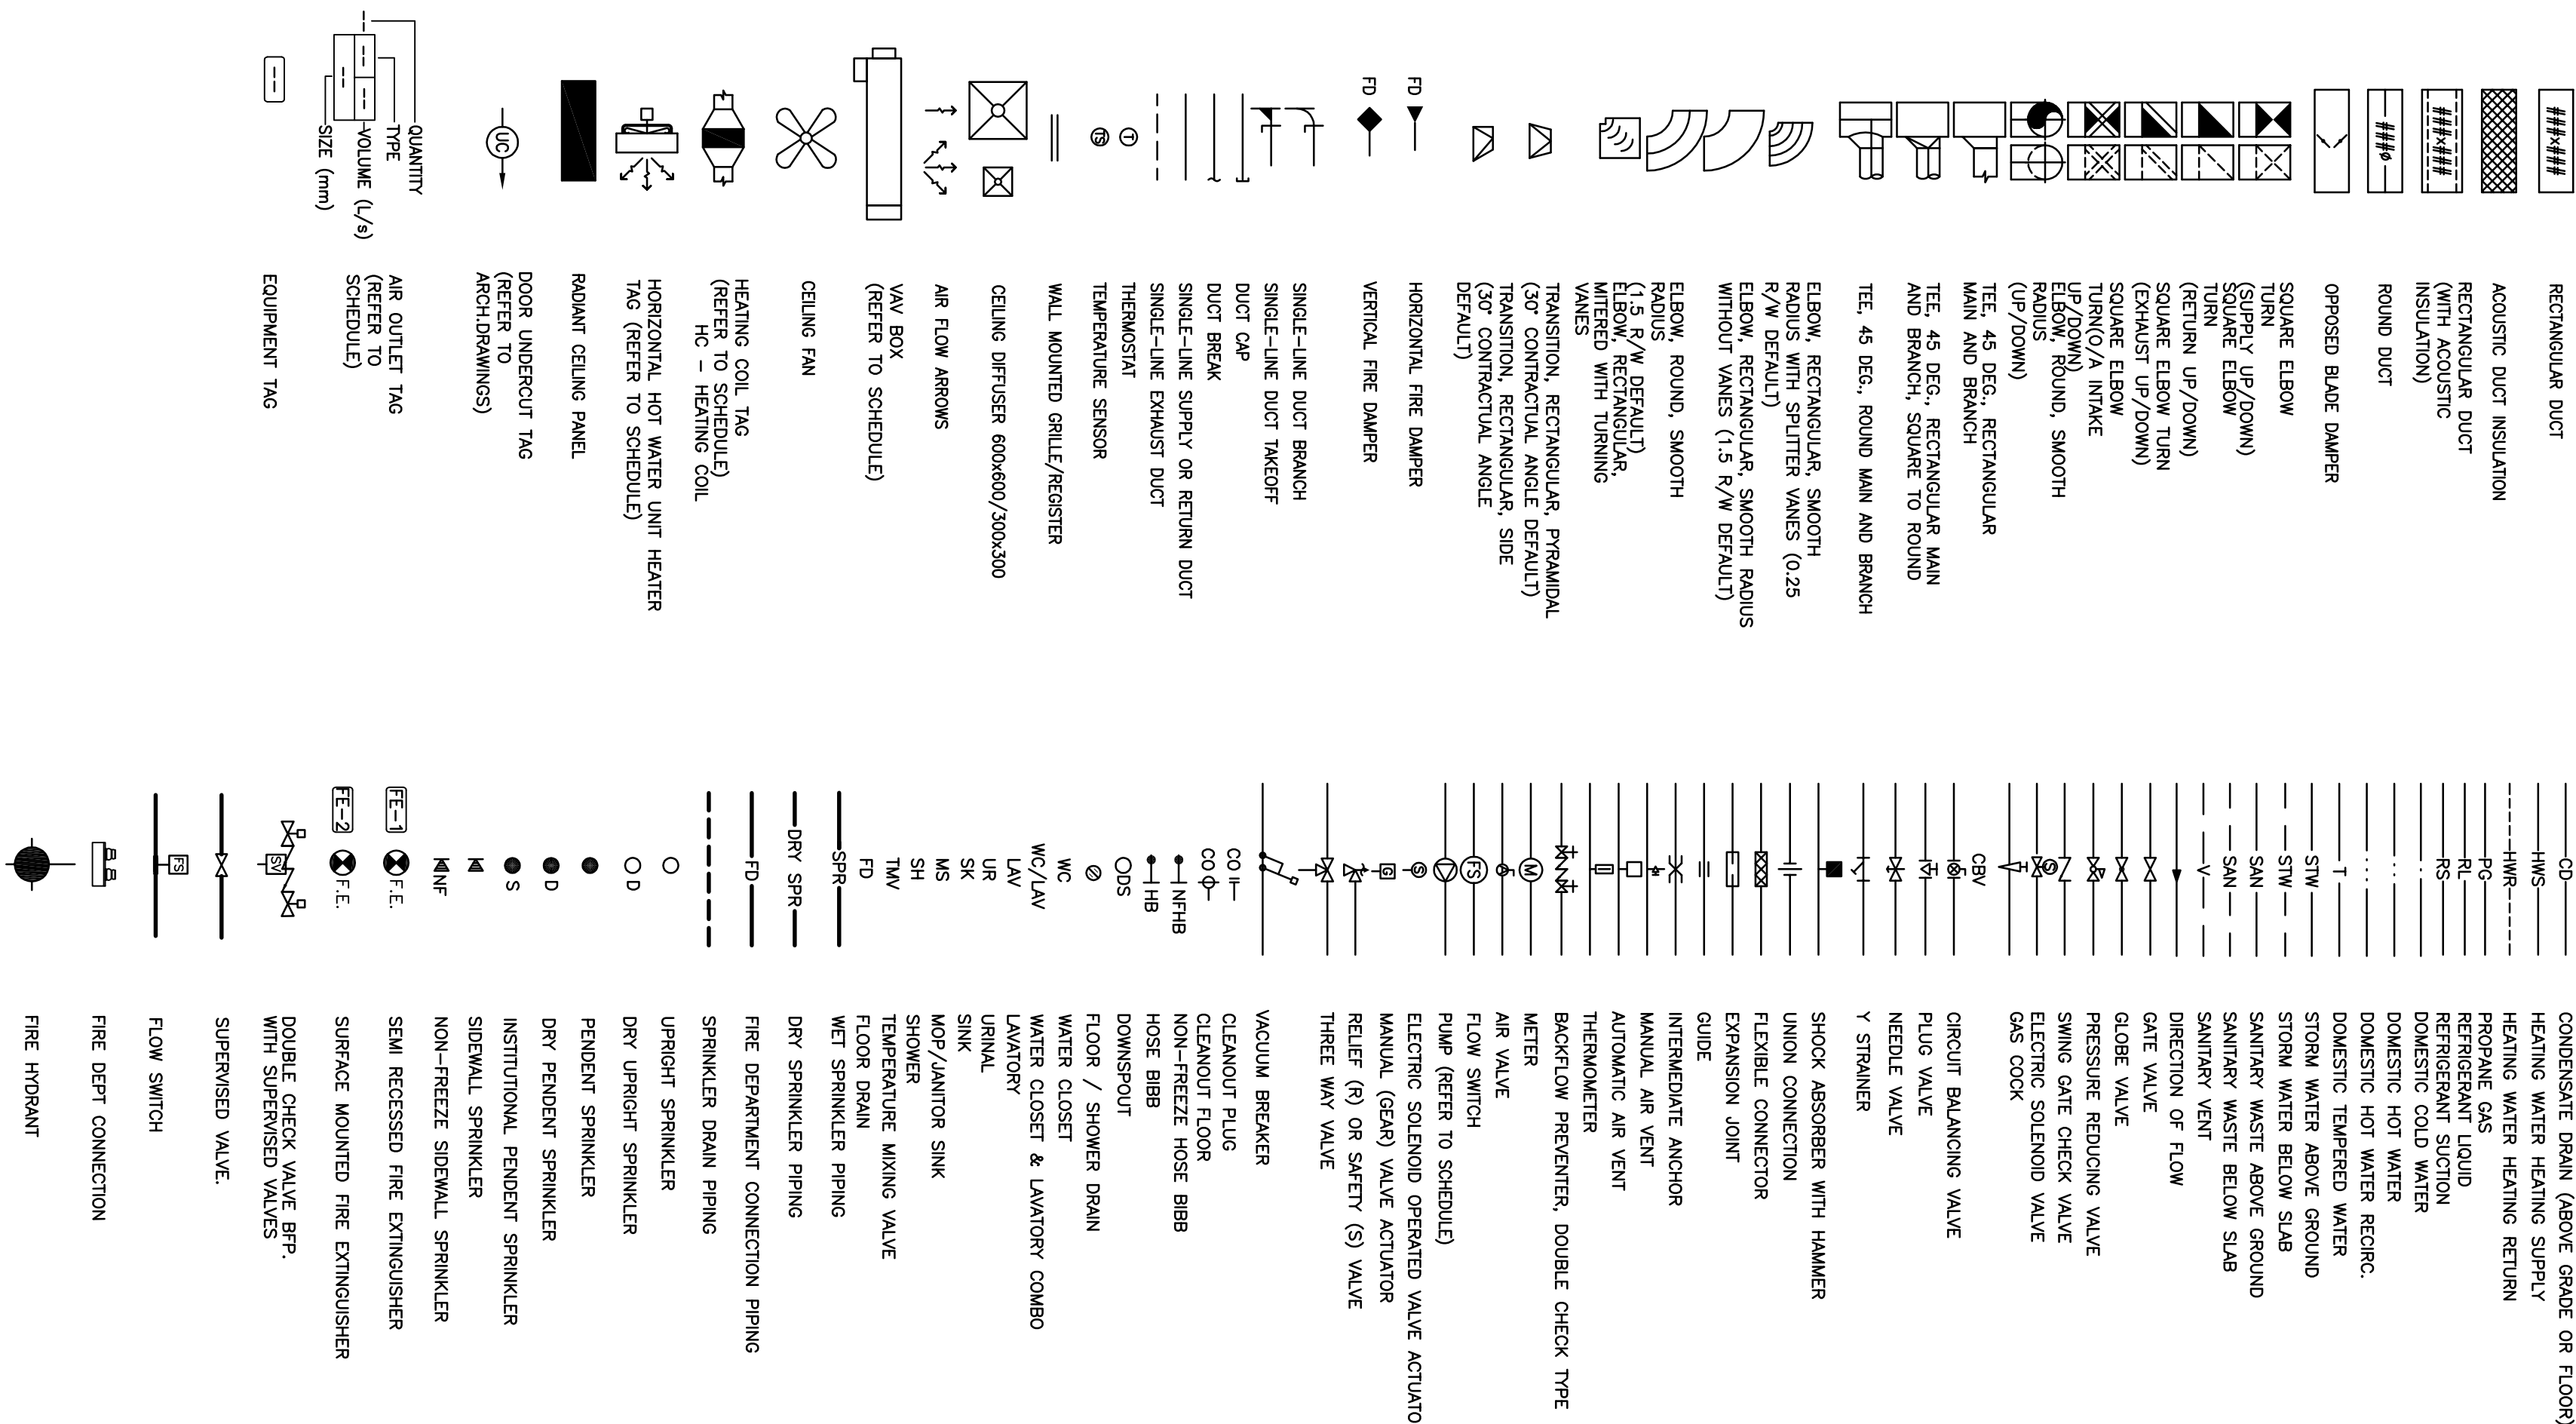

## GENERAL NOTES

(APPLY TO ALL DRAWINGS UNLESS OTHERWISE NOTED.)

1. PROVIDE THE EXHAUSTERS TO BEAP-10.
2. BUILDING IS FULLY SPRINKLED.
3. READ THESE DRAWINGS IN CONJUNCTION WITH THE SPECIFICATIONS.
4. ALL WORK SHALL COMPLY WITH THE NATIONAL BUILDING CODE, 2005.
5. FIRE STOP ALL PENETRATIONS THROUGH RAISED SEPARATIONS PER DMM 5-115.
6. REFERS TO ALL PENETRATIONS PER SITE DRAINAGE AND SERVICES BEYOND 1 METERS FROM FACE OF BUILDING.
7. ROOF DRAINAGE INCLUDING GUTTERS AND DOWN SPUTS PER ARCHITECTURAL DRAWINGS.
8. SANITARY DRAINAGE FROM 1 METERS FROM THE BUILDING PER CIVIL DRAWINGS.
9. SITE DRAINAGE PER CIVIL DRAWINGS.

## DRAWING LIST

DRG #	DRAINAGE NAME	SCALE
M-1	MECHANICAL, LEGEND & STEE PLAIN	1:100
M-2	FOUNDATION PLAN - PLUMBING	1:50
M-3	MAIN FLOOR PLAN - PLUMBING	1:50
M-4	MEZZANINE FLOOR PLAN - PLUMBING	1:50
M-5	ROOF PLAN - PLUMBING	1:50
M-6	MECHANICAL ROOM SUPPRESSION	1:50
M-7	MEZZANINE FLOOR PLAN - FIRE SUPPRESSION	1:50
M-8	PLUMBING & FIRE SUPPRESSION DETAILS	NTS
M-9	MAIN FLOOR PLAN - HVAC	1:50
M-10	MEZZANINE FLOOR PLAN - HVAC	1:50
M-11	MECHANICAL, ELEVATIONS	NTS
M-12	MECHANICAL, ELEVATIONS	NTS
M-13	HVAC DETAILS	NTS



Client/Client Organization/Project Description	Task/Description	Due Date
4	100% COMPLETE	03/05/12
3	FOR CONSTRUCTION	02/17/12
2	Submission FOR REVIEW	02/02/12
1	99% Submission NOT FOR CONSTRUCTION	03/31/11
0	ISSUED FOR 60% CLIENT REVIEW	03/29/07 FOR REVIEW

Project title/Titre du projet

POLICE BUILDING,  
100 MILE HOUSE B.C.

Consultant Approval Box Only

S. VULC

Designed by/Concepted por  
K. GER

Drawn by/Issuing por  
K. GER

Working title/Title du dessin

MECHANICAL LEGEND &  
SITE PLAN

SCALE 1" = 100'