


Mock-up / Maquette

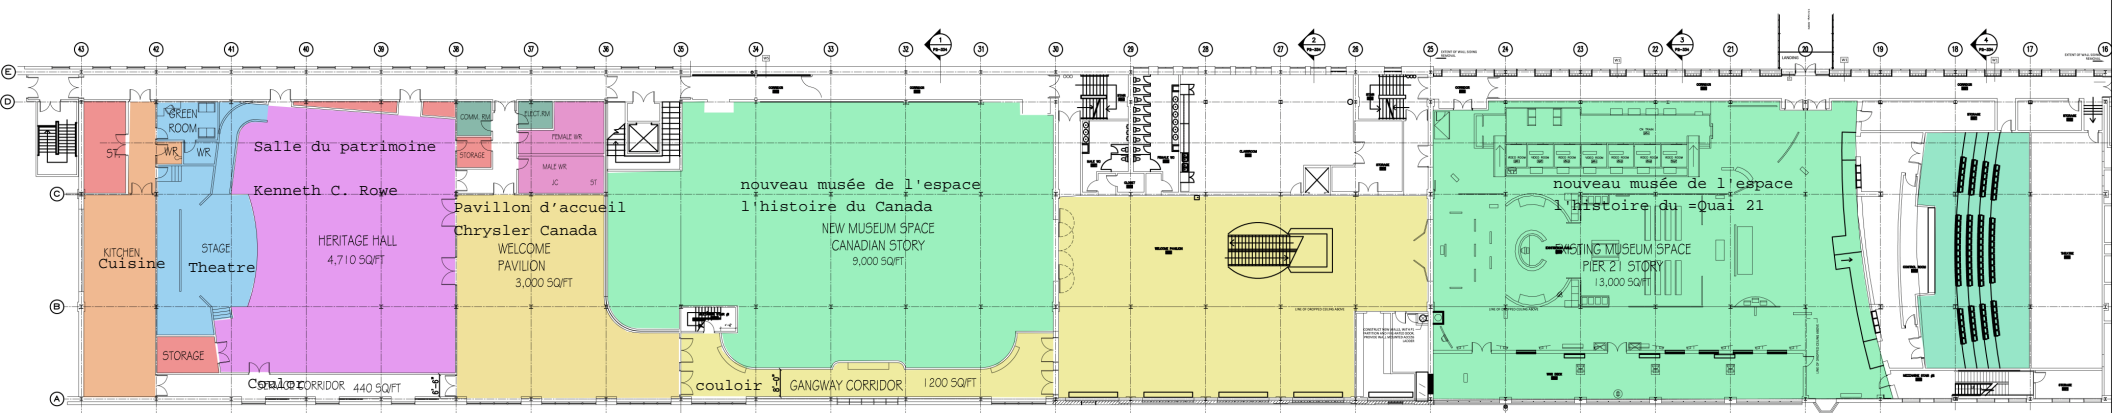

Provided by / fourni par S.P. Dumaresq Architect Ltd.


Mechanical Mezz. Plan

# ARCHITECTURAL PLANS


ANNEX  
10,842 SQ. FT.



FIRST FLOOR PLAN - SOUTH - ANNEX  
Scale: NTS

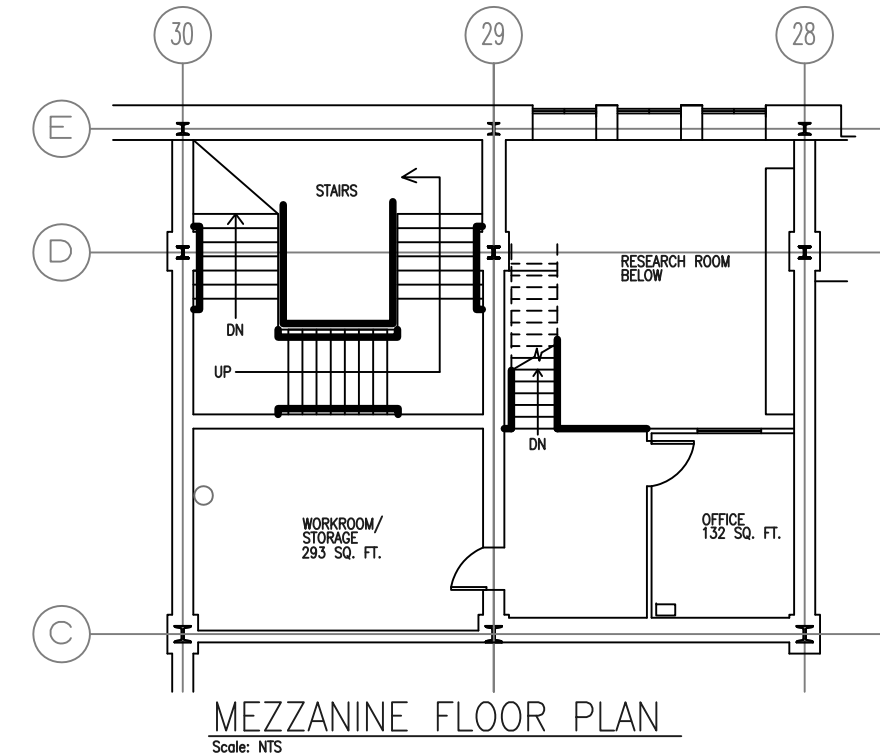


MEZZANINE FLOOR PLAN  
Scale: NTS

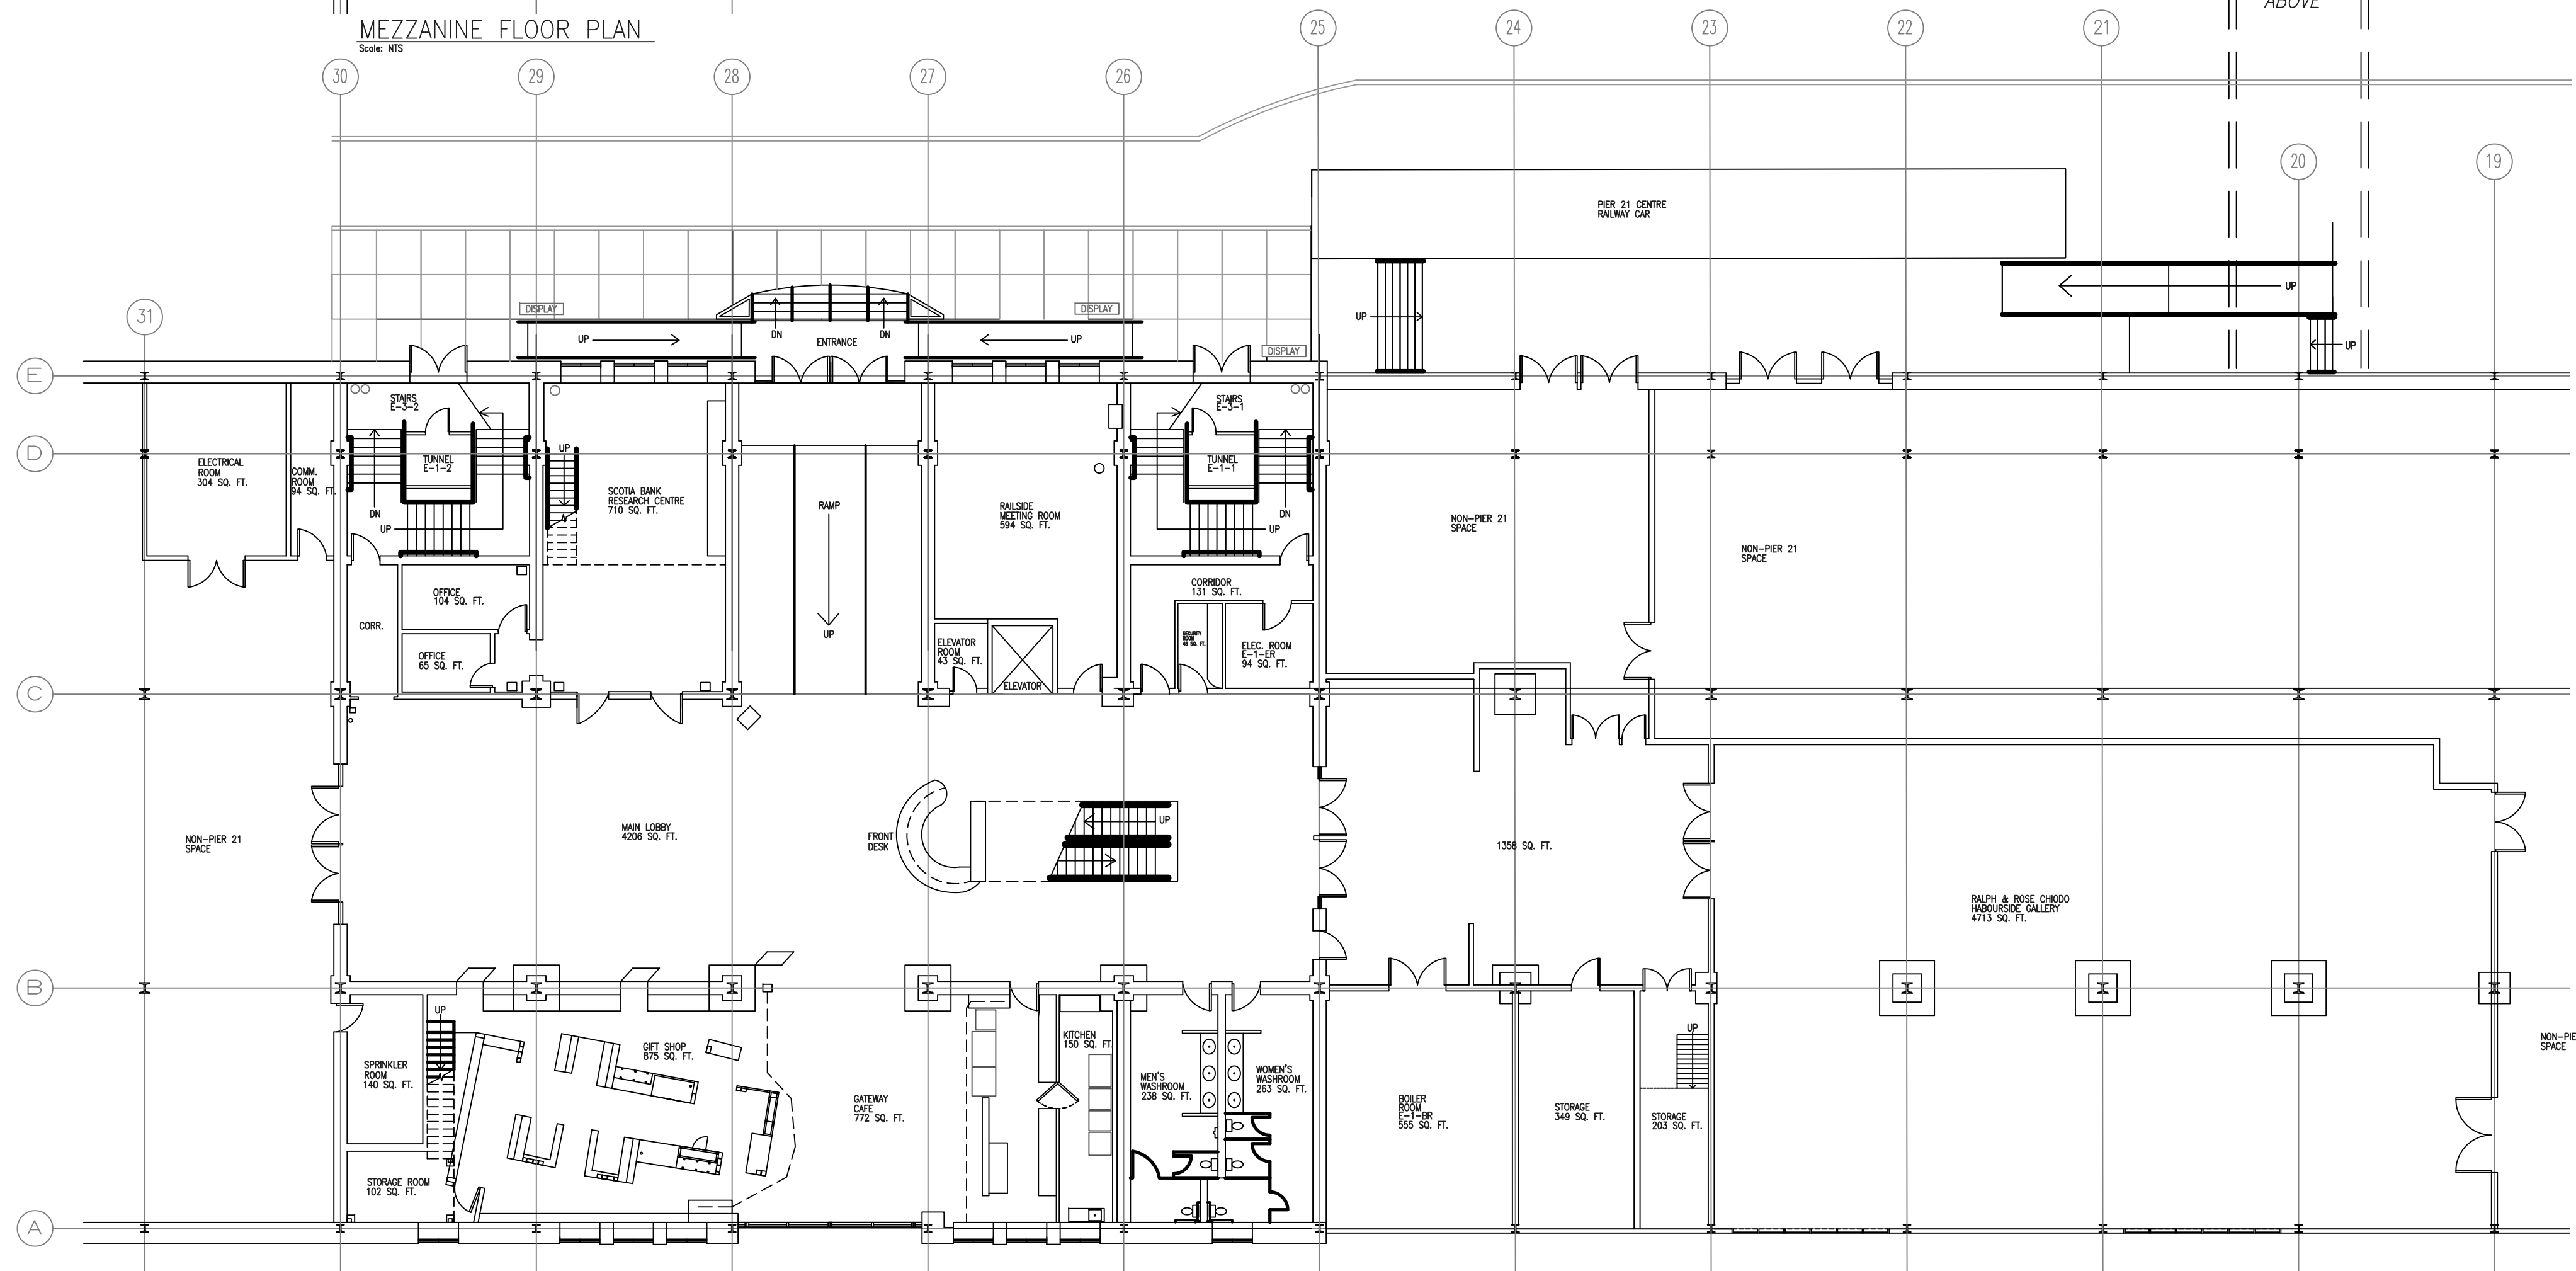


FIRST FLOOR PLAN - NORTH  
Scale: NTS

FIRST FLOOR PLAN - SOUTH  
Scale: NTS

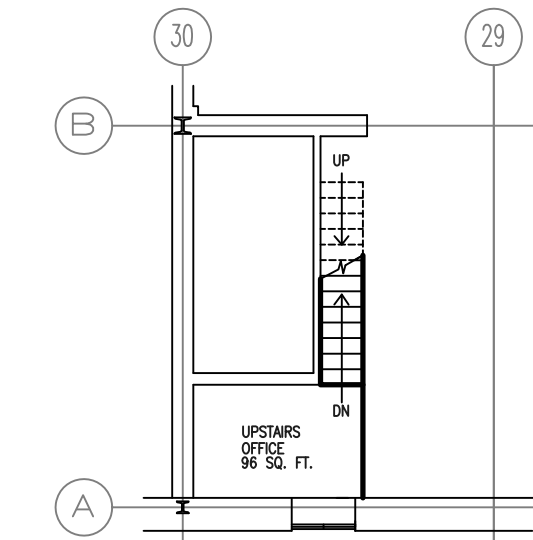

MEZZANINE FLOOR PLAN  
Scale: NTS

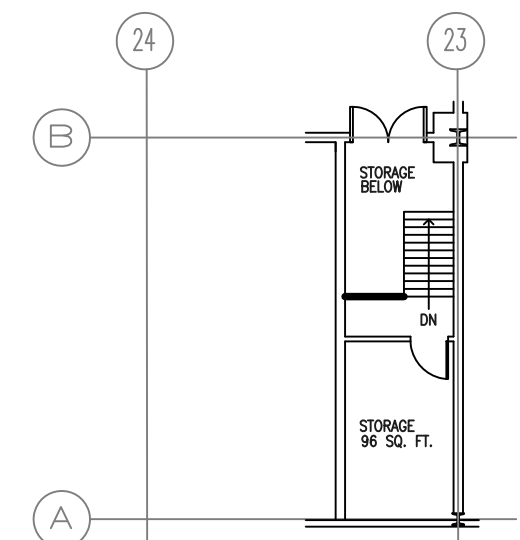


MEZZANINE FLOOR PLAN  
Scale: NTS

# ARCHITECTURAL PLANS




SECOND FLOOR PLAN - SOUTH - ANNEX  
Scale: N1/8"


PERWAY  
1147 SQ. FT.

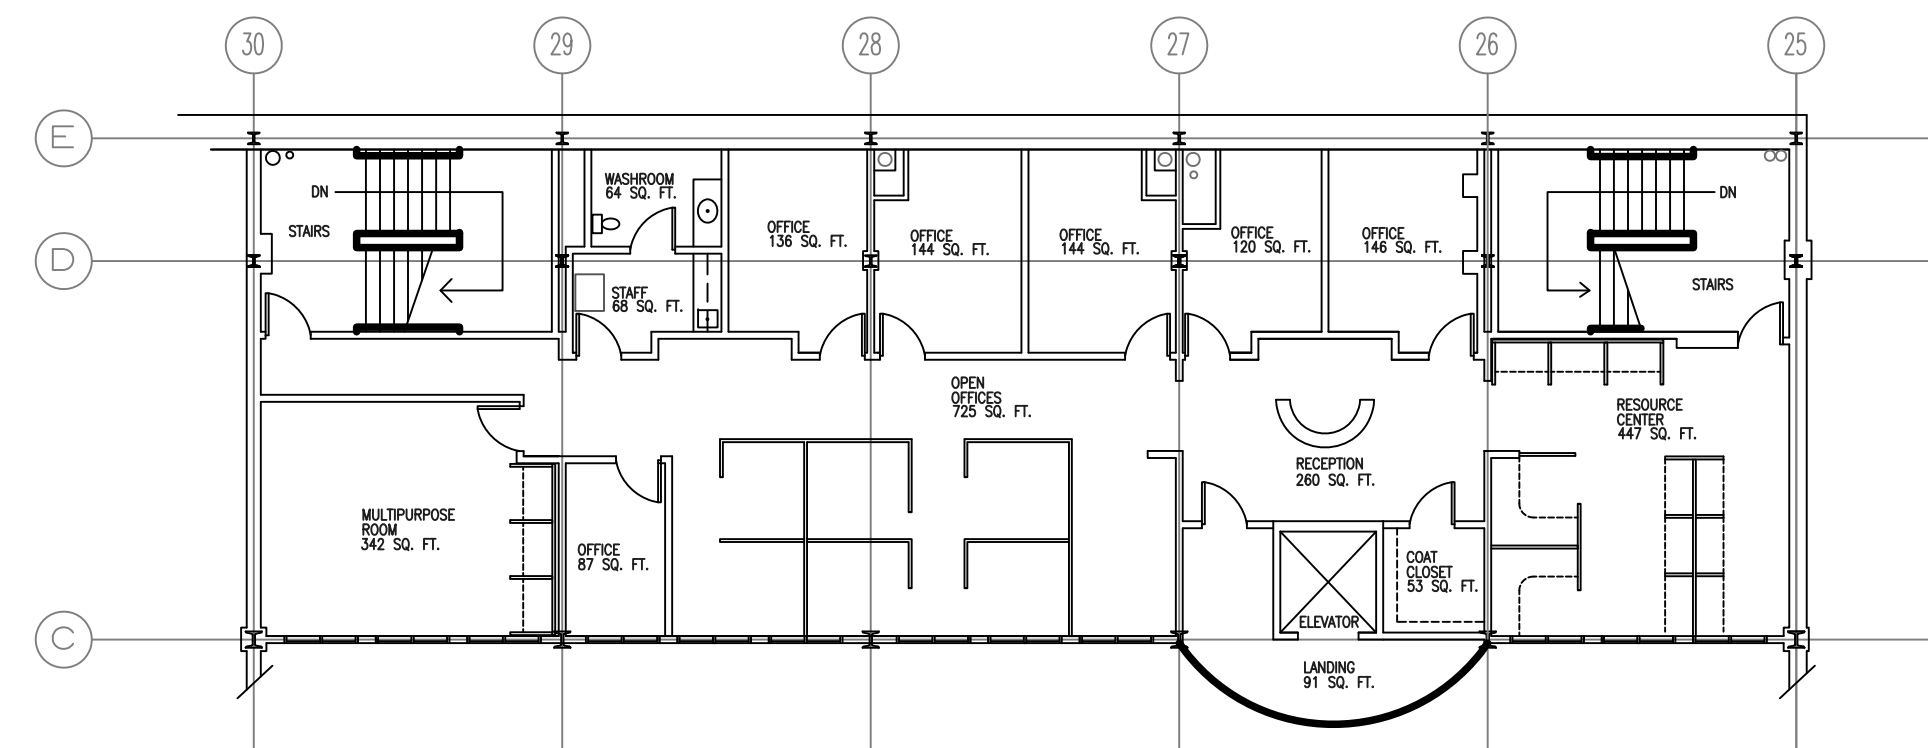

MEZZANINE FLOOR PLAN  
Scale: N1/8"

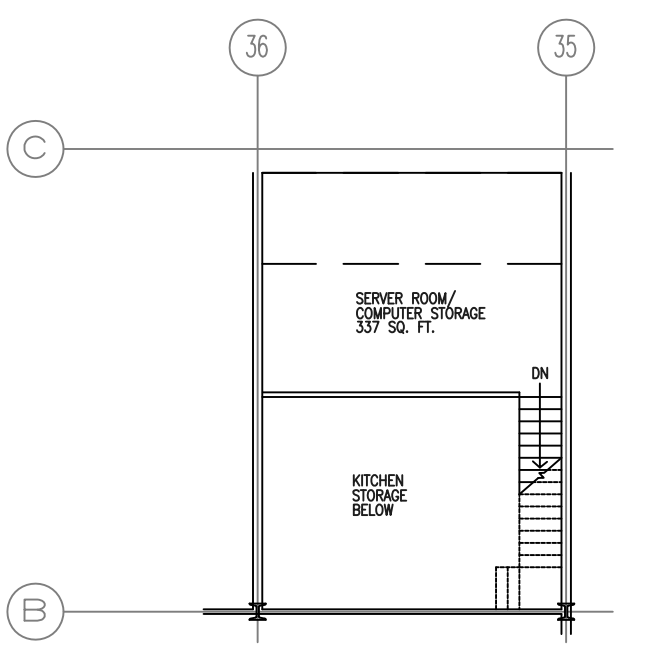


MEZZANINE FLOOR PLAN  
Scale: N1/8"

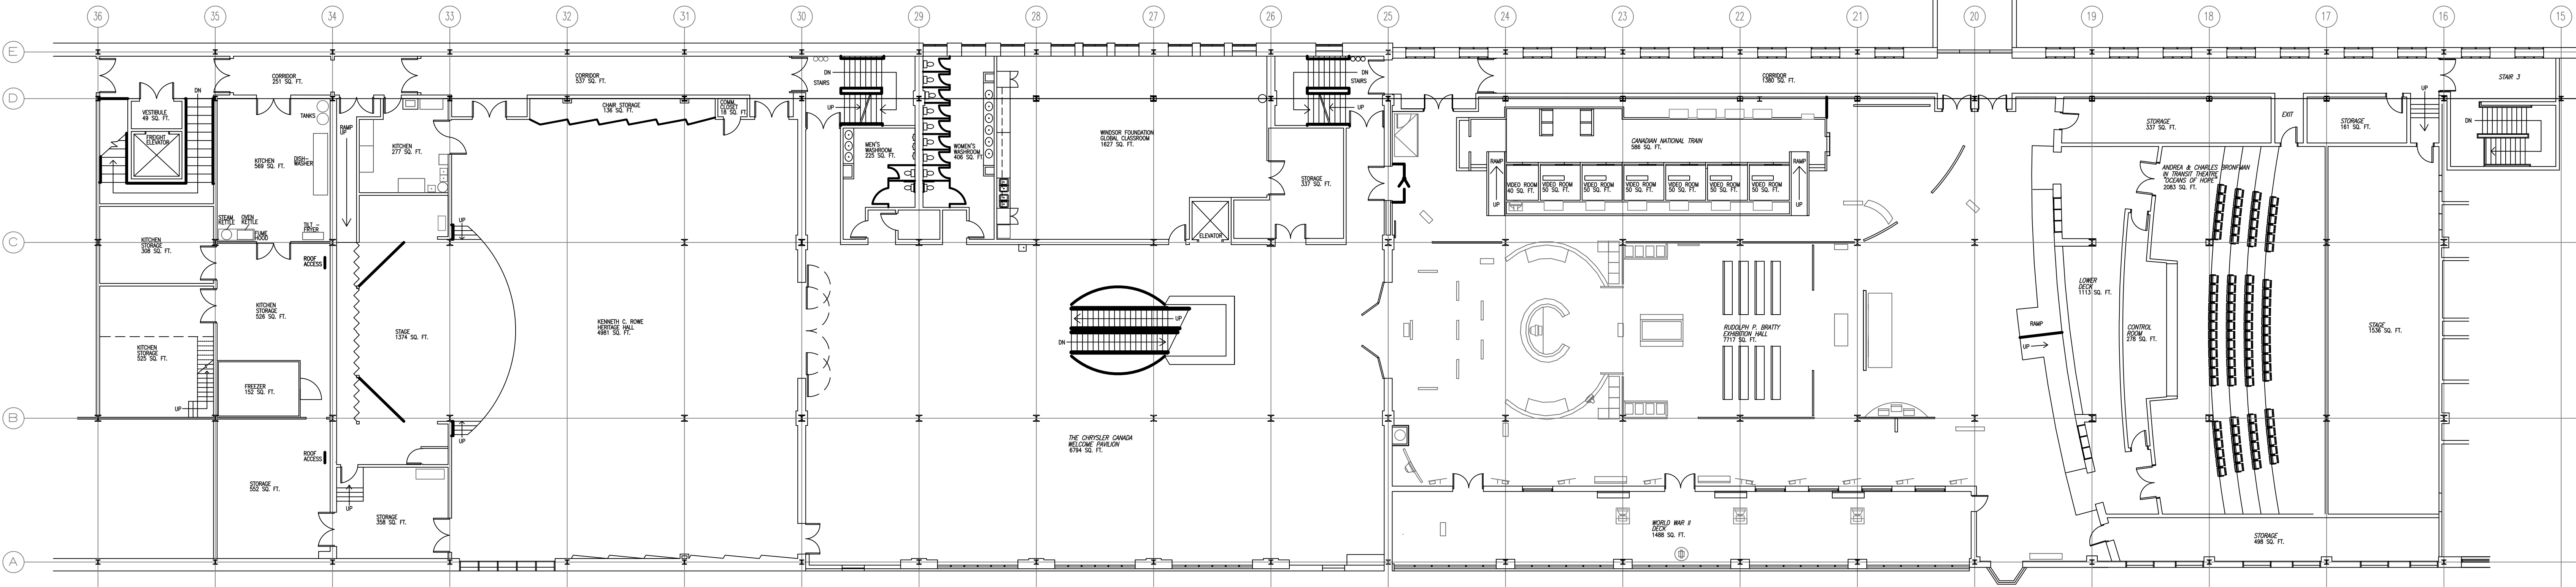

SECOND FLOOR PLAN - NORTH  
Scale: N1/8"


SECOND FLOOR PLAN - SOUTH  
Scale: N1/8"

# ELECTRICAL, MECHANICAL & EMERGENCY PLANS

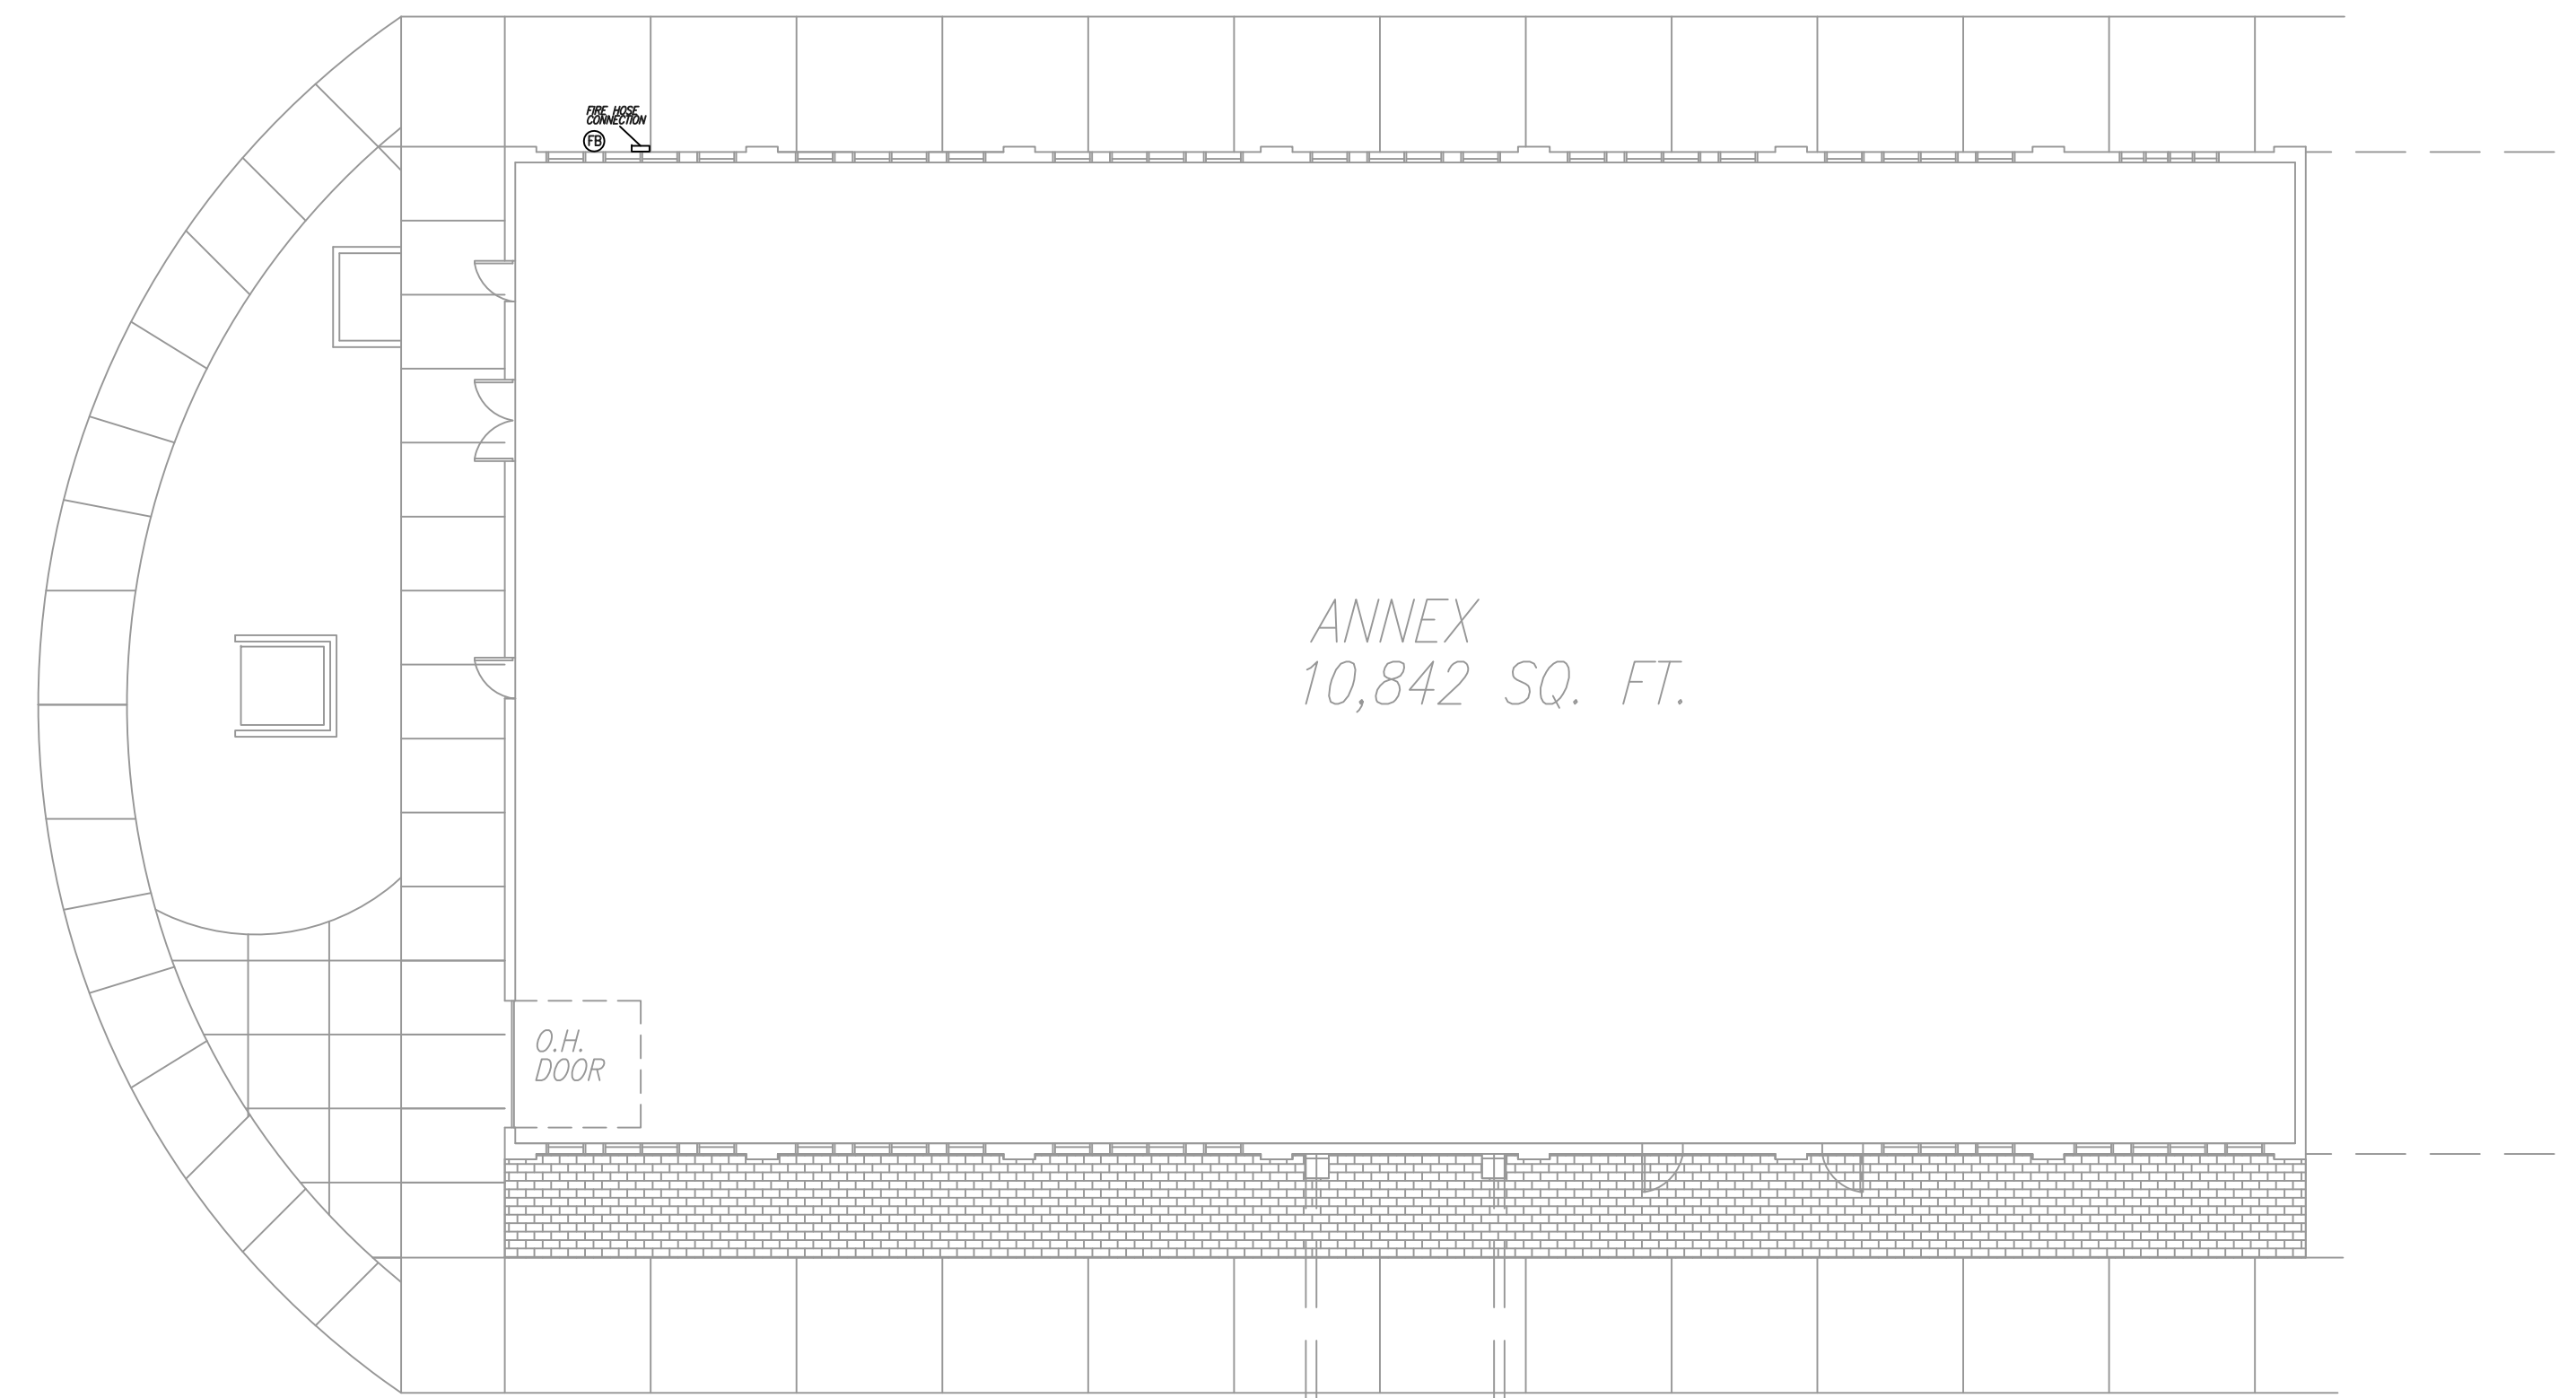


ANNEX  
10,842 SQ. FT.


FIRST FLOOR PLAN - SOUTH - ANNEX  
Scale: NTS

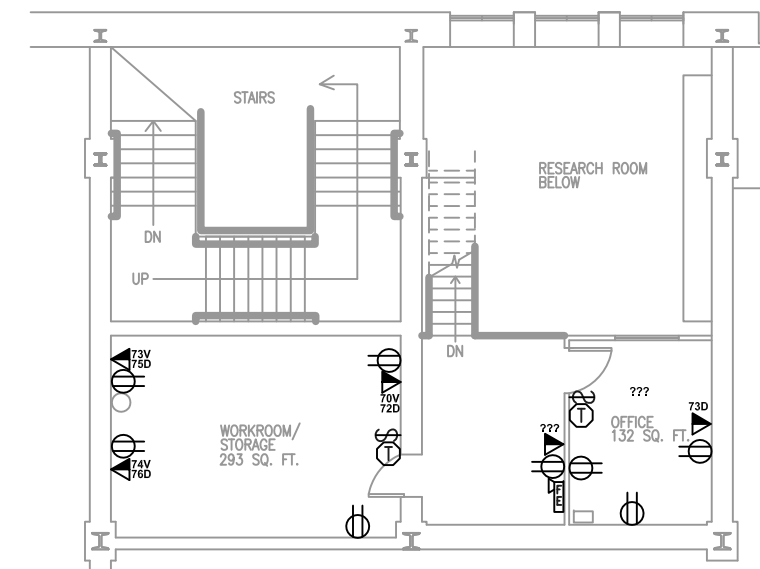


MEZZANINE FLOOR PLAN  
Scale: NTS

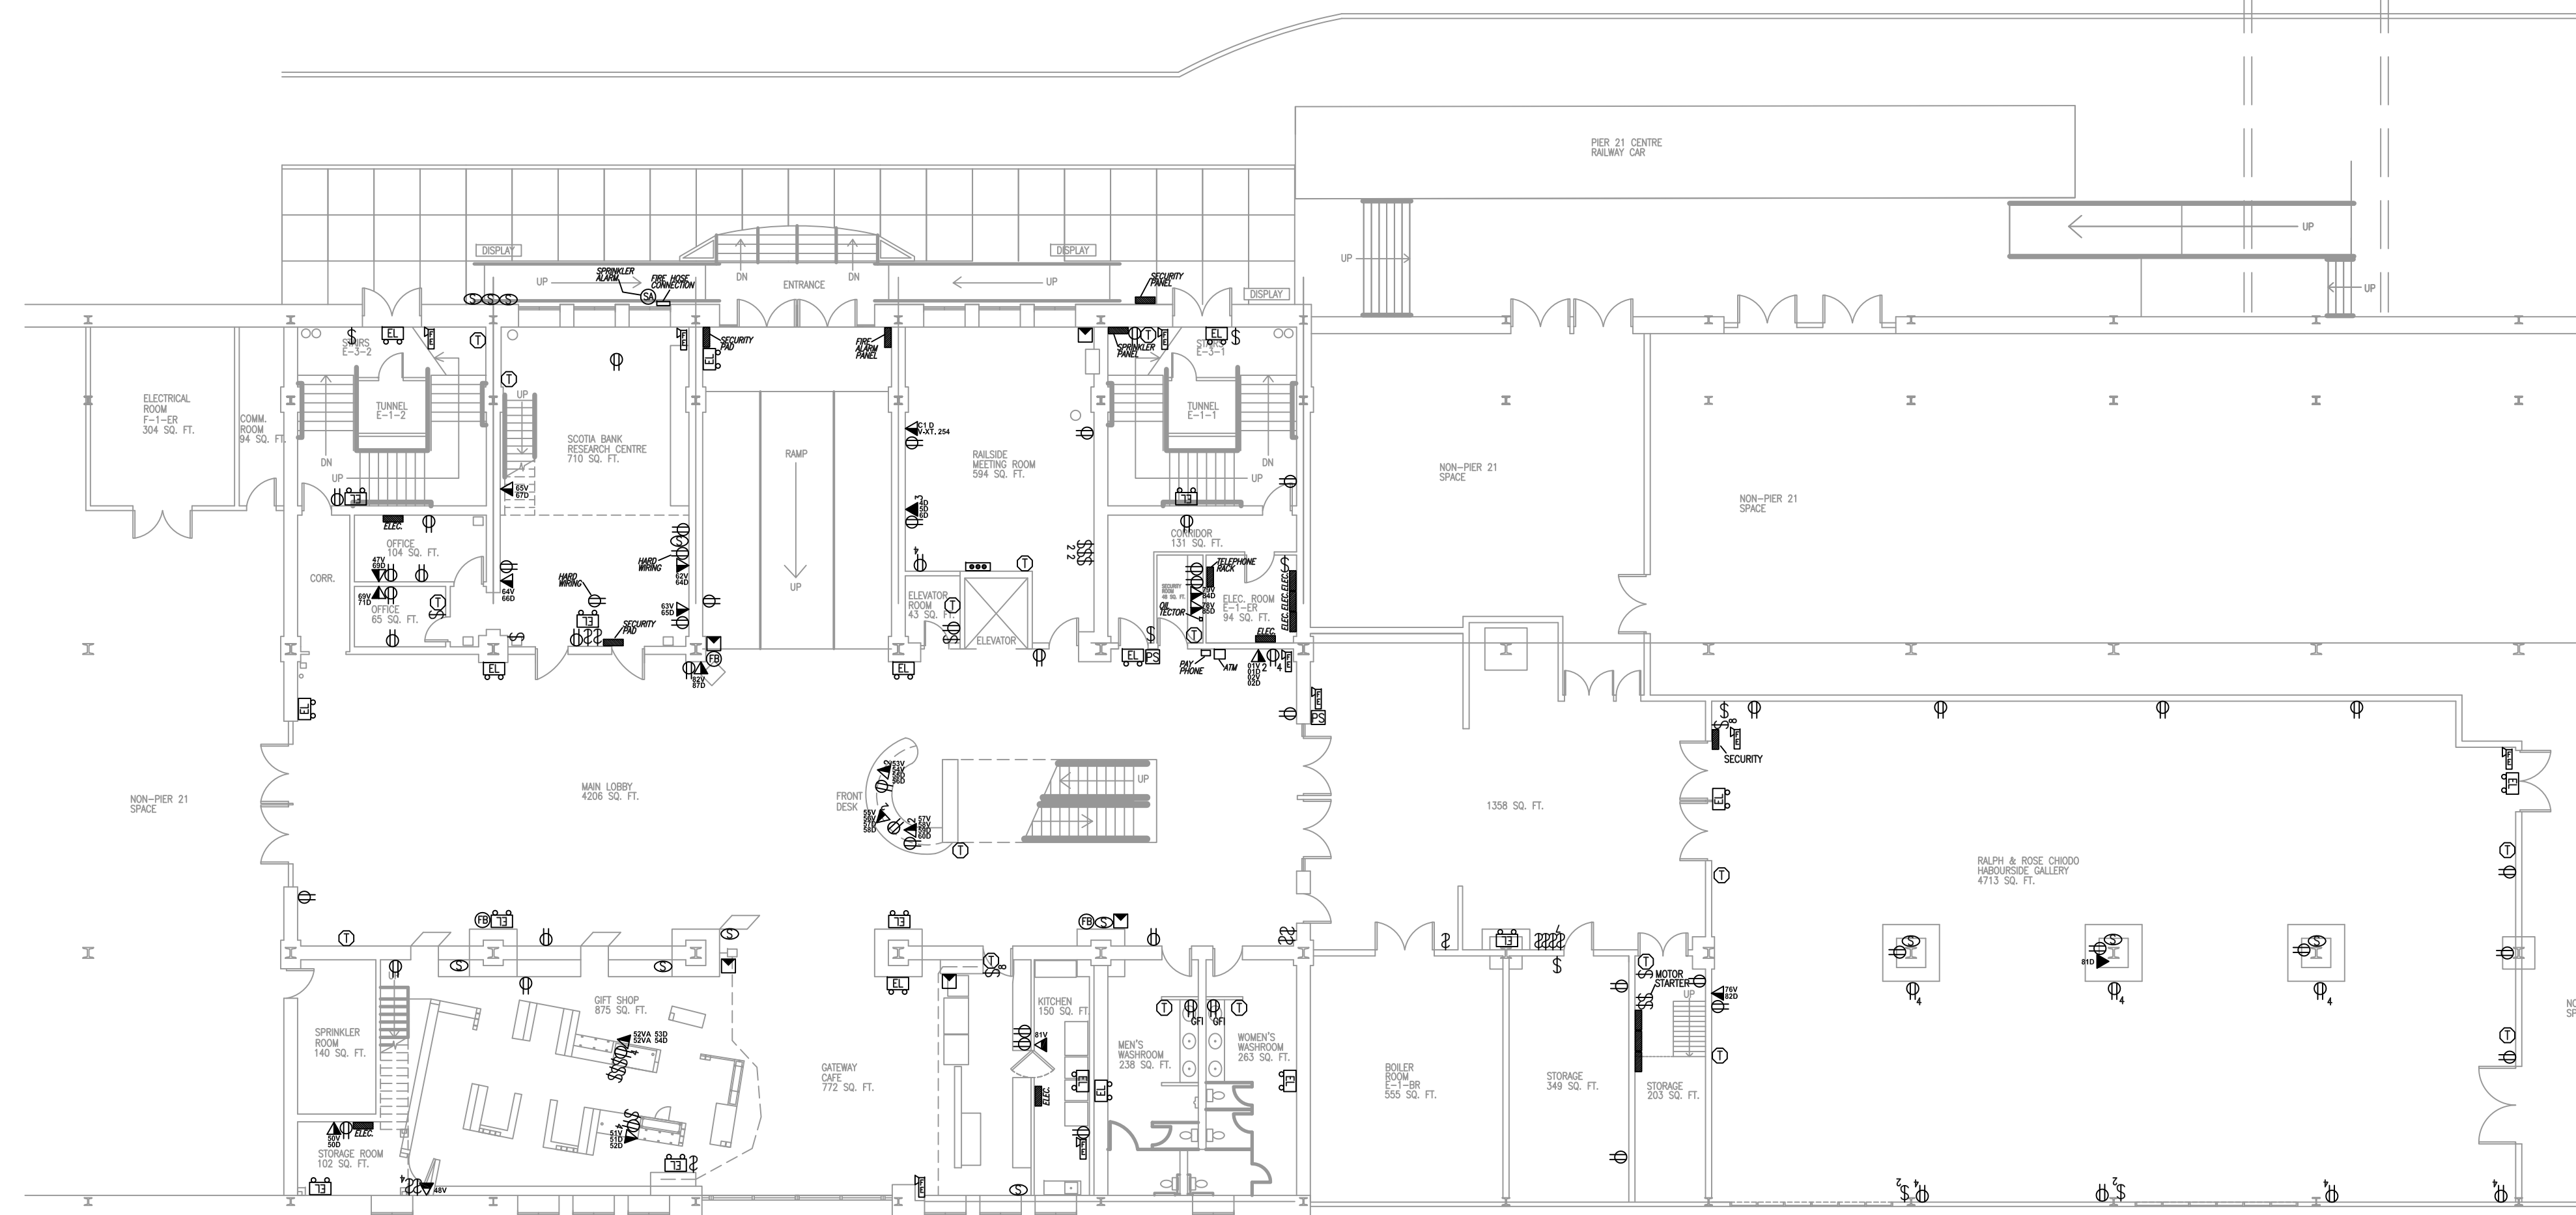

FIRST FLOOR PLAN - NORTH  
Scale: NTS

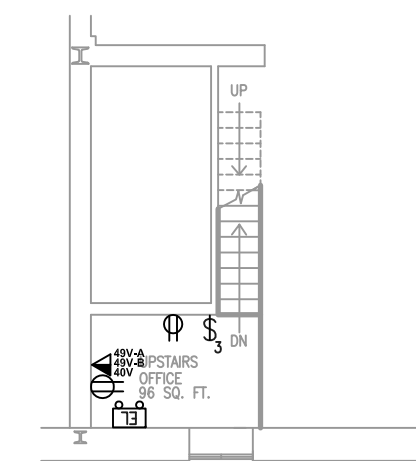

MEZZANINE FLOOR PLAN  
Scale: NTS

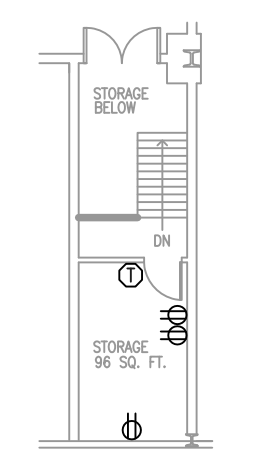

MEZZANINE FLOOR PLAN  
Scale: NTS


FIRST FLOOR PLAN - SOUTH  
Scale: NTS

LEGEND			
⊕	- 110V POWER OUTLET	⊞	- A/V CONNECTION
▲	- DUAL VOICE/DATA OUTLET	⊞	- MOTION SENSOR
▲	- DATA OUTLET	⊞	- FIRE PULL STATION
▲	- VOICE OUTLET	⊞	- FIRE BELL
⊞	- EMERGENCY LIGHT	⊞	- FIRE EXTINGUISHER
\$	- LIGHT SWITCH	⊞	- THERMOSTAT
⊞	- SECURITY CAMERA	■	- PANEL/PAD (AS MARKED)


# ELECTRICAL, MECHANICAL & EMERGENCY PLANS




SECOND FLOOR PLAN – SOUTH – ANNEX  
Scale: NTS

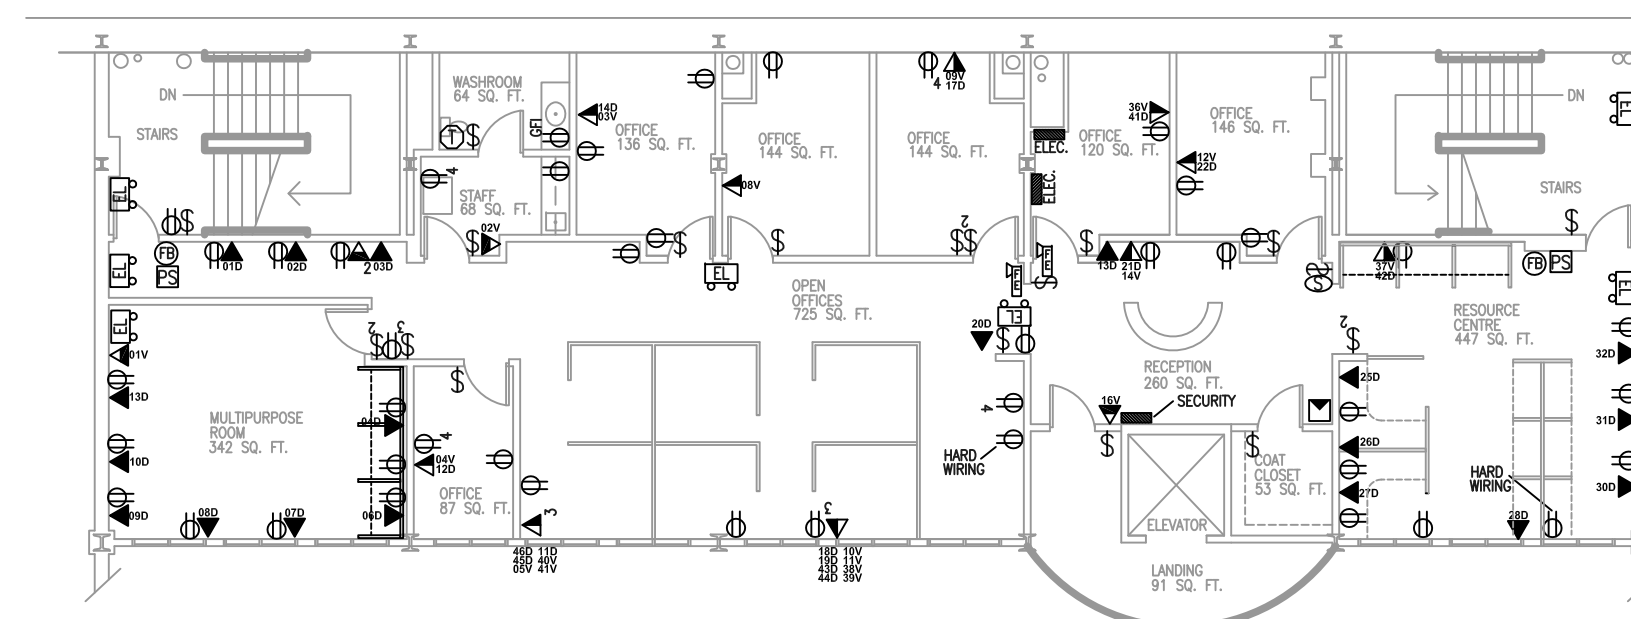

MEZZANINE FLOOR PLAN  
Scale: NTS

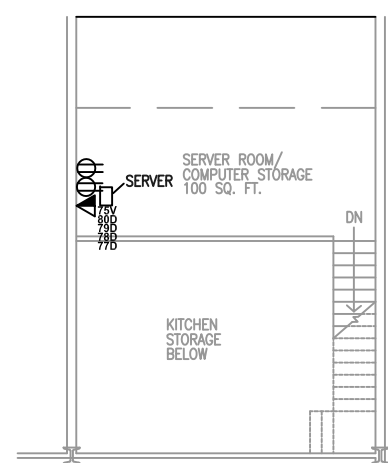

MEZZANINE FLOOR PLAN  
Scale: NTS

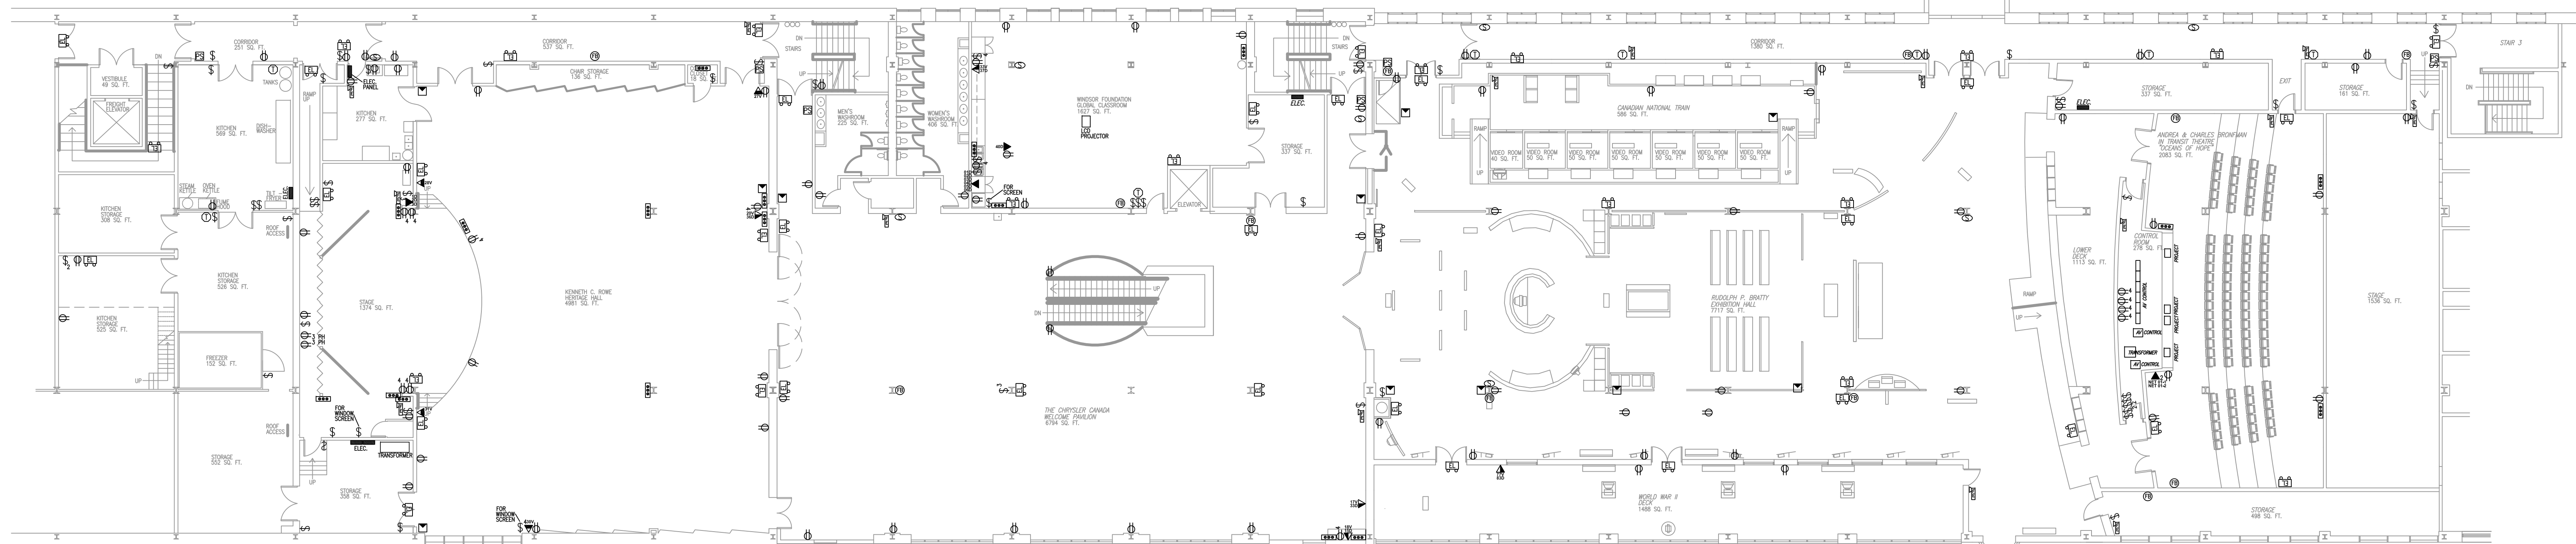

SECOND FLOOR PLAN – NORTH  
Scale: NTS

SECOND FLOOR PLAN – SOUTH  
Scale: NTS



