



LITTLE PLAYGREEN LAKE

LEGEND	
	POWER PANELBOARD - SURFACE MOUNT/FLUSH MOUNT
	UNIT HEATER
	DIRECT CONNECT
ER	EXISTING TO BE REMOVED
EX	EXISTING TO REMAIN

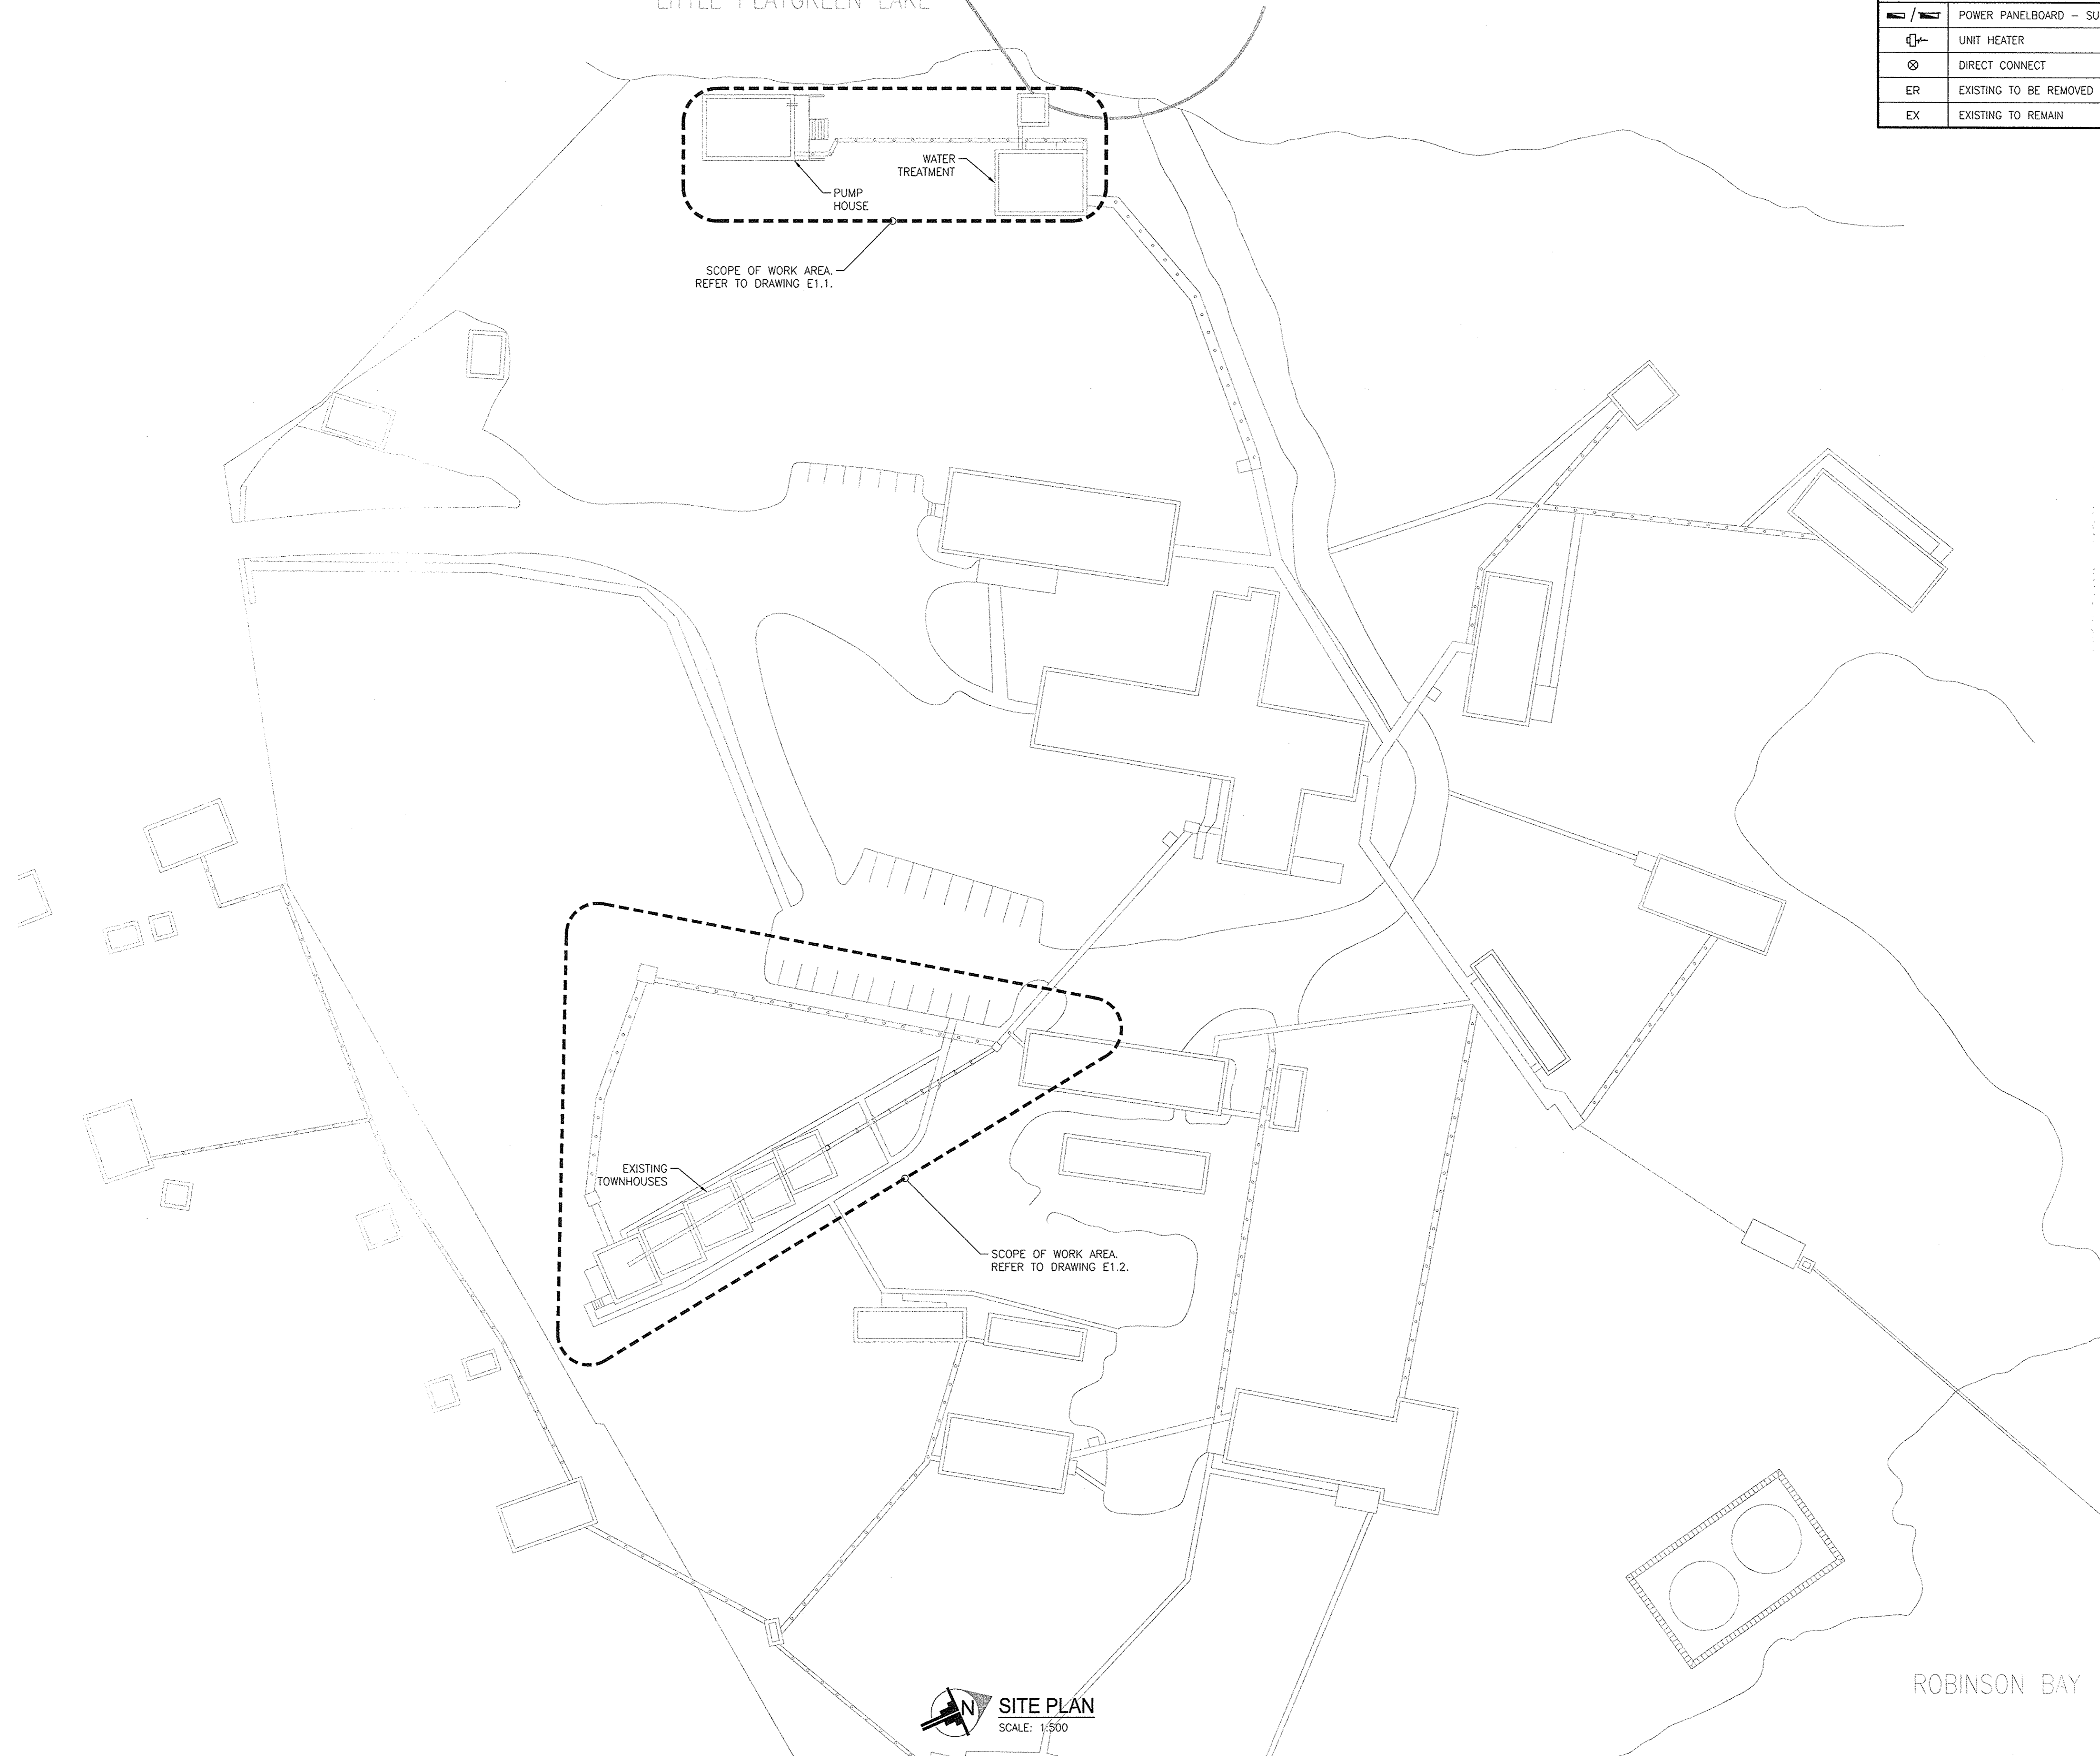

LEVEL	DATE	DESCRIPTION
2	10/8/13	ISSUED FOR TENDER
1	9/26/13	ISSUED FOR REVIEW

REVISIONS:  
 DRAWING NOT TO BE SCALED. ALL DIMENSIONS SHALL BE VERIFIED BEFORE WORK COMMENCES. ANY DISCREPANCIES, OMISSIONS, OR MISSING DIMENSIONS SHALL BE BROUGHT TO THE ATTENTION OF THE CONTRACTOR BEFORE WORK PROCEEDS.  
 ALL STRUCTURAL SYSTEMS AND COMPONENTS SHALL BE APPROVED BY A PROFESSIONAL ENGINEER. GW ARCHITECTURE INC. ASSUMES NO LIABILITY FOR ANY FAILURE IN THE STRUCTURAL SYSTEM OR THE COMPONENTS THERE-OF.

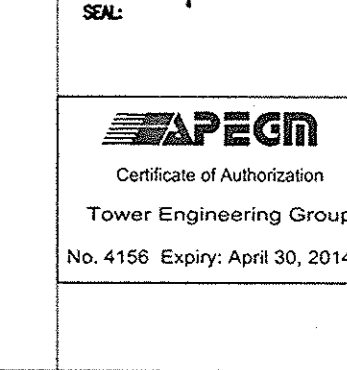

**gw architecture inc.**  
 102-44 PARKERS STREET WATKIN, WATKIN, ONTARIO M2H 1K2 TEL: (905) 880-2373 FAX: (905) 881-1018

STRUCTURAL/MECHANICAL/ELECTRICAL:  
**TOWER ENGINEERING GROUP**  
 TOWER PROJECT NO.: 131319  
 TOWER ENGINEERING GROUP  
 WINNIPEG, MB: (204) 925-1150  
 CALGARY, AB: (403) 235-2655  
 CAMBRIDGE, ON: (519) 957-1944  
 WWW.TOWERENG.CA

PROJECT:  
 NORWAY HOUSE HOSPITAL  
 NORWAY HOUSE, MANITOBA

DRAWING TITLE:  
 ELECTRICAL  
 SITE PLAN

SCALE: AS NOTED	FILE NO: 4.001.003
DATE:	DRAWN BY: E1.0
DRAWN BY: AJ	

**SITE PLAN**  
 SCALE: 1:500

ROBINSON BAY