

FORTRESS OF LOUISBOURG  
NATIONAL HISTORIC PARK

RESTORATION ARCHITECT  
APPROVED & RECOMMENDED Dec. 20/77  
APPROVED & RECOMMENDED  
CHECKED FOR HISTORICAL ACCURACY

revisions date

- LEGEND:
- SD1 - AUTOMATIC SMOKE DETECTOR TYPE I S. MOUNT.
  - SD2 - AUTOMATIC HEAT DETECTOR 135°F & RATE OF RISE.
  - SD3 - AUTOMATIC HEAT DETECTOR 135°F. FIXED TEMPERATURE.
  - F - MANUAL PULL STATION.

A detail no. détail no.  
B location dwg. no. sur dessin no.  
C drawing no. dessin no.

drawn by / tracé par scale / échelle  
JFK 1/4" = 1'-0"

designed by / établi par

checked by / vérifié par

job captain / chef du projet date

responsible officer / officier responsable date

project title titre du projet


TOWNSITE BLOCK 17  
DUHAGET  
HOUSE

drawing title titre du dessin


FIRE ALARM SYSTEM

reference no. no de référence


dwg no. dessin no.  
HAFLR 73/P2 6a

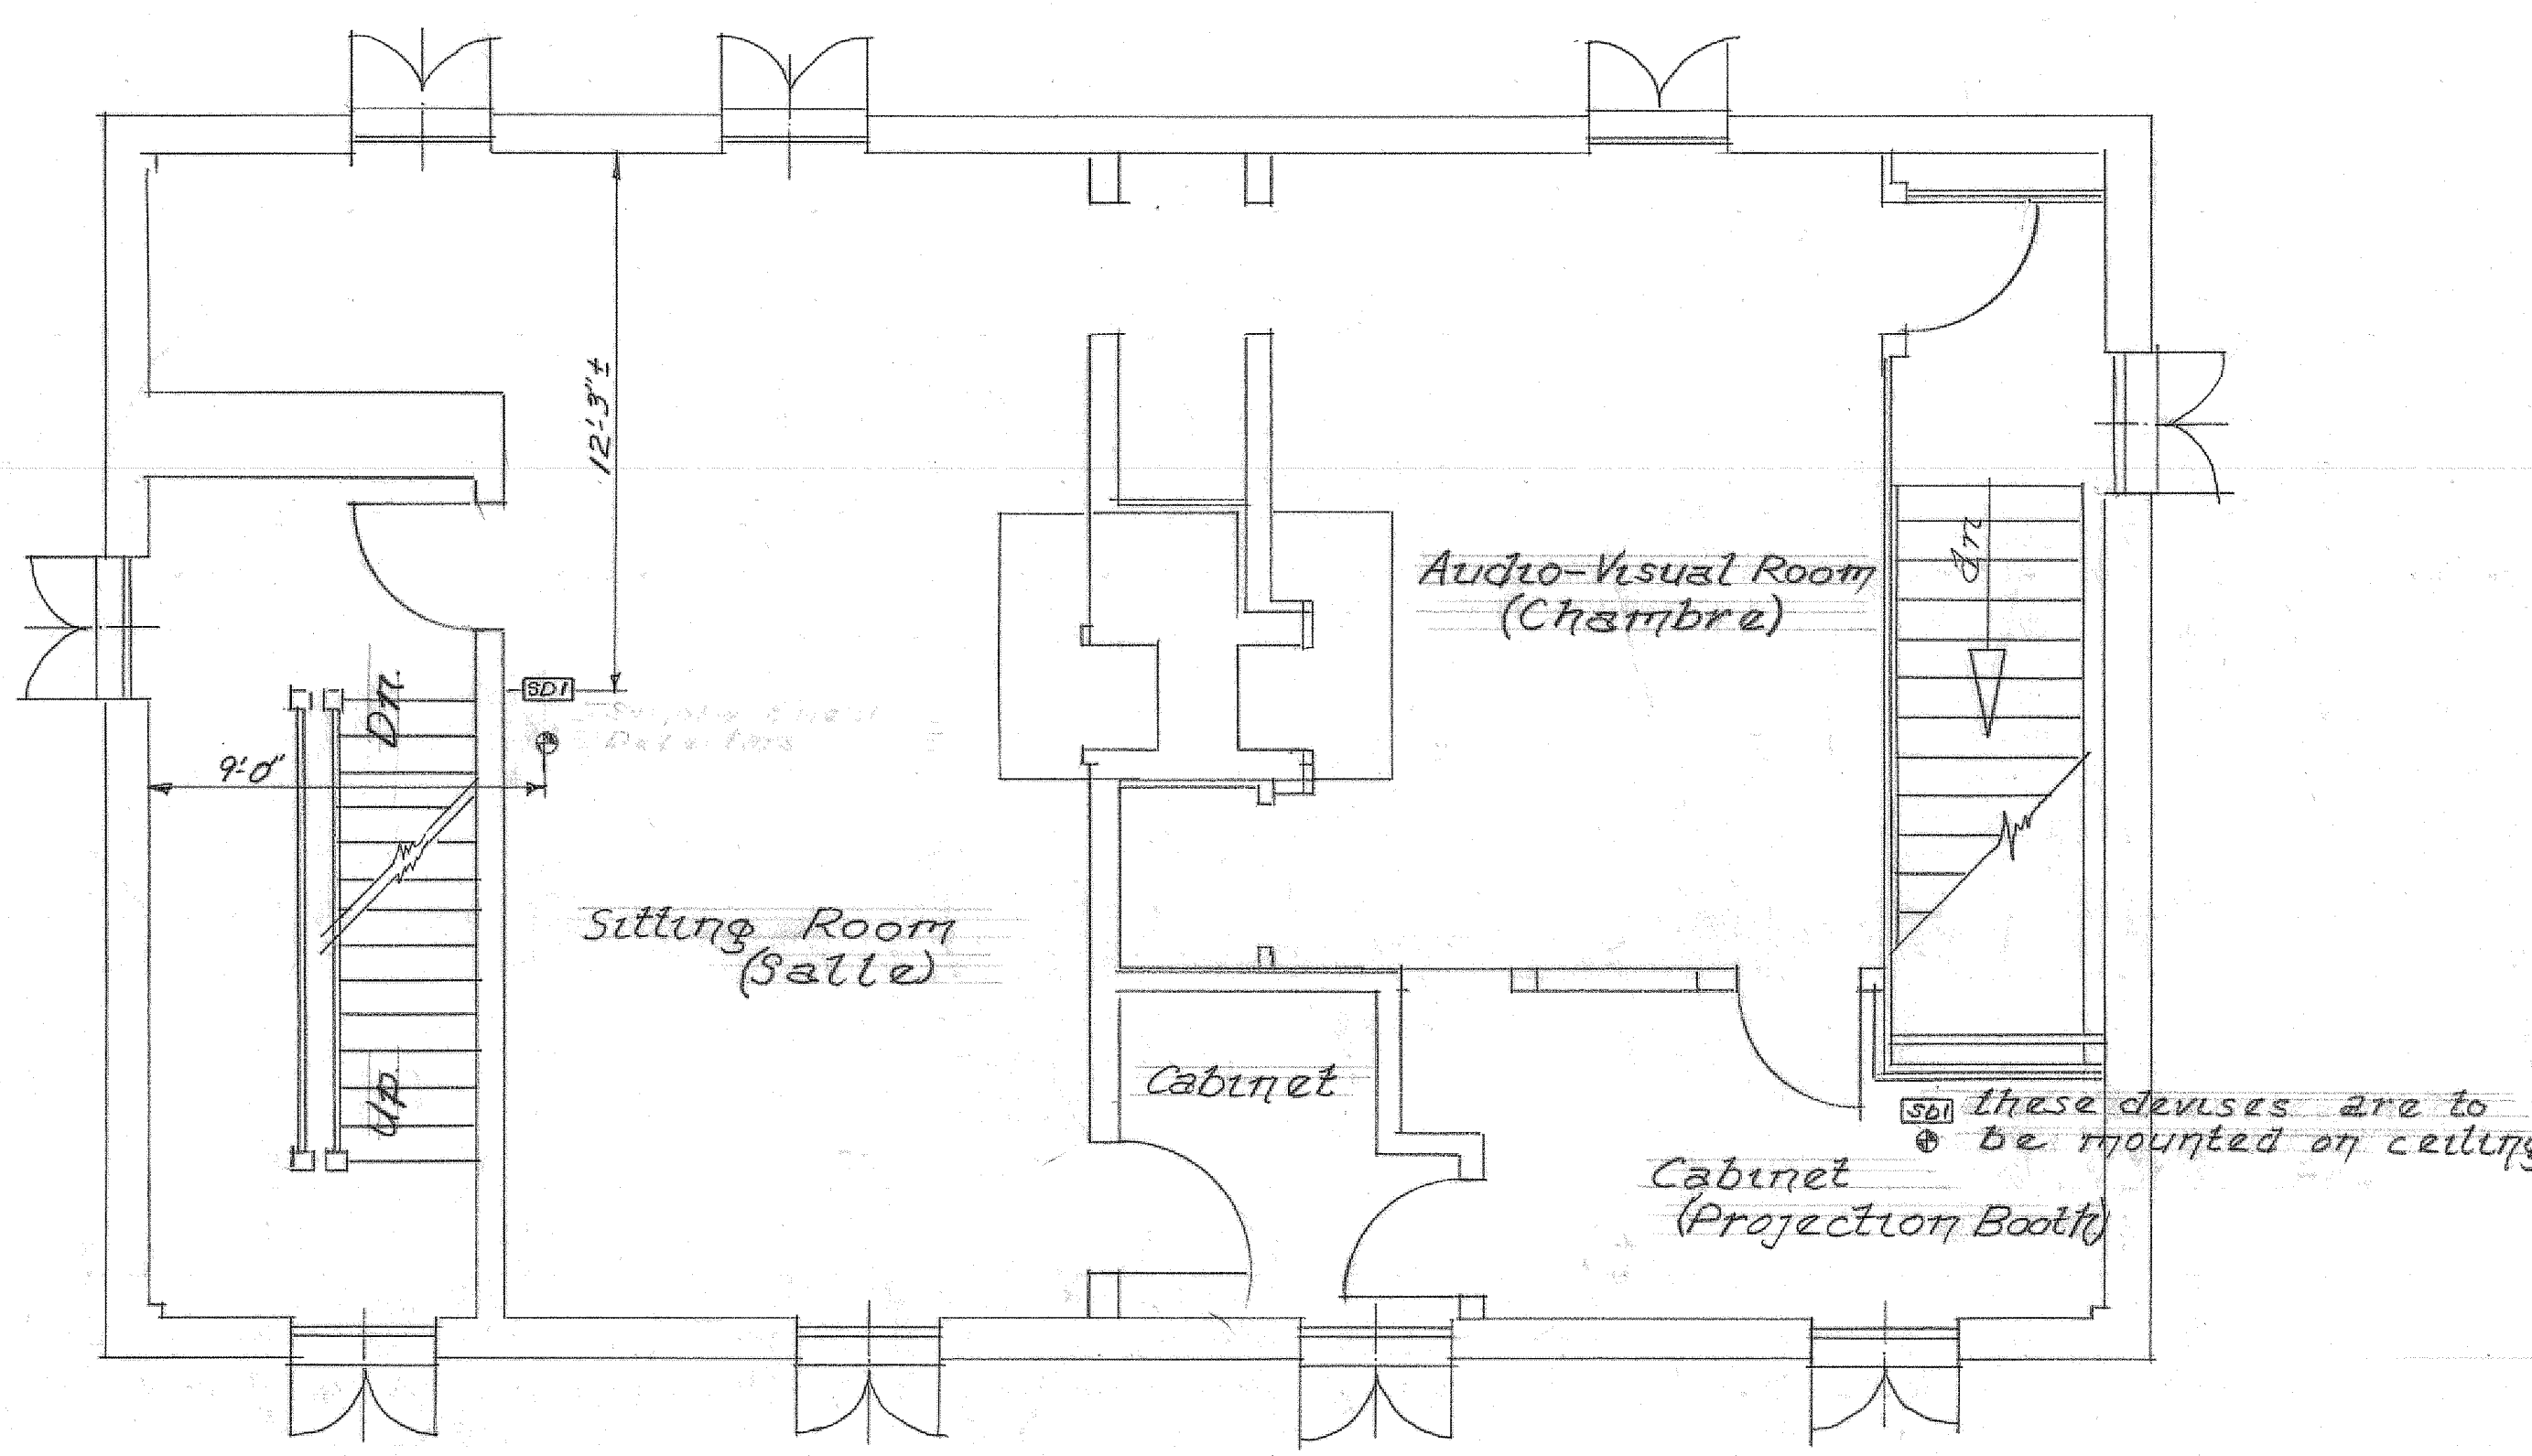


First Floor

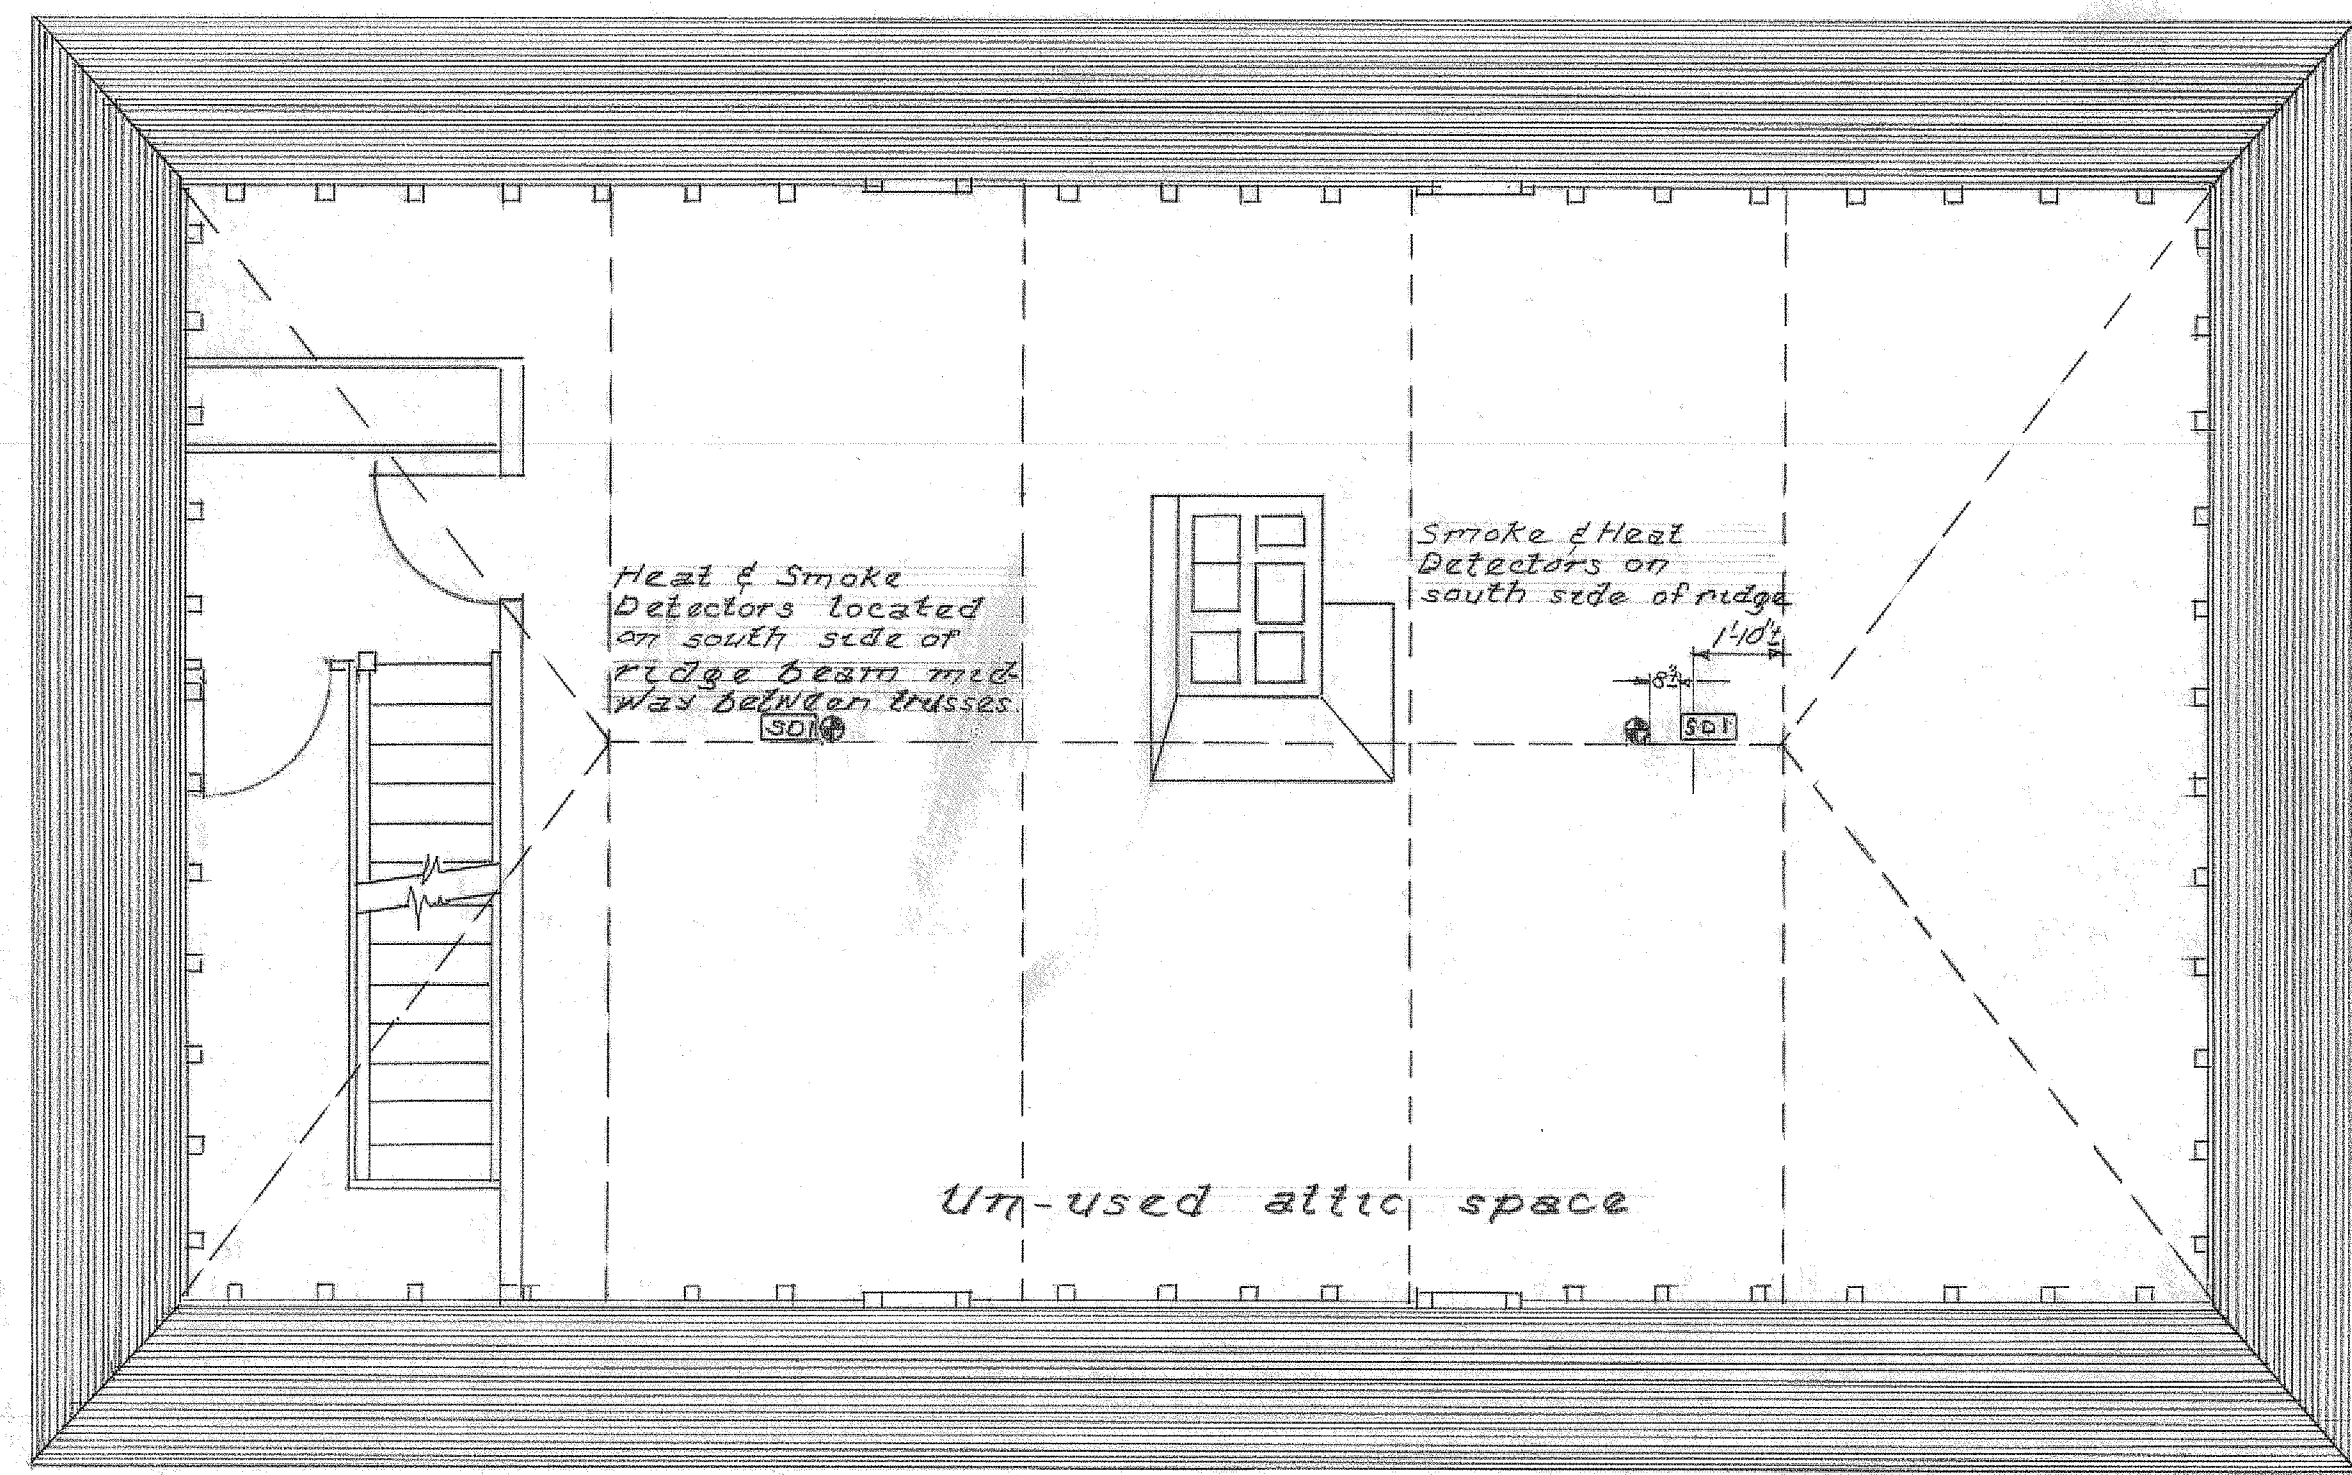

Attic Floor

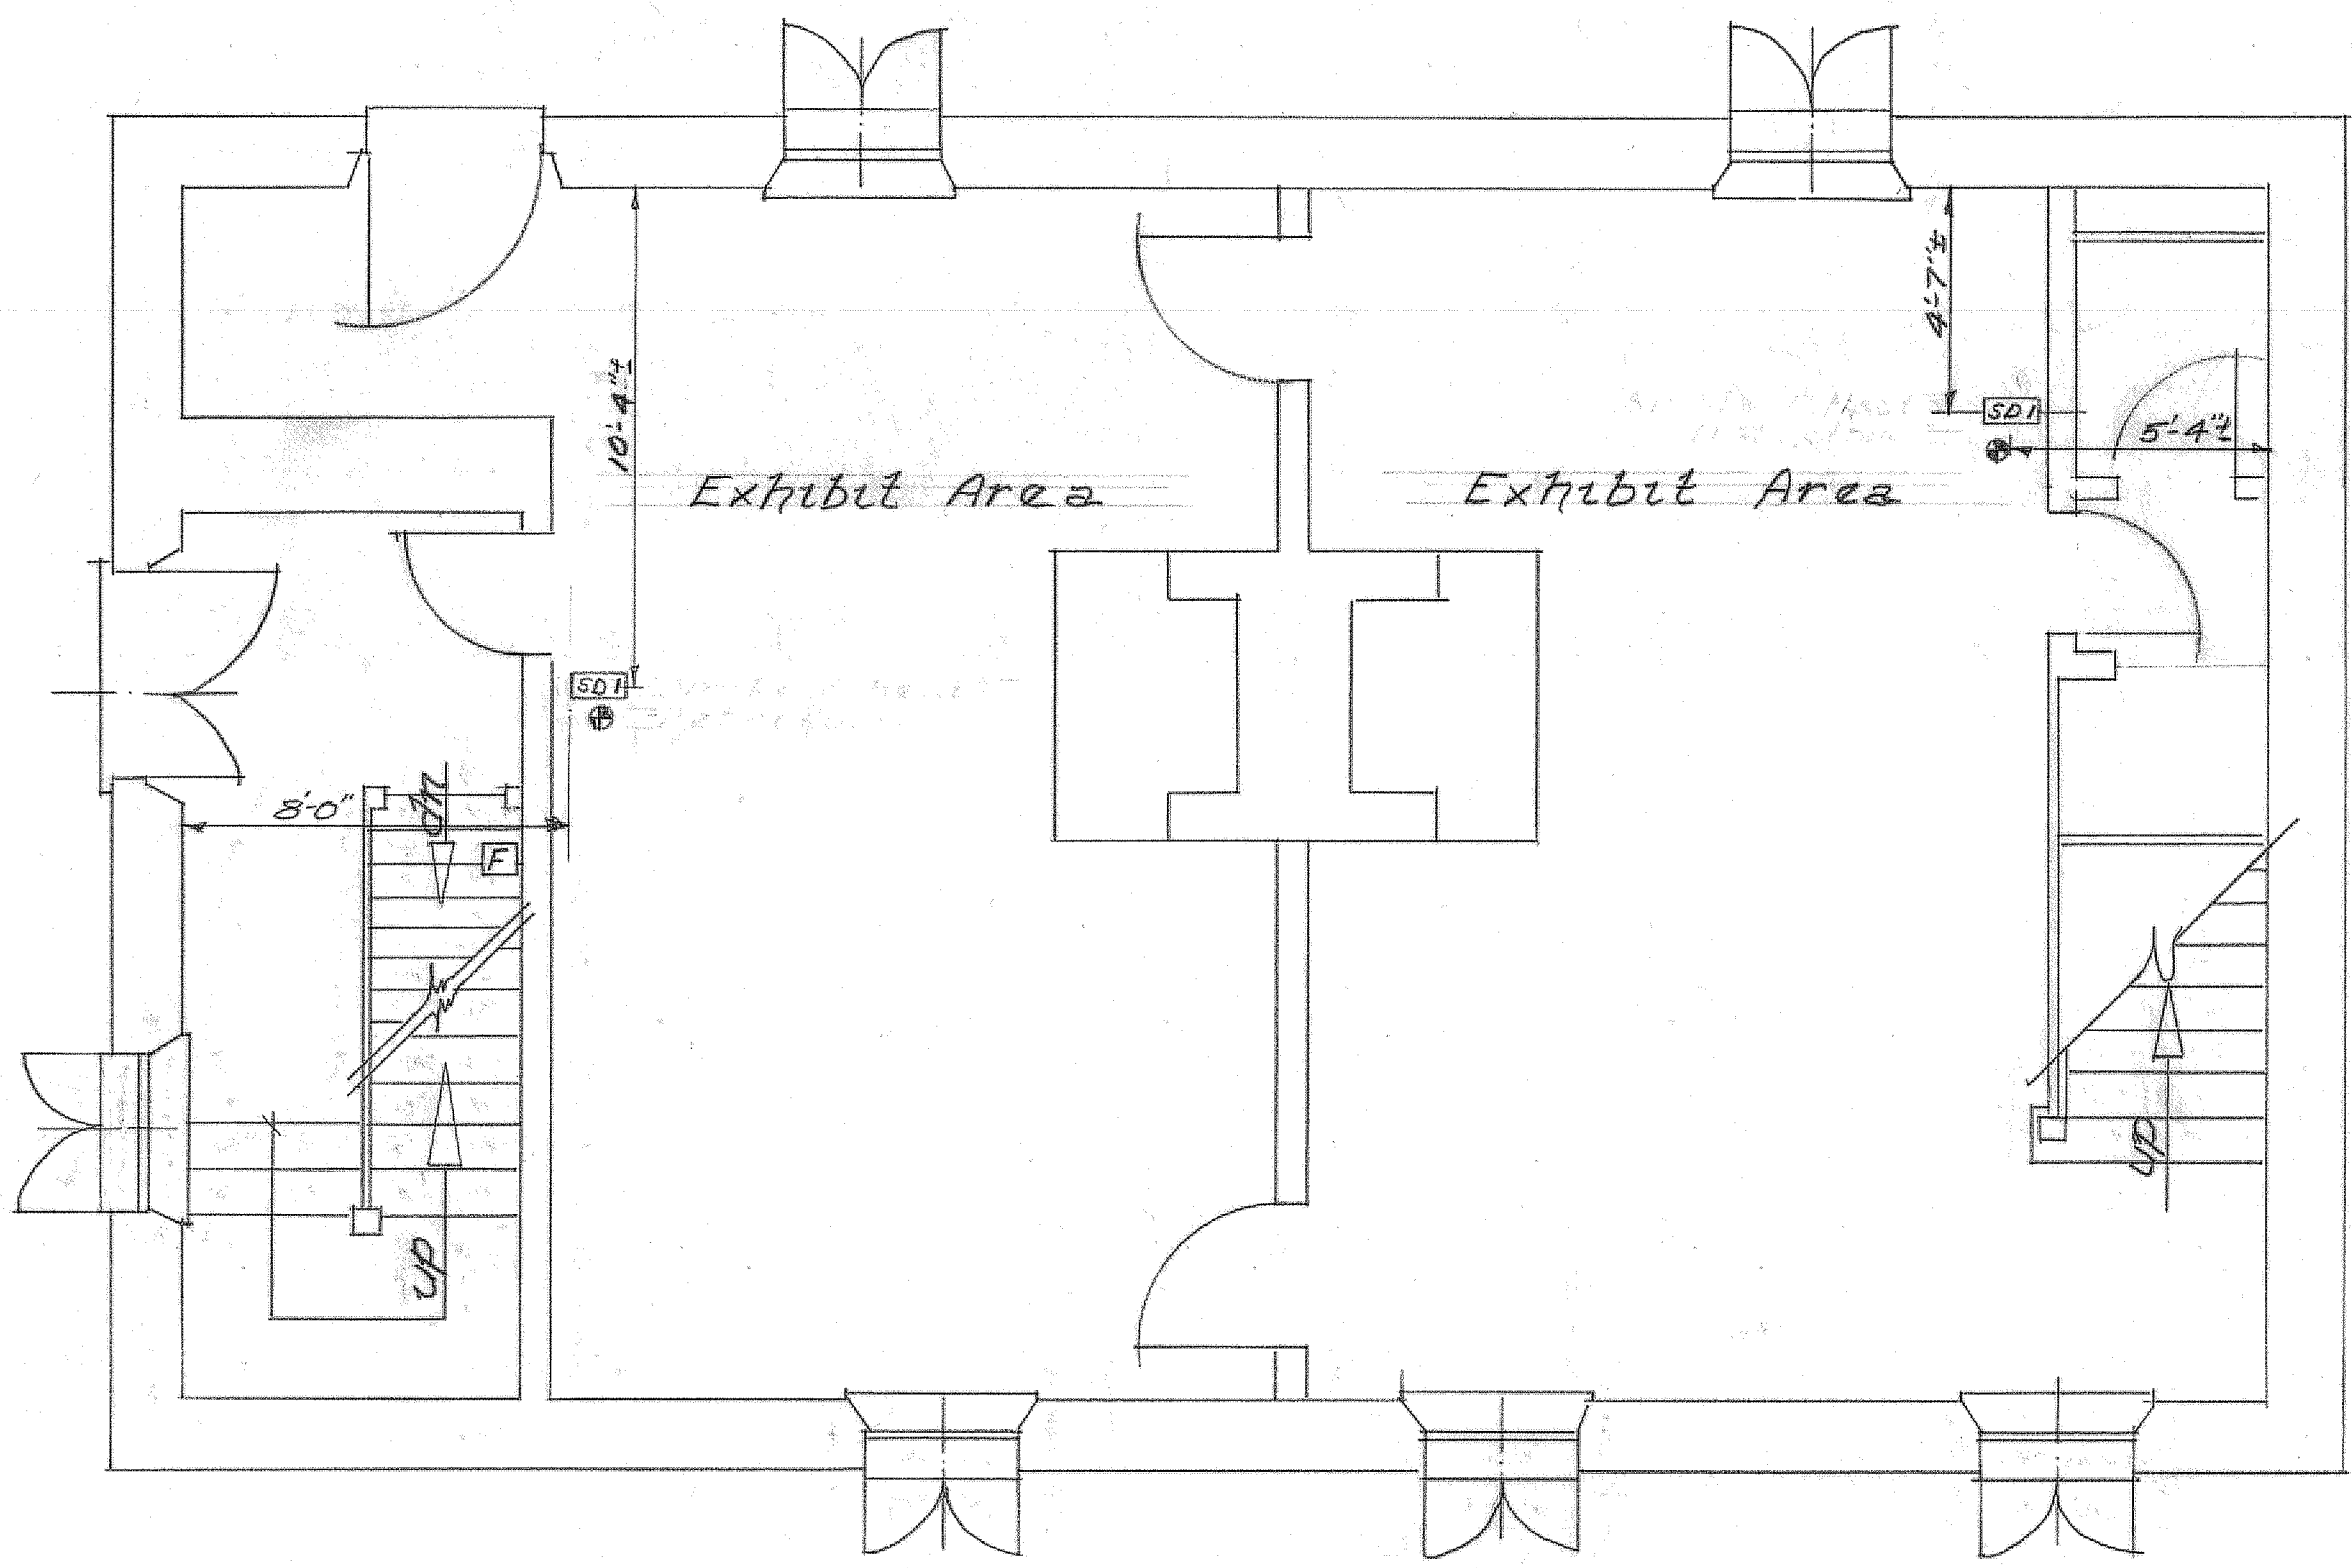

Ground Floor

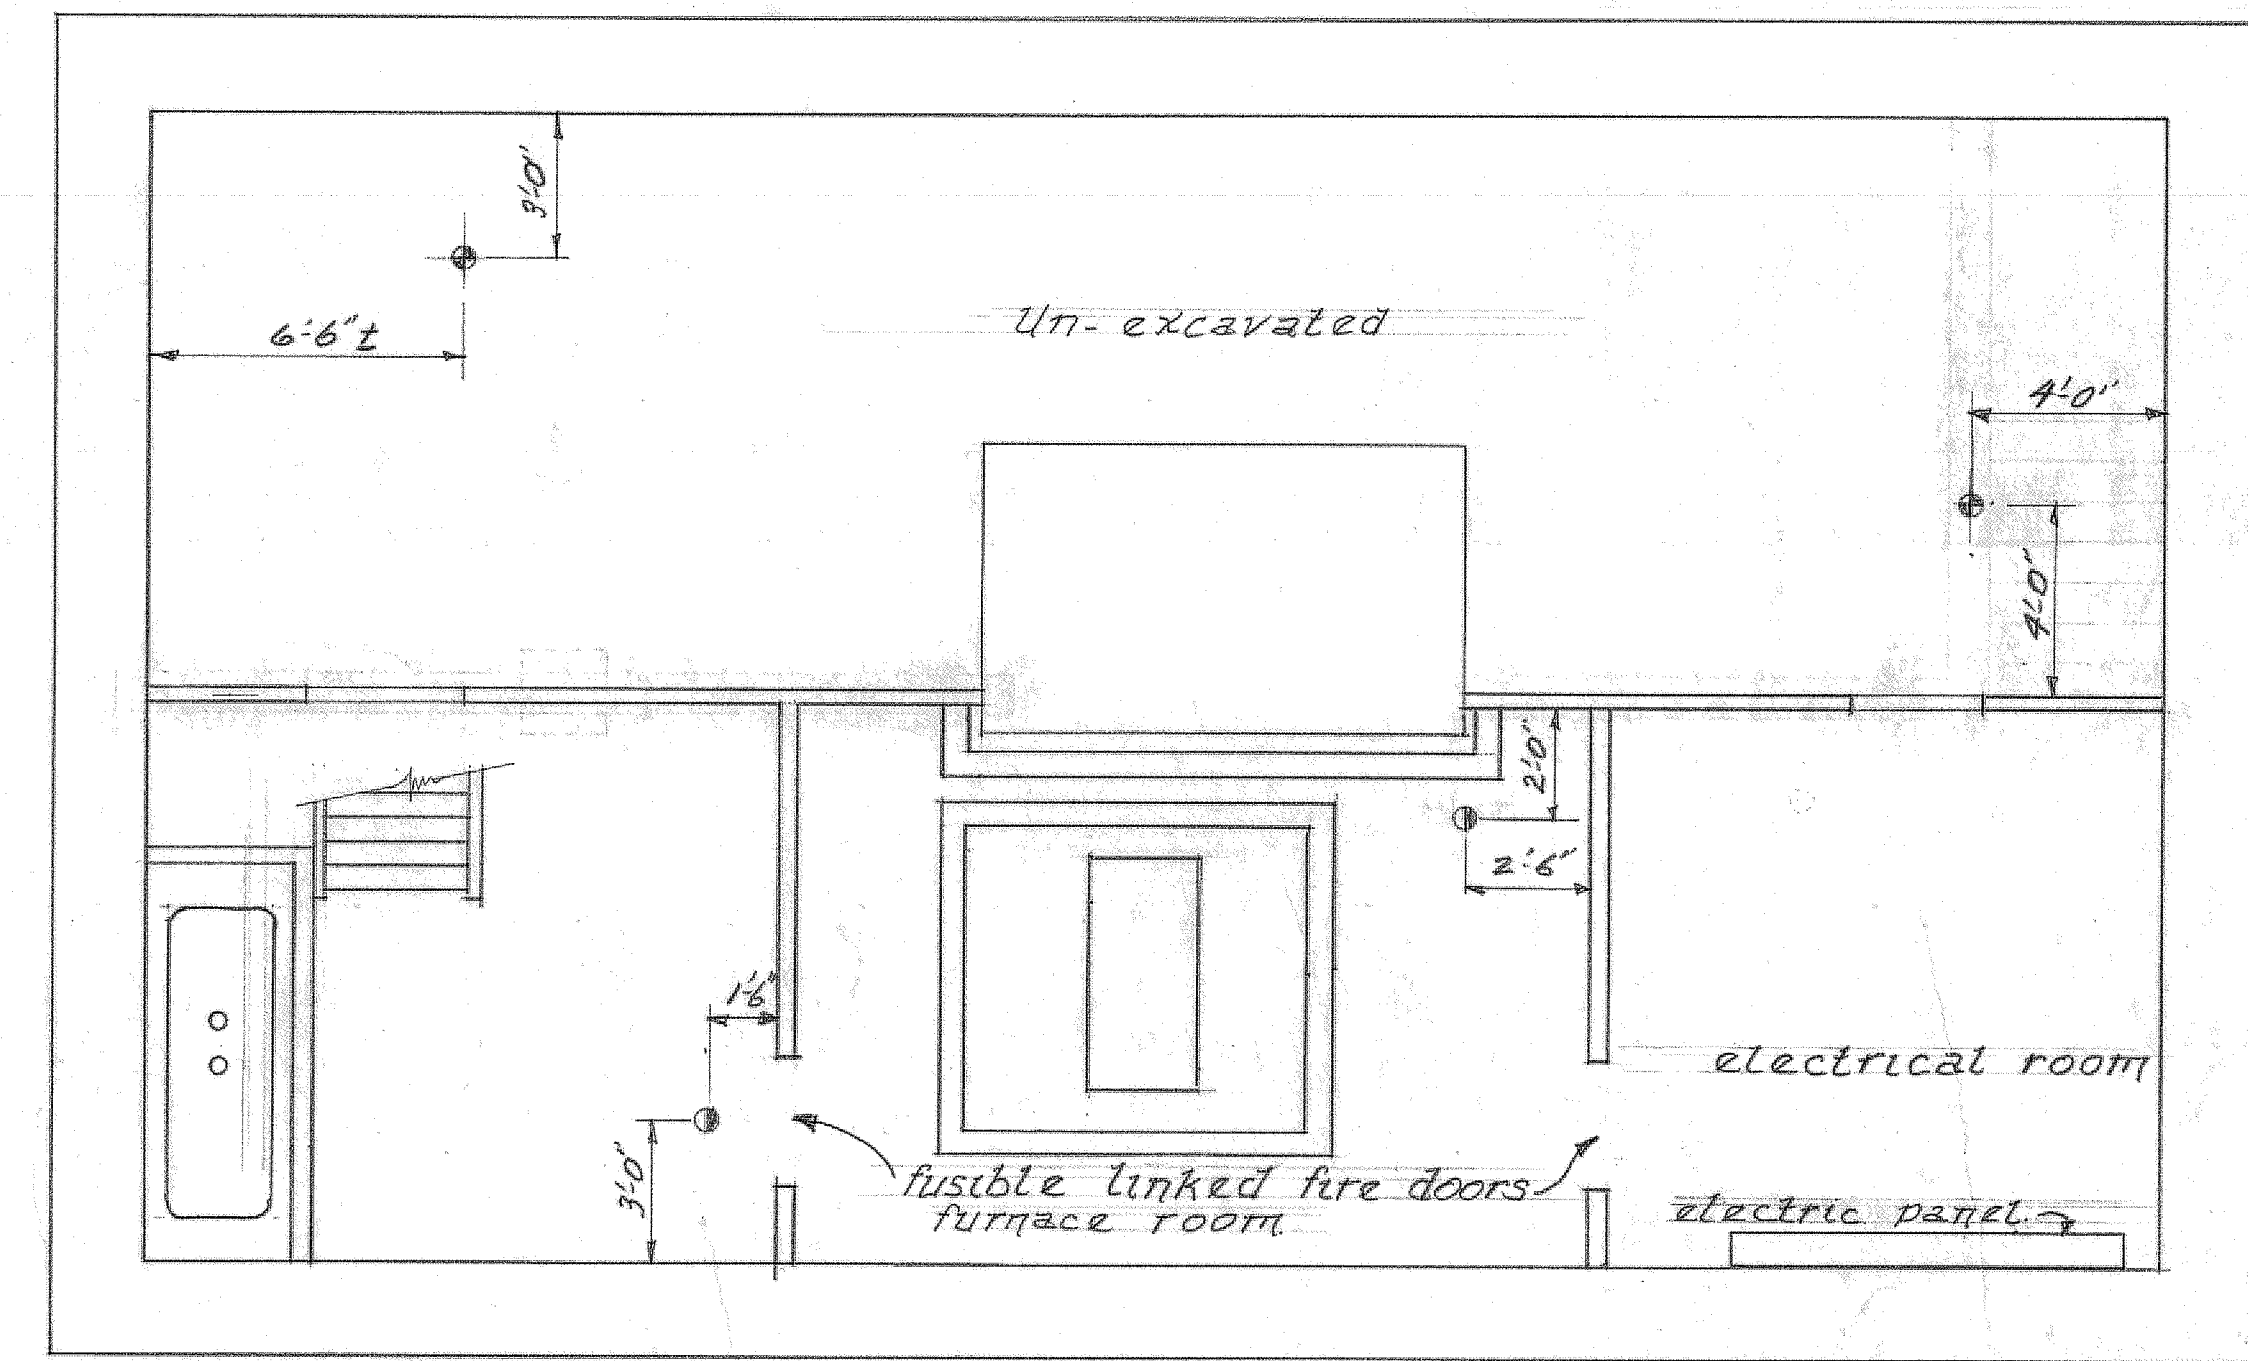

Basement