


LOCATION PLAN
SCALE: NTS

LIST OF DRAWINGS - LISTE DES DESSINS

- COVER SHEET
- M-01 - BAMFIELD LIFEBOAT STATION - SITE LAYOUT AND PIPING DETAILS
- E-01 - SITE PLAN, GROUNDING GRID AND LEGEND
- E-02 - SINGLE LINE DIAGRAMS
- E-03 - LIGHTING DETAILS AND TRENCH SECTION
- A-01 - SITE PLAN PAVING AND STAIRS
- A-02 - DETAILS PAVING AND STAIRS

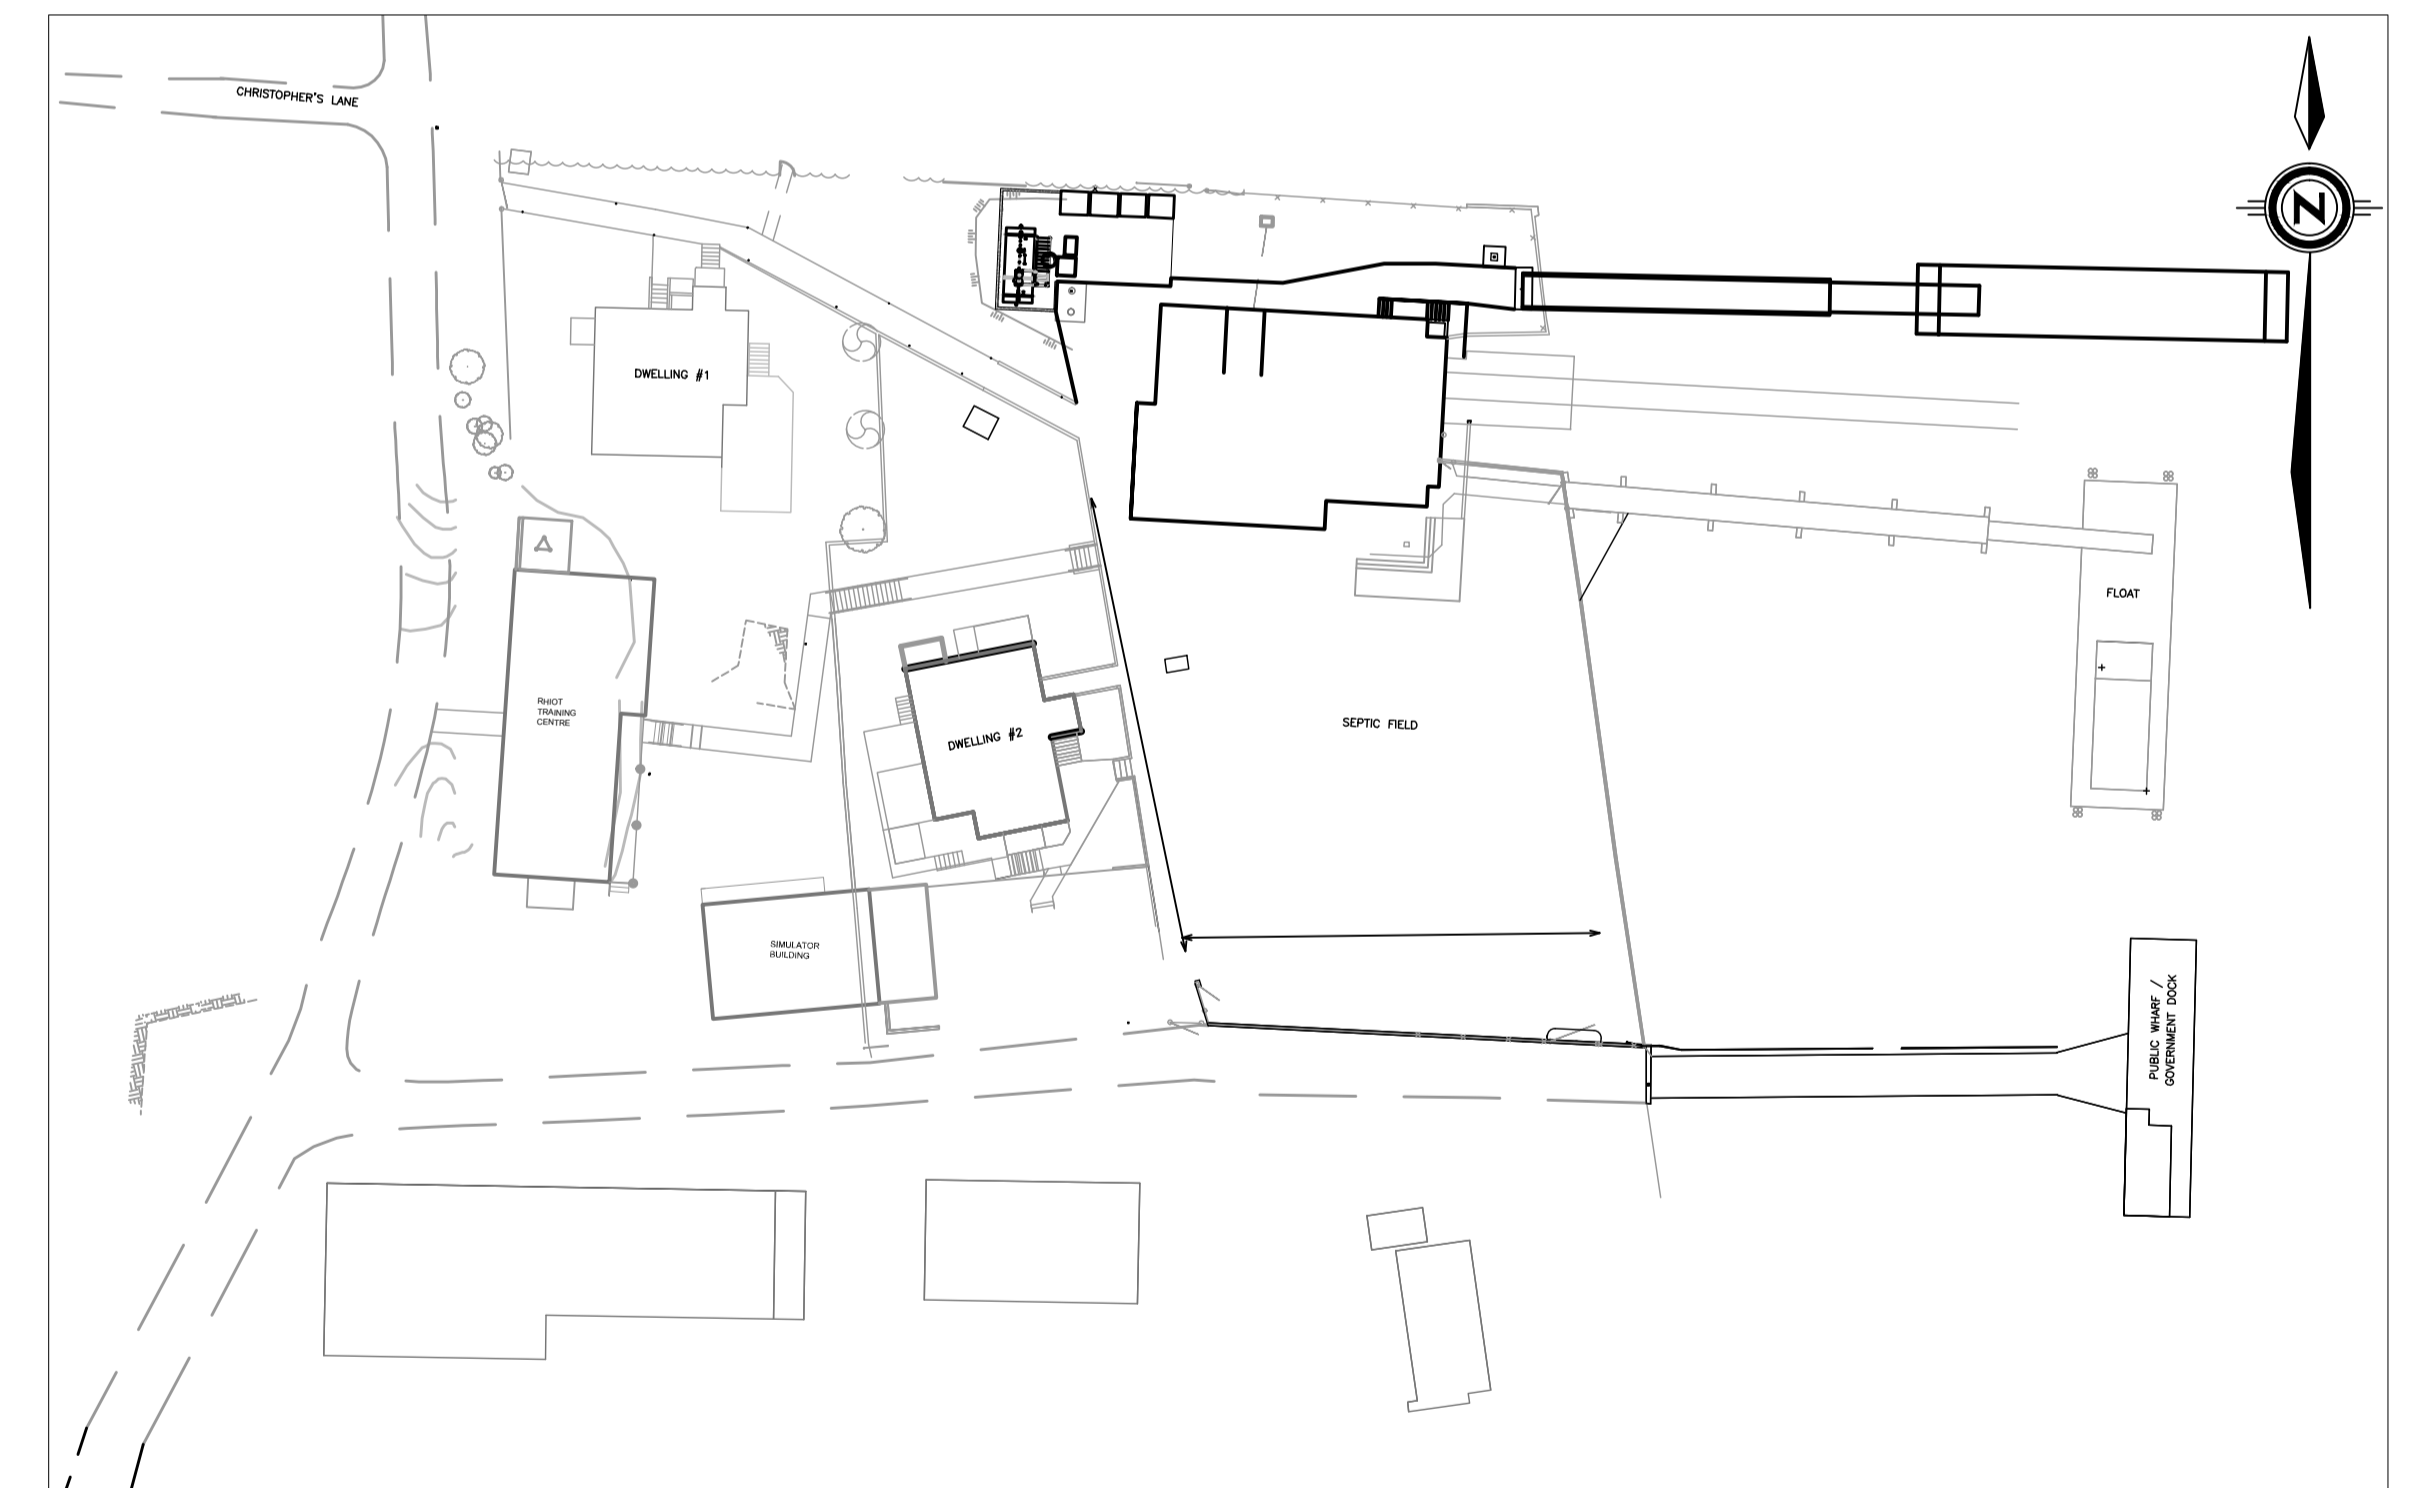

SITE PLAN
SCALE: 1:500



GENIVAR PROJECT # 121-24918-01

400-401 GARBALLY ROAD
VICTORIA (BRITISH COLUMBIA) CANADA V8T 5M3
TEL.: 250-384-5510 | FAX: 250-386-2844 | WWW.GENIVAR.COM

F1700-130551



FISHERIES AND OCEANS CANADA
REAL PROPERTY AND SAFETY AND SECURITY

BAMFIELD LIFEBOAT STATION

COVER SHEET

SCALE
1:50
START DATE
7/31/2013
DRAWING NUMBER



SUITE 400, 401 GARBALLY ROAD
VICTORIA (BRITISH COLUMBIA)
CANADA V8T 5M3
PHONE: 250-384-5510 FAX: 250-386-2844
WWW.GENIVAR.COM

2 2013/10/08 ISSUED FOR CONSTRUCTION
1 2013/09/17 ISSUED FOR CLIENT REVIEW

NO. DATE REVISIONS

DESIGNED
DMH
DRAWN
SG
CHECKED
RECOMMENDED
APPROVED

DWG. NO. DRAWING REFERENCES

NOTES