

PROJECT TITLE

Burlington, Ontario
Canada Centre for Inland Waters – CCIW
867 Lakeshore Road, Burlington, ON L7R-4A6

Library Renovation
Project Number R.061475.001

Addendum No. 3, dated 2014-01-29

This addendum shall form part of the documents referred to in the “Bid and Acceptance Form - Lump Sum.

This addendum is four pages in length and consists of two parts: Contract Amendments (Drawings/ Specification) and Bidder questions.

Part I – Contract Amendments (Drawings and Specifications)

DRAWINGS

1. Electrical drawings revisions and clarifications as prepared by Crossey Engineering Ltd.
(Refer to attached ELECTRICAL ADDENDUM NO. E-01, dated January 29, 2014 – 3 pages)

Part II – Bidders questions

BIDDERS QUESTIONS

Question 1:

On the electrical drawings and specs. there are not manufactures listed for the lighting or Low voltage relay panel. Can you please ask for who we should be contacting for lighting or who is specified?

Answer 1:

Refer to attached ELECTRICAL ADDENDUM NO. E-01 for response

Question 2:

Provide meaning of symbols ‘P’ and ‘SP’ – Electrical drawings

Answer 2:

Refer to attached ELECTRICAL ADDENDUM NO. E-01 for response

END OF ADDENDUM No.2



ELECTRICAL ADDENDUM NO. E-01

BURLINGTON LIBRARY RENOVATION
CANADA CENTRE for INLAND WATERS
867 Lakeshore Road, Toronto ON

Crossey Engineering Ltd.

2255 Sheppard Ave. E. Suite E-331
North York, Ontario M2J
Job No: 12412

Date: January 29, 2014

Total Number of Pages: 3

This Addendum becomes part of the General Contract Bid Documents and will be considered to have been included in the Tender. Additions, deletions, and revisions shall be incorporated in the Bid Documents as hereinafter described.

1.0 DRAWINGS

1.1 Refer to Drawing E-001: Electrical Legends and Drawing List

- 1.1.1 Add symbol " P" to Power legend that denotes power pole.
- 1.1.2 Add a general note to say "Existing base building Fire Alarm System manufacturer is Chubb Edwards and Existing Power distribution equipment manufacturer is Federal Pioneer"

1.2 Refer to Drawing E-002: Electrical Details & Schedules

- 1.2.1 Add a note to Luminaire Schedule to say "Electrical contractor are free to select Lighting fixtures that meet the requirements of the specifications as it is performance base"
- 1.2.2 Add a note to Luminaire Schedule to say "New Relay Panel to match existing Centralized lighting control. Product Delta DLC-PXXX Series, suitable for controlling up to 36 lighting zones, switching a maximum of 144 lighting relays".

1.3 Refer to Drawing E-003: Electrical Panel Schedules

- 1.3.1 Add a detail of new Telecommunication room layout as shown as per SKE-003x1.

1.4 Refer to Drawing E-302: Second floor New Power & System Plan

- 1.4.1 Revise the Telecommunication routing as indicated as per SKE-302x1.
- 1.4.2 Add relay panel LP-A located beside new panel LP-2C1 as indicated as per SKE-302x1.
- 1.4.3 Delete symbol "SP" from all Power & System plans.

END OF ADDENDUM E-01




Public Works and
Government Services Canada
Architectural and Engineering Services
Ontario Region

Travaux publics et
Services gouvernementaux Canada
Services d'architecture et de génie
Région de l'Ontario

CROSSEY
ENGINEERING
LTD.



2255 Sheppard Avenue. E.
Suite E-331
North York, On M2J 4Y1
(416) 497.3111 fax (416) 497.7210

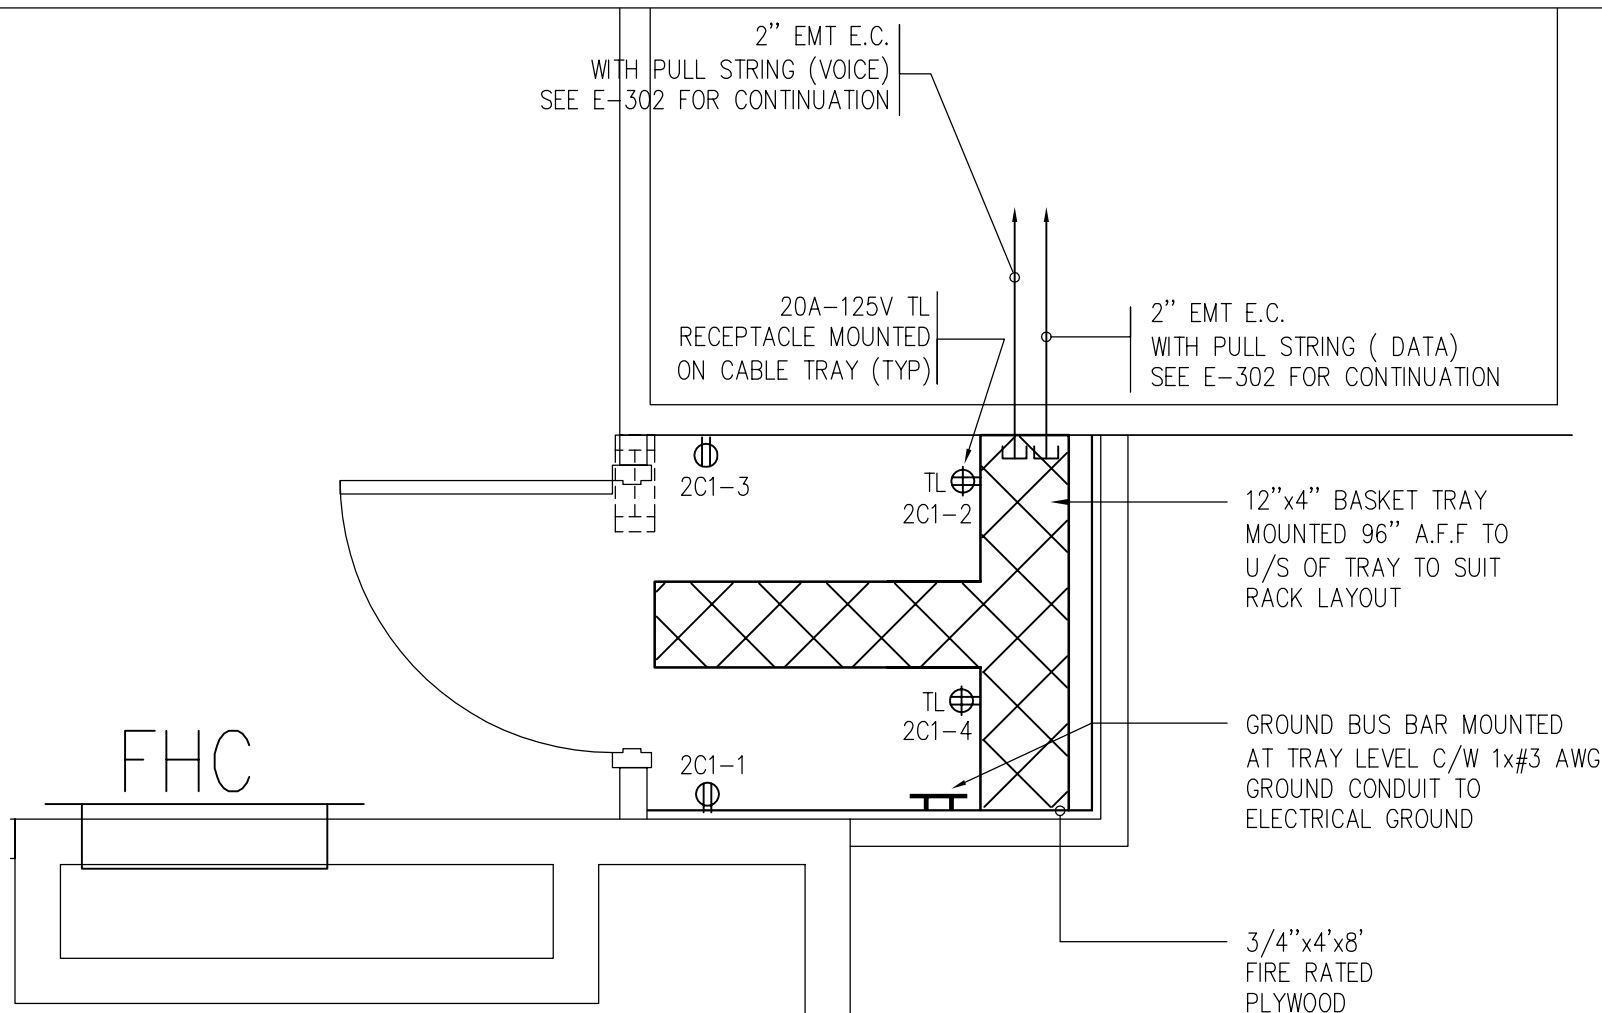

Project title: **BURLINGTON**
CANADA CENTRE FOR INLAND WATERS
867 LAKESHORE ROAD

LIBRARY RENOVATION

Drawing title: **ADDENDUM E-01**
TELECOMMUNICATION ROOM LAYOUT

Designed by : **LN**

Drawn by : **LN**

Approved by : **NN**

Tender:

Plot scale : **NTS**


Drawing no.: **SKE-E003X01**

Project no.: **R.061475.001**

Project date : **13-02-20**

Date plotted :

Cadd file : **E-003**

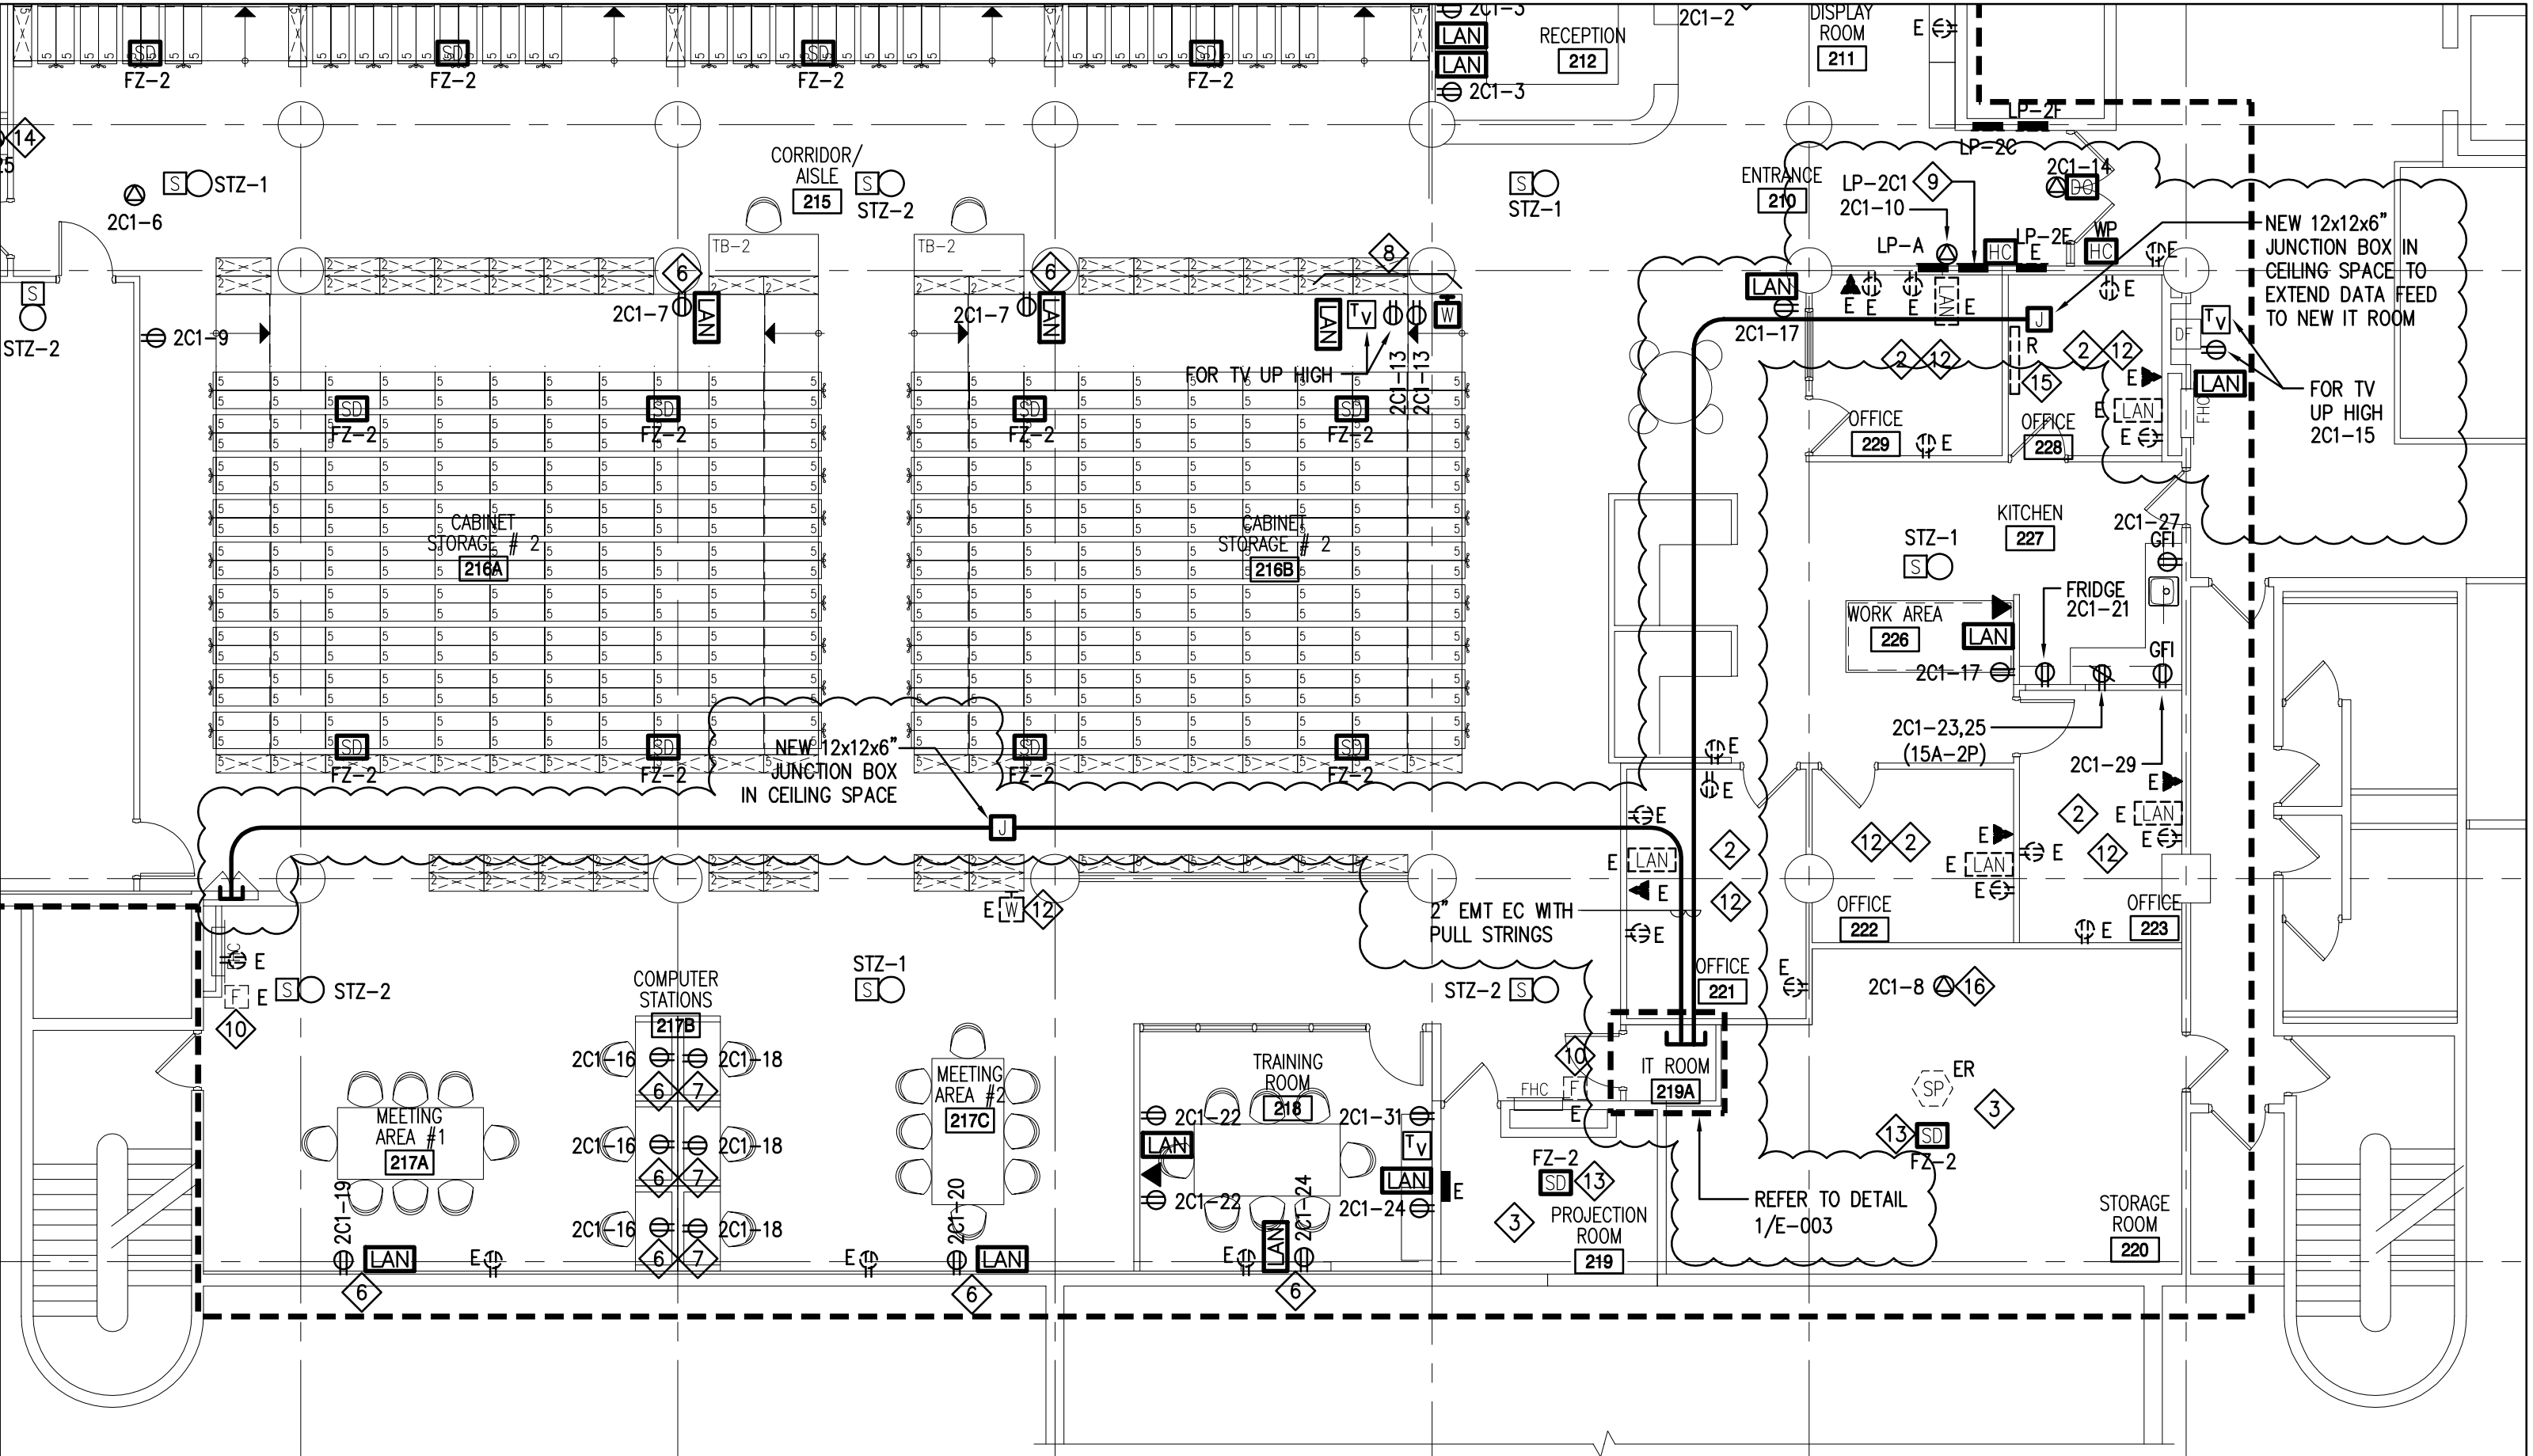

Project title: **BURLINGTON**
CANADA CENTRE FOR INLAND WATERS
867 LAKESHORE ROAD



Public Works and
Government Services Canada
Architectural and Engineering Services
Ontario Region

Travaux publics et
Services gouvernementaux Canada
Services d'architecture et de génie
Région de l'Ontario

CROSSEY
ENGINEERING
LTD.



2255 Sheppard Avenue. E.
Suite E-331
North York, On M2J 4Y1
(416) 497.3111 fax (416) 497.7210

Drawing title: **ADDENDUM E-01**
SECOND FLOOR
NEW POWER AND SYSTEMS PLAN

Designed by : **LN**
Drawn by : **LN**
Approved by : **NN**

Tender:
Plot scale : **1:100**

Drawing no.: **SKE-E302X01**

Project no.: **R.061475.001**

Project date : **13-02-20**

Date plotted :

Cadd file : **E-302**

LIBRARY RENOVATION