



GROUND FLOOR PLAN - ELECTRICAL

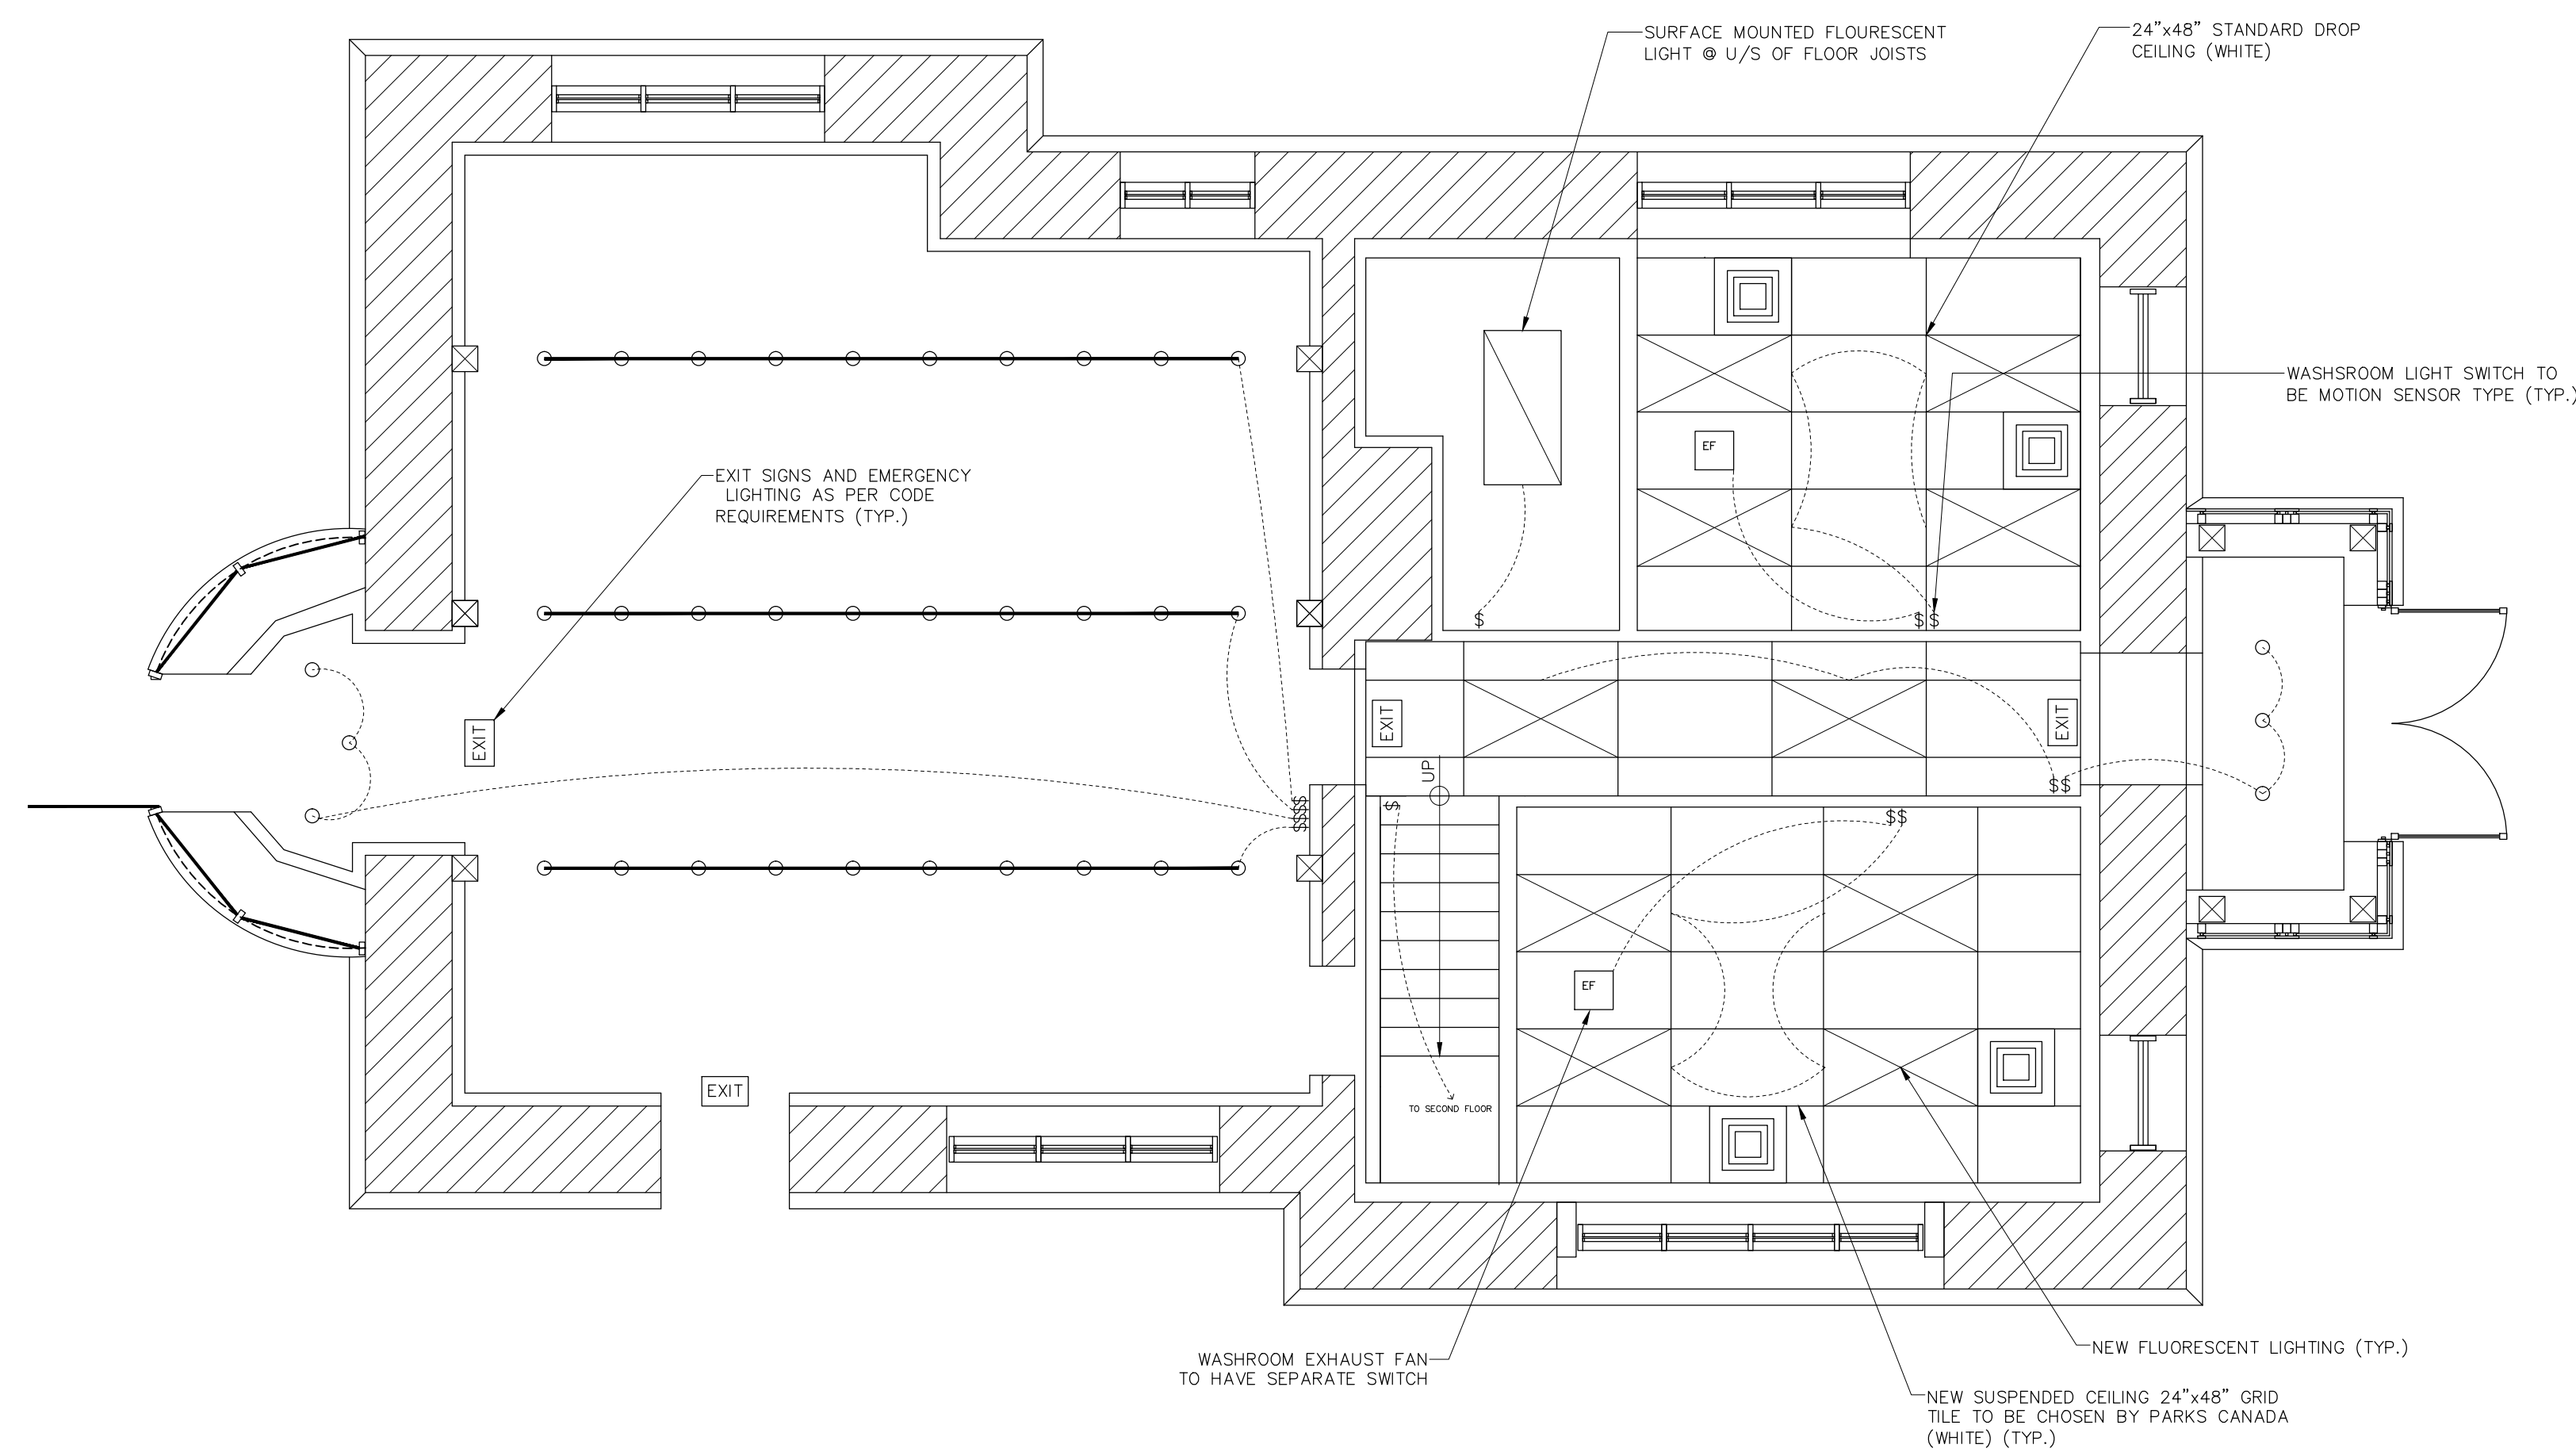

GROUND FLOOR PLAN - LIGHTING

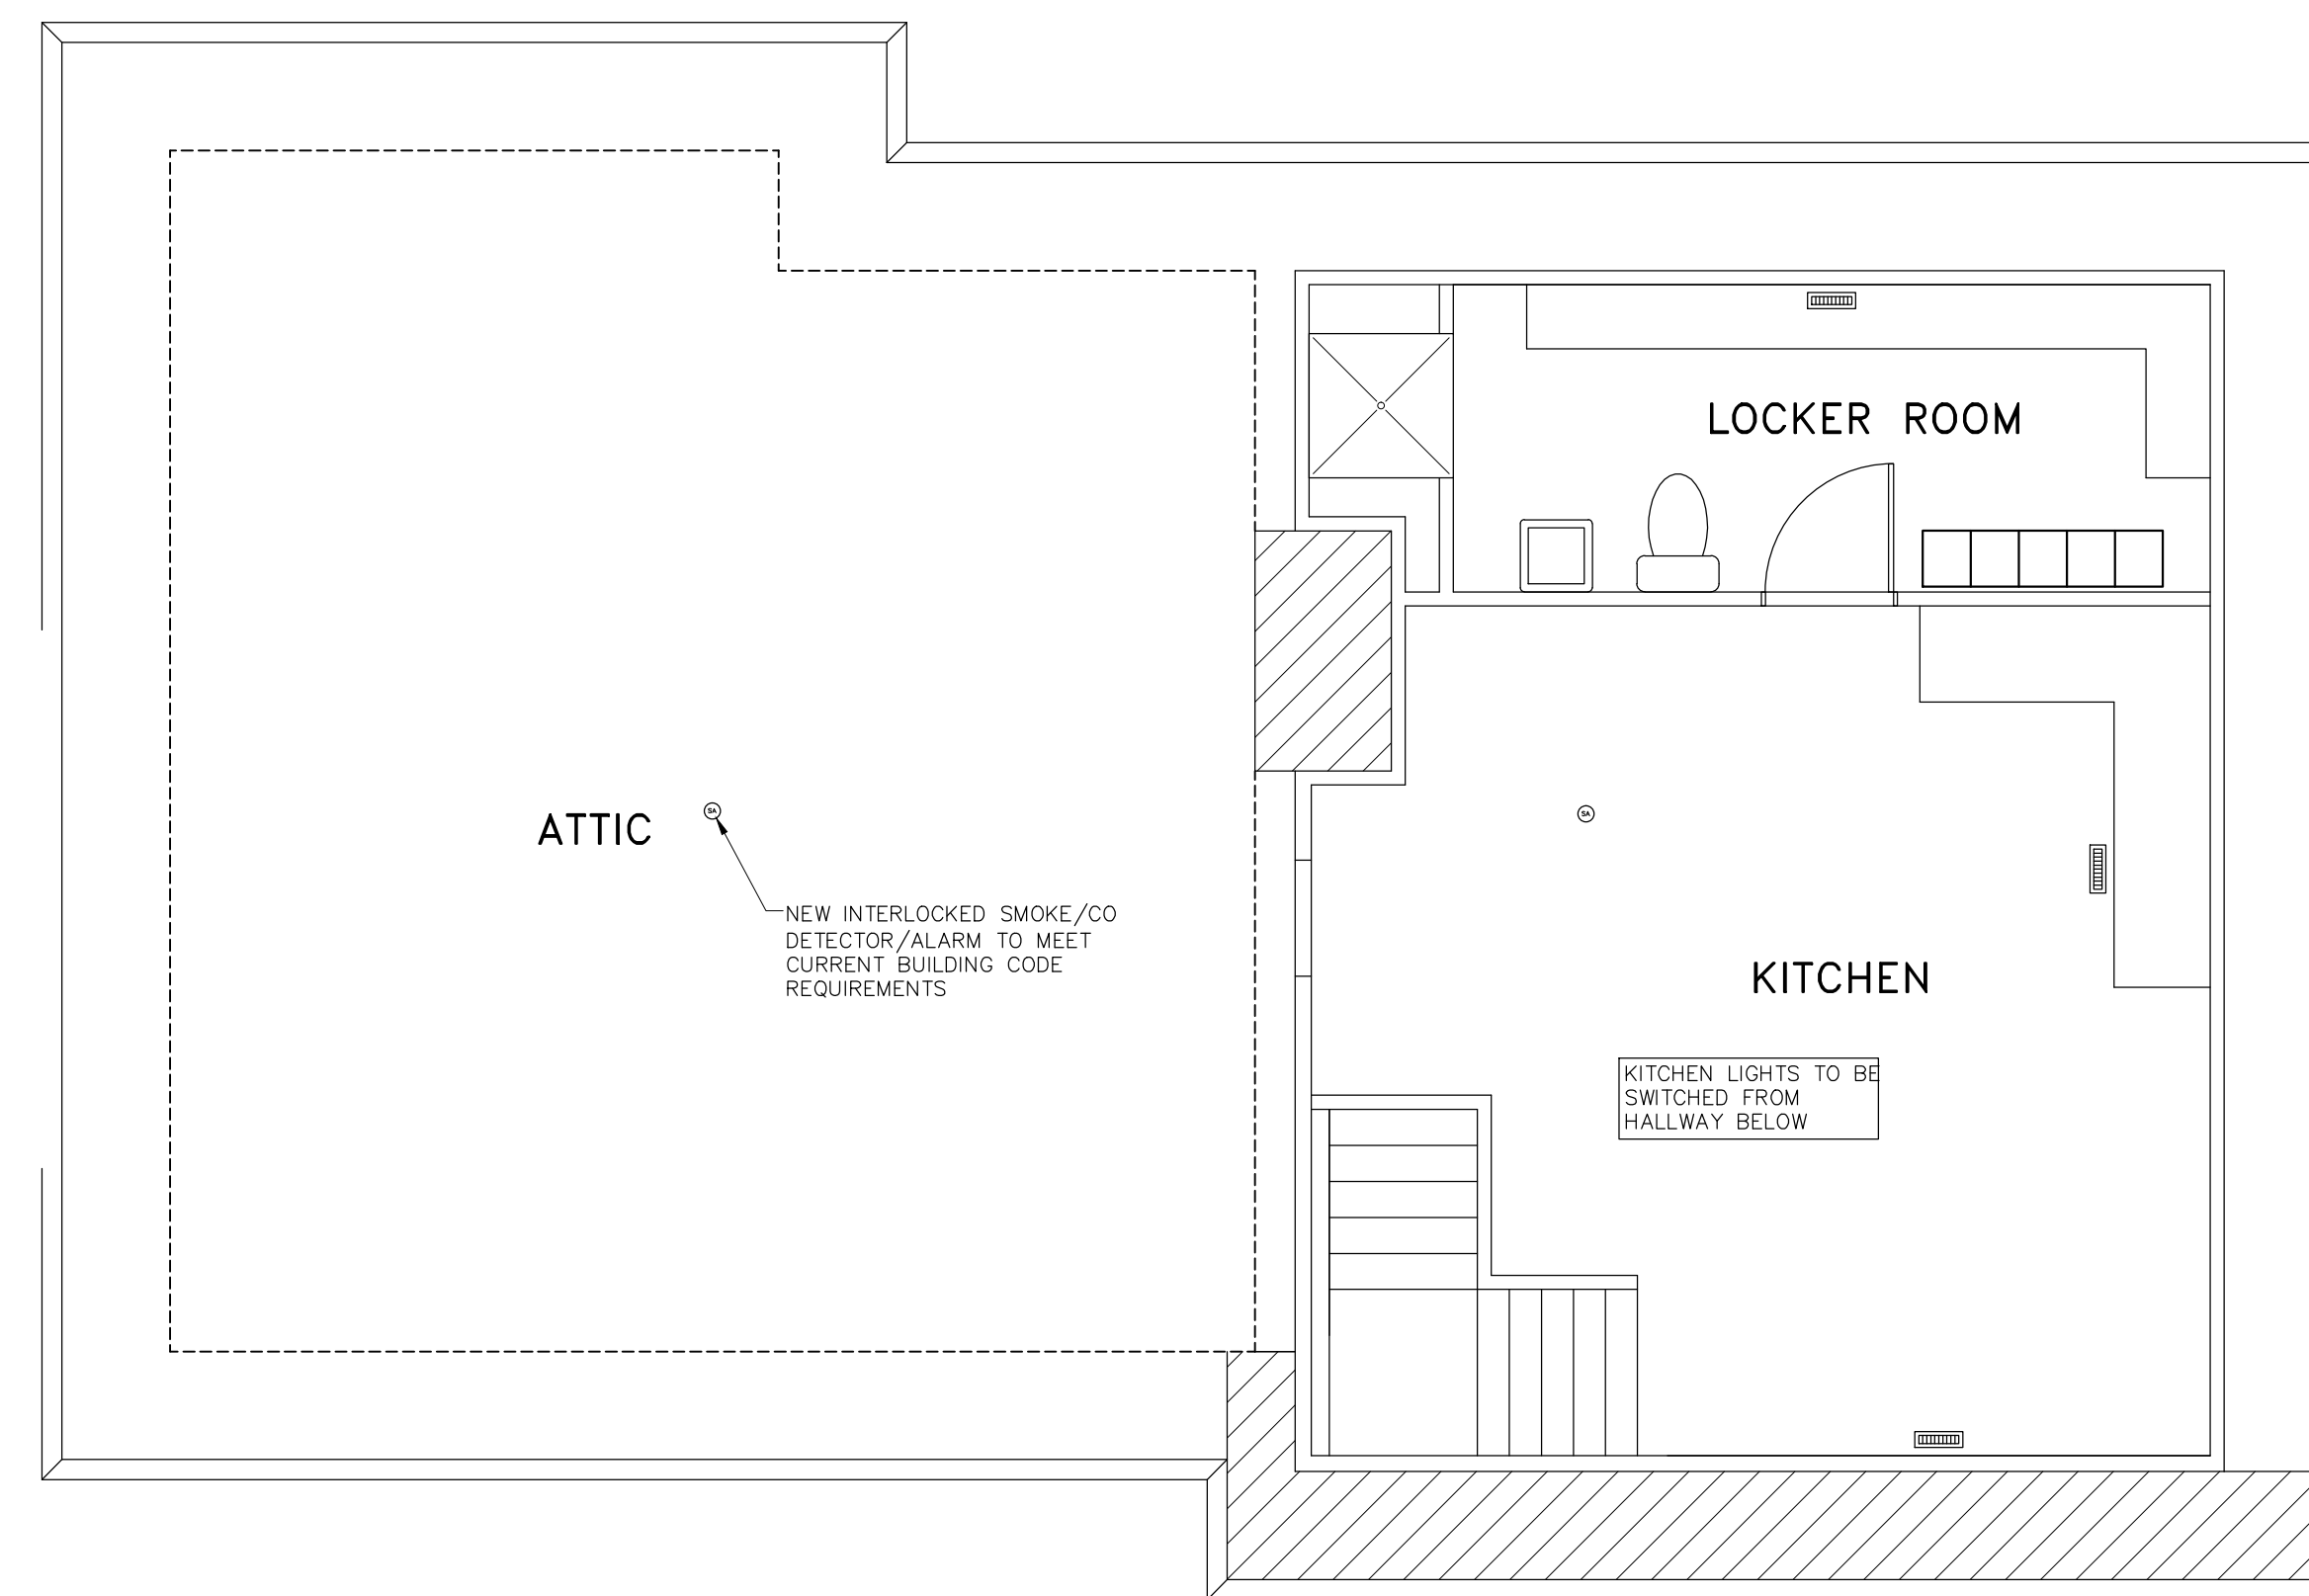

SECOND FLOOR PLAN - ELECTRICAL

FOR GENERAL NOTES REFER TO DRWG S1

no.	date	description
1	06.02.14	REVISED FOR TENDER
	13.01.14	ISSUED FOR TENDER
	06.01.14	ISSUED FOR 90% REVIEW
	18.12.13	ISSUED FOR REVIEW

revisions

Client Acceptance / Acceptation du client  
Signature \_\_\_\_\_ Date \_\_\_\_\_  
File No. / No. de dossier \_\_\_\_\_



ONTARIO WATERWAYS FIELD UNIT - RIDEAU CANAL NHS  
**Canada**

Type of Record / Type d'enregistrement  
TYPE

Project title / Titre du projet  
**RIDEAU CANAL NHS  
OTTAWA LOCK CONTROL  
BUILDING RENOVATION**

Drawing title / Titre du dessin  
**GROUND FLOOR PLAN  
SECOND FLOOR PLAN  
ELECTRICAL & LIGHTING**

Scale / Echelle  
SCALE

Drawn by/ Dessiné par Date  
W.J.L. 10.12.13

Field Recording by / Relevé-Terminé par Date

Approved by / Approuvé par Date

Checked by/ Vérifié par

Project No./ No. du projet Asset No. 00102 Sheet No./ Feuille No. A4

Drawing Re No./No. du Dessin