


 


Association of Professional Engineers & Geoscientists of Saskatchewan  
**CERTIFICATE OF AUTHORIZATION**  
HDA ENGINEERING LTD.  
Number 0381  
Permission to Consult Held by  
Discipline: Mechanical Signature: J. D. D.  
Mech. 6093

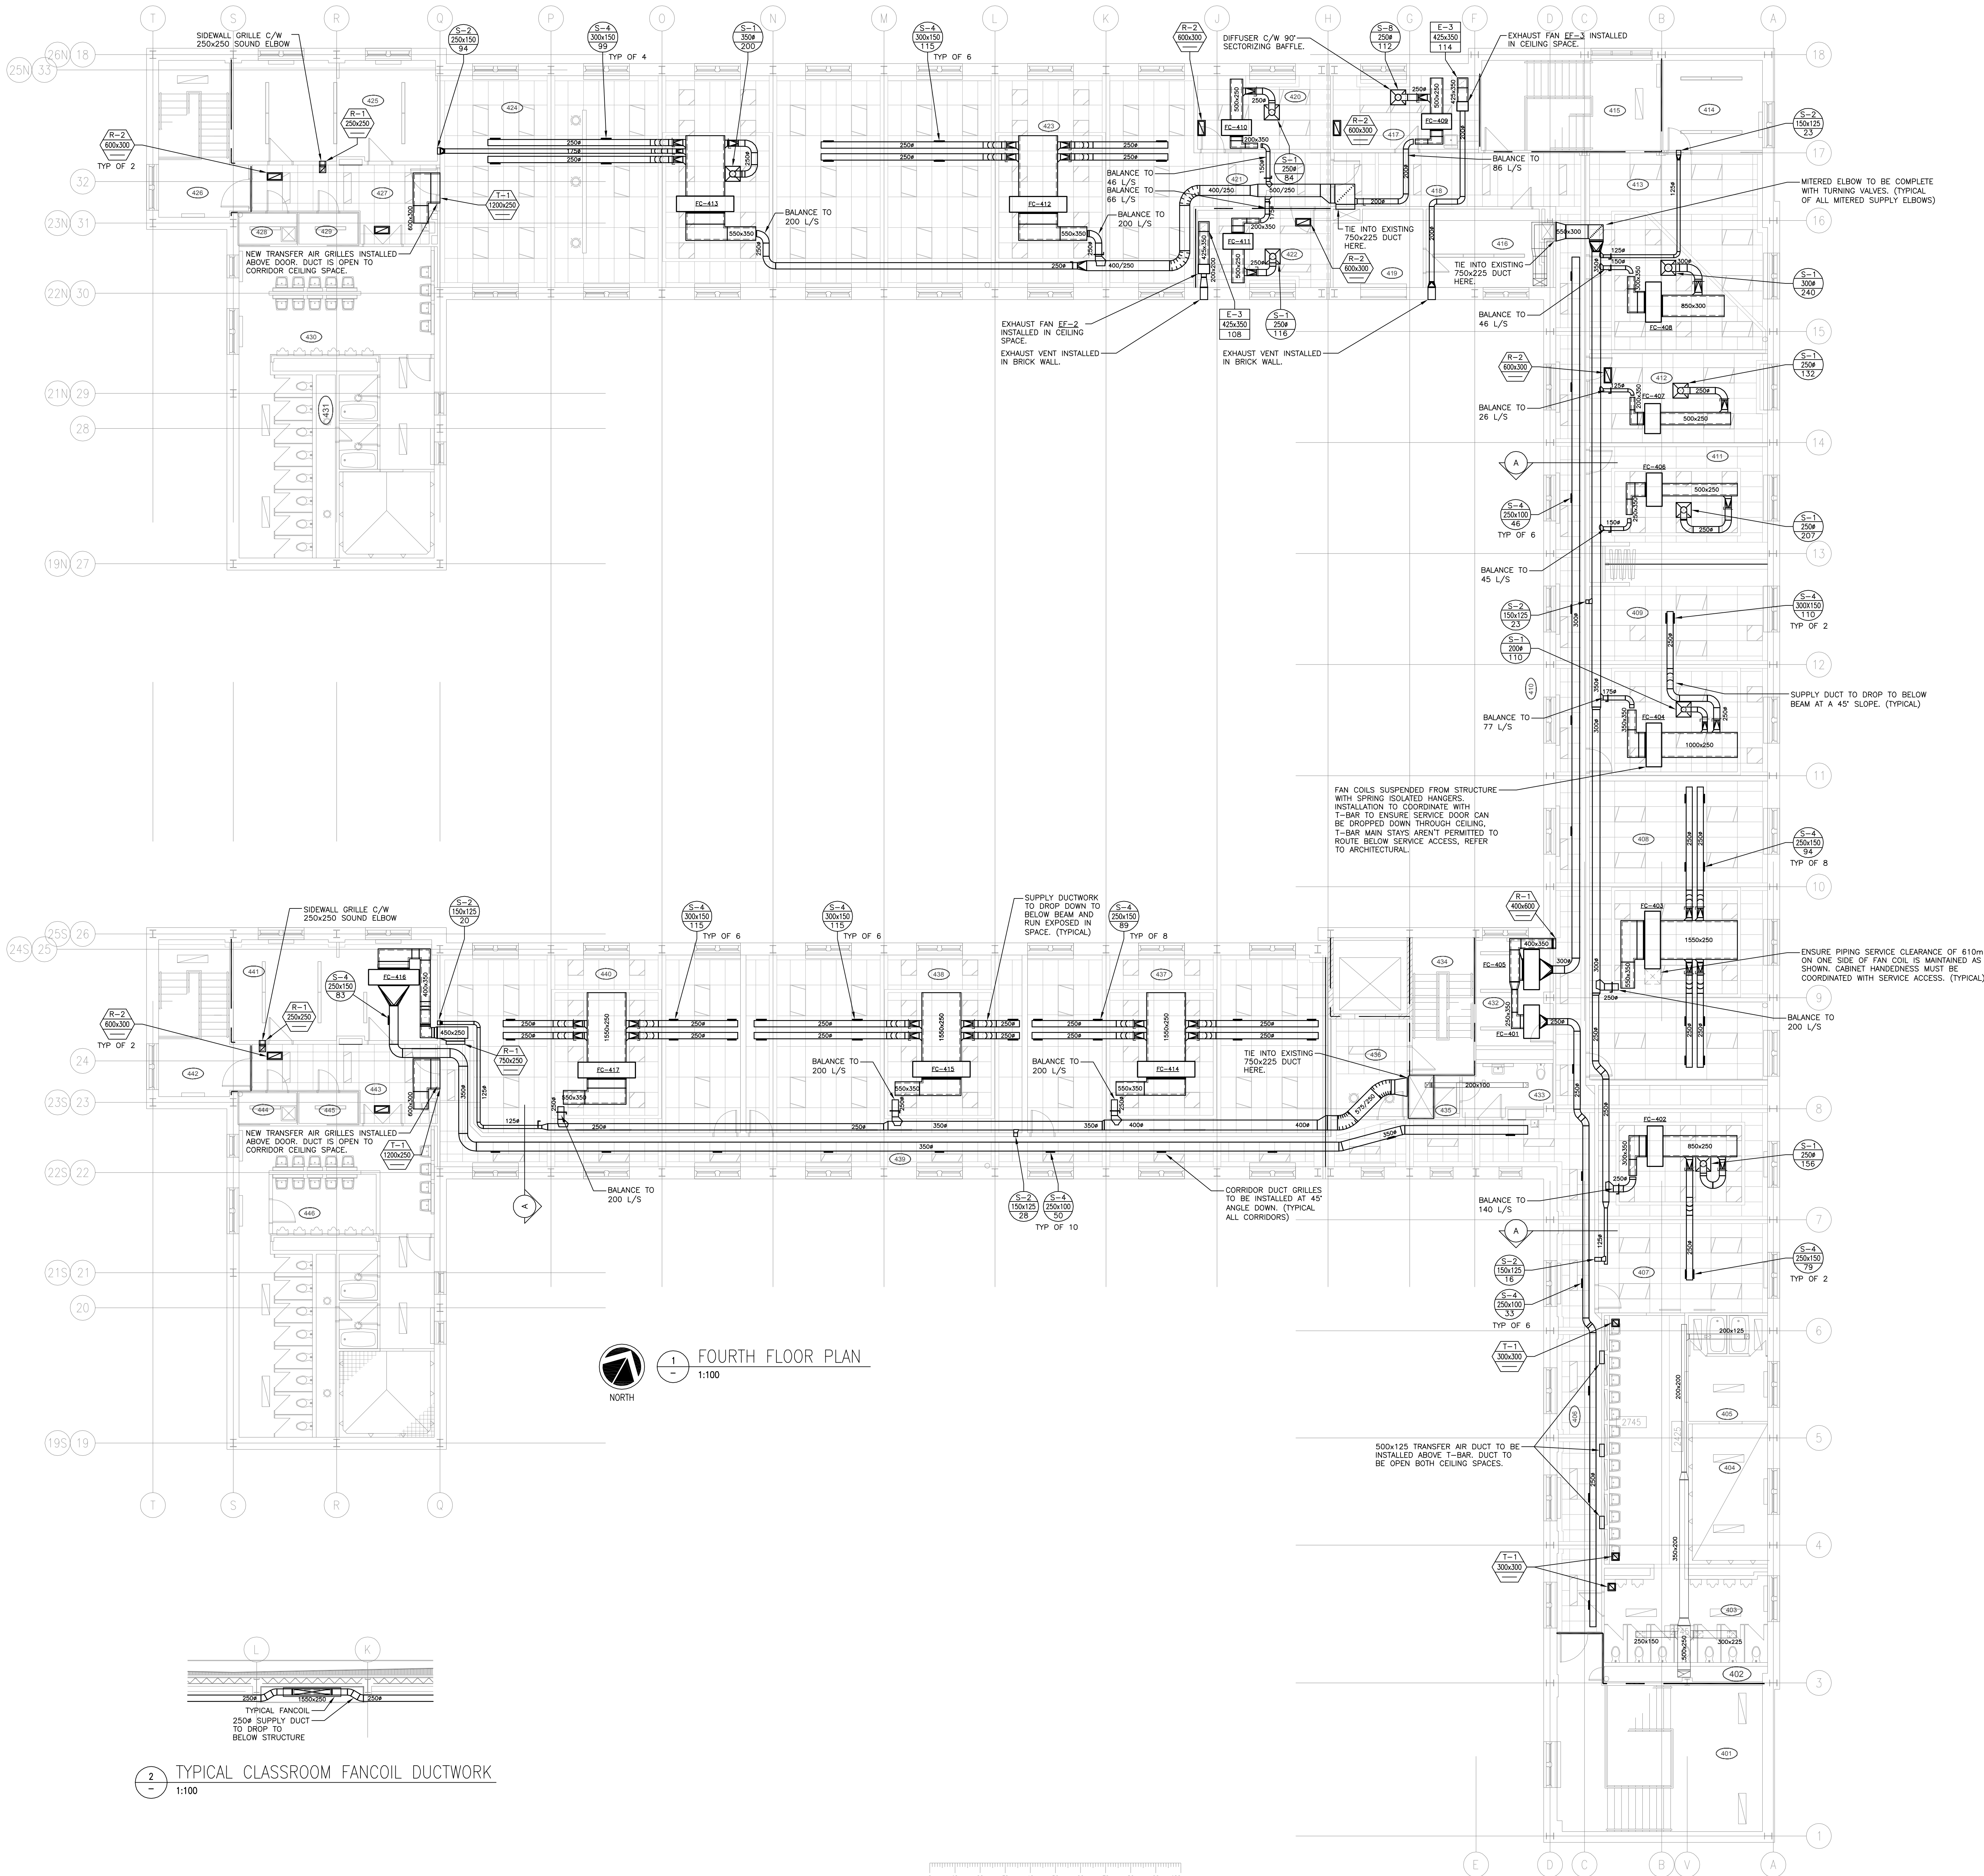

**FOURTH FLOOR PLAN**  
1:100

**2 TYPICAL CLASSROOM FANCOIL DUCTWORK**  
1:100



**DO NOT SCALE DRAWINGS**

Revision/Revision	Description/Description	Date/Date
0	ISSUED FOR TENDER	2014-01-17

Project Title/Titre du projet  
**SHARED LEARNING FACILITY**  
REGINA, SK

Approved by/Approve par  
Designed by/Concept par TKC  
Drawn by/Dessiné par TKC/JJB  
Project Manager/Administrateur de Projets AC  
Architectural and Engineering Resources Manager/ Ressources Architectural et de Directeur d'Ingénierie

Drawing Title/Titre du dessin  
**FOURTH FLOOR PLAN**  
**VENTILATION REVISIONS**