

ASSOCIATION OF PROFESSIONAL ENGINEERS
 OF SASKATCHEWAN
 CERTIFICATE OF AUTHORIZATION
 RITENBURG & ASSOCIATES LTD.
 NUMBER 52
 PERMISSION TO CONSULT HELD BY: SIGNATURE
 DISCIPLINE: ELECTRICAL 11782

Revision/Revisé	Description/Description	Date/Date

Client/client

Project title/Titre du projet
**SHARED LEARNING FACILITY
 REGINA, SK**

Approved by/Approuvé par

Designed by/Concept par
BDK, SBK, GTK

Drawn by/Dessiné par
BDK

Project Manager/Administrateur de Projets
AC

Architectural and Engineering Resources Manager/
 Ressources Architecturales et de Directeur d'Ingénierie


Client/client

Drawing title/Titre du dessin
**FOURTH FLOOR ACCESS CONTROL
 & FIRE ALARM PLAN**

Project No./No. du projet
05/2013

Sheet/Fauille
E3.5

Revision no./
 La Révision
 No.

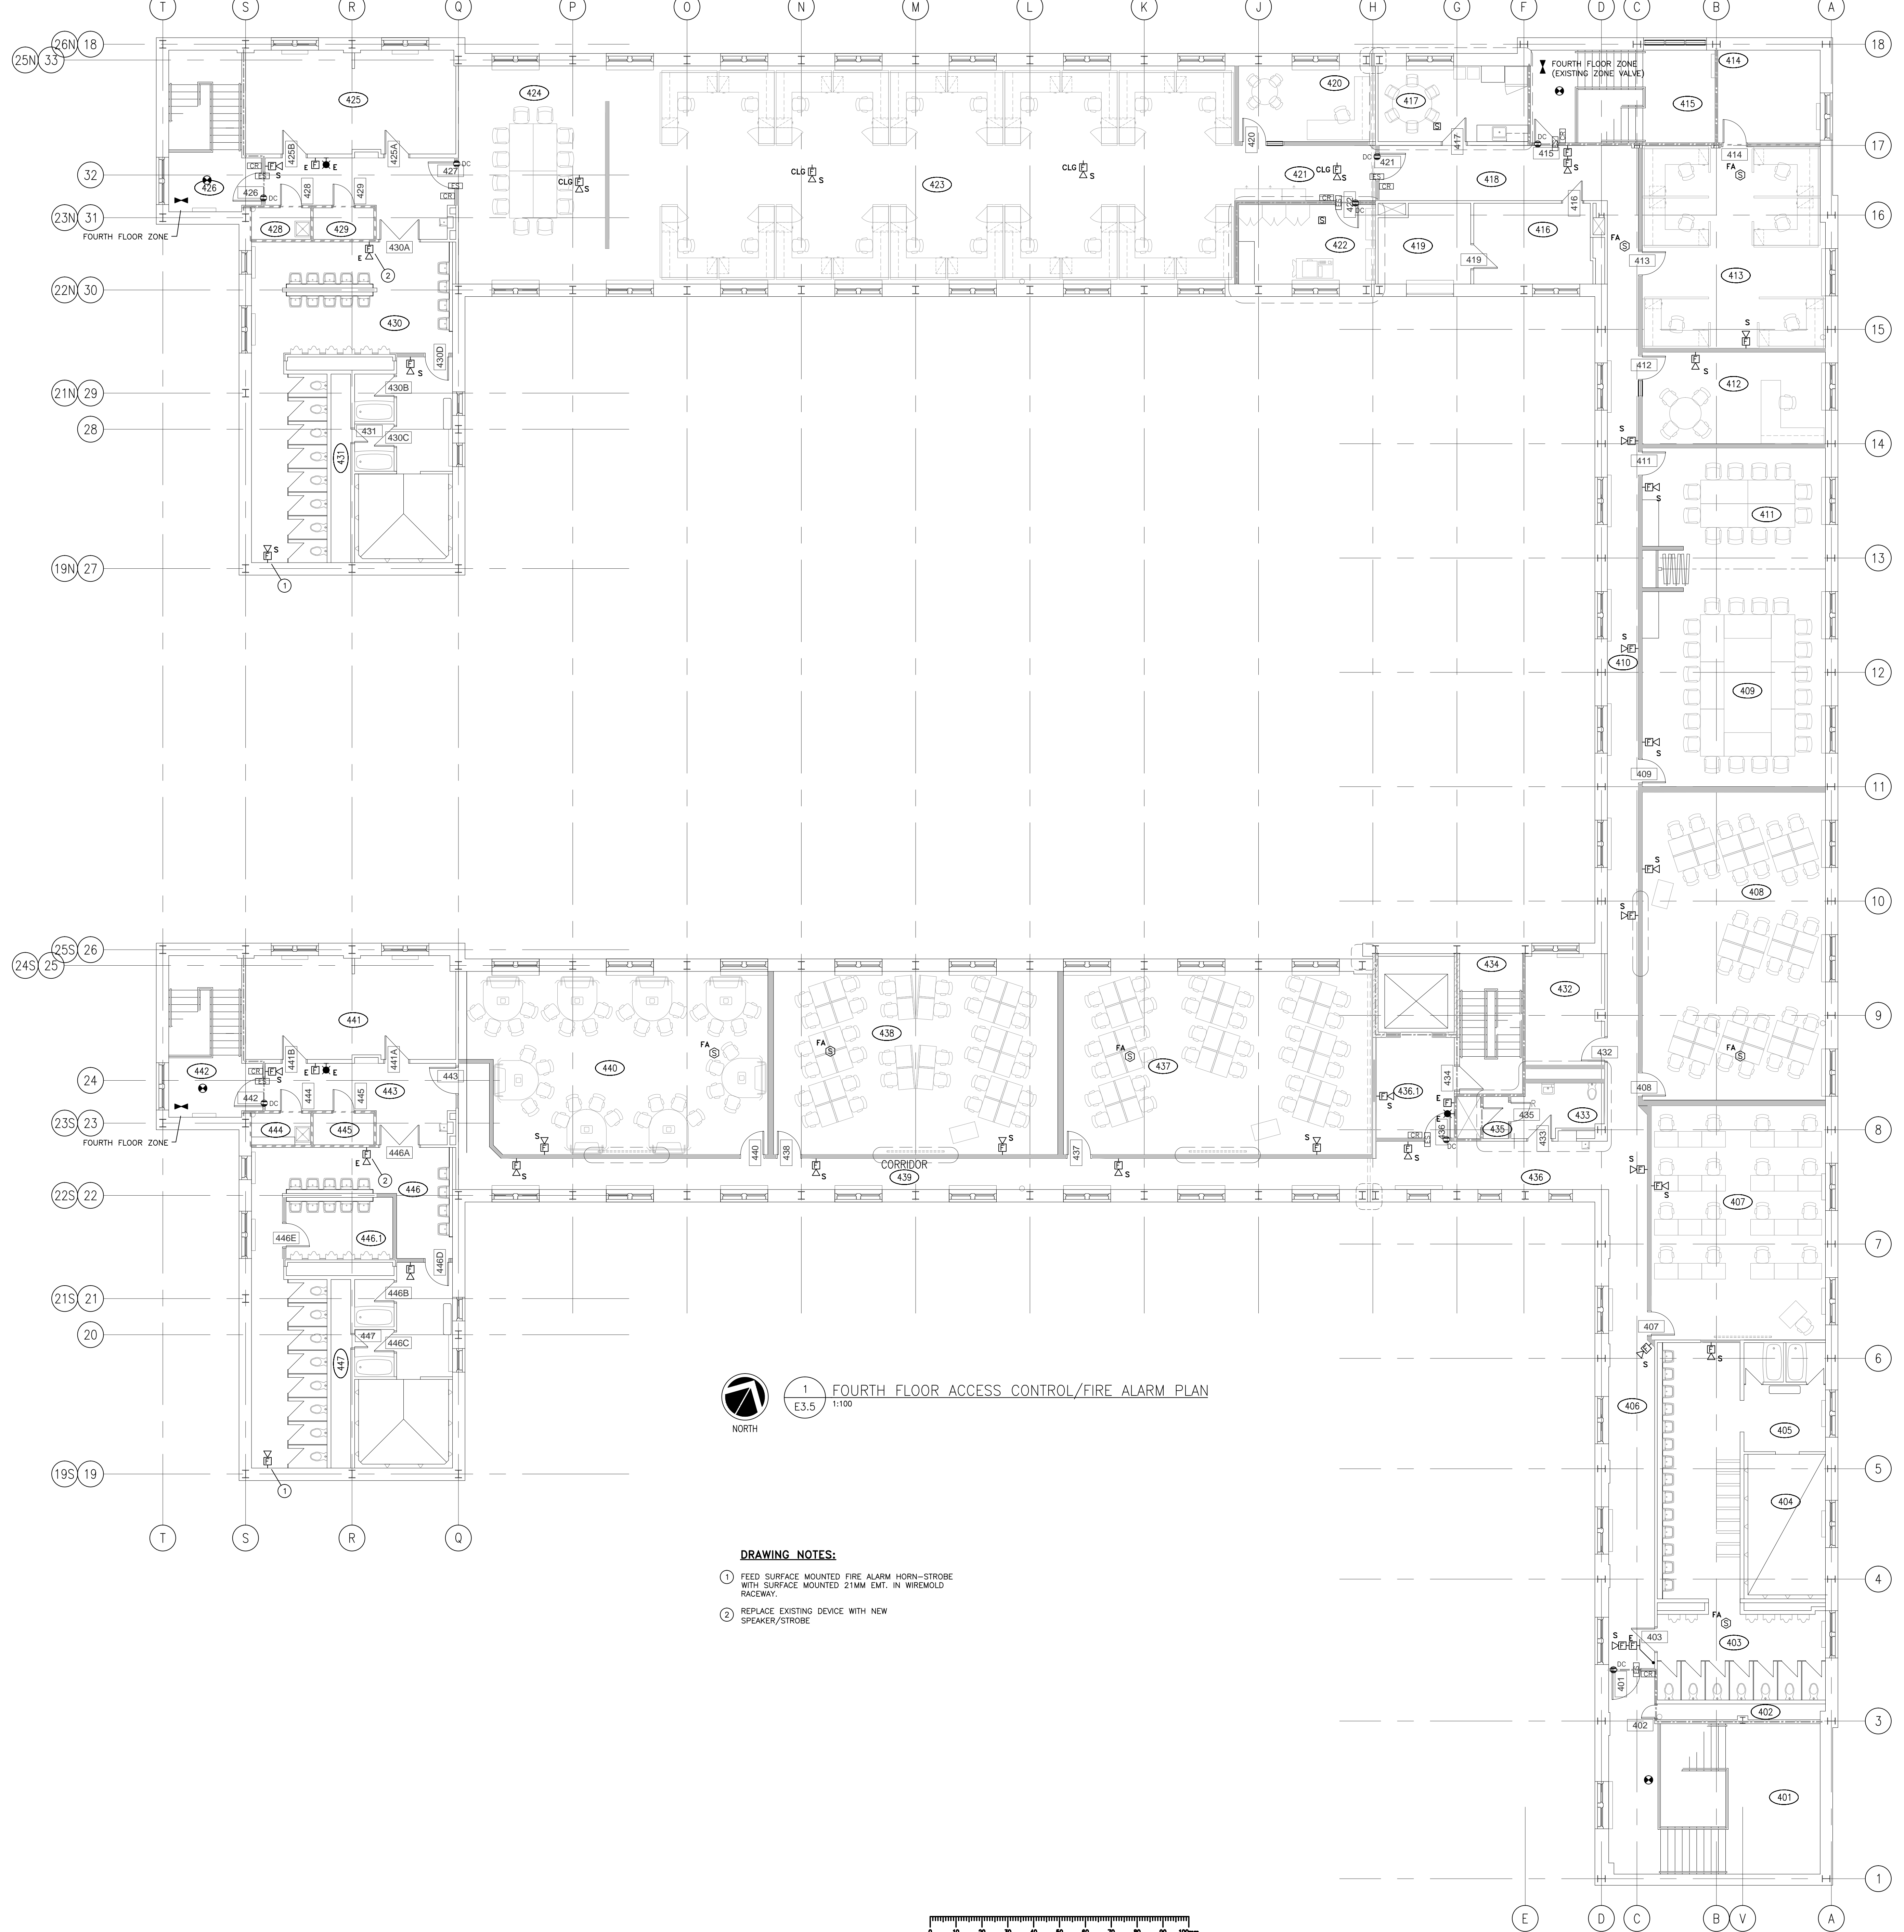

1
 E3.5
 1:100
FOURTH FLOOR ACCESS CONTROL/FIRE ALARM PLAN

DRAWING NOTES:

- 1 FEED SURFACE MOUNTED FIRE ALARM HORN-STROBE WITH SURFACE MOUNTED 21MM EMT, IN WIREMOLD RACEWAY.
- 2 REPLACE EXISTING DEVICE WITH NEW SPEAKER-STROBE.

