




ASSOCIATION OF PROFESSIONAL ENGINEERS
 OF SASKATCHEWAN
 CERTIFICATE OF AUTHORIZATION
 RITENBURG & ASSOCIATES LTD.

NUMBER 52

 
PERMISSION TO CONSULT HELD BY:
 DISCIPLINE: ELECTRICAL SIGNATURE: *[Signature]*
 SPEC. REG. NO.: 11782

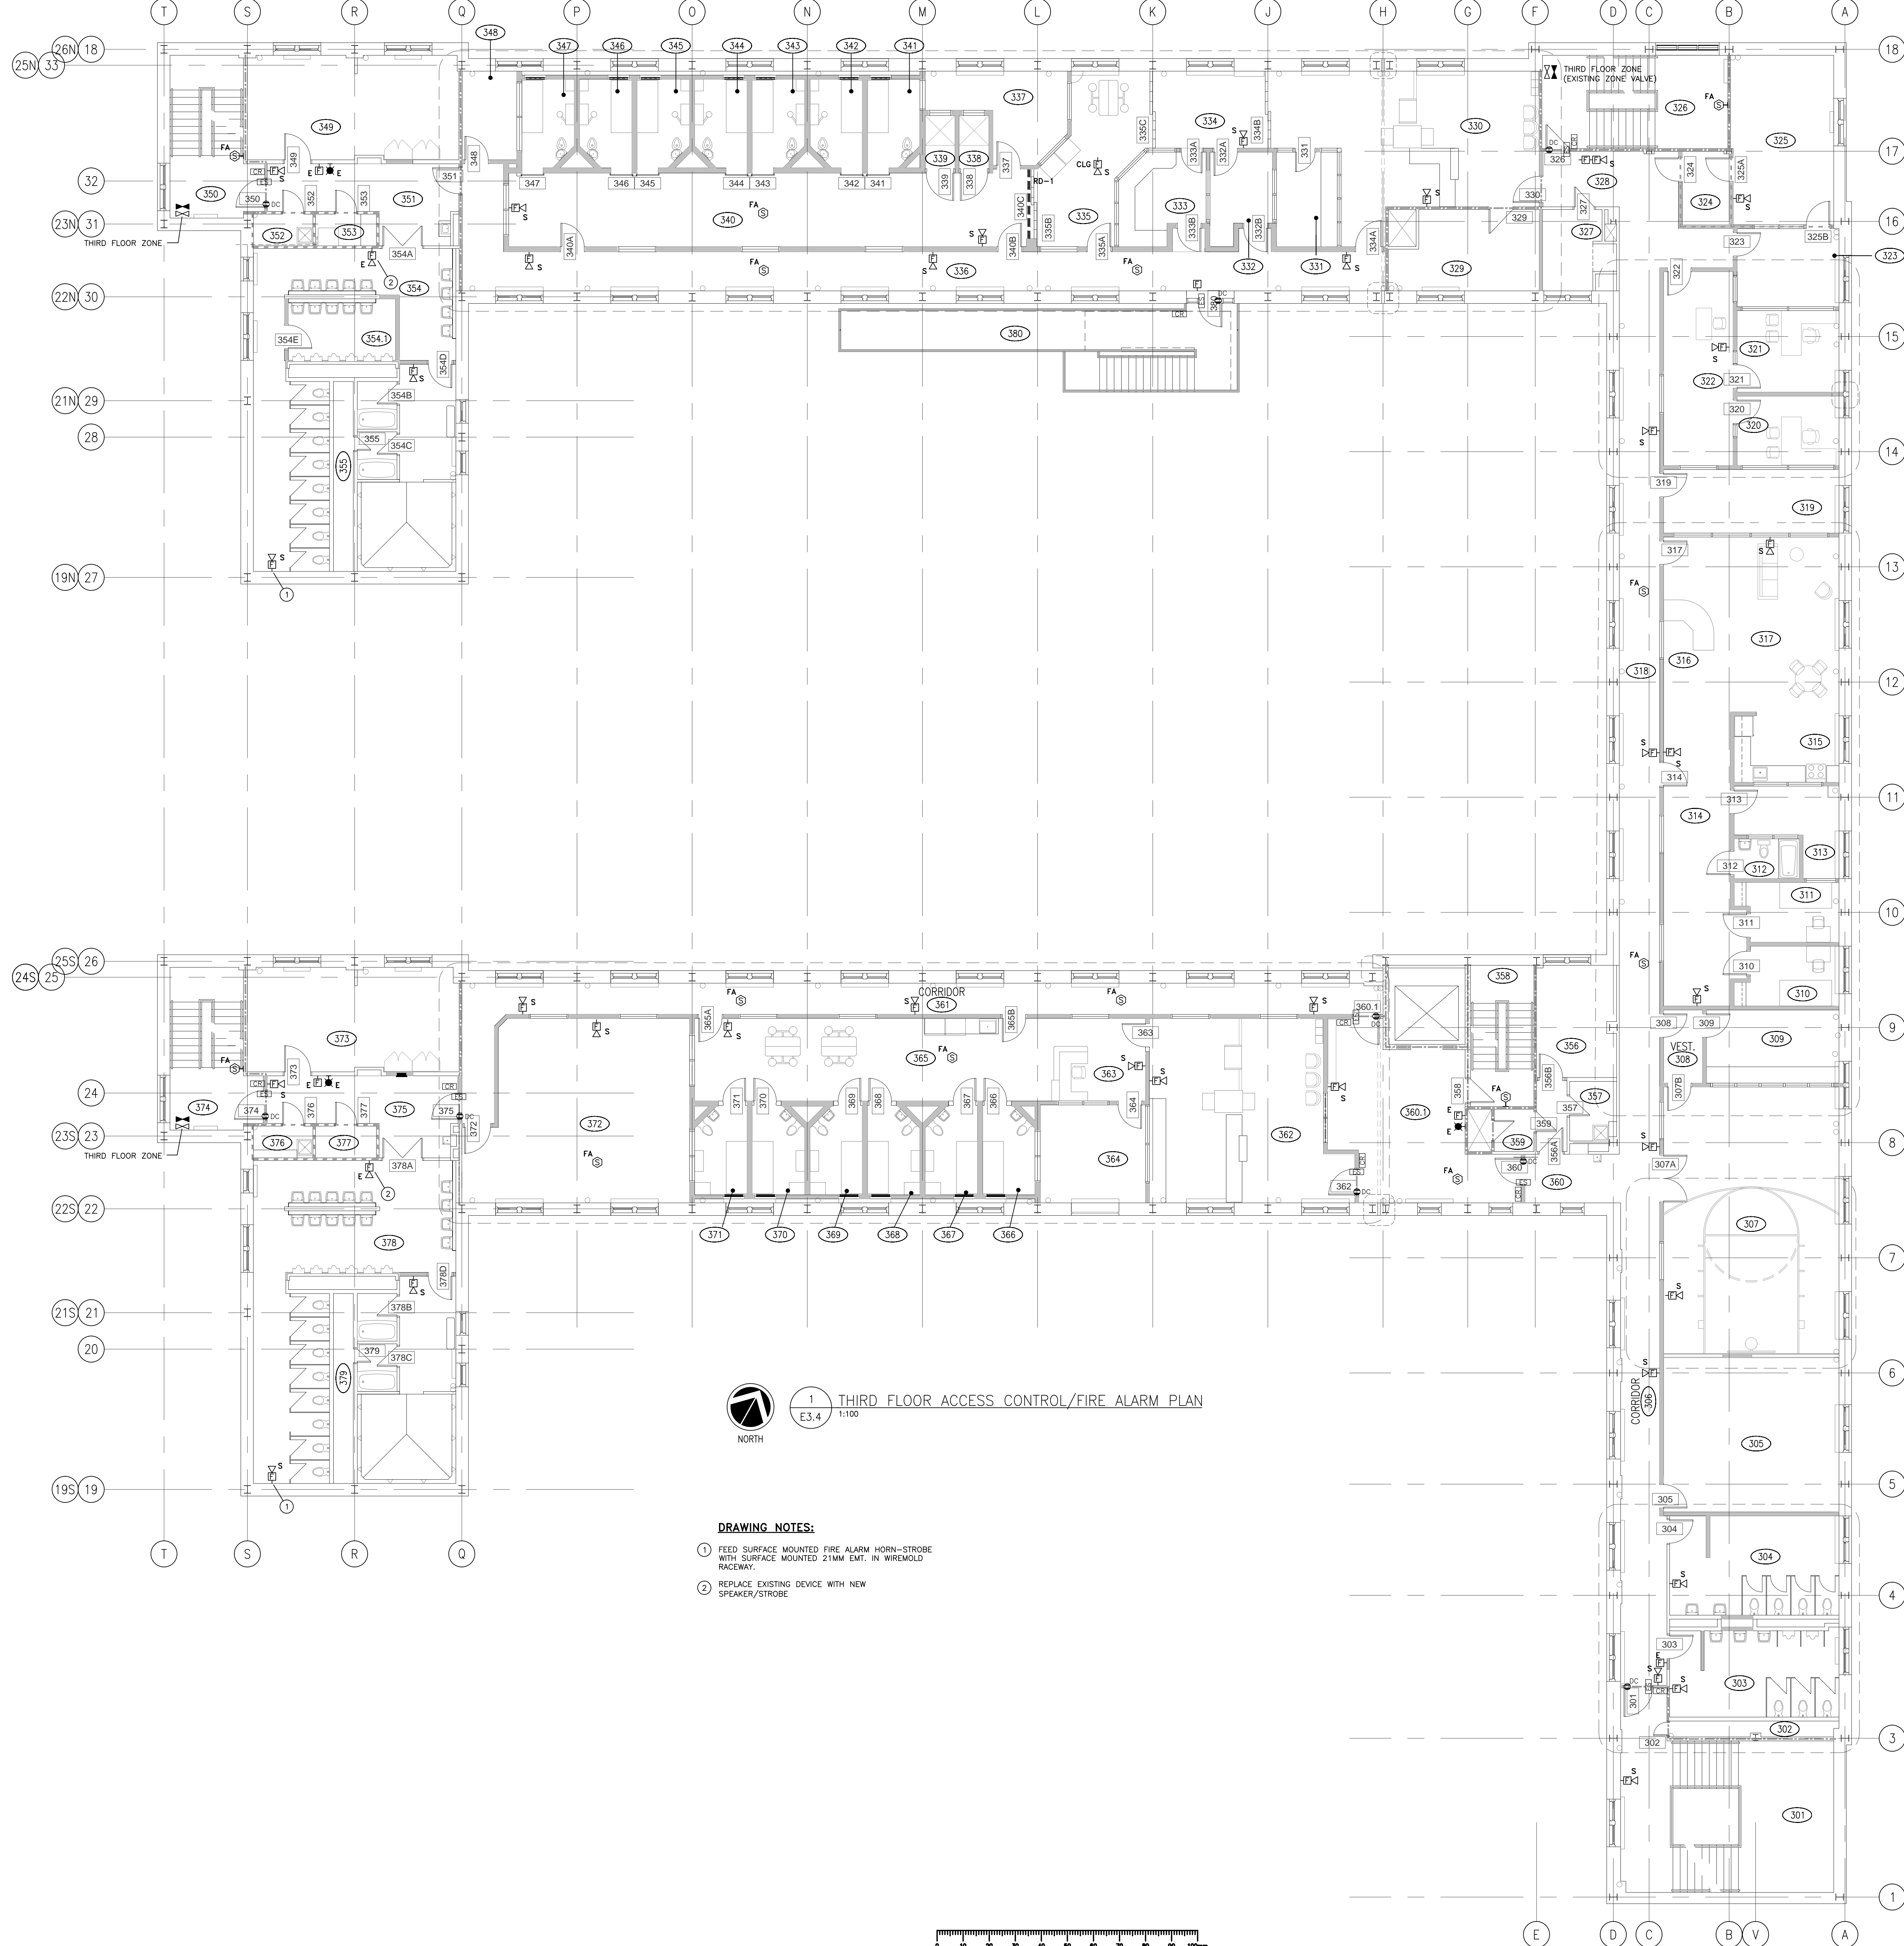

1 THIRD FLOOR ACCESS CONTROL/FIRE ALARM PLAN
 E.3.4 1:100

DRAWING NOTES:

- 1 FEED SURFACE MOUNTED FIRE ALARM HORN-STROBE WITH SURFACE MOUNTED 21MM EXT. IN WIREMOLD RACEWAY.
- 2 REPLACE EXISTING DEVICE WITH NEW SPEAKER-STROBE



Revision/Modification	Description/Description	Date/Date

Project Title/Titre du projet
**SHARED LEARNING FACILITY
 REGINA, SK**

Approved by/Approve par
 Designed by/Concept par
BDK,SBK,GTK
 Drawn by/Dessine par
BDK
 Project Manager/Administrateur de Projets
AC
 Architectural and Engineering Resources Manager/
 Ressources Architectural et de Directeur d'Ingénierie

Drawing Title/Titre du dessin
**THIRD FLOOR ACCESS CONTROL
 & FIRE ALARM PLAN**

Project No./No. du projet 05/2013	Sheet/Fauille E3.4	Revision no./ La Révision no.
---	------------------------------	----------------------------------