



SUITE 400-401 GARBALLY ROAD
VICTORIA (BRITISH COLUMBIA) CANADA V8T 5M3
TEL.: 250-384-5510 | FAX: 250-386-2844 | WWW.WSPGROUP.COM



5		
4		
3		
2		
1	ISSUED FOR TENDER	14/03/21
0	ISSUED FOR REVIEW	14/02/25
Revision/Édition	Description/Description	Date/Date

Client/client
**TRANSPORT CANADA
PORT HARDY AIRPORT**
Port Hardy, BC



Project title/Titre du projet
Port Hardy, BC

**ELECTRICAL GLIDE PATH
BUILDING FEEDER
UPGRADE**

Consultant Signature Only
Designed by/Concept par
John den Boer
Drawn by/Dessiné par
Paolo Paranpan
PWGSC Project Manager/Administrateur de Projets TPSGC
Tom Dunphy
Regional Manager, Architectural and Engineering Services
Gestionnaire régionale, Services d'architecture et de génie, TPSGC



Drawing title/Titre du dessin
KEY PLAN

Project No./No. du projet	Sheet/Feuille	Revision no./ La Révision no.
R.048881.001	E01 OF 03	1

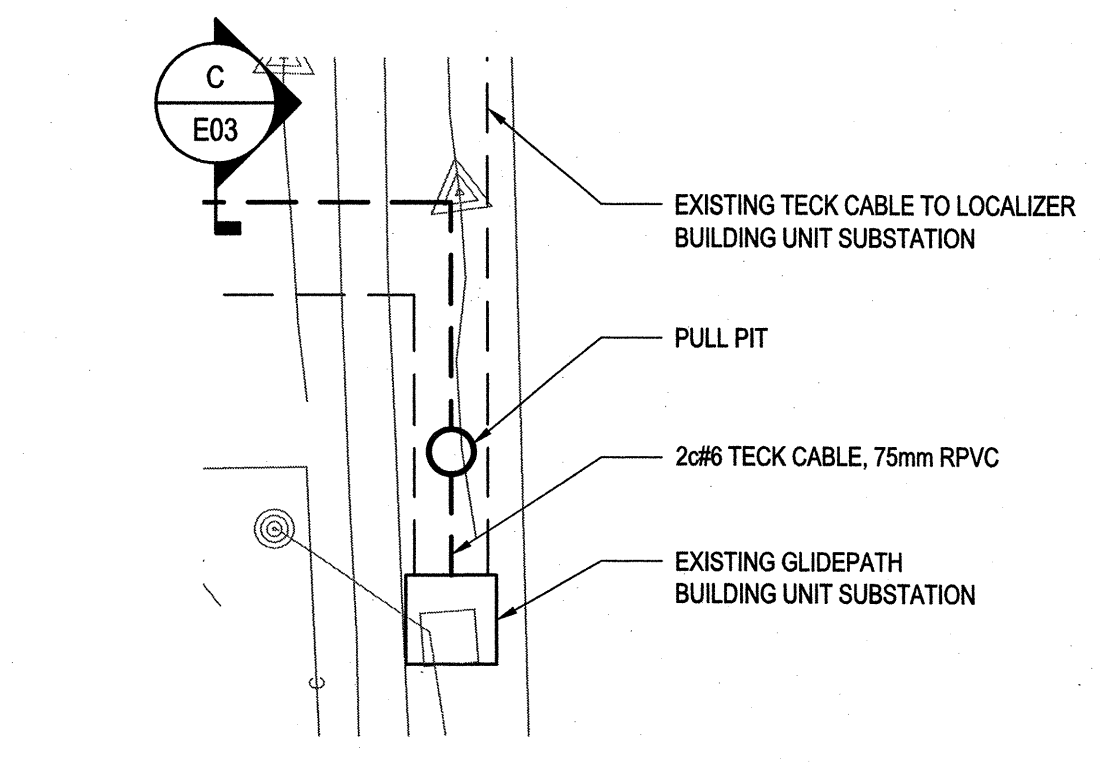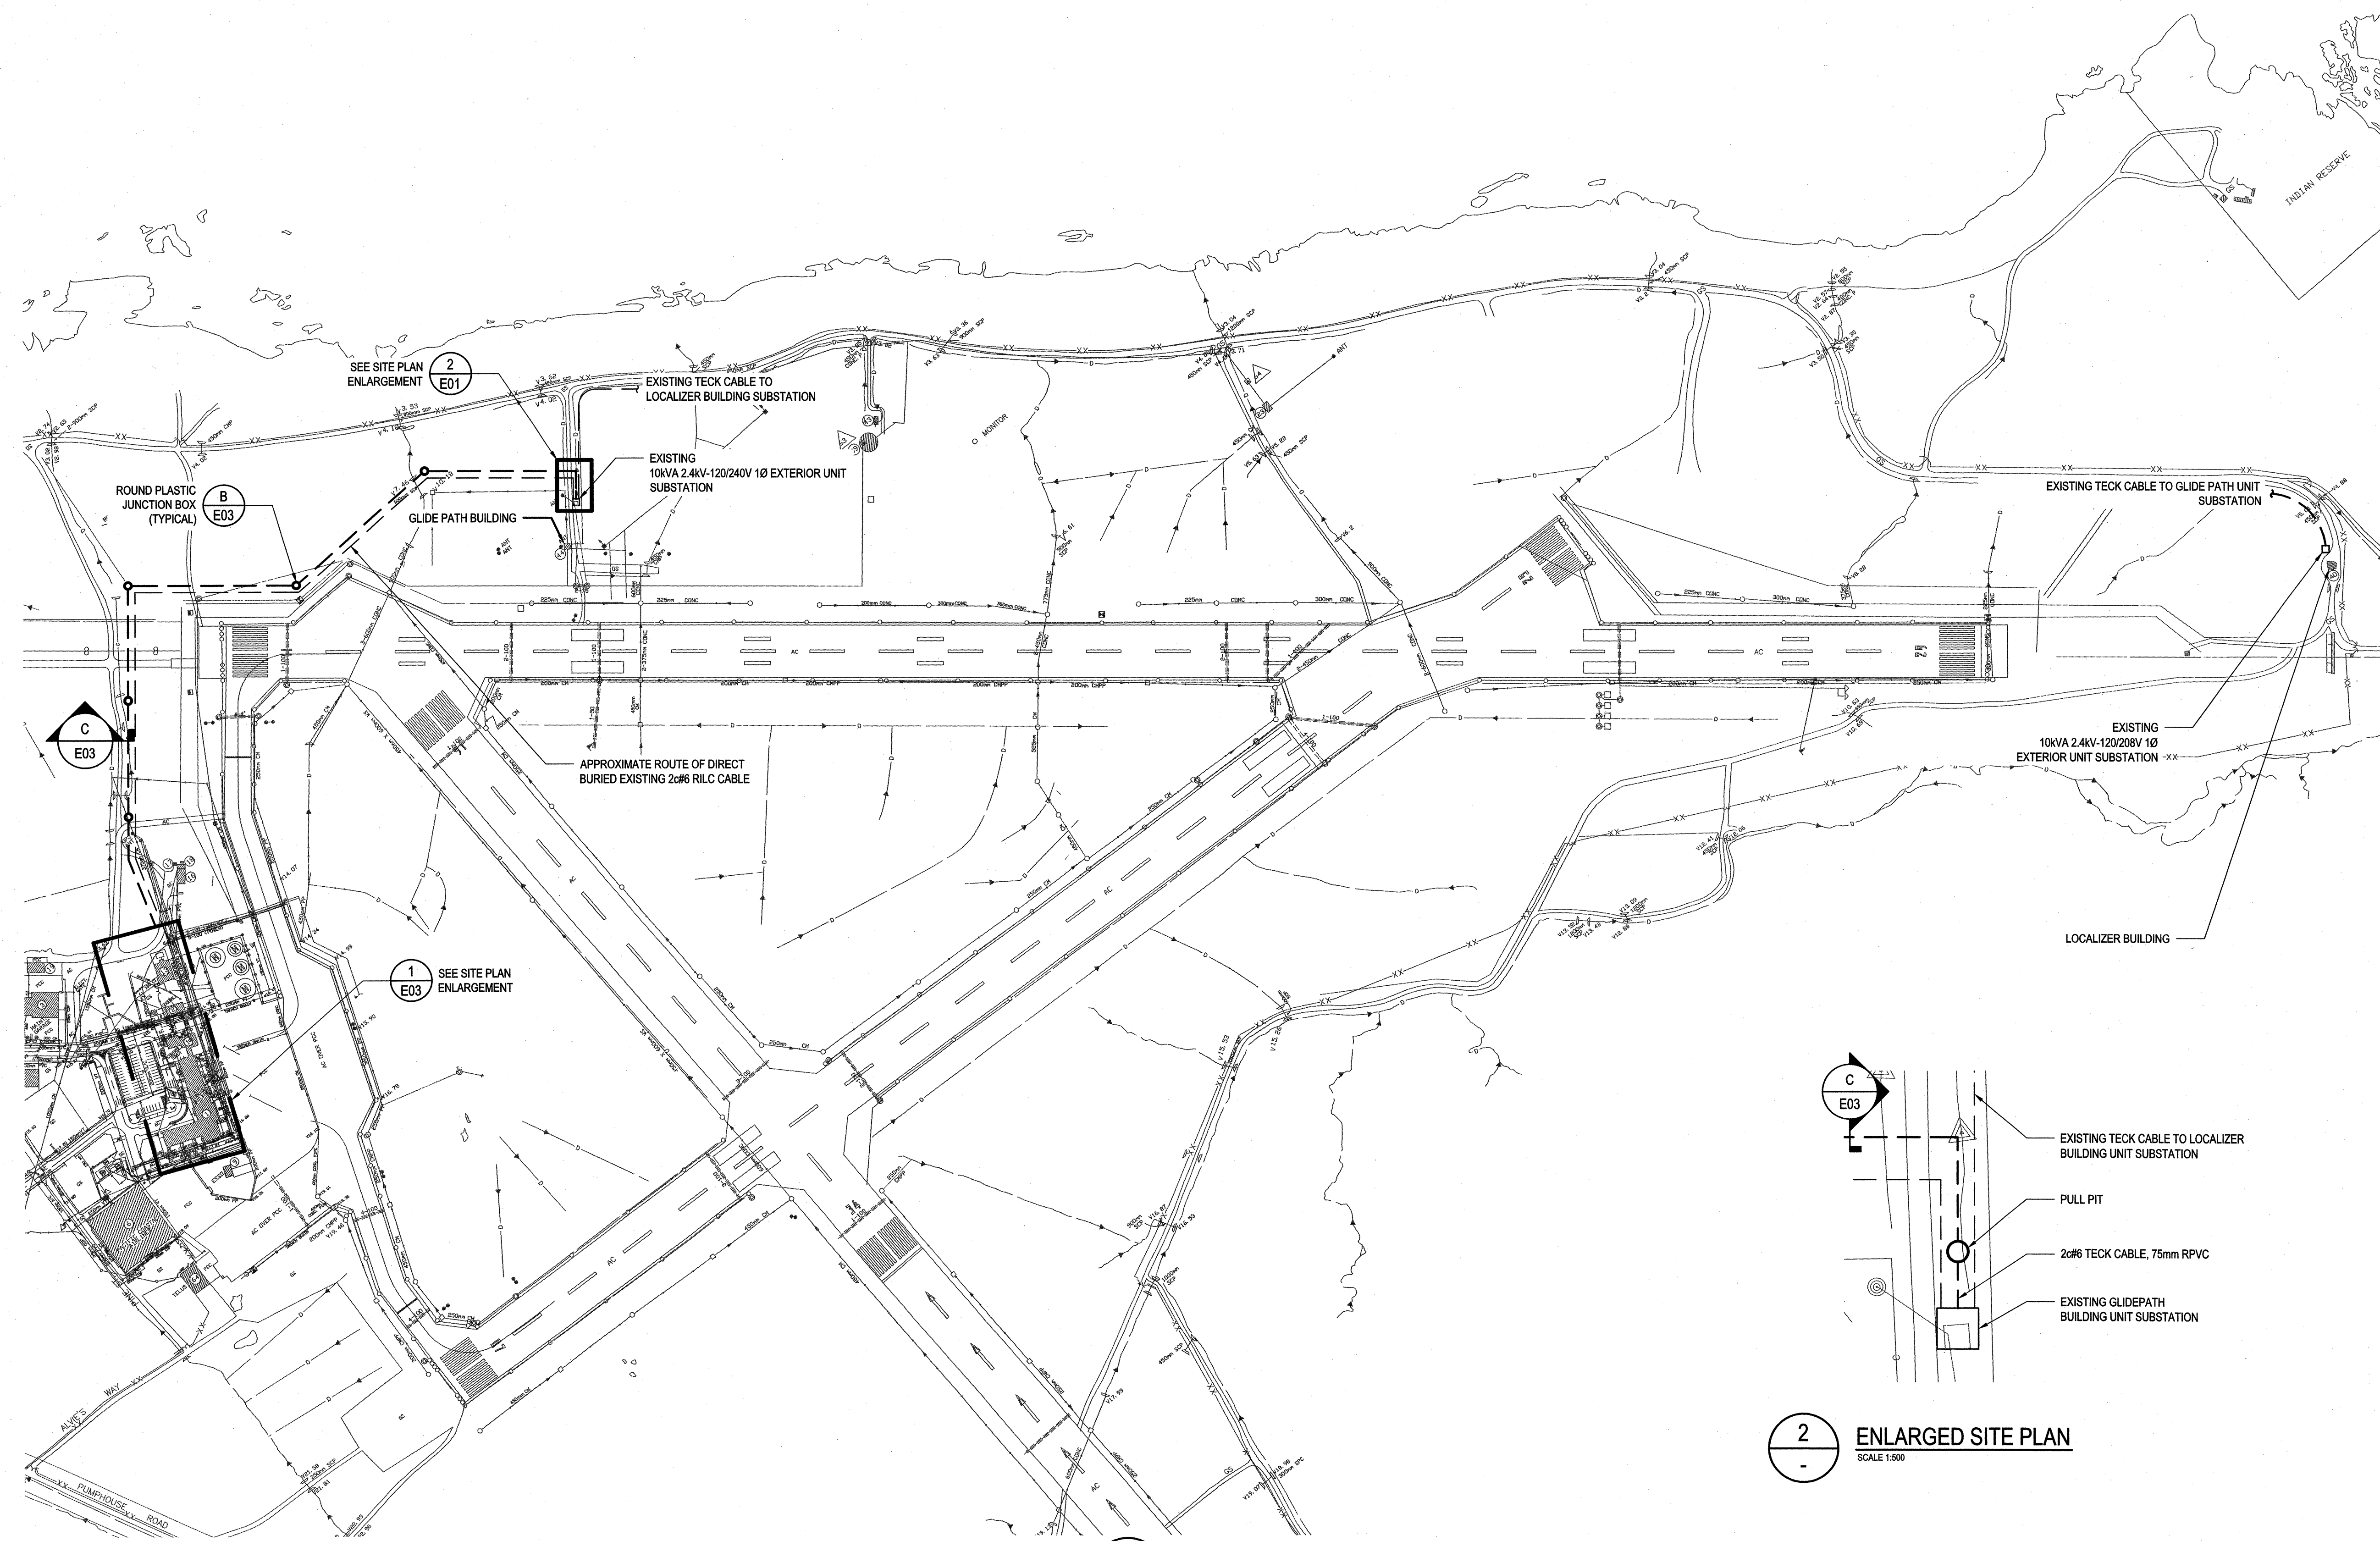

1 ELECTRICAL SITE PLAN
SCALE 1:3000

 2 ENLARGED SITE PLAN
SCALE 1:500

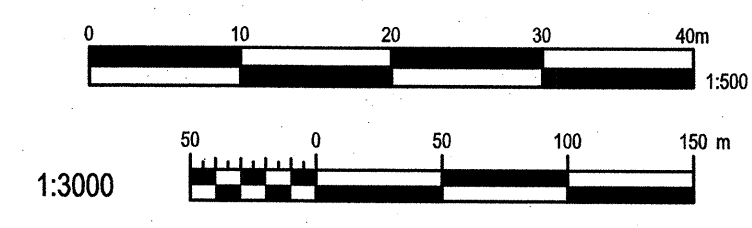

Plot Date: March 28, 2014 2:34 PM Plotted by: Peterson, Paolo
File Name: V:\PROJECTS\2013\131-12892-03 PWGSC PORT HARDY GLIDE PATH FEEDER COMPLETION.DWG/ELECT/PRODUCTION/LET (KEY PLAN).DWG