



Addendum / Addenda

No./N ^o 1

Project Description / Description de projet M-20 Passenger Elevator Modernization		
Solicitation No./ No de sollicitation 14-22022	Project No./N ^o de projet 3957	W.O. No./N ^o d'ordre de travail 9100030291
Departmental Representative / représentant ministériel Charles Cossette		Date June 10, 2014
<p>Notice: This addendum shall form part of the tender documents and all conditions shall apply and be read in conjunction with the original plans and specifications.</p>		<p>Nota: Cet addenda fait partie intégrale des dossiers d'appel d'offres; toutes les conditions énoncées doivent être lues et appliquées en conjonction avec les plans et les devis originaux.</p>

1.0 Drawings (revised)

1.1 Drawing D-3957-E6

- 1.1.1 Revise the location of existing panel board "P2" in Mechanical Penthouse Room 302 as shown on attached revised drawing #D-3957-E6, Electrical Power Plan Part Penthouse.

End of Electrical Addendum NO. E-01


2.0 Closing extention

Please note closing date has been pushed to June 25th , 2014 .



Smith + Andersen

1600 Carling Ave Suite 530 Ottawa Ontario K1Z 1G3
t 613 230 1186 f 613 230 2598 smithandandersen.com

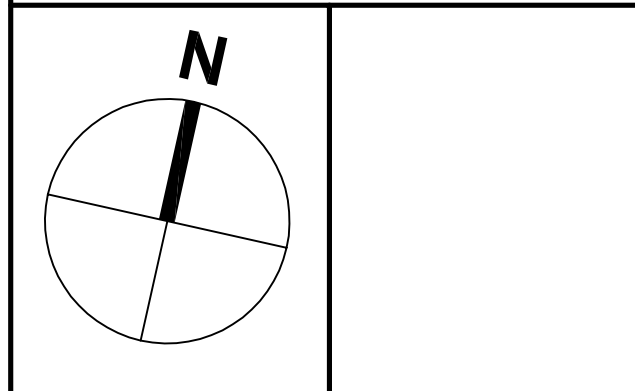

revisions	description	date
1	ISSUED FOR ADDENDUM 1	JUNE 03 2014
0	ISSUED FOR TENDER	APR 02 2014
A	ISSUED FOR REVIEW	MAR 21 2014

This drawing is the property of Smith and Andersen Consulting Engineering. All copyright is reserved.

Ce dessin est la propriété de Smith and Andersen Consulting Engineering. Tous droits de reproduction sont réservés.

Dimensions on drawing for estimating purposes only. It is the responsibility of each contractor and sub contractor to check all dimensions and conditions on site.

Les dimensions sur ce dessin sont uniquement pour établir un devis. Les entrepreneurs devront prendre leur propres mesures sur les lieux et en être responsables.

Project Title:
NRC BUILDING M-20
CENTRE ELEVATOR UPGRADE

Drawing Title:
ELECTRICAL POWER PLAN
PART PENTHOUSE

Project Number: 14138.001		Date: 2014-04-02
Scale: 1:100	Dwg. No. D-3957-E6	
Drawn By: S.S.	Approved By: A.D.	

DRAWING NOTES:

- (N-1) REPLACE EXISTING 3-POLE 60A BREAKER FOR CENTRE ELEVATOR AT CIRCUIT 5 OF EXISTING AMALGAMATED ELECTRIC PANEL BOARD WITH 3-POLE 100A BREAKER.
- (N-2) REPLACE EXISTING WIRING AND CONDUIT FOR CENTRE ELEVATOR FROM PANEL 'P2' TO EXISTING ELEVATOR TRANSFER SWITCH IN BASEMENT ELEVATOR MACHINE ROOM WITH 3#3+GND-35mmC. REFER TO DRAWING D-3957-E7 FOR LOCATION OF ELEVATOR TRANSFER SWITCH. VERIFY EXACT LOCATION OF PANEL 'P2' ON SITE.

