


GENERAL NOTES

UTILIZE EXISTING DDC PANEL FOR NEW EQUIPMENT CONNECTIONS

KEY NOTES

- ① DROP TO PASS JUST BELOW RETURN PIPE
- ② 100Ø EXISTING RETURN FROM MEZZ.

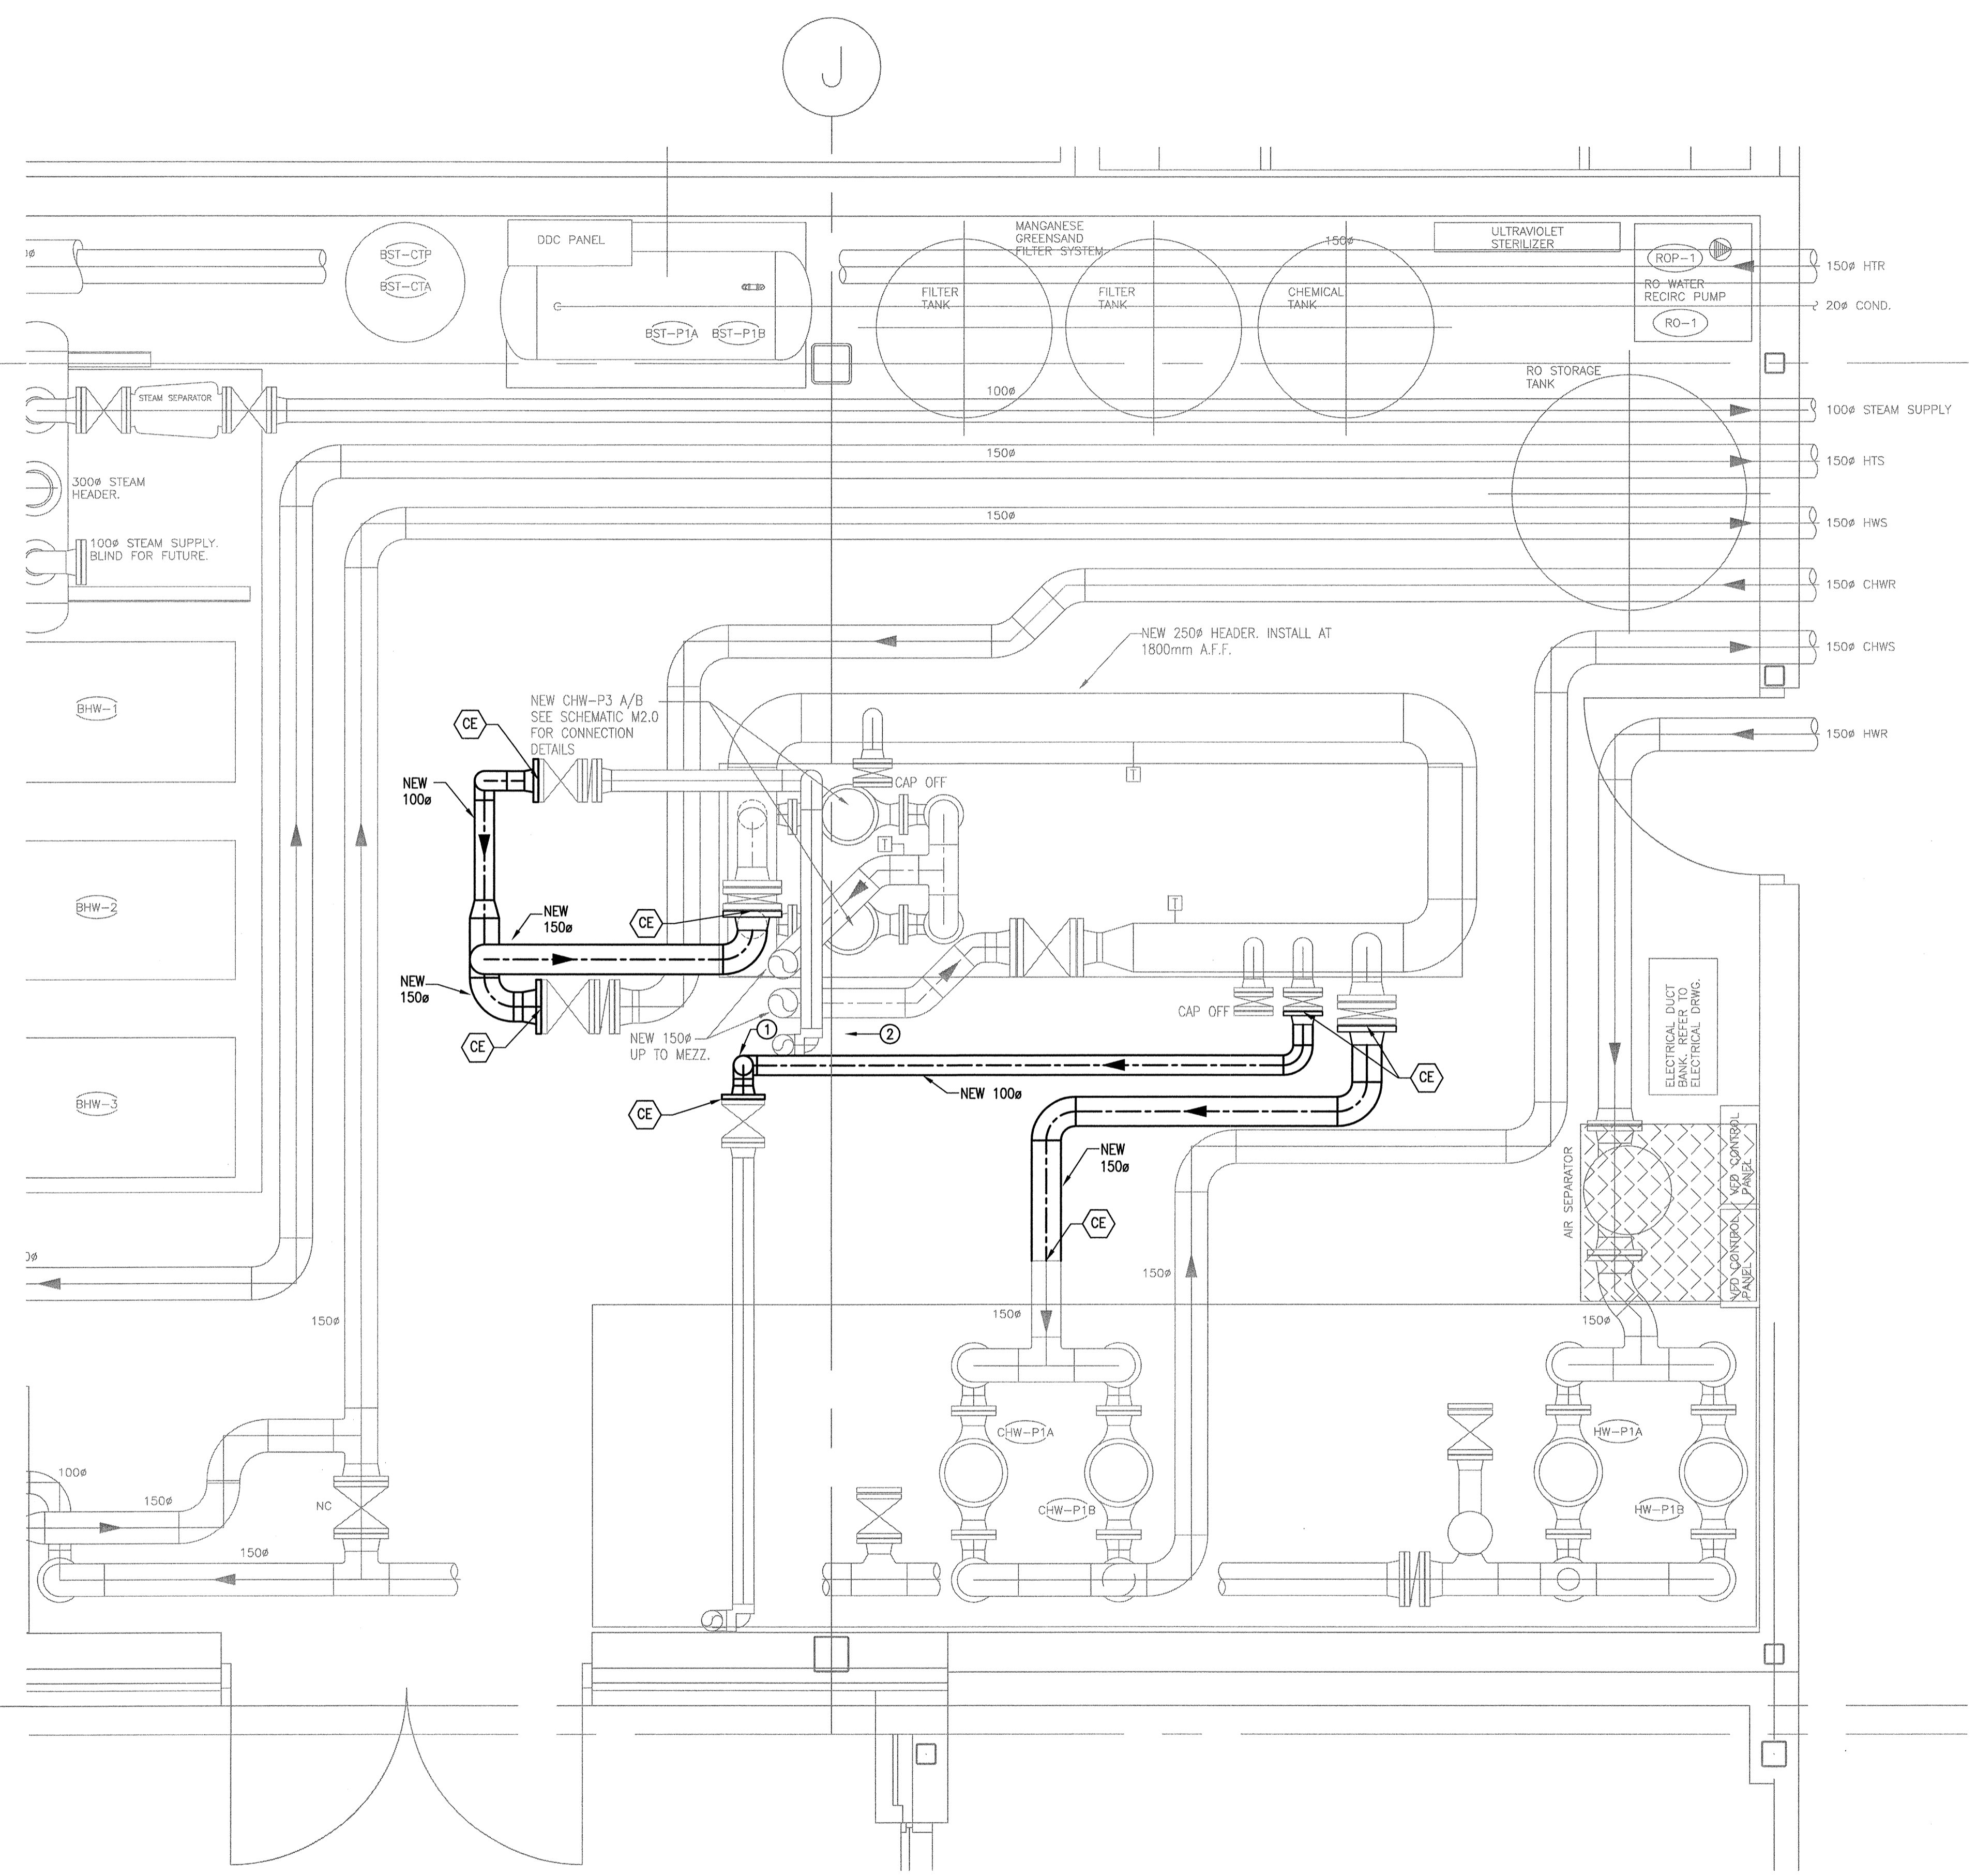

MECH ROOM PHASE 2 NEW LAYOUT PLAN
1:20

13

12

Revision/Modification	Description/Description	Date/Date
C	ISSUED FOR TENDER	14/05/02
B	100% SUBMISSION	14/01/24
A	55% SUBMISSION	13/12/13

Client/client
AGRICULTURE AND AGRI-FOODS CANADA

Project title/Titre du projet
**PARC AGASSIZ
 AGASSIZ, B.C.**
**ATES SYSTEM
 REPLACEMENT**

Approved by/Approuvé par
 NK
 Designed by/Concept par
 NK
 Drawn by/Dessiné par
 SA
 PWGSC Project Manager/Administrateur de Projets TP50C
 T. DUNPHY
 PWGSC Architectural and Engineering Resources Manager/
 Ressources Architectural et de Directeur d'Ingénierie, TP50C
 P. FUNG
 Client/client

Drawing title/Titre du dessin
 MECHANICAL ROOM PHASE
 2 NEW LAYOUT PLAN

Project No./No. du projet R.054815.001	Sheet/Feuille M4.1 OF	Revision no./ La Révision no. C
---	-----------------------------	---------------------------------------

