

KEY PLAN

Revision/Édition	Description/Description	Date/Date
C	ISSUED FOR TENDER	14/05/02
B	100% SUBMISSION	14/01/24
A	85% SUBMISSION	13/12/13

Client/client: **AGRICULTURE AND AGRI-FOODS CANADA**

Project title/Titre du projet: **PARC AGASSIZ AGASSIZ, B.C.**

**ATES SYSTEM REPLACEMENT**

Approved by/Approuvé par: **NK**

Designed by/Concept par: **NK**

Drawn by/Dessiné par: **SA**

PWSGC Project Manager/Administrateur de Projets TP50C: **T. DUNPHY**



PWSGC Architectural and Engineering Resources Manager/Ressources Architectural et de Directeur d'ingénierie, TP50C: **P. FUNG**

Client/client

Drawing title/Titre du dessin

**MECHANICAL ROOM PHASE 1 NEW LAYOUT PLAN**

Project No./No. du projet	Sheet/Feuille	Revision no./La Révision no.
R.054815.001	M2.1 OF	C

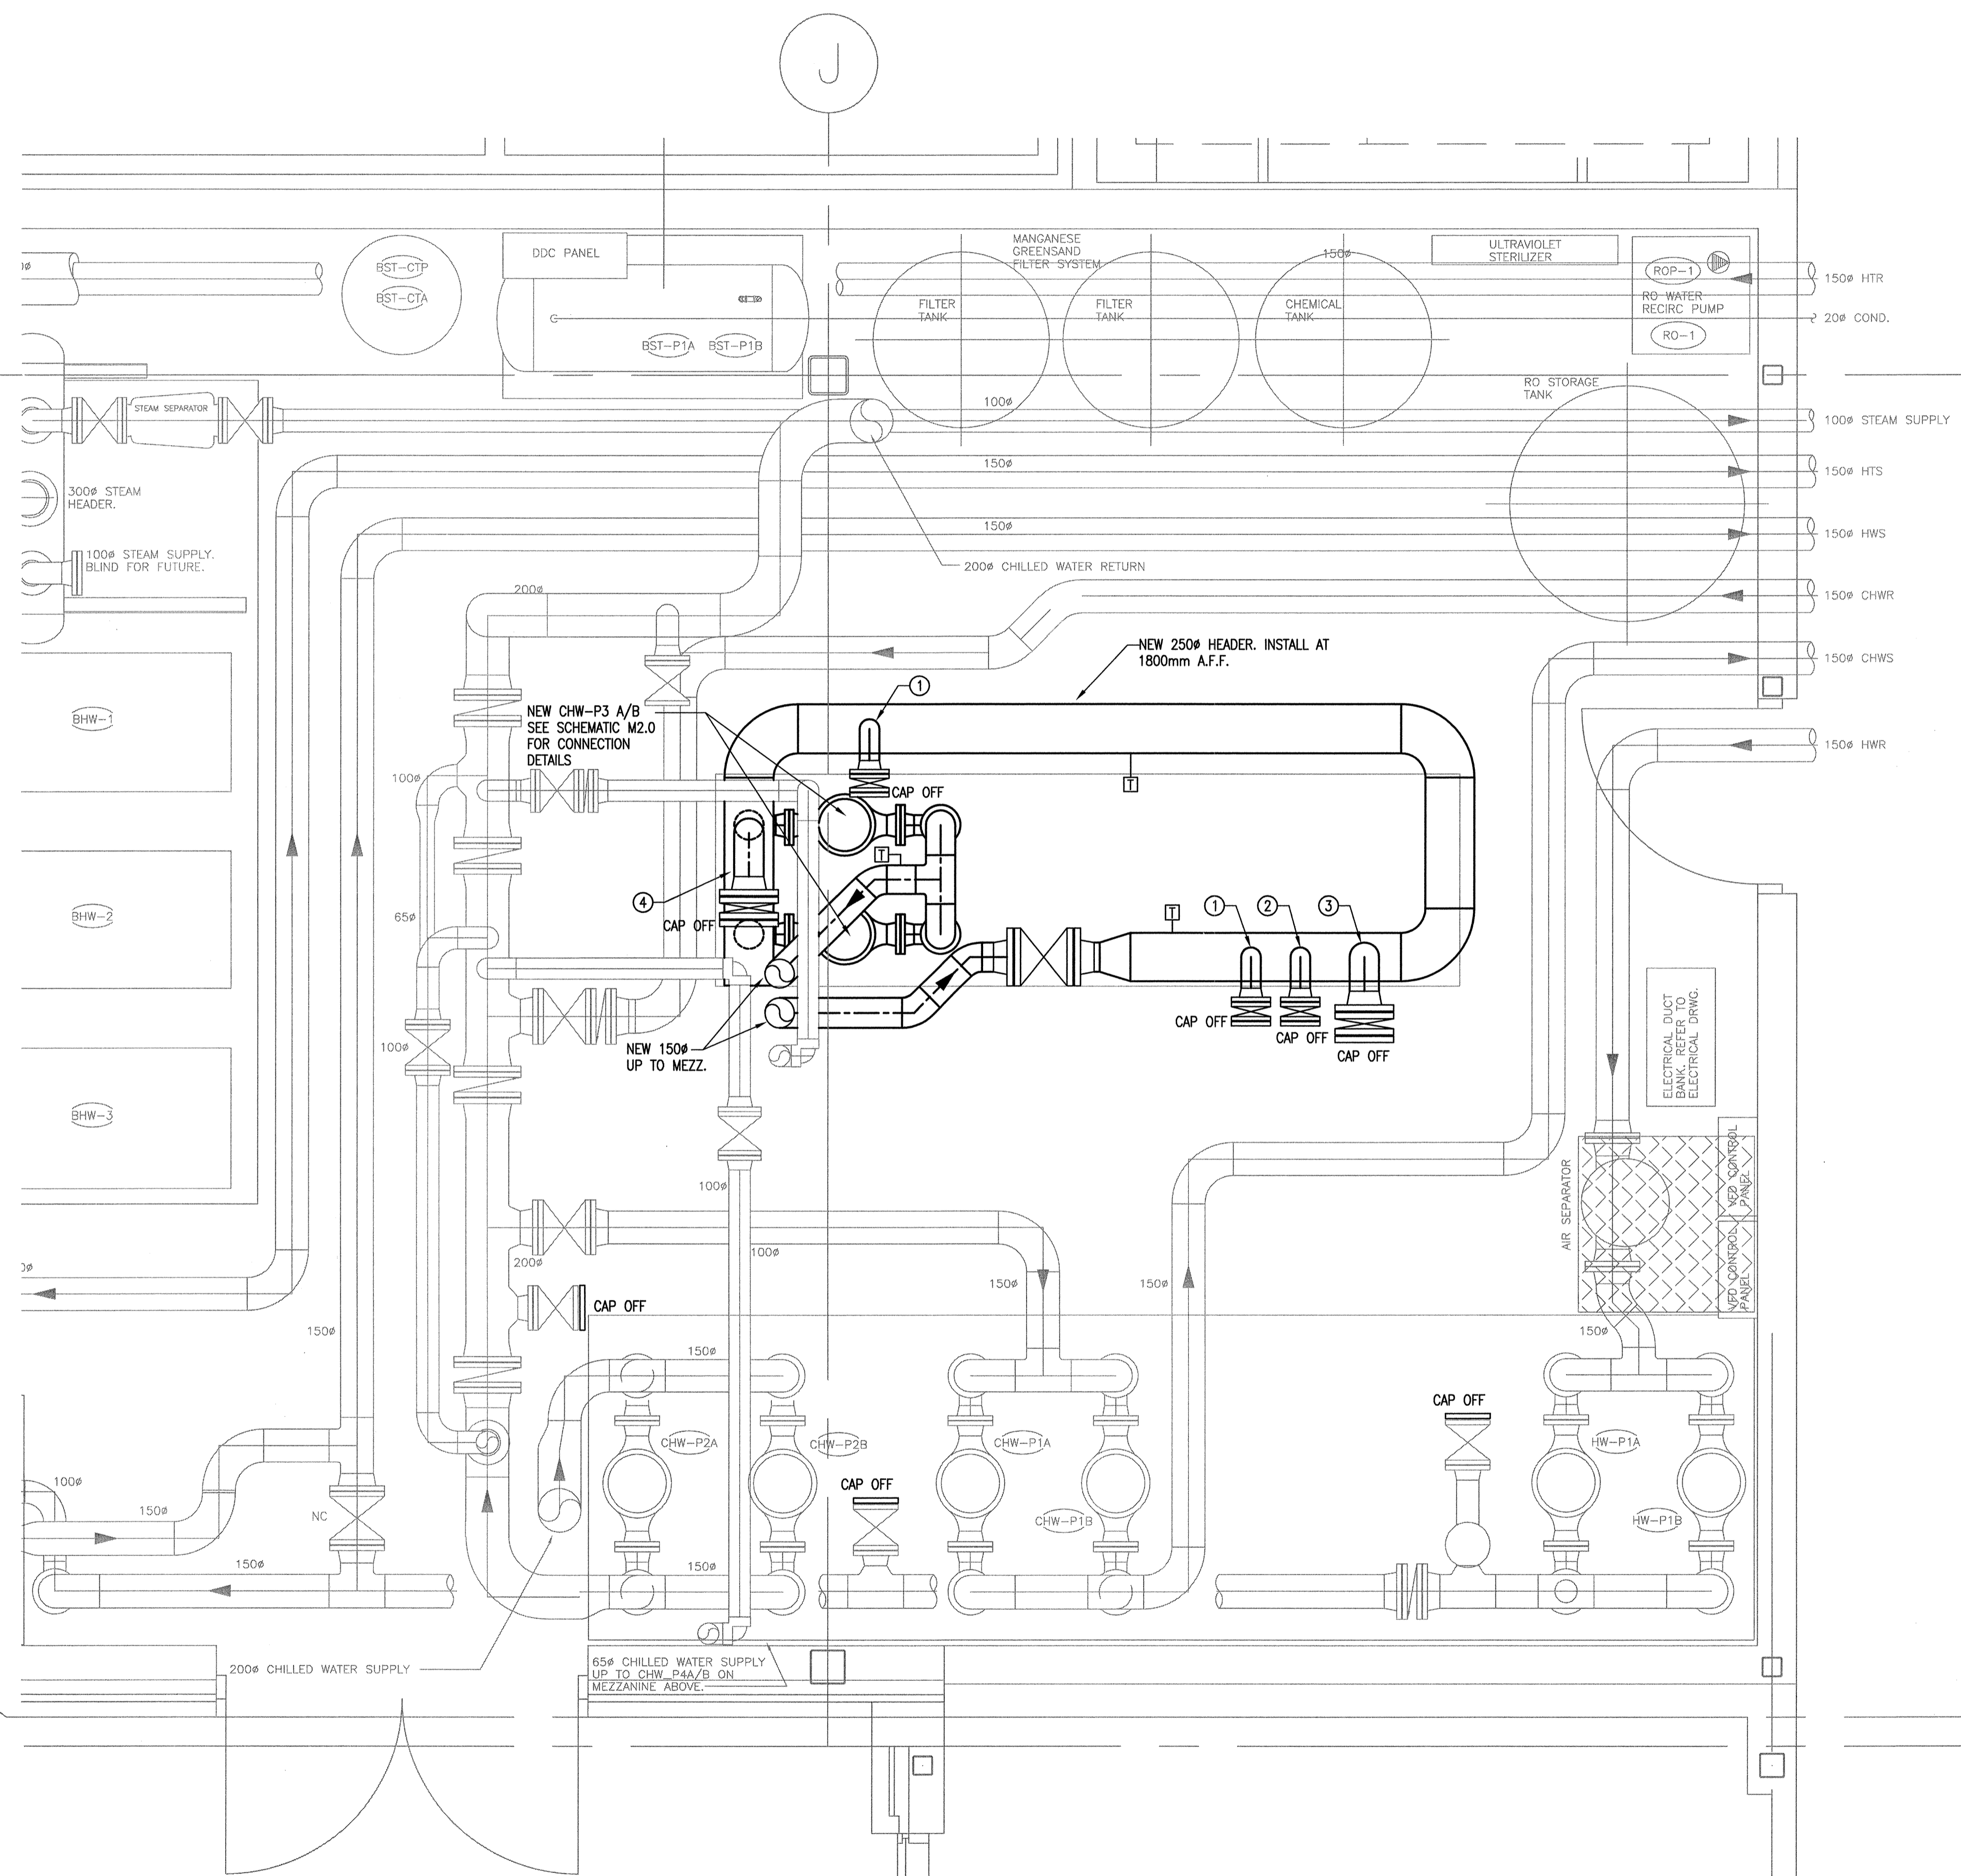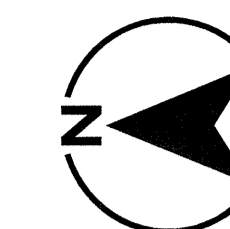

**GENERAL NOTES**

UTILIZE EXISTING DDC PANEL FOR NEW EQUIPMENT CONNECTIONS

**KEY NOTES**

- ① NEW 100# C/W VALVE AND CAP OFF FOR FUTURE USE
- ② NEW 100# C/W VALVE FOR CONNECTION TO CHW-P4 A/B AND CHW-P5 A/B IN PHASE 2
- ③ NEW 150# C/W VALVE FOR CONNECTION TO CHW-P1 A/B IN PHASE 2
- ④ NEW 150# C/W VALVE FOR CONNECTION TO CHWR LINE IN PHASE 2

MECH ROOM PHASE 1 NEW LAYOUT PLAN

1:20

