



LOCATION PLAN

**NOTE:**  
DARK LINE DENOTES NEW WORK.

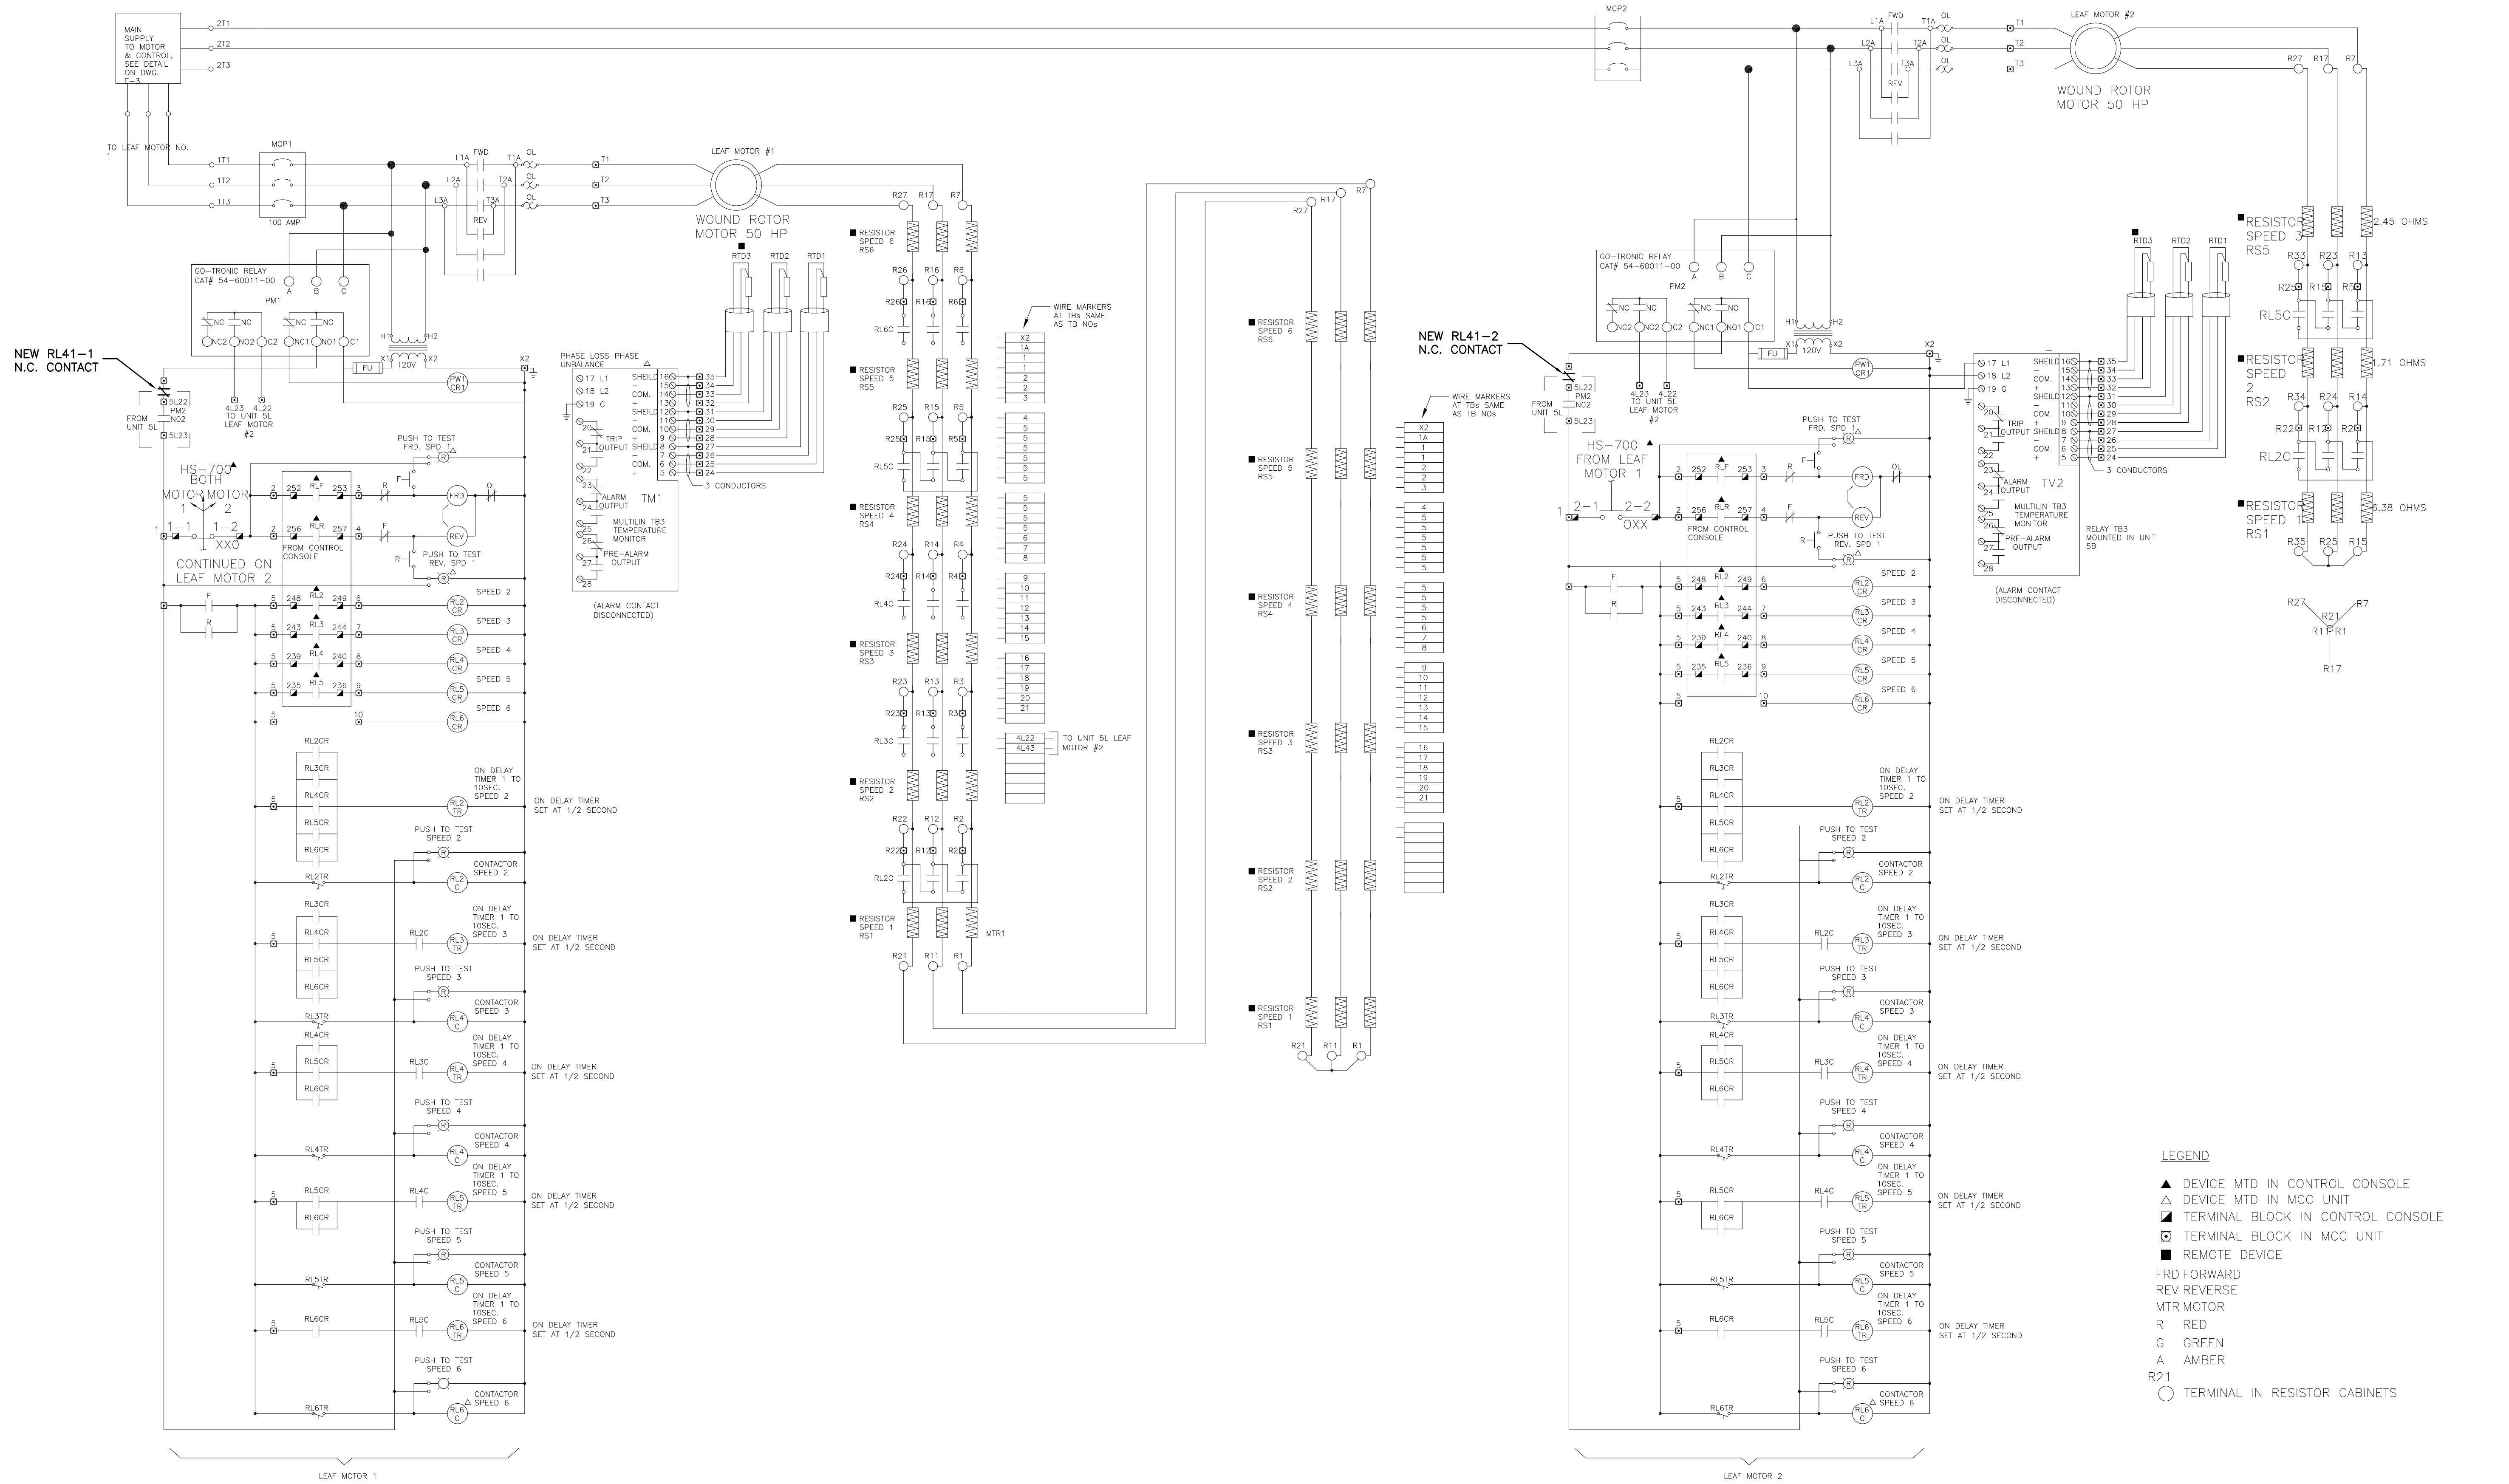


## LEGEND

- ▲ DEVICE MTD IN CONTROL CONSOLE
- △ DEVICE MTD IN MCC UNIT
- TERMINAL BLOCK IN MCC UNIT
- REMOTE DEVICE
- FWD FORWARD
- REV REVERSE
- MTR MOTOR
- R RED
- G GREEN
- A AMBER
- R21 TERMINAL IN RESISTOR CABINETS

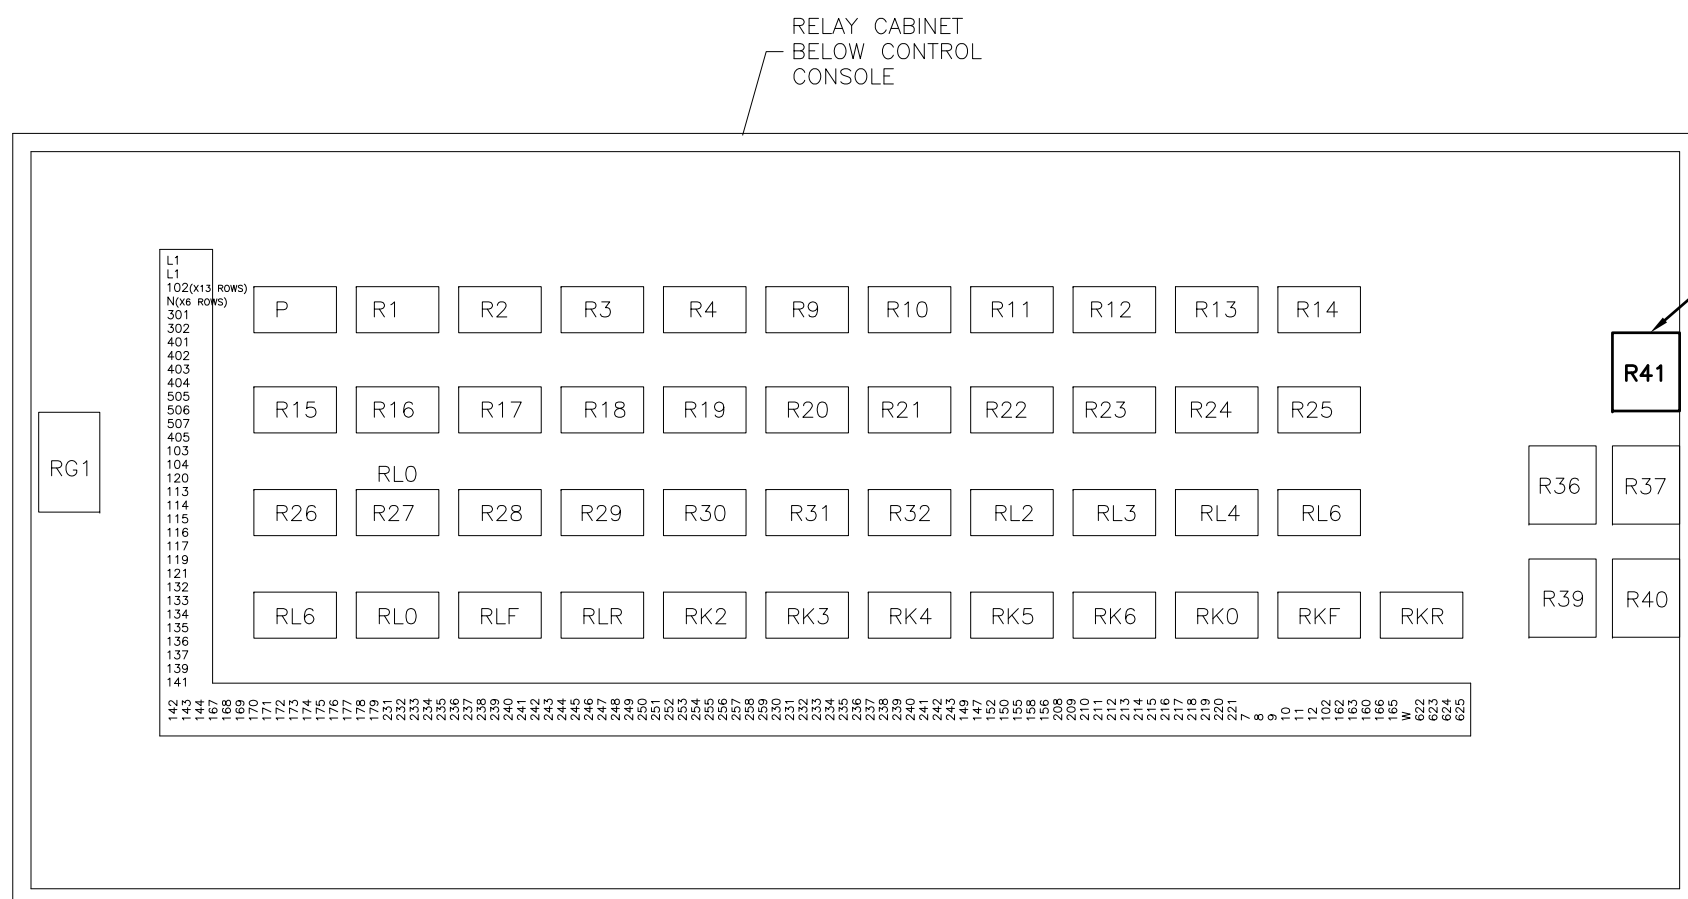

RELAY CABINET  
SCALE: NTS

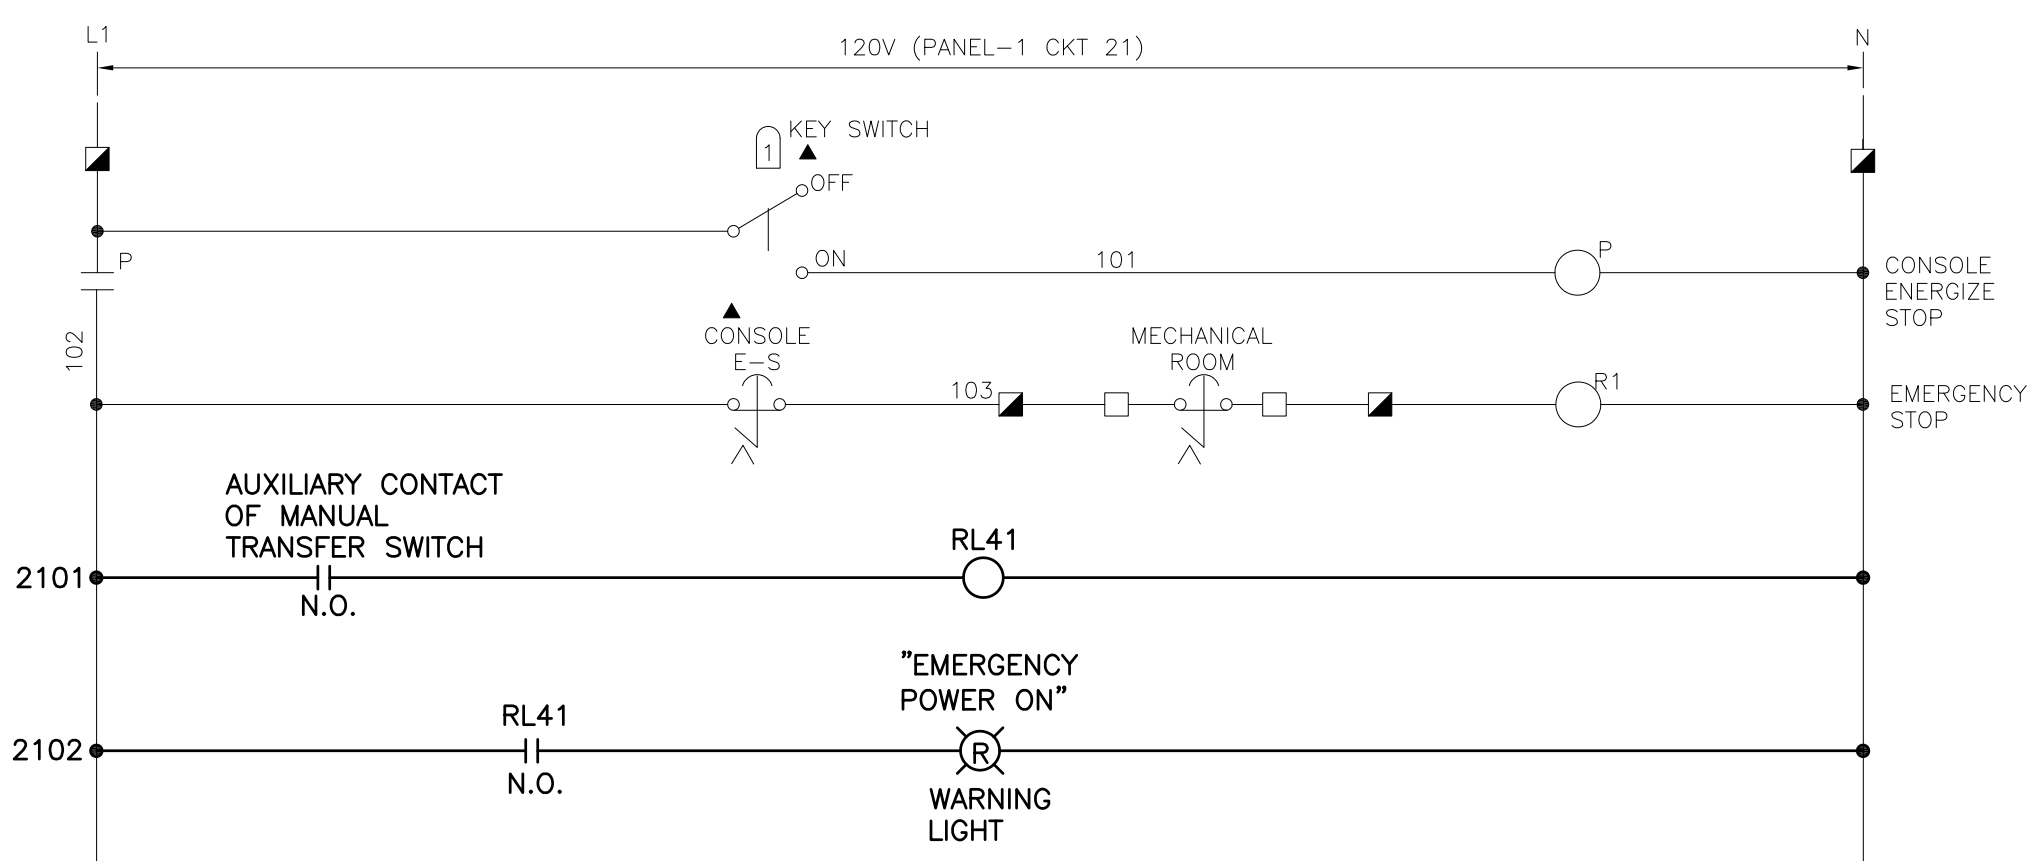

04		
03		
02		
01		
revision		date

Do not scale drawings.  
Verify all dimensions and conditions on site and immediately  
notify the Departmental Representative of all discrepancies.

A	Detail No.
B	No. du détail
C	drawing no. - where detail required
	dessin no. - où détail exigé
	drawing no. - where detailed
	dessin no. - où détaillé

project title  
titre du projet  
**KINGSTON** Ontario  
**LASALLE CAUSEWAY  
BASCULE BRIDGE**

## EMERGENCY POWER

drawing title  
titre du dessin  
**CONTROL DIAGRAM**

drawn by  
dessiné par  
**A. SOBREVILLA**

designed by  
conc par  
**TY HUYNH**

approved by  
approuvé par  
**SID KOCHAR**

bid  
offre  
project manager  
administrateur  
de projets

project date  
date du projet  
**2014-07-18**

project no.  
no. du projet  
**R.013375.034**

drawing no.  
dessiné no.  
**E-2**