


1  
M301

STEAM  
SCHEMATIC  
SCALE: N.T.S.

DRAWING NOTES

- 1 EXISTING TEE CONNECTION TO VENT FORMERLY SERVING STEAM GENERATOR #3 AND STEAM LINE FROM HEADER TO BE DEMOLISHED AND REPLACED WITH A NEW ELBOW DEDICATED TO THE STEAM LINE FROM THE STEAM

Public Works and  
Government Services Canada  
Architectural and Engineering Services  
Ontario Region  
Travaux publics et  
Services gouvernementaux Canada  
Services d'architecture et de génie  
Région de l'Ontario

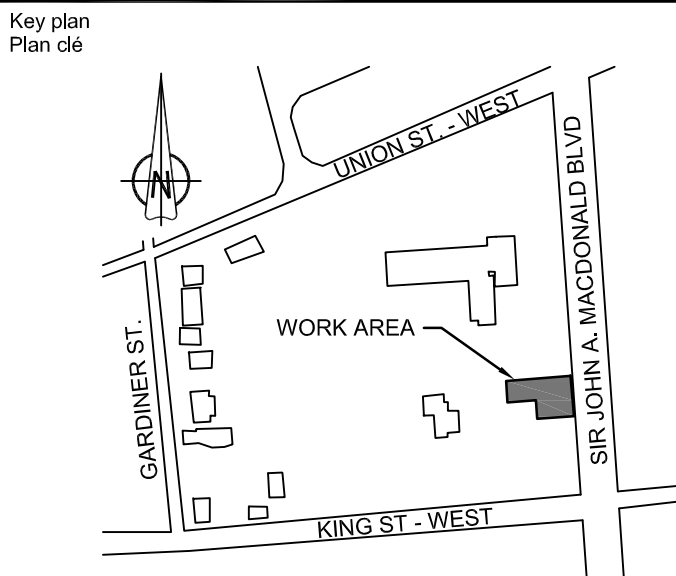

01	ISSUED FOR ADDENDUM 1	2014/08/08
00	ISSUED FOR TENDER	2014/07/24
0A	ISSUED FOR 99% REVIEW	2014/05/22
revision	description	date

Do not scale drawings.  
Verify all dimensions and conditions on site and  
immediately notify the engineer of all discrepancies.

A	Detail No. No. du détail
B	drawing no. - where detail required dessin no. - où détail exigé
C	drawing no. - where detailed dessin no. - où détaillé

project title  
titre du projet  
**OTTAWA** ONTARIO  
CLIENT  
560 KING STREET,  
KINGSTON, K7L 4V7  
**KINGSTON PENITENTIARY  
HEATING PLANT UPGRADE**

drawing title  
titre du dessin  
**SCHEMATIC  
DEMOLITION**

drawn by  
dessiné par  
DEAN PROCTOR

designed by  
conçu par  
DEAN PROCTOR

approved by  
approuvé par  
CARY MCGEE, P.ENG

tender  
soumission  
DUNCAN PARKER, P.ENG.

project manager  
administrateur  
de projets

project date  
date du projet  
2014/04/07

project no.  
no. du projet  
R.068125.001

drawing no.  
dessin no.  
M301