


**1**  
A03 **GROUND FLOOR PLAN - OFFICE 02 (MODIFICATION OF COLUMNS)**  
SCALE: 1:50

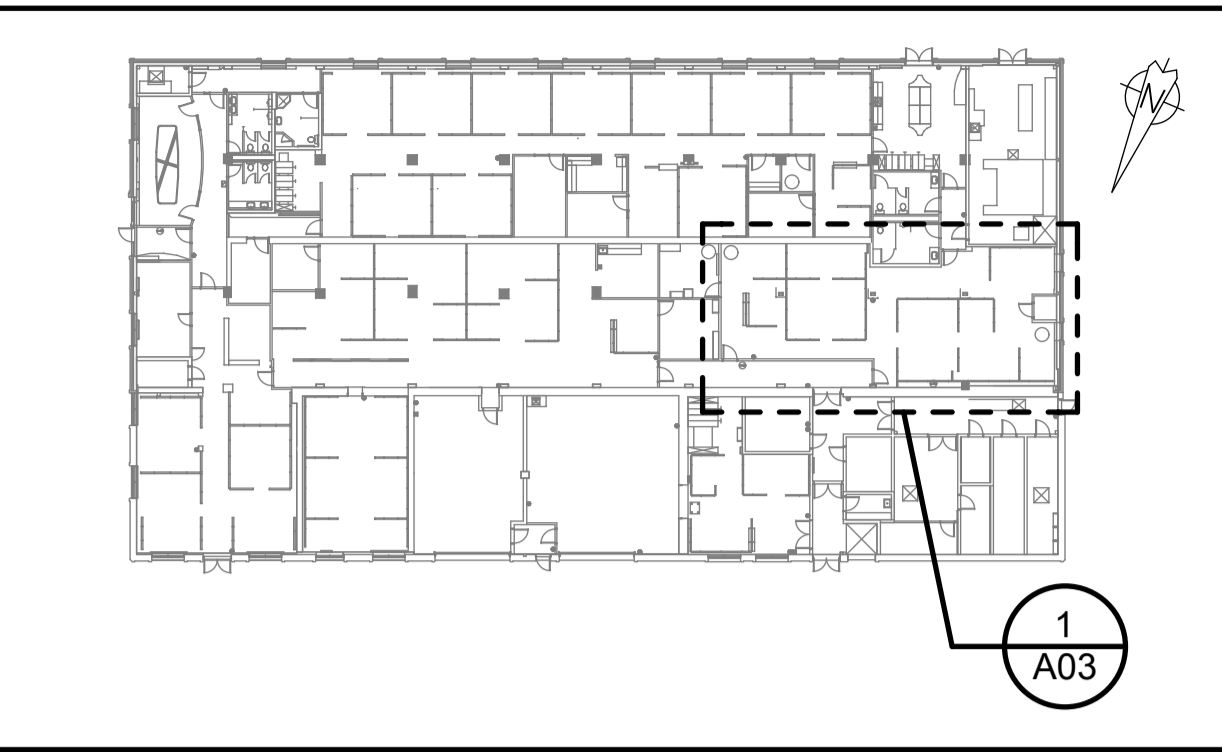

**3**  
A03 **GROUND FLOOR KEY PLAN**  
SCALE: 1:500

**GENERAL NOTES:**

E. GENERAL CONTRACTOR TO PROVIDE THE REQUIRED MECHANICAL AND ELECTRICAL ENGINEERING SERVICES TO SUCCESSFULLY COMPLETE THE CONTENT WITHIN THIS DRAWING PACKAGE. THIS INCLUDES, BUT IS NOT LIMITED TO:

- THE DEMOLITION OR RELOCATION OF EXISTING ELECTRICAL AND MECHANICAL SYSTEMS REQUIRED TO COMPLETE THE SCOPE OF WORK.
- THE DESIGN OF ANY PROPOSED NEW ELECTRICAL AND MECHANICAL SYSTEMS.
- THE PROPOSED M & E SYSTEMS INCLUDED IN THESE DRAWINGS ARE SCHEMATIC ONLY.
- COMPLETION OF ANY RELATED BUILDING PERMIT AND CONSTRUCTION DOCUMENTS.
- ASSOCIATED CONSTRUCTION REVIEW AND FINAL APPROVAL PROCESS.

THE NEW PROPOSED HVAC SYSTEM INSTALLATION IS THE EXCEPTION (NOTE F).

F. GENERAL CONTRACTOR TO COORDINATE WITH THE NEW PROPOSED HVAC INSTALLATION (SEPARATE PROJECT) FOR THE LOCATION OF SKYLIGHTS, AND THE HVAC INTEGRATION INTO THE NEW PROPOSED SUSPENDED ACOUSTICAL CEILING TILE/GRID (NOTE 29).

**Canada**  
Public Works and Government Services Canada / Travaux publics et services gouvernementaux Canada  
HEALTH CANADA / SANTÉ CANADA

**ILG & ILG**  
ILG AND ILG INC  
ARCHITECTURE & INTERIOR DESIGN  
200 General Ave., Ottawa, Ontario K1Z 7W8  
Phone: 613 231 2379  
ILG and ILG@Architects-InteriorDesigners.com

**ONTARIO ASSOCIATION OF ARCHITECTS**  
1985 ILG  
SCIENCE  
1429

Contractor to verify all dimensions & conditions on site and immediately notify the consultant of all discrepancies.


revisions	description	date
2	ISSUED FOR TENDER	2014/11/24
1	ISSUED FOR 99% COMPLETION REVIEW	2014/09/30

A C	A detail no. no. du detail	A B C	A detail no. no. du detail
	B location drawing no. sur dessin no.		B location drawing no. sur dessin no.
	C drawing no. dessin no.		C drawing no. dessin no.

project **HEALTH CANADA OCCUPATIONAL HEALTH UNIT (OHU) MODERNIZATION PROJECT** projet  
51 CHARDON DRIVEWAY  
TUNNEY'S PASTURE

drawing **OHU: GROUND FLOOR PLAN MODIFICATION OF COLUMNS** dessin

Designed By	Conçu par
Date	(yyyy/mm/dd)
Drawn By	Dessiné par
Date	2014/11/24 (yyyy/mm/dd)
Reviewed By	Examiné par
Date	2014/11/24 (yyyy/mm/dd)
Approved By	Approuvé par
Date	(yyyy/mm/dd)
Tender	Soumission
Project Manager	Administrateur de projets
Project no.	No. du projet
<b>H-018221</b>	
Drawing no.	No. du dessin
<b>A03</b>	

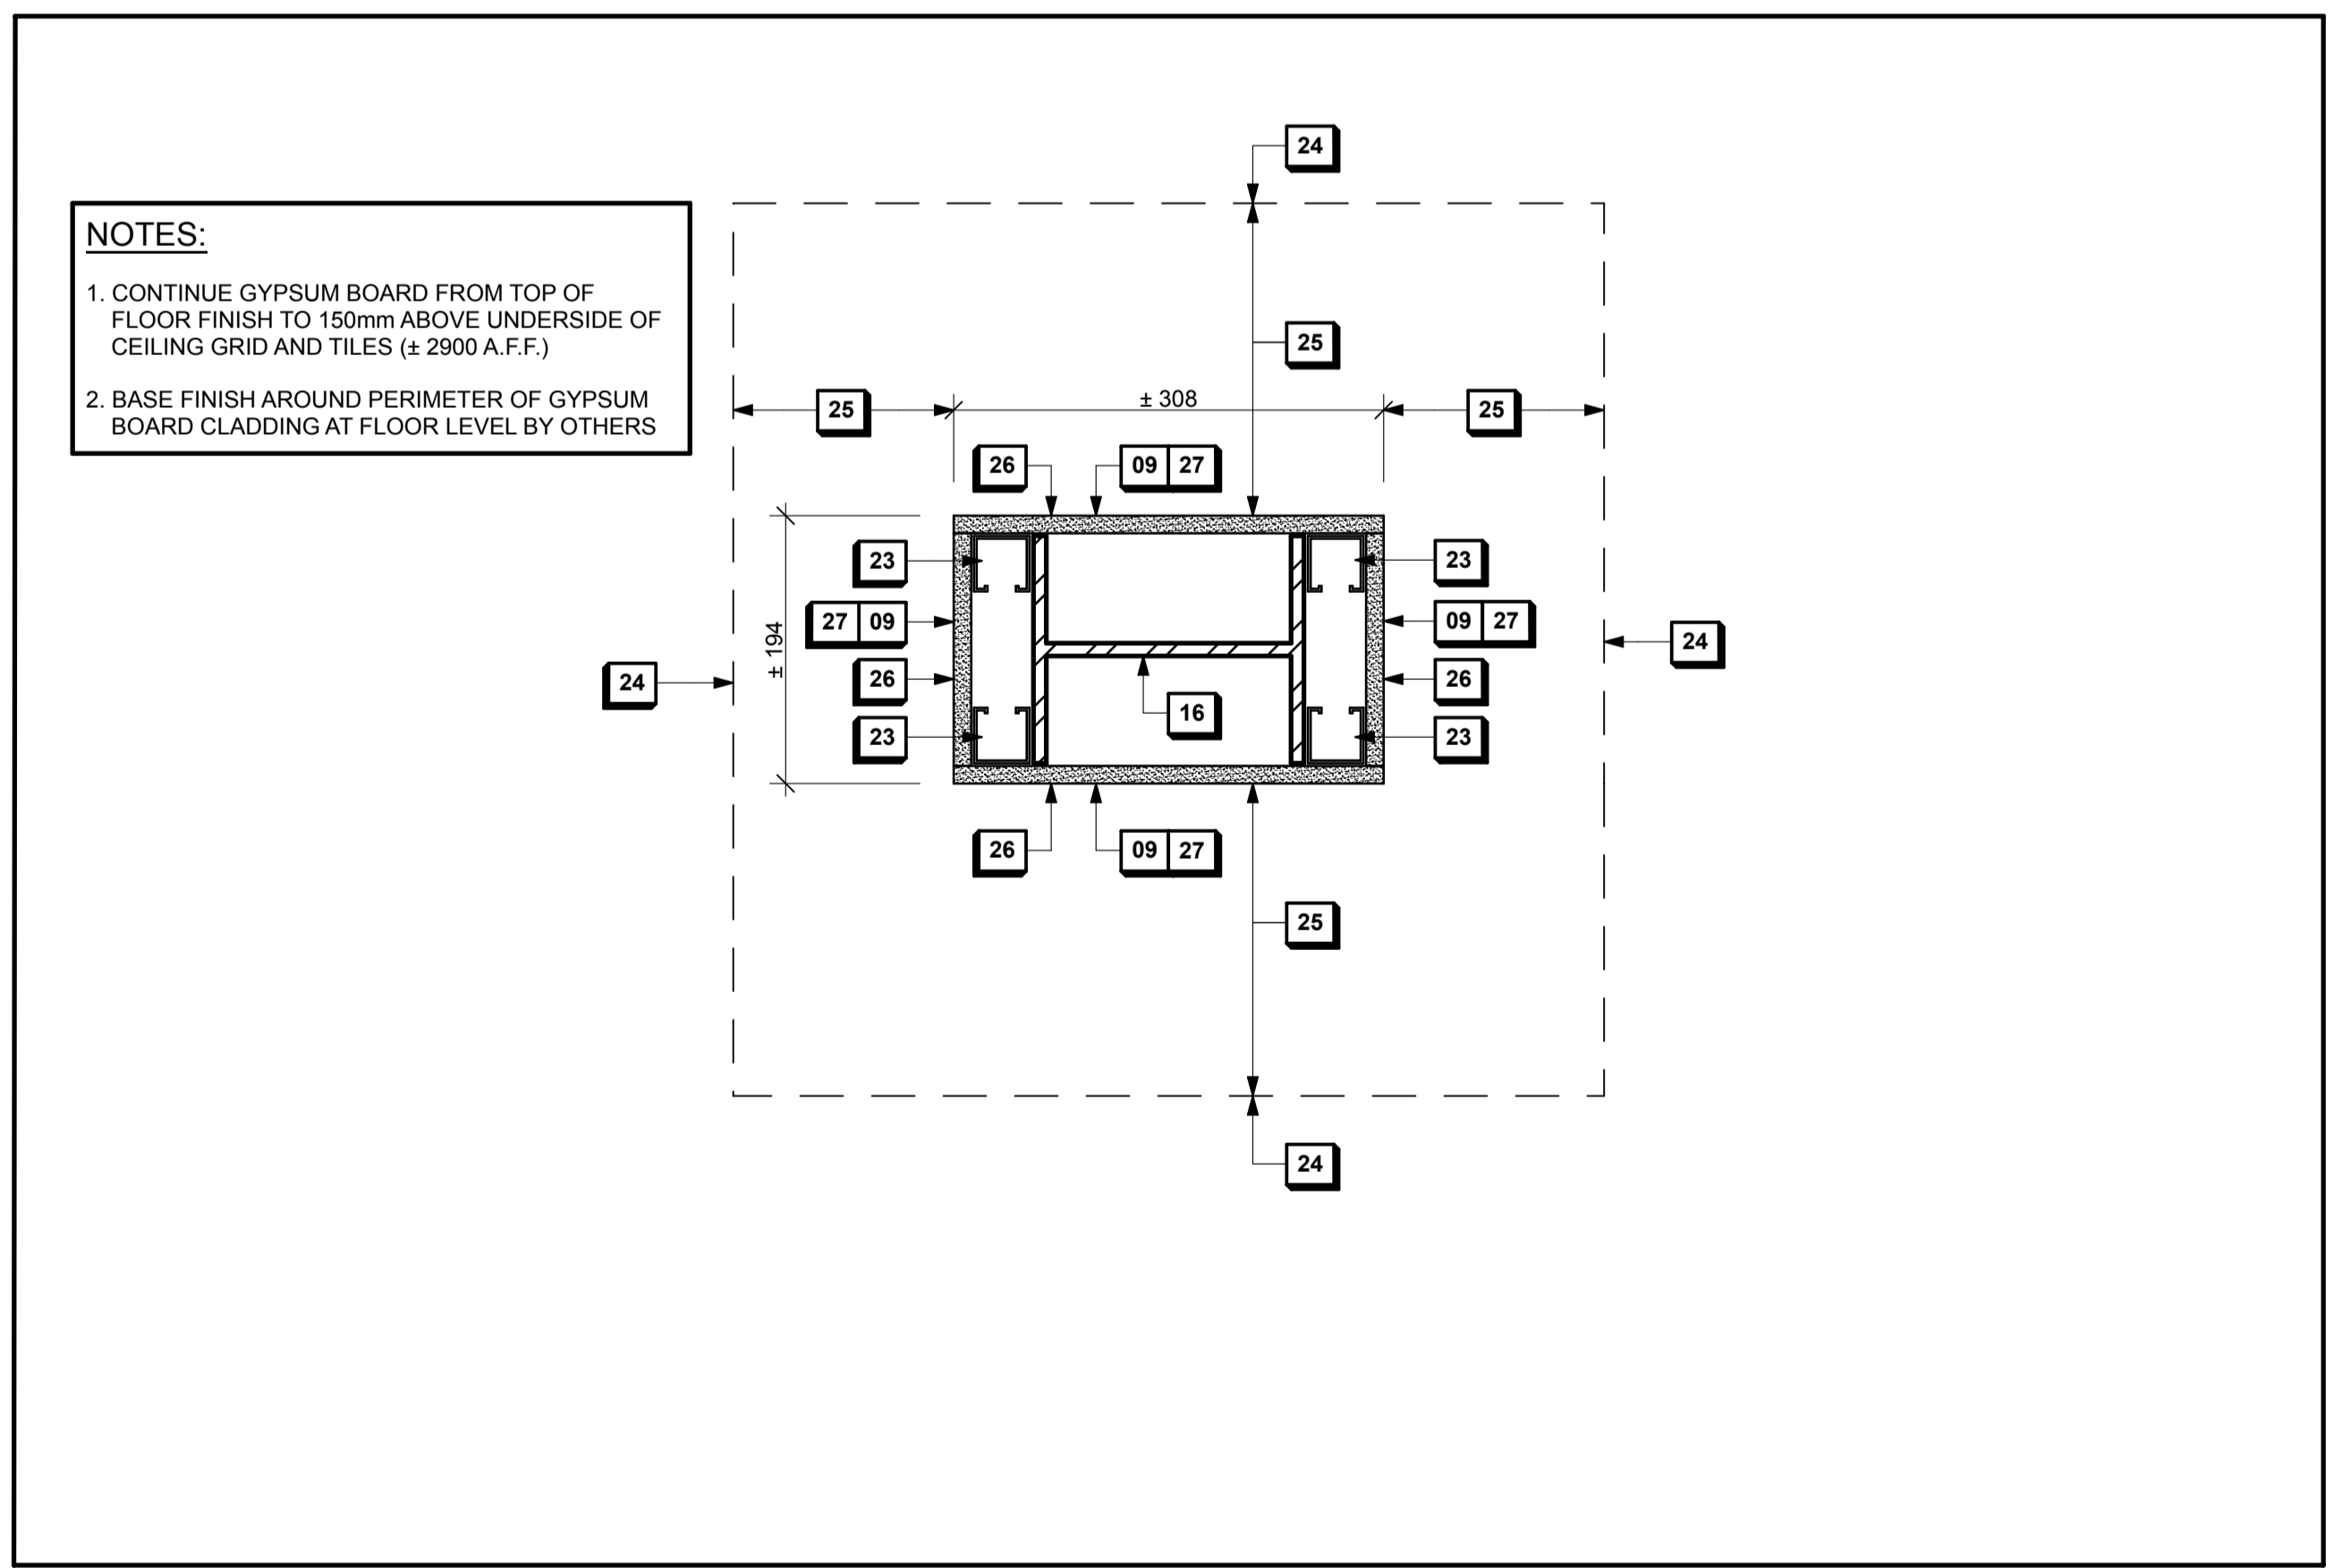

**2**  
A03 **NEW COLUMN FINISH - PLAN DETAIL**  
SCALE: 1:5