

Public Works and Government Services Canada
 Travaux publics et Services gouvernementaux Canada
 Ontario Region


Public Works and Government Services Canada
 Travaux publics et Services gouvernementaux Canada
 Région de l'Ontario

CONSULTANTS
 Public Works and Government Services Canada
 Architectural and Engineering Services
 Ontario Region

Revisions	Date
ISSUED FOR EDC REVIEW	26/04/2021
ISSUED FOR TENDER	26/04/2021


CEILING LEGEND

- REFLECTED CEILING: EXISTING
- SUSPENDED ACOUSTIC CEILING GRID
- GYPSUM BOARD: EXISTING
- GYPSUM BOARD: NEW AS NOTED, TO MATCH EXISTING TYPE IN ALL RESPECTS
- REFLECTED CEILING: 16 mm GYPSUM BD. BULKHEAD ON METAL FURRING AS NOTED AND DETAILED
- SUSPENDED CEILING: EXISTING
- SUSPENDED METAL LINEAR CEILING SYSTEM TO REMAIN, UNLESS OTHERWISE NOTED
- SPRINKLERS: SEE MECHANICAL PLAN FOR FINAL SCOPE OF WORK
- AIR DIFFUSER IN SUSP. CEILING: SEE MECHANICAL PLAN FOR FINAL SCOPE OF WORK
- LIGHTING FIXTURES IN SUSP. CEILING: SEE ELECTRICAL PLAN FOR FINAL SCOPE OF WORK
- LIGHTING FIXTURES IN EXP. CEILING: SEE ELECTRICAL PLAN FOR FINAL SCOPE OF WORK
- EXISTING HEAT OR SMOKE DETECTOR
- (13) OUTLINE OF WORK NOTES

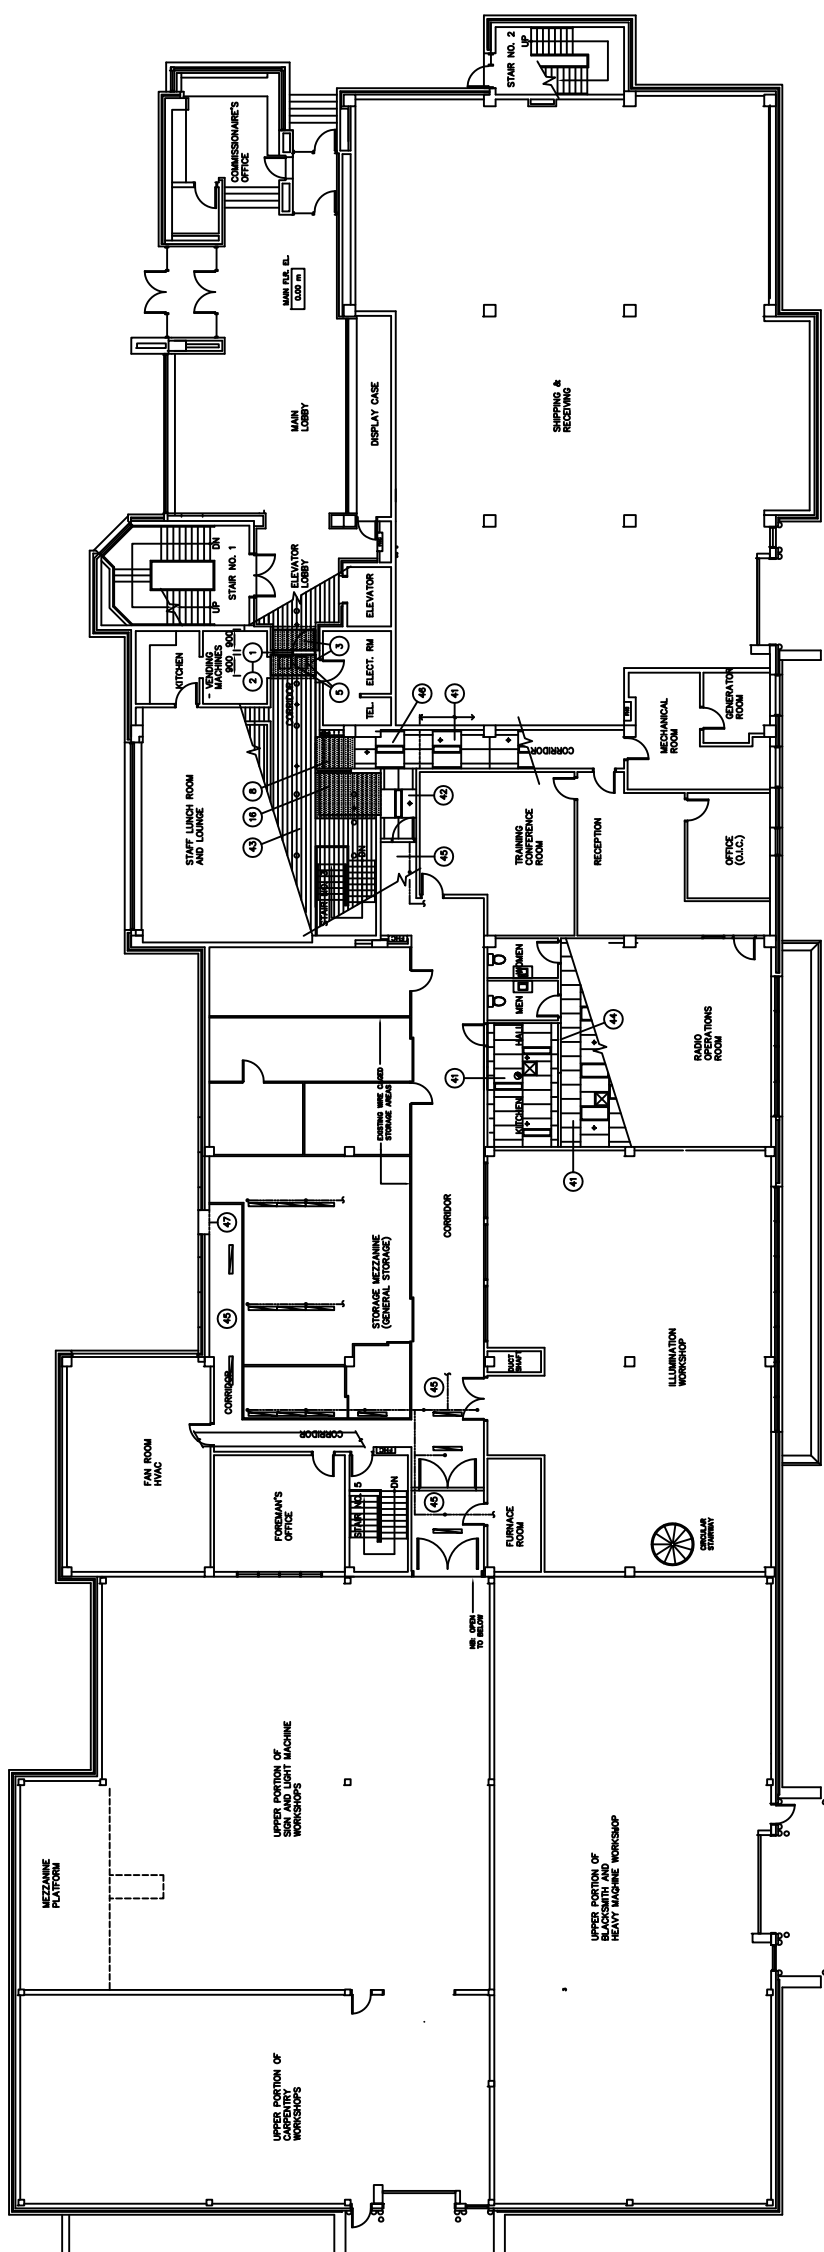


MEZZANINE FLOOR PLAN - REFLECTED CEILING

1:125
0 1 m 5 m 10 m

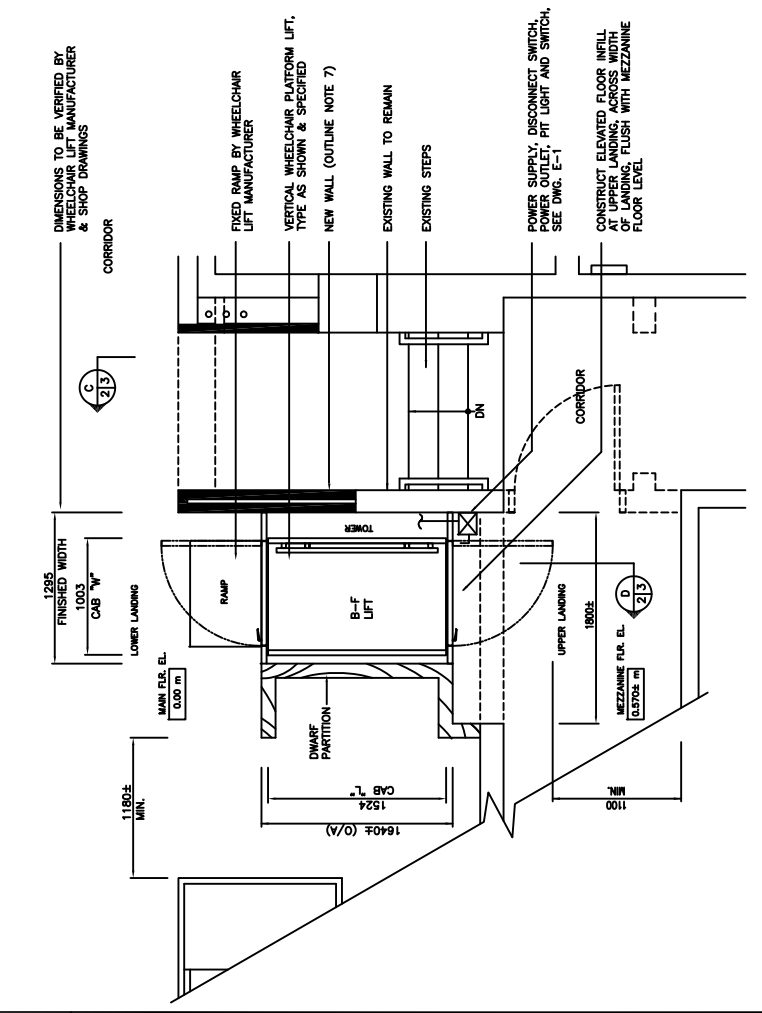


VERTICAL LIFT LAYOUT

1:25
0 1 m 2.5 m

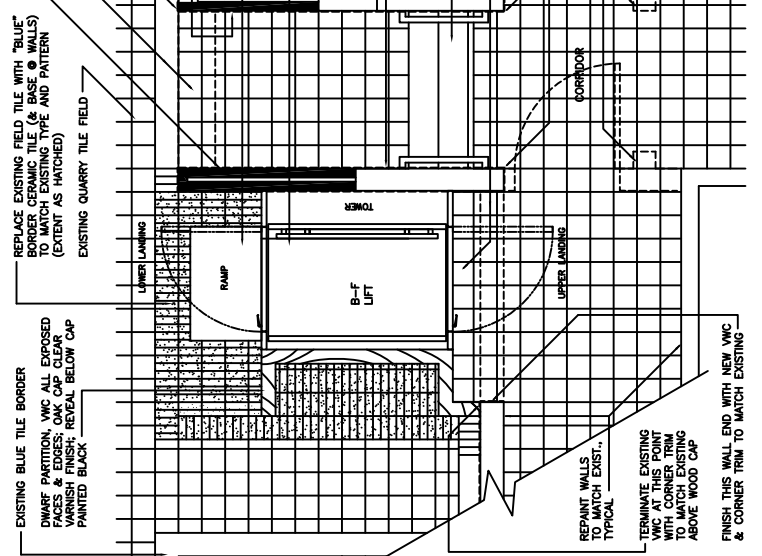

DWARF PARTITION

1:10
0 0.1 m 0.5 m 1 m

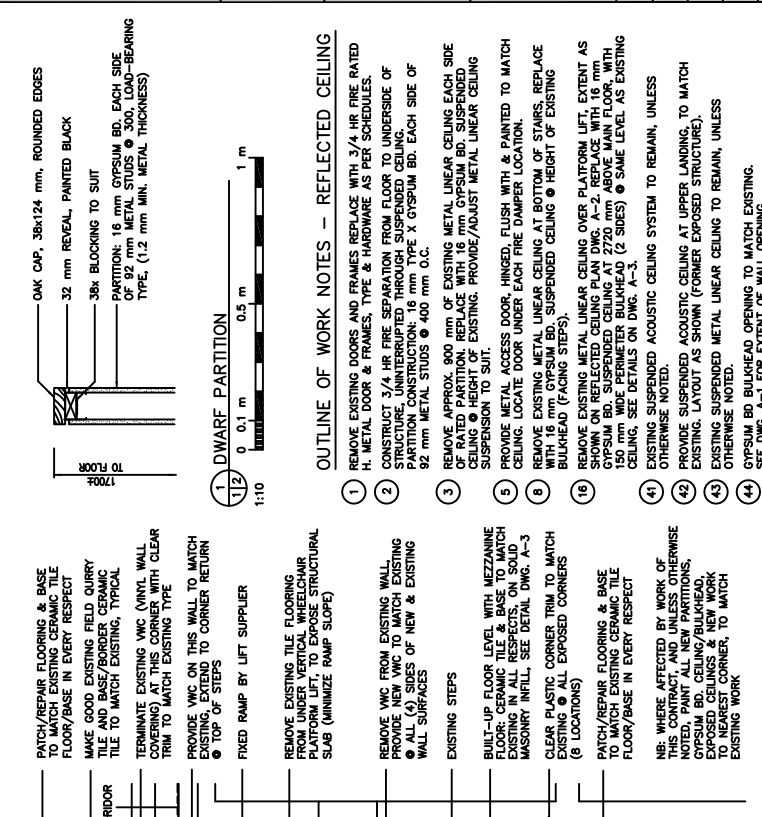

PROJECT TITLE
 PRESCOOTT
 MARINE BASE COMPLEX
 401 KING STREET WEST
 ONTARIO

DRAWING TITLE
 FIRE EXIT IMPROVEMENTS
 MEZZANINE FLOOR PLAN -
 REFLECTED CEILING
 PLATFORM LIFT LAYOUT
 FLOOR/WALL FINISHES @ LIFT

DESIGNED BY
 G.BREDA

DRAWN BY
 G.B.

REVIEWED BY
 [Signature]

APPROVED BY
 [Signature]

PROJECT DATE
 2004-10-31

PROJECT NO.
 304404

DRAWING NO.
 A-2