

 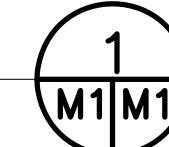
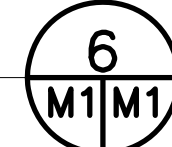



KEY — PLAN
N.T.S.

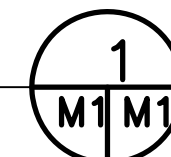

0	
revisions	date
project	project
<p>BREAKWATER RELOCATION AND BASIN EXPANSION</p> <p>STANLEY BRIDGE QUEENS COUNTY, P.E.I.</p>	
drawing	dessin
<p>SITE PLAN EXISTING</p>	
designed	conçue
N.L., P.Eng	
date	28 NOV 2014
drawn	N.L.
date	28 NOV 2014
approved	approuvé
date	
Tender	Soumission
PWOSC Project Manager	Administrateur de projets TPSC
project number	no. du projet
<p>R.064507.001</p>	
drawing no.	no. du dessin

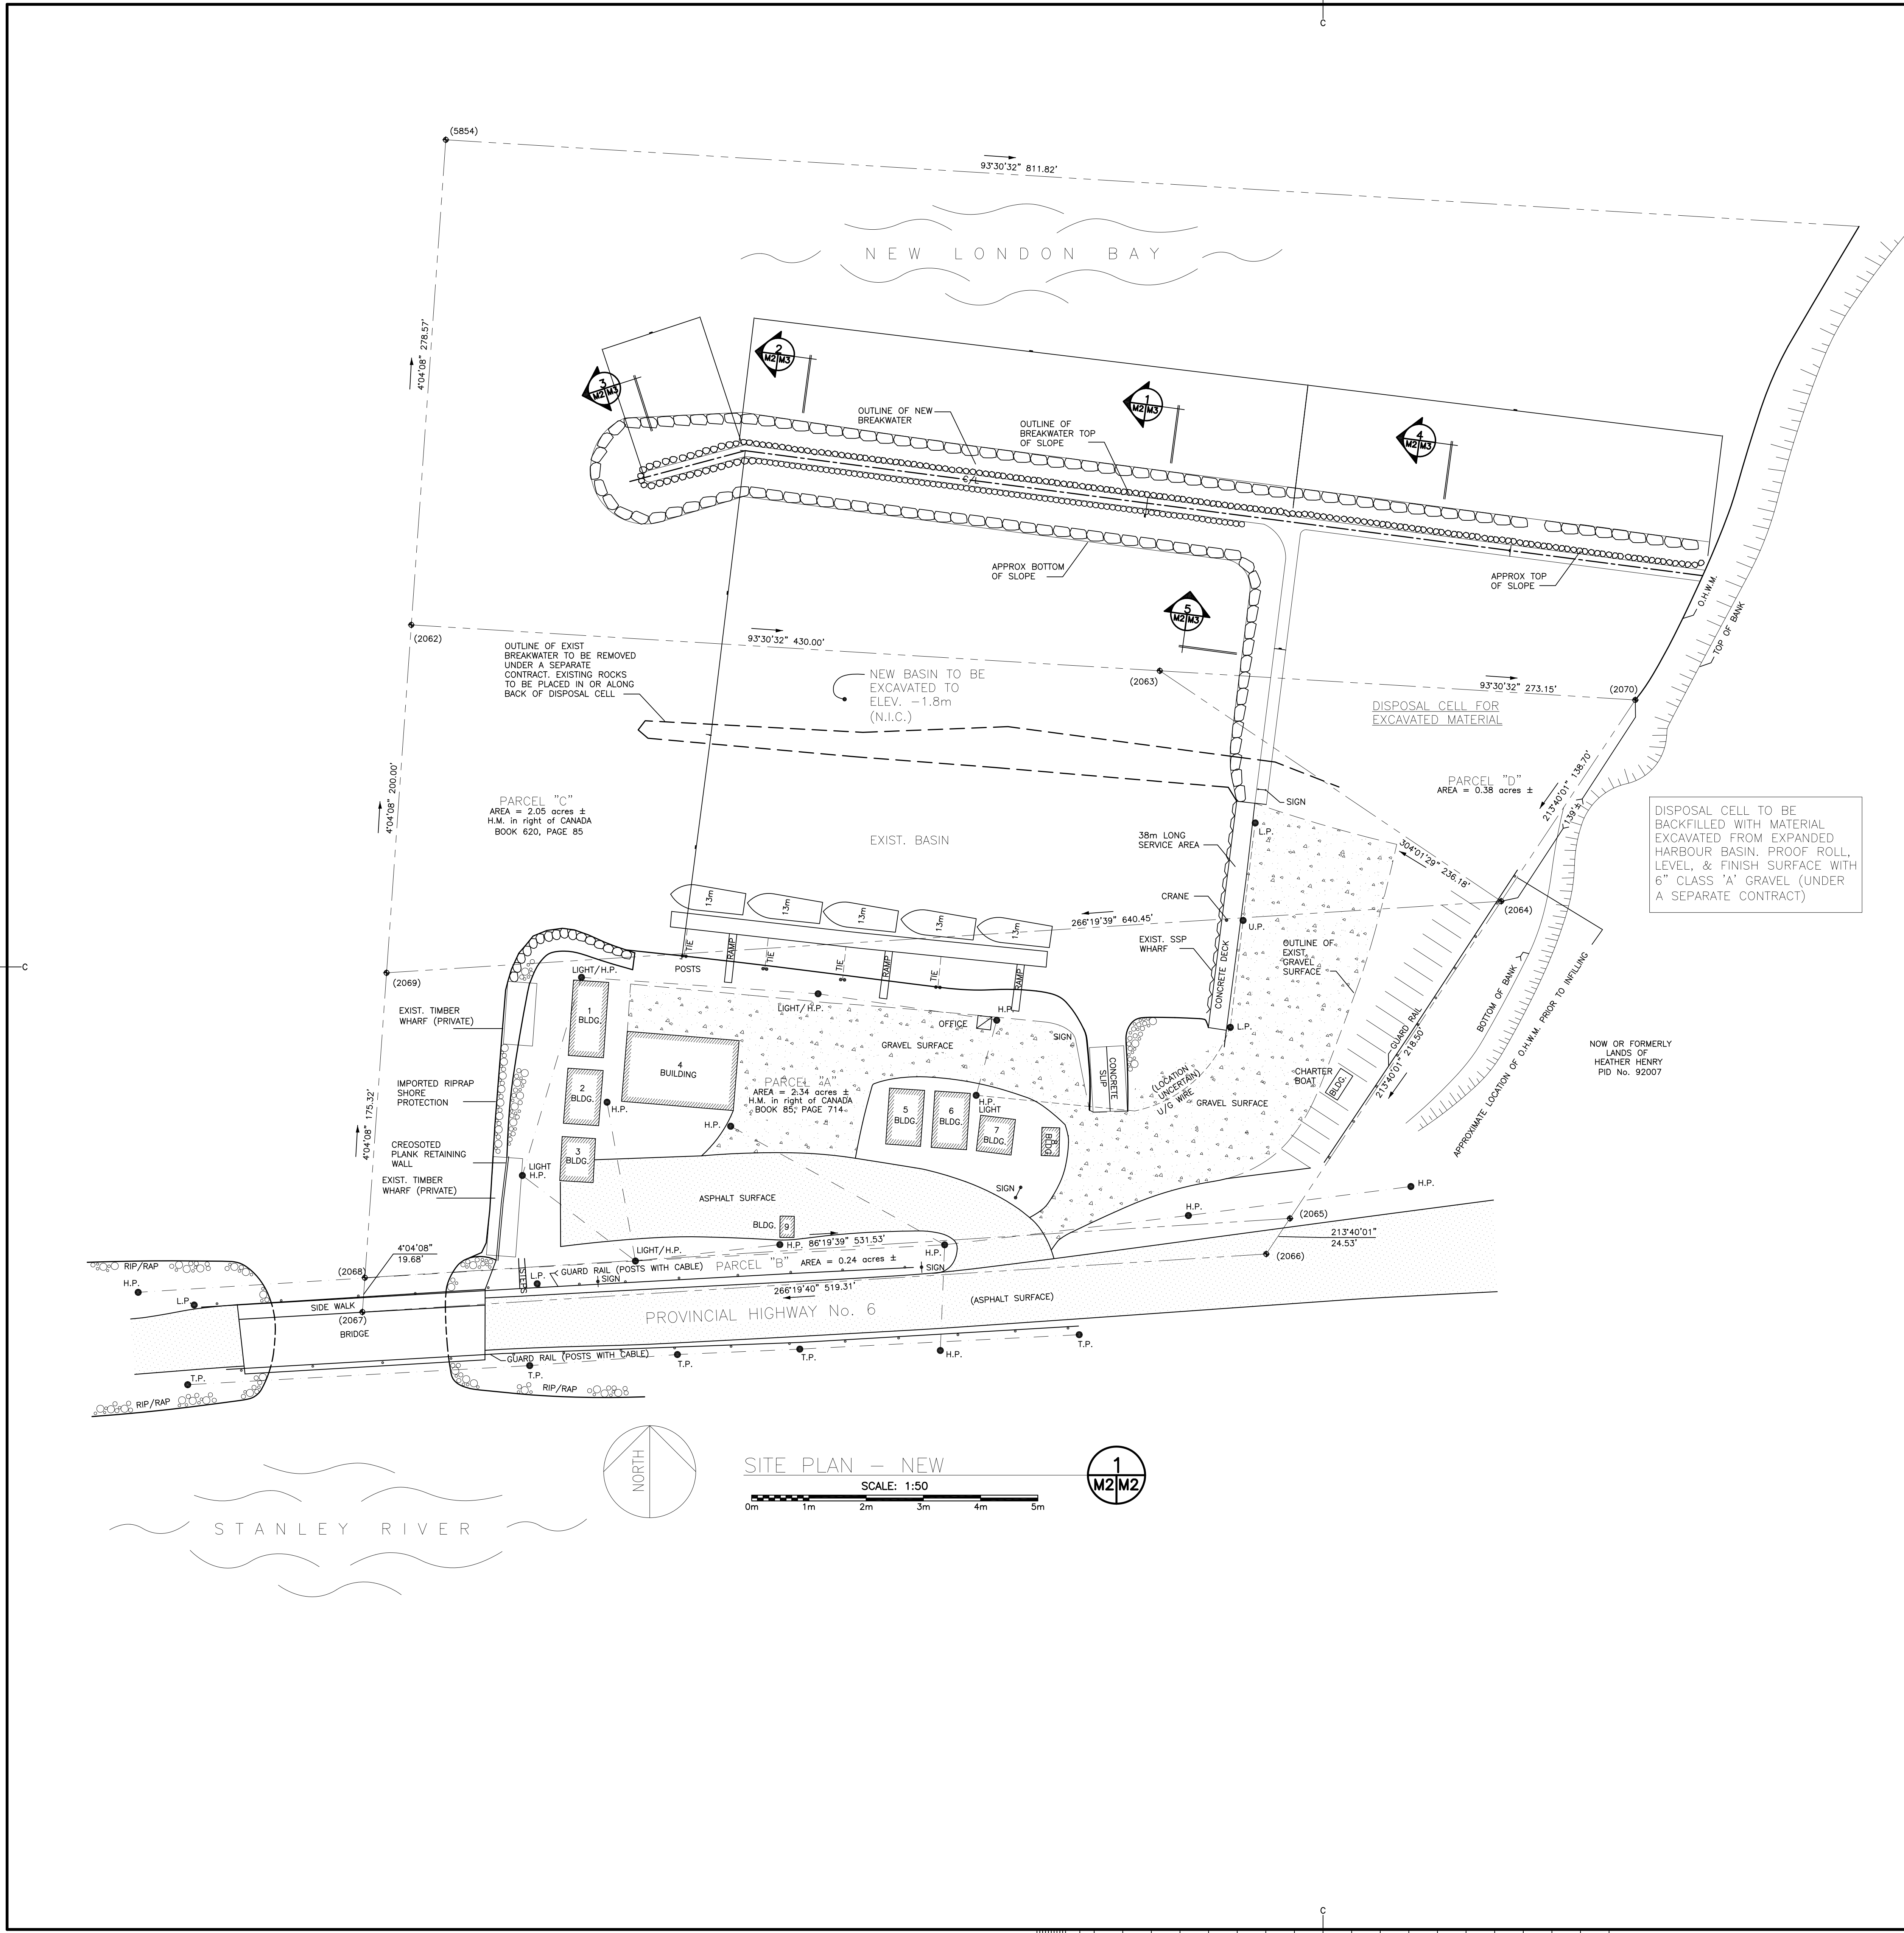

LEGEND

- LANDS DEALT WITH BY THIS PLAN
FENCE
CALCULATED POINT
HYDRO POLE
TELEPHONE POLE
LIGHT POLE
UTILITY POLE
RIP/RAP
GUARD RAIL
OVERHEAD WIRE
UNDERGROUND WIRE
PARCEL IDENTIFIER
PLACED SURVEY MARKER

PROPERTY LINE
NEW SANITARY LINE
NEW SANITARY FORCE MAIN
EXIST. SANITARY LINE
NEW WATER LINE
EXISTING WATER LINE
ROAD CENTER LINE
EXISTING ELEVATION
NEW ELEVATION
EXISTING SANITARY MANHOLE
NEW SANITARY MANHOLE
EXISTING WATER VALVE
NEW WATER VALVE
NEW REDUCER
EXISTING UTILITY POLE
NEW FIRE HYDRANT
EXISTING TREES


LIFT STATION

GENERAL NOTES:

1. EXAMINE SITE AND REPORT ANY DISCREPANCIES TO THE DEPARTMENTAL REPRESENTATIVE BEFORE PROCEEDING WITH THE WORK.
2. ALL DIMENSIONS AND ELEVATIONS ARE IN METRIC UNITS U.N.O.
3. SURVEY DATA AND EXISTING TOPOGRAPHIC INFORMATION HAS BEEN OBTAINED BY LOCUS SURVEY, DWG 94611, DATED 3 NOV 2004, DATED ... 2005.
4. SOUNDING DATA OBTAINED AND PROVIDED BY DFO ON A DWG DATED 30 MAY 2008.
5. SUBSURFACE INVESTIGATION WAS CARRIED OUT BY STANTEC AND REPORT DATED 31 MARCH 2014 IS AVAILABLE FOR REVIEW AT PWGSC CHARLOTTETOWN OFFICE.
6. PREVENT MOVEMENT OR SETTLEMENT AND SAFEGUARD AND MAINTAIN INTEGRITY OF EXISTING STRUCTURES, ADJACENT STRUCTURES, SERVICES AND ADJACENT GRADES AND ALSO MINIMIZE EXCAVATION.
7. CONSTRUCTION SEQUENCE TO BE PROPOSED BY THE CONTRACTOR AND TO BE REVIEWED BY THE DEPARTMENTAL REPRESENTATIVE PRIOR TO CONSTRUCTION.




0		
revisions		date
project	BREAKWATER RELOCATION AND BASIN EXPANSION	
	STANLEY BRIDGE QUEENS COUNTY, P.E.I.	
drawing	SITE PLAN NEW	
designed	N.L., P.Eng	conçu
date	28 NOV 2014	
drawn	N.L.	dessiné
date	28 NOV 2014	
approved		approuvé
date		
Tender		Soumission
PWGSC Project Manager	Administrateur de projets TPWSC	
project number	R.064507.001	
drawing no.	M2	

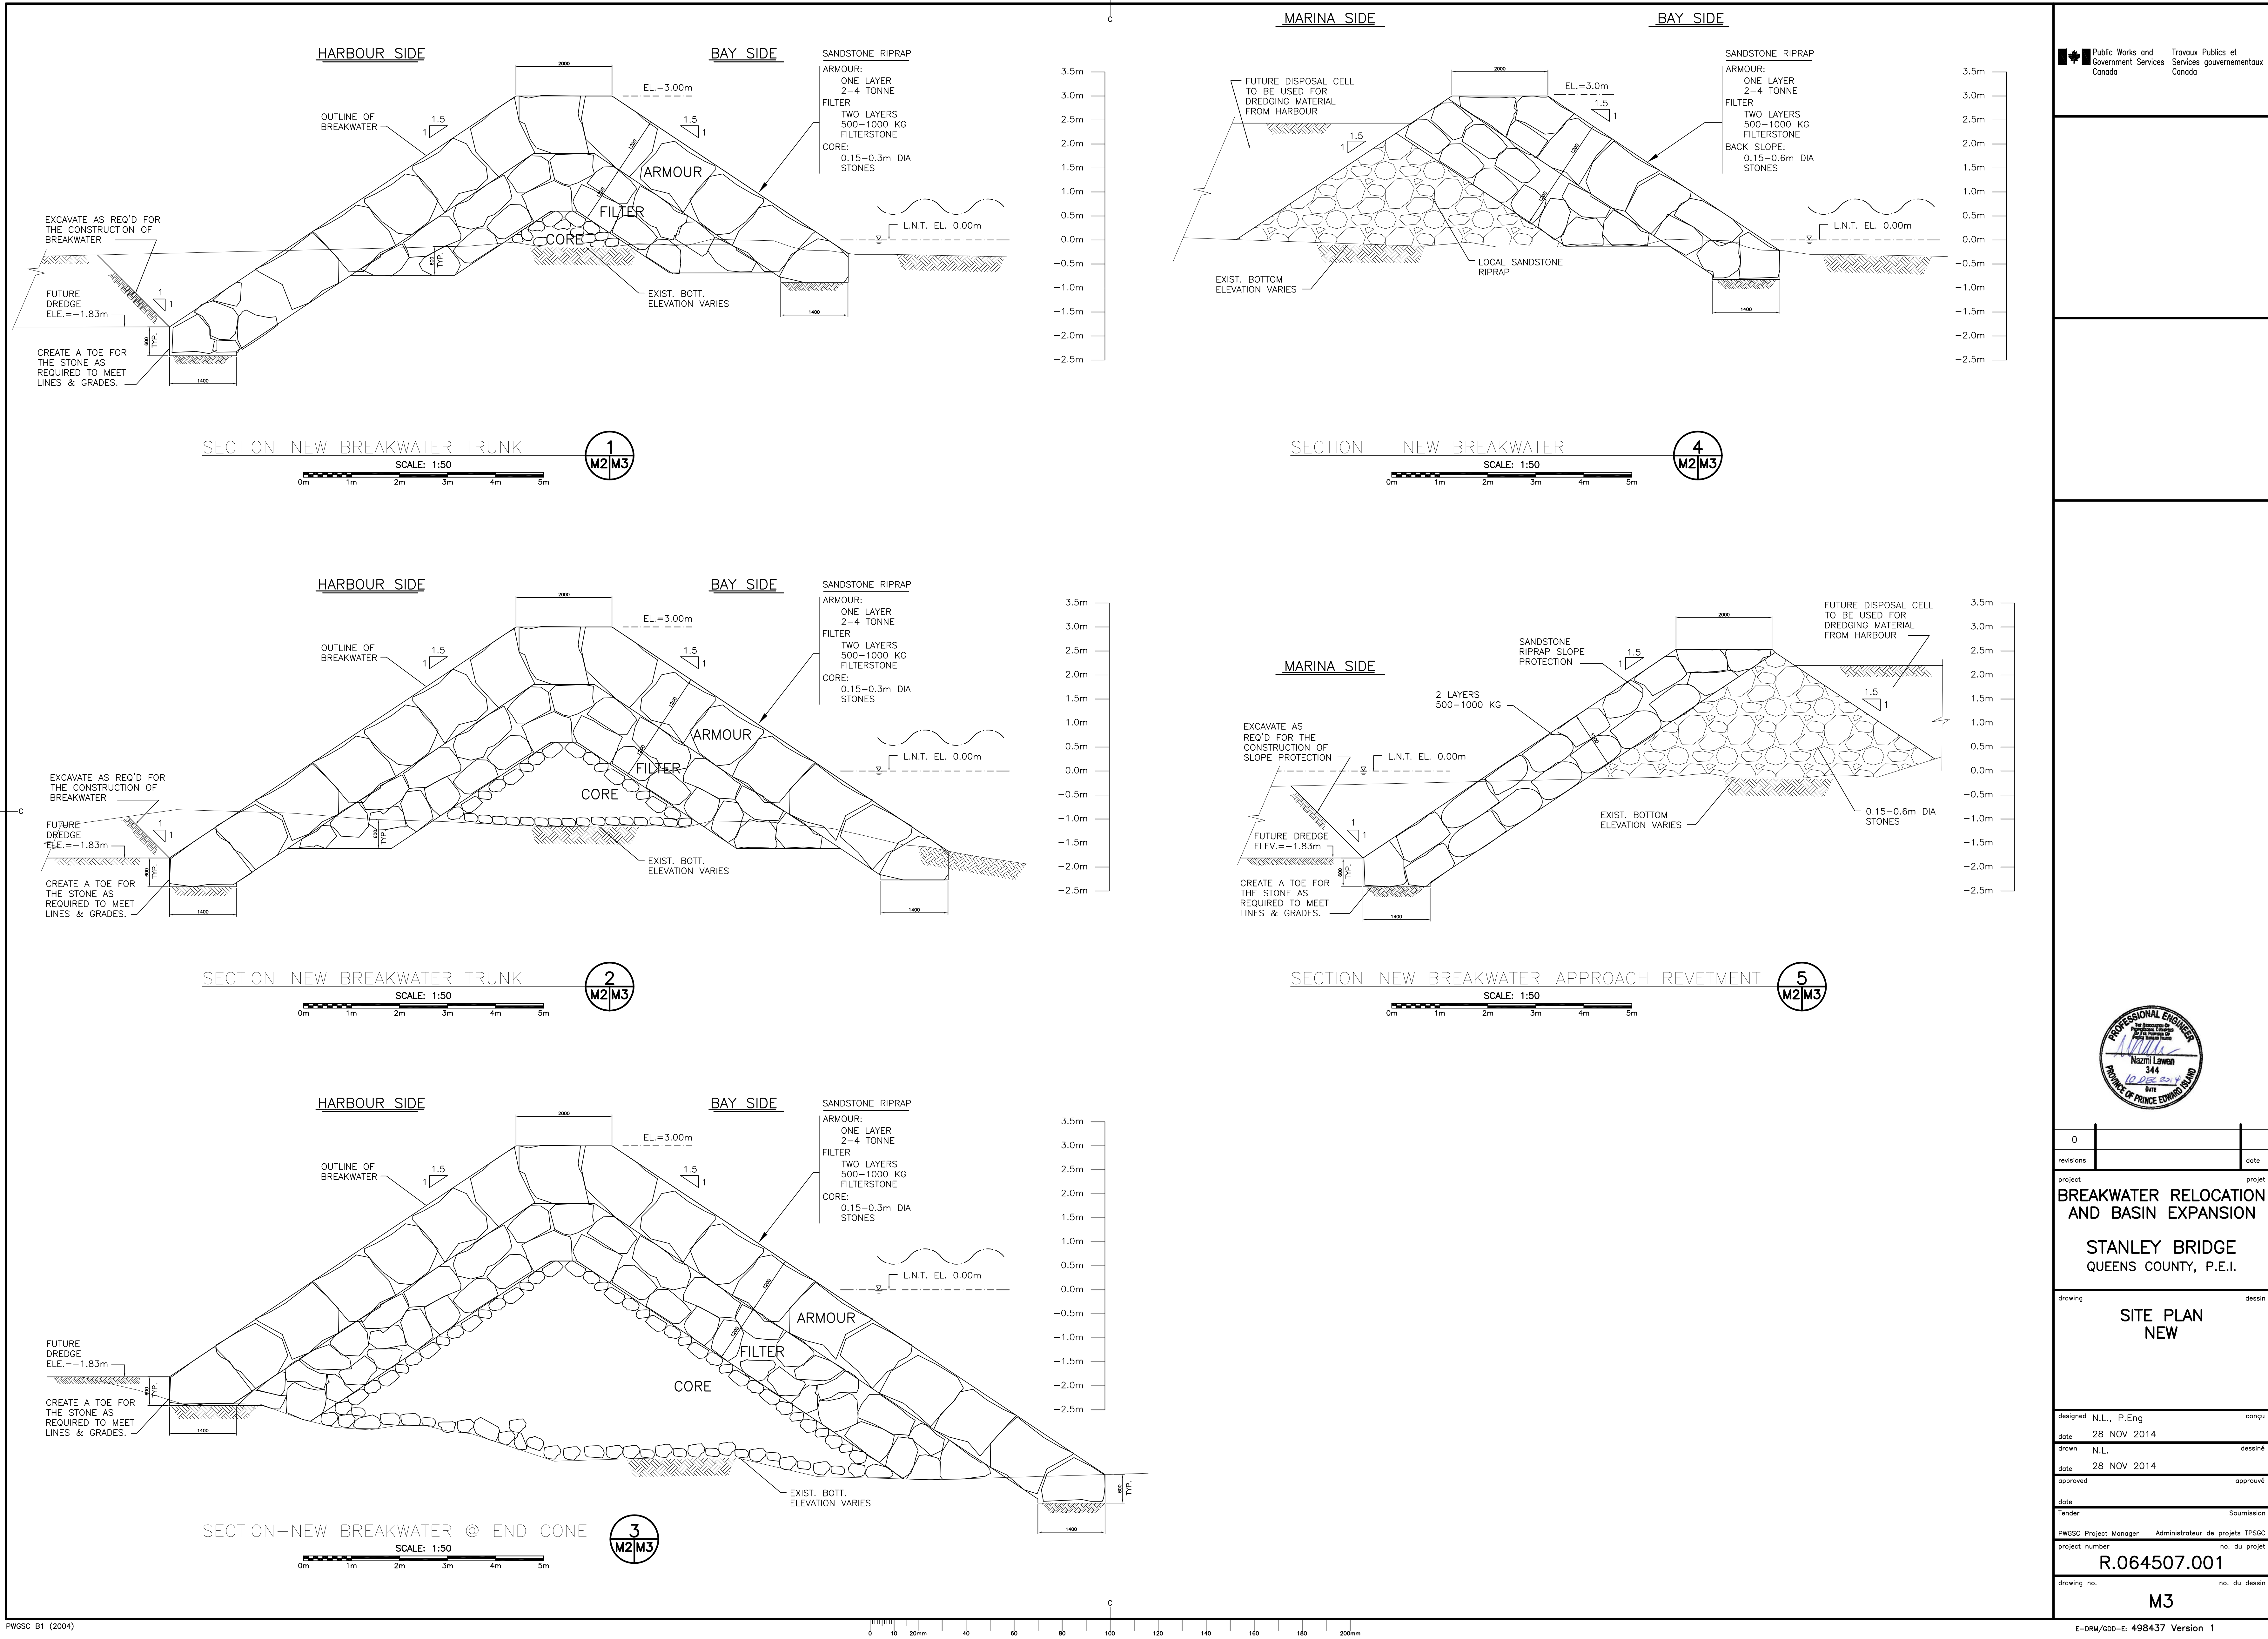

0		
revisions		date
project	BREAKWATER RELOCATION AND BASIN EXPANSION	
	STANLEY BRIDGE	
	QUEENS COUNTY, P.E.I.	
drawing	SITE PLAN NEW	
designed	N.L., P.Eng	conçu
date	28 NOV 2014	
drawn	N.L.	dessiné
date	28 NOV 2014	
approved		approuvé
date		
Tender		Soumission
PWGSC Project Manager	Administrateur de projets TPWSC	
project number	R.064507.001	
drawing no.	M3	

PWGSC B1 (2004)

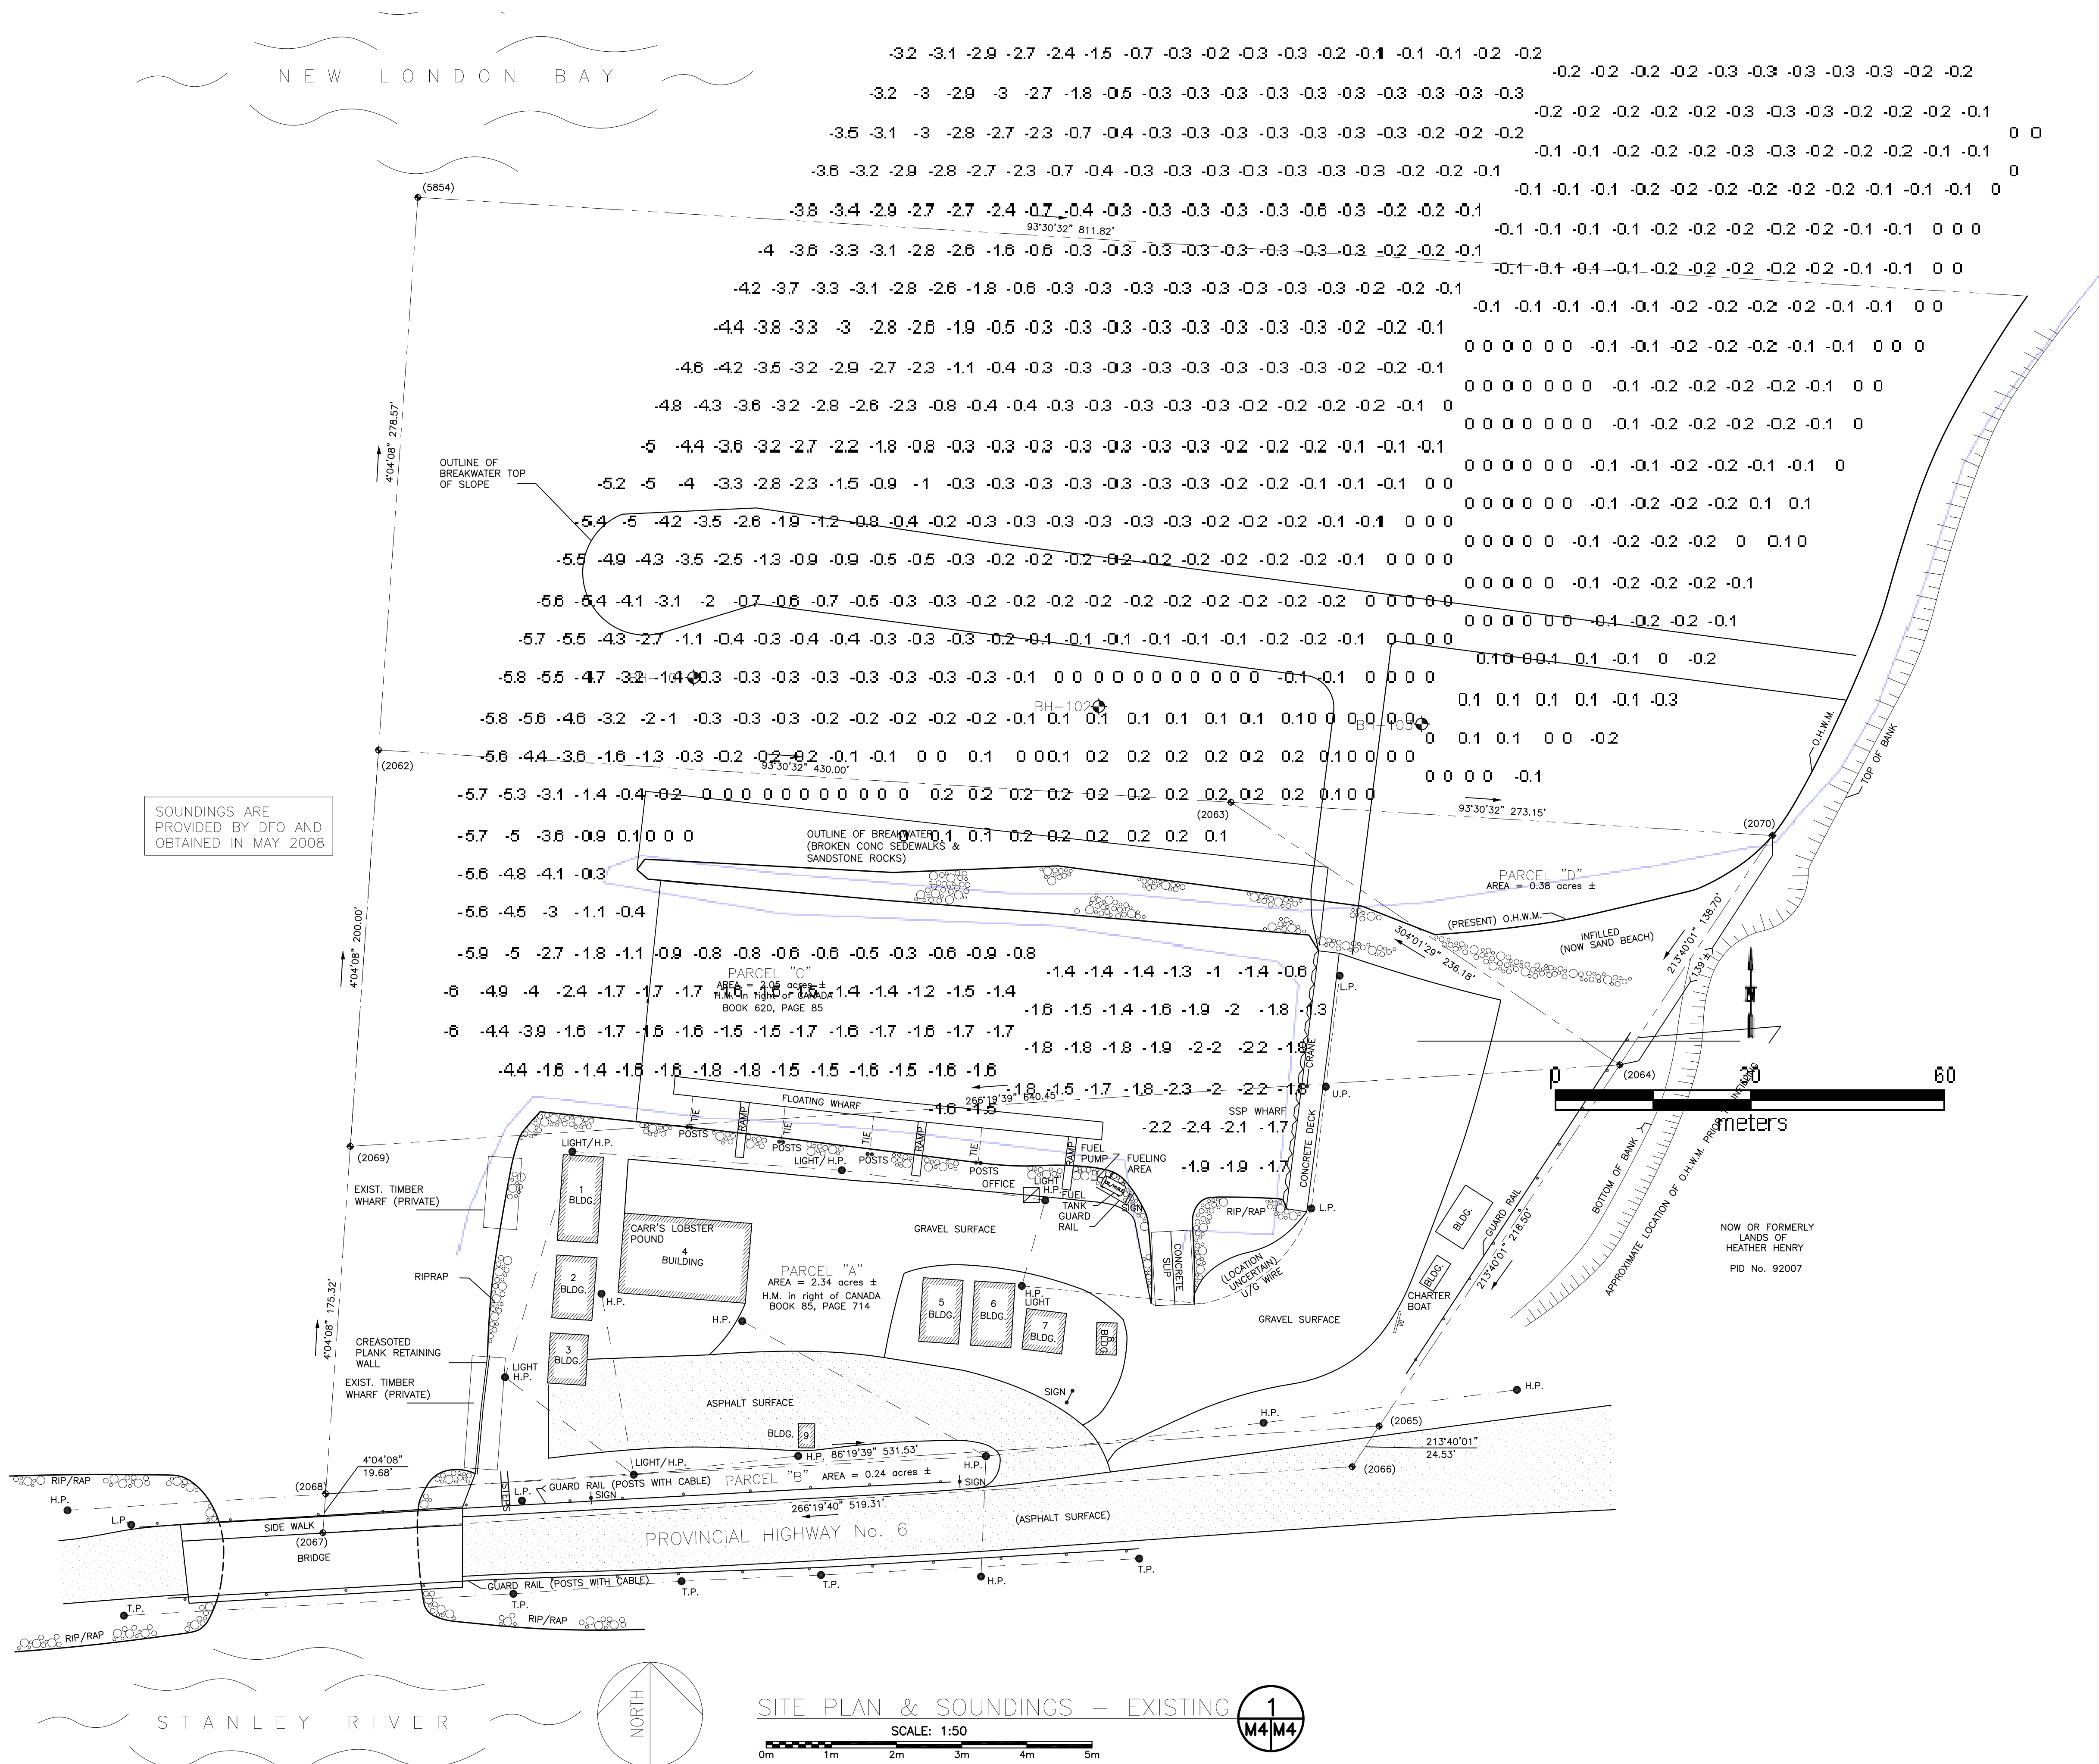

LEGEND

LANDS DEALT WITH BY THIS PLAN	—X—X—
FENCE	—X—X—
CALCULATED POINT	●
HYDRO POLE	H.P.
TELEPHONE POLE	T.P.
LIGHT POLE	L.P.
UTILITY POLE	U.
RIP/RAP	○
GUARD RAIL	—
OVERHEAD WIRE	—
UNDERGROUND WIRE	—
PARCEL IDENTIFIER	PID
PLACED SURVEY MARKER	■
PROPERTY LINE	—
NEW SANITARY LINE	—
NEW SANITARY FORCE MAIN	—
EXIST. SANITARY LINE	—
NEW WATER LINE	—
EXISTING WATER LINE	—
ROAD CENTER LINE	—
EXISTING ELEVATION	—
NEW ELEVATION	—
EXISTING SANITARY MANHOLE	SSMH
NEW SANITARY MANHOLE	MH
EXISTING WATER VALVE	W.V.
NEW WATER VALVE	W.V.
NEW REDUCER	—
EXISTING UTILITY POLE	—
NEW FIRE HYDRANT	—
EXISTING TREES	—
LIFT STATION	L.S.

Public Works and Government Services Canada

Travaux Publics et Services gouvernementaux Canada

PROFESSIONAL ENGINEER
Nazmi Lawan
10/03/2014
PRINCE OF PRINCE EDWARD ISLAND

0		
revisions		date

project
BREAKWATER RELOCATION
AND BASIN EXPANSION

STANLEY BRIDGE
QUEENS COUNTY, P.E.I.

drawing
SITE PLAN
& SOUNDINGS

designed	N.L., P.Eng	conçu
date	28 NOV 2014	
drawn	NL	dessiné
date	28 NOV 2014	
approved		approuvé
date		
Tender		Submission
PWGSC Project Manager	Administrateur de projets TPWSC	
project number		no. du projet
	R.064507.001	
drawing no.		no. du dessin
	M4	