



PRESCOTT MARINE BASE COMPLEX — ON

OUTLINE OF WORK NOTES — IMPORTANT: RADIO OPERATIONS ROOM TO REMAIN FUNCTIONAL DURING DEMOLITION AND RENOVATION PHASES.

- 1 PROVIDE APPROVED SCHEDULE OF WORK TO PWSC PROJECT MANAGER AND INCLUDE COAST GUARD OPERATIONAL SEQUENCE FOR DECOMMISSIONING AND REMOVING EXISTING RADIO ROOM EQUIPMENT A, B, C, D, (N.I.C.) AND REPLACING WITH NEW CONSOLES (N.I.C.) TO POSITION 1, 2, 3, 4. ON CONTRACT DRAWING.
- 2 COMPLETE WORK IN PHASE 1 AND PHASE 2 AND PROVIDE AND MAINTAIN PROTECTION OF ADJOINING AND ADJACENT AREAS, DUCTS, EQUIPMENT AND OPENINGS FROM CONTAMINATION AND DAMAGE BY DUST AND DEBRIS FROM DEMOLITION ACTIVITY.
- 3 WALLS AND DOORS TO BE REMOVED FOR PHASE 1.
- 4 NEW CABLE TRAY EXTENSION BELOW FLOOR SLAB (N.I.C.)
- 5 MAKE GOOD ALL AREAS, SURFACES, FINISHES AND SYSTEMS AND INSTALL OR RELOCATE EQUIPMENT AS INDICATED.. ENSURE FULL OPERATION OF ALL SYSTEMS TO SATISFACTION OF PROJECT MANAGER. ENSURE AREA IS KEPT CLEAN DAILY AND ALL REFUSE ITEMS ARE PROPERLY DISPOSED OF. PROVIDE WASTE MANAGEMENT PLAN.
- 6 EXISTING FLOOR CARPET AND VINYL FLOOR FINISH TO BE REMOVED AND REPLACED THROUGHOUT EXISTING ROOMS X201, X202, X203, X204. NEW FLOOR FINISH: AS SPECIFIED.
- 7 EXISTING SUSPENDED ACOUSTIC CEILING IN X204 TO REMAIN. EXISTING SUSPENDED ACOUSTIC CEILING IN X201, X202, X203 TO BE REMOVED AND REPLACED WITH NEW SUSPENDED ACOUSTIC CEILING SYSTEM AND TILES IN PATTERN AND AT HEIGHT TO MATCH X204.
- 8 RELOCATE THERMOSTATS, FIRE BELL, EMERGENCY LIGHT, AIR DIFFUSERS AS SHOWN AND ENSURE FULL OPERATION AS INDICATED IN WORK NOTE 3. RELOCATE EXISTING LIGHT FIXTURES AND DIFFUSERS WHERE INDICATED.
- 9 INSTALL NEW MECHANICAL PUSH BUTTON COMBINATION SECURITY LOCK ON EXISTING DOOR 9.
- 10 INSTALL TRANSLUCENT PLASTIC FILM ON GLAZING ON DOOR 10 ON X201 SIDE.
- 11 PAINT WALLS WITH 2 COATS TO UNIFY THE COMPLETE SPACE OF X201, X202, X203, WITH COLOR SELECTION FROM PROJECT MANAGER.
- 12 INSTALL DIMMER ON ONE ROW OF LIGHTS ALONG SOUTH PERIMETER WALL.
- 13 PROVIDE CORING AND LISTED FIRE STOPPING OF HOLES AT LOCATION TO SUIT NEW CONSOLES 3 AND 4.

SEE NOTE 6:
FLOORING: BEIGE COLOR 300X300 RUBBER TILES
GREY COLOR 300X300 RUBBER TILES.(BORDER)

N.I.C.:TEST TO CONFIRM EXISTING FLOOR TILES ARE NON-ASBESTOS CONTAINING MATERIAL.

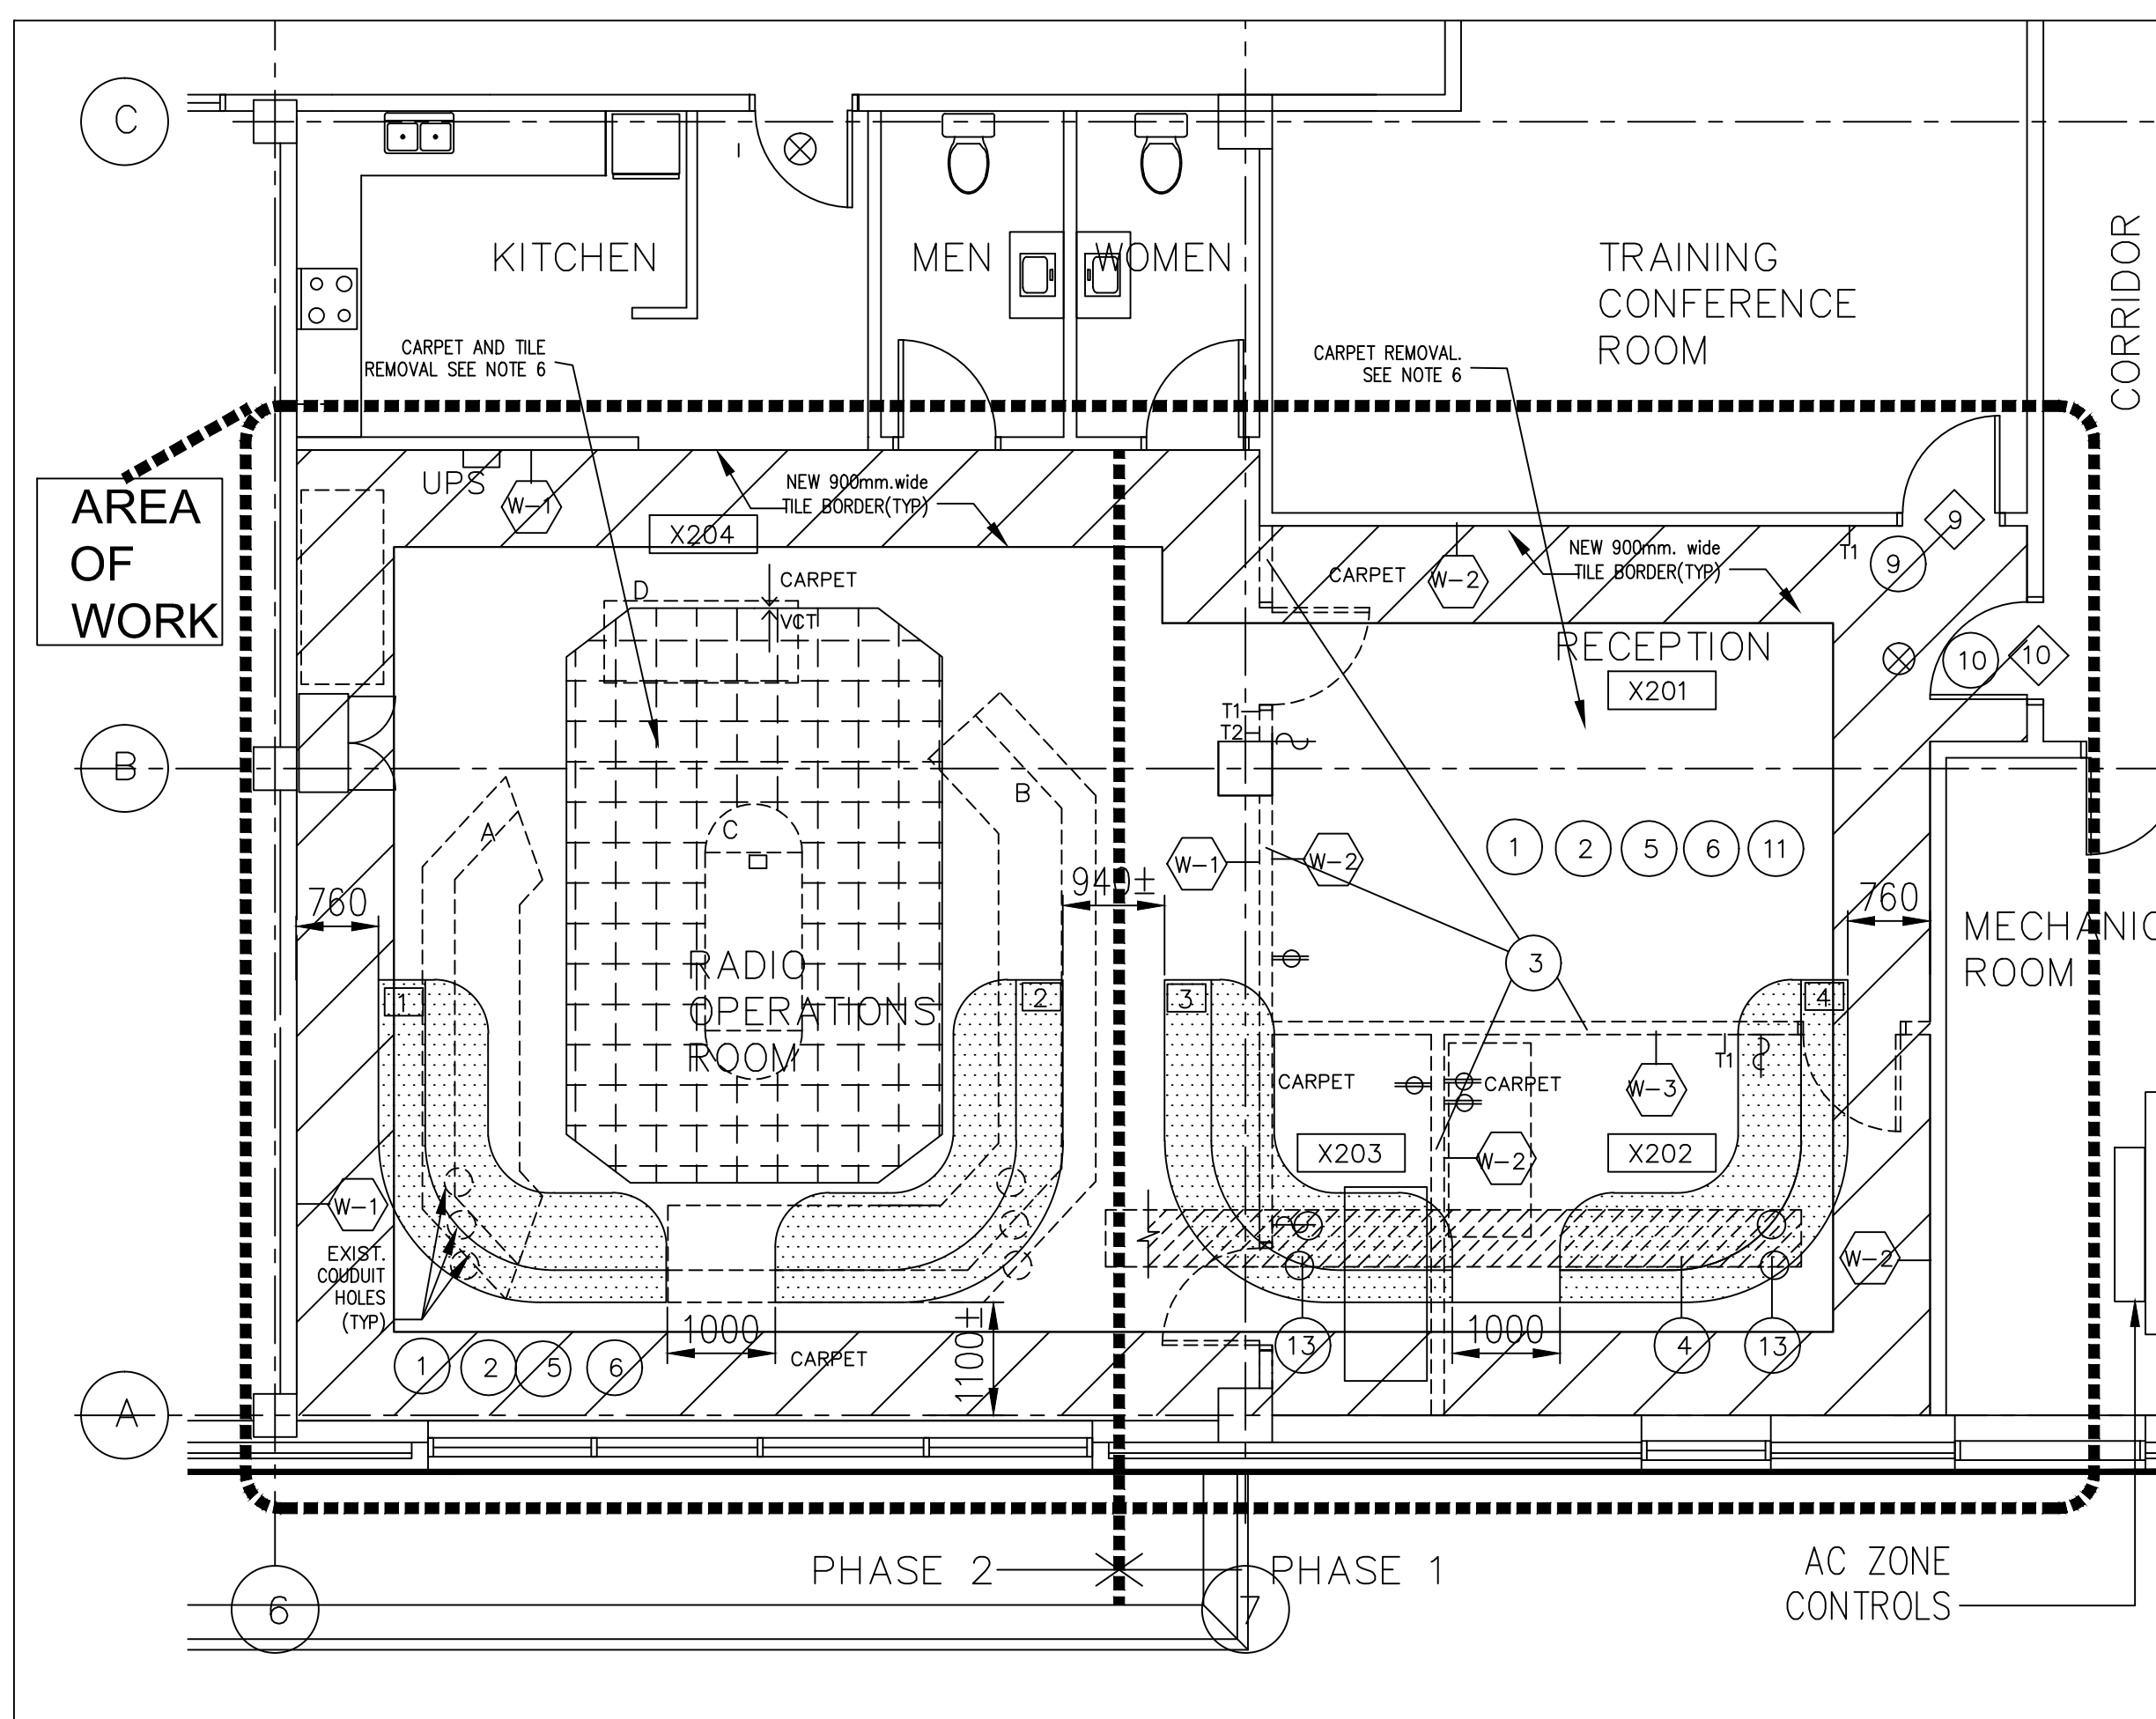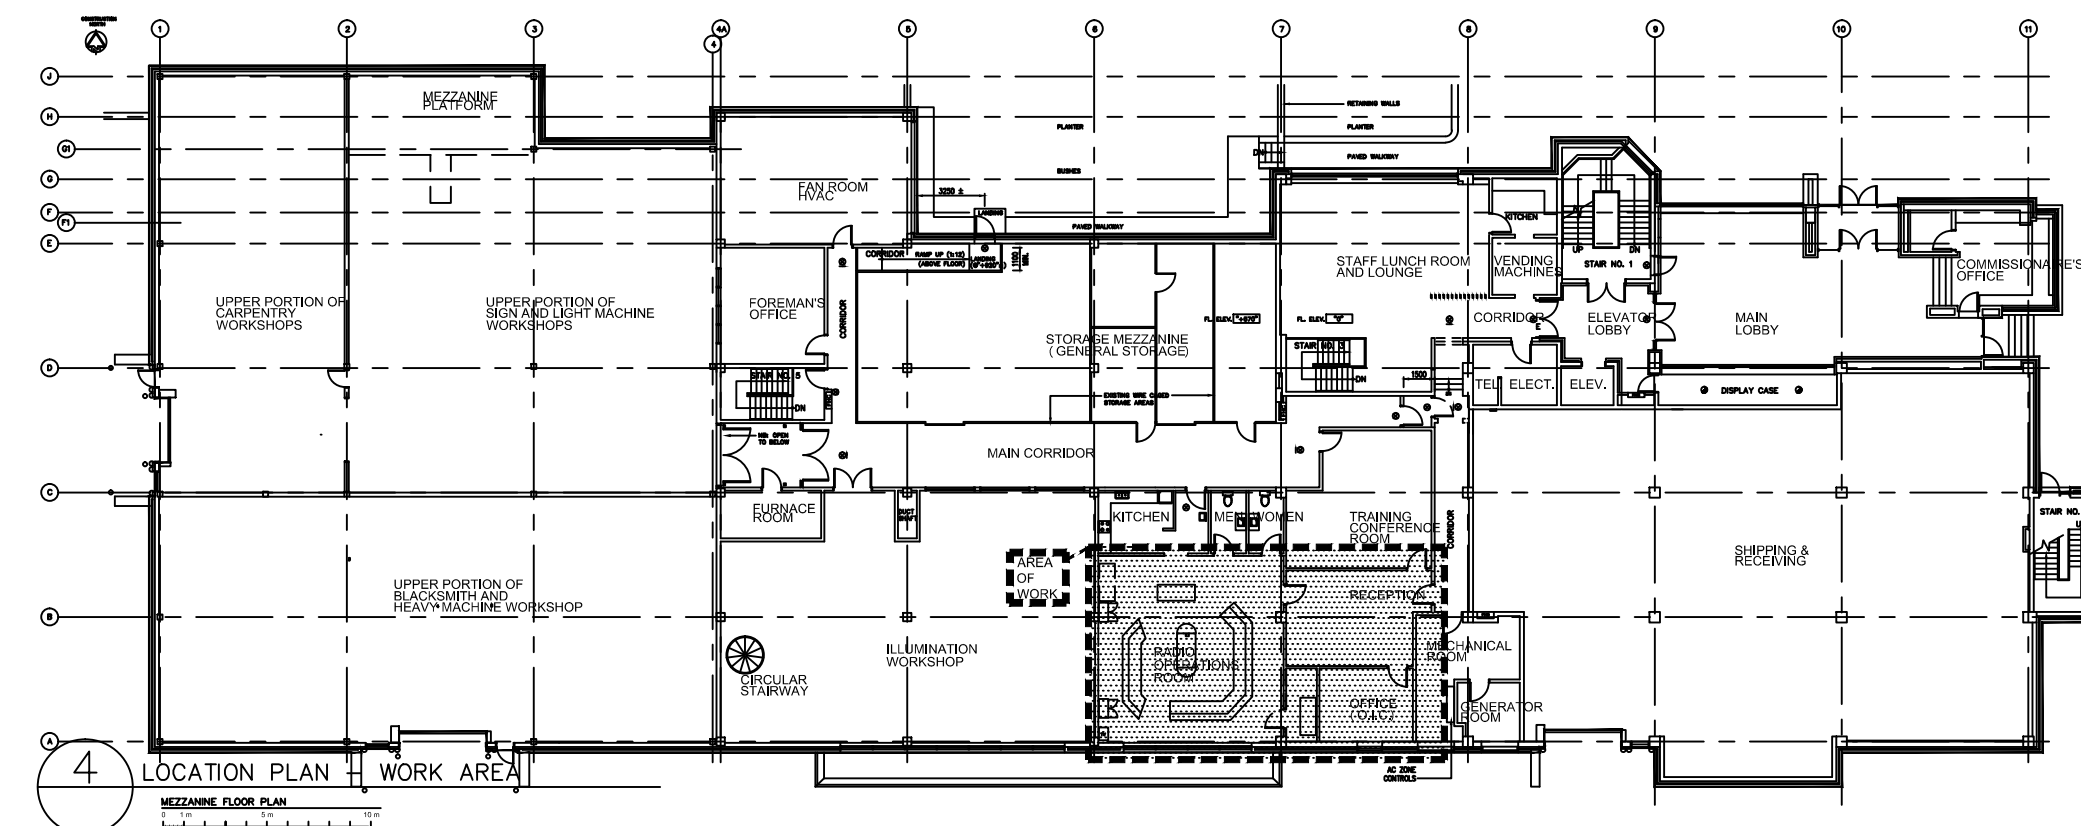

Public Works and
Government Services Canada
Architectural and Engineering Services
Ontario Region
Travaux publics et
Services gouvernementaux Canada
Services d'architecture et de génie
Région de l'Ontario



Revisions	COMMENT	DATE
2	ISSUED FOR CLIENT REVIEW	2014/10/09
1	ISSUED FOR PRICING	2014/10/07

LEGEND	
EXISTING WORK TO REMAIN	EXISTING WORK TO REMAIN
REMOVE EXISTING WORK	REMOVE EXISTING WORK
PROPOSED WORK AS SHOWN	PROPOSED WORK AS SHOWN
AIR DIFFUSER	AIR DIFFUSER
LINEAR AIR DIFFUSER	LINEAR AIR DIFFUSER
RETURN AIR GRILL	RETURN AIR GRILL
EXISTING (TO BE RE-USED) FLUORESCENT LIGHT	EXISTING (TO BE RE-USED) FLUORESCENT LIGHT
EXISTING (TO BE RE-USED) FLUORESCENT LIGHT	EXISTING (TO BE RE-USED) FLUORESCENT LIGHT
OUTLINE OF WORK NOTES	OUTLINE OF WORK NOTES
PROPOSED SMOKE DETECTOR	PROPOSED SMOKE DETECTOR
EXISTING SMOKE DETECTOR	EXISTING SMOKE DETECTOR
EXIT LIGHT	EXIT LIGHT
"E" DENOTES EXISTING	"E" DENOTES EXISTING
"R" DENOTES RELOCATED	"R" DENOTES RELOCATED
"N" DENOTES NEW	"N" DENOTES NEW
"T" DENOTES THERMOSTAT	"T" DENOTES THERMOSTAT
DIRECTION TO RELOCATE	DIRECTION TO RELOCATE
EXISTING SPRINKLER	EXISTING SPRINKLER
EXISTING ELECTRICAL SWITCH	EXISTING ELECTRICAL SWITCH
EXISTING ELECTRICAL OUTLET	EXISTING ELECTRICAL OUTLET
NEW CONSOLES (N.I.C.)	NEW CONSOLES (N.I.C.)
NEW CABLE TRAY BELOW (N.I.C.)	NEW CABLE TRAY BELOW (N.I.C.)
X204	DENOTES PROJECT ROOM NUMBER
DENOTES CARPET WALL FINISH	DENOTES CARPET WALL FINISH
DENOTES PAINT WALL FINISH (APPROX. HEIGHT OF 3050 TO U/S OF SLAB - METAL STUD WITH GYPSUMBOARD, TYPICAL)	DENOTES PAINT WALL FINISH (APPROX. HEIGHT OF 3050 TO U/S OF SLAB - METAL STUD WITH GYPSUMBOARD, TYPICAL)
DENOTES DOOR NUMBER	DENOTES DOOR NUMBER
NB: DIMENSIONS/ELEVATIONS SHOWN ARE IN MILLIMETRES	NB: DIMENSIONS/ELEVATIONS SHOWN ARE IN MILLIMETRES

Do not scale drawings.
Verify all dimensions and conditions on site and immediately notify the project manager of discrepancies.

A	Detail No.
B	No. to detail
C	drawing no. - where detail required
	dessin no. - ou detail exigé

project title
titre du projet
PRESCOTT
DFO-CCG
MARINE BASE COMPLEX
401 KING STREET WEST

ONTARIO

PROPOSED RENOVATION TO RADIO OPERATIONS ROOM

drawing title
titre du dessin
**MEZZANINE FLOOR PLAN
REFLECTED CEILING PLAN
OUTLINE OF WORK NOTES**

designed by conc par	P. HASTINGS
drawn by dessiné par	P.H.
reviewed by examiné par	B.V.
approved by approuvé par	B.V.

project date
date du projet
2014-10-03

project no.
no. du projet
R.072734.001

drawing no.
dessiné no.
A1