



MAIN SALMON HATCHERY-SITE PLAN

SCALE: 1:500
0m 10m 20m 30m 40m 50m

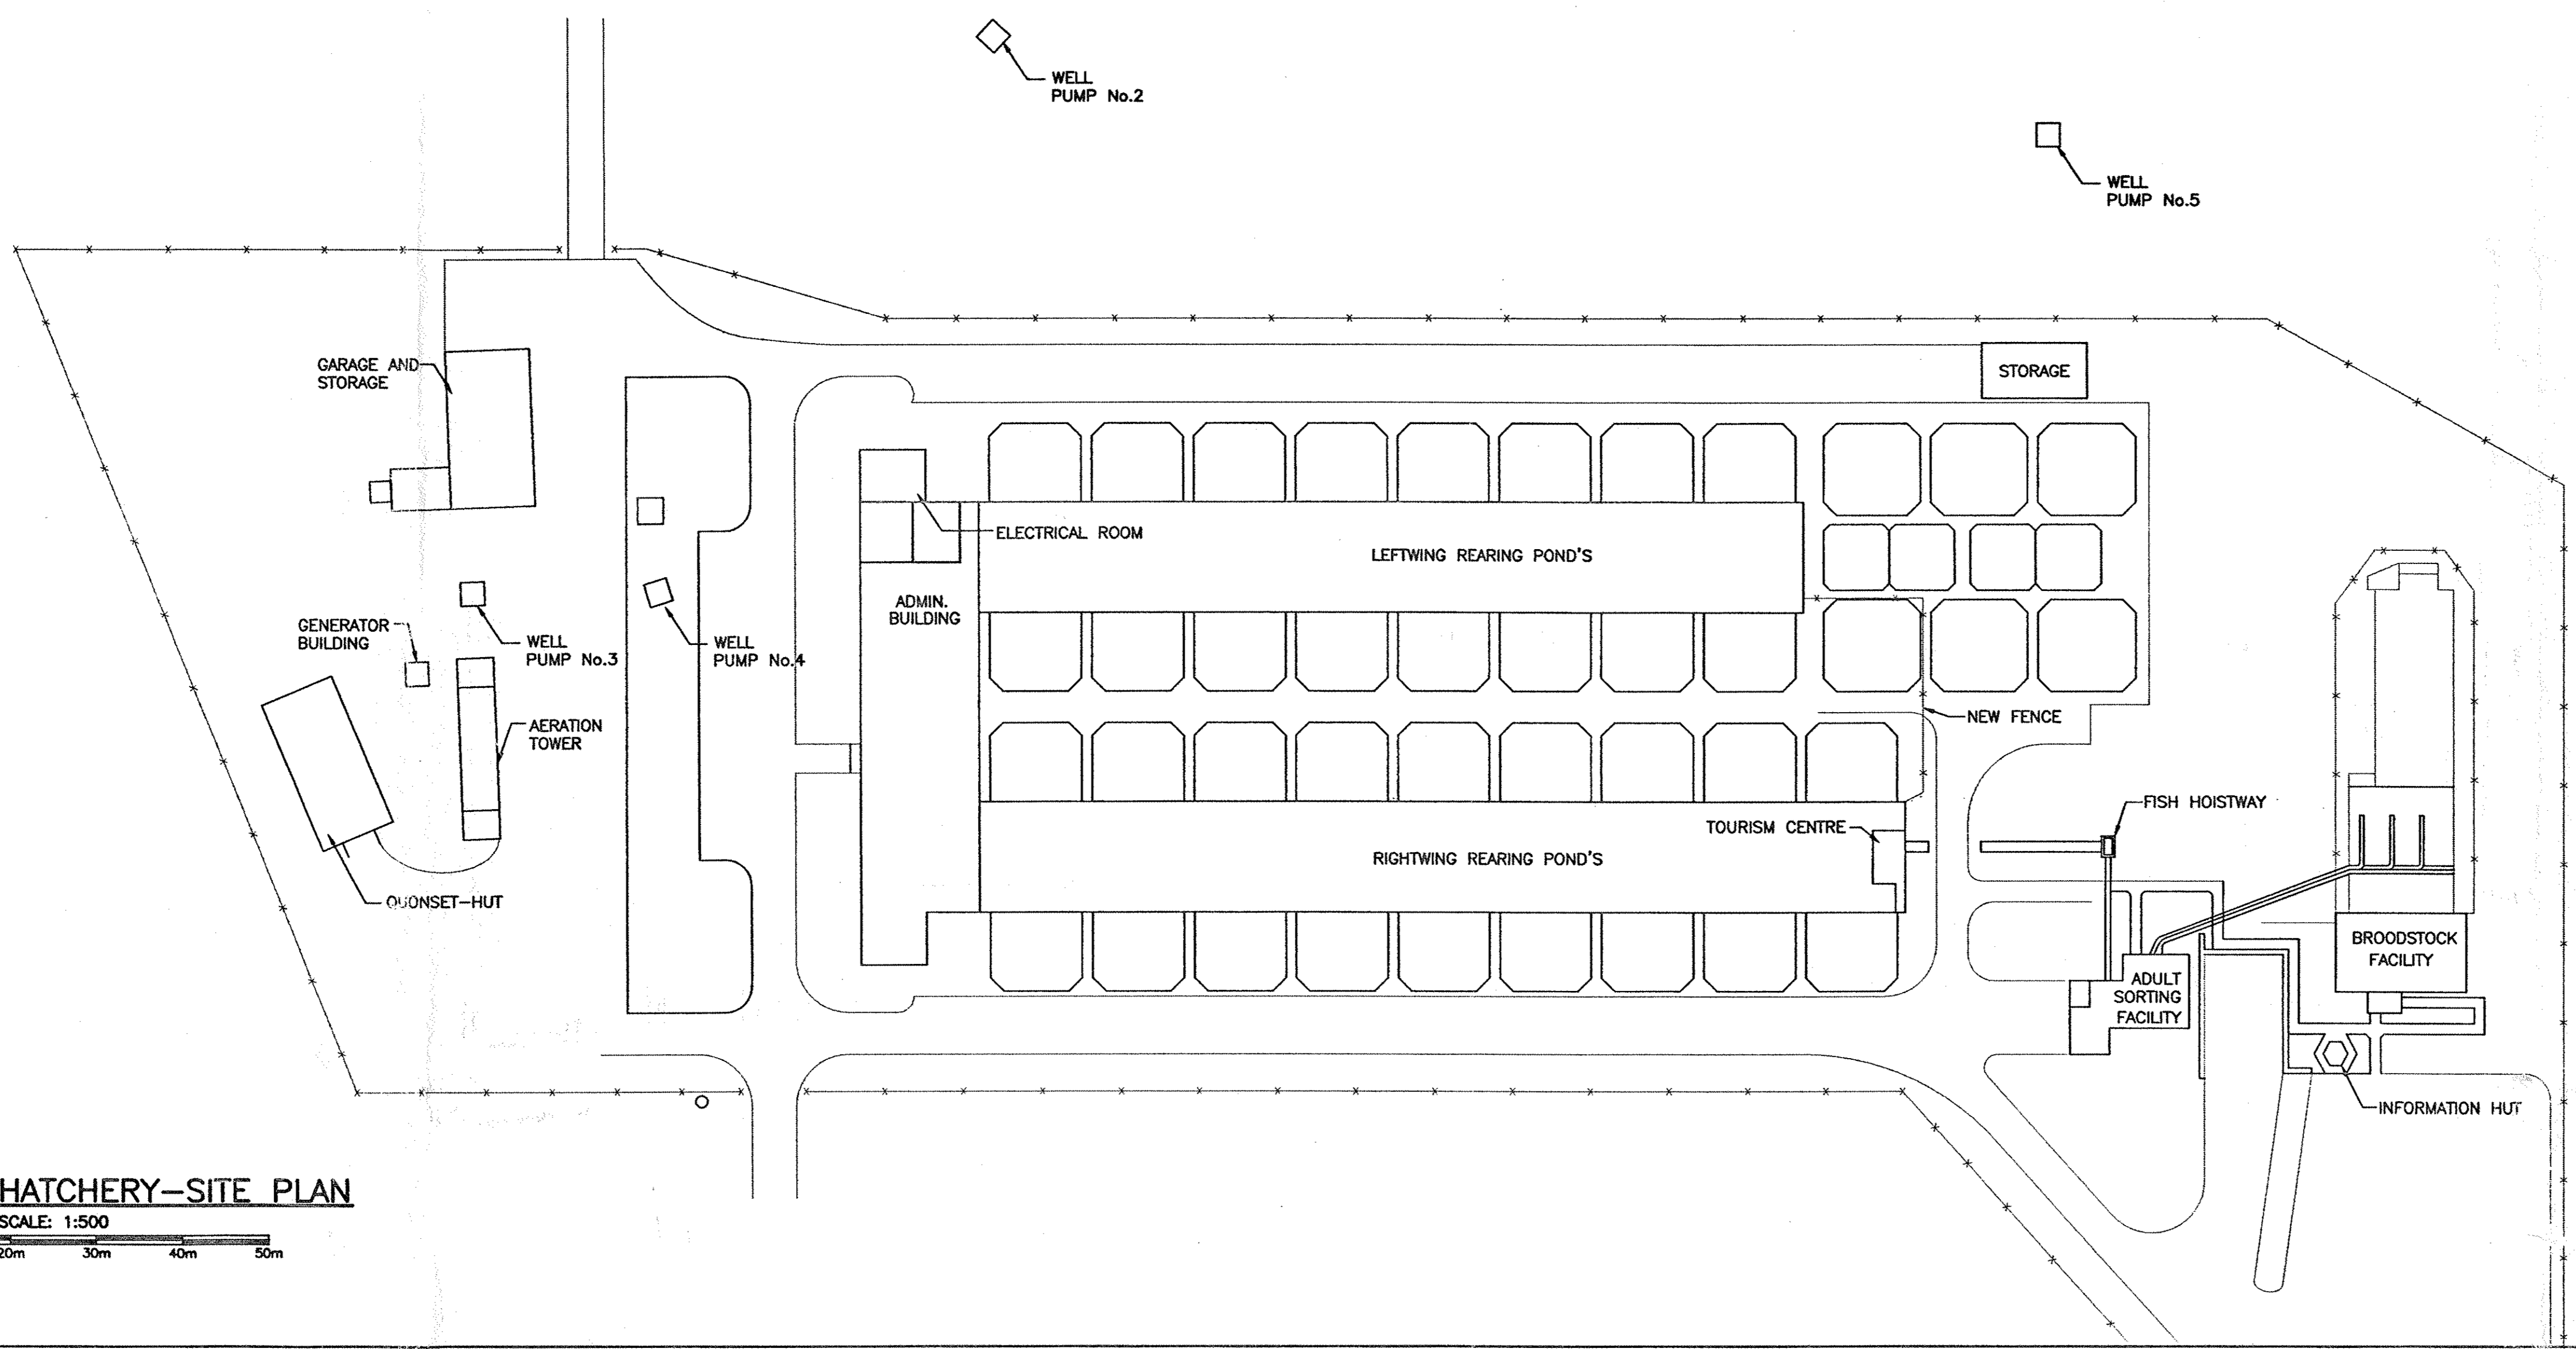

EARLY REARING FACILITY-SITE PLAN

SCALE: 1:500
0m 10m 20m 30m 40m 50m

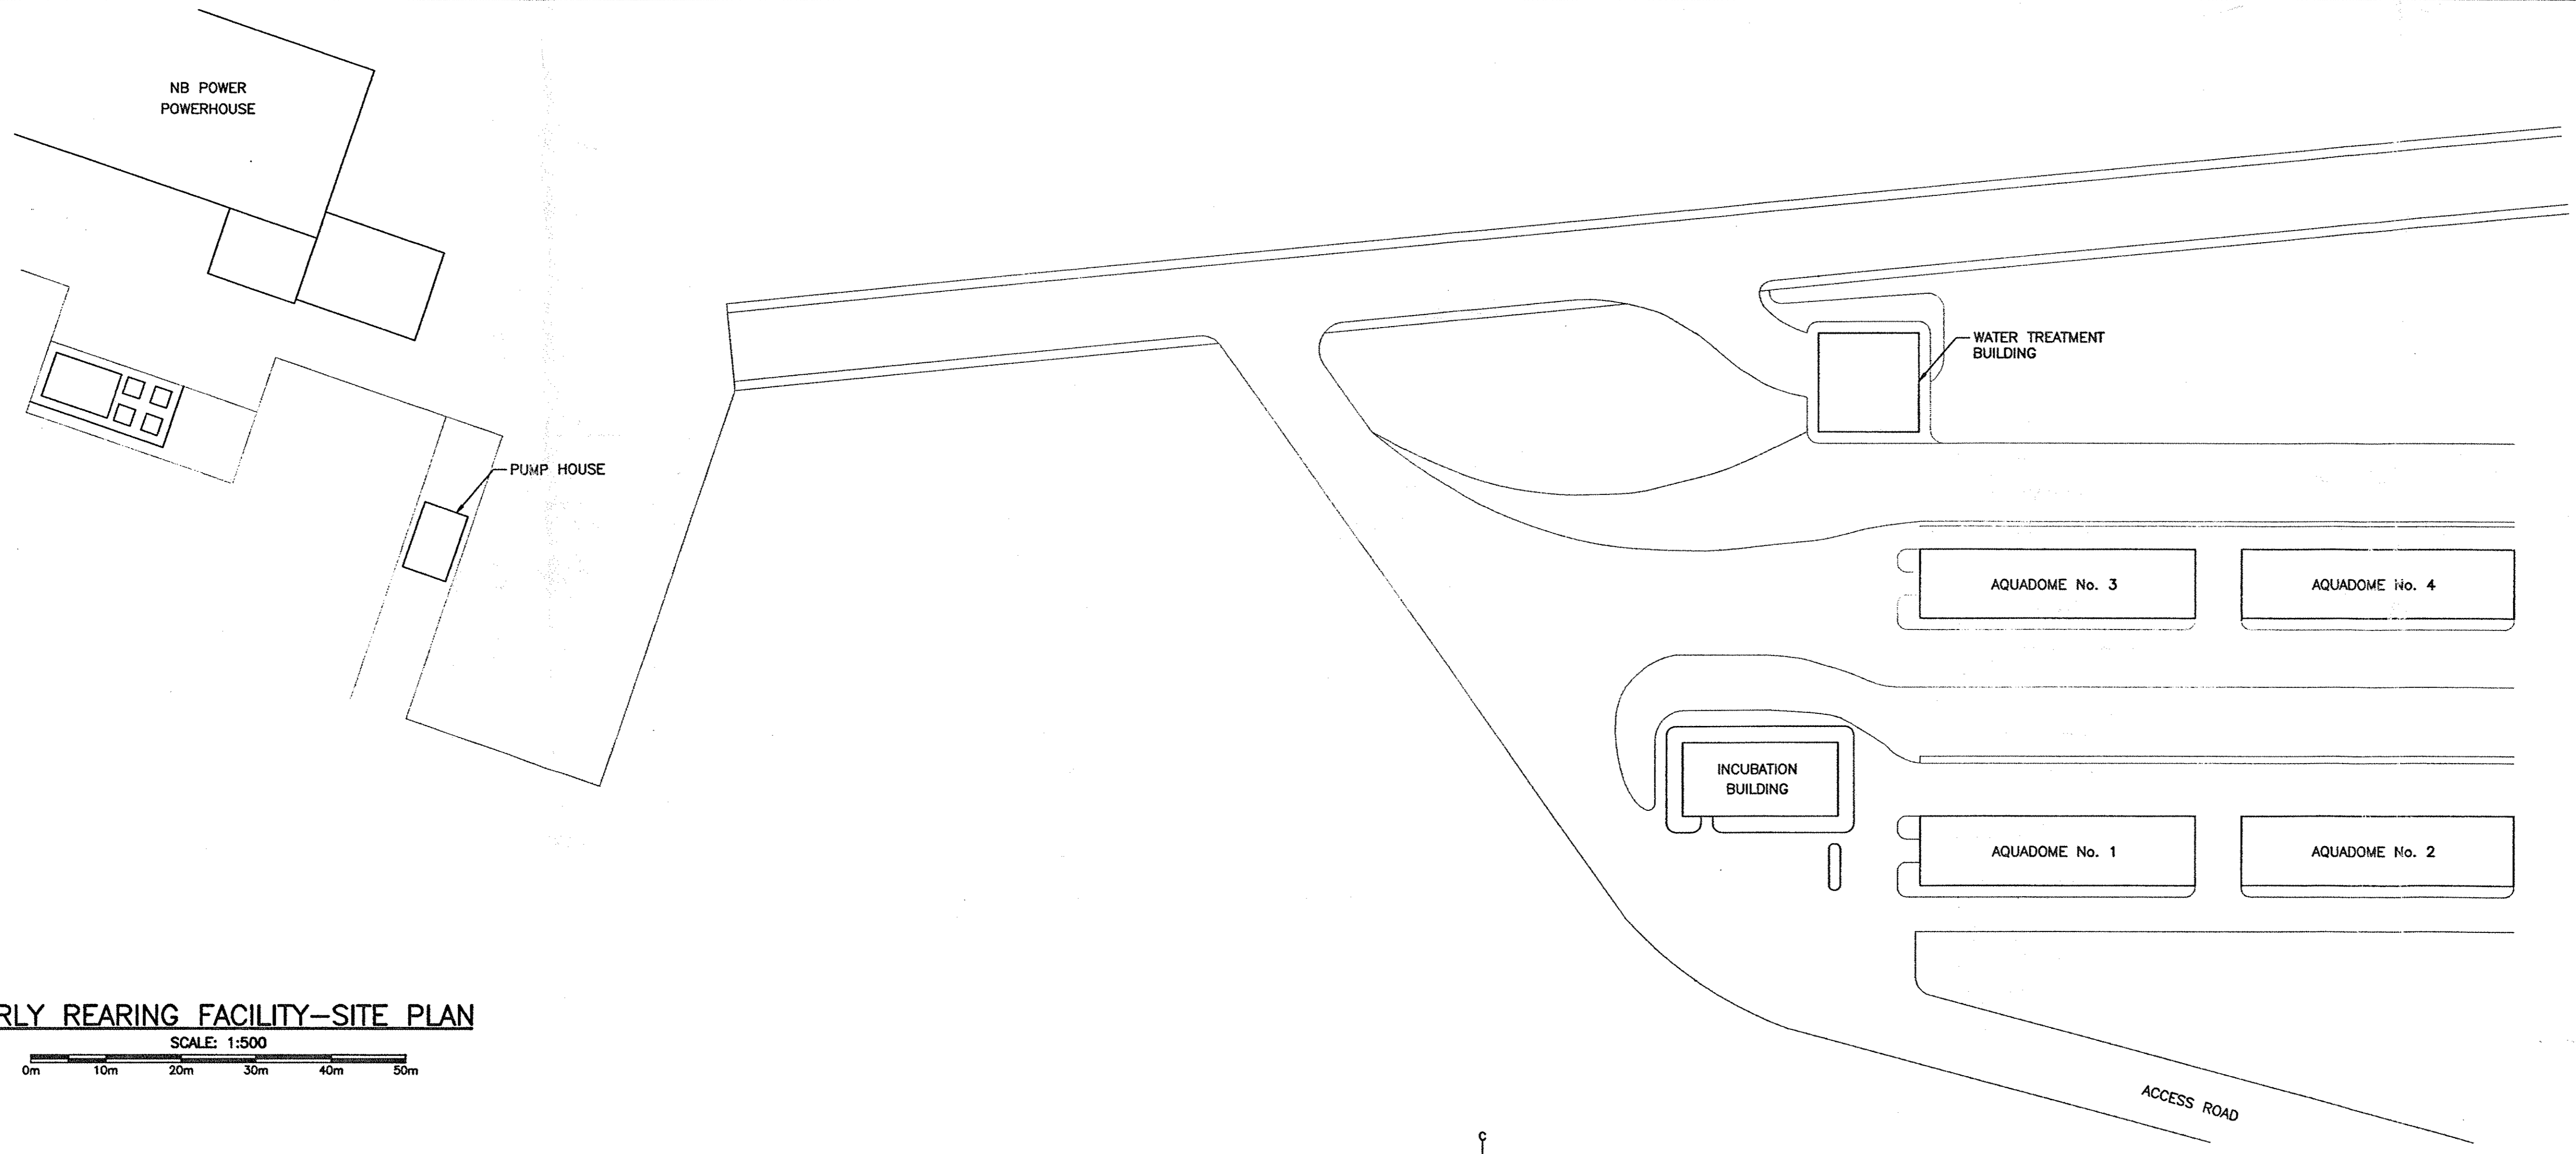

TO
R. HARTMAN
JAN 29/03
H.P.

0	ISSUED FOR TENDER	JAN 23 2003
A	ISSUED FOR APPROVAL	JAN 10 2003
revisions		date

A	A detail no. no. du detail	A
C	B location drawing no. sur dessin no.	B C
	C drawing no. dessin no.	

project project
ELECTRICAL UPGRADE FISH CULTURE CENTRE MACTAQUAC
YORK CO. N.B.

drawing dessin
MAIN SALMON HATCHERY AND EARLY REARING FACILITY ELECTRICAL SITE PLANS

designed M. MacDONALD conçu
date DECEMBER, 2002
drawn E. YU dessiné
date DECEMBER, 2002
approved *Michael R. MacDonald* approuvé
date 01/23/03

Tender Submission
PWOSC Project Manager / Administrateur de projet
project number no. du projet
308790

drawing no. no. du dessin
E-1