


GENERAL NOTES

1. THIS DRAWING INDICATES GENERAL INTENT OF DESIGN. ONLY CONTRACTOR TO VERIFY EXISTING SITE CONDITION, PRIOR TO ORDERING MATERIALS AND COMMENCING WORK. REPORT TO DEPARTMENTAL REPRESENTATIVE ANY DISCREPANCIES BETWEEN EXISTING AND DESIGN DRAWINGS.
2. PROVIDE NEW EQUIPMENTS, INCLUDING FITTINGS AND ACCESSORIES AS INDICATED.
3. UPON COMPLETION OF HVAC AND CONTROLS, THE CONTRACTOR SHALL BALANCE, EXHAUST FANS, DAMPERS AND DIFFUSERS FOR SPECIFIED FLOW.
4. PROVIDE GAS PIPING SUPPORT & EXPANSION IN ACCORDANCE WITH CSA B.149.

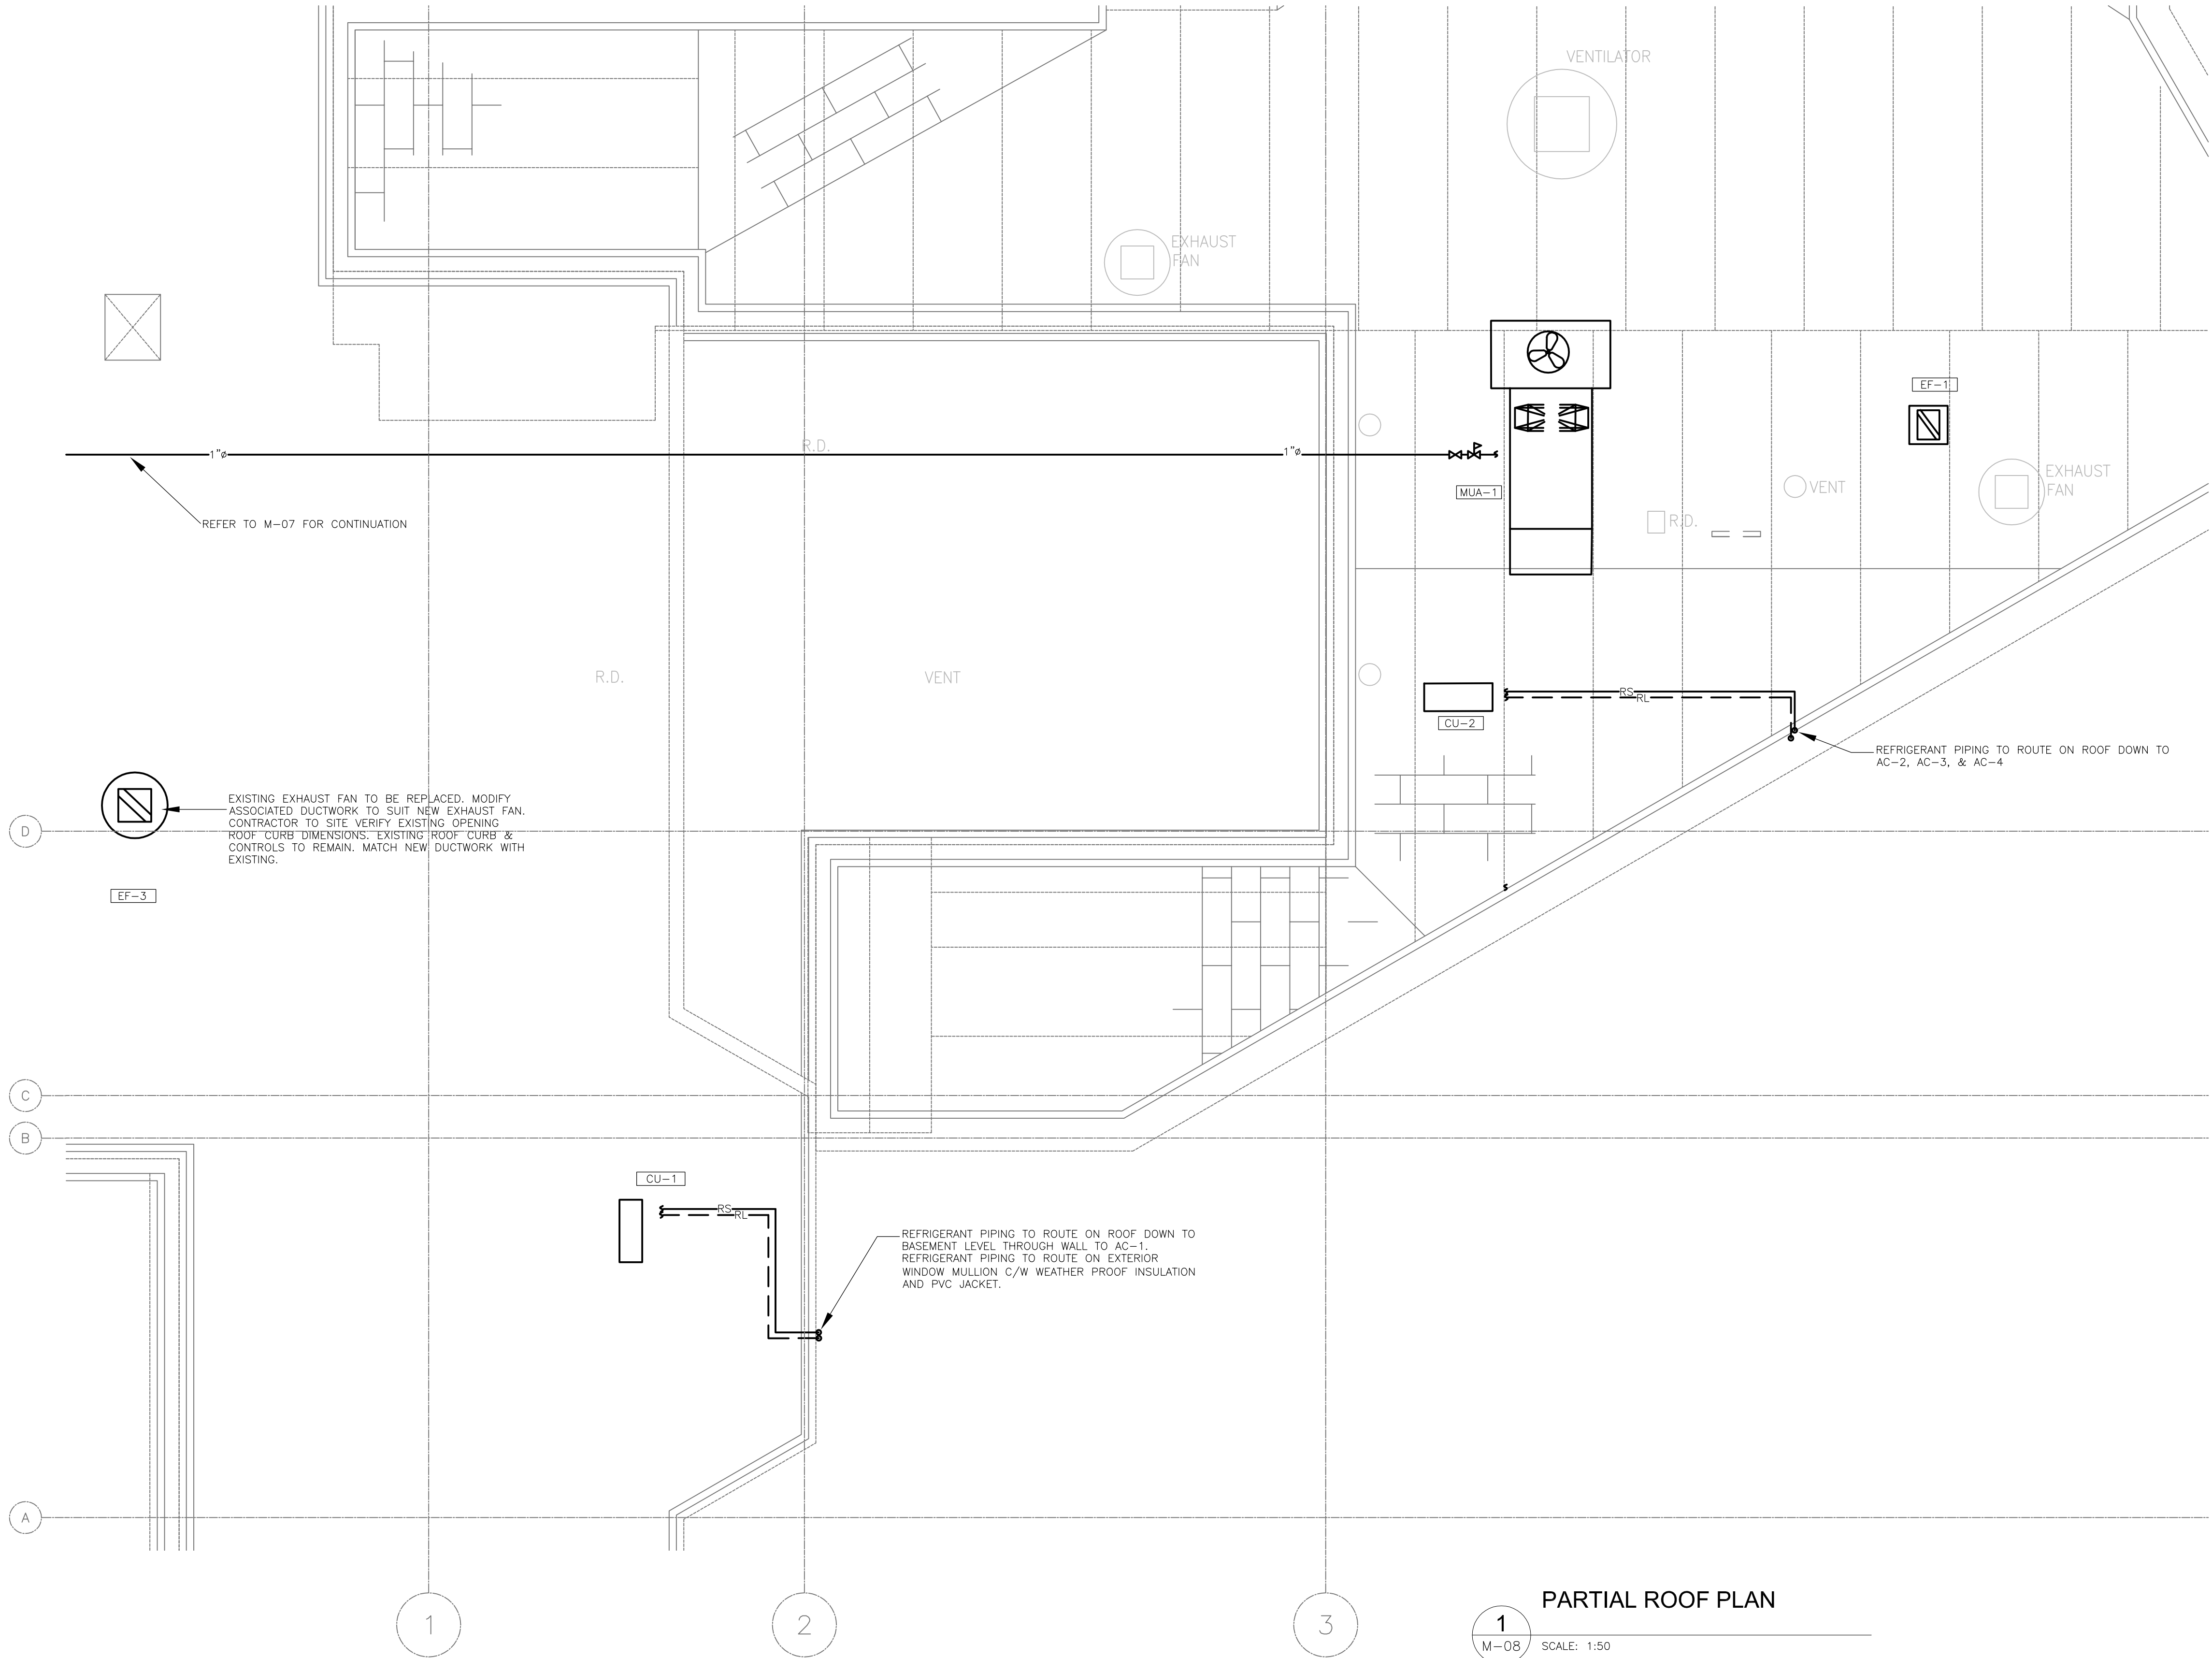

PARTIAL ROOF PLAN


1
M-08

SCALE: 1:50



DIALOG®

stamp

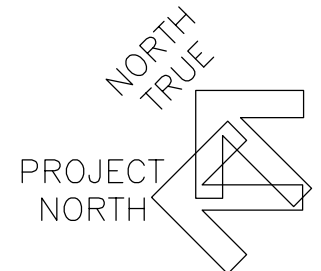

revision	issue	date
1	BID	2015-08-05

Do not scale drawings.
Verify all dimensions and conditions on site and immediately
notify the Departmental Representative of all discrepancies.

A	Detail No. No. du détail
B	drawing no. - where detail required dessin no. - où détail exigé
C	drawing no. - where detailed dessin no. - où détaillé

project title
titre du projet
**CAMPBELLFORD, ONTARIO
WARKWORTH INSTITUTION BLDG WW27
CORRECTIONAL SERVICES CANADA
15847 County Road 29, KOL 1L0
RETROFIT ARMOURY &
SMO WORK AREA**

drawing title
titre du dessin

SOUTH MECHANICAL ROOF PLAN

drawn by
dessiné par
M MOAZZAM

designed by
conçue par
H ABOUTALEBI

approved by
approuvé par
R DOMINGUEZ

bid
offre
K HAQUE

project manager
administrateur
de projets

project date
date du projet
2015-06-15

project no.
no. du projet
R.069651.001

drawing no.
dessiné no.
M-08