


NOTE:
ALL EXISTING EXHAUST OPENINGS CAPPED BY ARCHITECTURAL ARE TO HAVE BURGLAR BARS INSTALLED ACCORDING TO THIS DETAIL IF THEIR OPENING IS GREATER THAN 144 SQ. IN.


1 SECURITY BAR DETAILS

SCALE: N.T.S.
M:\BUILDINGS\T09253\81\CAD\MAL-M-501.dwg

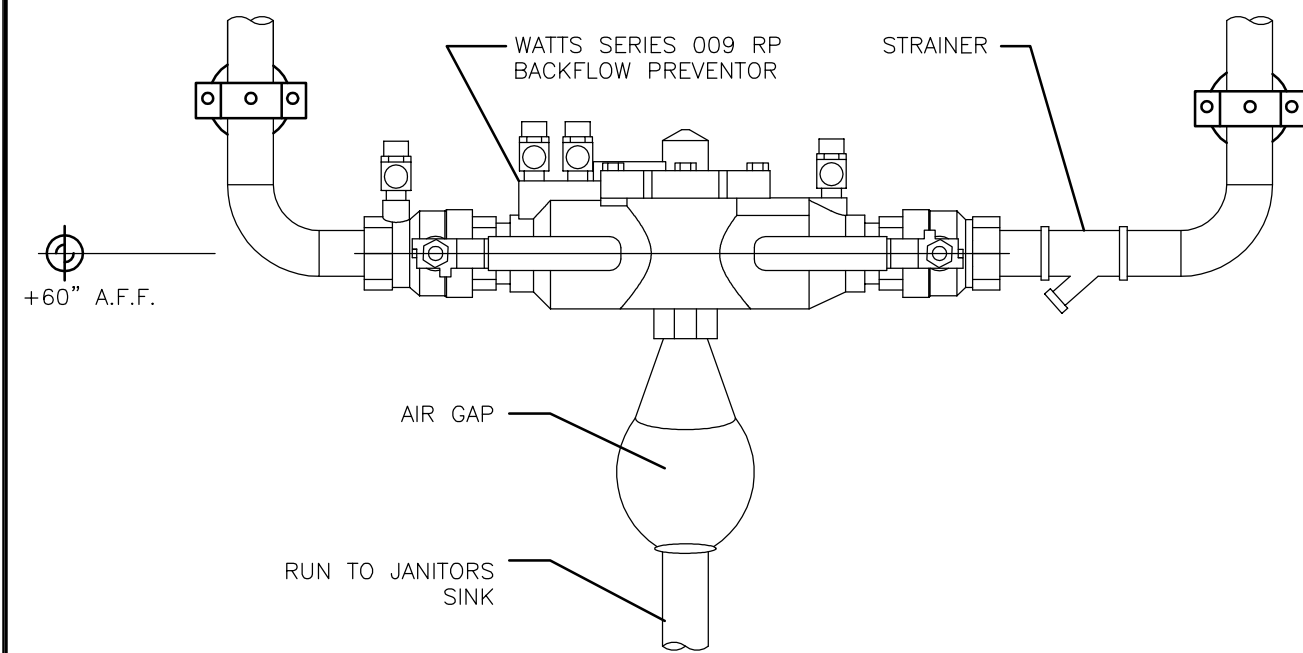


2 BACKFLOW PREVENTER INSTALLATION

SCALE: N.T.S.
J:\Office Procedures\Mechanical\CAD Details\Toronto\Details - Metric - DIALOG - PLUMBING & FIRE.dwg

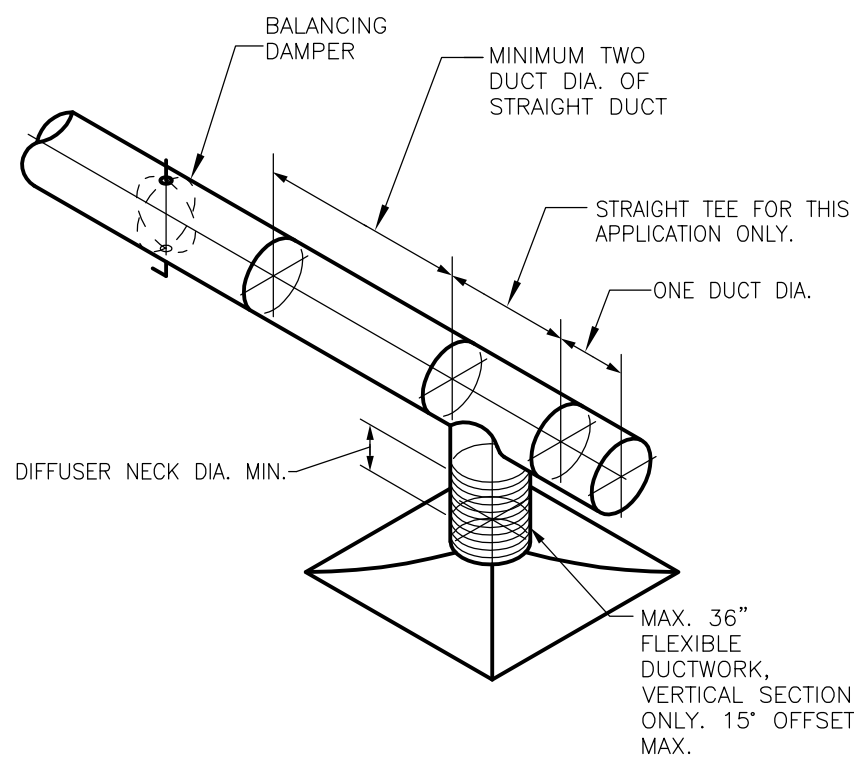

3 TYPICAL SUPPLY DIFFUSER CONNECTION DETAIL


SCALE: N.T.S.
M:\OFFICE PROCEDURES\MECHANICAL\RBC LIBRARY\RBC DESIGN\DRAWING TEMPLATES\RBD STANDARDS\M-DT01-M501.DWG

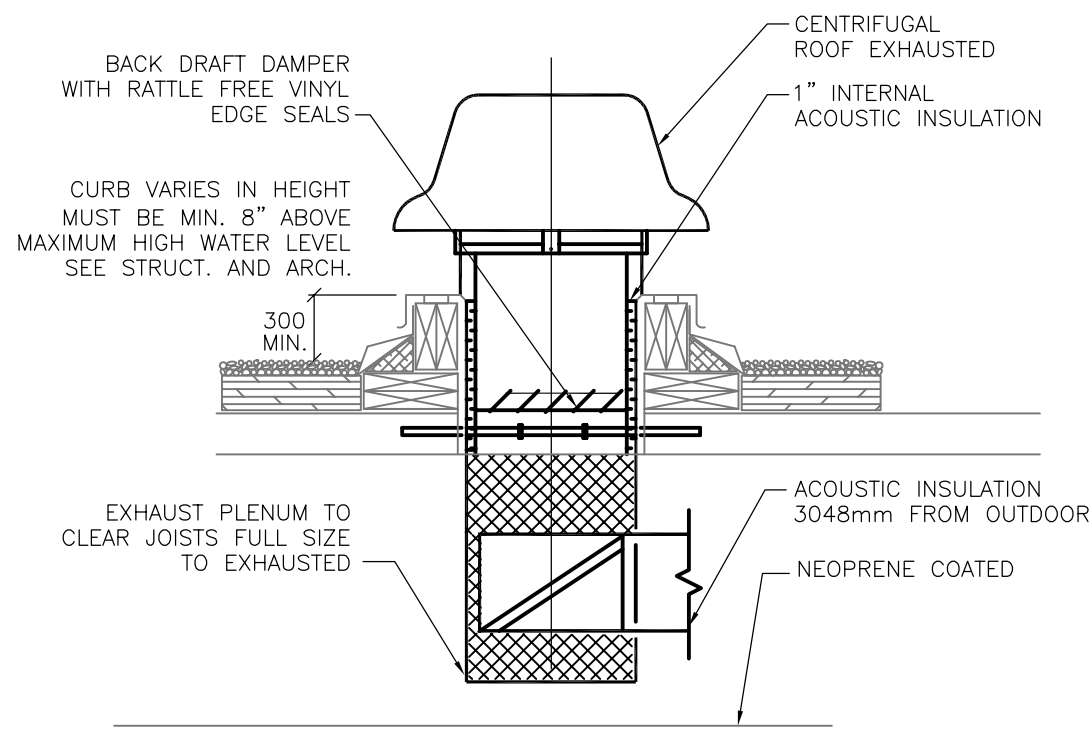

NOTE
FOR CURB, CANT STRIP, FLASHING (BY GEN. CONTRACTOR)

4 ROOF MOUNTED EXHAUST FAN DETAIL


SCALE: N.T.S.
M:\OFFICE PROCEDURES\MECHANICAL\RBC LIBRARY\RBC DESIGN\DRAWING TEMPLATES\RBD STANDARDS\M-DT01-M501.DWG

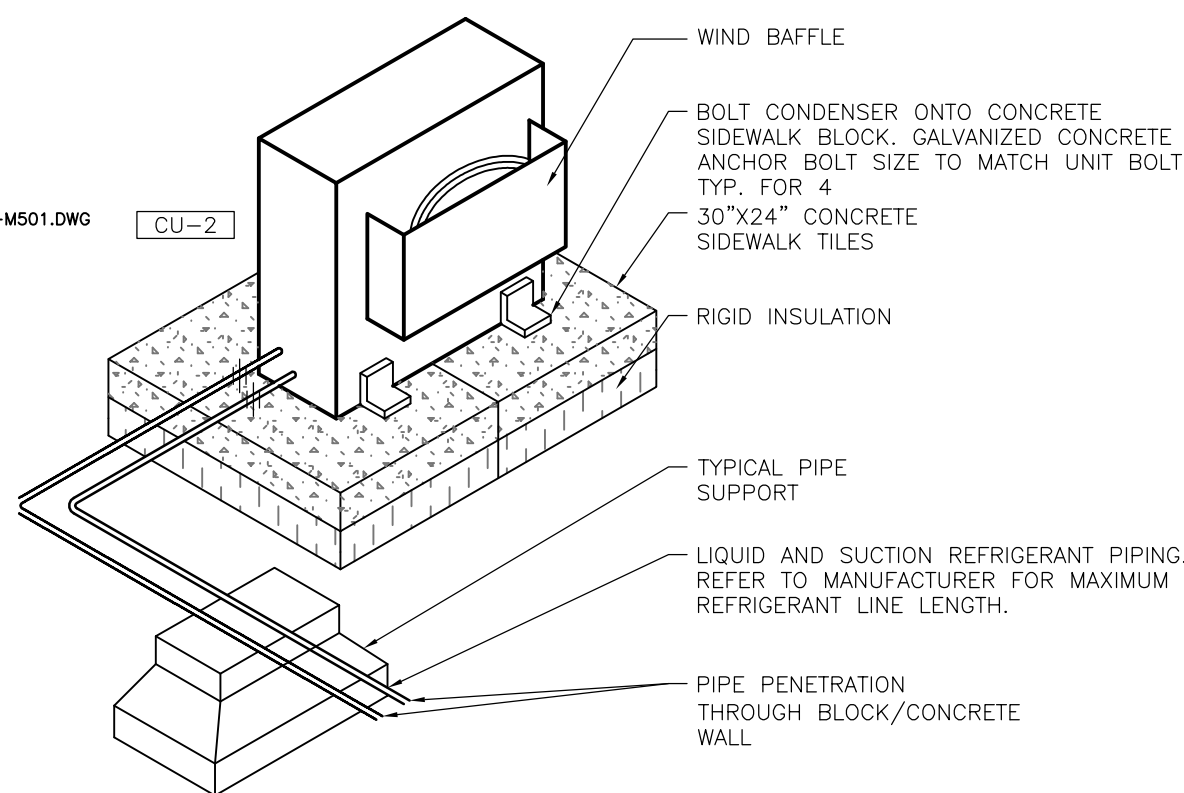

- NOTE:
1. VRF SYSTEM TO BE INSTALLED ACCORDING TO ALL APPLICABLE NATIONAL AND LOCAL ELECTRICAL, MECHANICAL AND BUILDING CODES.
 2. REFER TO MANUFACTURER FOR MINIMUM INSTALLATION CLEARANCES.
 3. INSTALL EQUIPMENT PER MANUFACTURER RECOMMENDATIONS.



5 VRF SYSTEM INSTALLATION DETAIL

SCALE: N.T.S.
M:\BUILDINGS\T09253\112\CAD\SUN-M-601.dwg

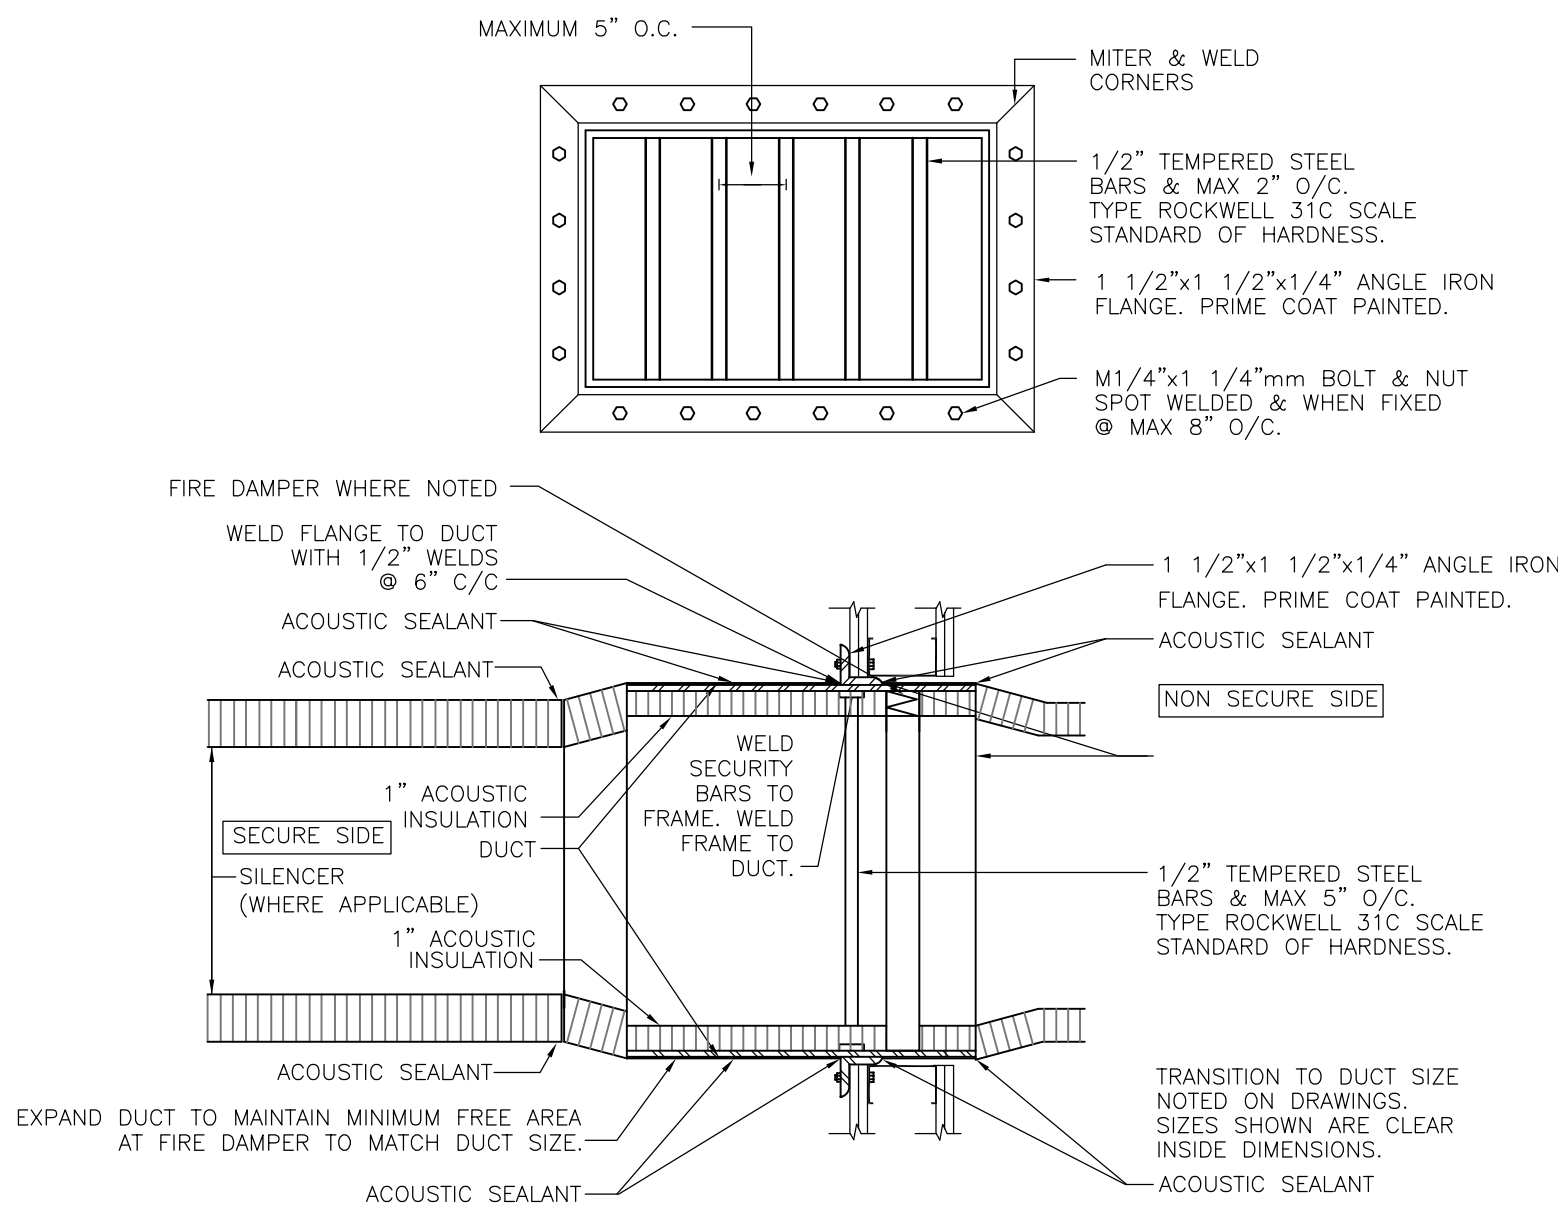


6 SECURITY BAR DETAILS

SCALE: N.T.S.
\\TORFILE\DATA\OFFICE PROCEDURES\MECHANICAL\PRODUCTION\TEMPLATE\M-501.DWG

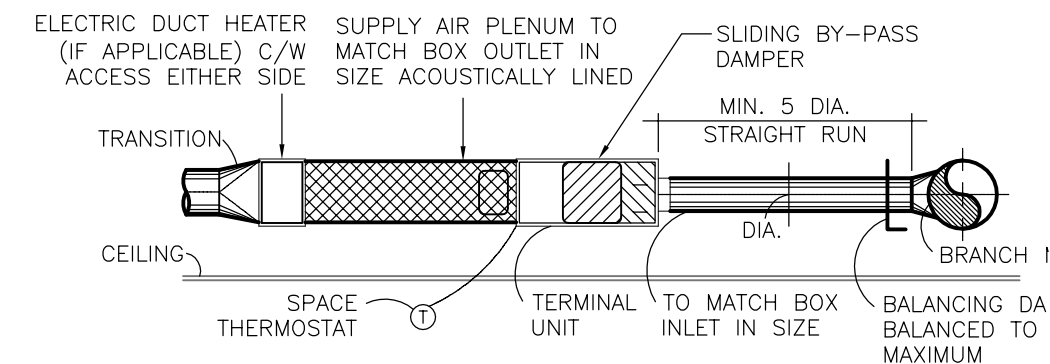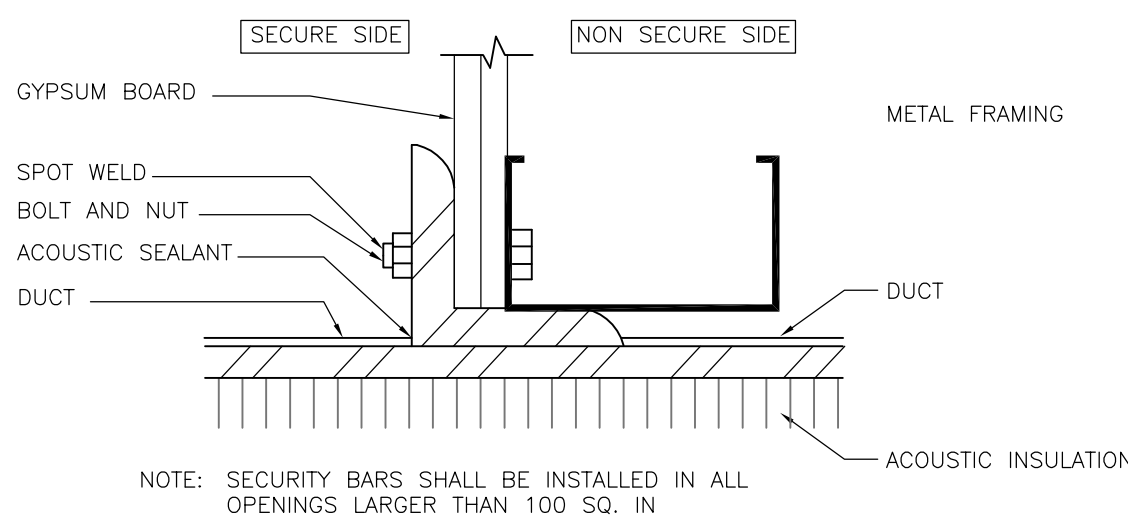

7 TERMINAL BOX DETAIL

SCALE: N.T.S.
M:\BUILDINGS\T09253\19\CAD\DMC-M-502.dwg

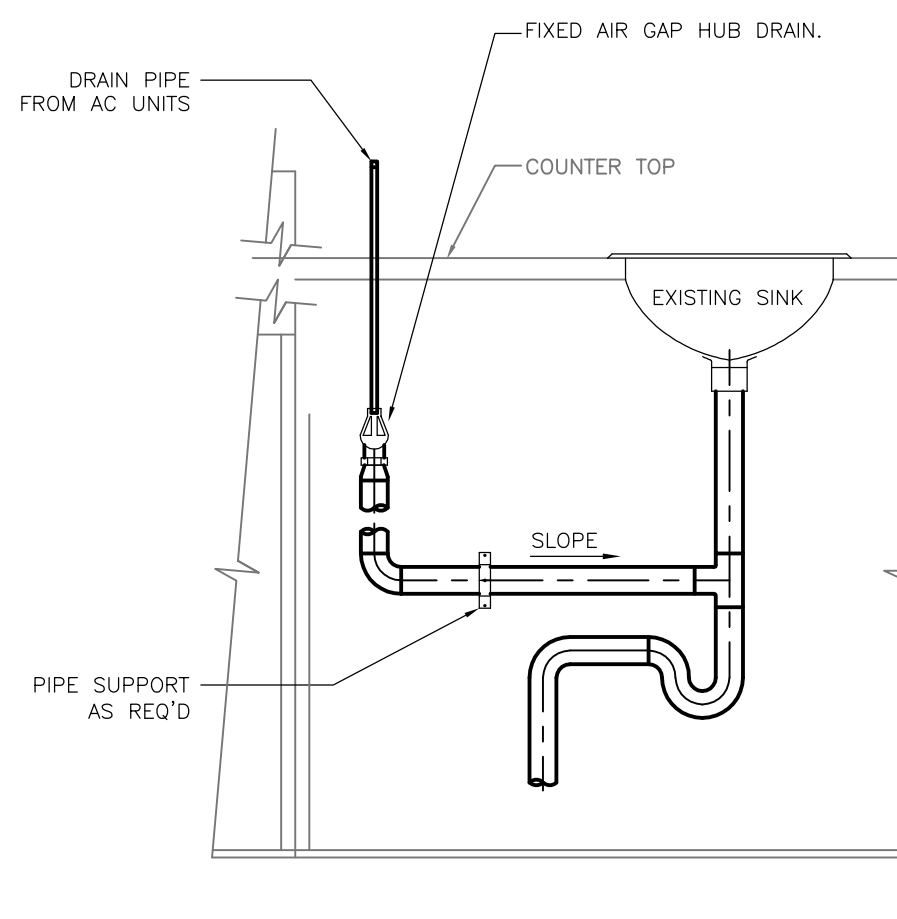


8 FUME HOOD EXHAUST FAN OVERVIEW

SCALE: N.T.S.
M:\BUILDINGS\T09253\19\CAD\DMC-M-502.dwg

DIALOG®

stamp

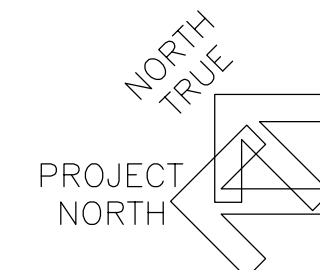

1	BID	2015-08-05
revision	issue	date

Do not scale drawings.
Verify all dimensions and conditions on site and immediately notify the Departmental Representative of all discrepancies.

A	Detail No.
B	No. du détail
C	drawing no. - where detail required dessin no. - où détail exigé
	drawing no. - where detailed dessin no. - où détaillé

project title
titre du projet
CAMPBELLFORD, ONTARIO
WARKWORTH INSTITUTION BLDG WW27
CORRECTIONAL SERVICES CANADA
15847 County Road 29, KOL 1LO
RETROFIT ARMOURY & SMO WORK AREA

drawing title
titre du dessin

MECHANICAL DETAILS

drawn by
dessiné par
M MOAZZAM

designed by
conc par
H ABOUTALEBI

approved by
approuvé par
R DOMINGUEZ

bid
offre
K HAQUE

project manager
administrateur
de projets

project date
date du projet
2015-06-15

project no.
no. du projet
R.069651.001

drawing no.
dessiné no.
M-09