

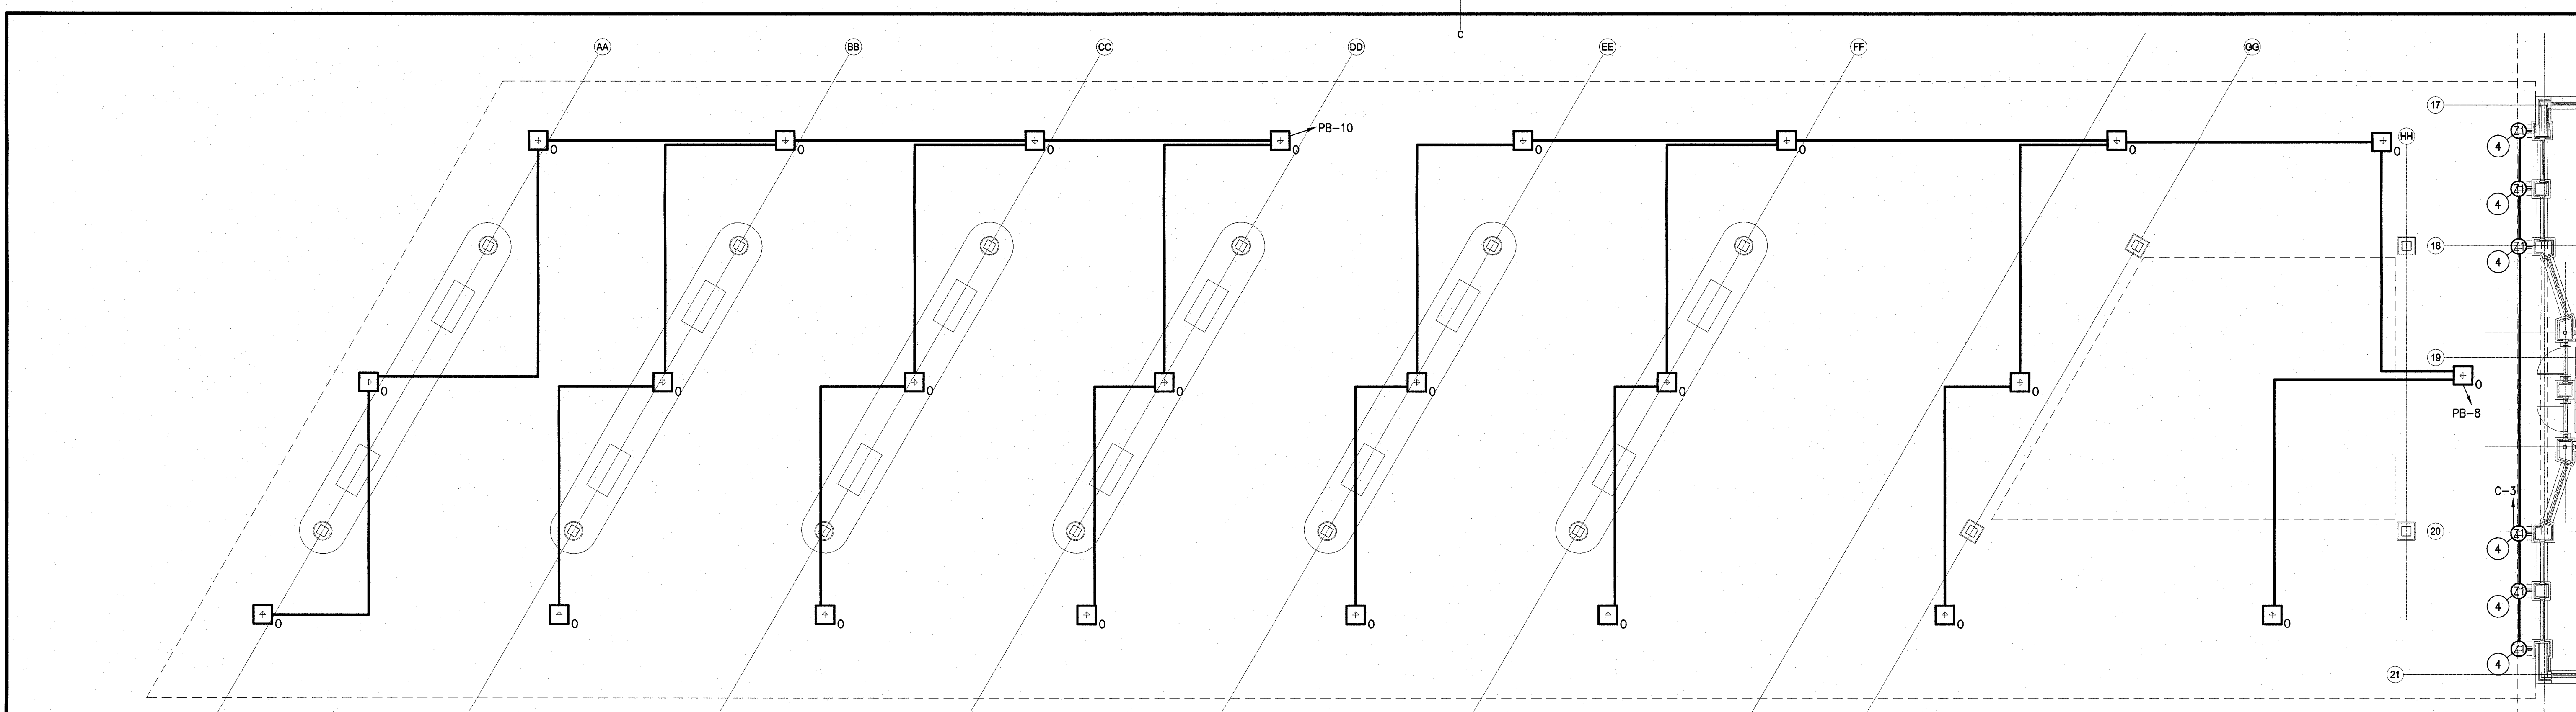



electrical consultant

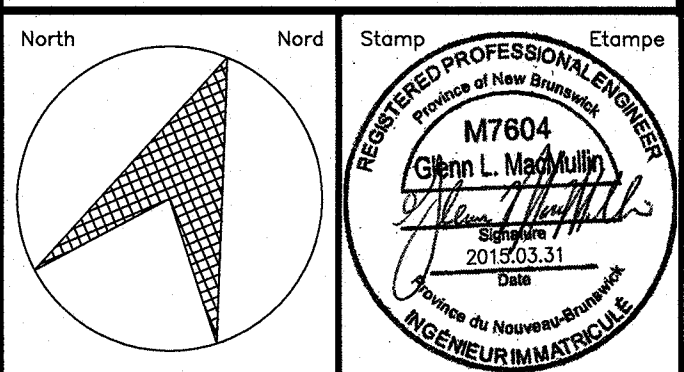

1 SECONDARY CANOPY LIGHTING LAYOUT  
SCALE 1:100

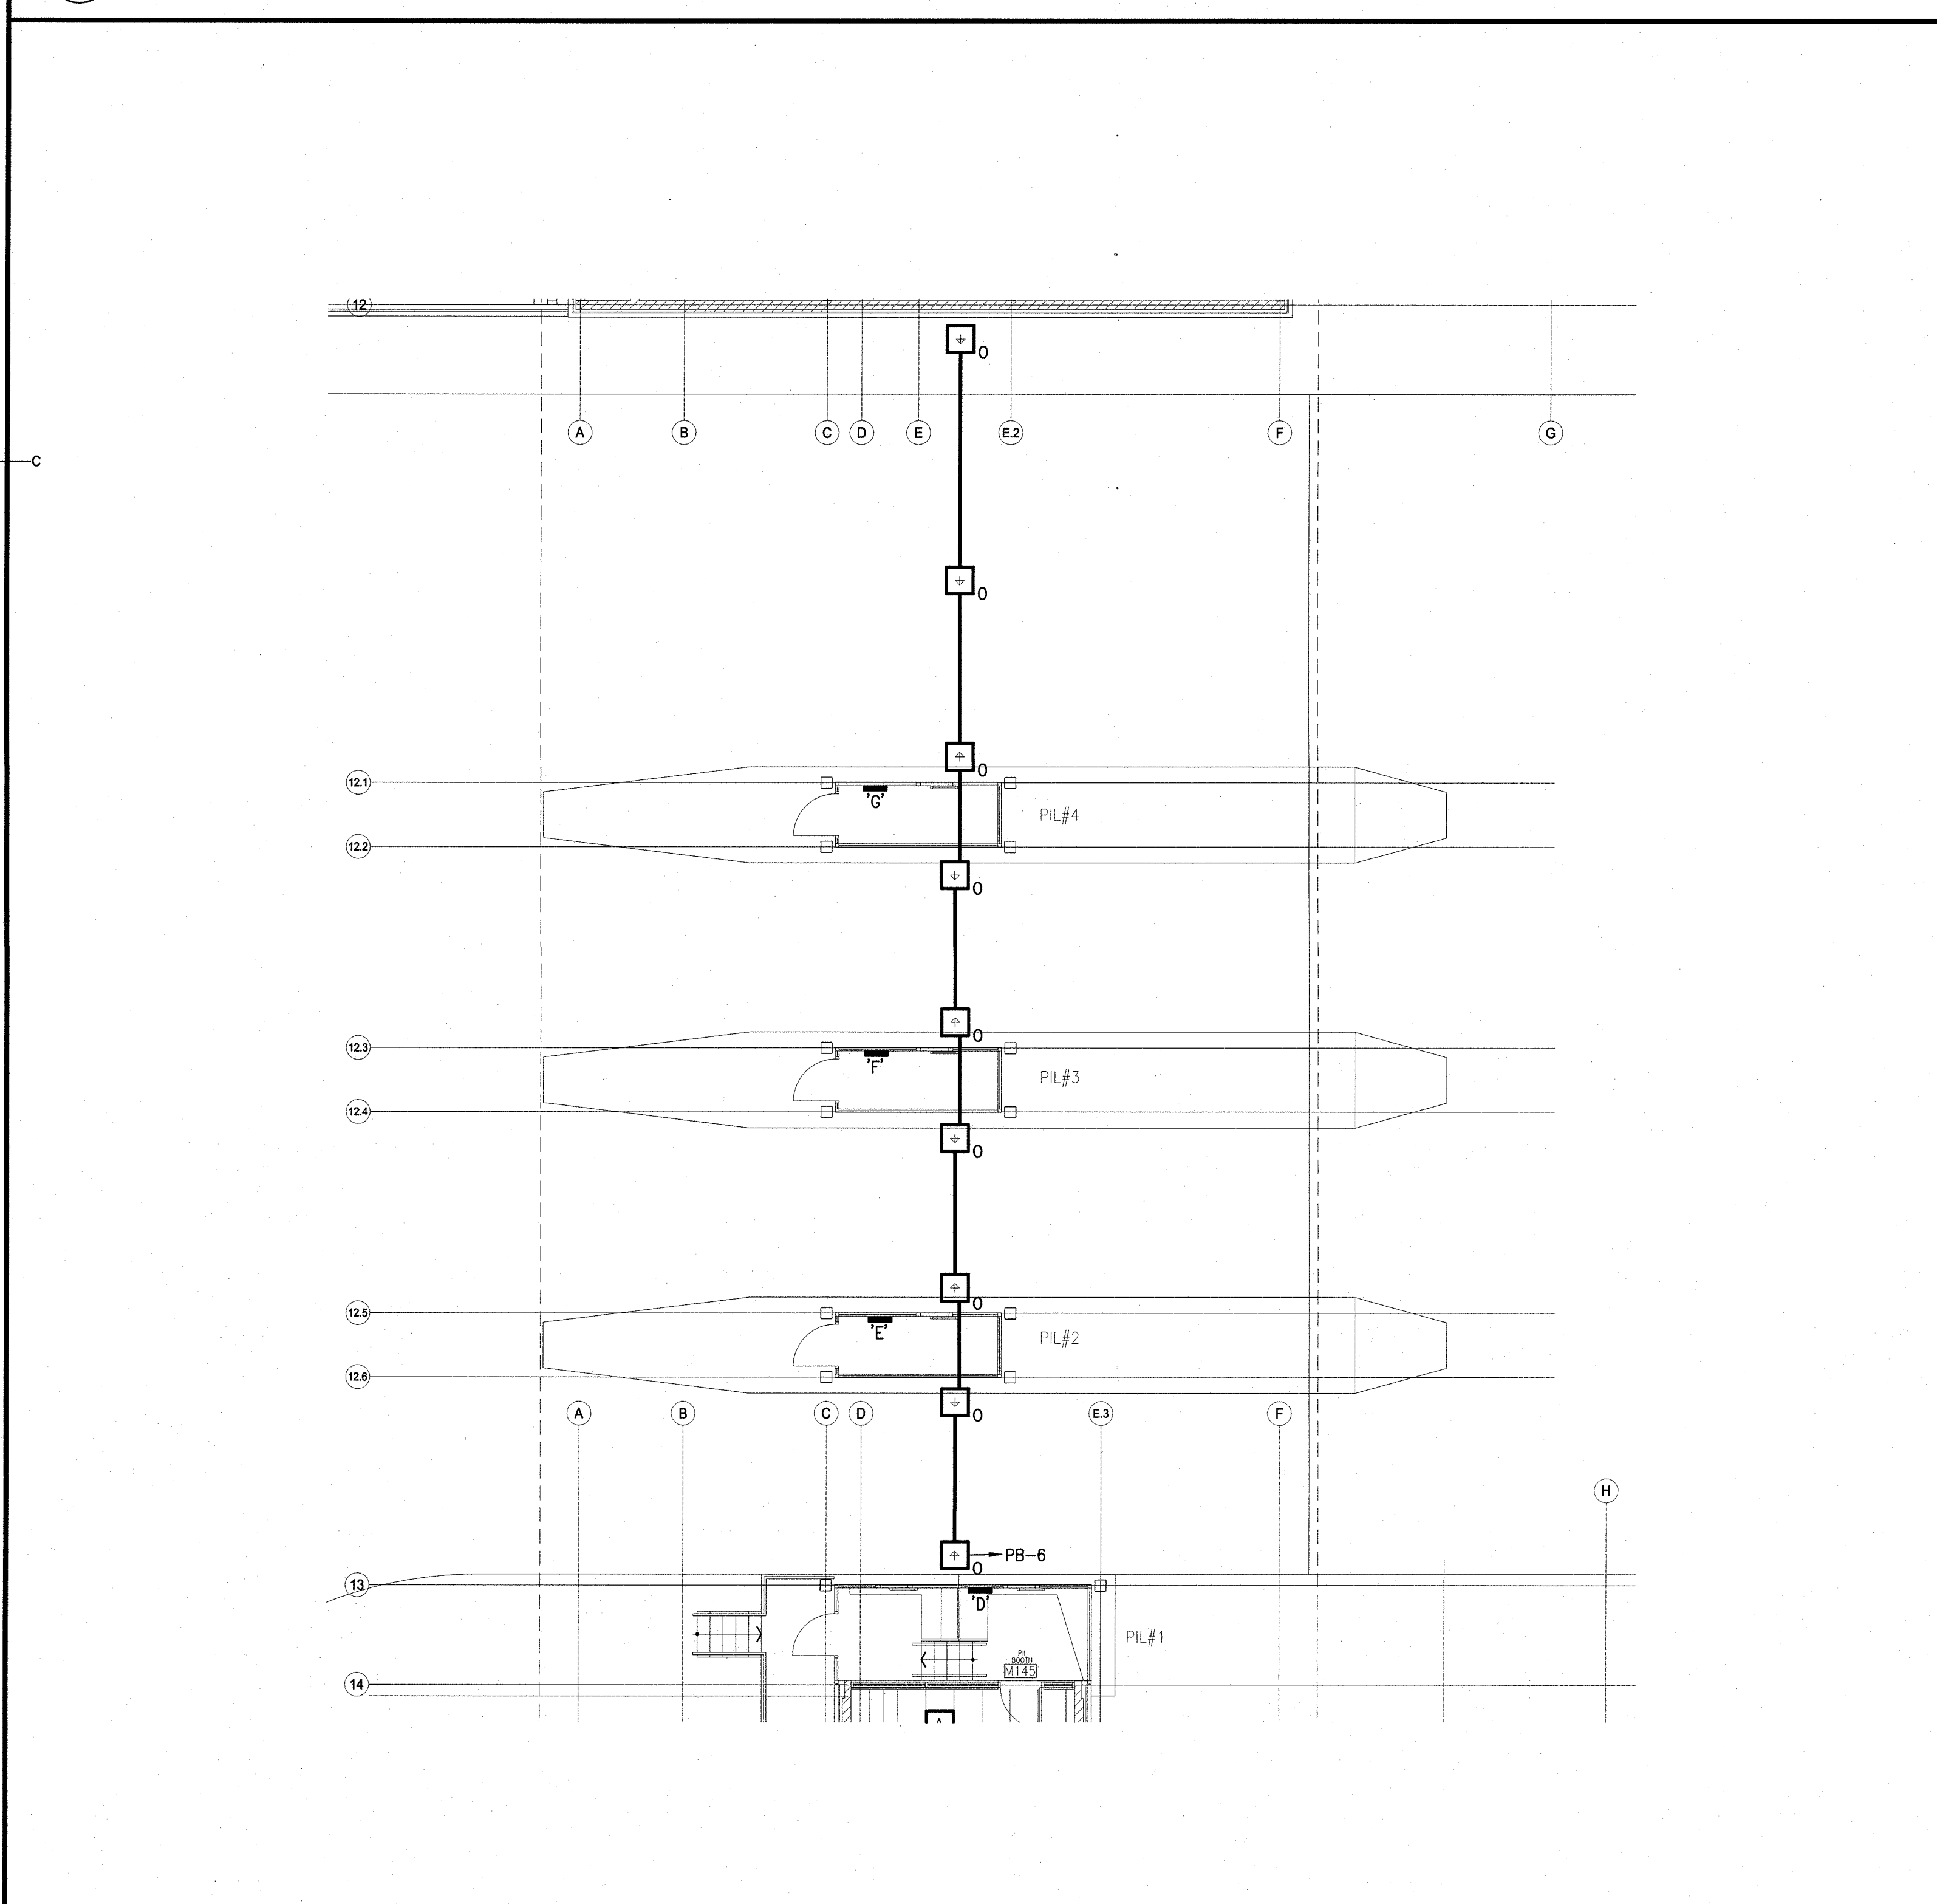

2 PRIMARY INSPECTION CANOPY LIGHTING LAYOUT  
SCALE 1:100

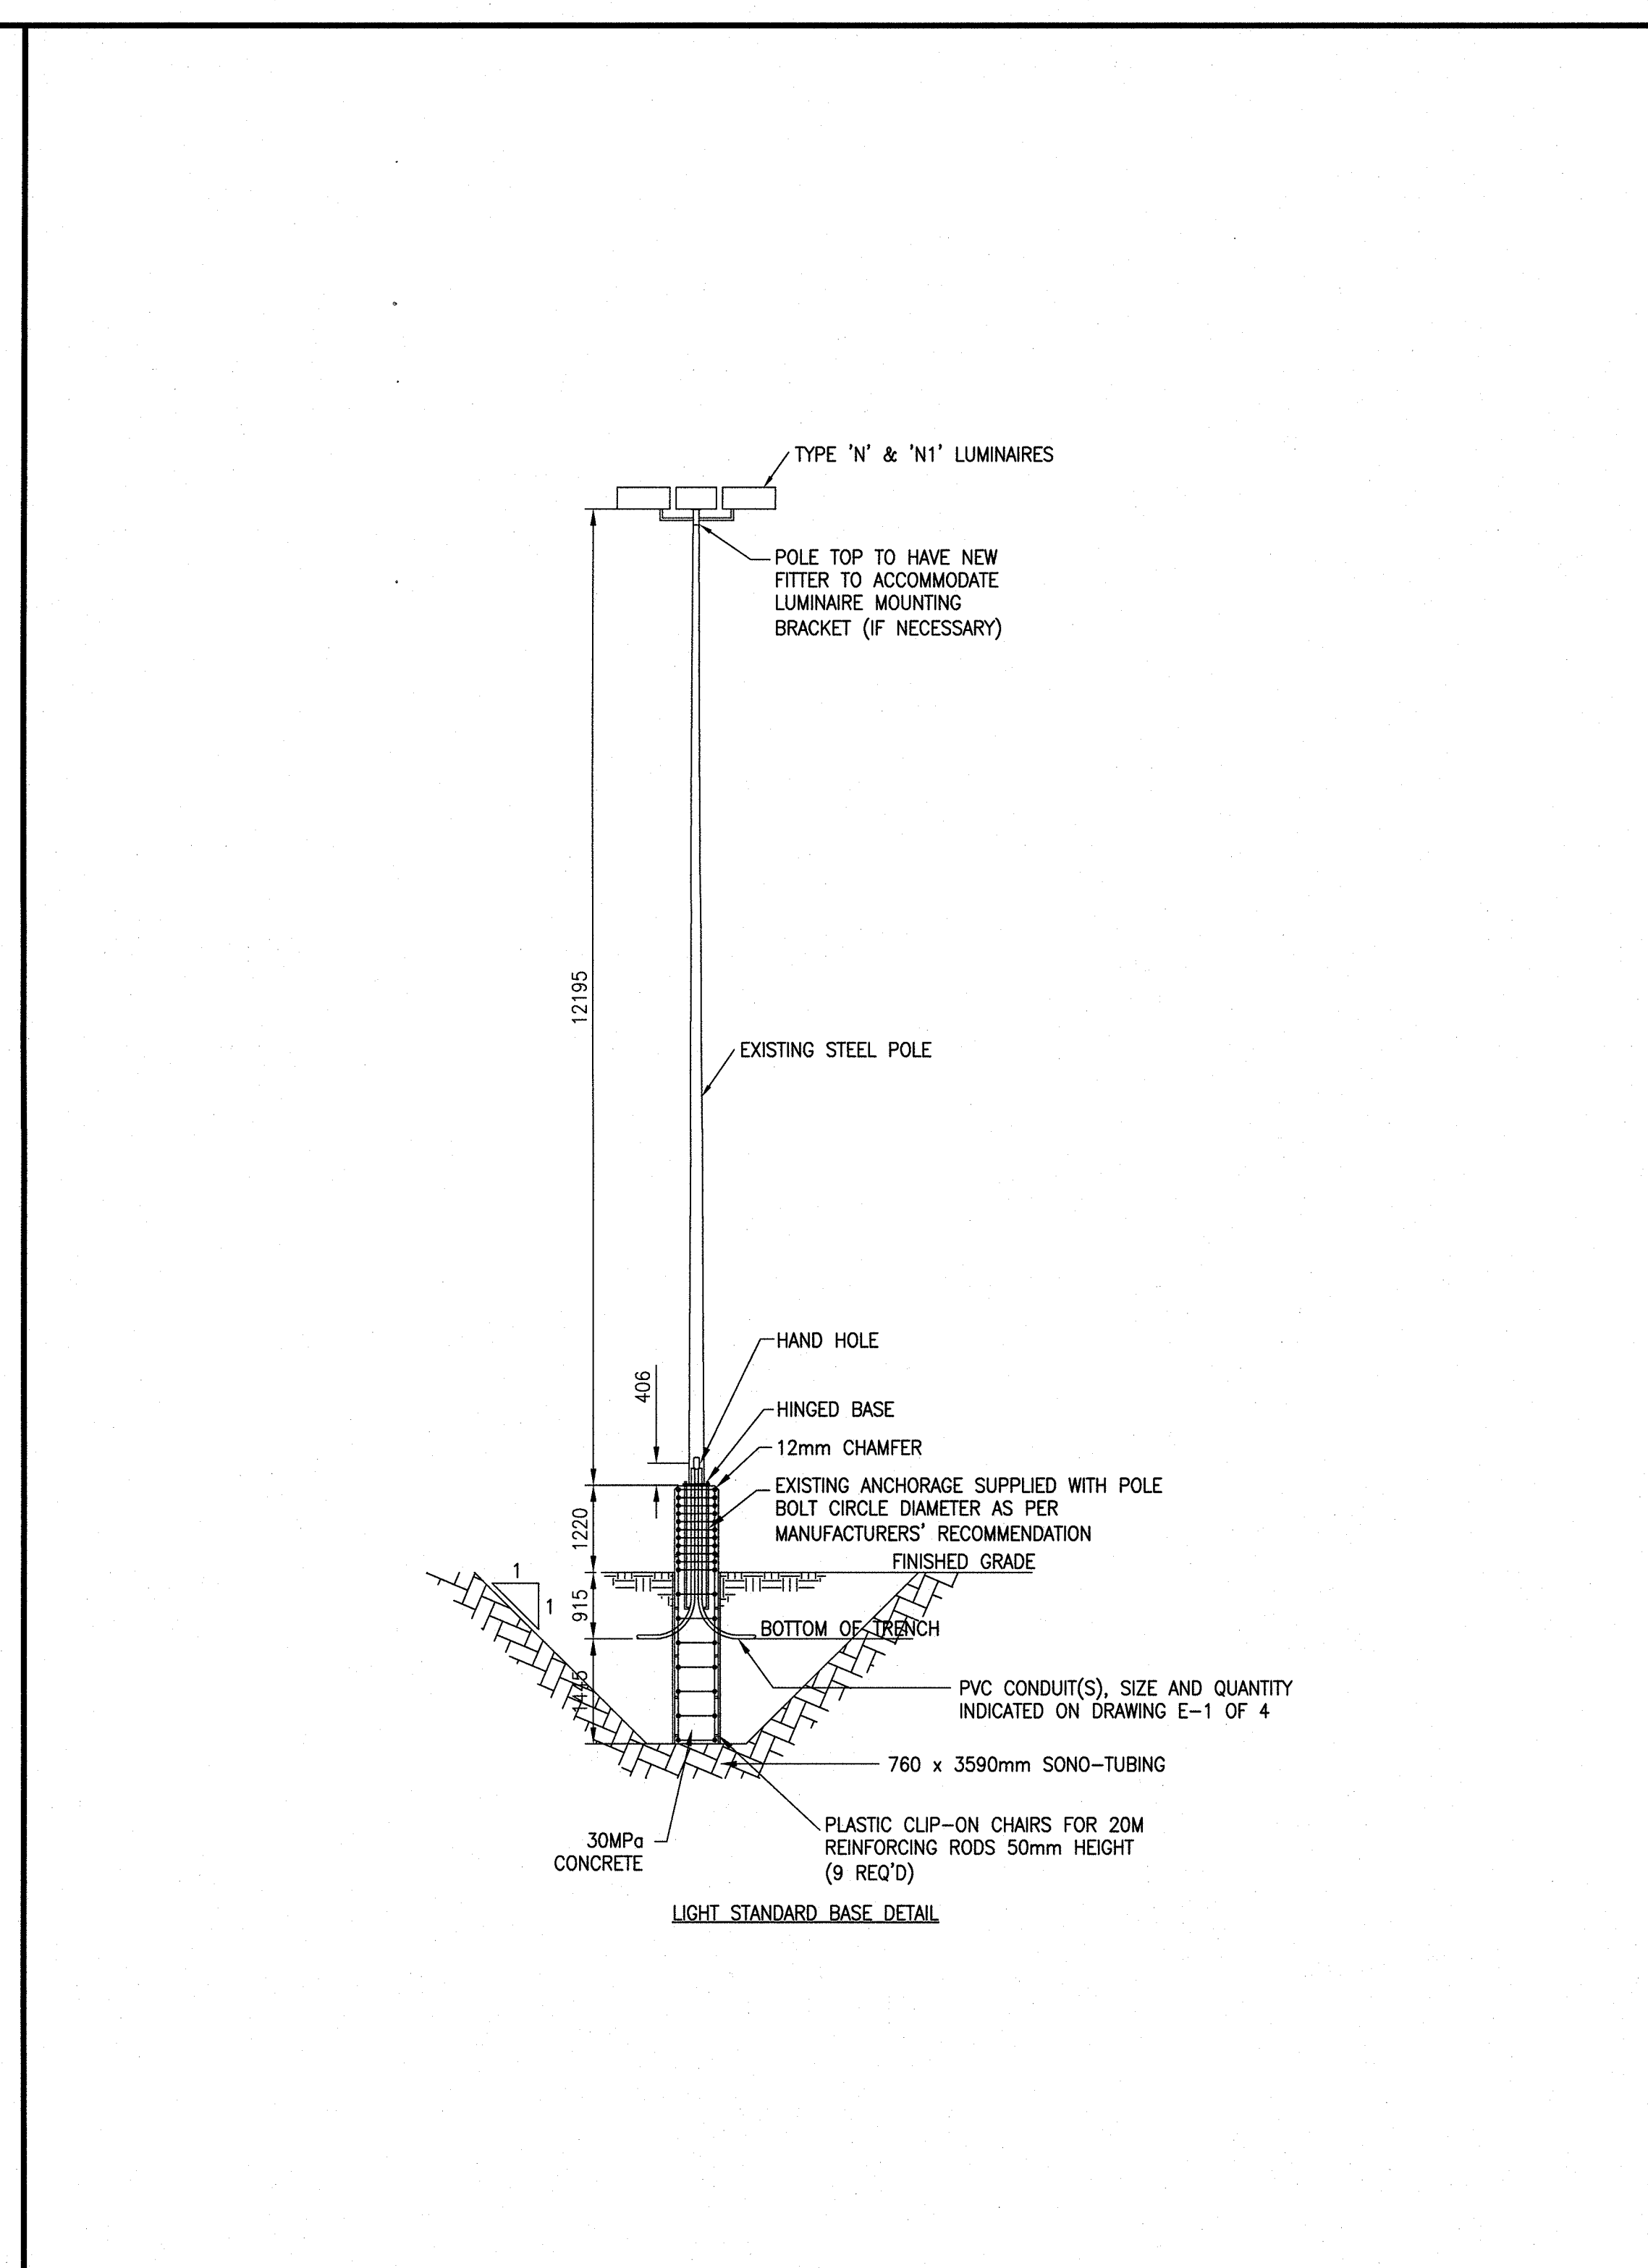

3 LIGHT STANDARD DETAIL (TYPE N, N1)  
SCALE N.T.S.

- NOTES
1. ALL LUMINAIRE LOCATIONS ARE EXISTING. EXISTING FIXTURES TO BE REPLACED WITH NEW TYPE AS INDICATED.
  2. GENERAL: FOR ALL BUILDING MOUNTED LUMINAIRES: ENSURE FINAL INSTALLATION CONSISTS OF A FIXTURE THAT COVERS ALL EXISTING BACK BOXES & PENETRATIONS OR PROVIDE MEANS TO COVER OR SEAL ANY UNCOVERED BOXES AND/OR PENETRATIONS.
  3. TYPE 'V' FIXTURES ARE MOUNTED ON 7.6m (25'-0") HIGH DAVIT POLE.
  4. EXISTING TYPE 'Z1' FIXTURE C/W WIRING & CONTROLS IS TO REMAIN.

0	ISSUED FOR TENDER	2015.03.31
revisions	description	date

project EXTERIOR LIGHTING REPLACEMENT  
PORT OF ST. STEPHEN

drawing CANOPY LIGHTING LAYOUT & LIGHT STANDARD DETAIL

designed GLENN MACMULLIN, P.ENG  
date 2015.03.31  
drawn JODI PARKER  
approved TRACEY MCDADE, P.ENG  
date 2015.03.31  
Tender  
PWSC Project Manager  
project number R.073546.001  
drawing no. E4 of/de 4