


9 MAKEUP AIR UNIT OVERVIEW
M-09 SCALE: N.T.S.
M:\BUILDINGS\T09253\19\CAD\DMC-M-502.dwg

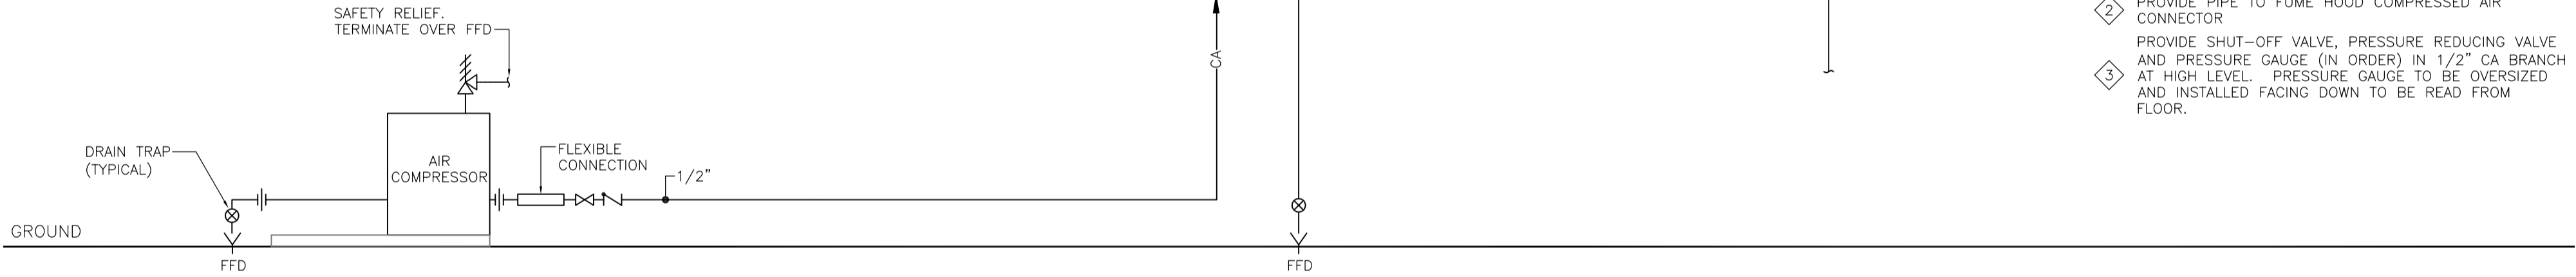


10 COMPRESSED AIR SYSTEM DISTRIBUTION SCHEMATIC
M-09 SCALE: N.T.S.

KEYNOTES

- 1 PROVIDE 1/2" FEMALE THREAD COUPLING, TO CONNECT TO 1/2" CA BRANCH PIPE AT HIGH LEVEL
- 2 PROVIDE PIPE TO FUME HOOD COMPRESSED AIR CONNECTOR
- 3 PROVIDE SHUT-OFF VALVE, PRESSURE REDUCING VALVE AND PRESSURE GAUGE (IN ORDER) IN 1/2" CA BRANCH AT HIGH LEVEL. PRESSURE GAUGE TO BE OVERSIZED AND INSTALLED FACING DOWN TO BE READ FROM FLOOR.

DIALOG

stamp

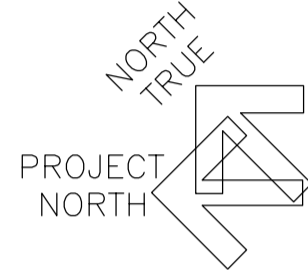

1	BID	2015-08-05
revision	issue	date

Do not scale drawings.
Verify all dimensions and conditions on site and immediately
notify the Departmental Representative of all discrepancies.

A	Detail No. No. du détail
B	drawing no. - where detail required dessin no. - où détail exigé
C	drawing no. - where detailed dessin no. - où détaillé

project title
titre du projet
**CAMPBELLFORD, ONTARIO
WARKWORTH INSTITUTION BLDG WW27
CORRECTIONAL SERVICES CANADA
15847 County Road 29, KOL 1L0
RETROFIT ARMOURY &
SMO WORK AREA**

drawing title
titre du dessin

MECHANICAL DETAILS

drawn by dessiné par	M MOAZZAM	project manager administrateur de projets
designed by conc par	H ABOUTALEBI	
approved by approuvé par	R DOMINGUEZ	
bid offre	K HAQUE	
project date date du projet	2015-06-15	
project no. no. du projet	R.069651.001	
drawing no. dessiné no.	M-10	