



NOTES
DO NOT SCALE FROM DRAWING
ALL DIMENSIONS TO BE VERIFIED BY CONTRACTOR
PRIOR TO MANUFACTURING OR CONSTRUCTION
CONTRACTOR TO REPORT ANY DISCREPANCIES TO NGC
IMMEDIATELY
CONTRACTOR TO PROVIDE SHOP DRAWINGS OF ALL
CUSTOM COMPONENTS FOR APPROVAL BY NGC PRIOR
TO MANUFACTURING
THE DRAWING AND THE WORKS DEPICTED ARE THE
COPYRIGHT OF LUMSDEN DESIGN LTD AND MAY NOT BE
REPRODUCED EXCEPT BY WRITTEN PERMISSION

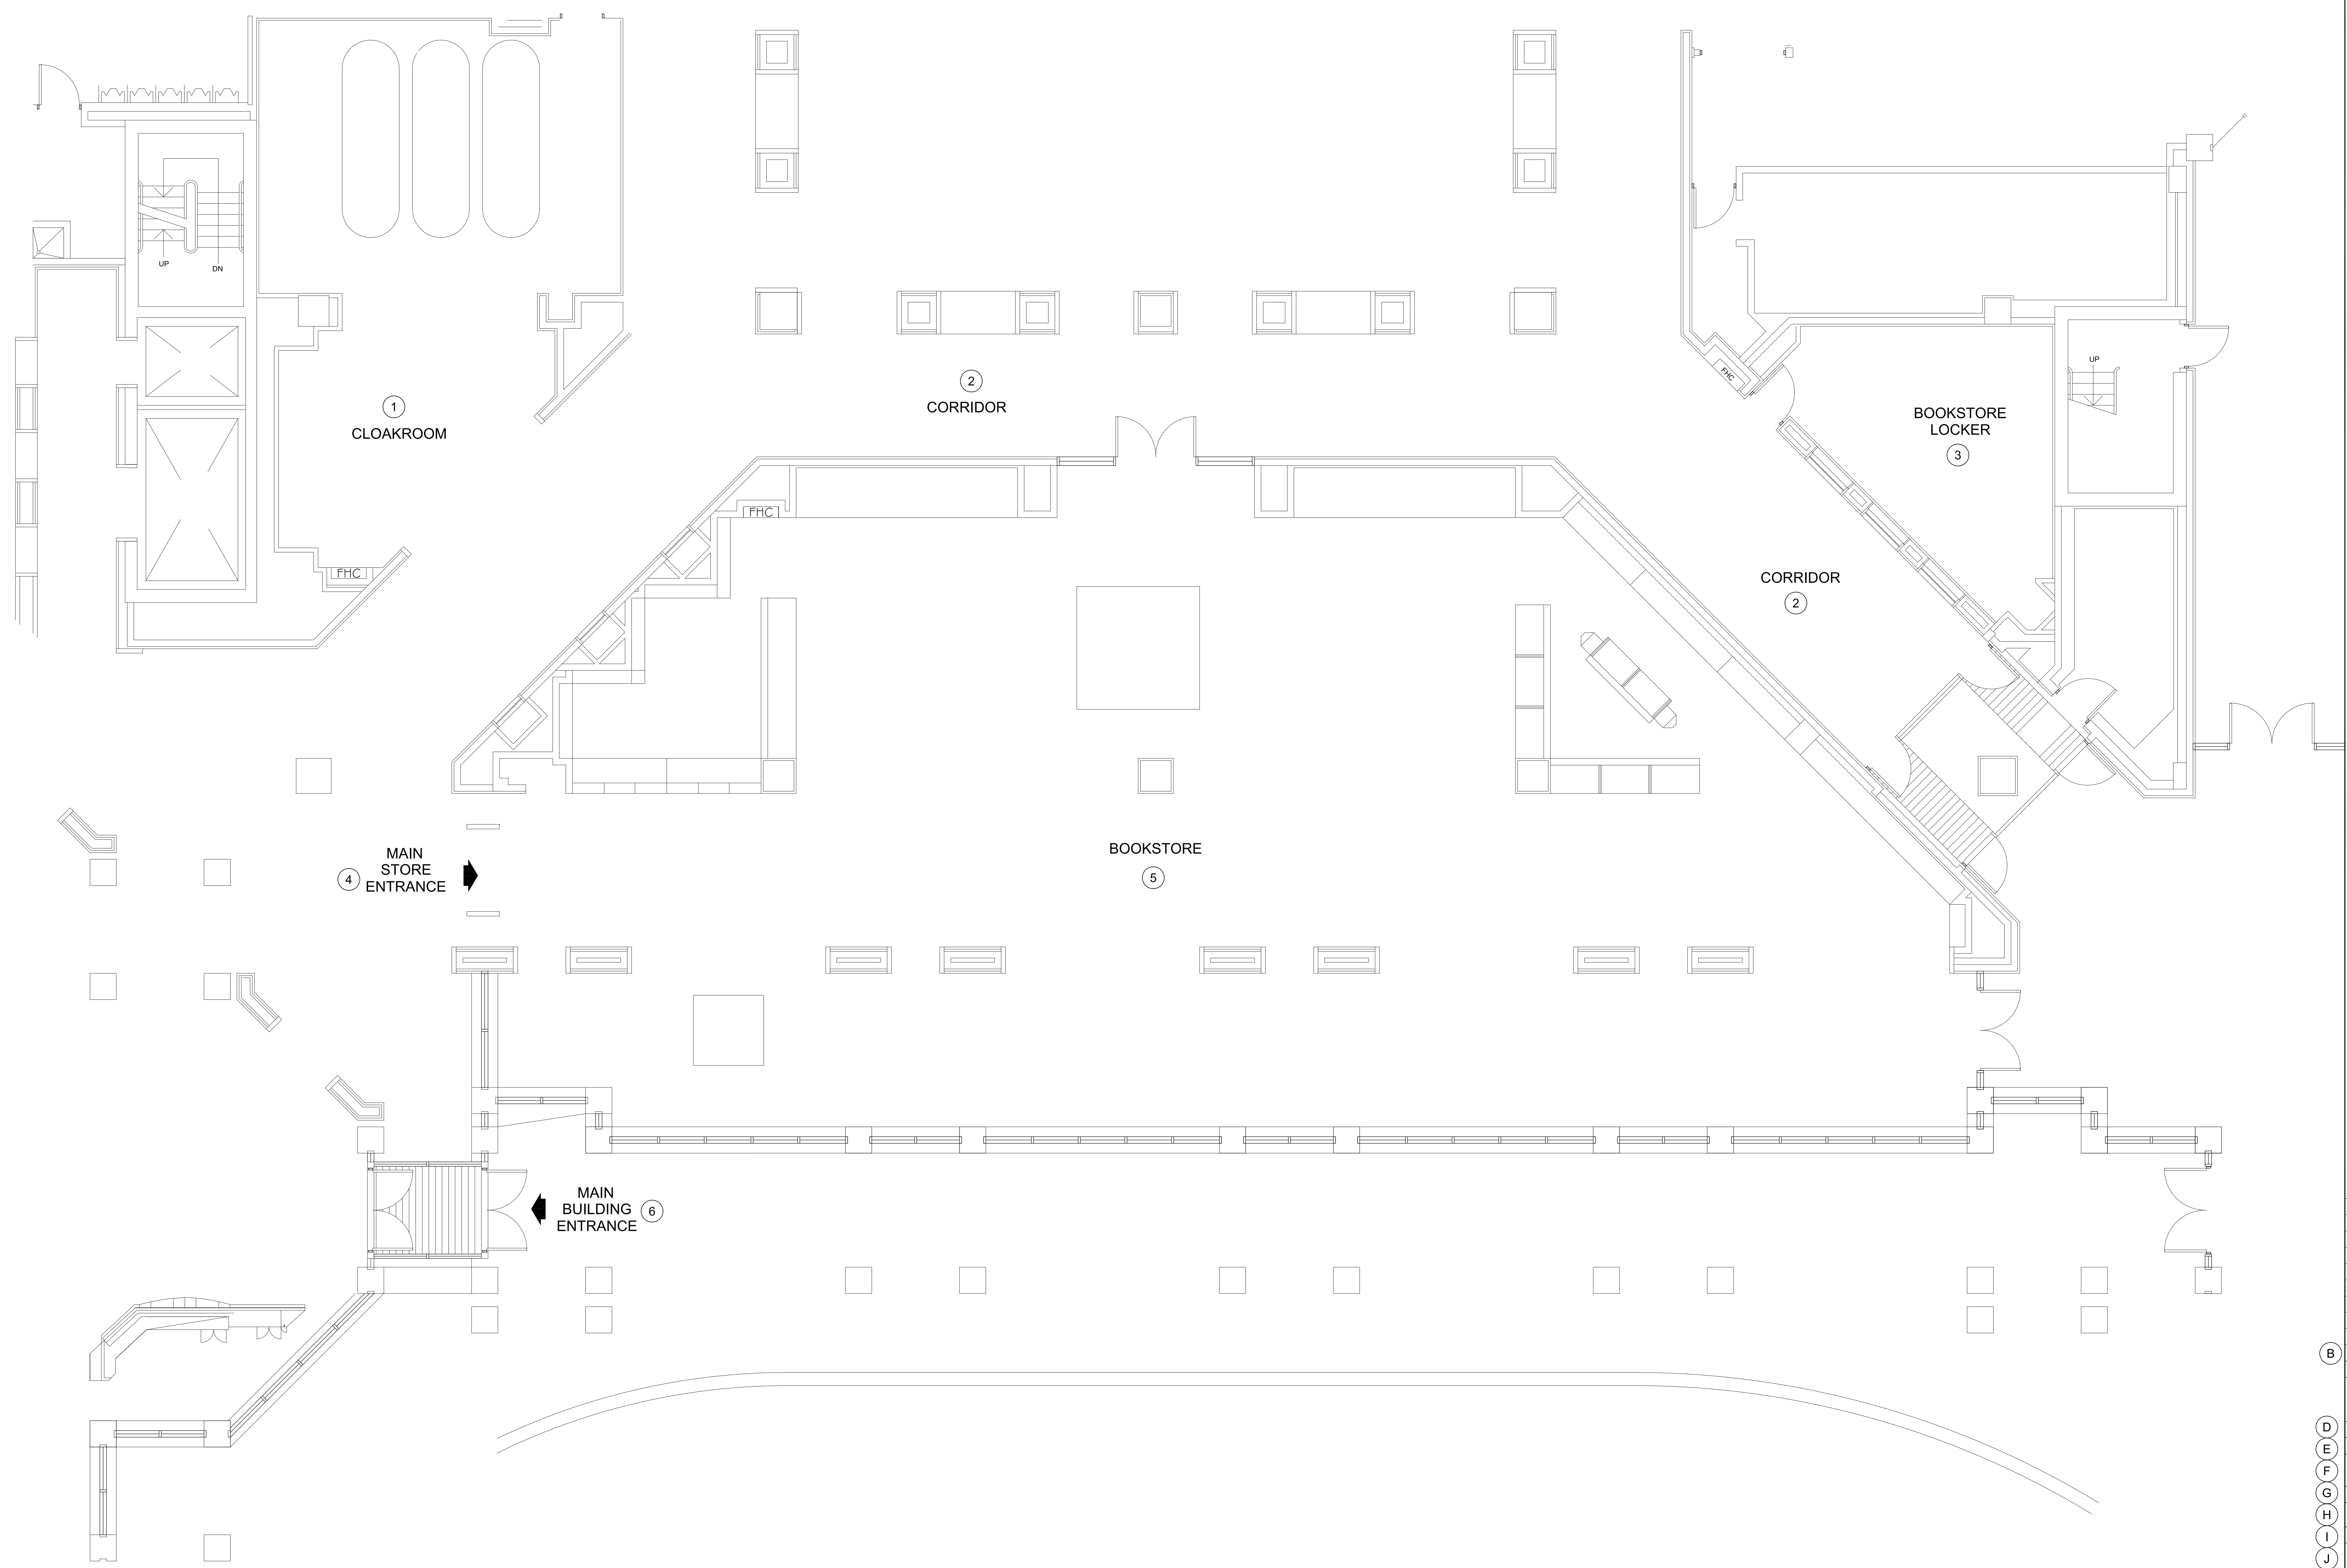

B	REV	DATE	DESCRIPTION	BY
	-	SEPT 10 2015	ISSUED FOR TENDER	-
C	3 Commercial Street London EC1M 6DR UK T +44(0)20 3384 1400			
	CLIENT	NATIONAL GALLERY OF CANADA		
D	PROJECT	NEW RETAIL STORE		
	ORG	EXISTING PLAN		
E	DRG No.	A-01	REV	-
	SCALE	1:50 @ A0	DATE	JUN 2015
F	DRAWN BY		CM	
	SHEET NO.			
G	A-01			
H				
I				
J				

SCALE 1:50 2

- NOTE: 3
- ALL GRANITE TILES, DOORS & DOOR HARDWARE TO BE RETURNED TO THE CLIENT.
 - CONTRACTOR IS RESPONSIBLE FOR THE REMOVAL OF ALL CONSTRUCTION DEBRIS ON A DAILY BASIS.
 - FOR DEMOLITION OF THE DECORATIVE GRANITE COLUMNS REFER TO THE STRUCTURAL DRAWINGS FOR DETAIL (AND FOR DETAIL OF THE PRE CAST ELEMENTS).
 - AT PROJECT COMPLETION, REMOVE ALL 3M FILM FROM BOUTIQUE SIDE ONLY. REMOVE ALL HOARDING AND FLOOR PROTECTION AND MAKE GOOD ALL EXISTING FINISHES.

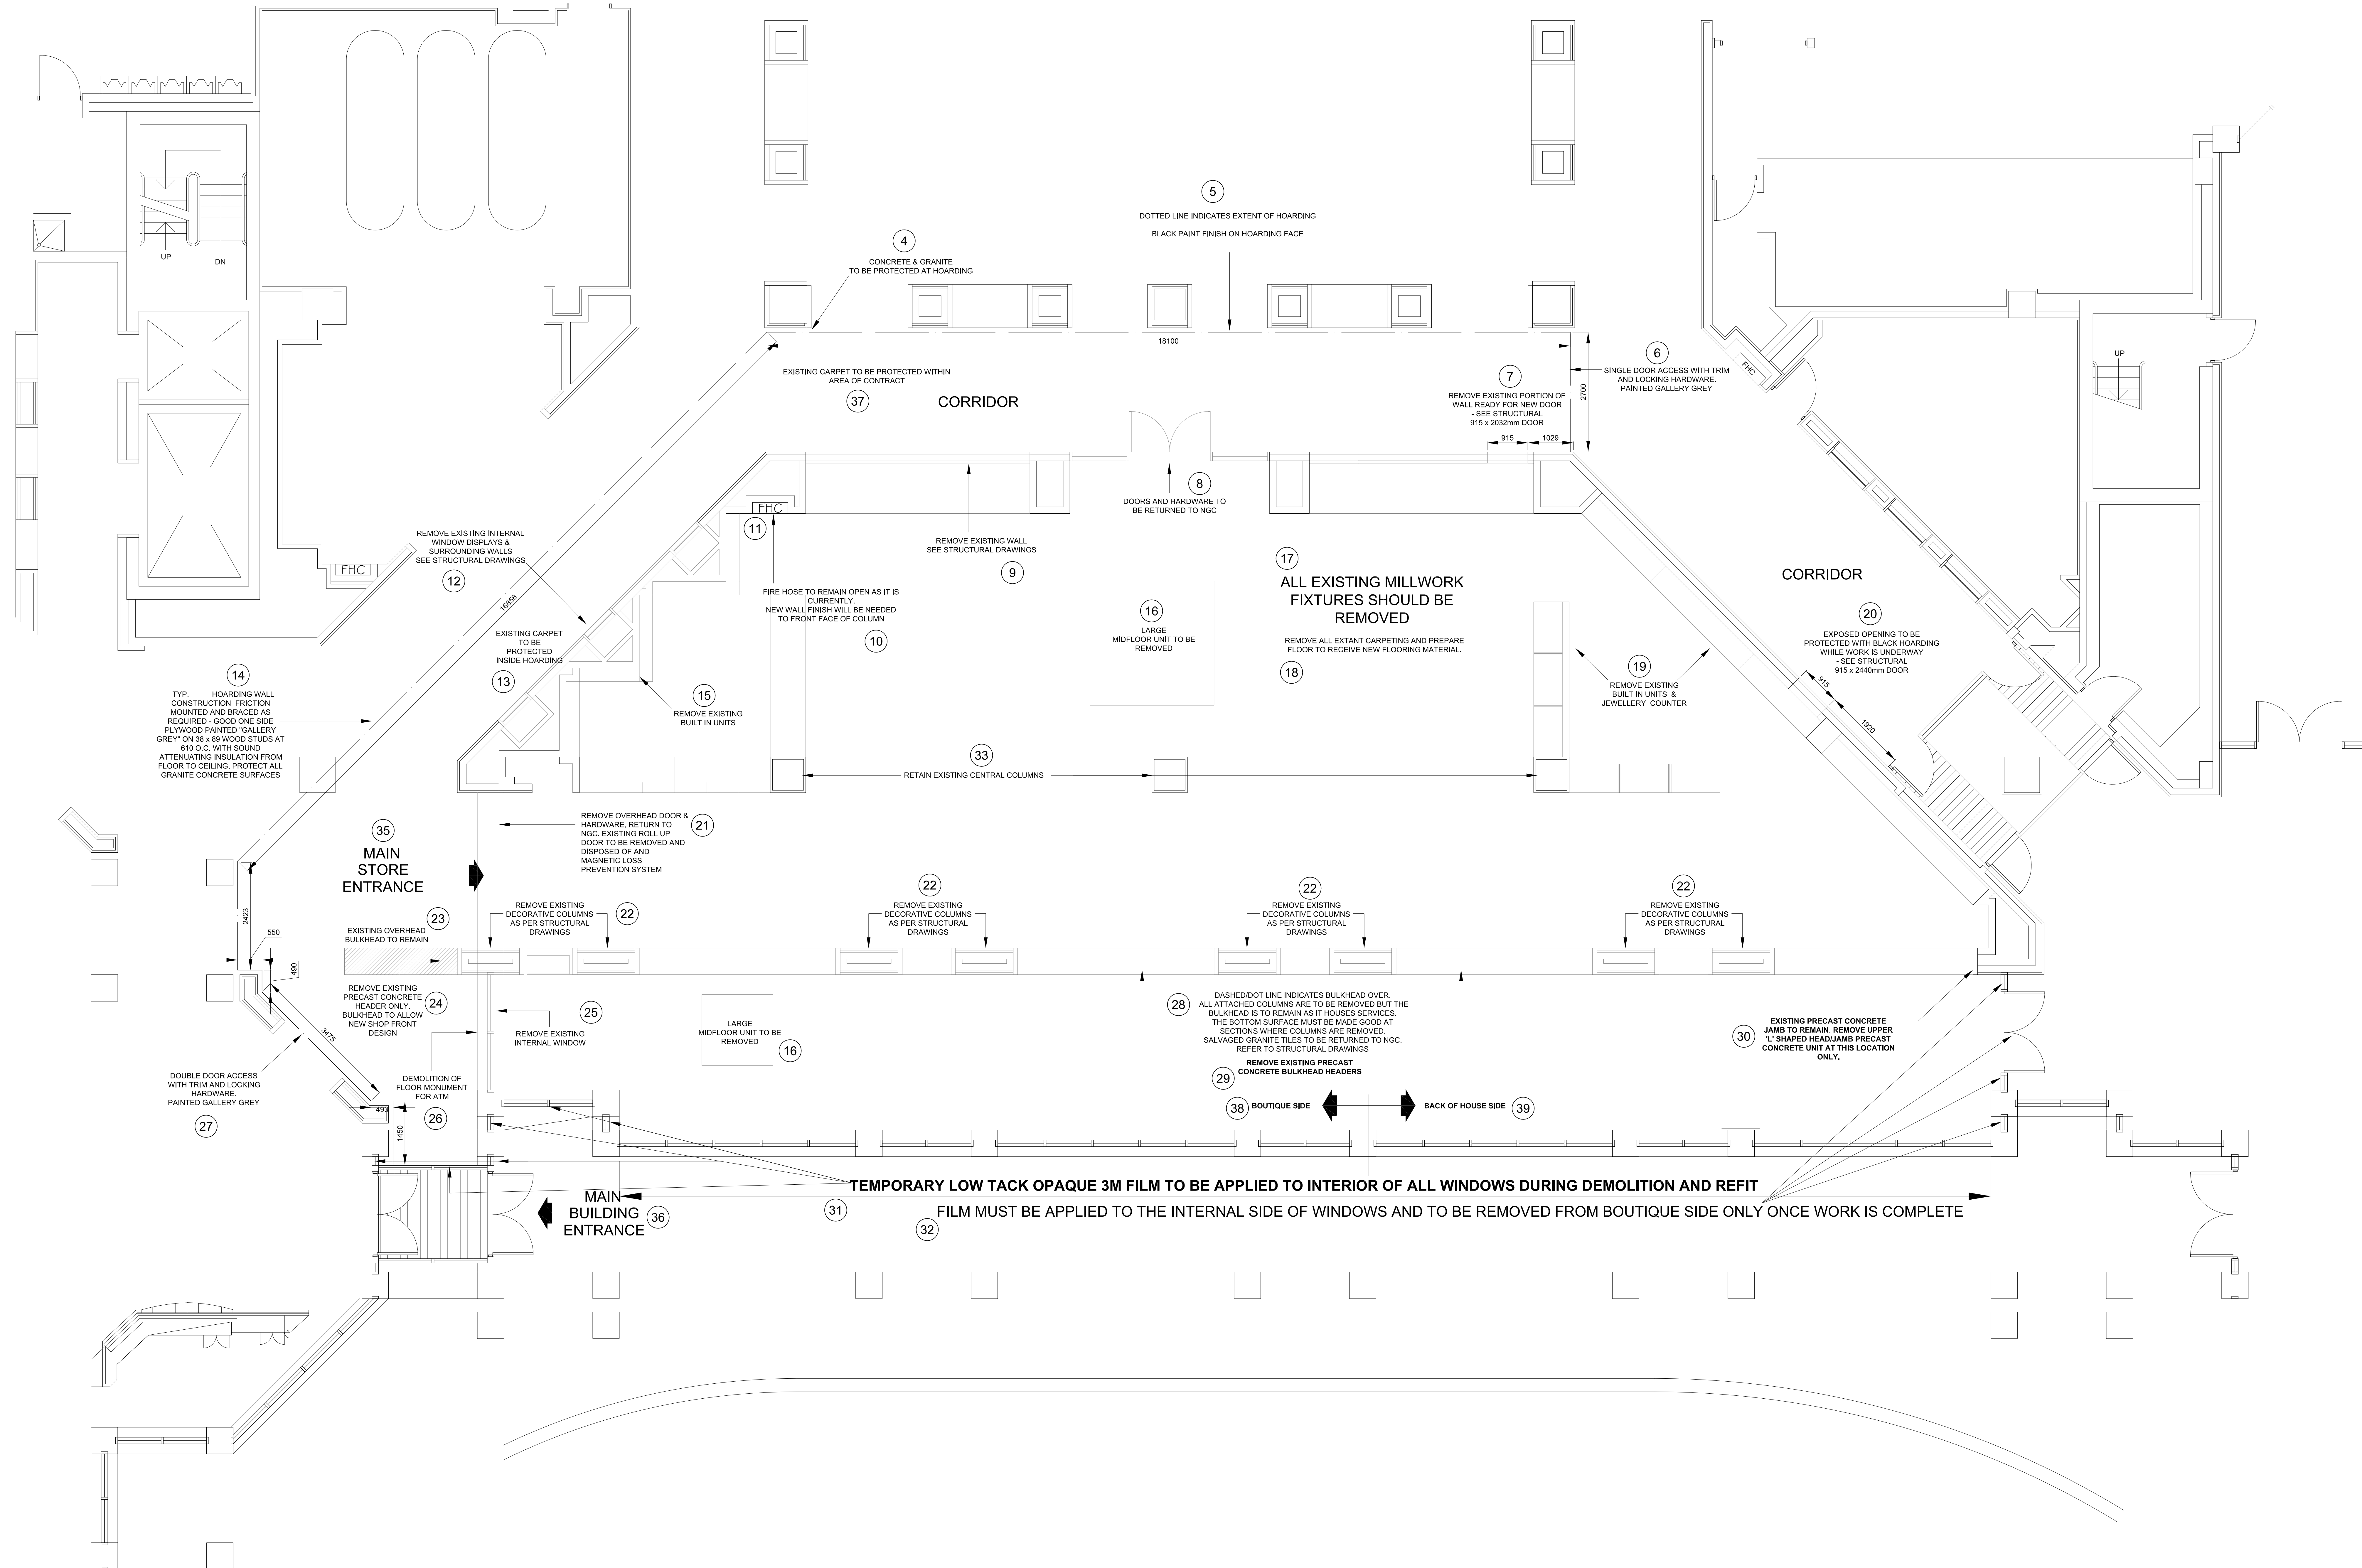

NOTES
 DO NOT SCALE FROM DRAWING
 ALL DIMENSIONS TO BE SITE VERIFIED BY CONTRACTOR PRIOR TO MANUFACTURING OR CONSTRUCTION. CONTRACTOR TO REPORT ANY DISCREPANCIES TO NGC IMMEDIATELY.
 CONTRACTOR TO PROVIDE SHOP DRAWINGS OF ALL CUSTOM COMPONENTS FOR APPROVAL BY NGC PRIOR TO MANUFACTURING.
 THE DRAWING AND THE WORKS DEPICTED ARE THE COPYRIGHT OF LUSSEN DESIGN LTD AND MAY NOT BE REPRODUCED EXCEPT BY WRITTEN PERMISSION.

REV	DATE	DESCRIPTION	BY
-	SEPT 10 2015	ISSUED FOR TENDER	-

3 Commercial Street
 London EC1M 6DR UK
 T +44(0)20 3384 1400

CLIENT NATIONAL GALLERY OF CANADA
 PROJECT NEW RETAIL STORE
 DRG DEMOLITION PLAN 1

DRG No: A-02 REV: -
 SCALE: 1:50 @ A0 DATE: JUN 2015
 DRAWN BY: CM
 SHEET NO: A-02

2


PARTITIONS DETAILS
92MM (3 5/8") STEEL STUDS (25 GAUGE) 400mm O.C.
16MM DRYWALL
MIN 38MM (1 1/2") SOUND ATTENUATION BATONS
JOINTS TAPED AND SANDED

WALL CONSTRUCTION KEY

- P1 SLAB TO SLAB - NO DRYWALL ON BOUTIQUE SIDE
- P2 SLAB TO SLAB, DRYWALL BOTH SIDES
- P3 TO UIS OF FINISHED CEILING WITH PLENUM BAFFLE

NEW PARTITIONS NOTE ALL DIMENSIONS MEASURED TO FACE OF STUD
EXISTING PARTITIONS TO FACE OF EXISTING WALL OR COLUMN

NOTES
DO NOT SCALE FROM DRAWING
ALL DIMENSIONS TO BE SITE VERIFIED BY CONTRACTOR
PRIOR TO MANUFACTURING OR CONSTRUCTION.
CONTRACTOR TO REPORT ANY DISCREPANCIES TO NSG
IMMEDIATELY.
CONTRACTOR TO PROVIDE SHOP DRAWINGS OF ALL
CUSTOM COMPONENTS FOR APPROVAL BY NSG PRIOR
TO MANUFACTURING.
THE DRAWING AND THE WORKS DEPICTED ARE THE
COPYRIGHT OF LUSSEN DESIGN LTD AND MAY NOT BE
REPRODUCED EXCEPT BY WRITTEN PERMISSION

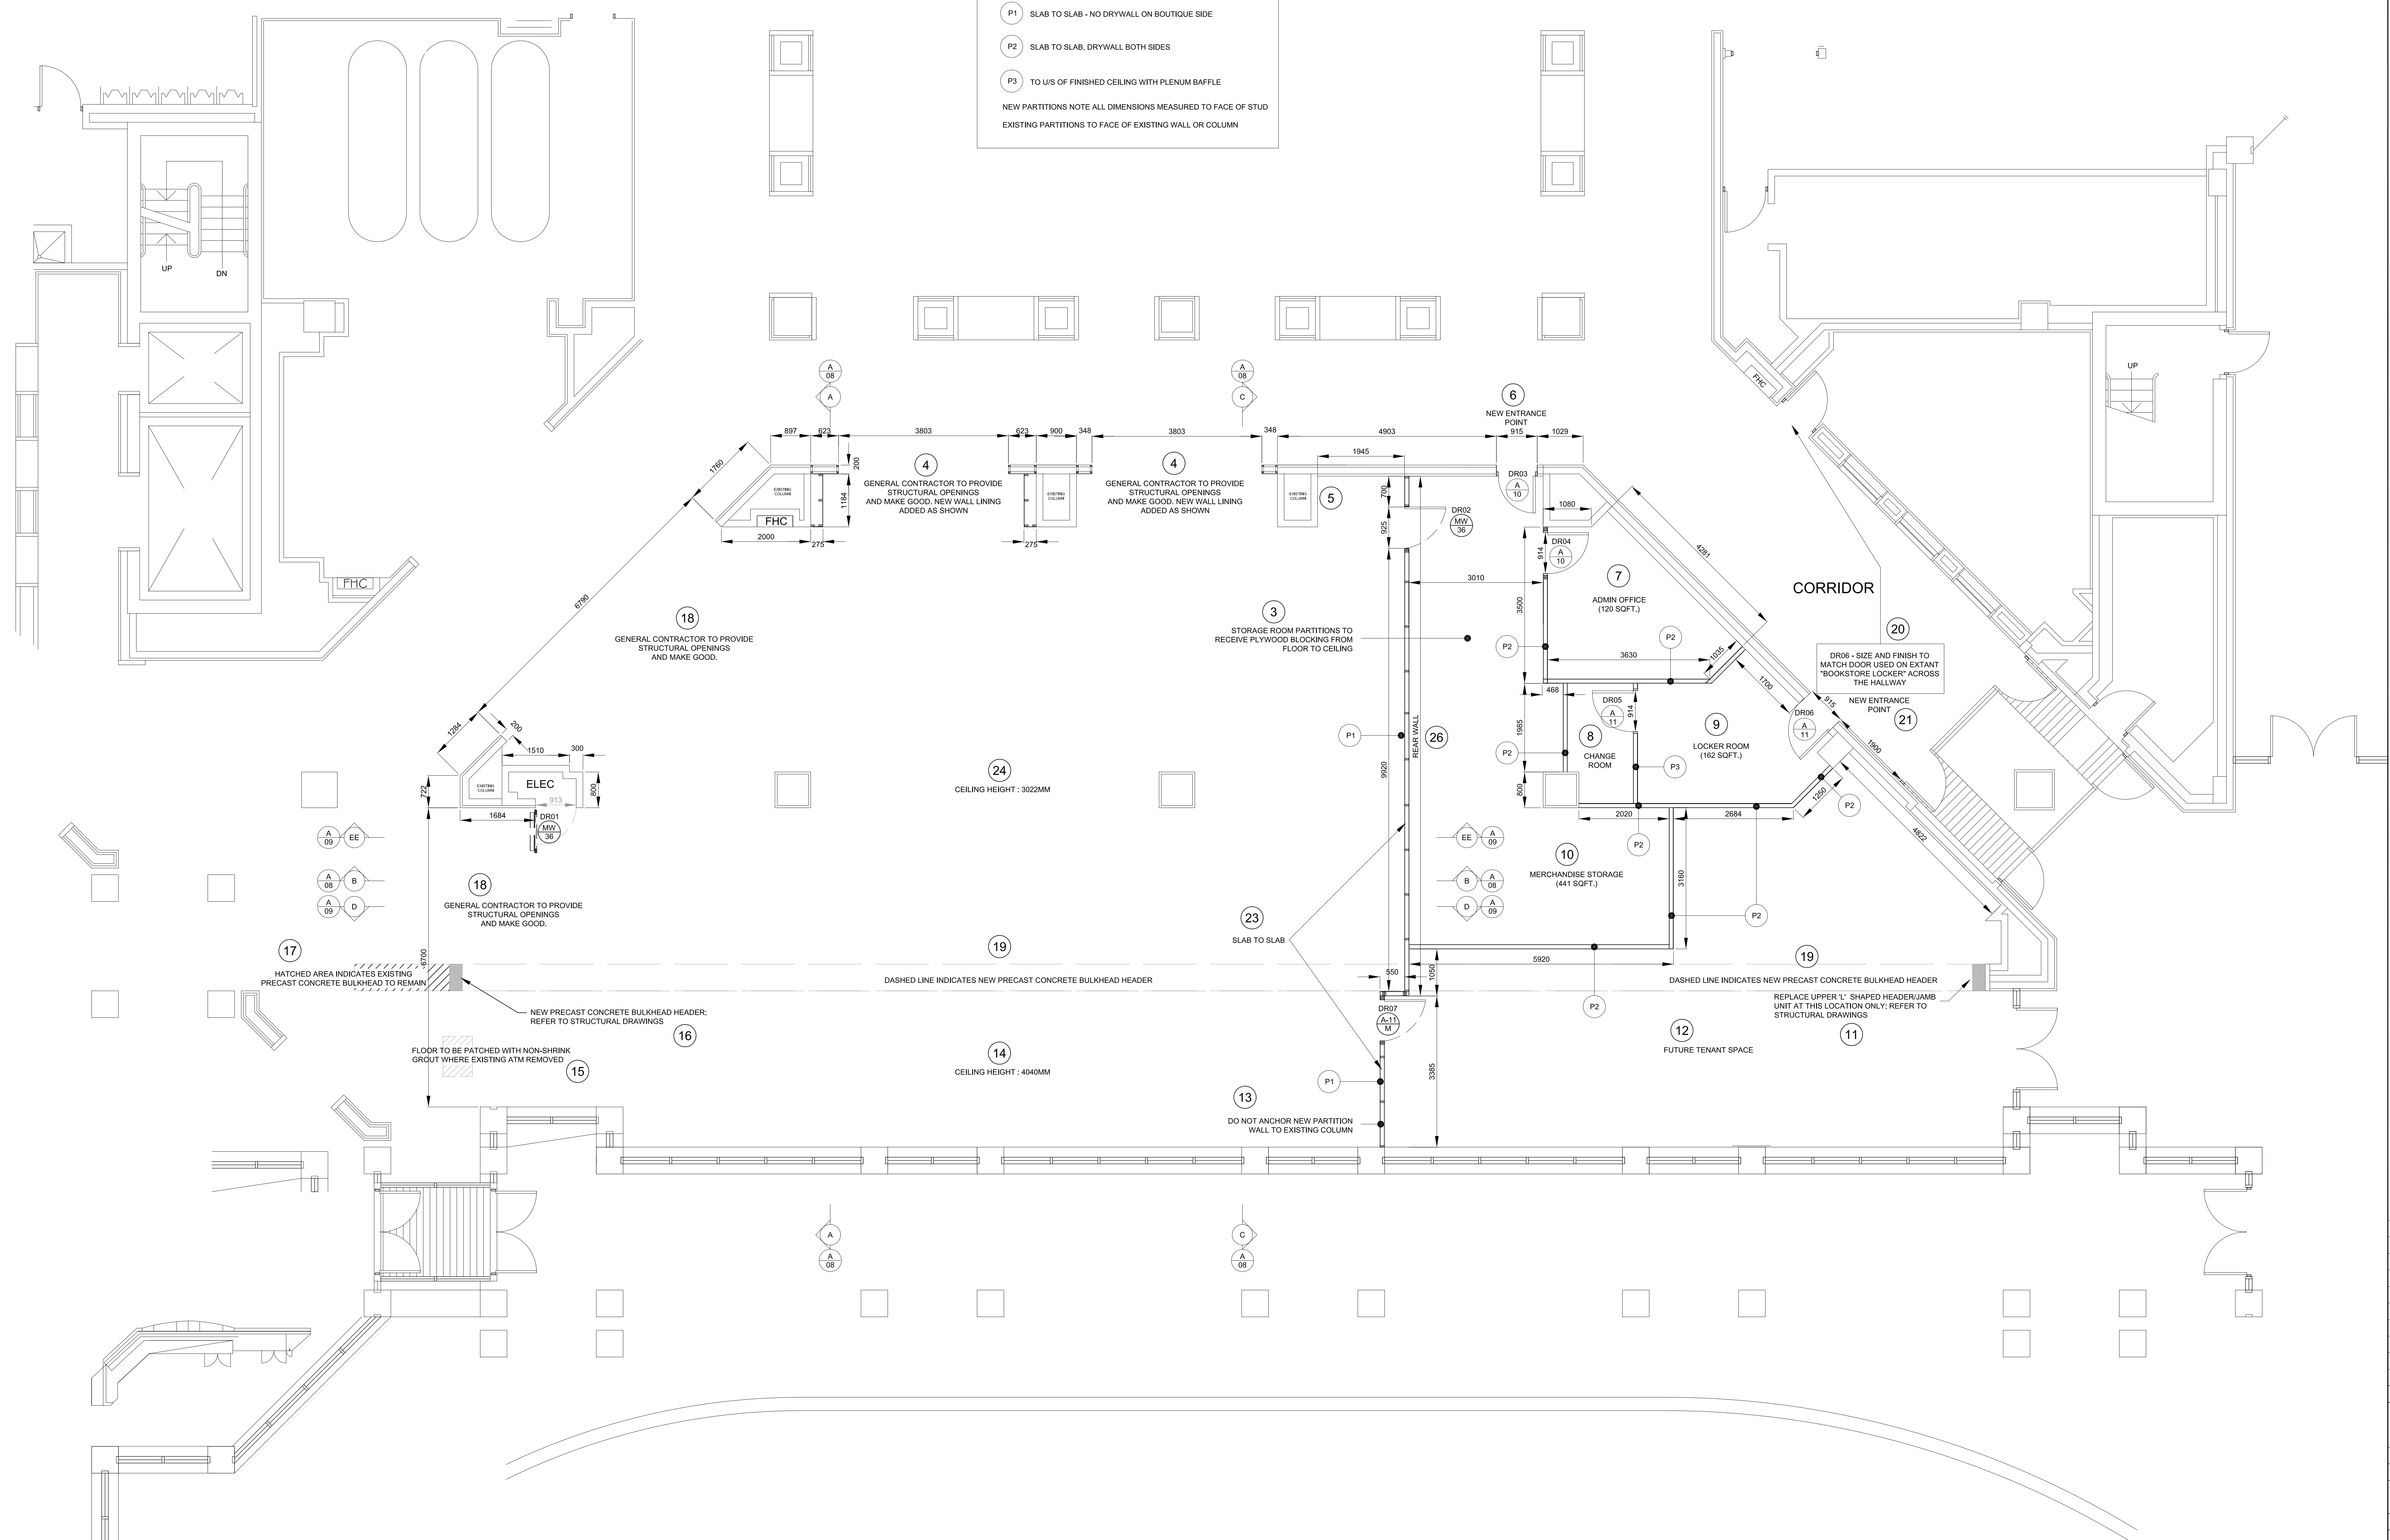

REV	DATE	DESCRIPTION	BY
-	SEPT 10 2015	ISSUED FOR TENDER	-

2 Commercial Street
London EC1M 6DR UK
T +44(0)20 3384 1400

CLIENT NATIONAL GALLERY OF CANADA
PROJECT NEW RETAIL STORE
ORG CONSTRUCTION PLAN **1**



DRG No: A-03 REV -
SCALE 1:50 @ A0 DATE JUN 2015
DRAWN BY CM
SHEET NO. **A-03**

NATIONAL GALLERY OF CANADA 9
 REFLECTED CEILING PLAN DEMOLITION 3

SCALE 1:50

NOTE: FOR ALL ELECTRICAL AND MECHANICAL DEMOLITION REFER TO MECHANICAL, ELECTRICAL AND STRUCTURAL DRAWINGS 1

NOTES
 DO NOT SCALE FROM DRAWING
 ALL DIMENSIONS TO BE SITE VERIFIED BY CONTRACTOR PRIOR TO MANUFACTURING OR CONSTRUCTION. CONTRACTOR TO REPORT ANY DISCREPANCIES TO NGC IMMEDIATELY.
 CONTRACTOR TO PROVIDE SHOP DRAWINGS OF ALL CUSTOM COMPONENTS FOR APPROVAL BY NGC PRIOR TO MANUFACTURING.
 THE DRAWING AND THE WORKS DEPICTED ARE THE COPYRIGHT OF LUSSEN DESIGN LTD AND MAY NOT BE REPRODUCED EXCEPT BY WRITTEN PERMISSION.

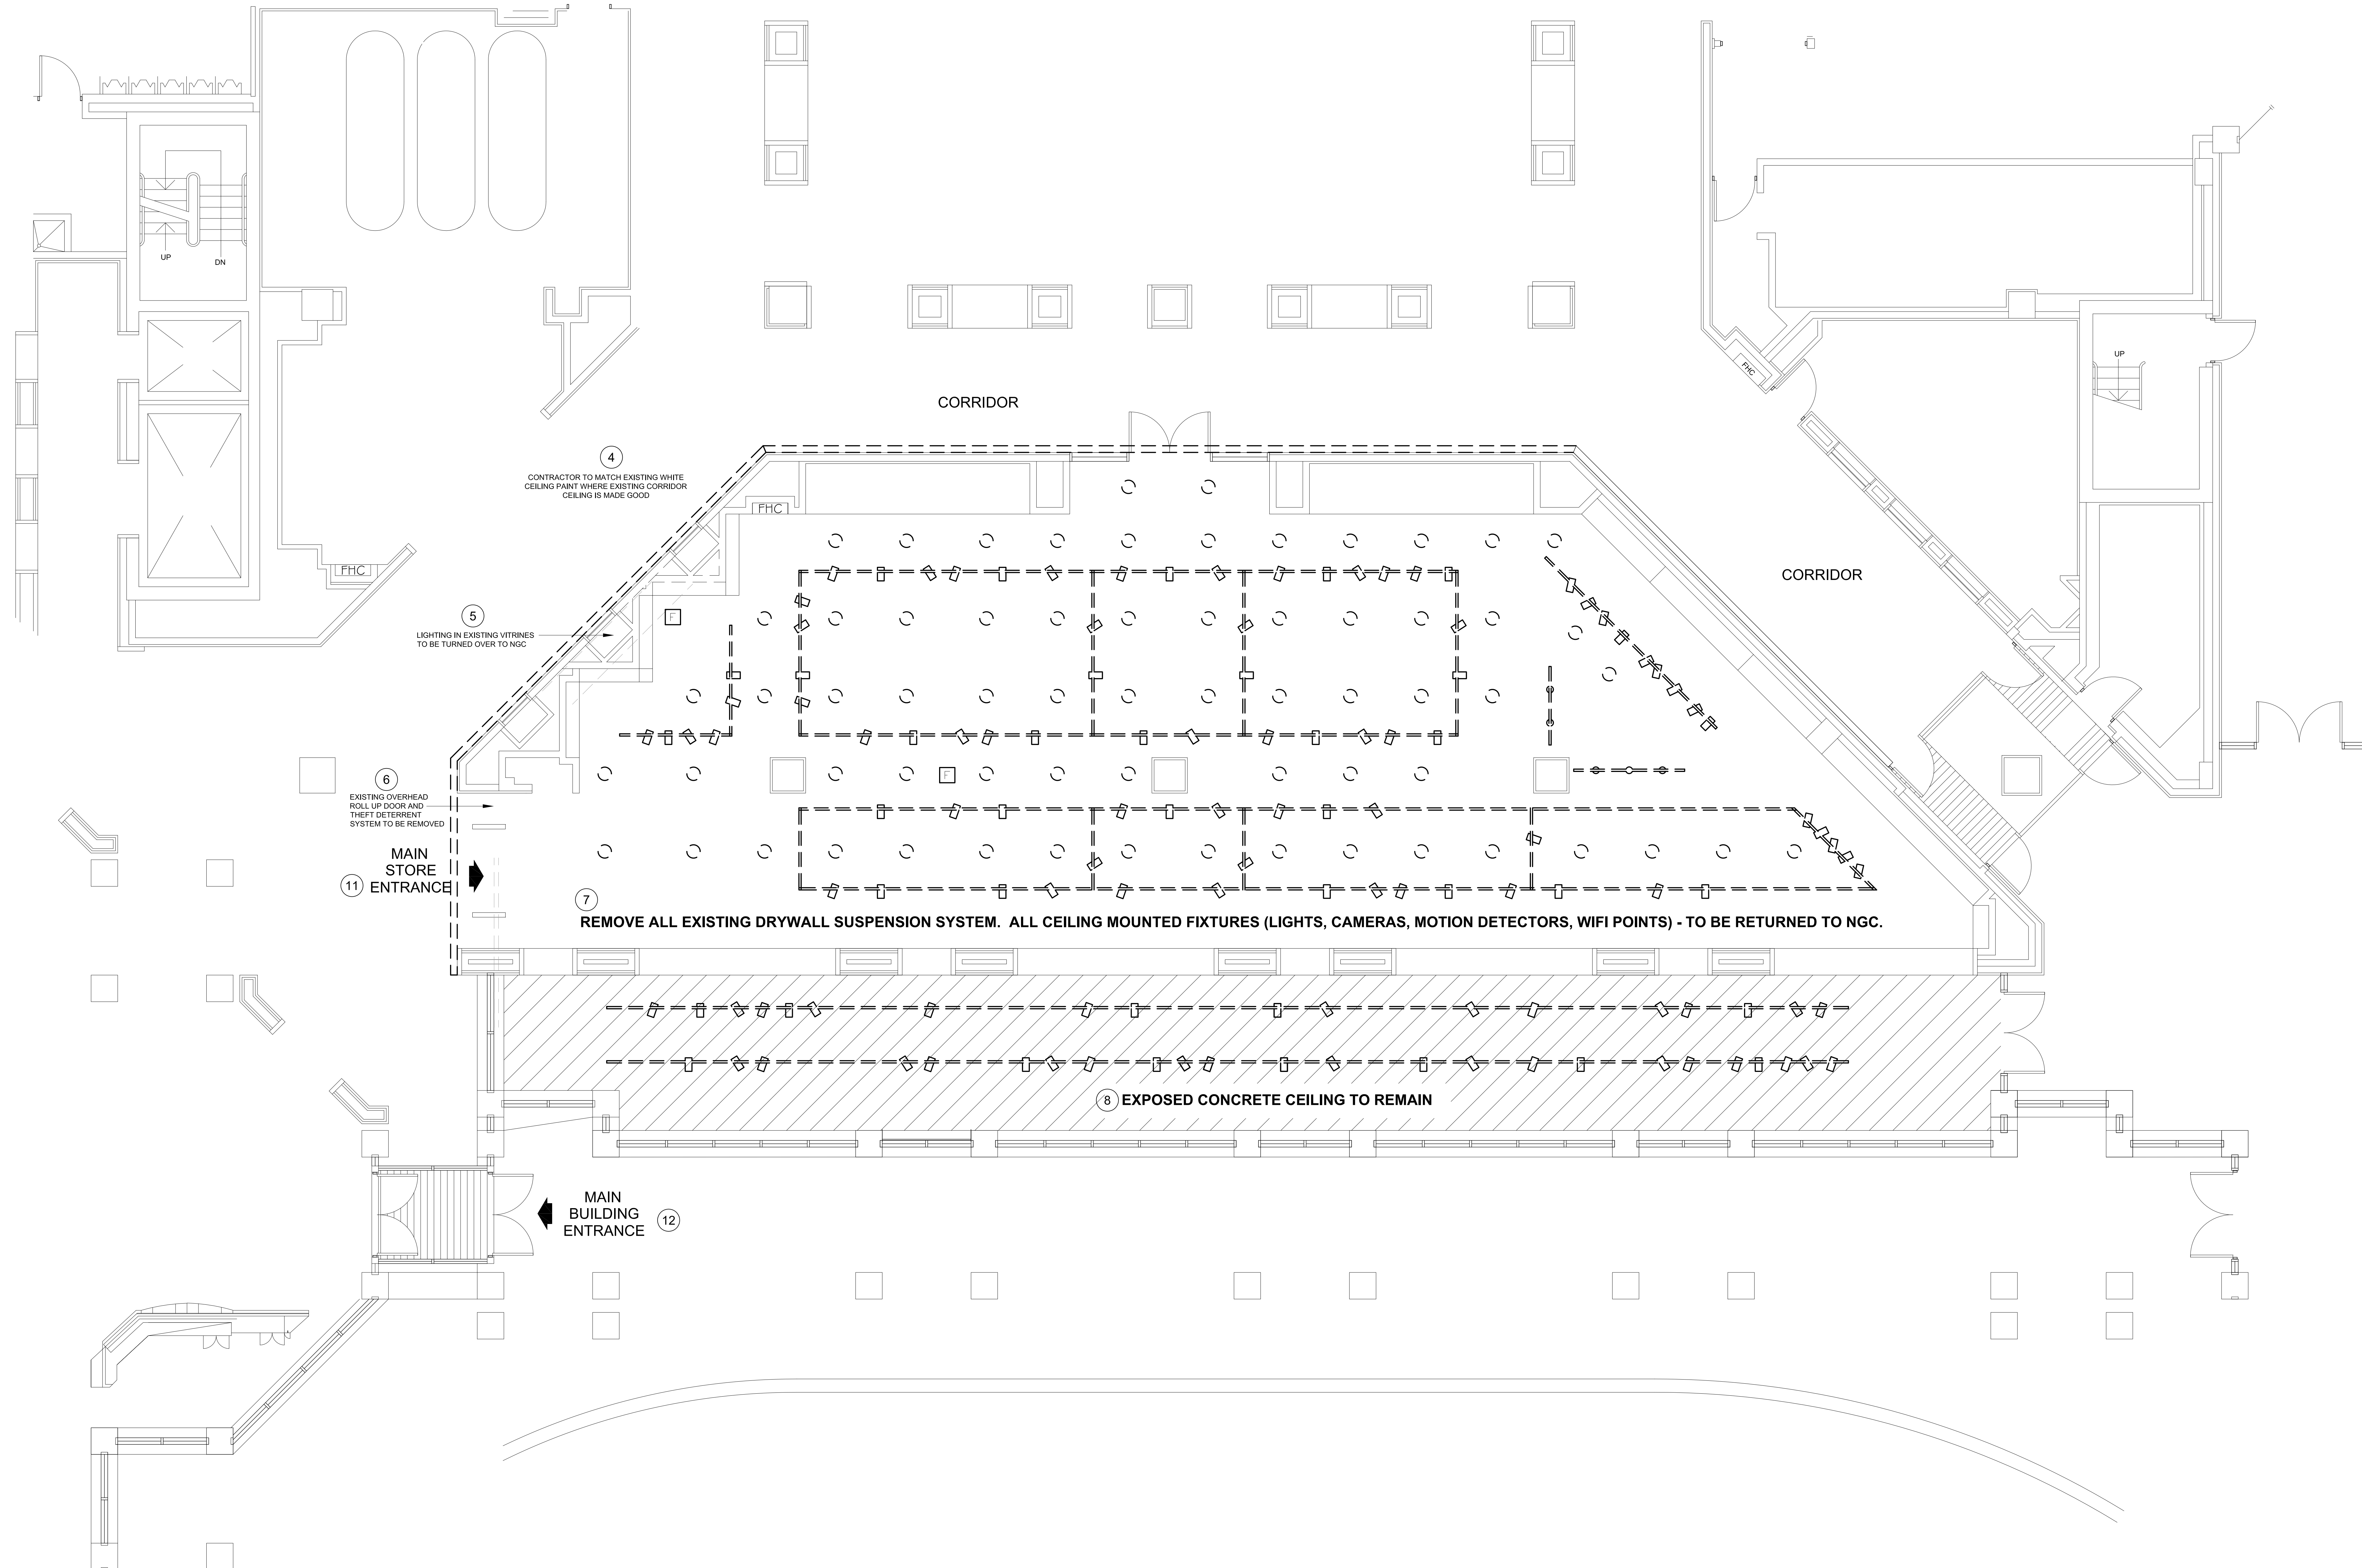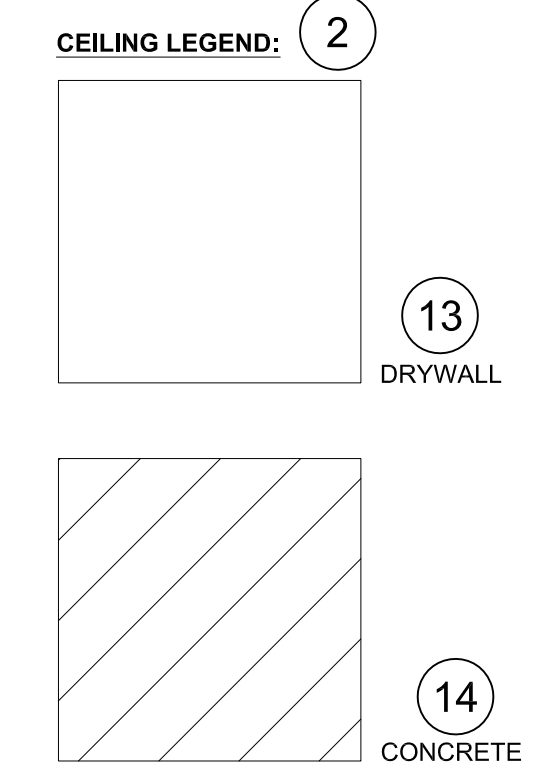

REV	DATE	DESCRIPTION	BY
-	SEPT 10 2015	ISSUED FOR TENDER	-

3 Commercial Street
 London EC1M 6DR UK
 T +44(0)20 3384 1400


CLIENT NATIONAL GALLERY OF CANADA
 PROJECT NEW RETAIL STORE
 ORG REFLECTED CEILING PLAN DEMOLITION 3
 DRG No: A-04 REV -
 SCALE 1:50 @ A0 DATE SEP 2015
 DRAWN BY CM
 SHEET NO. A-04

SCALE 1:50


NEWLY PROPOSED DRYWALL LAY-IN CEILING TO EXISTING SUSPENDED CEILING GRID
NEW CEILING SHOULD BE PAINTED OUT BRIGHT WHITE

ALL RECESSED LIGHTING TRACKS TO BE PAINTED BLACK ON INTERIOR

DETAIL 1
SCALE 1:5

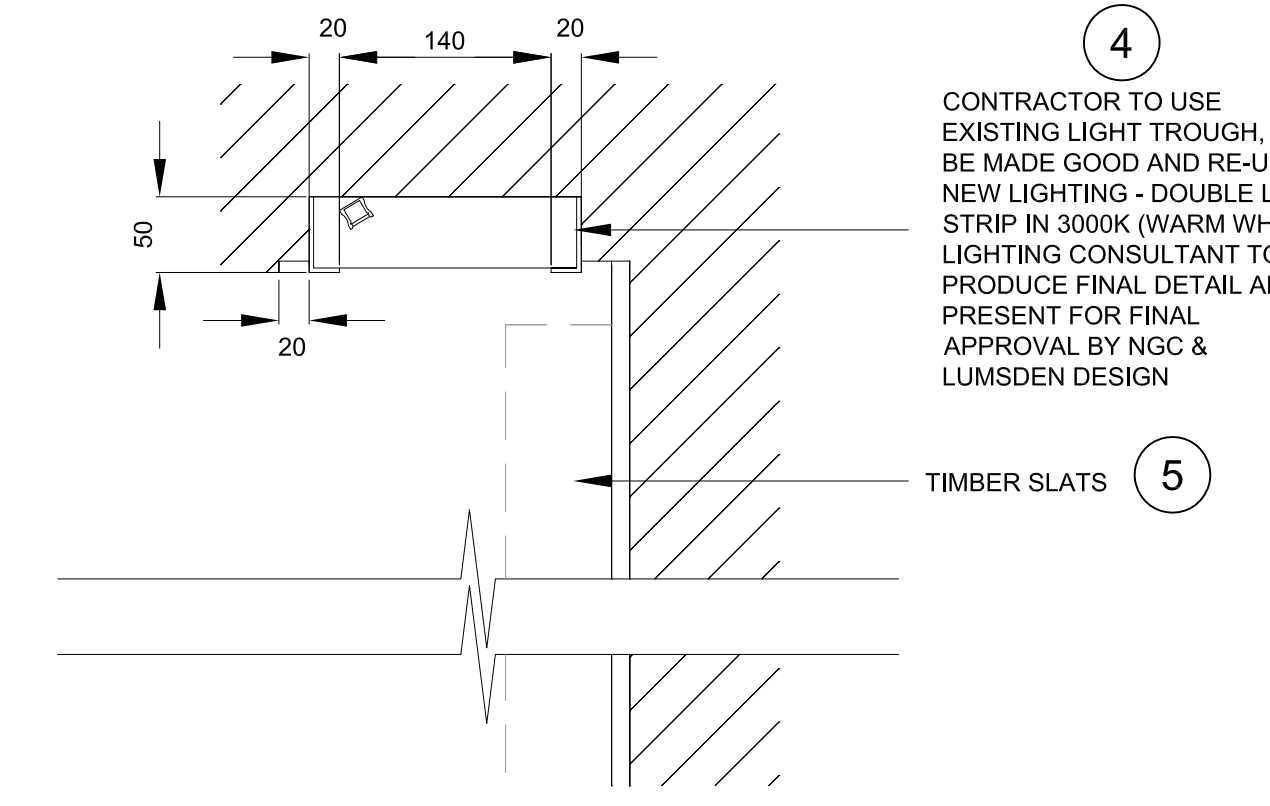

DETAIL 2
SCALE 1:5

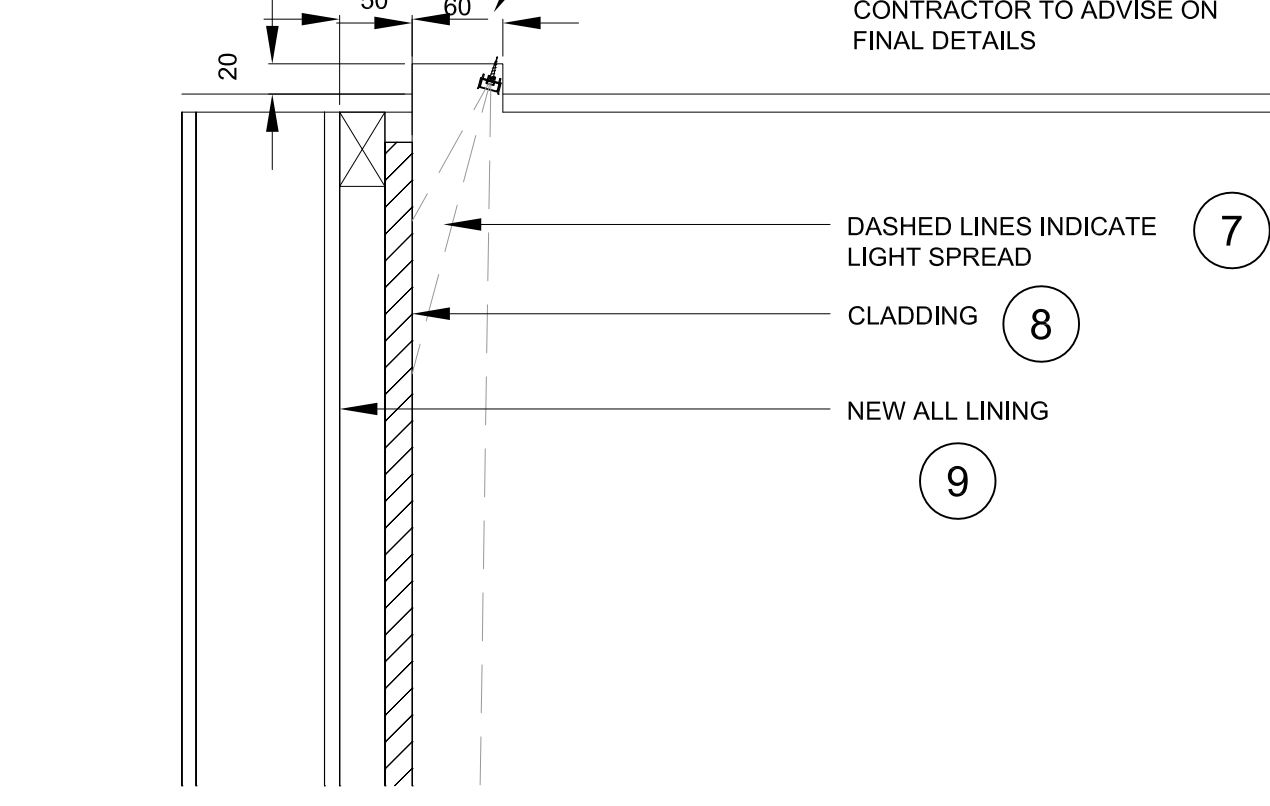


NOTES
DO NOT SCALE FROM DRAWING
ALL DIMENSIONS TO BE SITE VERIFIED BY CONTRACTOR
PRIOR TO MANUFACTURING OR CONSTRUCTION.
CONTRACTOR TO REPORT ANY DISCREPANCIES TO NGC
IMMEDIATELY.
CONTRACTOR TO PROVIDE SHOP DRAWINGS OF ALL
CUSTOM COMPONENTS FOR APPROVAL BY NGC PRIOR
TO MANUFACTURING.
THE DRAWING AND THE WORKS DEPICTED ARE THE
COPYRIGHT OF LUMSDEN DESIGN LTD AND MAY NOT BE
REPRODUCED EXCEPT BY WRITTEN PERMISSION.

MATERIALS LEGEND:

PLEASE NOTE:
CONTRACTOR TO PROVIDE SAMPLES
OF ALL MATERIALS FOR APPROVAL BY
NGC PRIOR TO CONSTRUCTION.

J4 SPRAY PAINTED MDF
DARK GREY BLACK
MATCH TO DULUX GORN 07/00
CLEAR LACQUER FINISH

36

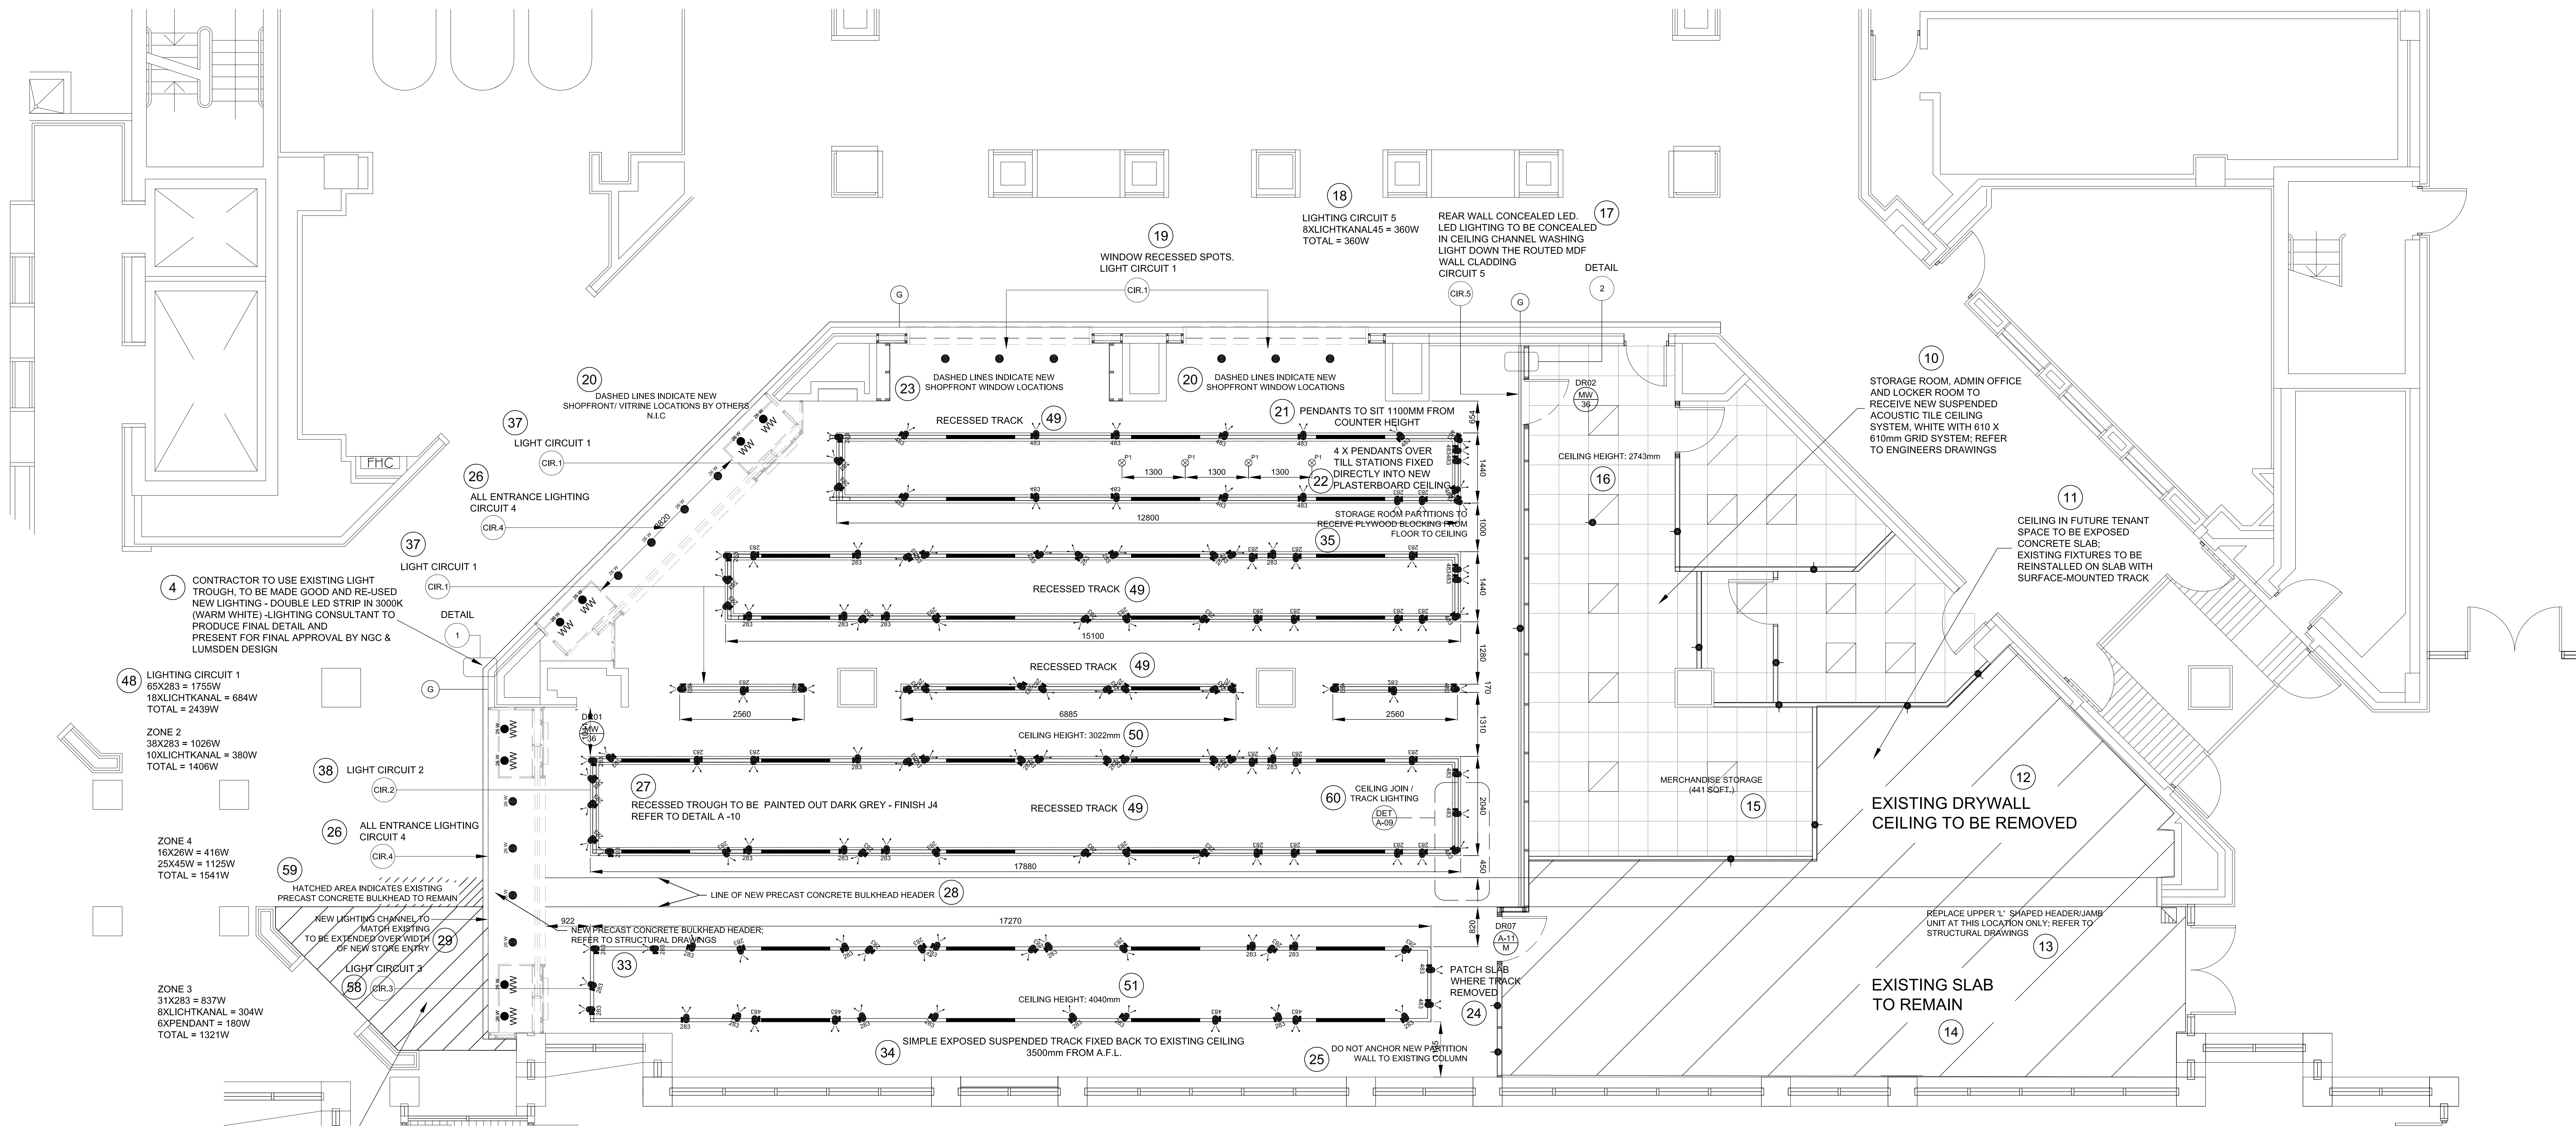

4 CONTRACTOR TO USE EXISTING LIGHT TROUGH, TO BE MADE GOOD AND RE-USED NEW LIGHTING - DOUBLE LED STRIP IN 3000K (WARM WHITE) - LIGHTING CONSULTANT TO PRODUCE FINAL DETAIL AND PRESENT FOR FINAL APPROVAL BY NGC & LUMSDEN DESIGN

48 LIGHTING CIRCUIT 1
65X283 = 1755W
18XLICHTKANAL = 694W
TOTAL = 2439W

ZONE 2
38X283 = 1026W
10XLICHTKANAL = 380W
TOTAL = 1406W

ZONE 4
16X26W = 416W
25X45W = 1125W
TOTAL = 1541W

59 HATCHED AREA INDICATES EXISTING PRECAST CONCRETE BULKHEAD TO REMAIN

NEW LIGHTING CHANNEL TO MATCH EXISTING TO BE EXTENDED OVER WIDTH OF NEW STORE ENTRY

ZONE 3
31X283 = 837W
8XLICHTKANAL = 304W
6XPENDANT = 180W
TOTAL = 1321W

30 HATCHED SECTION HIGHLIGHTS AREA FOR NEW DRYWALL CEILING WITH NEW LIGHTING CHANNEL, TO EXTEND FROM EXISTING CHANNEL

31 EXISTING RECESSED LIGHTING AND CEILING-MOUNTED SERVICES TO BE REINSTALLED IN NEW DRYWALL CEILING.

32 CEILING AREA AROUND SHOPFRONT SHOULD BE PATCHED UP WITH WHITE PAINT TO MATCH EXISTING.

A	Fagerhult Retail CSA 40 Downlight LED 2305lm 29W 3000K Hole opening: 105 mm - Recessed: 105 mm Colour: White, Art.No. CSALP 40.2030.50	D	Fagerhult Retail LichtKanal Channel With track Inserts and Blanking plates	G	Fagerhult Retail LichtKanal 45 Length: ...mm - Height: 60 mm - Width: 45 mm
B	Fagerhult Retail BIXX LED Spotlight LED 27W 2175lm 830 Flood Colour: White, Art.No. BIXX 102.30.50.2	E	Fagerhult Retail Global Track 3-Circuit Recessed Length: 4000 mm - Height: 32.5 mm - Width: 56 mm Colour: White, Art.no. 78626	H	Fagerhult Retail suspended track Specification TBC
C	Fagerhult Retail LichtKanal LED	F	Fagerhult Retail Topas Wallwasher LED Wallwasher LED 26W 1600lm 830 Asymmetric Colour: White, Art.No. TPSW 183.20.30	I	Fagerhult Retail Recessed BIXX LED Recessed Spotlight LED 36W 2680lm 830 Flood Colour: White, Art.No. BIXX 153.30.50

REV	DATE	DESCRIPTION	BY
-	SEPT 10 2015	ISSUED FOR TENDER	-


SCALE 1:50 25

GENERAL CONTRACTOR TO CHALK OUT CORE DRILL LOCATIONS FOR FINAL NGC APPROVAL 2
 (FLOOR BOXES/FLOOR MONUMENTS).

ELECTRICAL LEGEND 3

SYMBOL	DESCRIPTION
4	DUPLEX RECEPTACLE
5	FLOOR MONUMENT - FLOOR MONUMENTS AT CASH DESK TO HAVE CONDUIT TERMINATED AT FLOOR LEVEL FOR WIRING OF POWER, TELEPHONE AND DATA (CABLING BY NGC) - FLOOR MONUMENTS BELOW SHELVING AND MIDFLOOR UNITS TO HAVE DUPLEX POWER RECEPTACLES
21	INDICATES WHERE FLOOR MONUMENT TO HAVE COMBINED POWER, TELEPHONE, DATA SOCKET
22	INDICATED POWER REQUIRED TO UNIT (HARDWIRED)
23	GENERAL CONTRACTOR TO PROVIDE CONDUIT AND RECEPTACLES; CABLING BY NGC

NOTES
 DO NOT SCALE FROM DRAWING
 ALL DIMENSIONS TO BE SITE VERIFIED BY CONTRACTOR PRIOR TO MANUFACTURING OR CONSTRUCTION. CONTRACTOR TO REPORT ANY DISCREPANCIES TO NGC IMMEDIATELY.
 CONTRACTOR TO PROVIDE SHOP DRAWINGS OF ALL CUSTOM COMPONENTS FOR APPROVAL BY NGC PRIOR TO MANUFACTURING.
 THE DRAWING AND THE WORKS DEPICTED ARE THE COPYRIGHT OF LUMSDEN DESIGN LTD AND MAY NOT BE REPRODUCED EXCEPT BY WRITTEN PERMISSION.

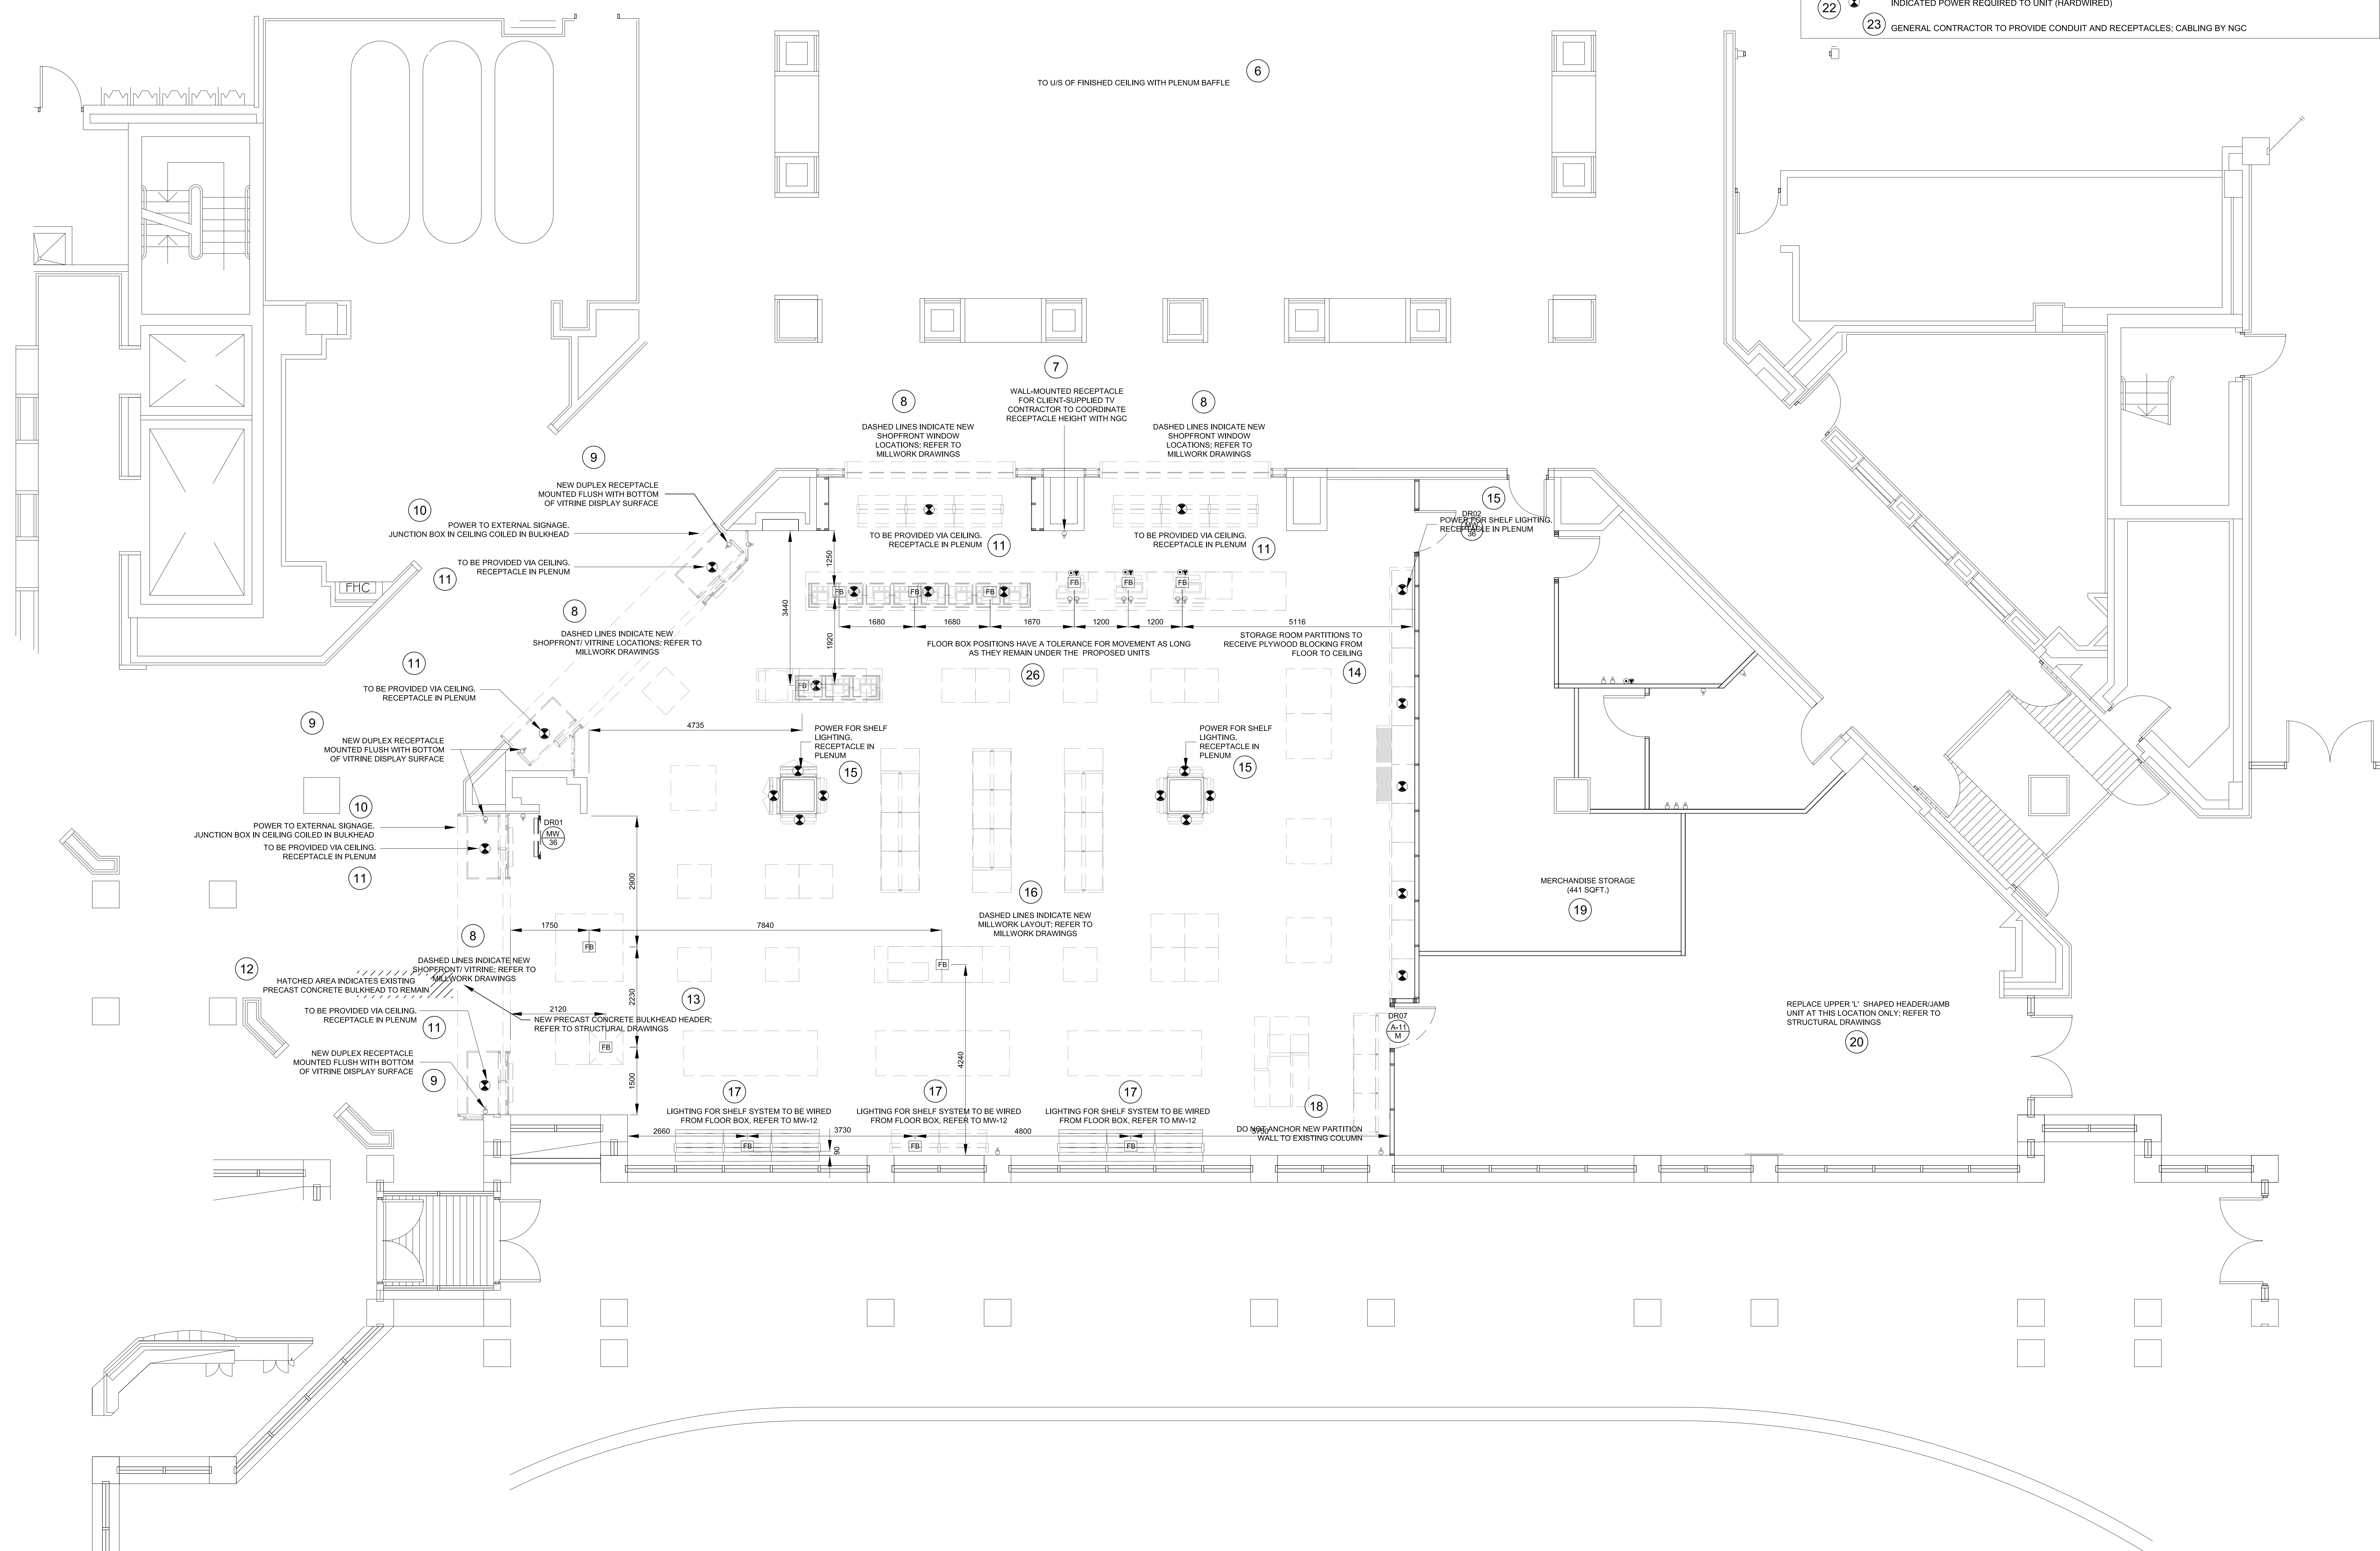


REV	DATE	DESCRIPTION	BY
-	SEPT 10 2015	ISSUED FOR TENDER	-


3 Commercial Street
 London EC1M 6DR UK
 T +44(0)20 3384 1400

CLIENT NATIONAL GALLERY OF CANADA
 PROJECT NEW RETAIL STORE
 DRG SMALL POWER PLAN 1


DRG No. A-06 REV -
 SCALE 1:50 @ A0 DATE JUN 2015
 DRAWN BY RJC
 SHEET NO. A-06

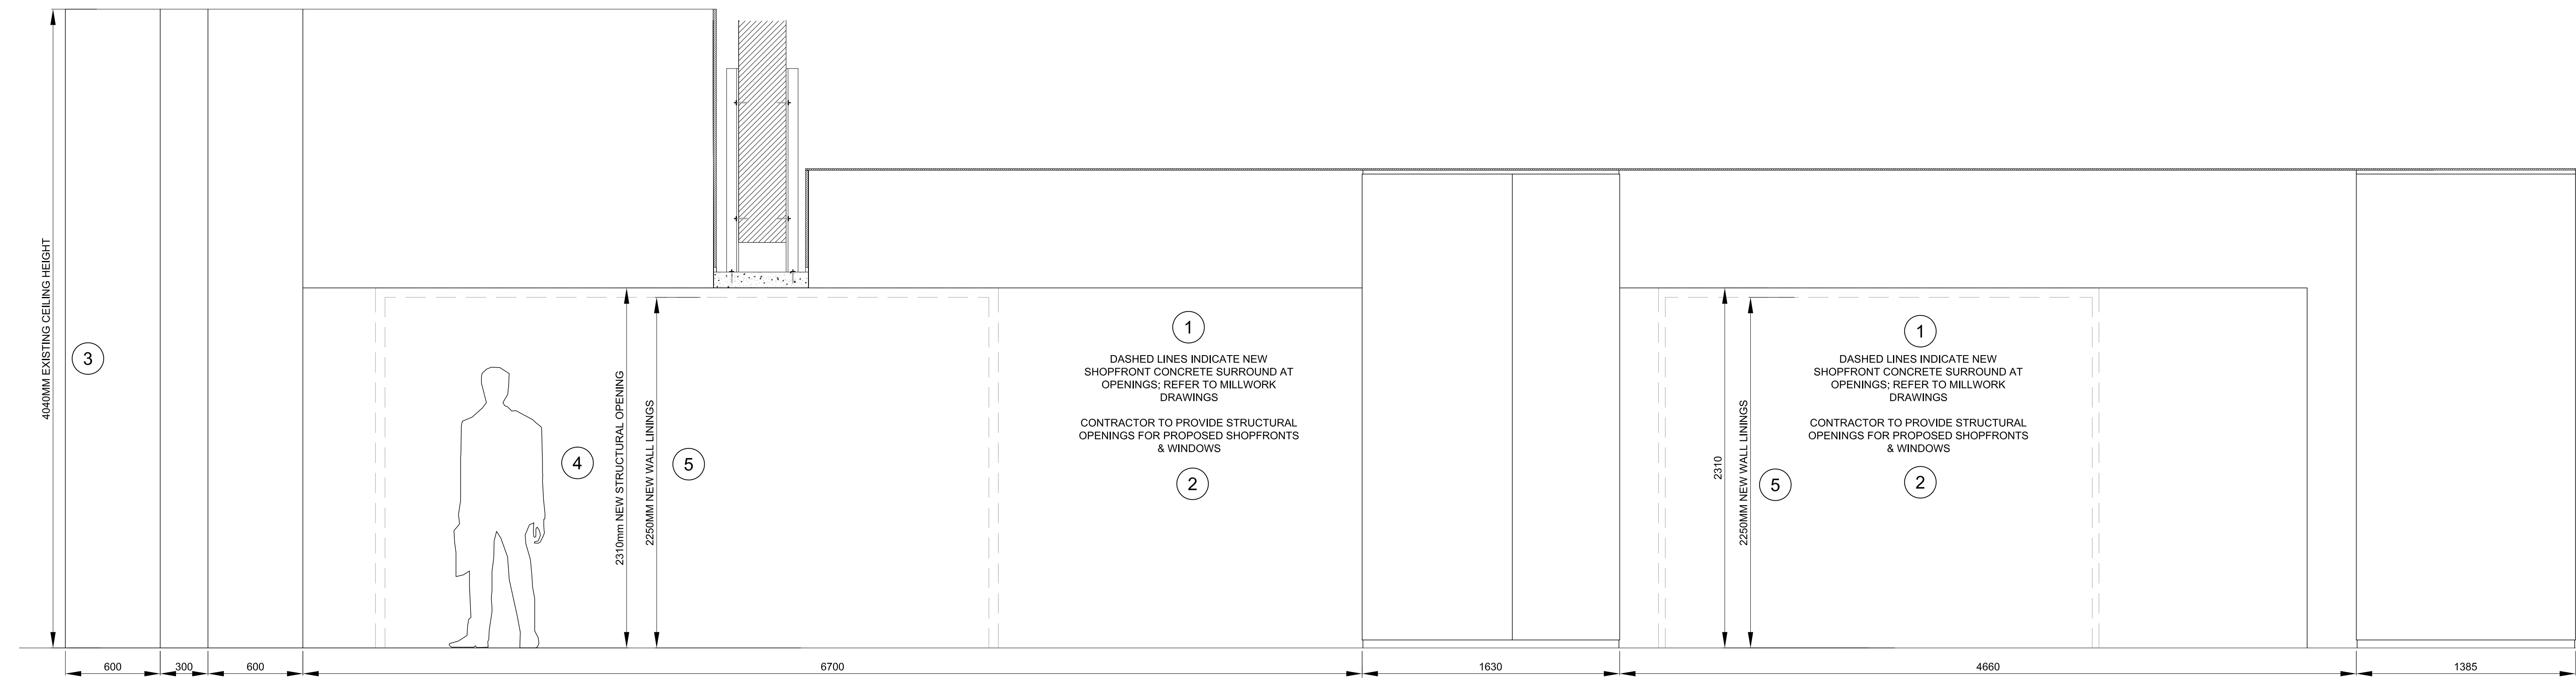

ELEVATION A

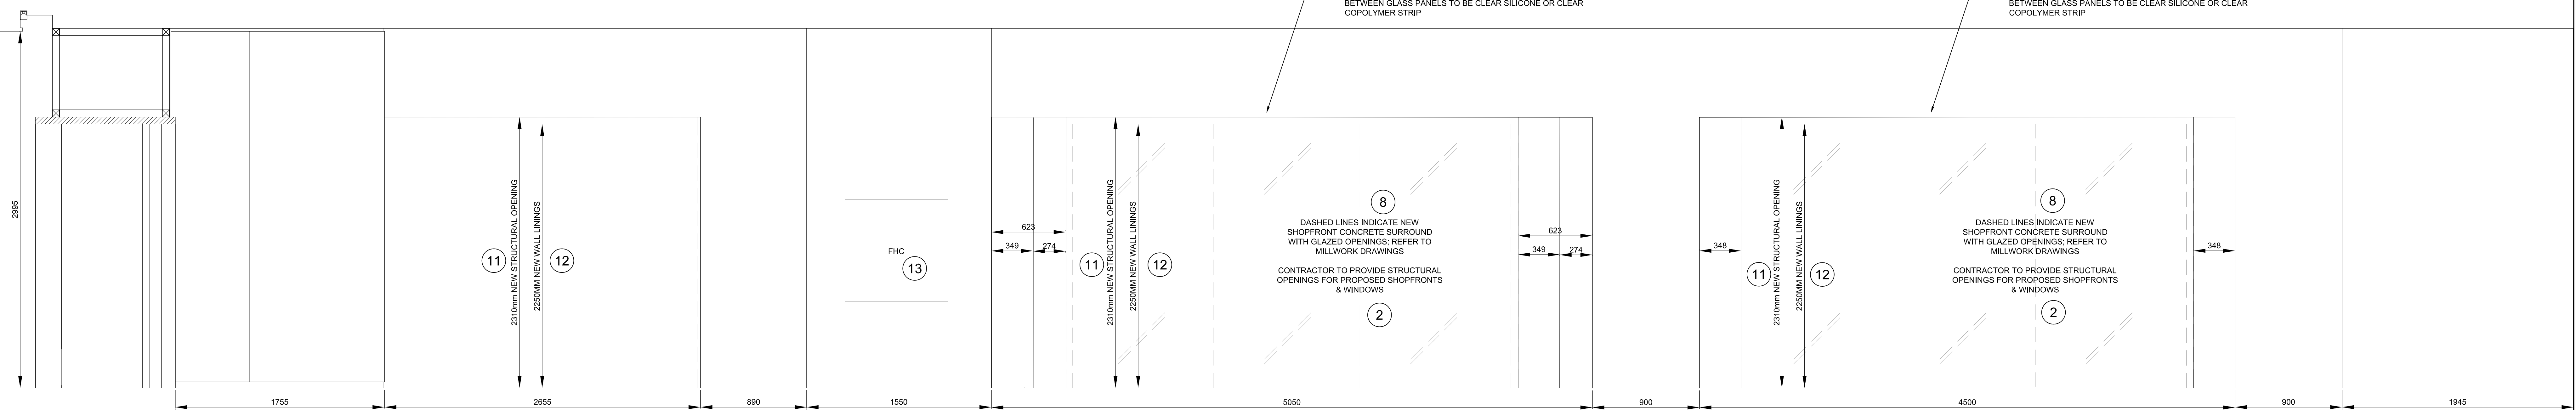

ELEVATION B

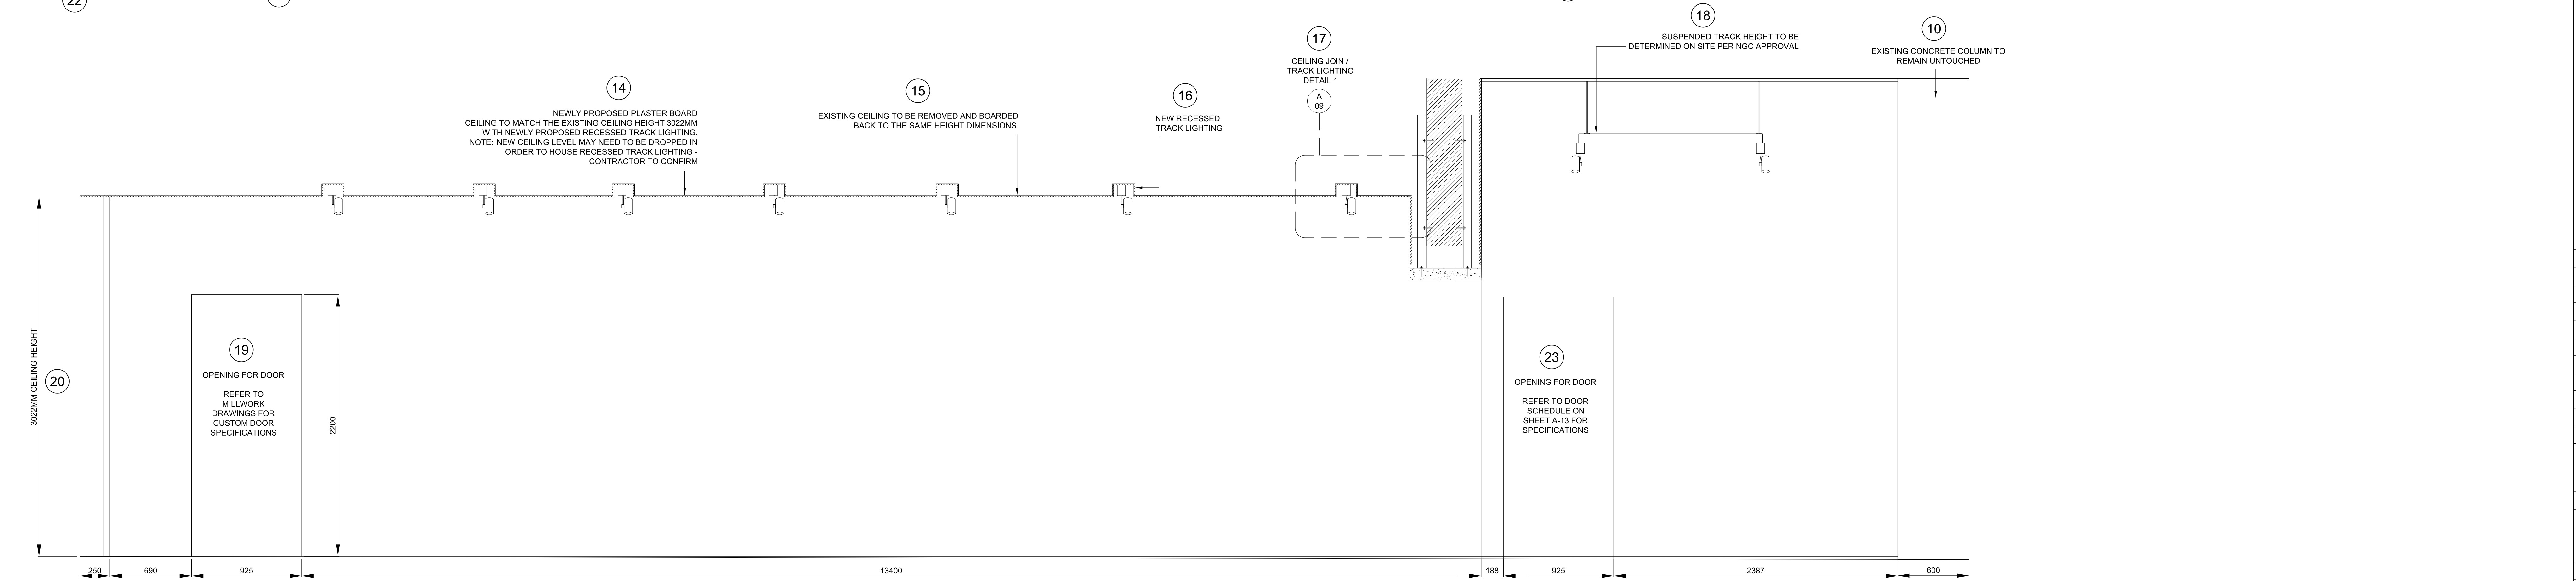

ELEVATION C


NOTES
DO NOT SCALE FROM DRAWING
ALL DIMENSIONS TO BE SITE VERIFIED BY CONTRACTOR PRIOR TO MANUFACTURE AND CONSTRUCTION. CONTRACTOR TO REPORT ANY DISCREPANCIES TO INCC IMMEDIATELY.
CONTRACTOR TO PROVIDE SHOP DRAWINGS OF ALL CUSTOM COMPONENTS FOR APPROVAL BY INCC PRIOR TO MANUFACTURE.
THE DRAWING AND THE WORKS DEPICTED ARE THE COPYRIGHT OF LUSSEN DESIGN LTD AND MAY NOT BE REPRODUCED EXCEPT BY WRITTEN PERMISSION.

MATERIALS LEGEND:

- PLEASE NOTE: CONTRACTOR TO PROVIDE SAMPLES OF ALL MATERIALS FOR APPROVAL BY INCC PRIOR TO CONSTRUCTION.
- METALWORK FINISHES
- M1 POWDER COAT RAL 7010 - TARPAULIN GREY SEMI-MATT FINISH 25%
 - M2 POWDER COAT RAL 9002 - GREY / WHITE SEMI-MATT FINISH 25%
 - M3 POWDER COAT RAL 3031 - ORIENT RED SEMI-MATT FINISH 25%
 - M4 BRUSHED STAINLESS STEEL
 - M5 POWDER COAT RAL 7038 - AGATE GREY SEMI-MATT FINISH 25%
 - M6 BLACK SMOCKED METAL
- JOINERY FINISHES
- J1 BLACK STAINED AMERICAN OAK MATCH TO SAMPLE
 - J2 WHITE STAINED CANADIAN MAPLE MATCH TO SAMPLE
 - J3 NATURAL FINISH AMERICAN OAK MATCH TO SAMPLE
 - J4 SPRAY PAINTED MDF DARK GREY BLACK MATCH TO DULUX 009N 0700 CLEAR LACQUER FINISH
 - J5 SPRAY PAINTED MDF - RED MATCH TO DULUX 09YR 11475 CLEAR LACQUER FINISH
 - J6 SPRAY PAINTED MDF - STONE MATCH TO DULUX 20Y 57060 CLEAR LACQUER FINISH
 - J7 SPRAY PAINTED SATIN WHITE
 - J8 DARK PAINT FINISH TO MATCH EXISTING
- LAMINATE FINISHES
- L1 DARK GREY POLYREY - FA-P114 POWRE
- OTHER FINISHES
- C1 VALCHROMAT COLOURED MDF - MID GREY 2-PACK CLEAR LACQUER FINISH
 - C2 Quartz Surfaces Zodiak® Dove Grey www.zodiak.com
 - S1 SILESTONE BLANCO NORTE / WHITE NORTE
 - U1 BUTE FABRIC - LEWIS 2825 PRODUCT CODE: CF840-2825 100% PURE WOOL
- WALL FINISHES
- W1 HONED CONCRETE EFFECT SKIM WALL RENDER MATCH TO RAL 7044 SILK GREY
 - W2 HONED CONCRETE EFFECT SKIM WALL RENDER MATCH TO RAL 7030 STONE GREY

REV	DATE	DESCRIPTION	BY
-	SEPT 10 2015	ISSUED FOR TENDER	-

CLIENT	NATIONAL GALLERY OF CANADA
PROJECT	NEW RETAIL STORE
ORG	INTERIOR ELEVATIONS 6
DRG No.	A-08
SCALE	1:20 @ A0
DATE	AUG 2015
DRAWN BY	CM
SHEET NO.	A-08

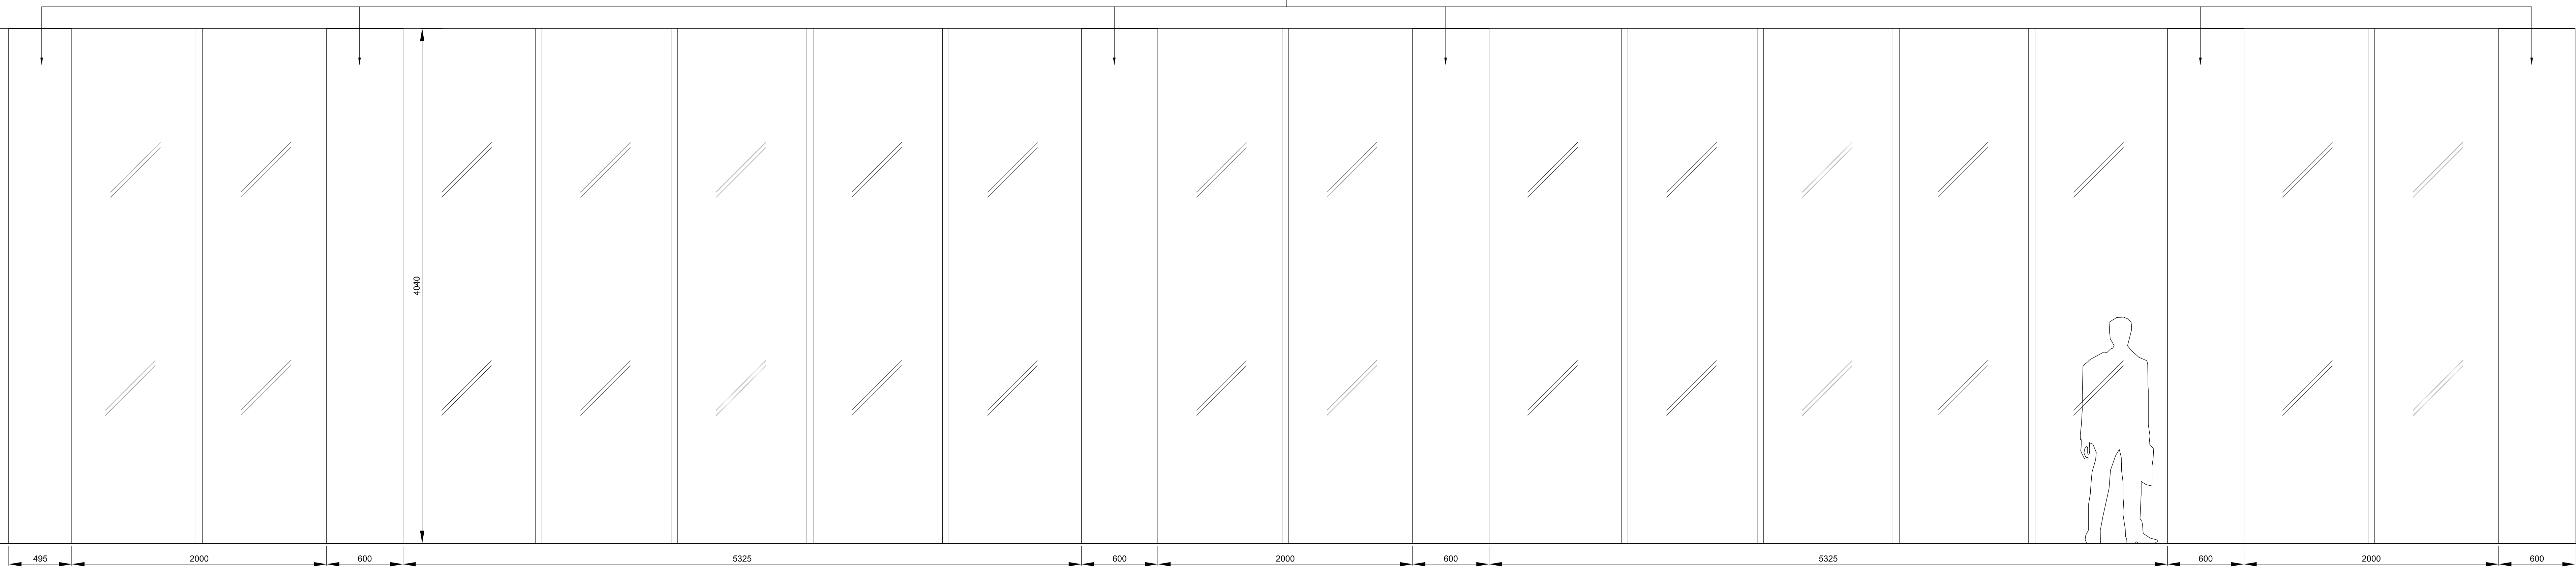


ELEVATION D



SECTION EE

TYPICAL CEILING / TRACK LIGHTING
DETAIL 1

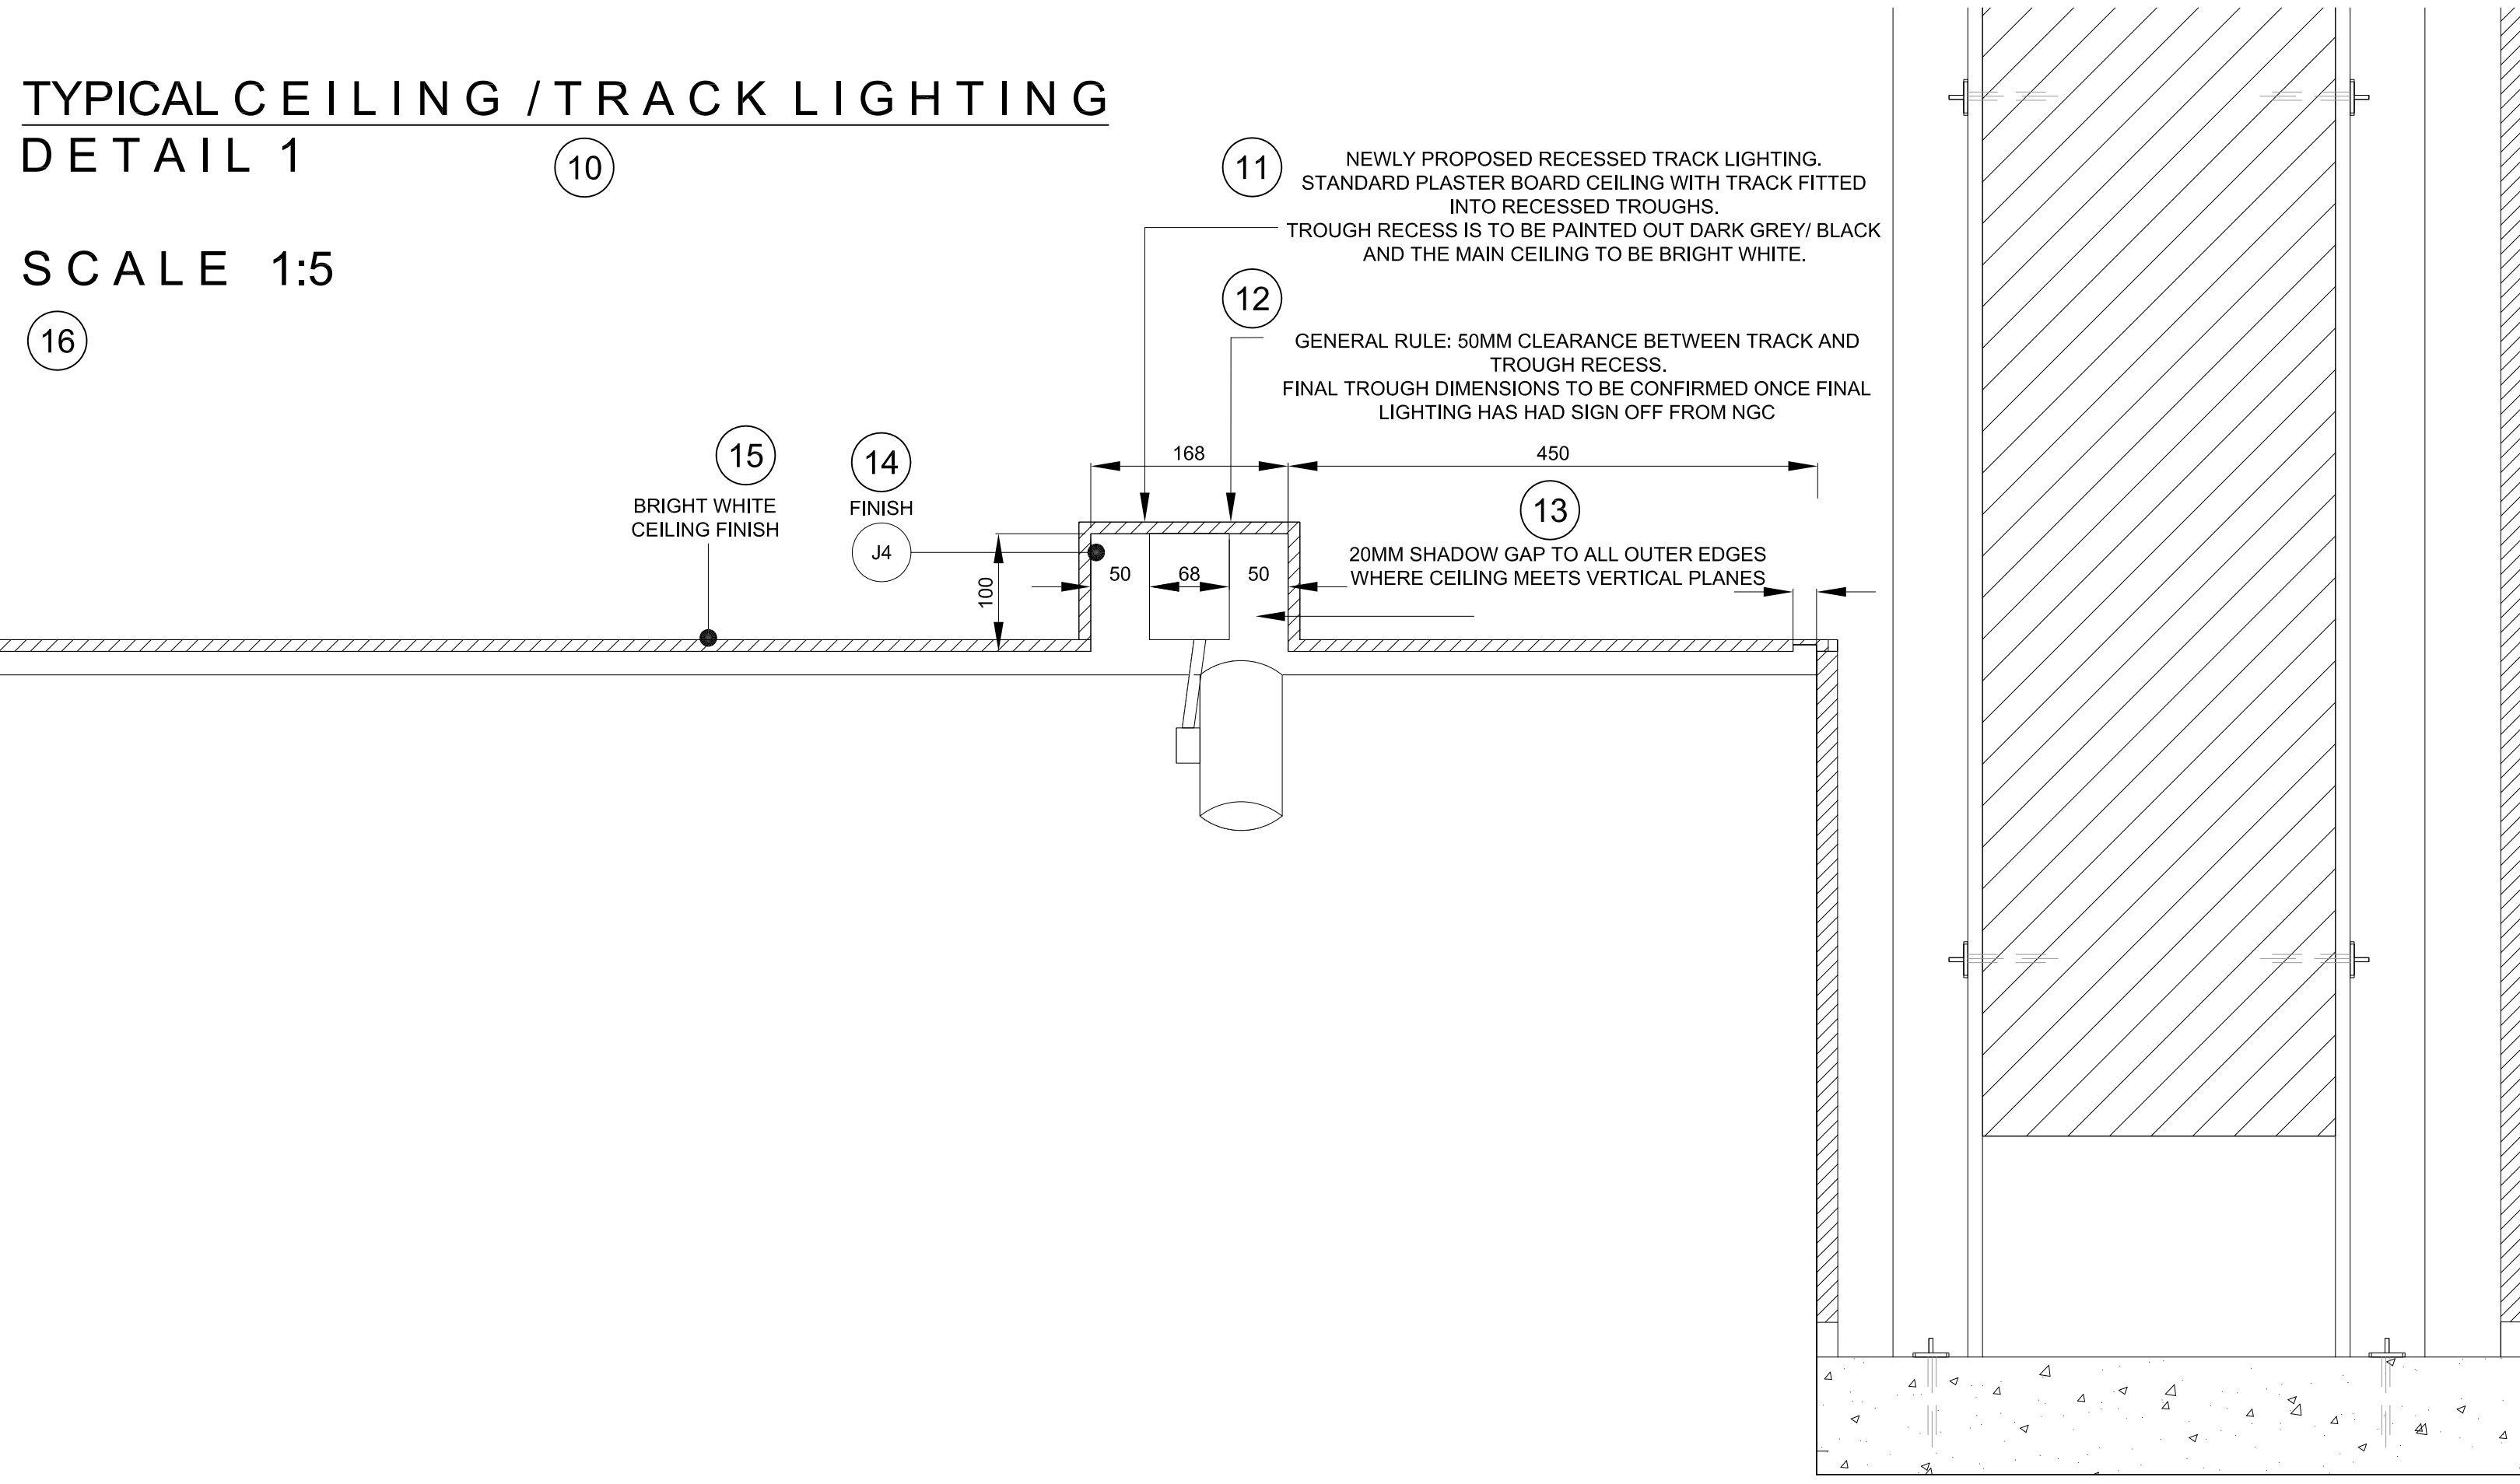


NOTES
DO NOT SCALE FROM DRAWING
ALL DIMENSIONS TO BE SITE VERIFIED BY CONTRACTOR PRIOR TO MANUFACTURE OR CONSTRUCTION. CONTRACTOR TO REPORT ANY DISCREPANCIES TO NGC IMMEDIATELY.
CONTRACTOR TO PROVIDE SHOP DRAWINGS OF ALL CUSTOM COMPONENTS FOR APPROVAL BY NGC PRIOR TO MANUFACTURE.
THE DRAWING AND THE WORKS DEPICTED ARE THE COPYRIGHT OF LUMSDEN DESIGN LTD AND MAY NOT BE REPRODUCED EXCEPT BY WRITTEN PERMISSION.

MATERIALS LEGEND:

- PLEASE NOTE: CONTRACTOR TO PROVIDE SAMPLES OF ALL MATERIALS FOR APPROVAL BY NGC PRIOR TO CONSTRUCTION.
- METAL WORK FINISHES
- M1 POWDER COAT RAL 7010 - TARPULIN GREY SEMI-MATT FINISH 25%
 - M2 POWDER COAT RAL 9002 - GREY / WHITE SEMI-MATT FINISH 25%
 - M3 POWDER COAT RAL 3031 - ORIENT RED SEMI-MATT FINISH 25%
 - M4 BRUSHED STAINLESS STEEL
 - M5 POWDER COAT RAL 7038 - AGATE GREY SEMI-MATT FINISH 25%
 - M6 BLACK SMOCKED METAL
- JOINERY FINISHES
- J1 BLACK STAINED AMERICAN OAK MATCH TO SAMPLE
 - J2 WHITE STAINED CANADIAN MAPLE MATCH TO SAMPLE
 - J3 NATURAL FINISH AMERICAN OAK MATCH TO SAMPLE
 - J4 SPRAY PAINTED MDF DARK GREY BLACK MATCH TO DULUX 00NN 0700 CLEAR LACQUER FINISH
 - J5 SPRAY PAINTED MDF - RED MATCH TO DULUX 09YR 11475 CLEAR LACQUER FINISH
 - J6 SPRAY PAINTED MDF - STONE MATCH TO DULUX 20Y 57060 CLEAR LACQUER FINISH
 - J7 SPRAY PAINTED SATIN WHITE
 - J8 DARK PAINT FINISH TO MATCH EXISTING
- LAMINATE FINISHES
- L1 DARK GREY POLYREY - FA-P114 POVRE
- OTHER FINISHES
- C1 VALCHROMAT COLOURED MDF - MID GREY 2-PACK CLEAR LACQUER FINISH
 - C2 Quartz Surfaces Zodia® Dove Grey www.dgspr.com
 - S1 SILESTONE BLANCO NORTE / WHITE NORTE
 - U1 BUTE FABRIC - LEWIS 2825 PRODUCT CODE: CF840-2825 100% PURE WOOL
- WALL FINISHES
- W1 HONED CONCRETE EFFECT SKIM WALL RENDER MATCH TO RAL 7044 SILK GREY
 - W2 HONED CONCRETE EFFECT SKIM WALL RENDER MATCH TO RAL 7030 STONE GREY


REV	DATE	DESCRIPTION	BY
-	SEPT 10 2015	ISSUED FOR TENDER	-

DR01 (ELECTRICAL CLOSET)

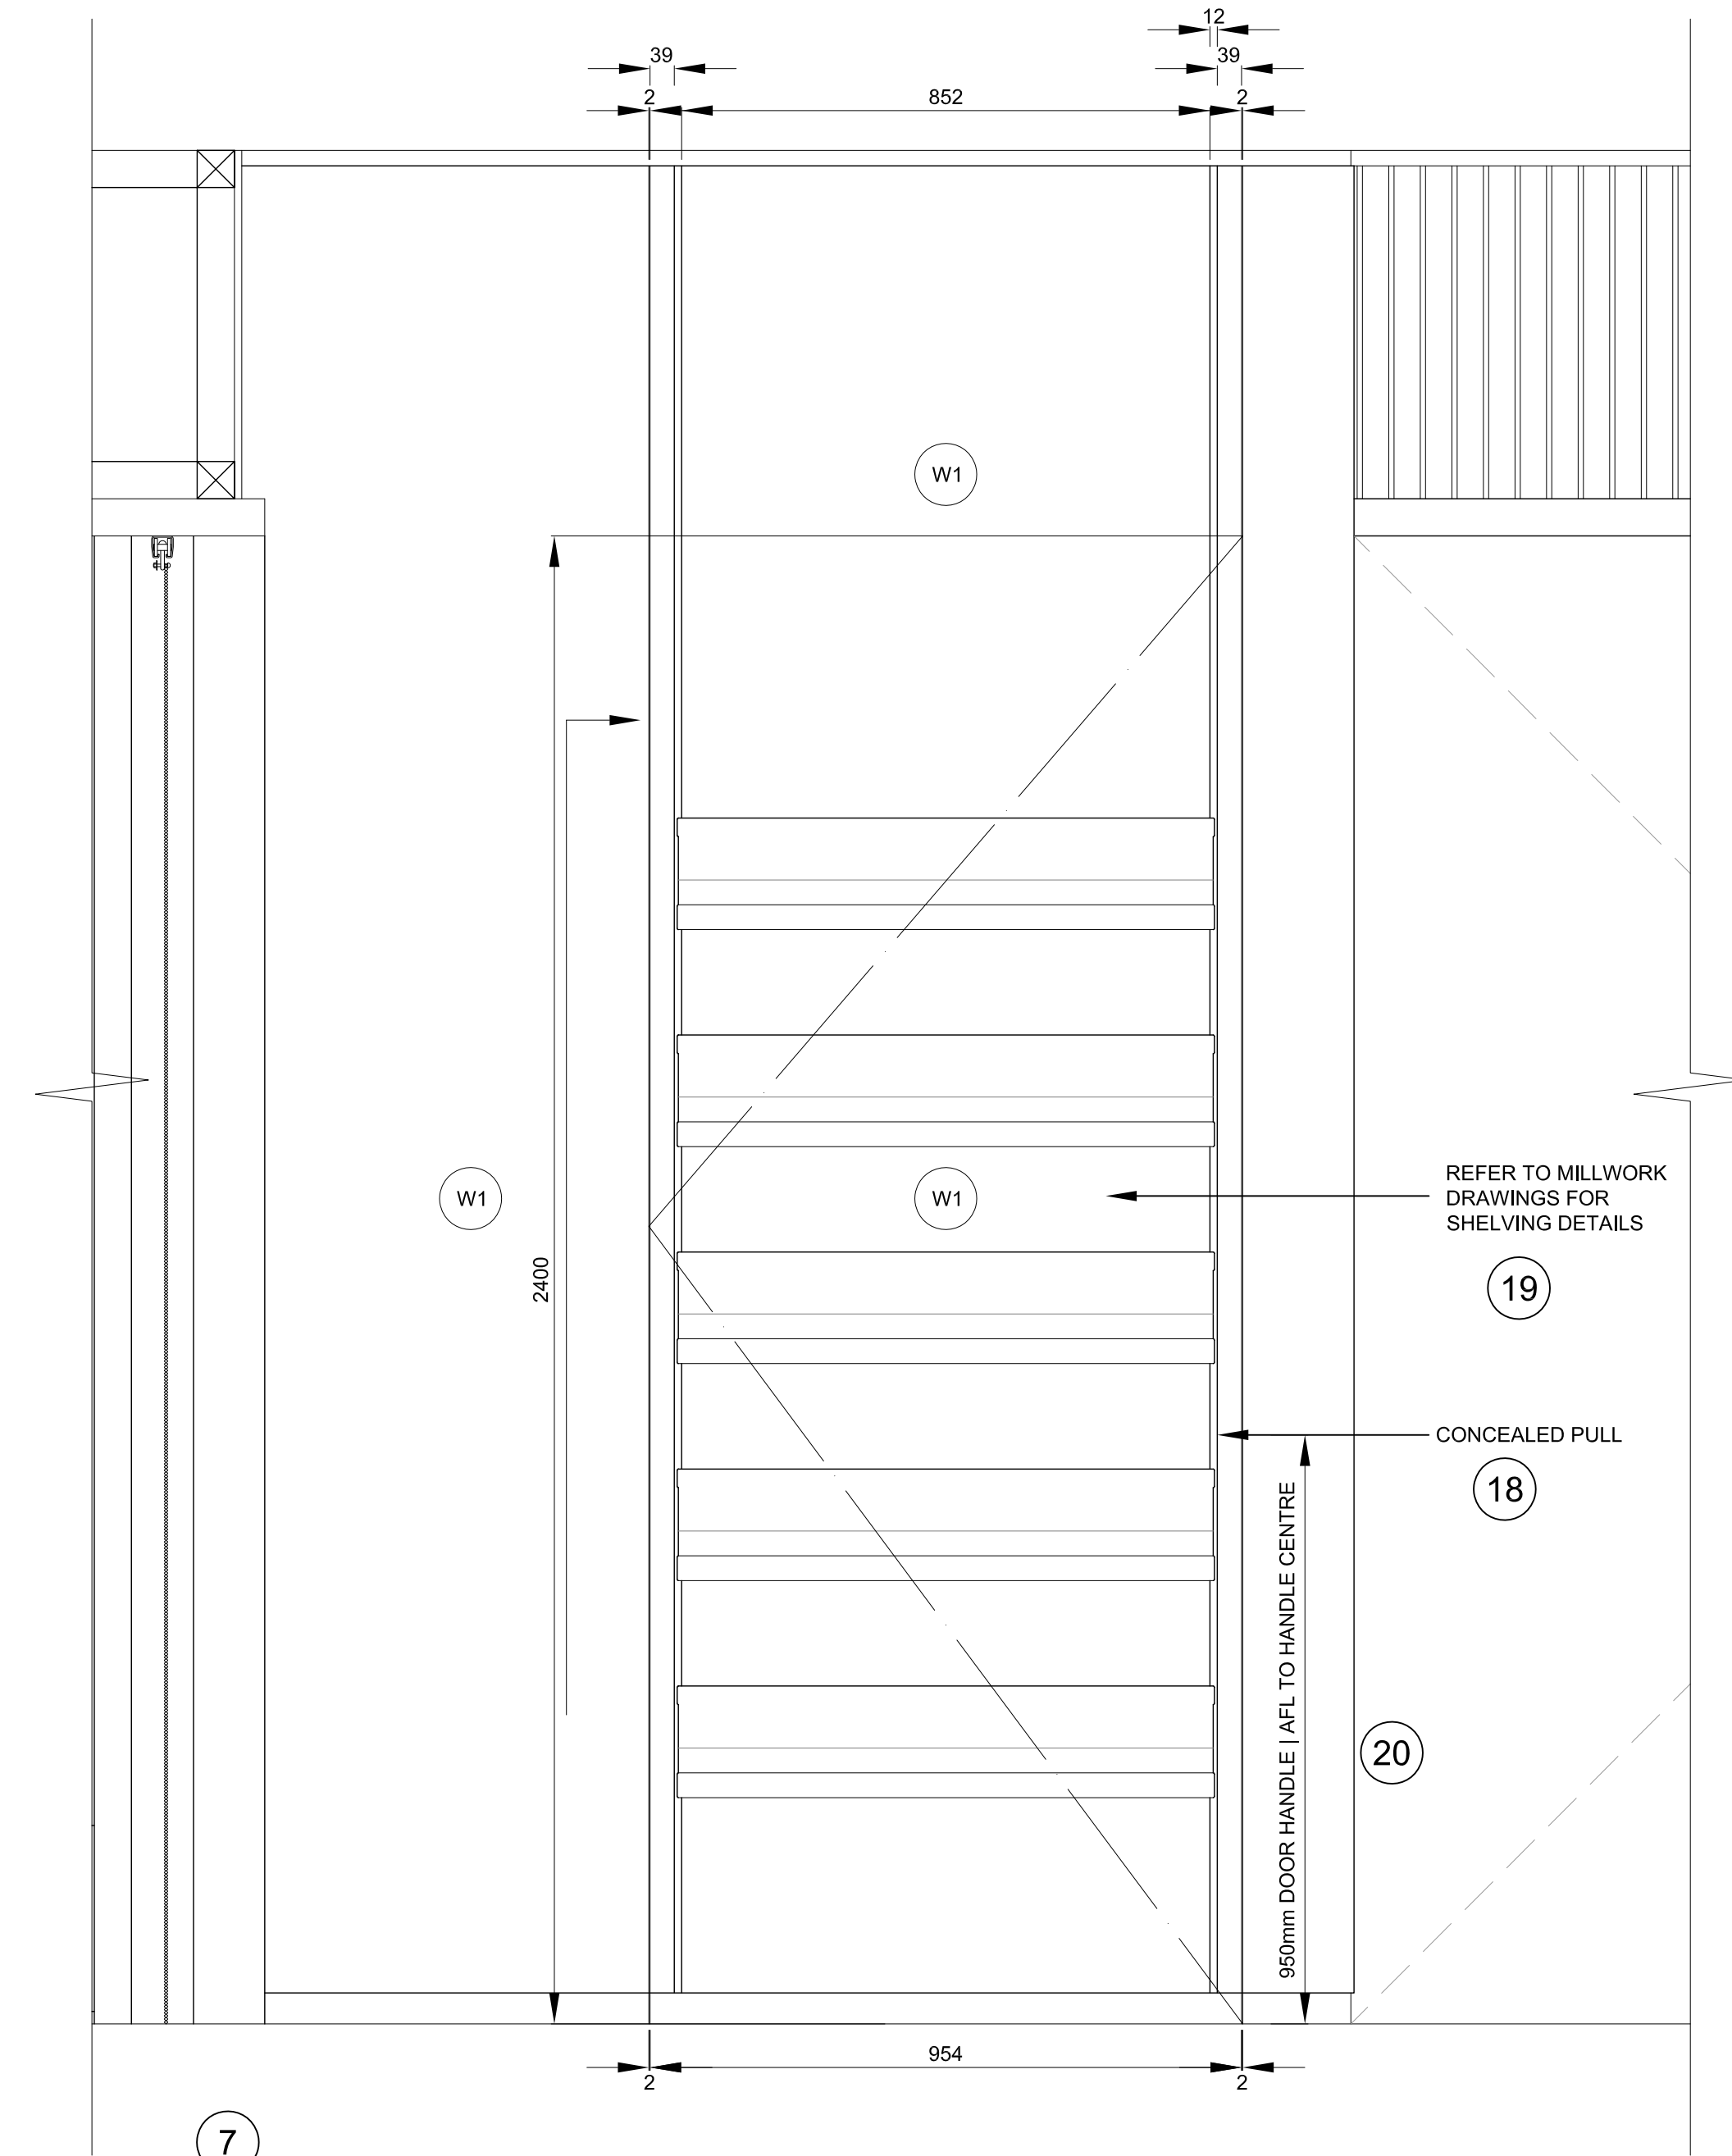

FRONT ELEVATION A


PLAN

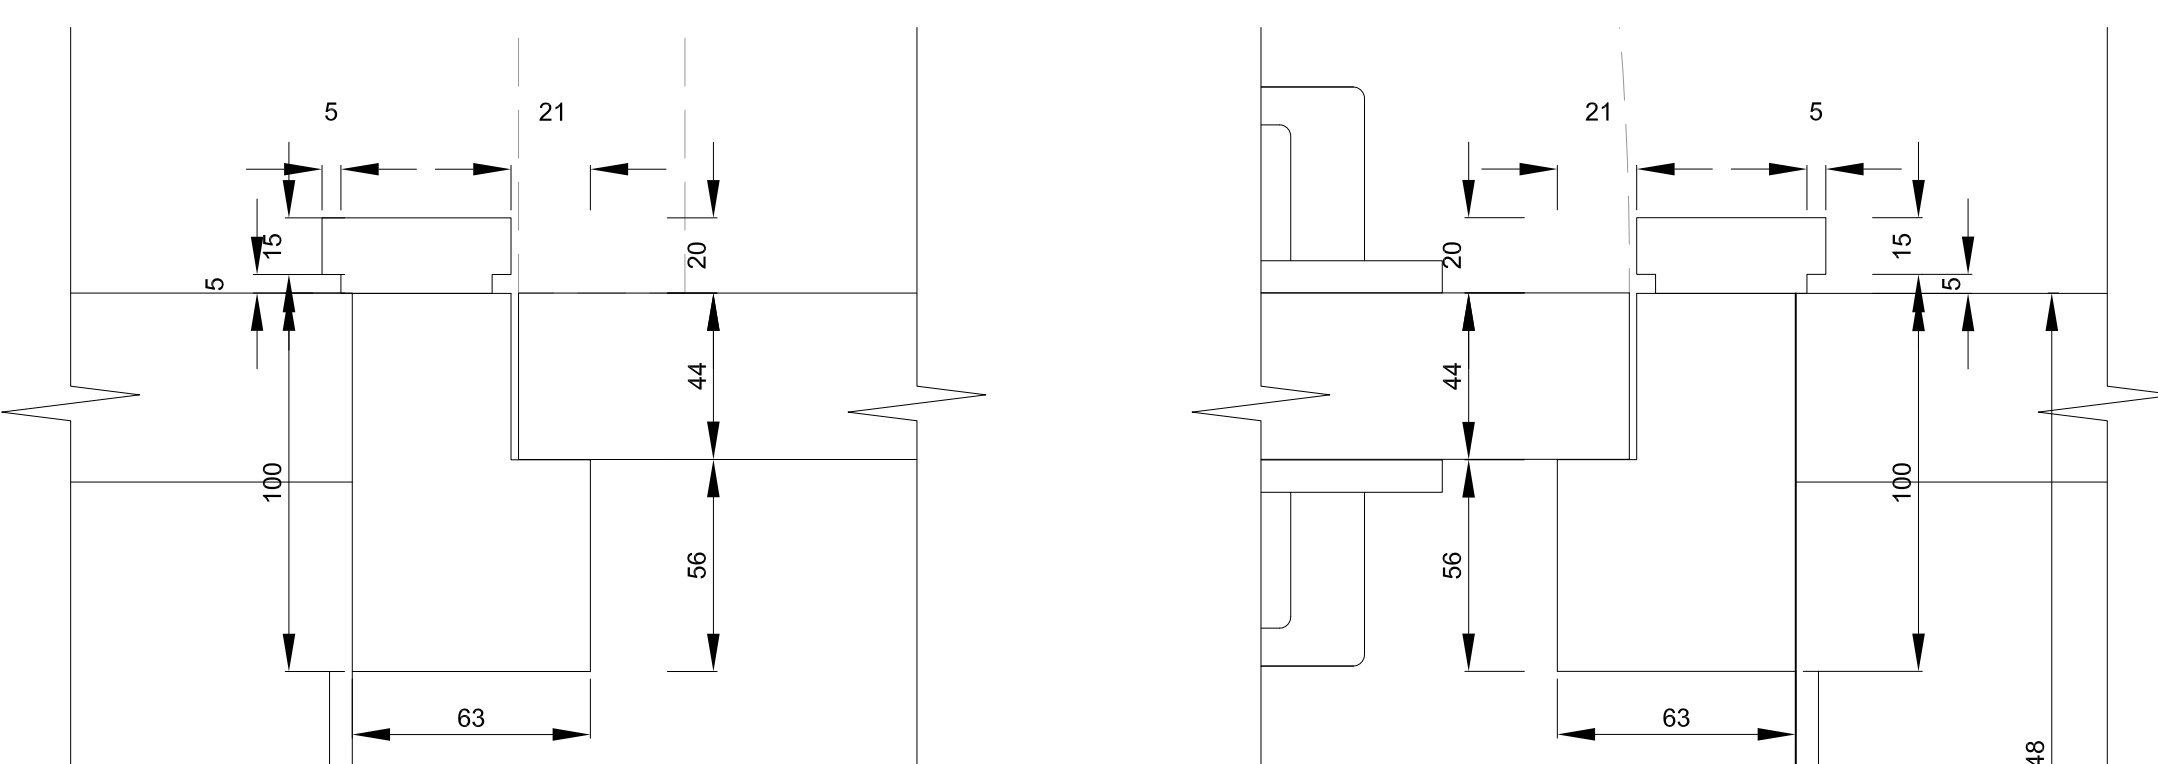

DETAIL 1
SCALE 1:2


DETAIL 2
SCALE 1:2

DR02 (BOUTIQUE TO STORAGE ROOM)

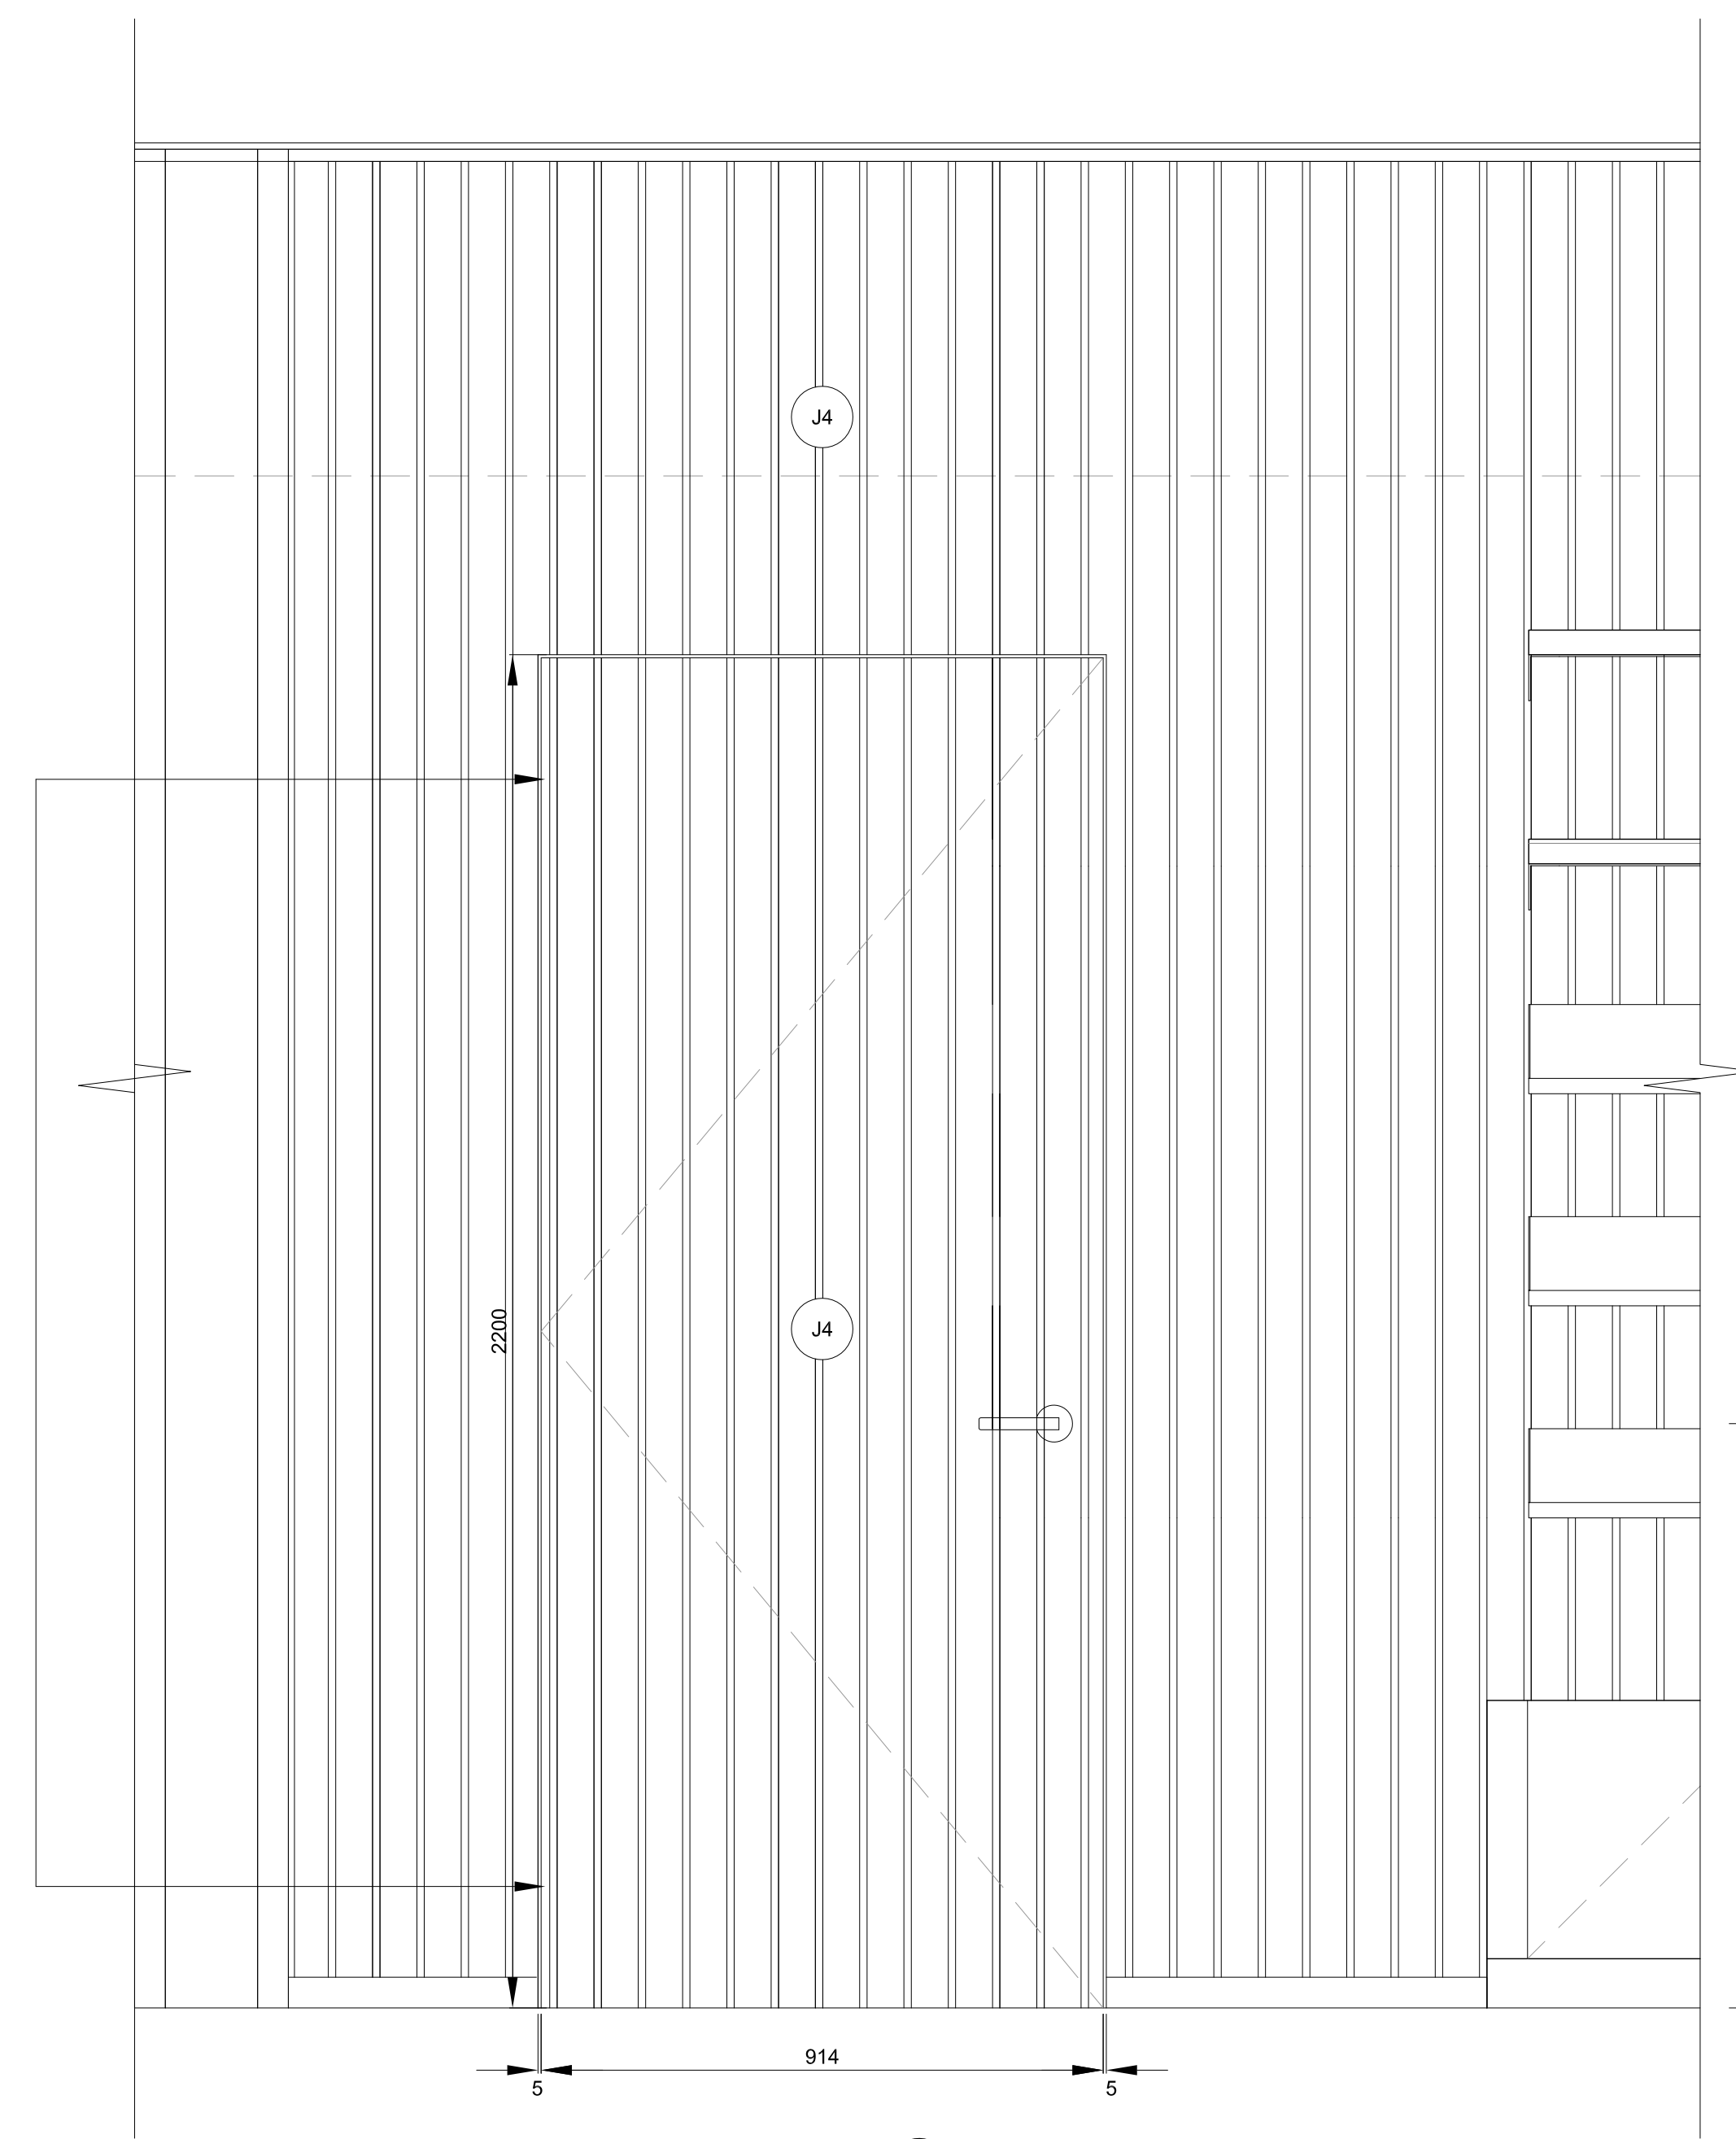


FRONT ELEVATION C

PLAN

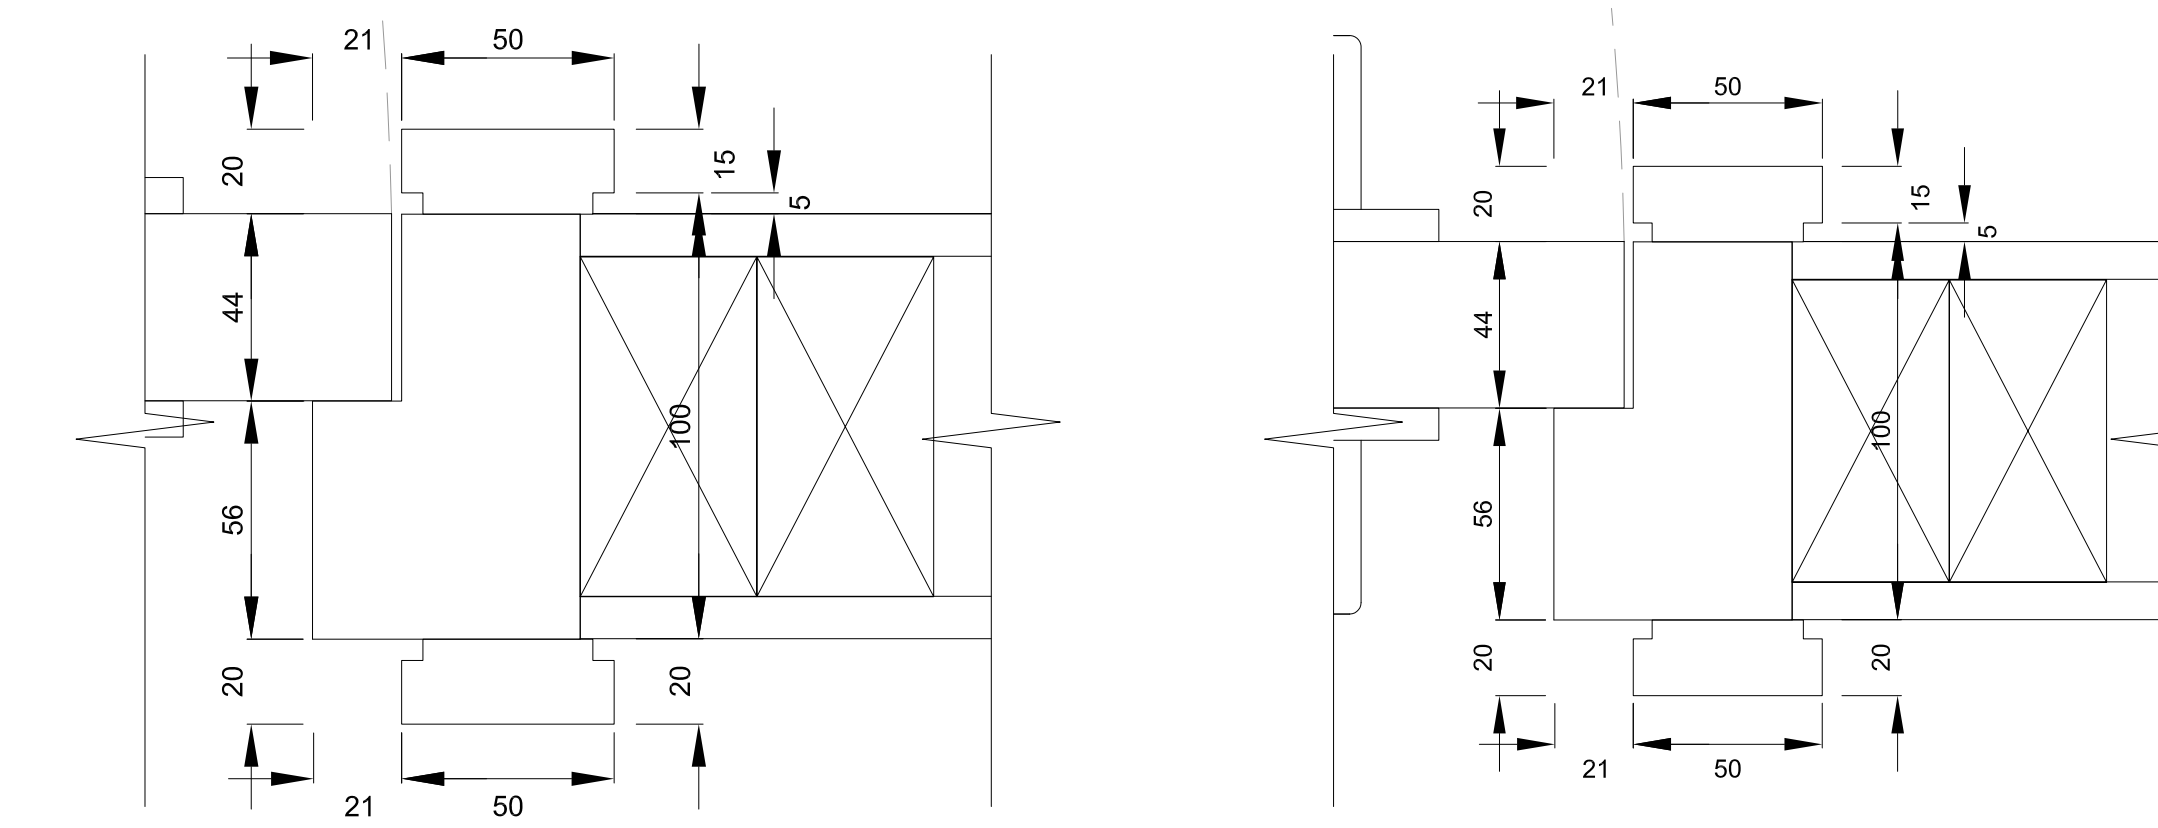


DETAIL 3
SCALE 1:2

DETAIL 4
SCALE 1:2

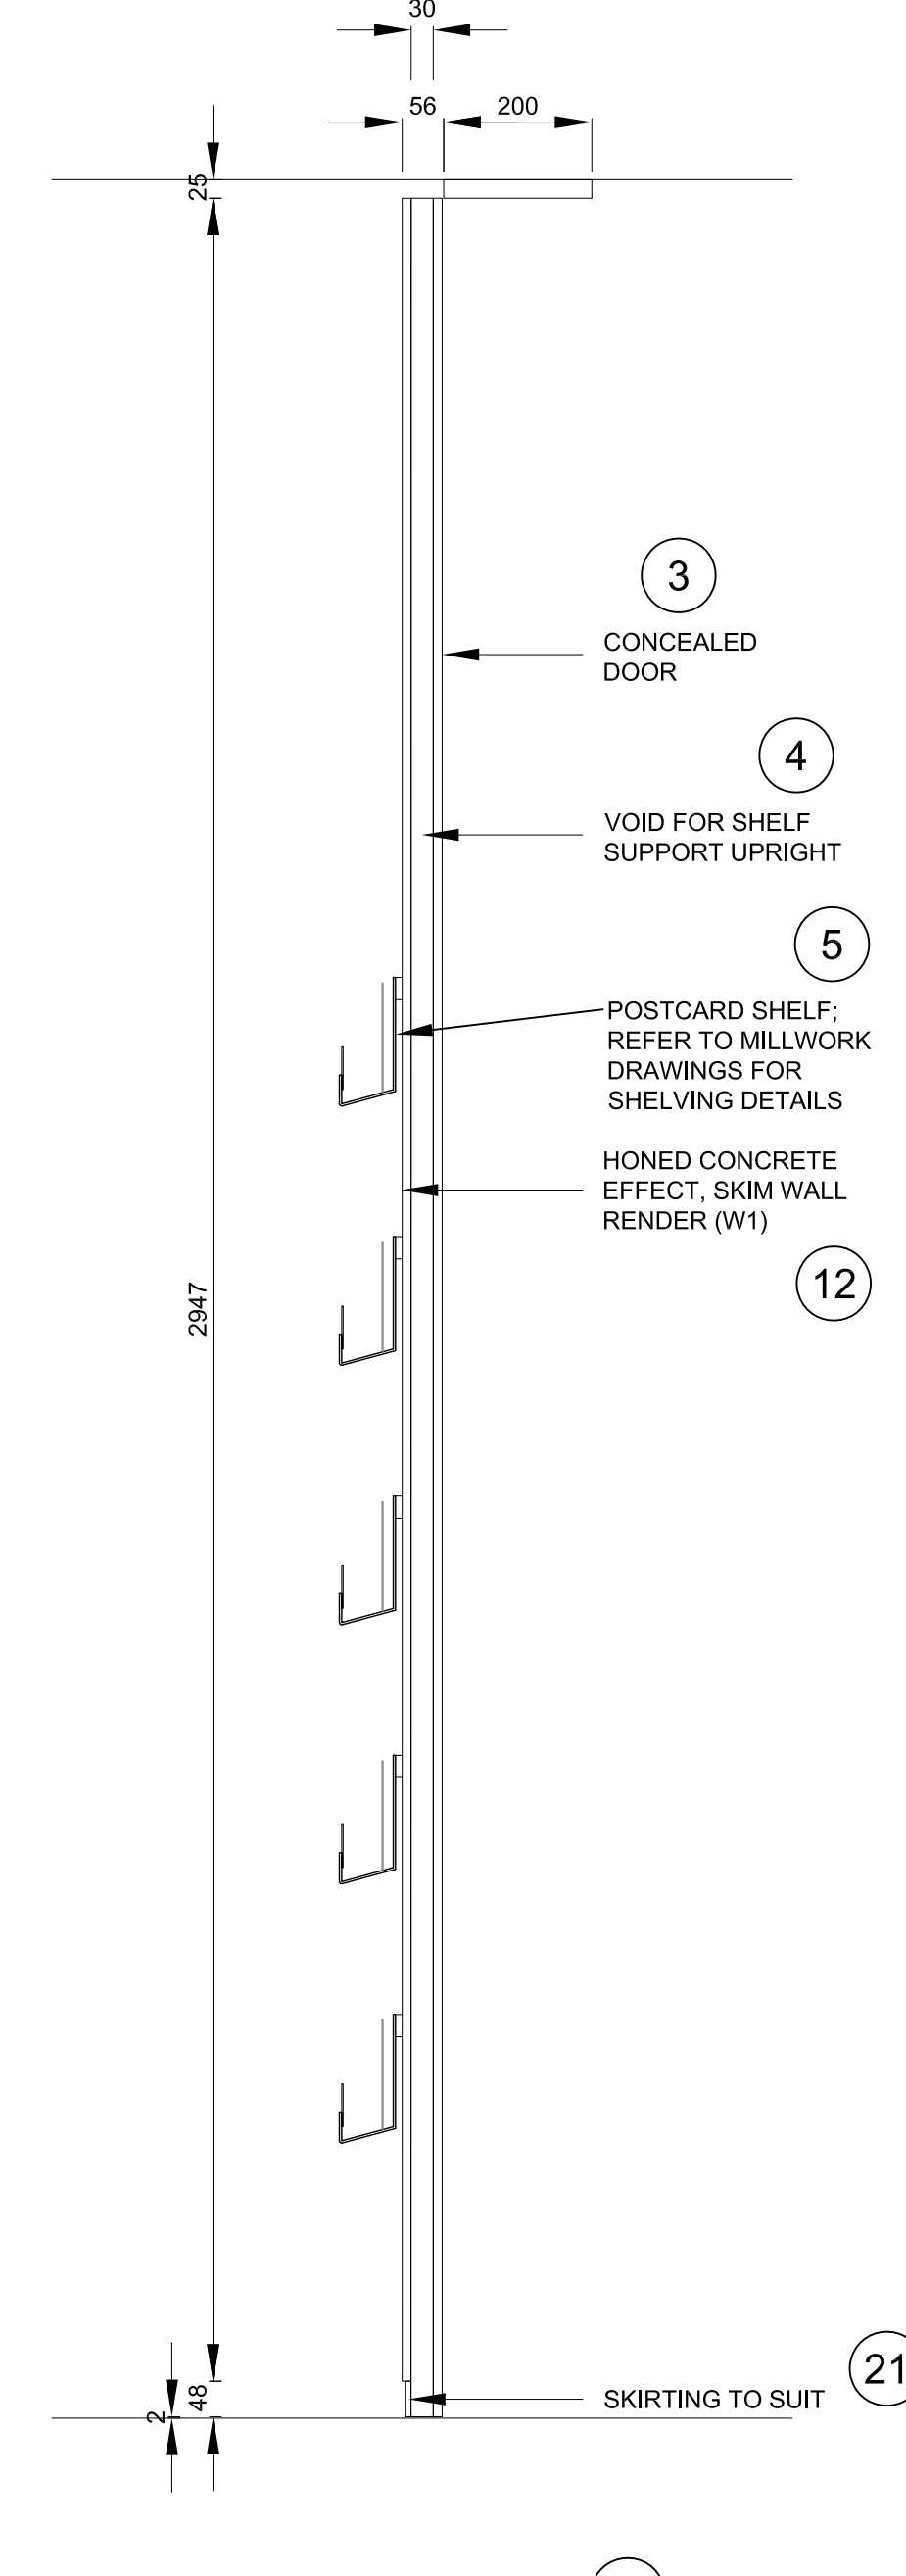

SECTION BB

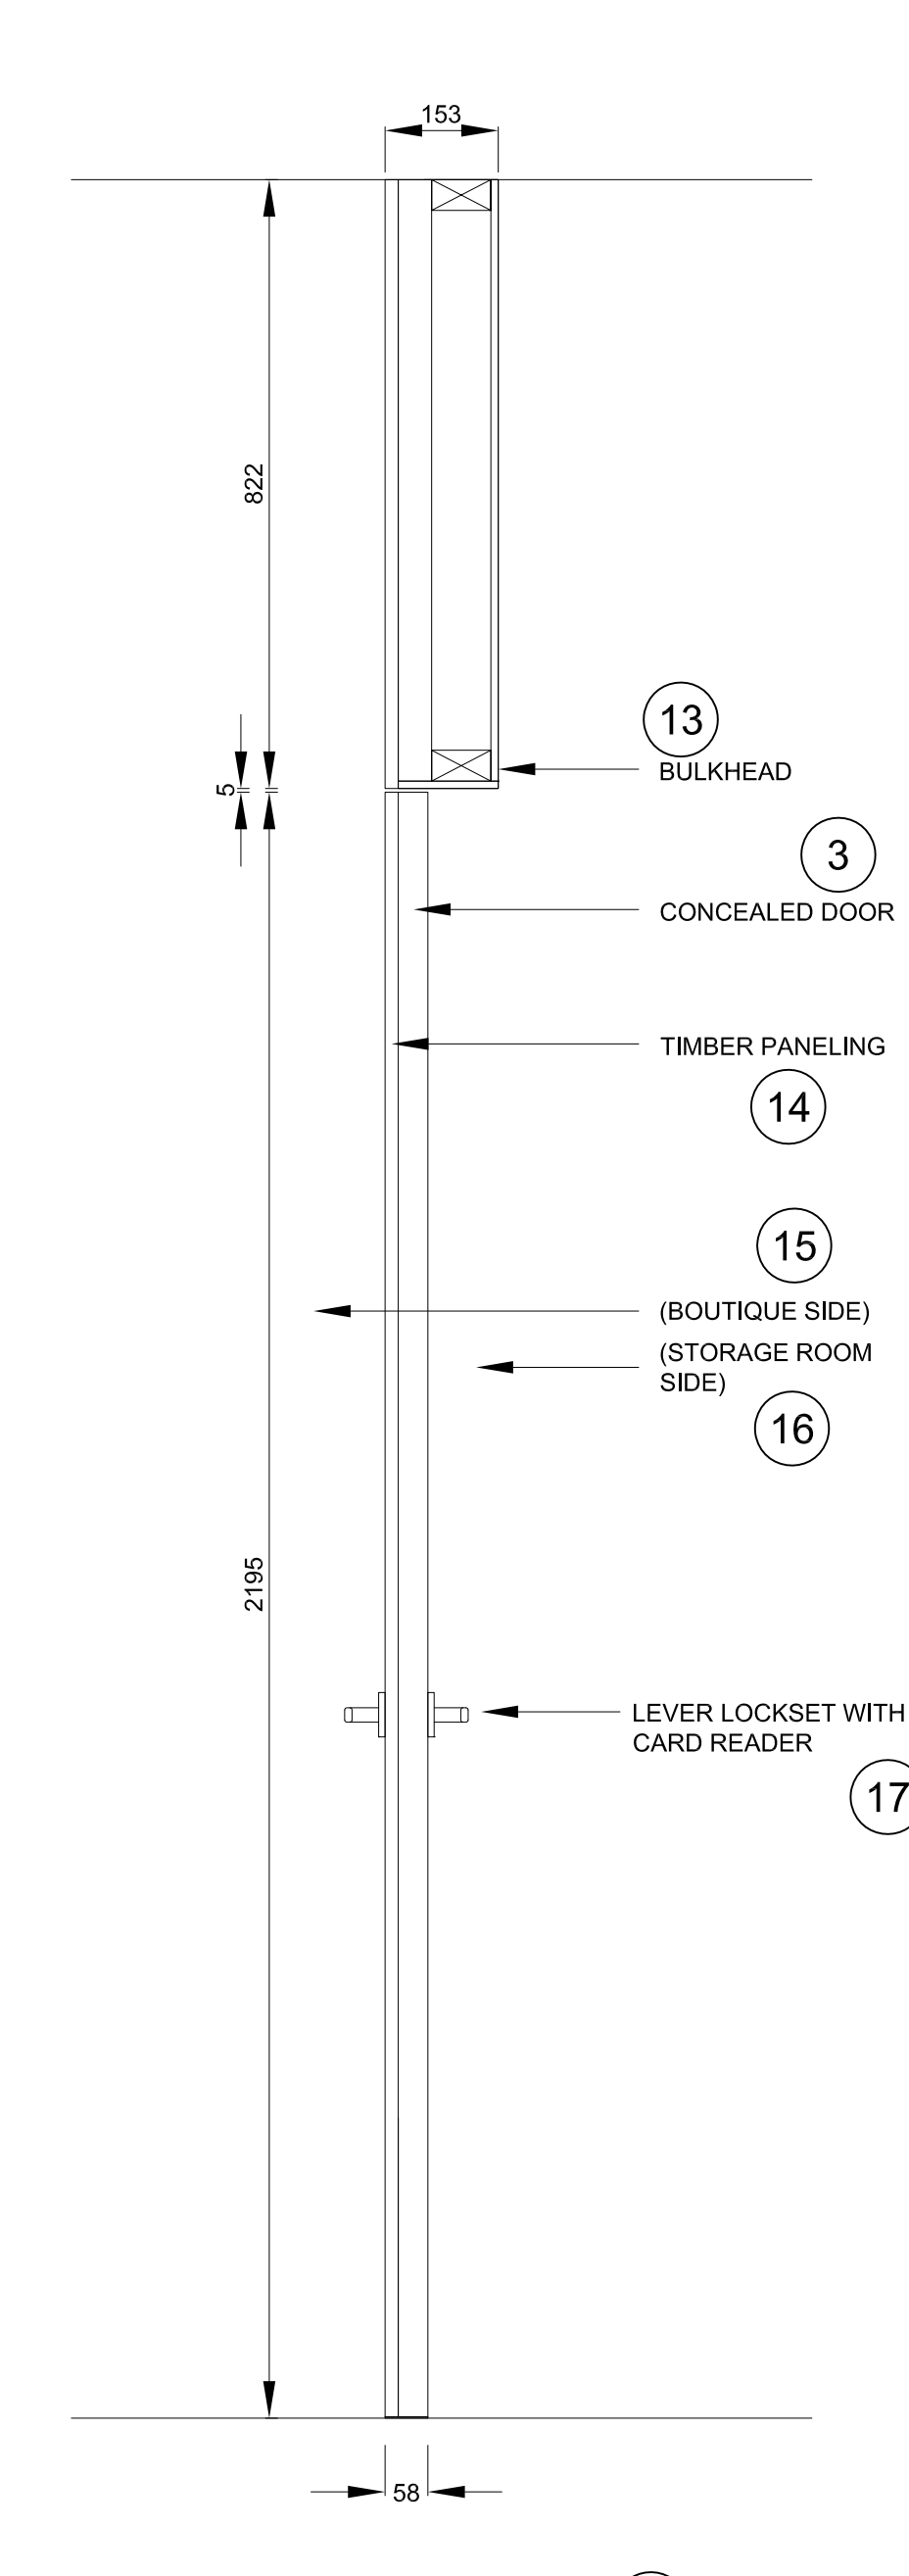

SECTION DD

NOTES
DO NOT SCALE FROM DRAWING
ALL DIMENSIONS TO BE SITE VERIFIED BY CONTRACTOR
PRIOR TO MANUFACTURING OR CONSTRUCTION
CONTRACTOR TO REPORT ANY DISCREPANCIES TO NGC
IMMEDIATELY
CONTRACTOR TO PROVIDE SHOP DRAWINGS OF ALL
CUSTOM COMPONENTS FOR APPROVAL BY NGC PRIOR
TO MANUFACTURING
THE DRAWING AND THE WORKS DEPICTED ARE THE
COPYRIGHT OF LUSSEN DESIGN LTD AND MAY NOT BE
REPRODUCED EXCEPT BY WRITTEN PERMISSION

MATERIALS LEGEND:

PLEASE NOTE:
CONTRACTOR TO PROVIDE SAMPLES
OF ALL MATERIALS FOR APPROVAL BY
NGC PRIOR TO CONSTRUCTION.


- METALWORK FINISHES
- M1 POWDER COAT RAL 7010 - FARSPALLIN GREY SEMI-MATT FINISH 25%
 - M2 POWDER COAT RAL 9002 - GREY / WHITE SEMI-MATT FINISH 25%
 - M3 POWDER COAT RAL 3031 - ORIENT RED SEMI-MATT FINISH 25%
 - M4 BRUSHED STAINLESS STEEL
 - M5 POWDER COAT RAL 7038 - AGATE GREY SEMI-MATT FINISH 25%
 - M6 BLACK SMOKED METAL
- JOINERY FINISHES
- J1 BLACK STAINED AMERICAN OAK MATCH TO SAMPLE
 - J2 WHITE STAINED CANADIAN MAPLE MATCH TO SAMPLE
 - J3 NATURAL FINISH AMERICAN OAK MATCH TO SAMPLE
 - J4 SPRAY PAINTED MDF DARK GREY BLACK MATCH TO DULUX D99N 0700 CLEAR LACQUER FINISH
 - J5 SPRAY PAINTED MDF -RED MATCH TO DULUX 99YR 11475 CLEAR LACQUER FINISH
 - J6 SPRAY PAINTED MDF -STONE MATCH TO DULUX 20Y 57060 CLEAR LACQUER FINISH
 - J7 SPRAY PAINTED SATIN WHITE
 - J8 DARK PAINT FINISH TO MATCH EXISTING
- LAMINATE FINISHES
- L1 DARK GREY POLYREY - FA-P114 POIVRE
- OTHER FINISHES
- C1 VALCHROMAT COLOURED MDF - MID GREY 2-PACK CLEAR LACQUER FINISH
 - C2 Quartz Surfaces Zodiak® Dove Grey www.dupont.com
 - S1 SILESTONE BLANCO NORTE / WHITE NORTE
 - U1 BUTE FABRIC - LEWIS 2825 PRODUCT CODE: CF40-2825 100% PURE WOOL
- WALL FINISHES
- W1 HONED CONCRETE EFFECT SKIM WALL RENDER MATCH TO RAL 7044 SILK GREY
 - W2 HONED CONCRETE EFFECT SKIM WALL RENDER MATCH TO RAL 7030 STONE GREY

REV	DATE	DESCRIPTION	BY
1	SEPT 10 2015	ISSUED FOR TENDER	

2 Commercial Street
London EC1M 6DR UK
T +44(0)20 3384 1400

CLIENT NATIONAL GALLERY OF CANADA
PROJECT NEW RETAIL STORE
ORG DOOR DETAILS 1
DRG No: A-10 REV: -
SCALE 1:10 @ A0 DATE JUL 2015
DRAWN BY RJC
SHEET NO. A-10

DR03 (STORAGE ROOM ENTRY FROM CORRIDOR)

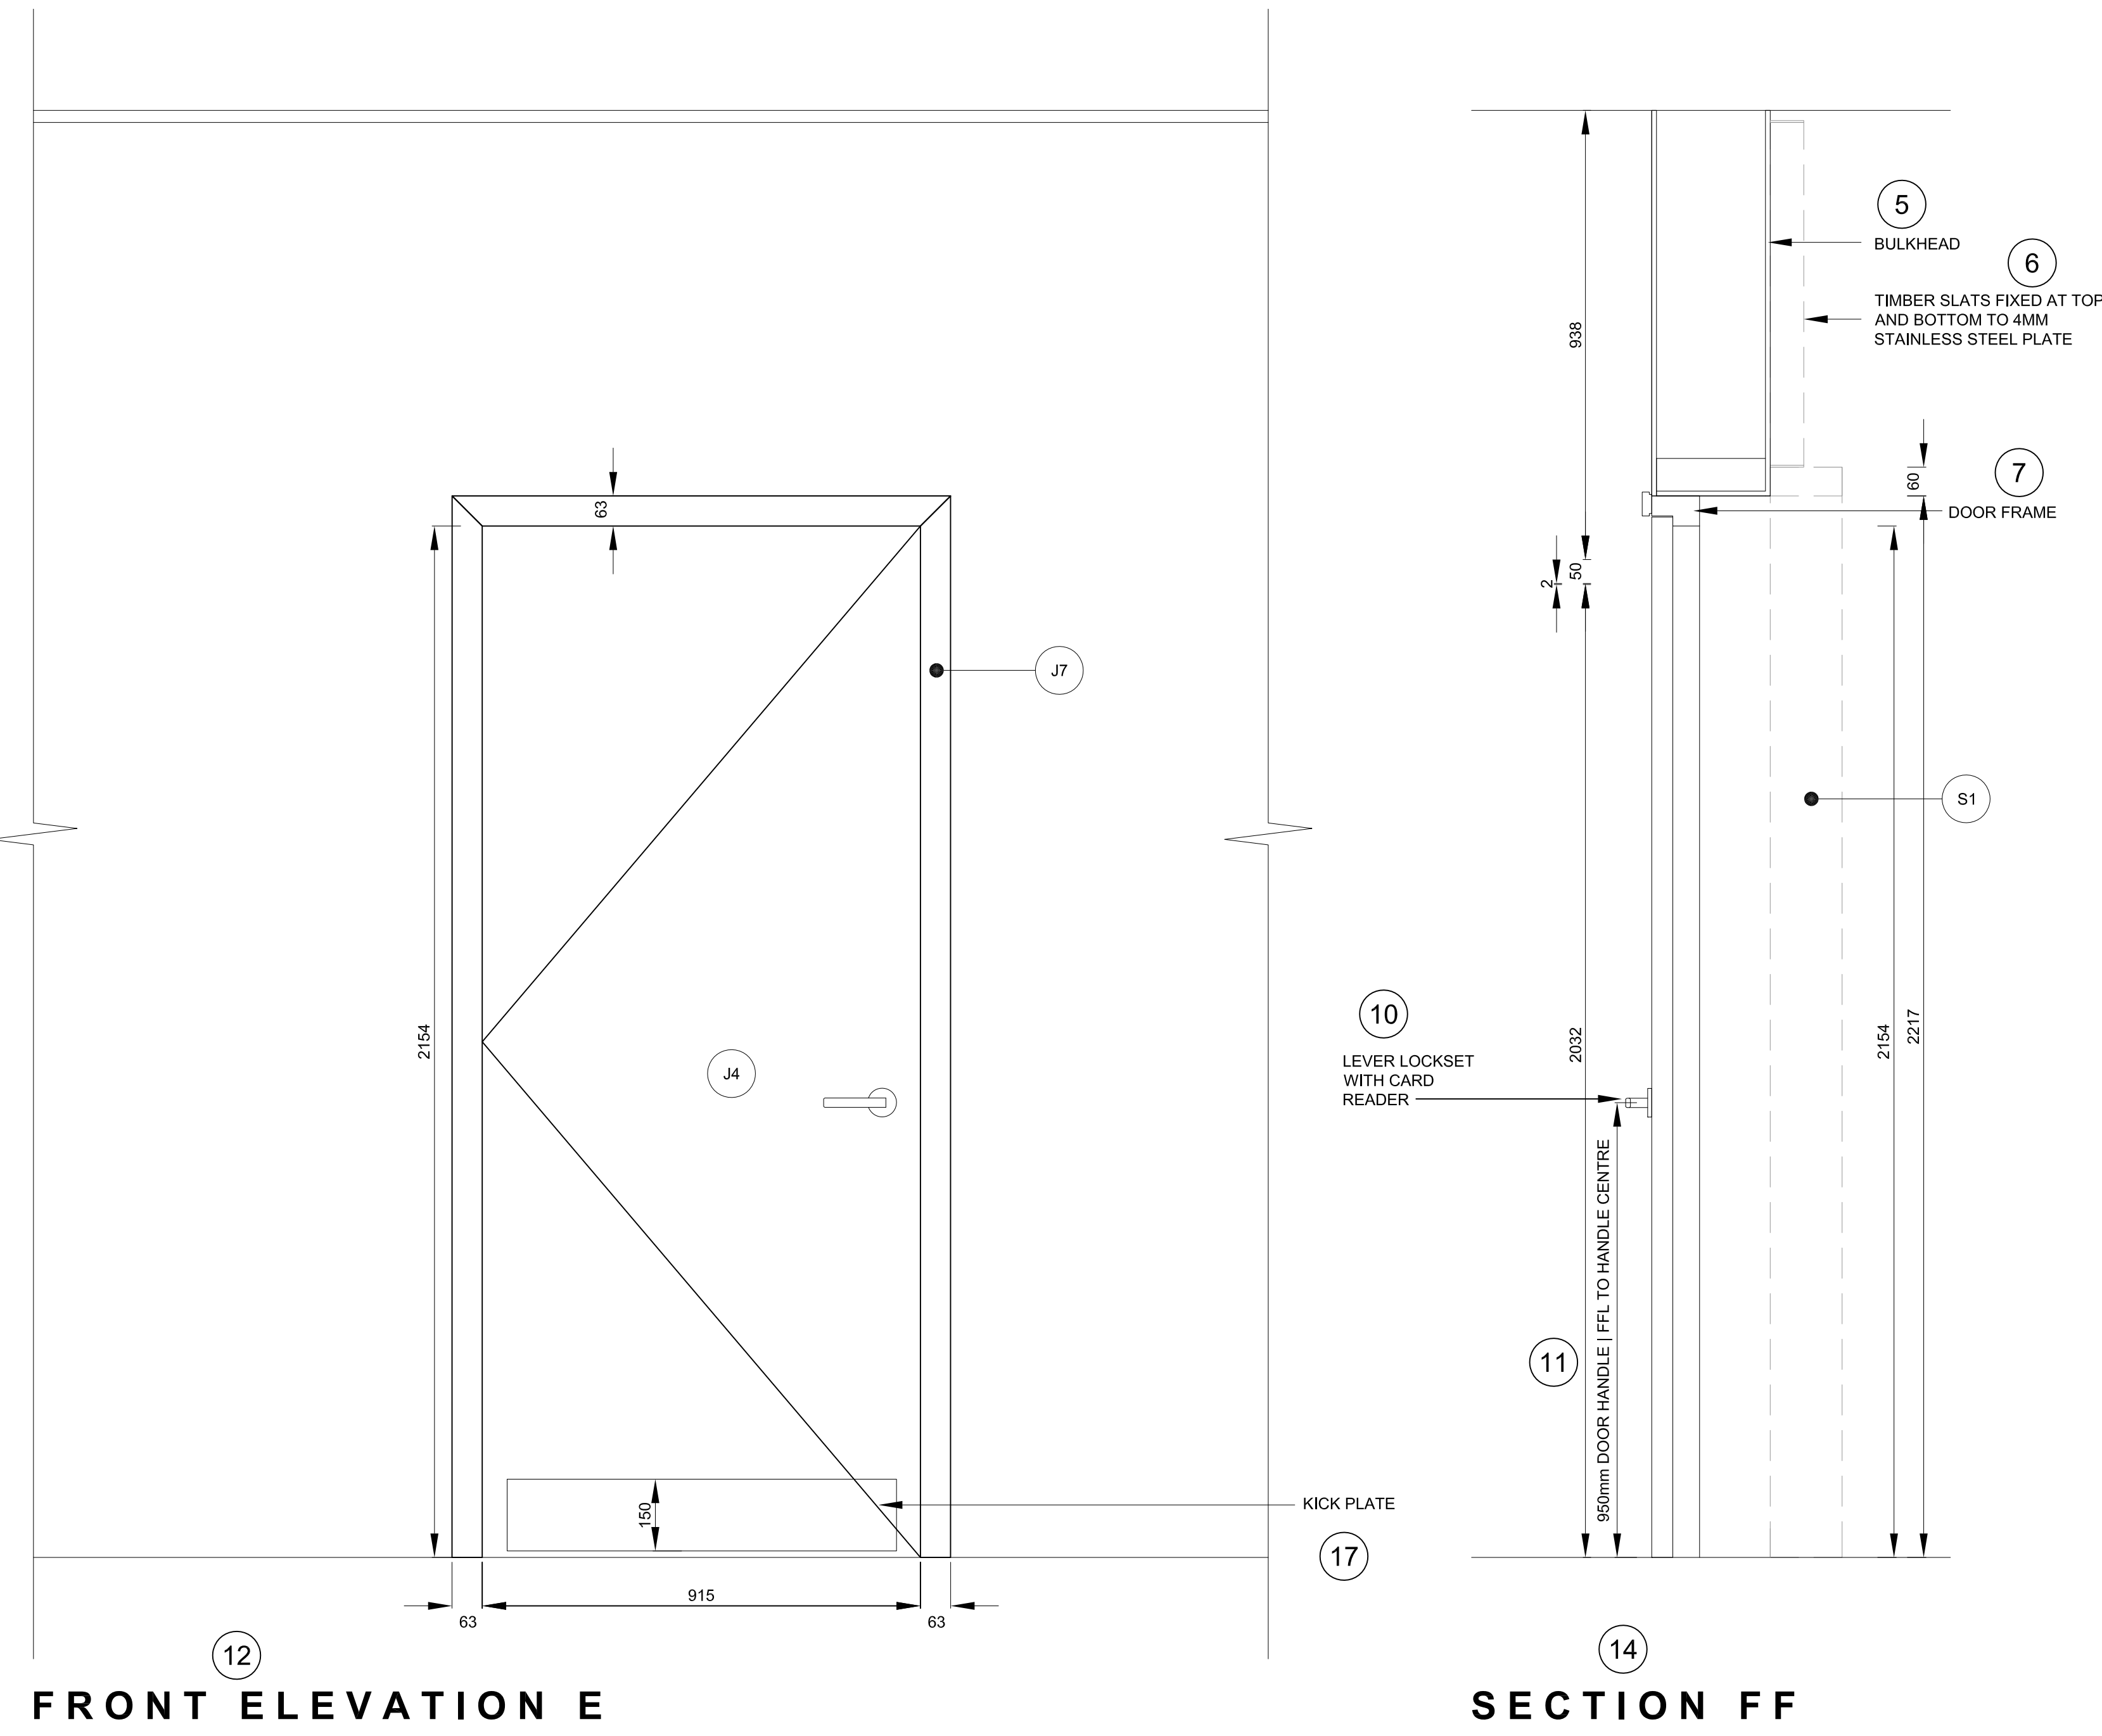

FRONT ELEVATION E


SECTION FF

PLAN

20
19
DETAIL 5
SCALE 1:2

21
19
DETAIL 6
SCALE 1:2

DR04 (ADMIN OFFICE)

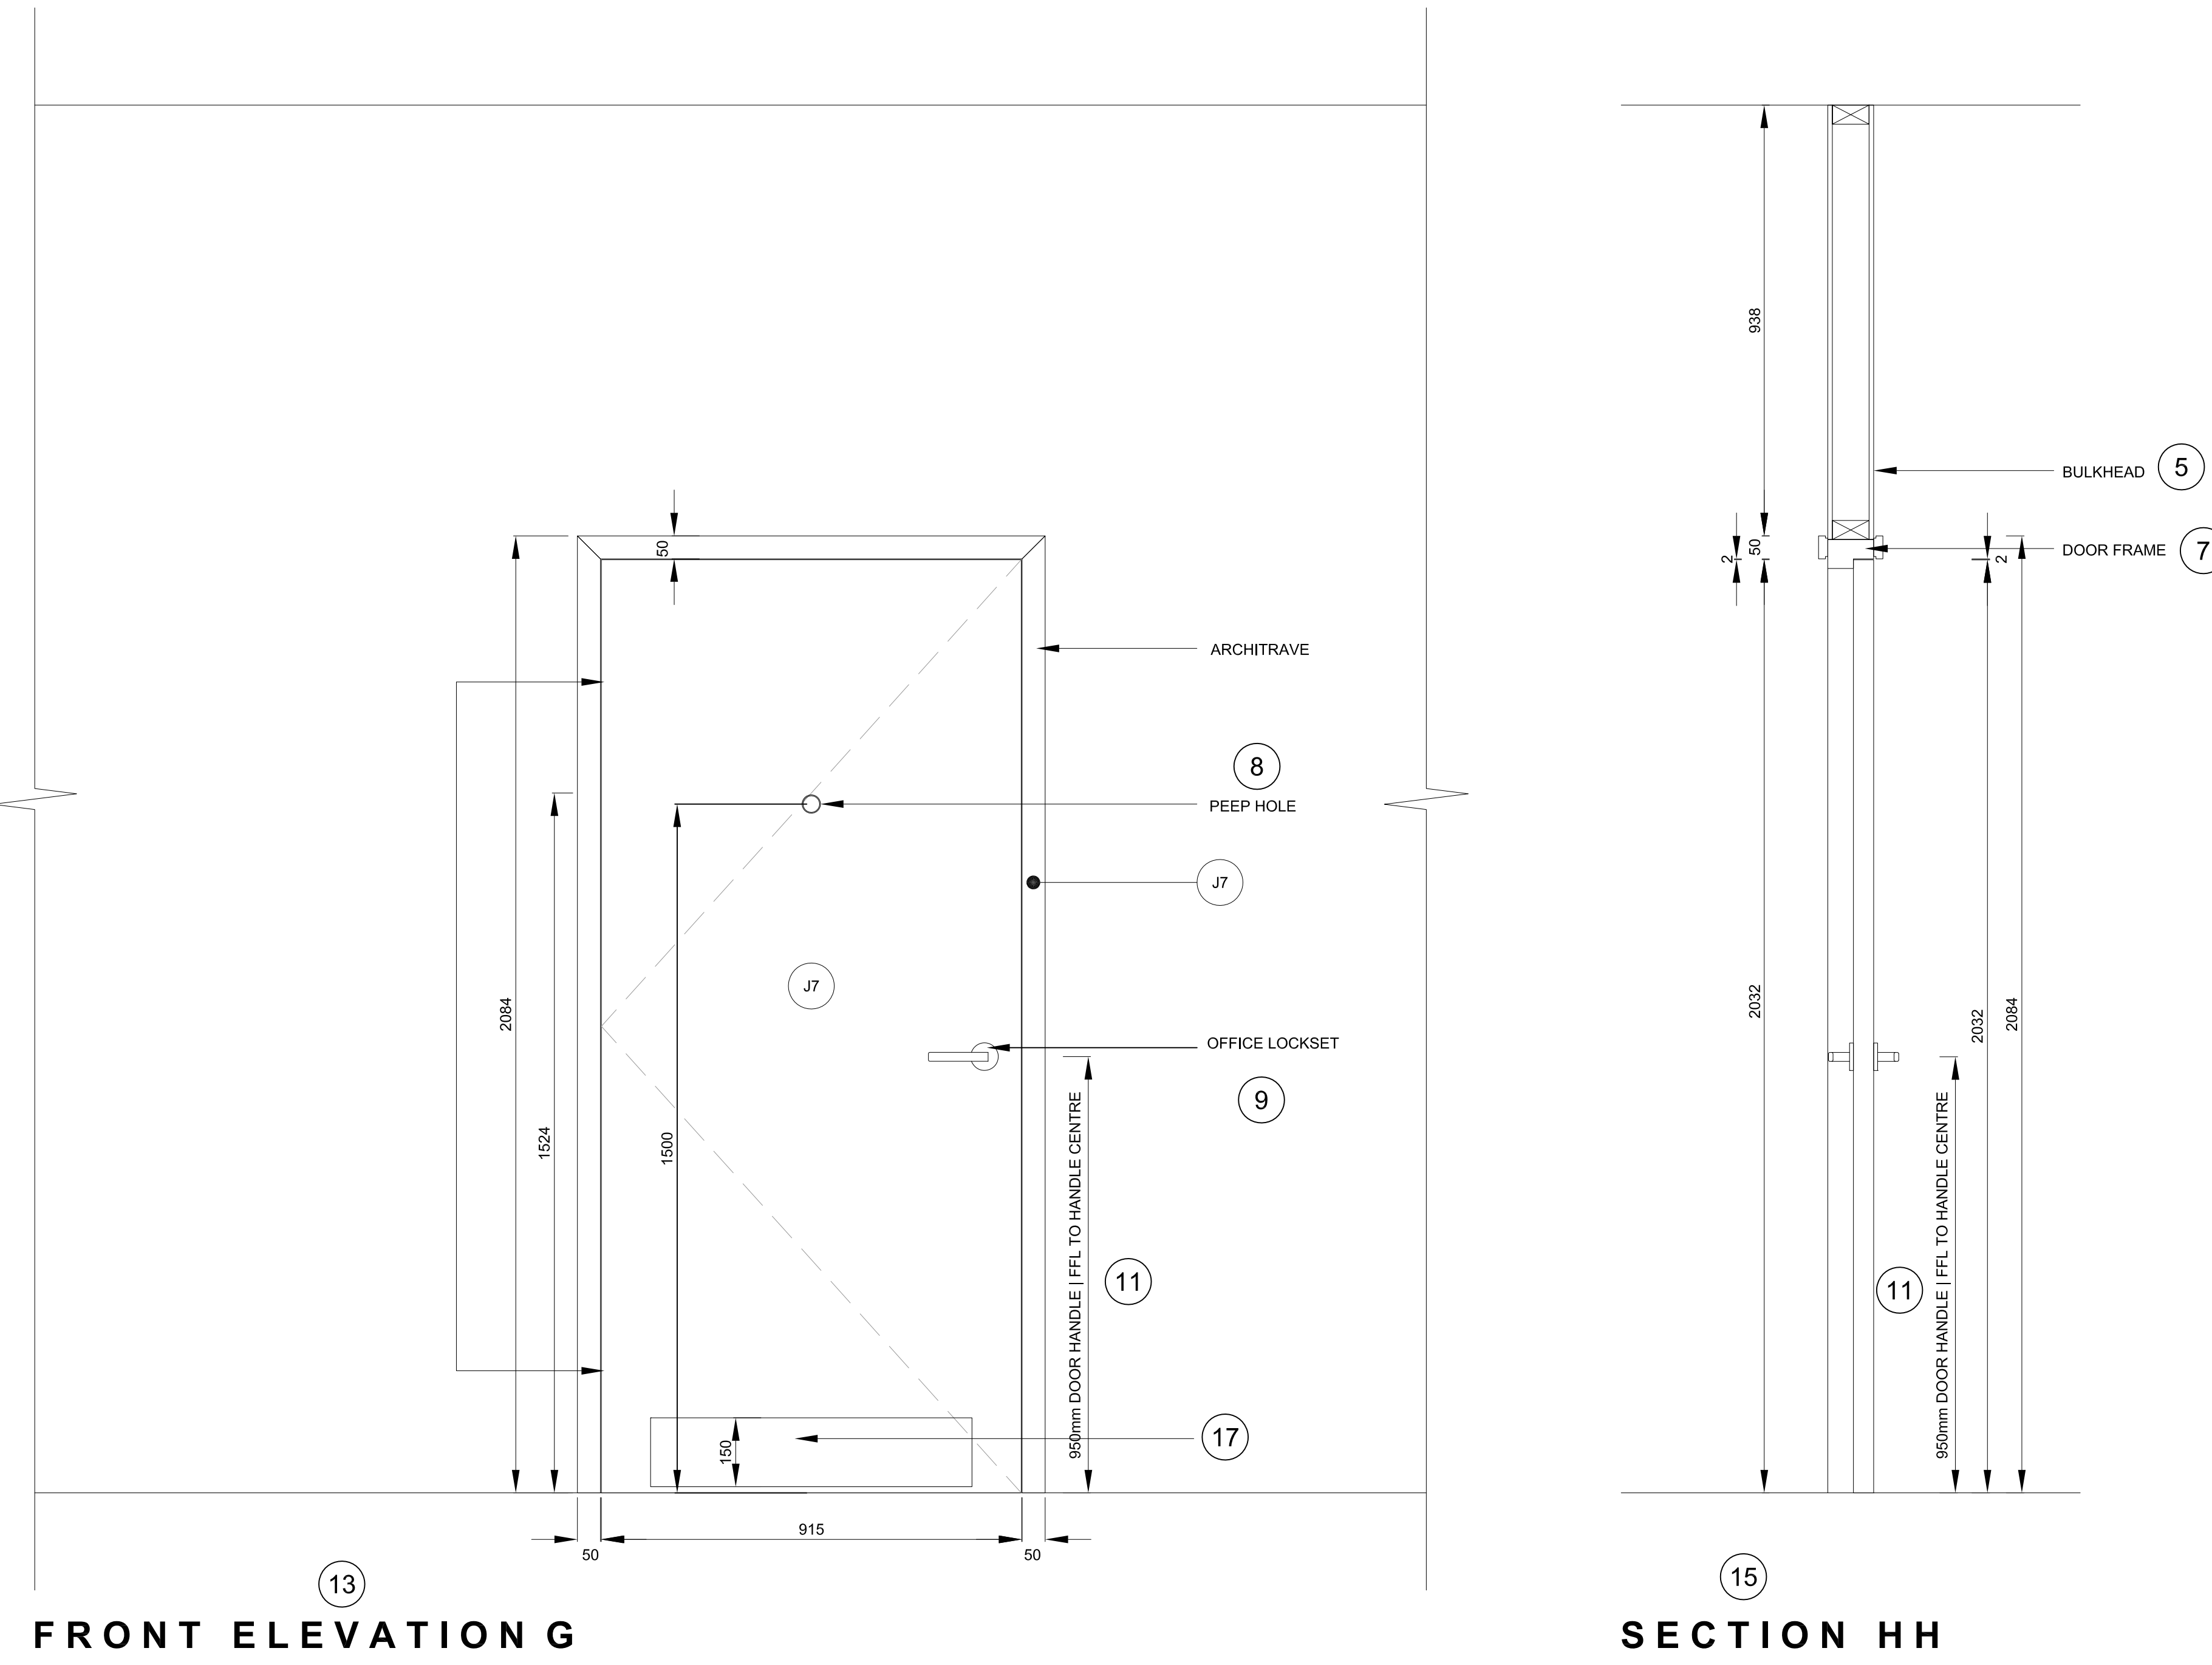

FRONT ELEVATION G

SECTION HH

PLAN

22
19
DETAIL 7
SCALE 1:2

23
19
DETAIL 8
SCALE 1:2

NOTES
DO NOT SCALE FROM DRAWING
ALL DIMENSIONS TO BE SITE VERIFIED BY CONTRACTOR PRIOR TO MANUFACTURE OR CONSTRUCTION. CONTRACTOR TO REPORT ANY DISCREPANCIES TO NGC IMMEDIATELY.
CONTRACTOR TO PROVIDE SHOP DRAWINGS OF ALL CUSTOM COMPONENTS FOR APPROVAL BY NGC PRIOR TO MANUFACTURE.
THE DRAWING AND THE WORKS DEPICTED ARE THE COPYRIGHT OF LUSSEN DESIGN LTD AND MAY NOT BE REPRODUCED EXCEPT BY WRITTEN PERMISSION.

MATERIALS LEGEND:


PLEASE NOTE:
CONTRACTOR TO PROVIDE SAMPLES OF ALL MATERIALS FOR APPROVAL BY NGC PRIOR TO CONSTRUCTION.

- METALWORK FINISHES**
- M1 POWDER COAT RAL 7010 - FARBPALIN GREY SEMI-MATT FINISH 25%
 - M2 POWDER COAT RAL 9002 - GREY / WHITE SEMI-MATT FINISH 25%
 - M3 POWDER COAT RAL 3031 - ORIENT RED SEMI-MATT FINISH 25%
 - M4 BRUSHED STAINLESS STEEL
 - M5 POWDER COAT RAL 7038 - AGATE GREY SEMI-MATT FINISH 25%
 - M6 BLACK SMOKED METAL
- JOINERY FINISHES**
- J1 BLACK STAINED AMERICAN OAK MATCH TO SAMPLE
 - J2 WHITE STAINED CANADIAN MAPLE MATCH TO SAMPLE
 - J3 NATURAL FINISH AMERICAN OAK MATCH TO SAMPLE
 - J4 SPRAY PAINTED MDF DARK GREY BLACK MATCH TO DULUX D0NN 0700 CLEAR LACQUER FINISH
 - J5 SPRAY PAINTED MDF -RED MATCH TO DULUX 991R 11475 CLEAR LACQUER FINISH
 - J6 SPRAY PAINTED MDF -STONE MATCH TO DULUX 20Y 57060 CLEAR LACQUER FINISH
 - J7 SPRAY PAINTED SATIN WHITE
 - J8 DARK PAINT FINISH TO MATCH EXISTING
- LAMINATE FINISHES**
- L1 DARK GREY POLYSEY - FA-P114 POIVRE
- OTHER FINISHES**
- C1 VALCHROMAT COLOURED MDF - MID GREY 2-PACK CLEAR LACQUER FINISH
 - C2 Quartz Surfaces Zodiak® Dove Grey www.dupont.com
 - S1 SILESTONE BLANCO NORTE / WHITE NORTE
 - U1 BUTE FABRIC - LEWIS 2825 PRODUCT CODE: CF40-2825 100% PURE WOOL
- WALL FINISHES**
- W1 HONED CONCRETE EFFECT SKIM WALL RENDER MATCH TO RAL 7044 SILK GREY
 - W2 HONED CONCRETE EFFECT SKIM WALL RENDER MATCH TO RAL 7030 STONE GREY

REV	DATE	DESCRIPTION	BY
-	SEPT 10 2015	ISSUED FOR TENDER	-

CLIENT	NATIONAL GALLERY OF CANADA
PROJECT	NEW RETAIL STORE
DRG	DOOR DETAILS 1
DRG No.	A-10
SCALE	1:10 @ AD
DATE	JUL 2015

DR05 (CHANGE ROOM) 3

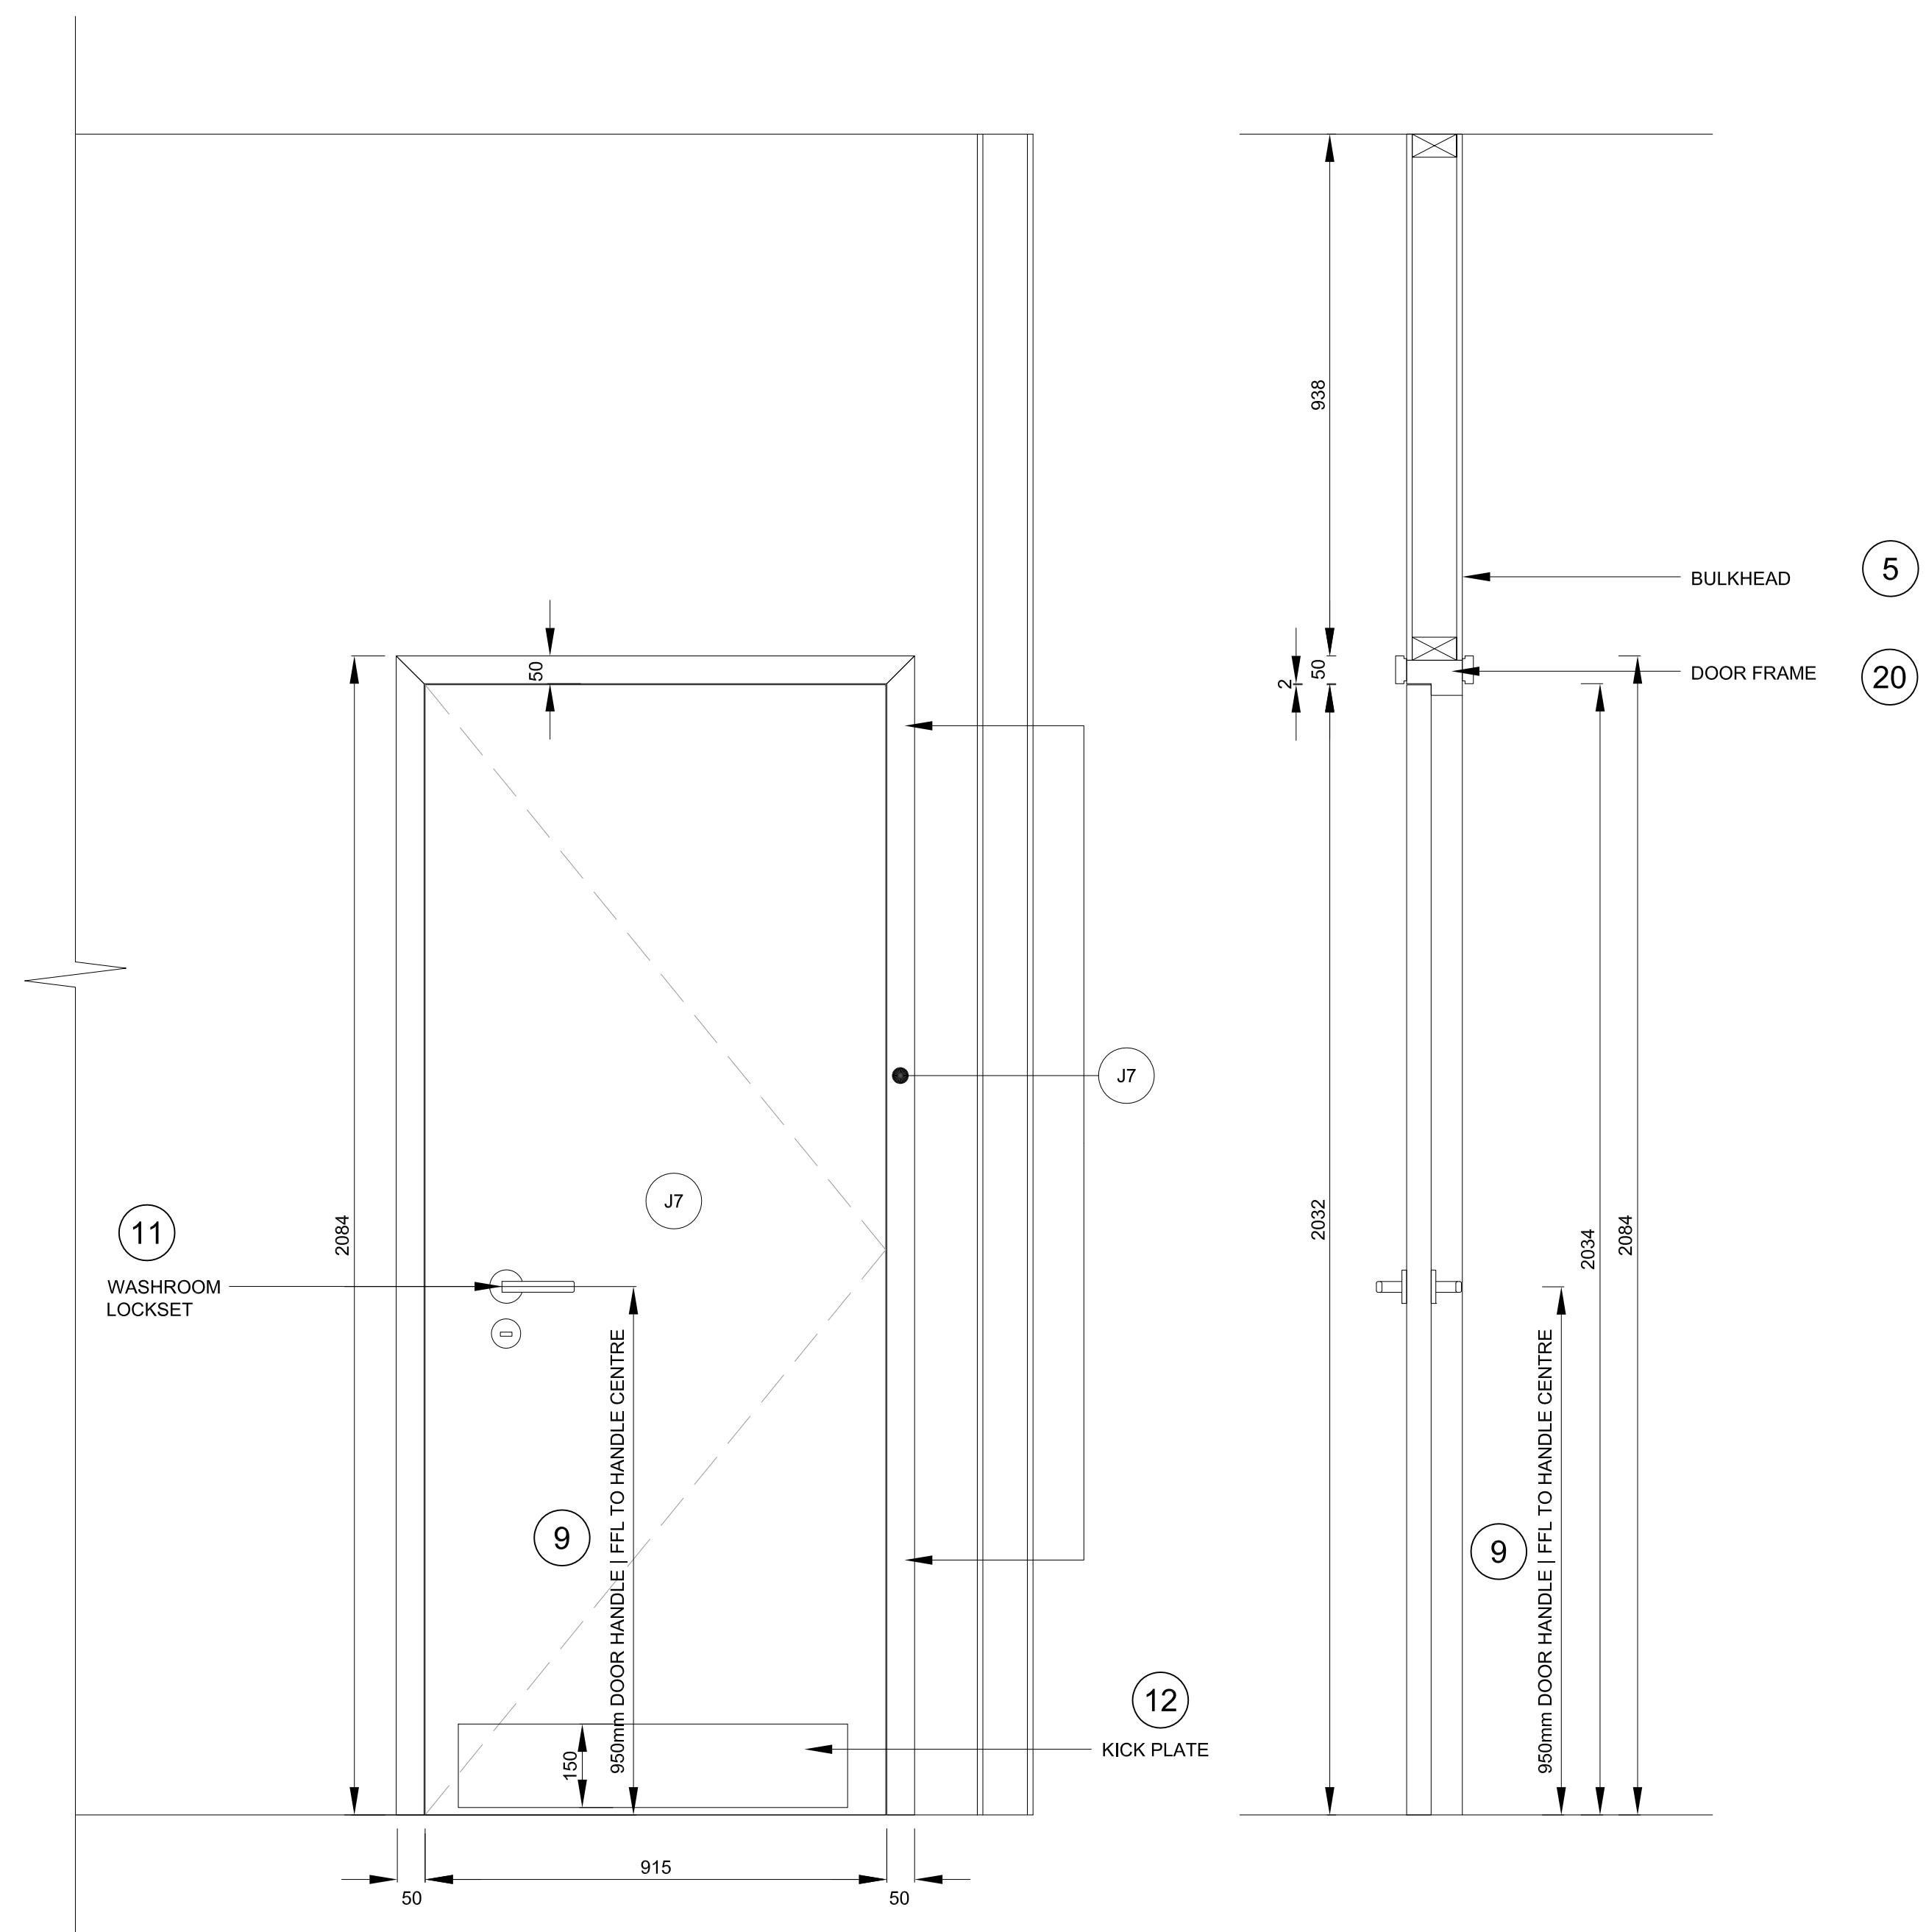


FRONT ELEVATION I

SECTION JJ

15


17

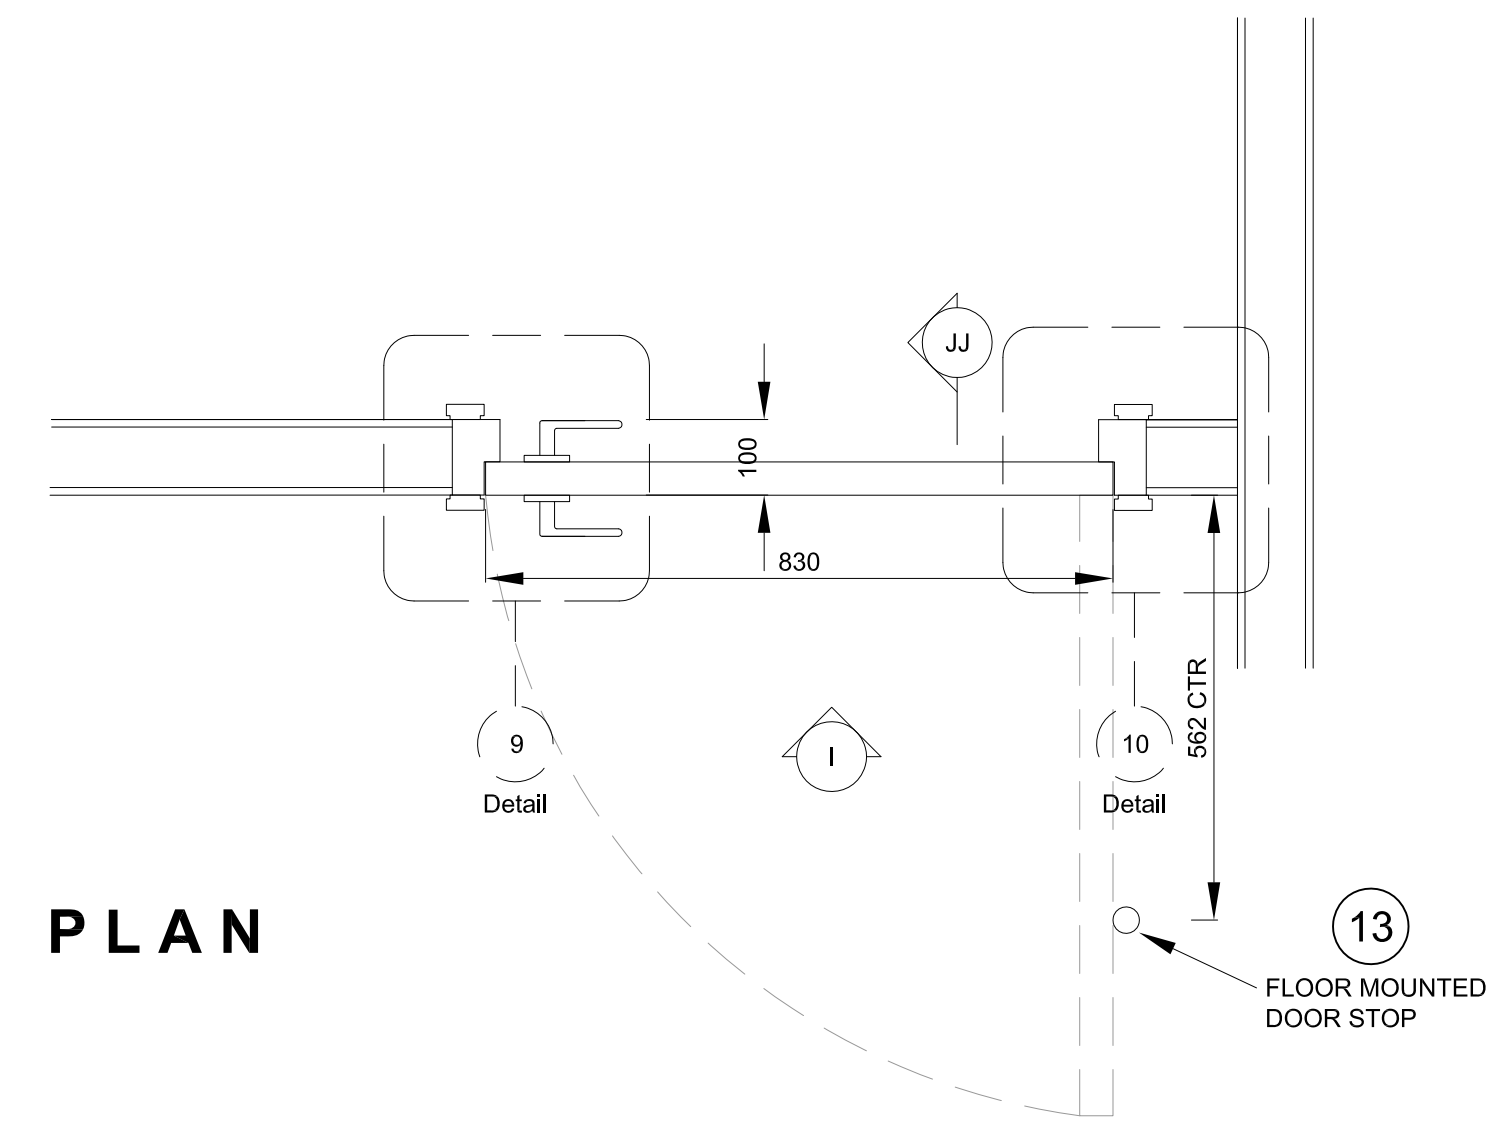

PLAN

13

DR06 (LOCKER ROOM ENTRY) 4

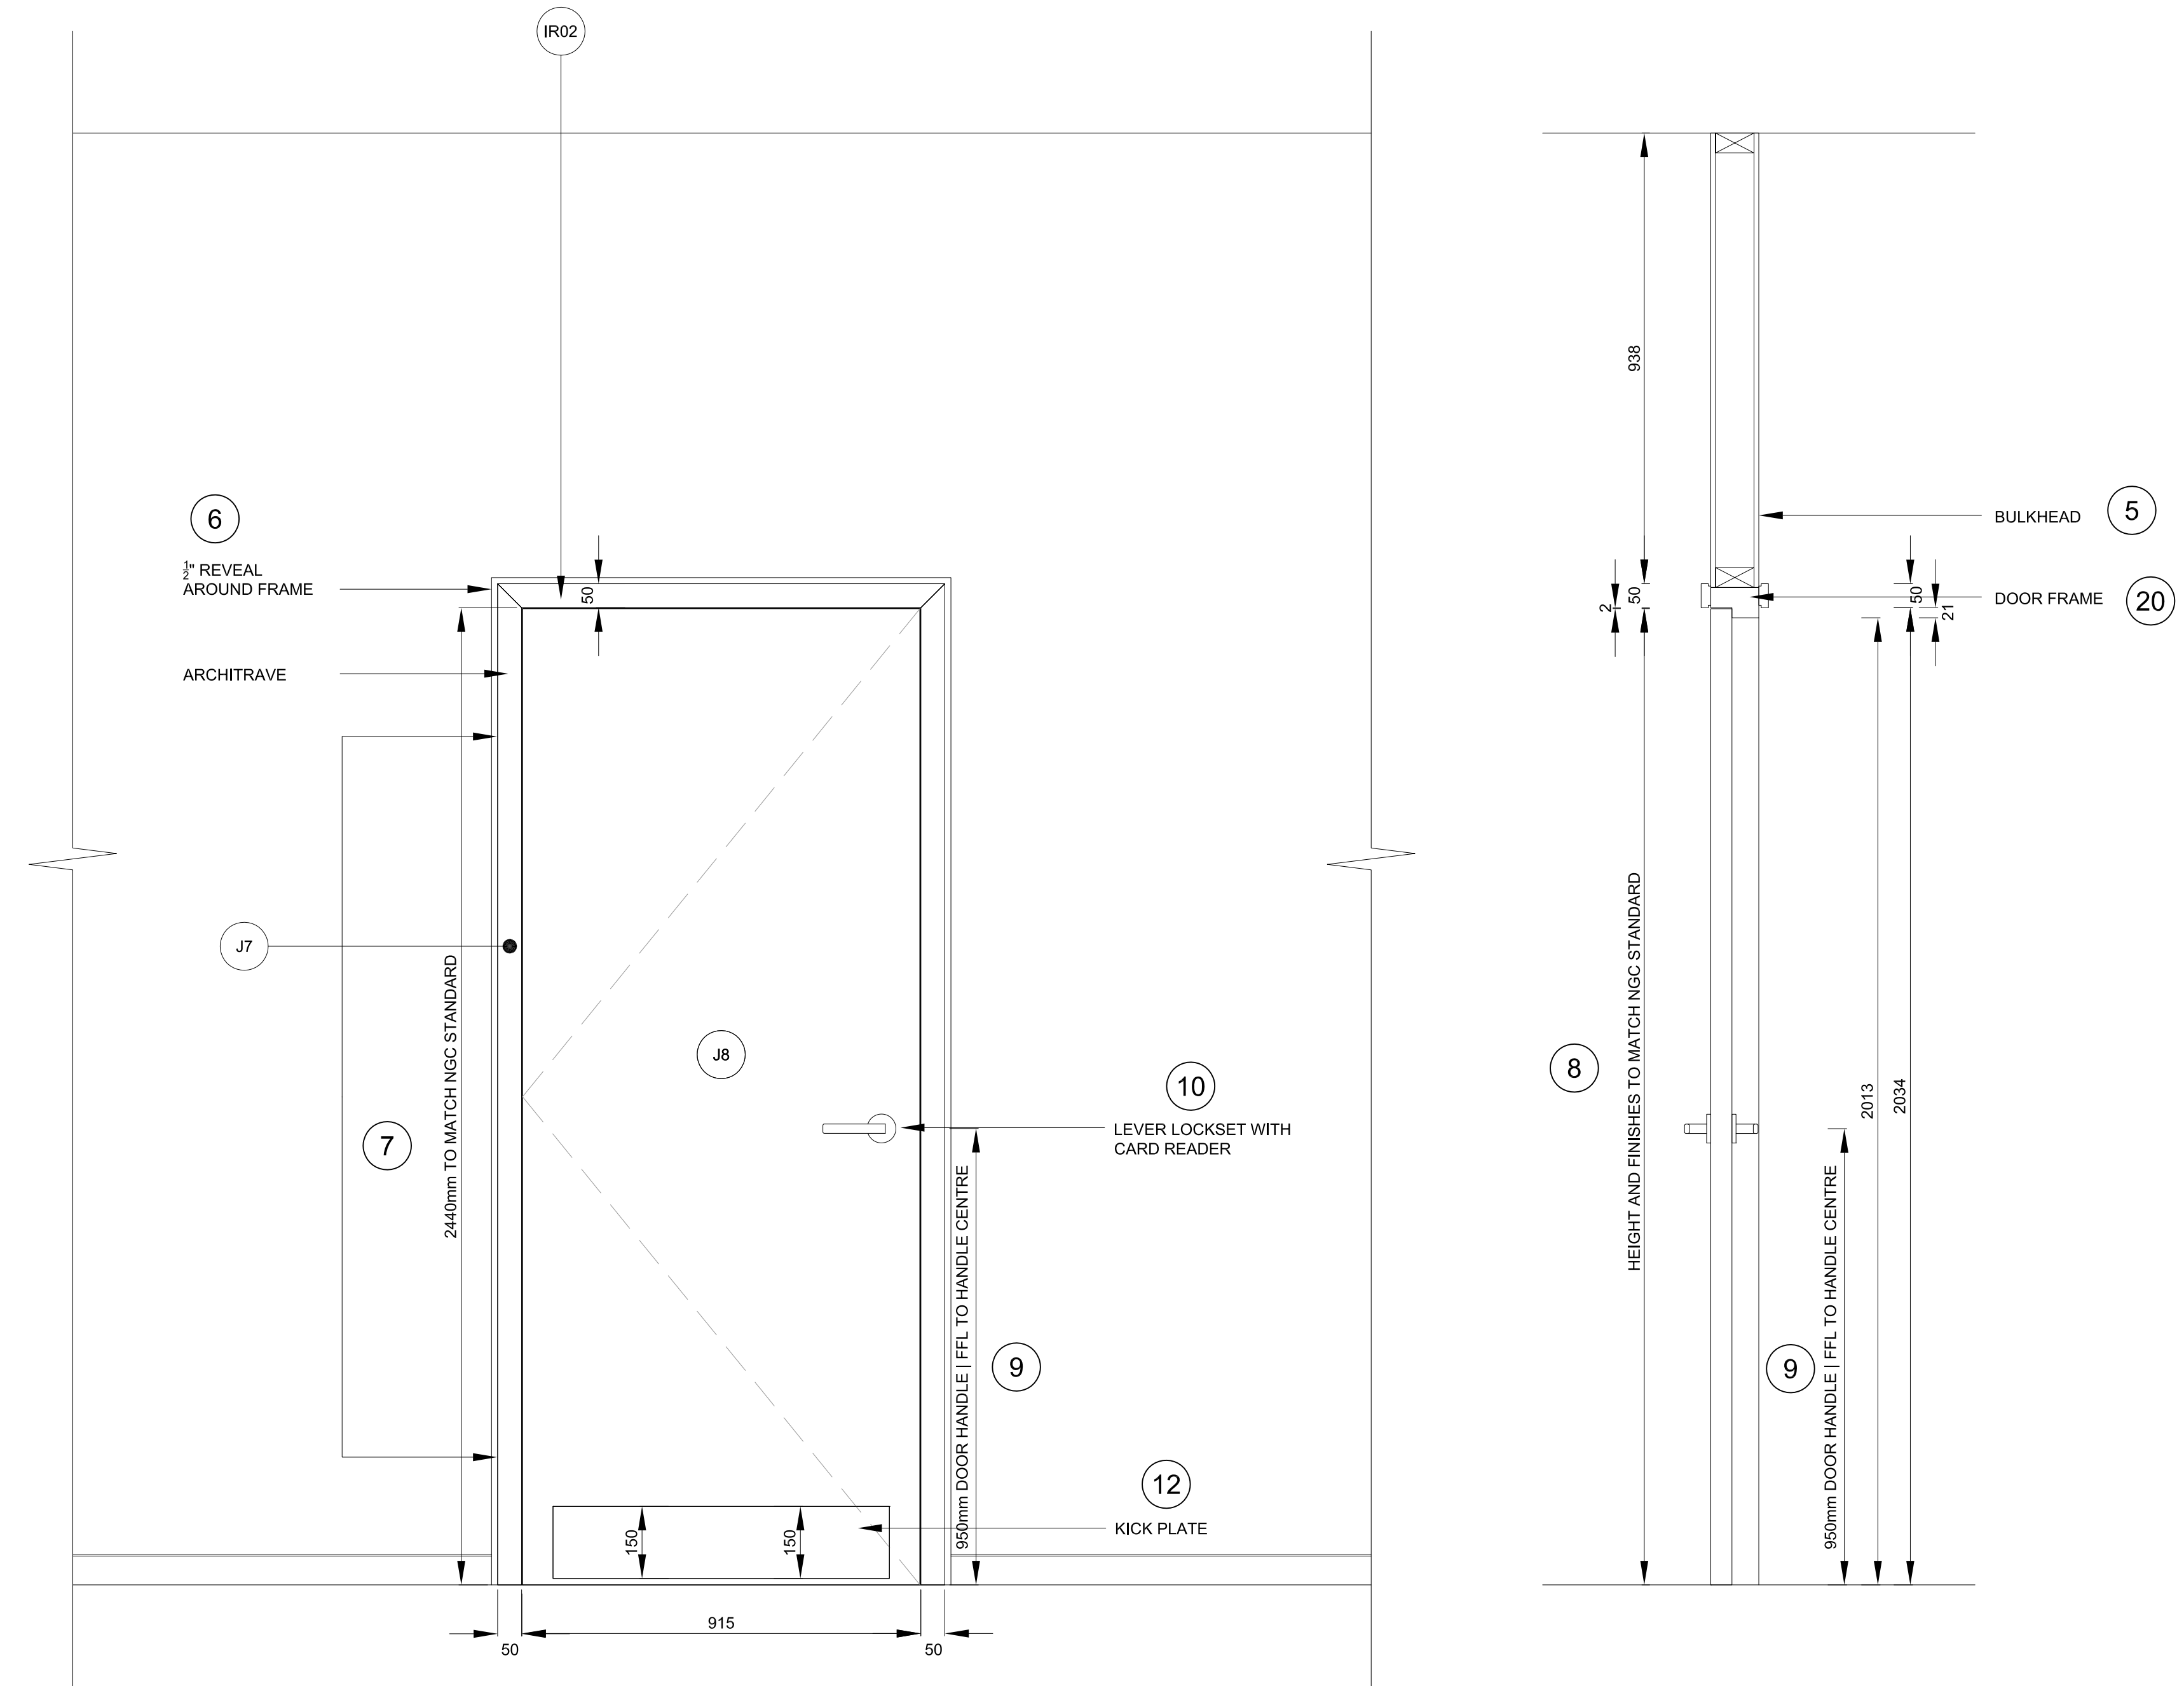


FRONT ELEVATION K

SECTION LL


16

18

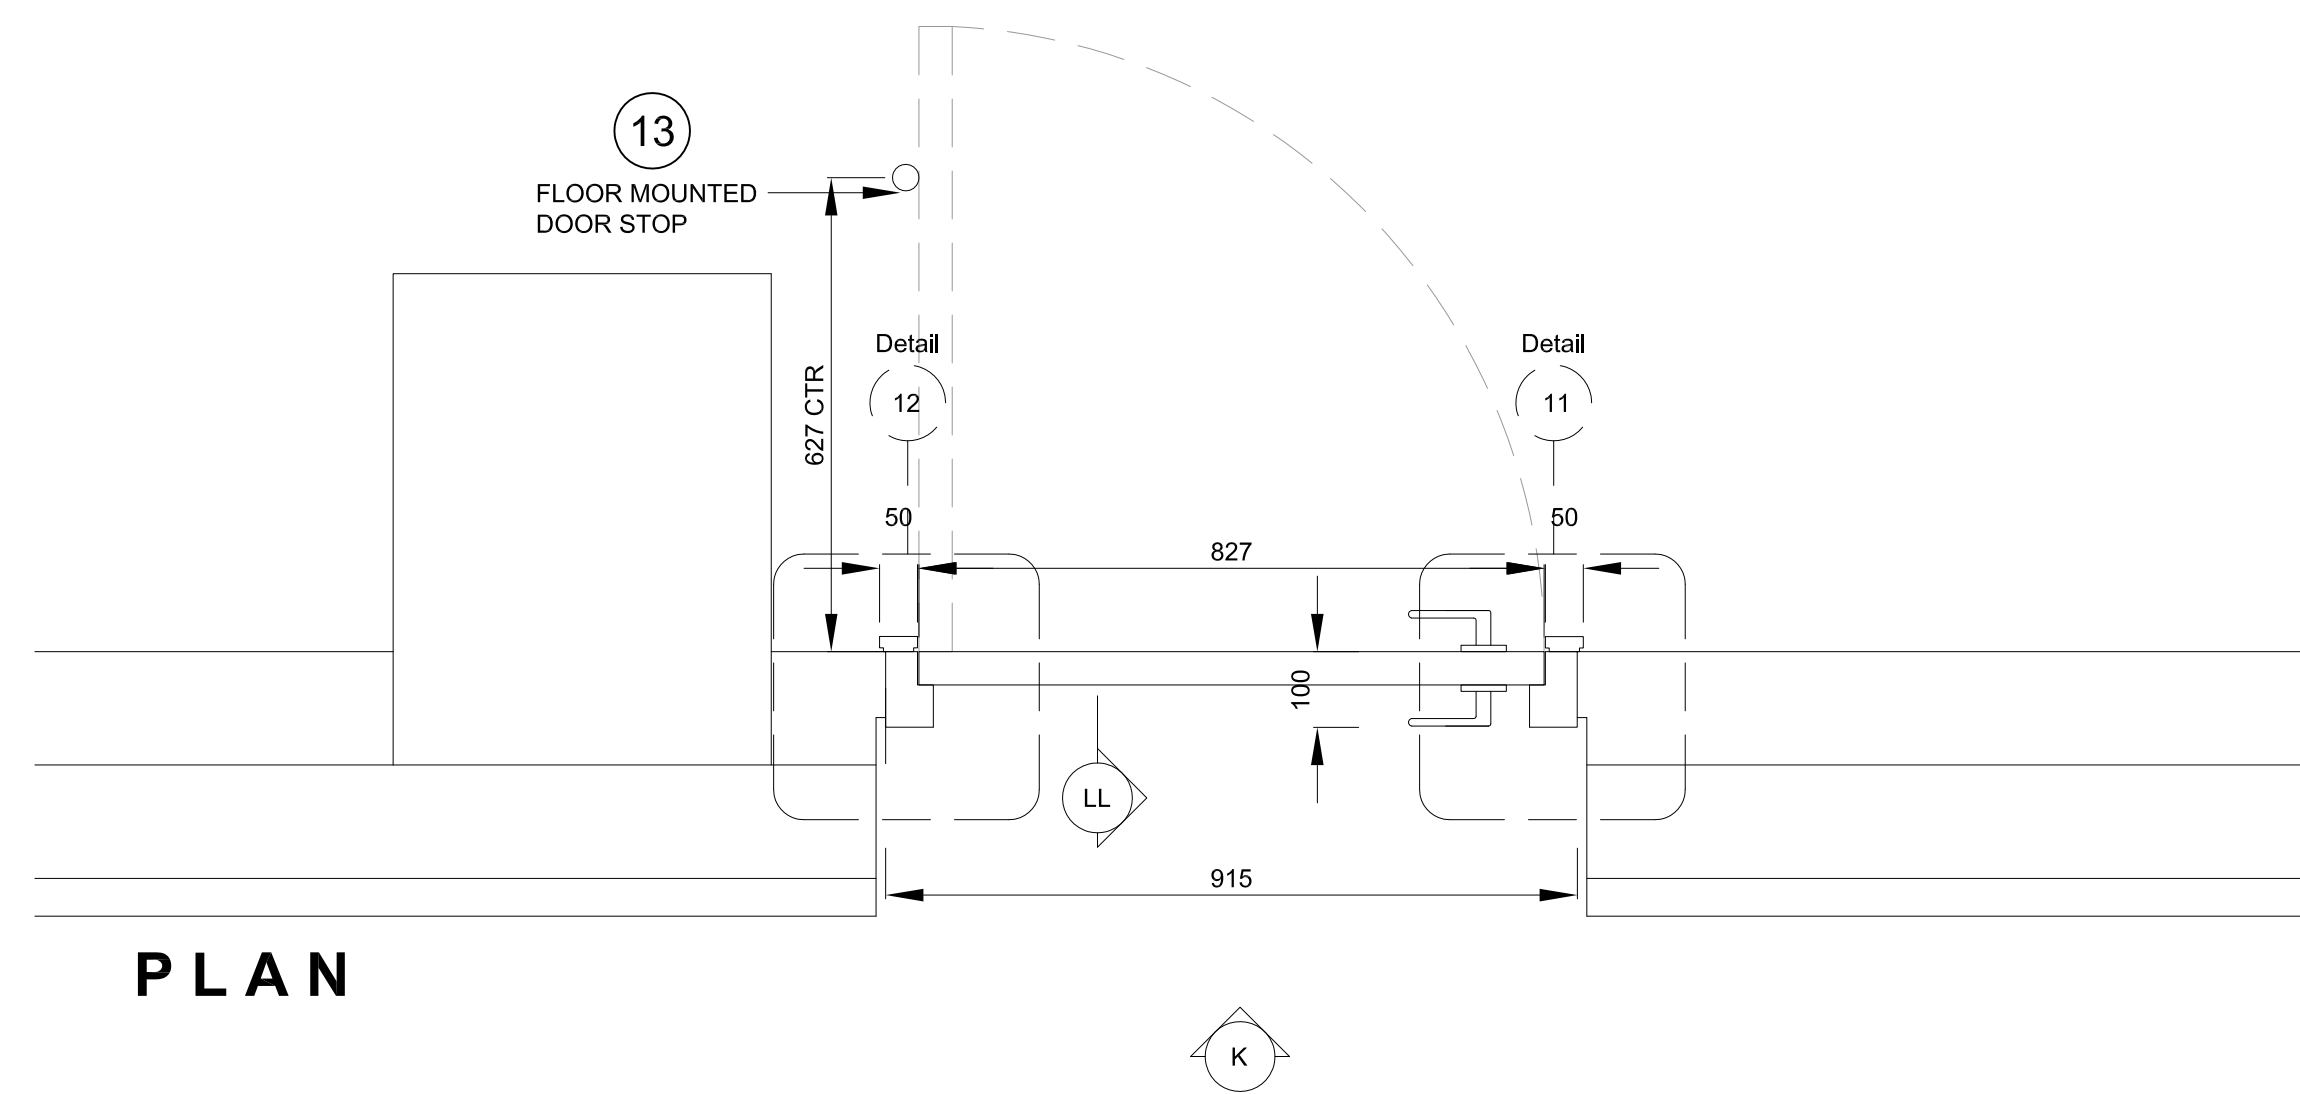


PLAN

13

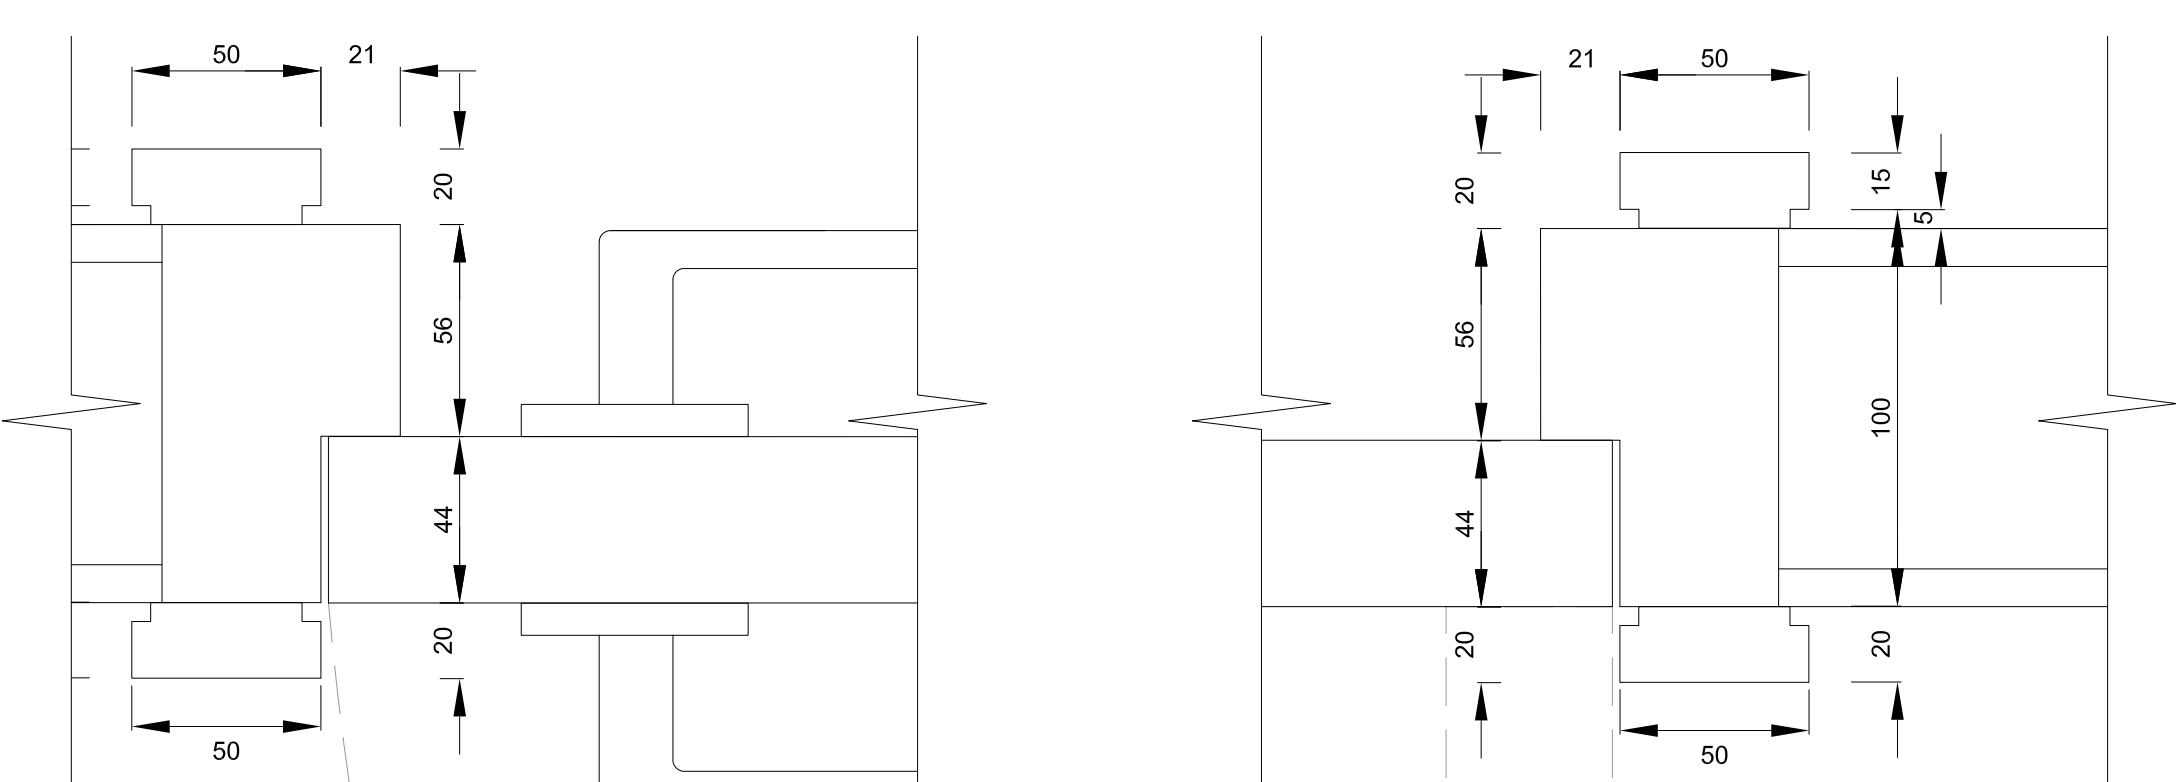

14
21
DETAIL 9
SCALE 1:2

22
21
DETAIL 10
SCALE 1:2

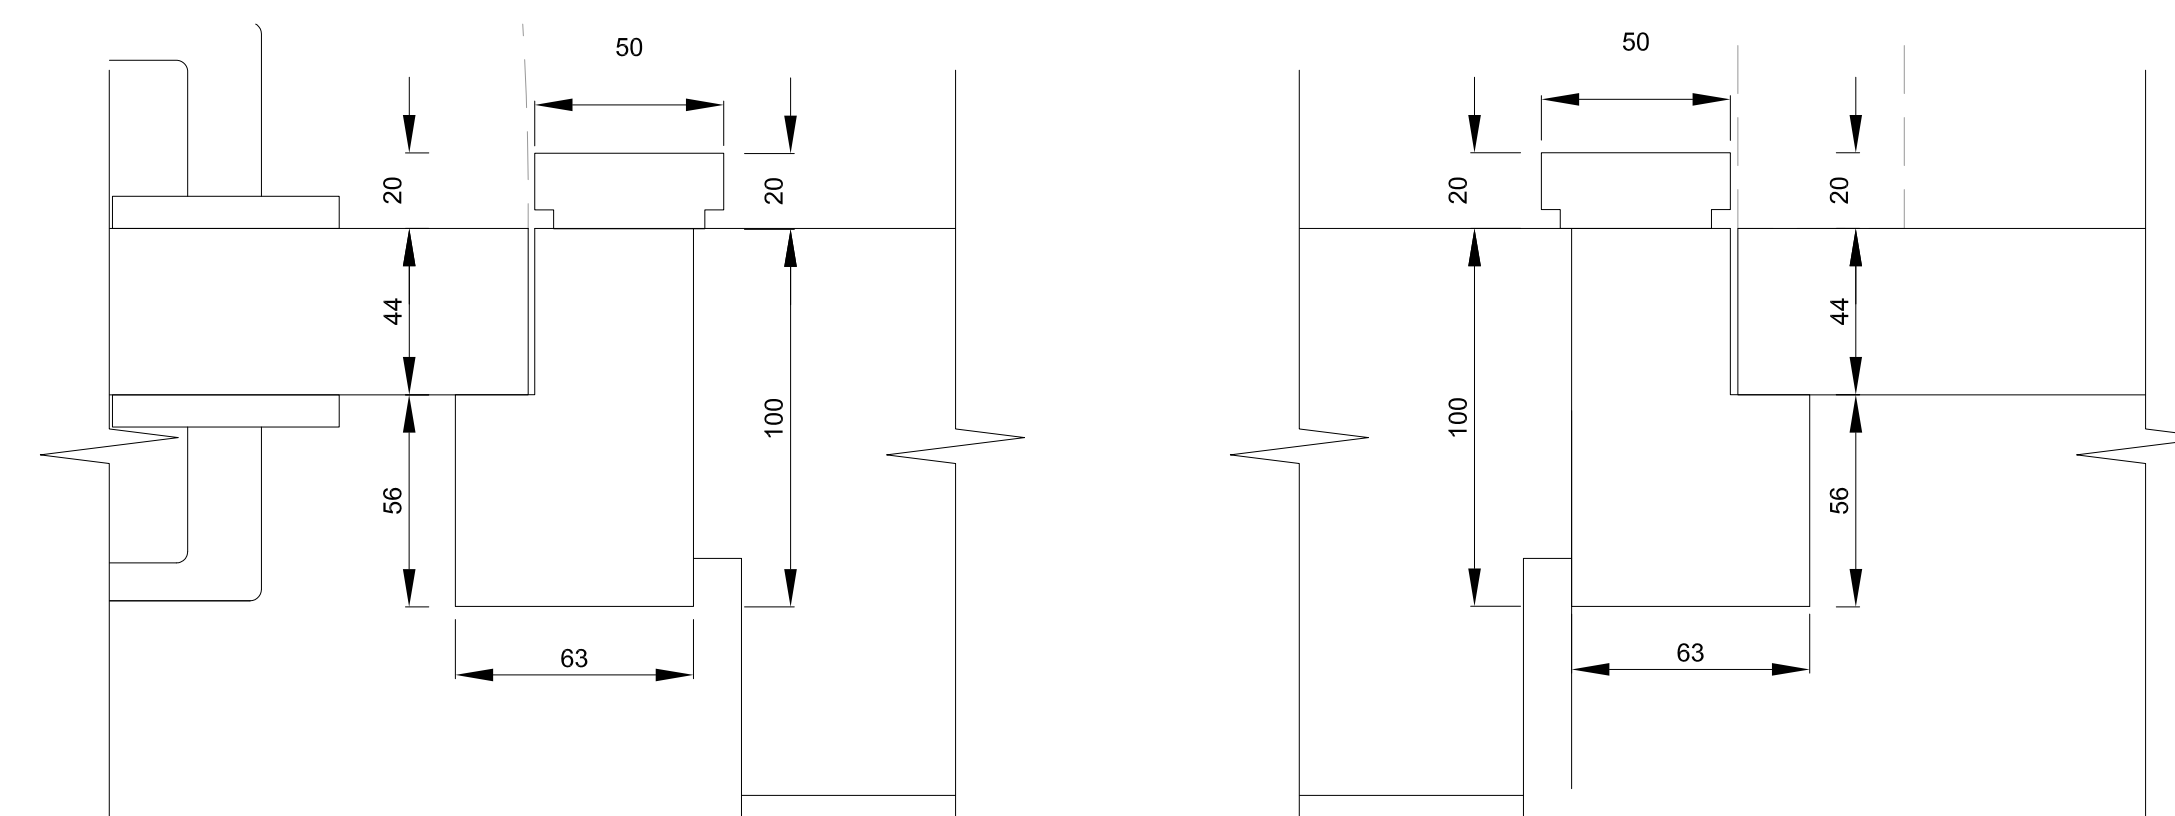

23
21
DETAIL 11
SCALE 1:2

24
21
DETAIL 12
SCALE 1:2

NOTES
DO NOT SCALE FROM DRAWING
ALL DIMENSIONS TO BE SITE VERIFIED BY CONTRACTOR
PRIOR TO MANUFACTURE OR CONSTRUCTION
CONTRACTOR TO REPORT ANY DISCREPANCIES TO NSG
IMMEDIATELY
CONTRACTOR TO PROVIDE SHOP DRAWINGS OF ALL
CUSTOM COMPONENTS FOR APPROVAL BY NSG PRIOR
TO MANUFACTURE
THE DRAWING AND THE WORKS DEPICTED ARE THE
COPYRIGHT OF LUMSDEN DESIGN LTD AND MAY NOT BE
REPRODUCED EXCEPT BY WRITTEN PERMISSION

MATERIALS LEGEND:


PLEASE NOTE:
CONTRACTOR TO PROVIDE SAMPLES
OF ALL MATERIALS FOR APPROVAL BY
NSG PRIOR TO CONSTRUCTION.

- METALWORK FINISHES
- M1 POWDER COAT
RAL 7010 - FARPAULIN GREY
SEMI-MATT FINISH 25%
 - M2 POWDER COAT
RAL 9002 - GREY / WHITE
SEMI-MATT FINISH 25%
 - M3 POWDER COAT
RAL 3031 - ORIENT RED
SEMI-MATT FINISH 25%
 - M4 BRUSHED
STAINLESS STEEL
 - M5 POWDER COAT
RAL 7038 - AGATE GREY
SEMI-MATT FINISH 25%
 - M6 BLACK SMOKED
METAL
- JOINERY FINISHES
- J1 BLACK STAINED
AMERICAN OAK
MATCH TO SAMPLE
 - J2 WHITE STAINED
CANADIAN MAPLE
MATCH TO SAMPLE
 - J3 NATURAL FINISH
AMERICAN OAK
MATCH TO SAMPLE
 - J4 SPRAY PAINTED MDF
DARK GREY BLACK
MATCH TO DULUX D9NN 0700
CLEAR LACQUER FINISH
 - J5 SPRAY PAINTED MDF - RED
MATCH TO DULUX 99HR 11475
CLEAR LACQUER FINISH
 - J6 SPRAY PAINTED MDF - STONE
MATCH TO DULUX 20YY 57060
CLEAR LACQUER FINISH
 - J7 SPRAY PAINTED SATIN WHITE
 - J8 DARK PAINT FINISH TO
MATCH EXISTING
- LAMINATE FINISHES
- L1 DARK GREY
POLYREY - FA-P114 POIVRE
- OTHER FINISHES
- C1 VALCHROMAT
COLOURED MDF - MID GREY
2-PACK CLEAR LACQUER FINISH
 - C2 Quartz Surfaces
Zodiaq® Dove Grey
www.dupont.com
 - S1 SILESTONE
BLANCO NORTE / WHITE NORTE
 - U1 BUTE FABRIC - LEWIS 2825
PRODUCT CODE: CF40-2825
100% PURE WOOL
- WALL FINISHES
- W1 HONED CONCRETE EFFECT
SKIM WALL RENDER
MATCH TO RAL 7044 SILK GREY
 - W2 HONED CONCRETE EFFECT
SKIM WALL RENDER
MATCH TO RAL 7030 STONE GREY

REV	DATE	DESCRIPTION	BY
-	SEPT 10 2015	ISSUED FOR TENDER	-


CLIENT	NATIONAL GALLERY OF CANADA
PROJECT	NEW RETAIL STORE
DRG	DOOR DETAILS 1
DRG No.	A-11
SCALE	1:10 @ AD
DATE	JUL 2015
DRAWN BY	RJC
SHEET NO.	A-12

2
DR07 (BOUTIQUE TO VACANT SPACE)

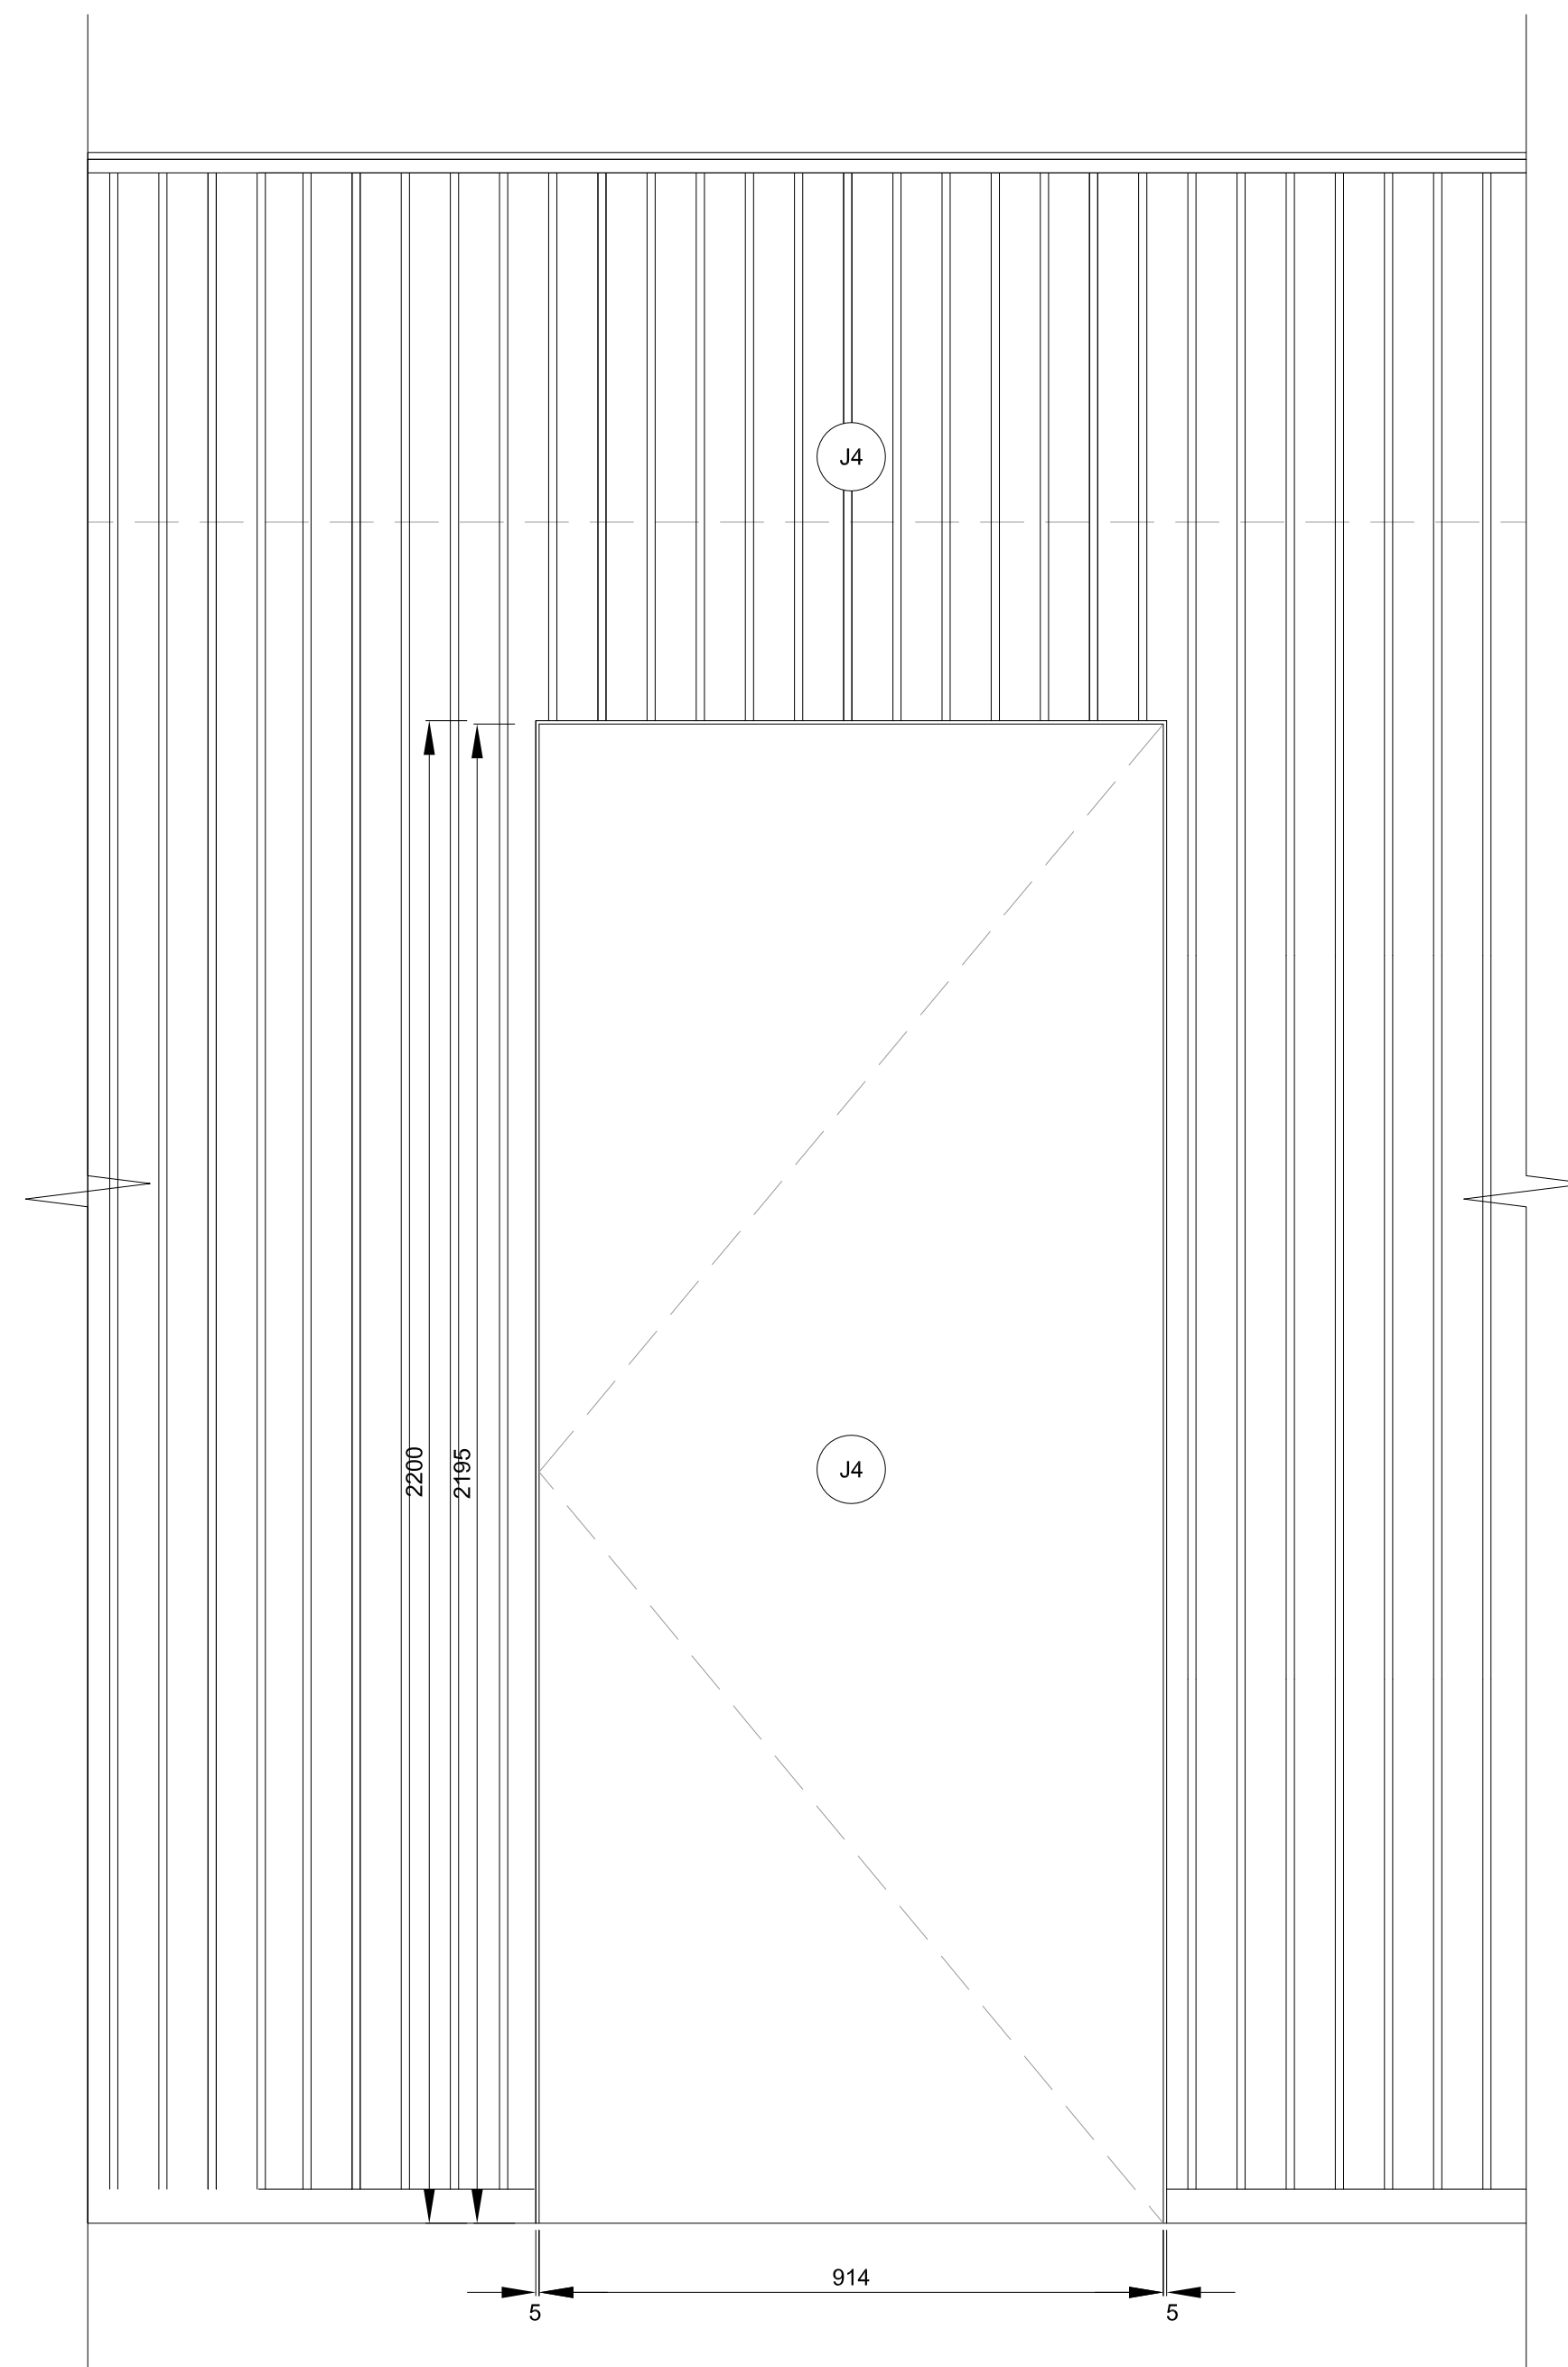


FRONT ELEVATION C

3

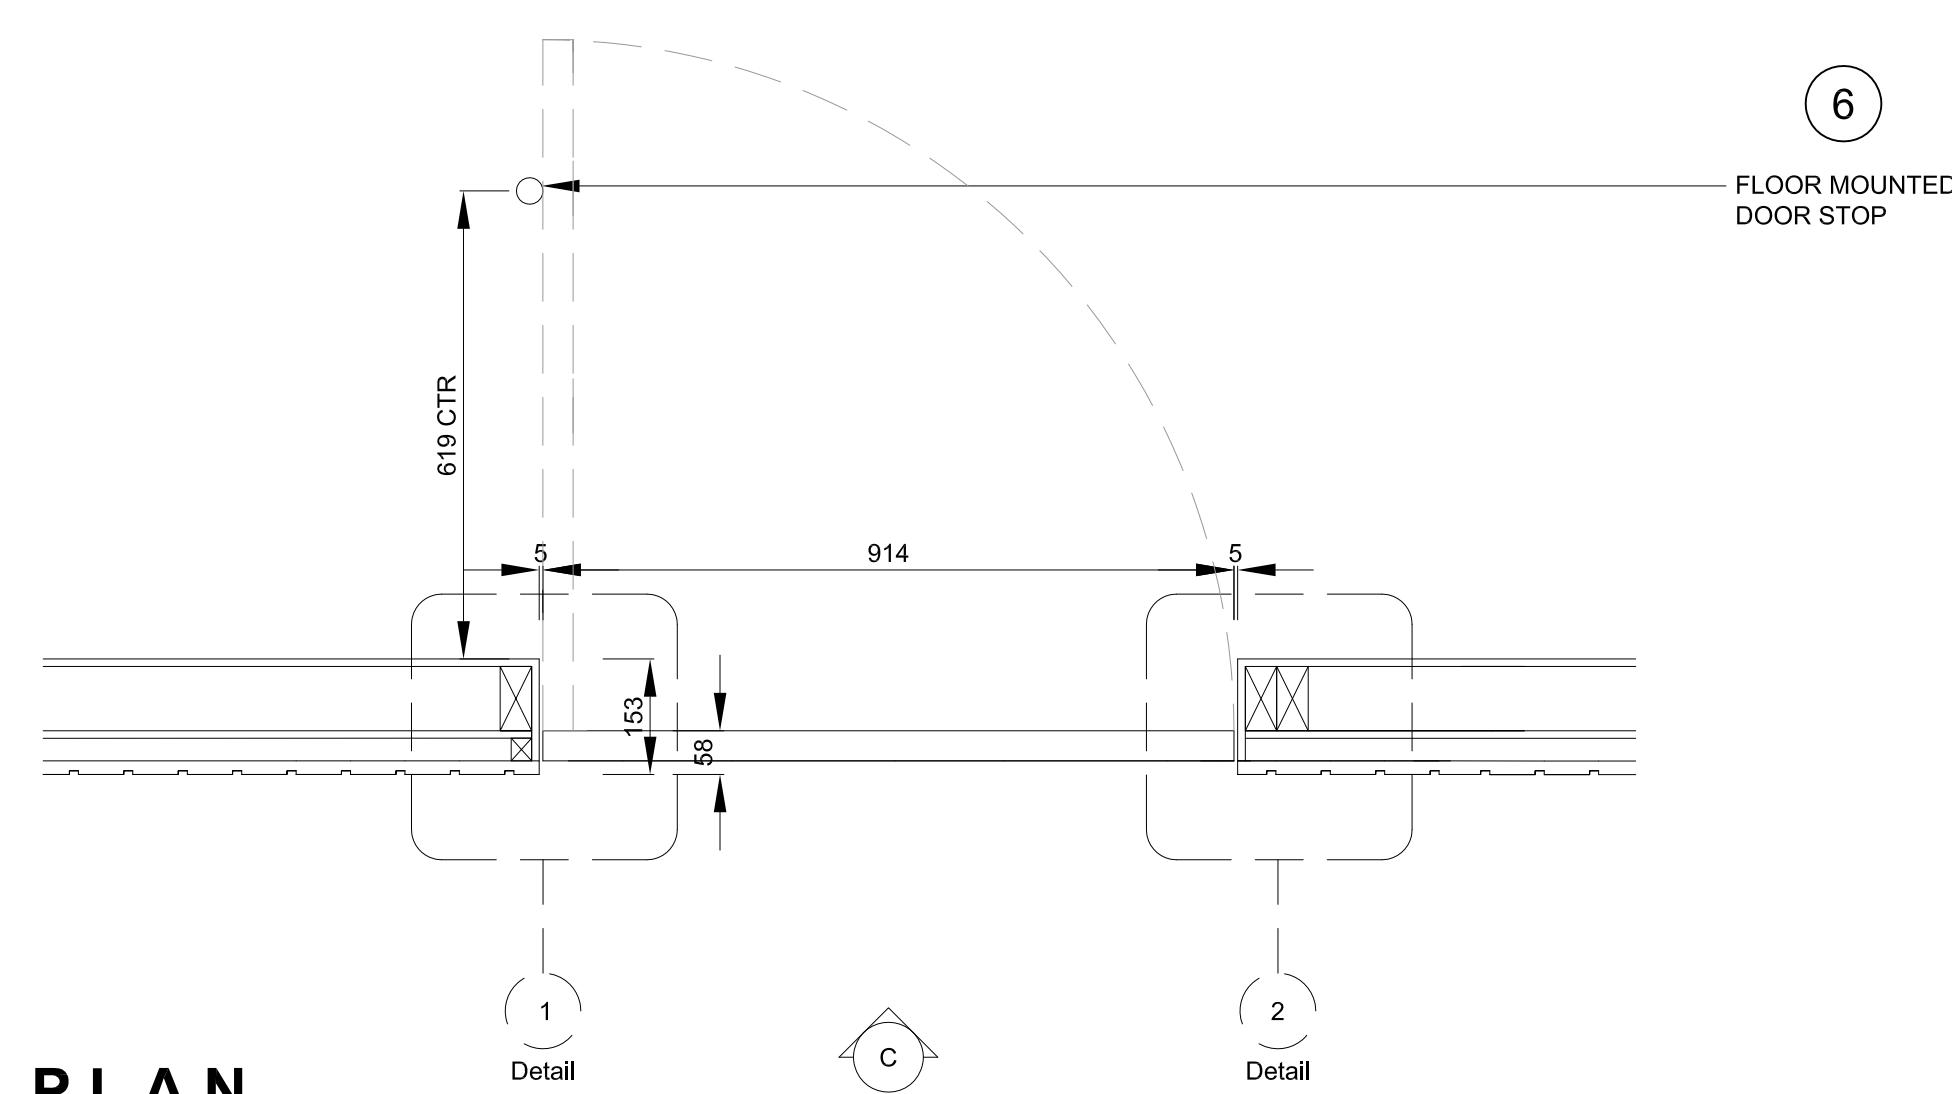

PLAN

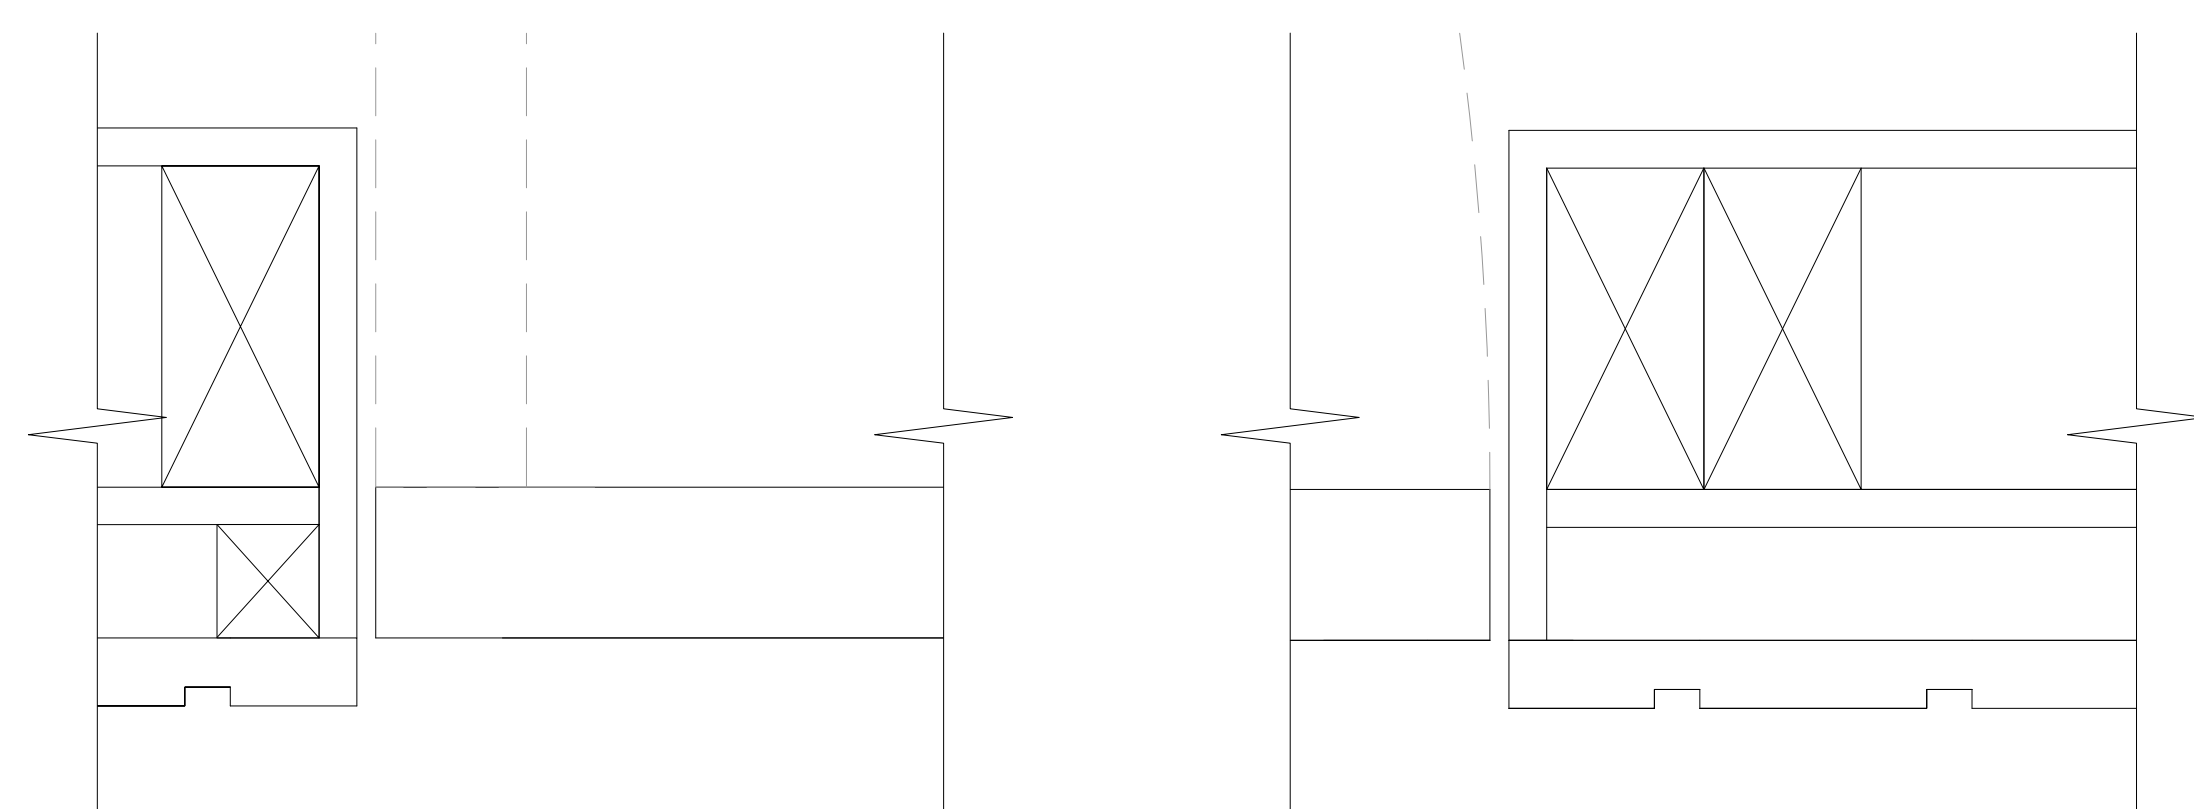

4
5
DETAIL 1
SCALE 1:2

45
5
DETAIL 2
SCALE 1:2

DR NO.	ROOM NAME	DOOR TYPE	SWING	W	H	FINISH	FRAME TYPE	WALL DEPTH	FINISH	HARDWARE LATCHSET	STOP	CLOSER	NOTES
DR 01	ELECTRICAL CLOSET	WD	LHR	954	FULL HEIGHT	CR	N/A	150	N/A	CONCEALED PULL	N/A	N/A	CUSTOM DOOR WITH INTEGRATED SHELVING; REFER TO MW06
DR 02	STORAGE ROOM ENTRANCE FROM BOUTIQUE	WD	LH	915	2200	PT	N/A	100	N/A	LEVER LOCKSET, CARD READER	YES	N/A	CUSTOM DOOR WITH PAINTED WOOD FINISH; REFER TO MILLWORK DRAWINGS
DR 03	STORAGE ROOM FROM HALLWAY	WD	LH	915	2200	ST	WD	248	PT	LEVER LOCKSET, CARD READER	YES	YES	
DR 04	ADMIN. OFFICE	WD	LH	915	2134	PT	WD	100	PT	OFFICE LOCKSET	YES	N/A	PEEPHOLE TO BE INSTALLED AT 1500mm AFF
DR 05	CHANGE ROOM	WD	RH	915	2134	PT	WD	100	PT	WASHROOM LOCKSET	YES	N/A	
DR 06	LOCKER ROOM	WD	LH	915	2134	PT	WD	150	PT	LEVER LOCKSET, CARD READER	YES	YES	PAINT TO MATCH EXISTING NGC BLACK DOOR
DR 07	EGRESS DOOR (BOUTIQUE TO VACANT AREA)	HMD	LH	915	2200	PT	HMF	150	PT	PANIC BAR EXIT, CARD READER	N/A	YES	PAINT TO MATCH SURROUNDING WALL FINISH CARD READER, MAG LOCK & PANIC BAR WITH DELAYED EGRESS

LEGEND:
 WD SOLID WOOD
 HMD HOLLOW METAL DOOR (45min FIRE RATED)
 HMF HOLLOW METAL FRAME (45min FIRE RATED)
 CR CONCRETE RENDER
 PT PAINTED
 GL-1 TEMPERED GLAZING 6MM
 ST WHITE STAINED MAPLE

NOTES
 DO NOT SCALE FROM DRAWING
 ALL DIMENSIONS TO BE SITE VERIFIED BY CONTRACTOR PRIOR TO MANUFACTURE OR CONSTRUCTION. CONTRACTOR TO REPORT ANY DISCREPANCIES TO NGC IMMEDIATELY.
 CONTRACTOR TO PROVIDE SHOP DRAWINGS OF ALL CUSTOM COMPONENTS FOR APPROVAL BY NGC PRIOR TO MANUFACTURE.
 THE DRAWING AND THE WORKS DEPICTED ARE THE COPYRIGHT OF LUMSDEN DESIGN LTD AND MAY NOT BE REPRODUCED EXCEPT BY WRITTEN PERMISSION.

MATERIALS LEGEND:

PLEASE NOTE:
 CONTRACTOR TO PROVIDE SAMPLES OF ALL MATERIALS FOR APPROVAL BY NGC PRIOR TO CONSTRUCTION.

- METALWORK FINISHES
- M1 POWDER COAT RAL 7010 - FARBPAULIN GREY SEMI-MATT FINISH 25%
 - M2 POWDER COAT RAL 9002 - GREY / WHITE SEMI-MATT FINISH 25%
 - M3 POWDER COAT RAL 3031 - ORIENT RED SEMI-MATT FINISH 25%
 - M4 BRUSHED STAINLESS STEEL
 - M5 POWDER COAT RAL 7038 - AGATE GREY SEMI-MATT FINISH 25%
 - M6 BLACK SMOKED METAL
- JOINERY FINISHES
- J1 BLACK STAINED AMERICAN OAK MATCH TO SAMPLE
 - J2 WHITE STAINED CANADIAN MAPLE MATCH TO SAMPLE
 - J3 NATURAL FINISH AMERICAN OAK MATCH TO SAMPLE
 - J4 SPRAY PAINTED MDF DARK GREY BLACK MATCH TO DULUX D9NN 0700 CLEAR LACQUER FINISH
 - J5 SPRAY PAINTED MDF -RED MATCH TO DULUX 99YR 11475 CLEAR LACQUER FINISH
 - J6 SPRAY PAINTED MDF -STONE MATCH TO DULUX 20Y 57060 CLEAR LACQUER FINISH
 - J7 SPRAY PAINTED SATIN WHITE
 - J8 DARK PAINT FINISH TO MATCH EXISTING
- LAMINATE FINISHES
- L1 DARK GREY POLYSEY - FA-P114 POIVRE
- OTHER FINISHES
- C1 VALCHROMAT COLOURED MDF - MID GREY 2-PACK CLEAR LACQUER FINISH
 - C2 Quartz Surfaces Zodiak® Dove Grey www.dupont.com
 - S1 SILESTONE BLANCO NORTE / WHITE NORTE
 - U1 BUTE FABRIC - LEWIS 2825 PRODUCT CODE: CF40-2825 100% PURE WOOL
- WALL FINISHES
- W1 HONED CONCRETE EFFECT SKIM WALL RENDER MATCH TO RAL 7044 SILK GREY
 - W2 HONED CONCRETE EFFECT SKIM WALL RENDER MATCH TO RAL 7030 STONE GREY

REV	DATE	DESCRIPTION	BY
-	SEPT 10 2015	ISSUED FOR TENDER	-

2 Commercial Street
 London EC1M 6DR UK
 T +44(0)20 3384 1400

CLIENT NATIONAL GALLERY OF CANADA
 PROJECT NEW RETAIL STORE
 ORG DOOR DETAILS 1

DRG No: A-11 REV -
 SCALE 1:10 @ A0 DATE JUL 2015
 DRAWN BY RJC
 SHEET NO. A-13