


exp Services Inc.
 t: +1.506.452.9000 | f: +1.506.459.3954
 1133 Regent Street, Suite 300
 Fredericton, NB E3B 3Z2
 CANADA
 www.exp.com



exp. Project No. FRE-00214763-A5

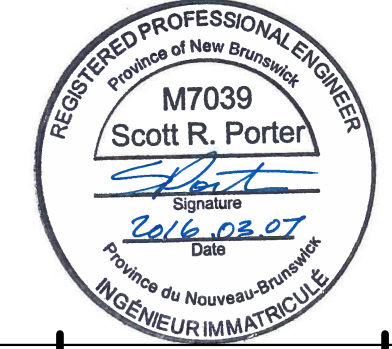

0 RELEASED FOR CONSTRUCTION 03/07/2016

revisions date
 project projet

**NEW
 G.O.C.B.
 SAINT LÉONARD
 NEW BRUNSWICK**

drawing dessin

BASE RADIO LAYOUT

designed SRP conçu

date 03/07/2016

drawn CAM dessiné

date 03/07/2016

approved DAG approuvé

date 03/07/2016

Tender Soumission

PWGSC Project Manager Administrateur de projets TPSGC


project number no. du projet

R.069499.001

drawing no. no. du dessin

2700-3

E-DRM/GDD-E: 535500

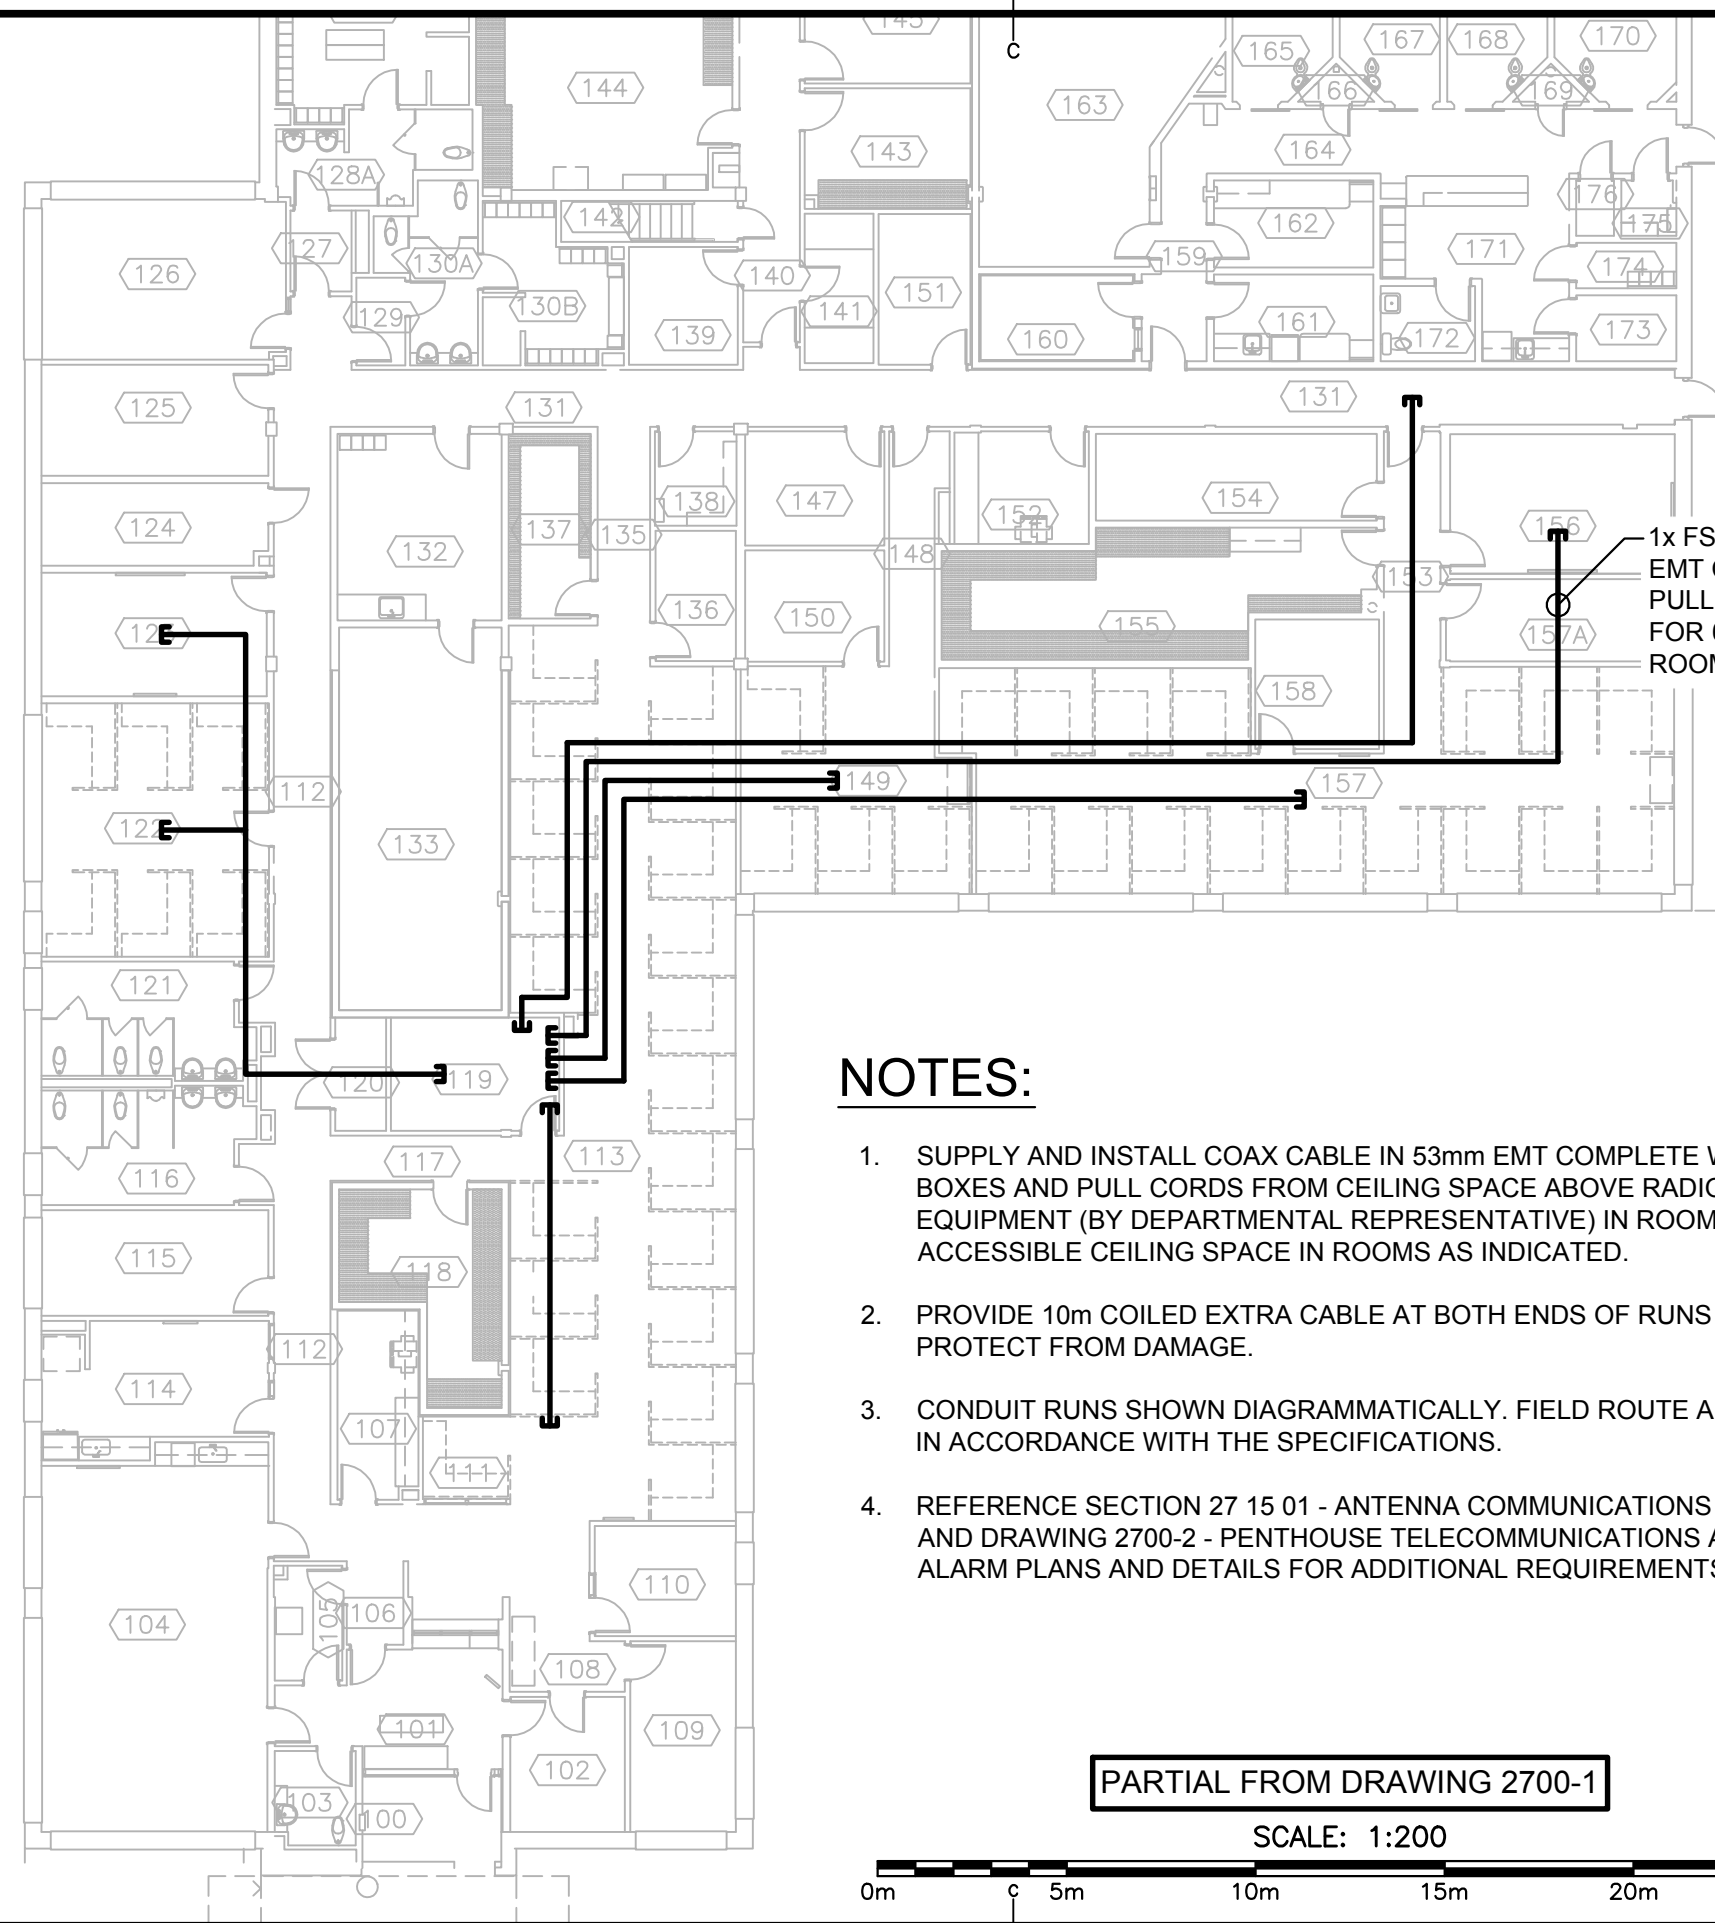

NOTES:

1. SUPPLY AND INSTALL COAX CABLE IN 53mm EMT COMPLETE WITH PULL BOXES AND PULL CORDS FROM CEILING SPACE ABOVE RADIO EQUIPMENT (BY DEPARTMENTAL REPRESENTATIVE) IN ROOM 119 TO ACCESSIBLE CEILING SPACE IN ROOMS AS INDICATED.
2. PROVIDE 10m COILED EXTRA CABLE AT BOTH ENDS OF RUNS AND PROTECT FROM DAMAGE.
3. CONDUIT RUNS SHOWN DIAGRAMMATICALLY. FIELD ROUTE AND VERIFY IN ACCORDANCE WITH THE SPECIFICATIONS.
4. REFERENCE SECTION 27 15 01 - ANTENNA COMMUNICATIONS CABLING AND DRAWING 2700-2 - PENTHOUSE TELECOMMUNICATIONS AND FIRE ALARM PLANS AND DETAILS FOR ADDITIONAL REQUIREMENTS.

PARTIAL FROM DRAWING 2700-1

SCALE: 1:200

