

AIR INTAKE DETAIL
SCALE: N.T.S.

DRAWING NOTES:


- ① RAISE AIR INTAKE TO 0.6m (24") ABOVE ROOF. EXTEND ROOF CURB.
- ② REMOVE AND REINSTALL EXHAUST FAN. DISCONNECT AND RECONNECT POWER.
- ③ REPLACE ROOF DRAIN
- ④ REMOVE AND REINSTALL CONDENSING UNIT, DISCONNECT AND RECONNECT REFRIGERANT PIPES, POWER, AND CONTROLS WIRING.
- ⑤ LIFT AND PAINT GAS PIPE, MOUNT GAS PIPE AS REQUIRED TO 200 (8") ABOVE ROOF.
- ⑥ MODIFY GAS RISER FOR NEW ROOF HEIGHT.
- ⑦ REMOVE AND REINSTALL RTU. DISCONNECT AND RECONNECT POWER SUPPLY, CONTROLS AND GAS PIPE.
- ⑧ REMOVE AND REINSTALL ROUND AIR INTAKE.
- ⑨ REMOVE CABLE SUPPORTS AND LIFT CABLES FOR ROOFING WORK. PROVIDE TEMPORARY SUPPORTS AS NECESSARY. PROVIDE NEW SUPPORTS FOR CABLE RUNS. PERMANENT SUPPORTS SHALL BE INSTALLED AT NO MORE THAN 1500MM SPANS.
- ⑩ EXISTING SATELLITE DISH AND ANTENNA CABLES TO BE REMOVED/REROUTED AND REINSTALLED.
- ⑪ EXISTING WEATHER STATIONS TO BE REMOVED AND REINSTALLED BY OTHERS. (N.I.C.)
- ⑫ REMOVE EXHAUST FAN, STACK, AND DUCT. REINSTALL. DISCONNECT AND RECONNECT POWER.
- ⑬ REMOVE AND REINSTALL EXHAUST HOODS.

GENERAL NOTES:


- a) ALL DIMENSIONS SHOWN REPRESENT EXISTING CURB HEIGHT ABOVE ROOF OR GAS PIPE HEIGHT. (EXCEPT ROOF DRAINS)
- b) UNLESS OTHERWISE NOTED, ALL GAS PIPING IS TO BE LIFTED, REPAINTED AND PROPERLY SUPPORTED.
- c) STACKS SHOWN FOR REFERENCE ONLY. FLASHING MODIFICATION BY CONTRACTOR.

LEGEND

	ACCESS HATCH
	ROUND AIR INTAKE
	STACK
	FRESH AIR INTAKE HOOD
	EXHAUST FAN
	ROOF DRAIN, SIZE IN mm (INCHES)
	CONDENSING UNIT
	ROOFTOP HVAC UNIT
	GAS PIPE
	POWER CABLE
	WEATHER STATION

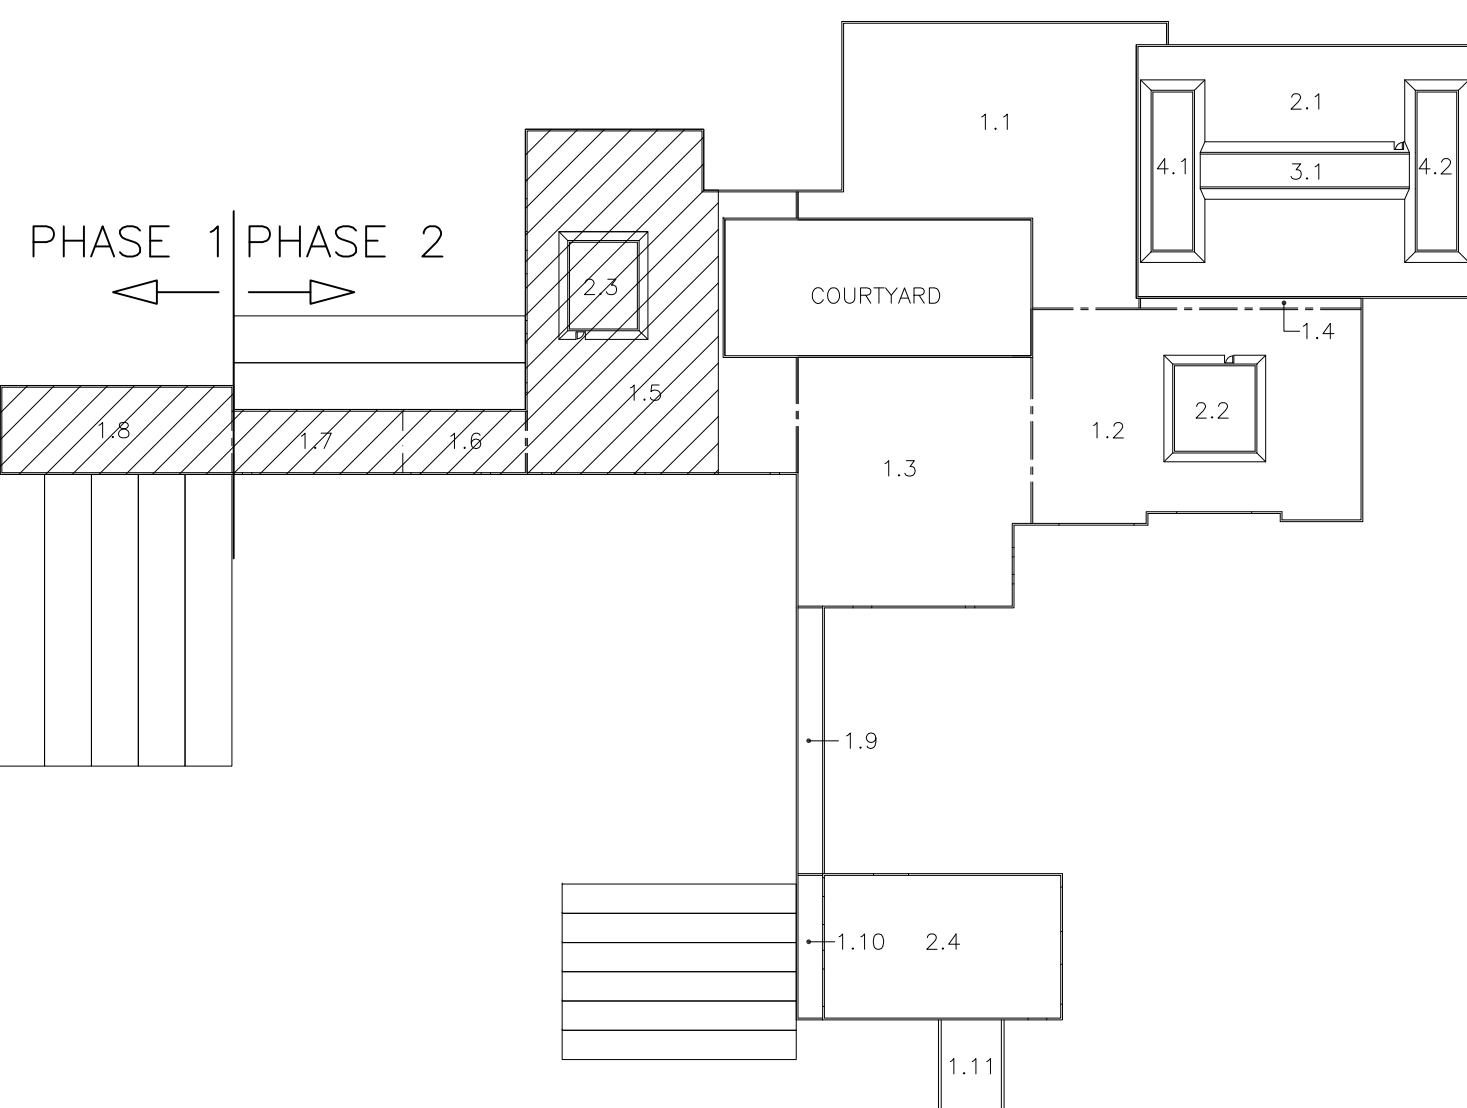

KEYPLAN
N.T.S.

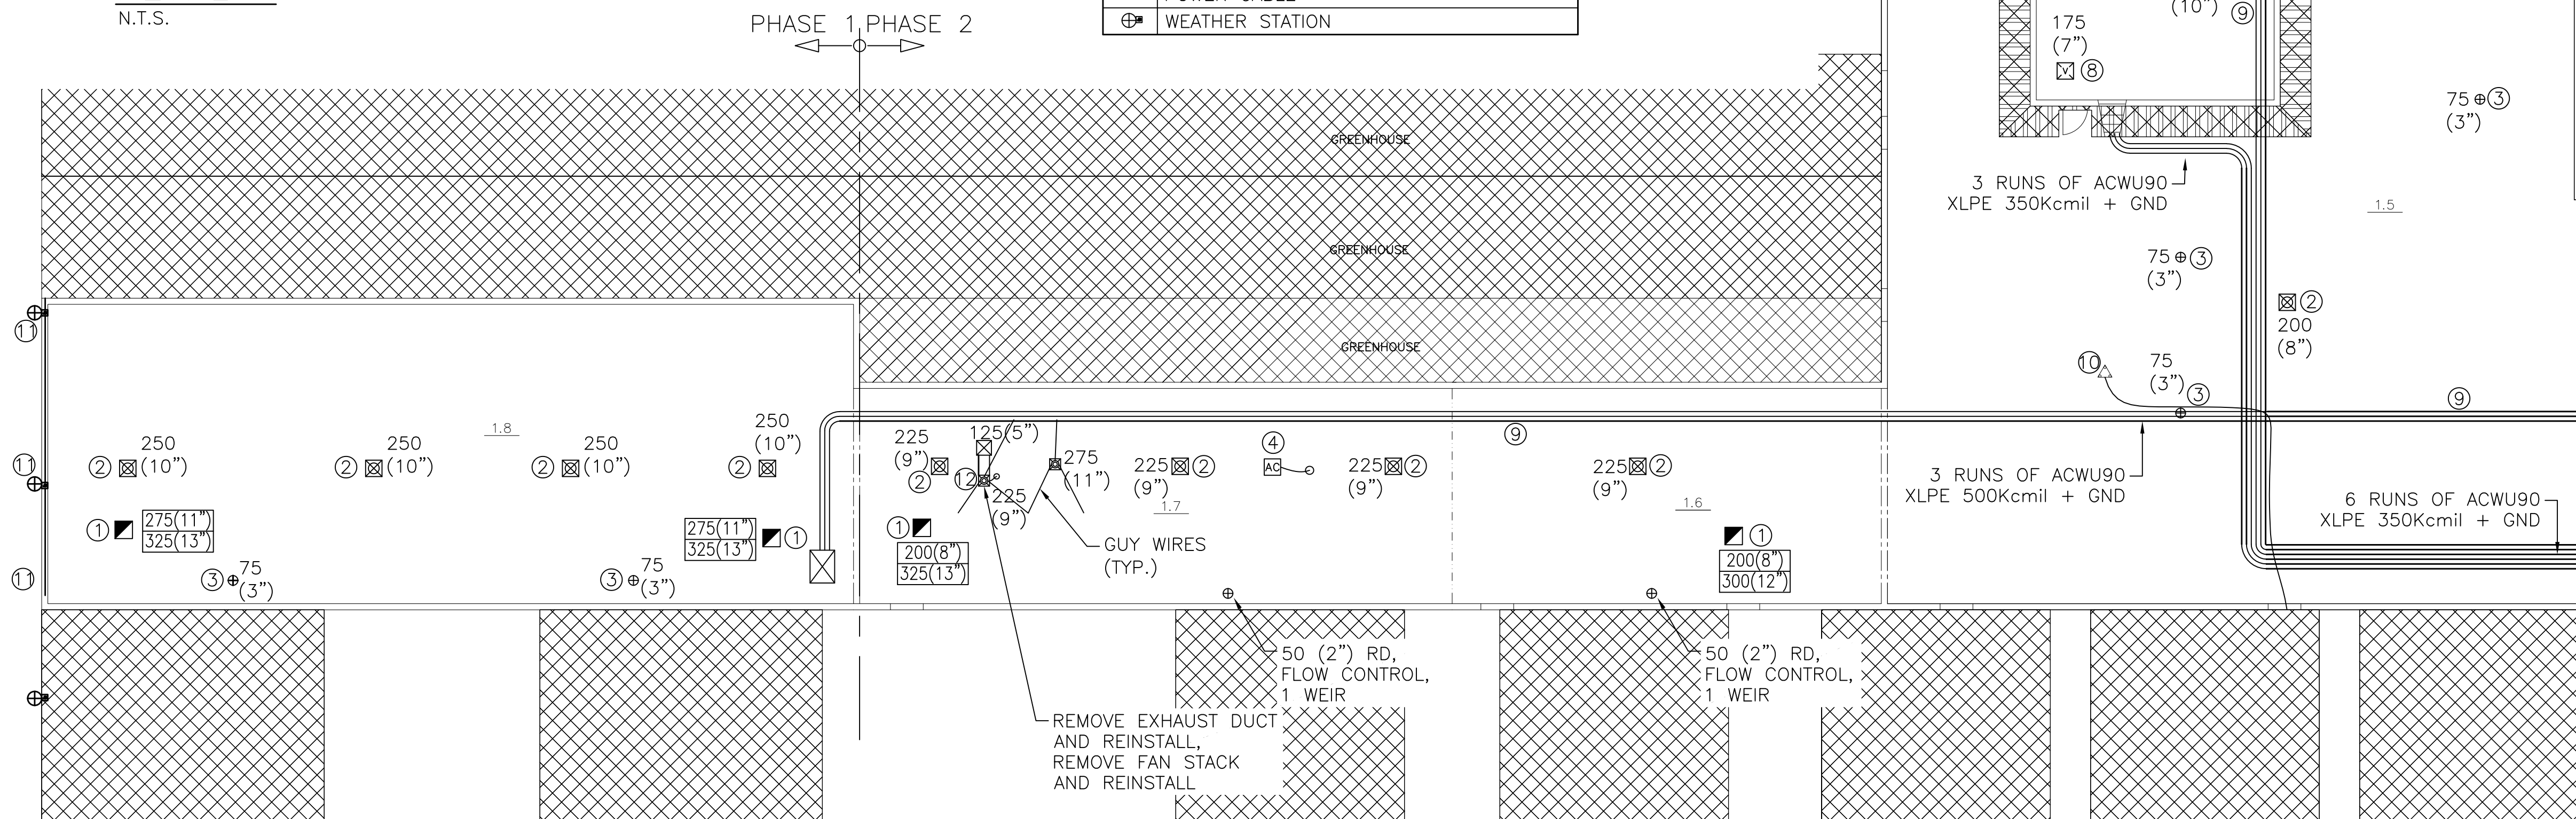

Public Works and
Government Services Canada
Architectural and Engineering Services
Ontario Region
Travaux publics et
Services gouvernementaux Canada
Services d'architecture et de génie
Région de l'Ontario




Brantford Studio K-W Studio
127 Brant Ave., Brantford, 564 Weber St. N., Suite 1, Waterloo,
ON N3T 3H5 ON N2L 5C8
519.756.6331 1.877.789.6662 519.575.2227 1.877.789.6662
www.mmmc.on.ca

IRC BUILDING SCIENCES GROUP
VANCOUVER - CALGARY - LONDON - MISSISSAUGA - OTTAWA - MONTRÉAL
TOLL FREE: 1-888-607-5245 TEL: 905-607-7244
WWW.IRCGROUP.COM FAX: 905-607-7288

MELEX
ENGINEERING LTD.

2453 MAIN STREET, P.O. BOX 93
LONDON, ONTARIO N6P 1P9
TEL: (519) 652-1193
FAX: (519) 652-0112
www.melex.on.ca

STAMP

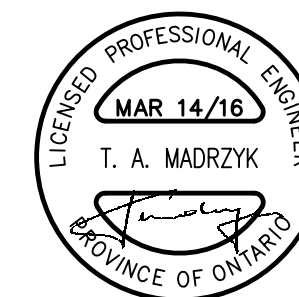

04		
03	ADDENDUM	JUN. 16/16
02	TENDER	APR. 18/16
01	CLIENT REVIEW	MAR. 14/16
revision		date

Do not scale drawings.
Verify all dimensions and conditions on site and immediately
notify the Departmental Representative of all discrepancies.

A	Detail No.
B	No. du détail
C	drawing no. - where detail required dessin no. - où détail exigé
C	drawing no. - where detailed dessin no. - où détaillé

project title
titre du projet
HARROW Ontario
AGRICULTURE & AGRI-FOODS CANADA
2585 COUNTY ROAD 20

ROOF REPLACEMENT

drawing title
titre du dessin
PARTIAL ROOF PLAN
PHASES 1 & 2

drawn by
dessiné par
MELEX ENG: R.A.

designed by
conçu par
MELEX ENG: T.M.


approved by
approuvé par
MELEX ENG: T.M.

bid
offre
M.B.

project date
date du projet
2016-04-04

project no.
no. du projet
R.076726.001

drawing no.
dessiné no.
ME1

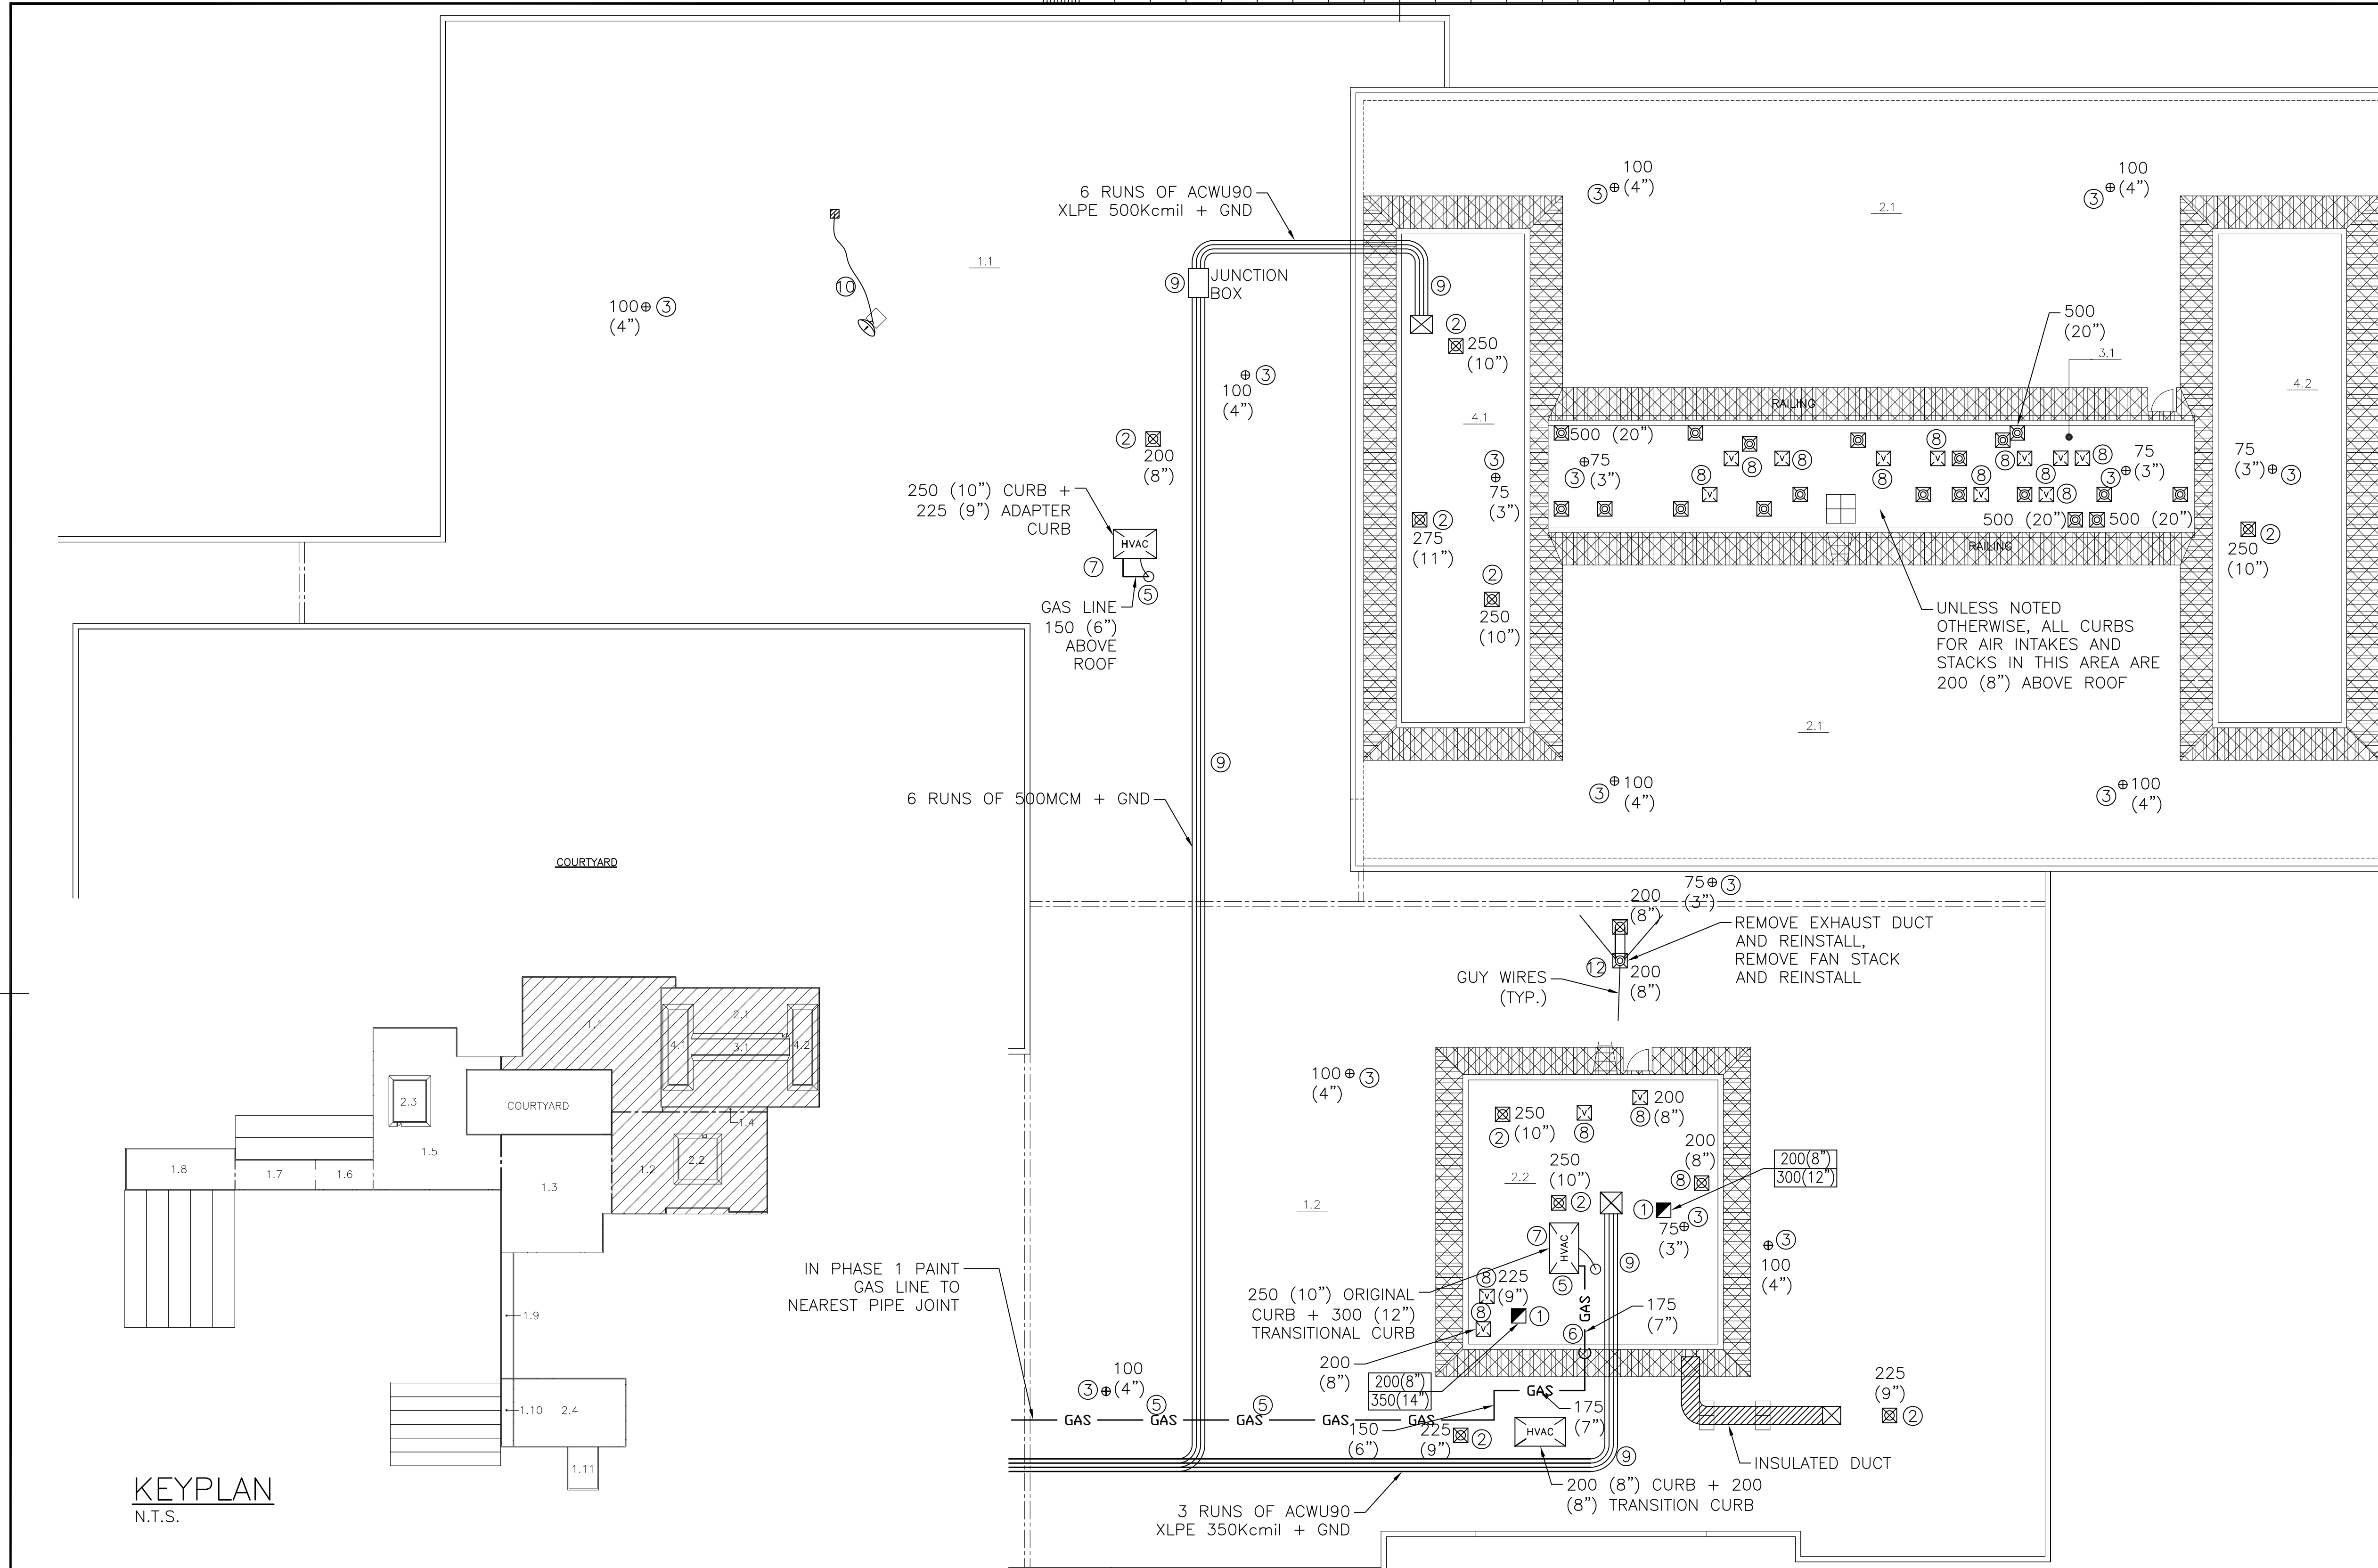**DRAWING NOTES:**

- ① RAISE AIR INTAKE TO 0.6m (24") ABOVE ROOF. EXTEND ROOF CURB.
- ② REMOVE AND REINSTALL EXHAUST FAN. DISCONNECT AND RECONNECT POWER.
- ③ REPLACE ROOF DRAIN
- ④ REMOVE AND REINSTALL CONDENSING UNIT, DISCONNECT AND RECONNECT REFRIGERANT PIPES, POWER, AND CONTROLS WIRING.
- ⑤ LIFT AND PAINT GAS PIPE, MOUNT GAS PIPE AS REQUIRED TO 200 (8") ABOVE ROOF.
- ⑥ MODIFY GAS RISER FOR NEW ROOF HEIGHT.
- ⑦ REMOVE AND REINSTALL RTU. DISCONNECT AND RECONNECT POWER SUPPLY, CONTROLS AND GAS PIPE.
- ⑧ REMOVE AND REINSTALL ROUND AIR INTAKE.
- ⑨ REMOVE CABLE SUPPORTS AND LIFT CABLES FOR ROOFING WORK. PROVIDE TEMPORARY SUPPORTS AS NECESSARY. PERMANENT SUPPORTS SHALL BE INSTALLED AT NO MORE THAN 1500MM SPANS.
- ⑩ EXISTING SATELLITE DISH AND ANTENNA CABLES TO BE REMOVED/REROUTED AND REINSTALLED.
- ⑪ EXISTING WEATHER STATIONS TO BE REMOVED AND REINSTALLED BY OTHERS. (N.I.C.)
- ⑫ REMOVE EXHAUST FAN, STACK, AND DUCT. REINSTALL. DISCONNECT AND RECONNECT POWER.
- ⑬ REMOVE AND REINSTALL EXHAUST HOODS.

LEGEND

	ACCESS HATCH
	ROUND AIR INTAKE
	STACK
	FRESH AIR INTAKE HOOD
	EXHAUST FAN
	ROOF DRAIN, SIZE IN mm (INCHES)
	x(x") - CURB HEIGHT mm (INCHES) y(y") - HEIGHT OF INLET ABOVE ROOF mm (INCHES)
	CONDENSING UNIT
	ROOFTOP HVAC UNIT
	GAS PIPE
	POWER CABLE
	WEATHER STATION


GENERAL NOTES:

- a) ALL DIMENSIONS SHOWN REPRESENT EXISTING CURB HEIGHT ABOVE ROOF OR GAS PIPE HEIGHT. (EXCEPT ROOF DRAINS)
- b) UNLESS OTHERWISE NOTED, ALL GAS PIPING IS TO BE LIFTED, REPAINTED AND PROPERLY SUPPORTED.
- c) STACKS SHOWN FOR REFERENCE ONLY. FLASHING MODIFICATION BY CONTRACTOR.



Public Works and
Government Services Canada
Architectural and Engineering Services
Ontario Region

Travaux publics et
Services gouvernementaux Canada
Services d'architecture et de génie
Région de l'Ontario

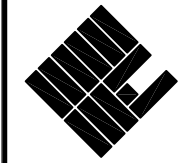**MMC ARCHITECTS**

Brantford Studio K-W Studio
127 Brant Ave., Brantford, 564 Weber St. N., Suite 1, Waterloo,
ON N3T 3H5 ON N2L 5C8
519.756.6331 1.877.789.6662 519.575.2227 1.877.789.6662
www.mmc.on.ca



IRC BUILDING SCIENCES GROUP
VANCOUVER • CALGARY • LONDON • MISSISSAUGA • OTTAWA • MONTREAL
TOLL FREE: 1-888-607-5245 TEL: 905-607-7244
WWW.IRCGROUP.COM FAX: 905-607-7288

MELEX
ENGINEERING LTD.

2453 MAIN STREET, P.O. BOX 93
LONDON, ONTARIO N6P 1P9
TEL: (519) 652-1193
FAX: (519) 652-0112
www.melex.on.ca

STAMP



04		
03	ADDENDUM	JUN. 16/16
02	TENDER	APR. 18/16
01	CLIENT REVIEW	MAR. 14/16
revision		date

Do not scale drawings.
Verify all dimensions and conditions on site and immediately
notify the Departmental Representative of all discrepancies.

A	Detail No.
B	No. du détail
C	drawing no. - where detail required dessin no. - où détail exigé
	drawing no. - where detailed dessin no. - où détaillé

project title
titre du projet
HARROW Ontario
AGRICULTURE & AGRI-FOODS CANADA
2585 COUNTY ROAD 20

ROOF REPLACEMENT

drawing title
titre du dessin
PARTIAL ROOF PLAN
PHASE 1

drawn by
dessiné par
MELEX ENG: R.A.

designed by
conçue par
MELEX ENG: T.M.

approved by
approuvé par
MELEX ENG: T.M.

bid
offre
M.B.

project manager
administrateur
de projets

project date
date du projet
2016-04-04

project no.
no. du projet
R.076726.001

drawing no.
dessiné no.
ME2

