

Correctional Service
of Canada

Service Correctionnel
du Canada

LIST OF DRAWINGS

CIVIL

C-101 SITE PLAN AND PUMPING STATION

ELECTRICAL

C-501 SINGLE LINE DIAGRAM AND ELECTRICAL LAYOUT


CAMPBELLFORD, ONTARIO.
WARKWORTH INSTITUTION
PFV PUMPING STATION

CSC Proj. No.: 460--2507--0


ISSUED FOR
TENDER

DATE: APRIL 12, 2016


Canada

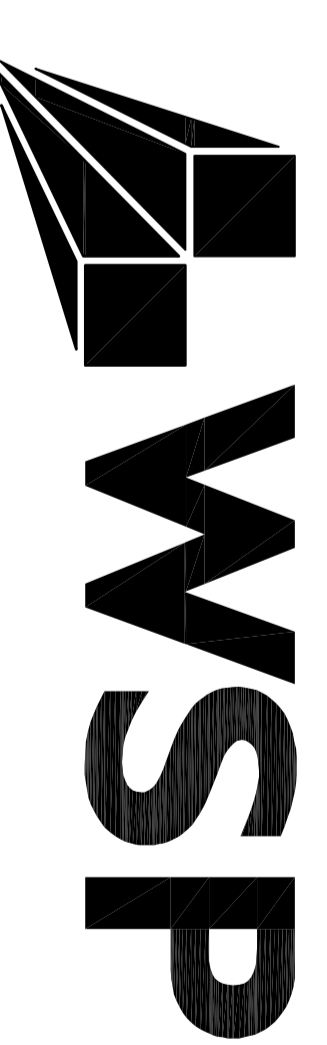


WSP CANADA INC.
1224 GARDINERS ROAD, SUITE 201, KINGSTON, ON
TEL: (613) 634-7373
FAX: (613) 634-3523
WEBSITE: www.wspgroup.com

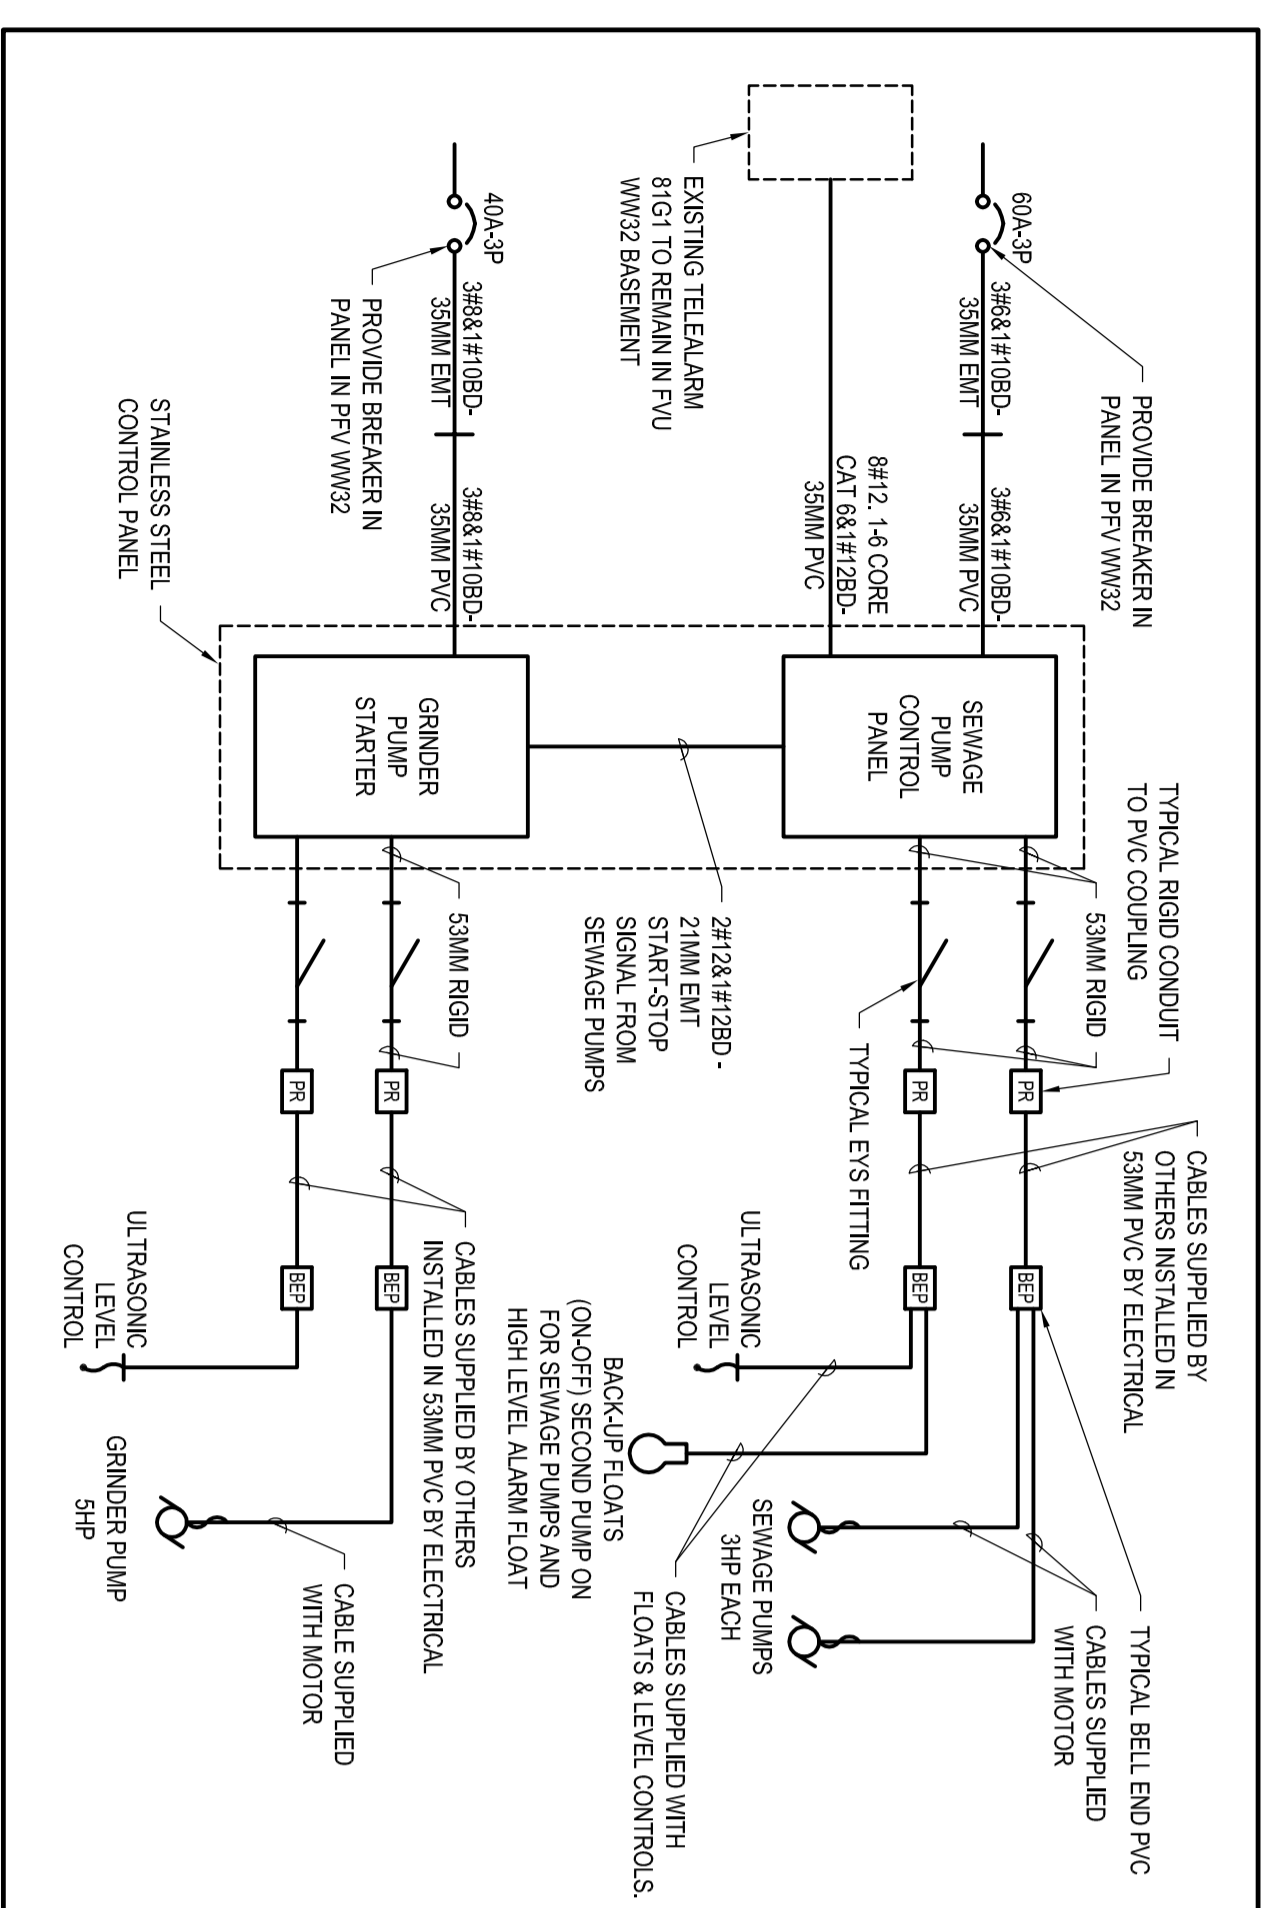

A SINGLE LINE DIAGRAM
SCALE: NTS

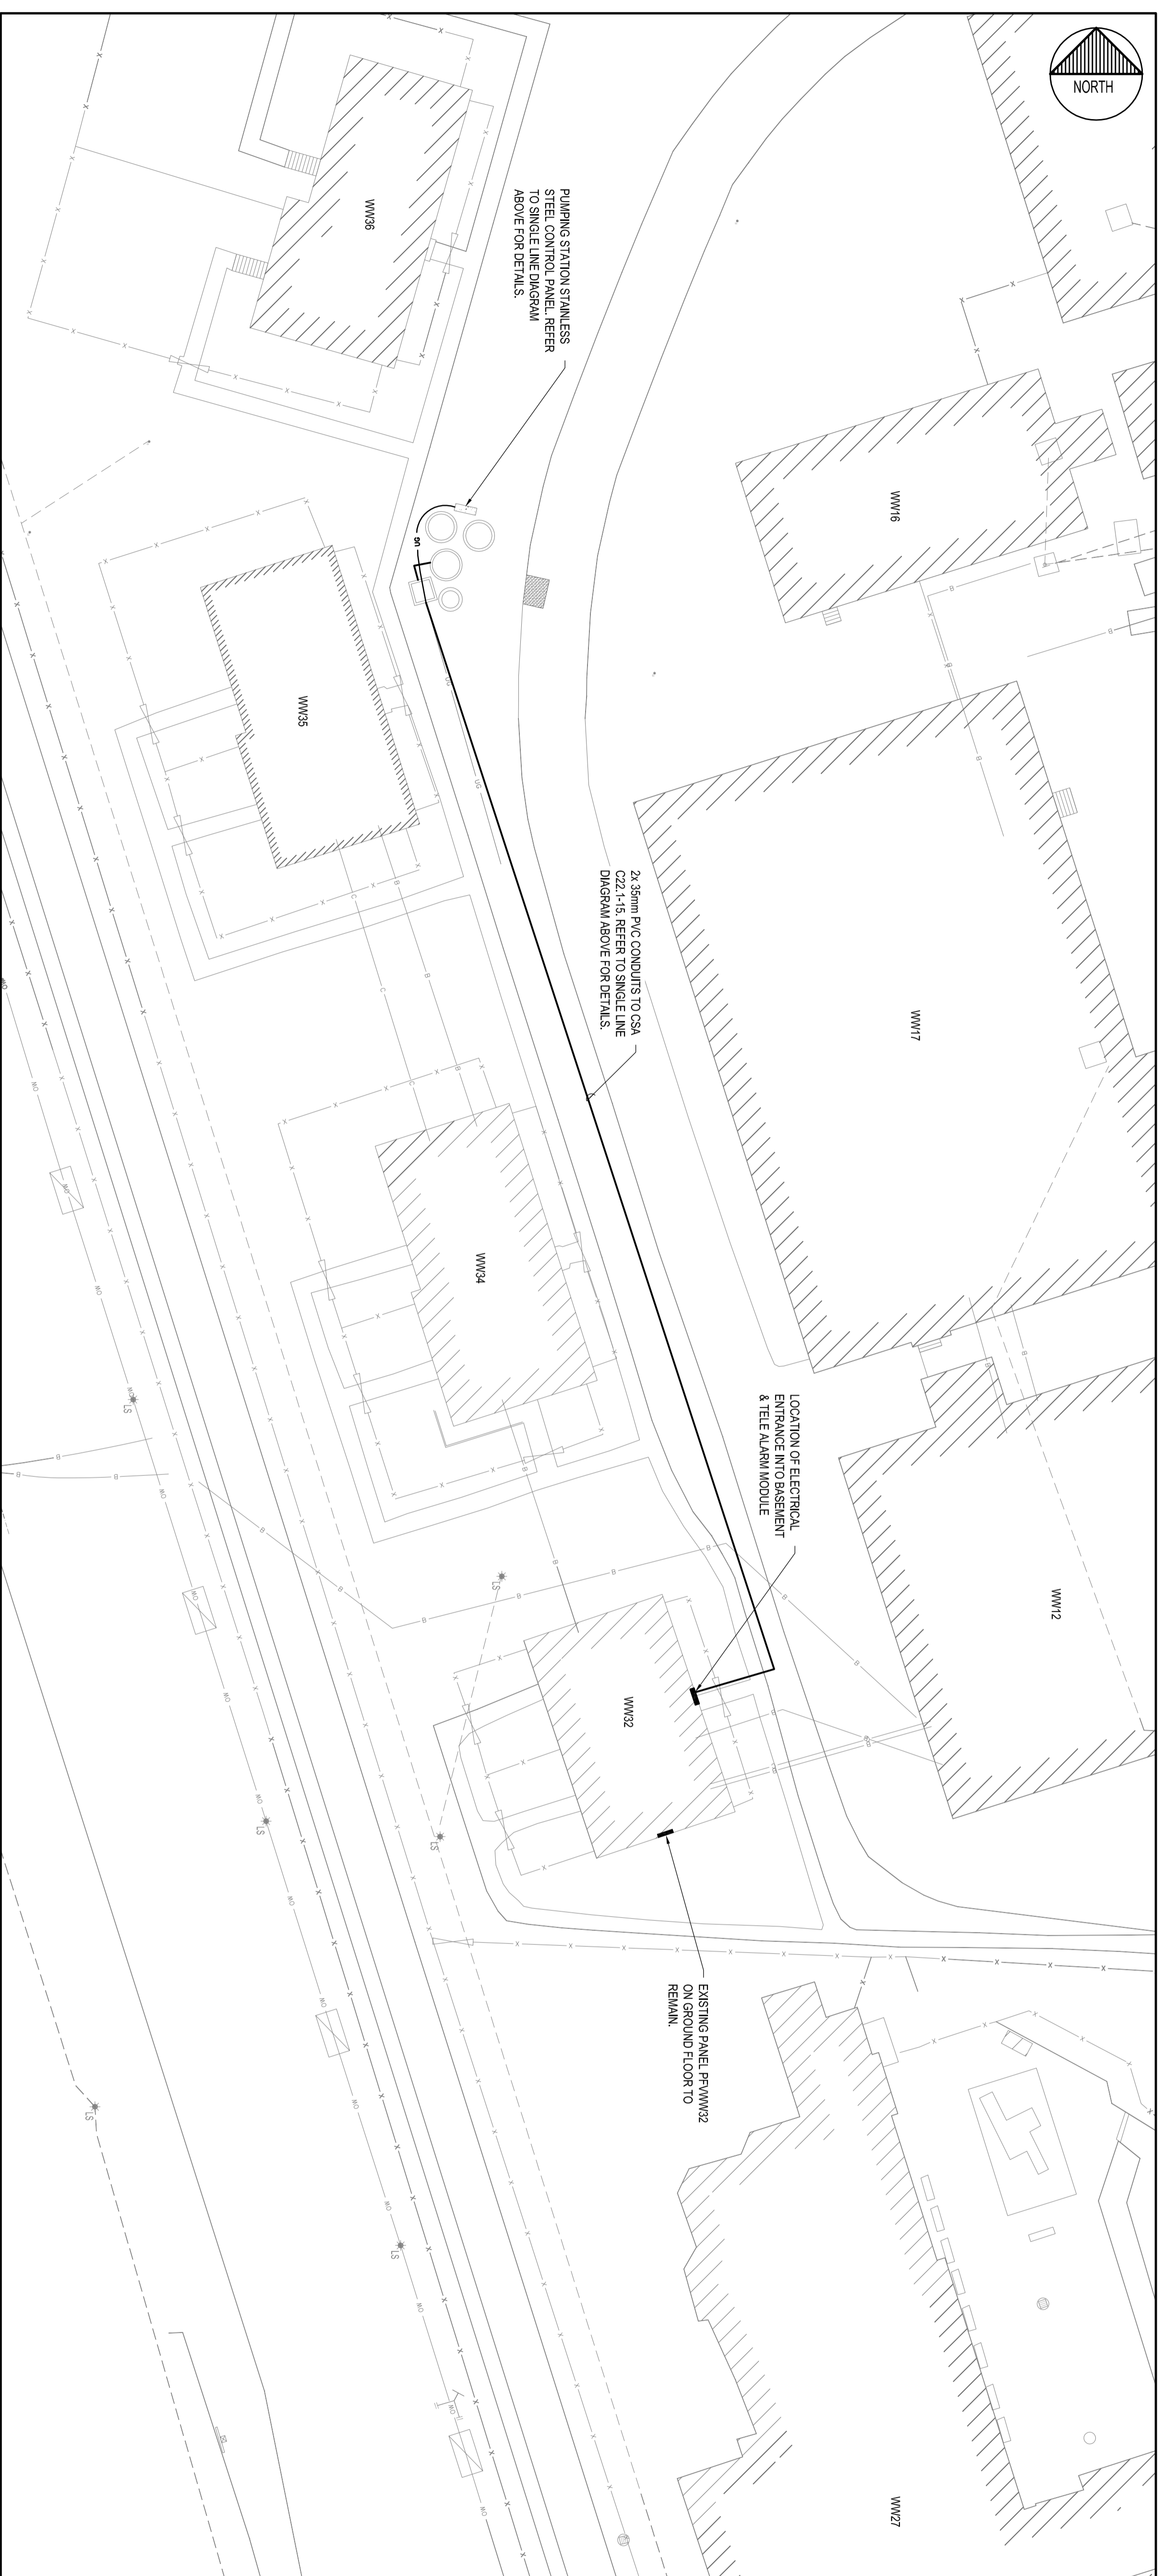


B ELECTRICAL LAYOUT
SCALE: 1:250


 


1:250

Operational Service
of
Service Operational
di Service

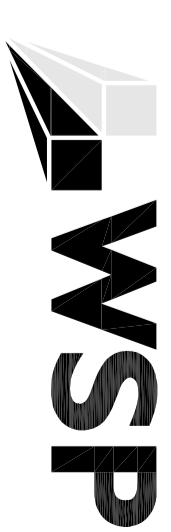

1224 GARDNER ROAD, SUITE 201
CAMBELLFORD, ONTARIO
PHONE: 615-454-4333
WWW.WSPGROUP.COM

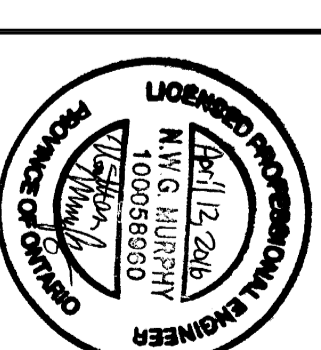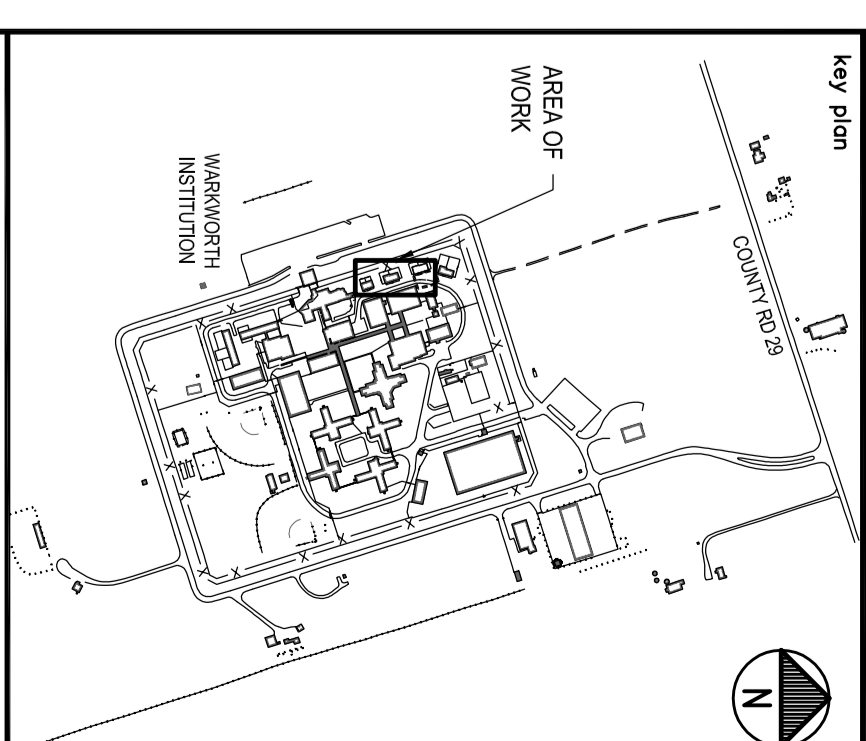

04		
03		
02		
01	ISSUED FOR TENDER	2016-04-12
revision		date

Do not scale drawings. Verify all dimensions and conditions on site and immediately notify the supervisory representative of all discrepancies.

A Detail No. - where detail required
B drawing no. - du detail enqit
C design no. - du detail

project title
Campbellford
Warkworth Institution
Ontario

drawing title
SINGLE LINE DIAGRAM
AND ELECTRICAL LAYOUT

drawn by
ML

designed by
GL

approved by
NMI

project date
April 2016

project no.
460-2507-0

drawing no.
E501