
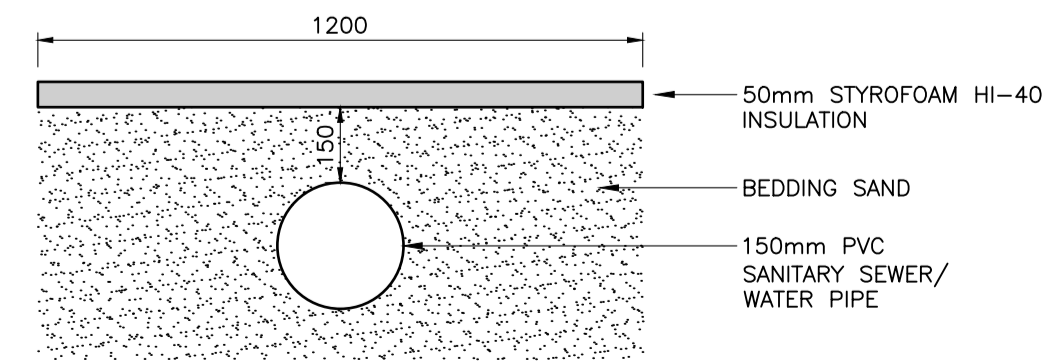
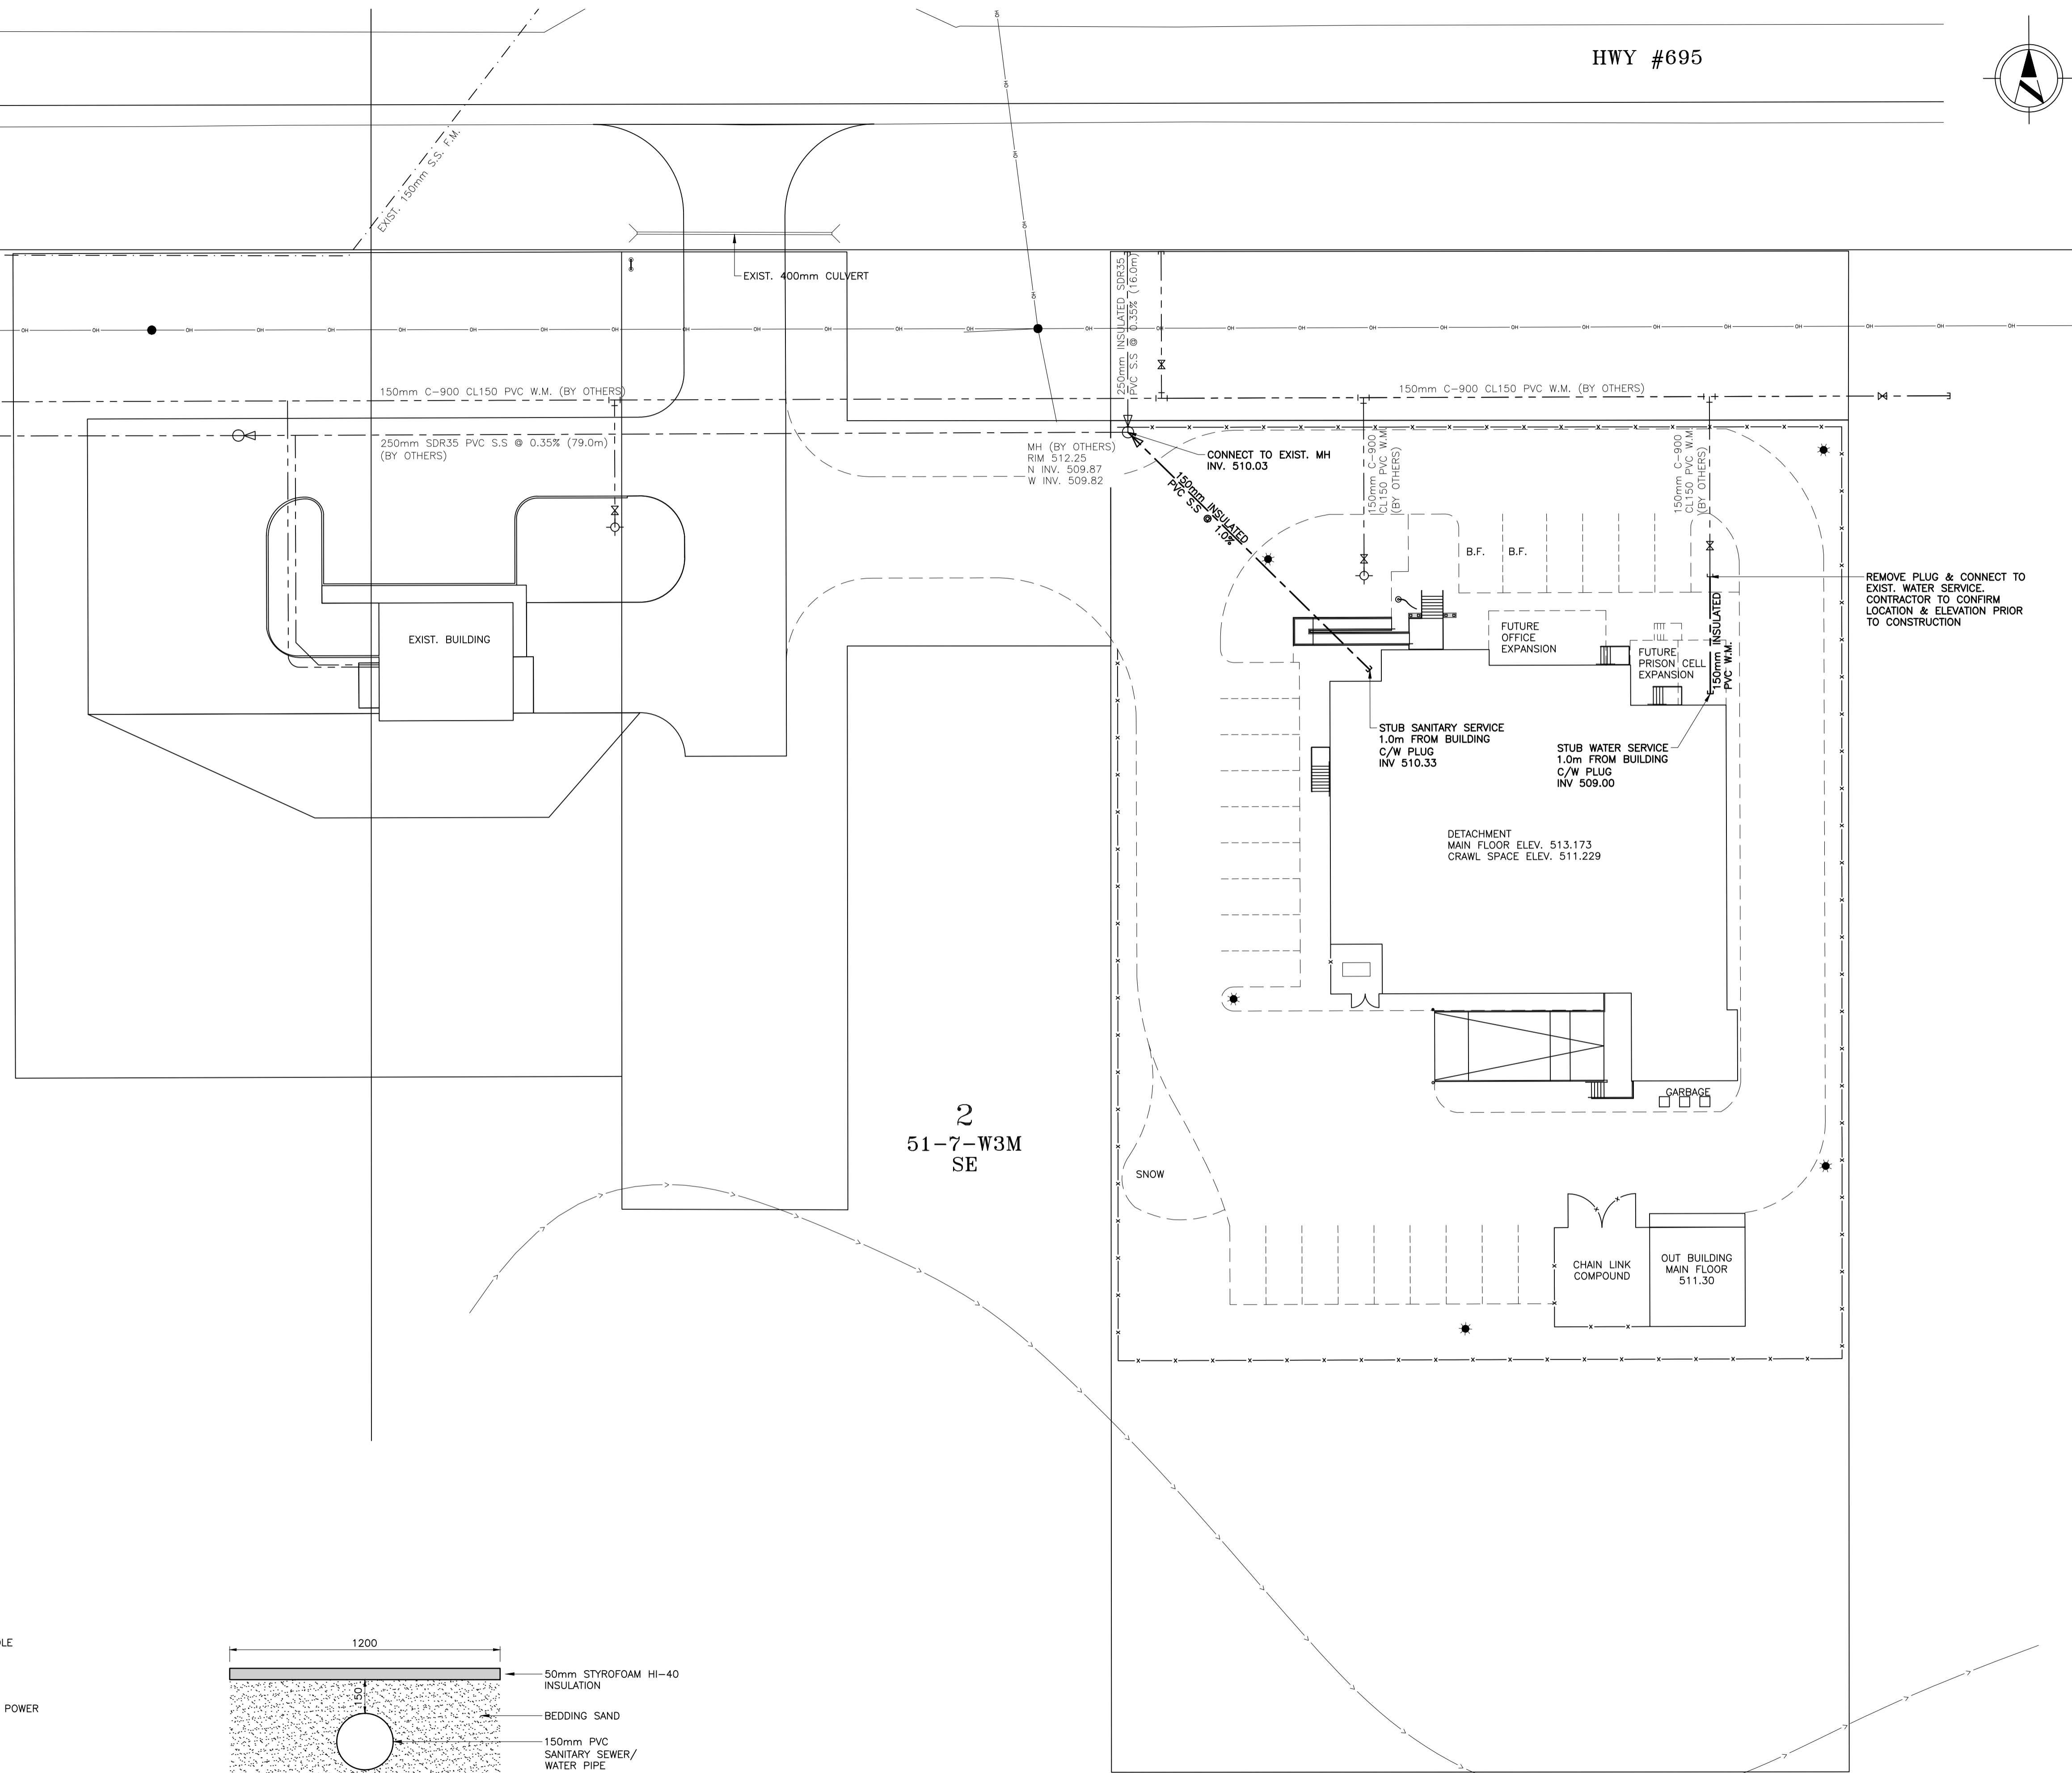



HWY #695

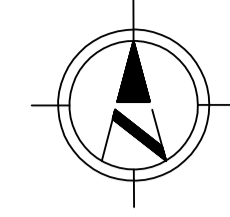

**LEGEND:**

 - EXIST. MANHOLE
- ▽ FLOW DIRECTION
- ⌋ PLUG
- ⊕ EXIST. HYDRANT
- ⊗ EXIST. VALVE
- ⊥ EXIST. TEE
- EXIST. POWER POLE
- ★ LIGHT STANDARD
- EXIST. CULVERT
- EXIST. OVERHEAD POWER
- EXIST. DITCH
- FENCE

SCALE: 1:300



**PIPE INSULATION DETAIL**

SCALE: N.T.S.

**SEPW Architecture Inc.**  
 100 - 3725 Patten Street, Regina, SK S4S 6A8 ph: (306) 569-2255  
 102 - 3718 Knauer Place, Saskatoon, SK S7P 5A6 ph: (306) 652-6457  
 website: www.sepw.ca

**CATTERALL & WRIGHT**  
 CONSULTING ENGINEERS  
 1221 - 9th Street East  
 SASKATOON, SK S7H 0S5  
 Tel: (306) 343-7280, Fax: (306) 956-3199

Association of Professional Engineers & Geoscientists  
 of Saskatchewan  
**CERTIFICATE OF AUTHORIZATION**  
 CONTRACTOR TO CONFIRM  
 LOCATION & ELEVATION PRIOR  
 TO CONSTRUCTION  
 Number C848  
 Permission to Consult held by:  
 Discipline Sk. Reg. No. Signature  
 CIVIL 13385

PROFESSIONAL ENGINEER  
 B. A. LAROCHE  
 MEMBER 13385  
 16 08 12  
 YR. MN. DAY  
 SASKATCHEWAN

**DO NOT SCALE DRAWINGS**

Revision/Revision	Description/Description	Date/Date
2	ISSUED FOR TENDER	16/08/12
1	99% SUBMISSION	15/12/21
0	ISSUED FOR 50% REVIEW	15/09/28

 
Project title/Titre du projet

**NEW MODULAR RCMP BUILDING**  
**AHTAHKAKOOP, SASKATCHEWAN**


Approved by/Approve par  
 BAL  
 Designed by/Concept par  
 EBG  
 Drawn by/Dessine par  
 ERL  
 Project Manager/Administrateur de Projets  
 Architectural and Engineering Resources Manager/  
 Client/client

Drawing title/Titre du dessin  
**SERVICING SITE PLAN**

Project No./No. du projet	Sheet/	Revision no./
S-35-2014	C1.0	0



HWY #695

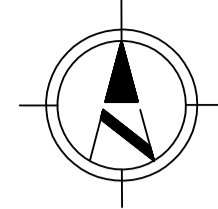

**SEPW Architecture Inc.**  
 100 - 3725 Patten Street, Regina, SK S4S 6A8 ph: (306) 569-2255  
 102 - 3718 Kiewit Place, Saskatoon, SK S7P 3A6 ph: (306) 652-6457  
 website: www.sepw.ca

**CATTERALL & WRIGHT**  
 CONSULTING ENGINEERS  
 1221 - 9th Street East  
 SASKATOON, SK S7H 0S5  
 Tel: (306) 343-7200, Fax: (306) 956-3199



DO NOT SCALE DRAWINGS

Revision/Revision	Description/Description	Date/Date
1	ISSUED FOR TENDER	16/08/12
0	99% SUBMISSION	15/12/21

Project title/Titre du projet

**NEW MODULAR RCMP BUILDING**  
**AHTAHKAKOOP, SASKATCHEWAN**

Approved by/Approve par  
**BAL**  
 Designed by/Concept par  
**EBG**  
 Drawn by/Dessine par  
**ERL**  
 Project Manager/Administrateur de Projets

Architectural and Engineering Resources Manager/

Client/client

Drawing title/Titre du dessin  
**GRADING SITE PLAN**

Project No./No. du projet	Sheet/	Revision no./
S-35-2014	C2.0	0



- LEGEND:**
- ↖ % DRAINAGE GRADE & DIRECTION
  - XXX.XX FINISHED GROUND ELEV.
  - PG XXX.XX PERIMETER GRADE
  - EXIST. MANHOLE
  - ⊕ EXIST. HYDRANT
  - ⊗ EXIST. VALVE
  - EXIST. POWER POLE
  - ★ LIGHT STANDARD
  - EXIST. CULVERT
  - EXIST. GROUND CONTOUR
  - - - EXIST. OVERHEAD POWER
  - - - EXIST. DITCH
  - - - FENCE
  - 150mm GRANULAR BASE

SCALE: 1:300

