




- NOTES:**
1. PROVIDE A WATER GONG AND A GENERAL ALARM SWITCH IN DRY VALVE NEI. IF THESE ITEMS ARE NOT EXISTING.
 2. PROVIDE ADEQUATE SIGNS CIVIC FIRE DEPT. SIAMESK CONNECTIONS.
 3. SEE ELECTRICAL DWG. FOR FIRE ALARM BELLS.

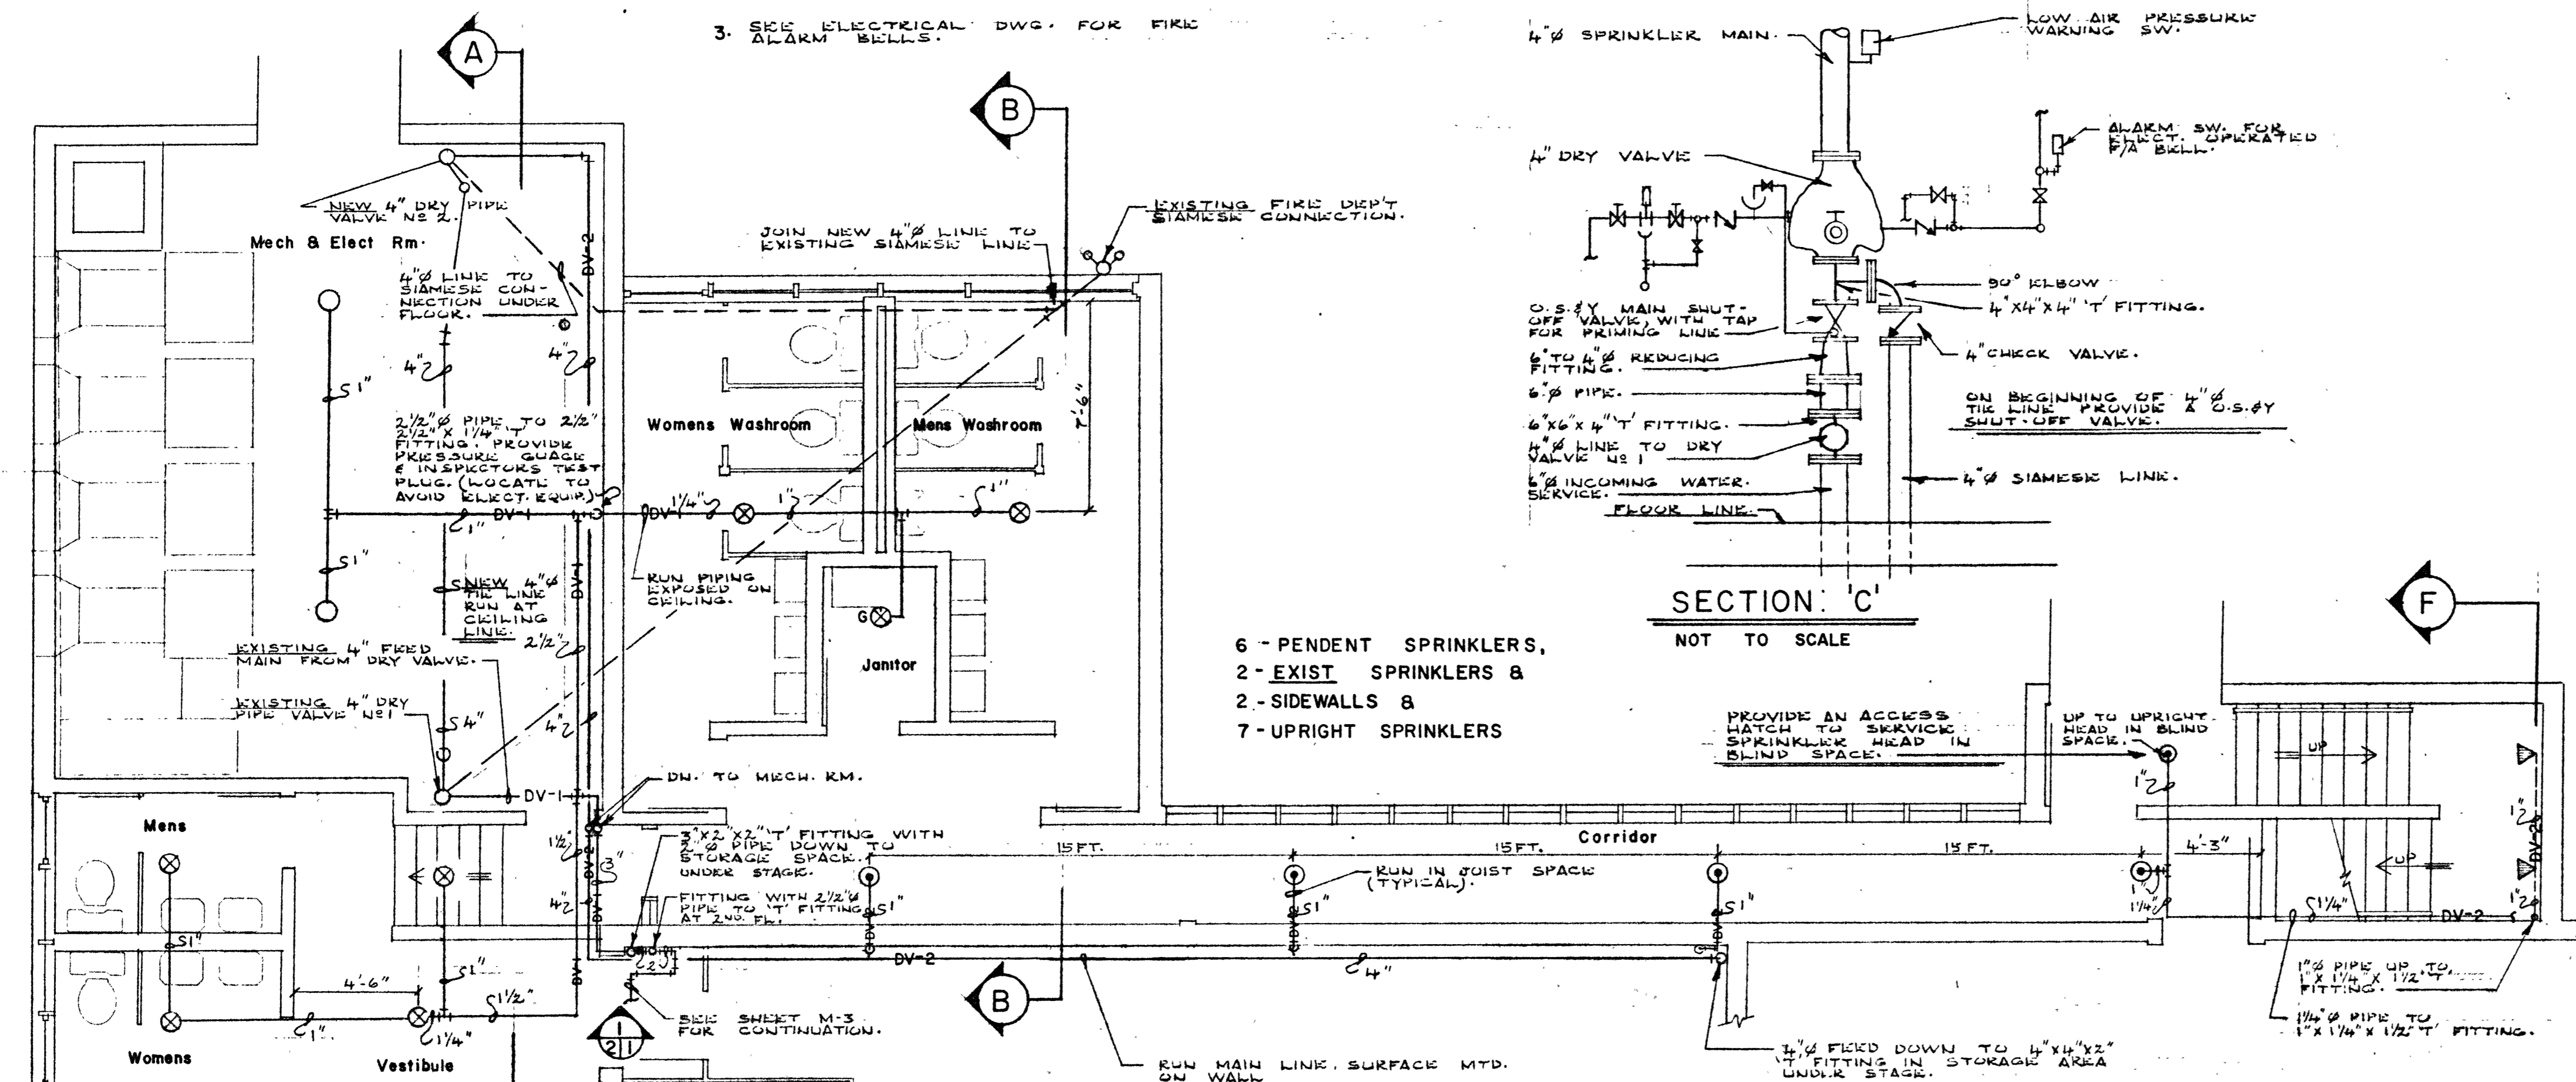

GROUND FLOOR SERVICE BLDG & CORRIDOR REFLECTED CEILING PLAN
SCALE: 1/4" = 1'-0"

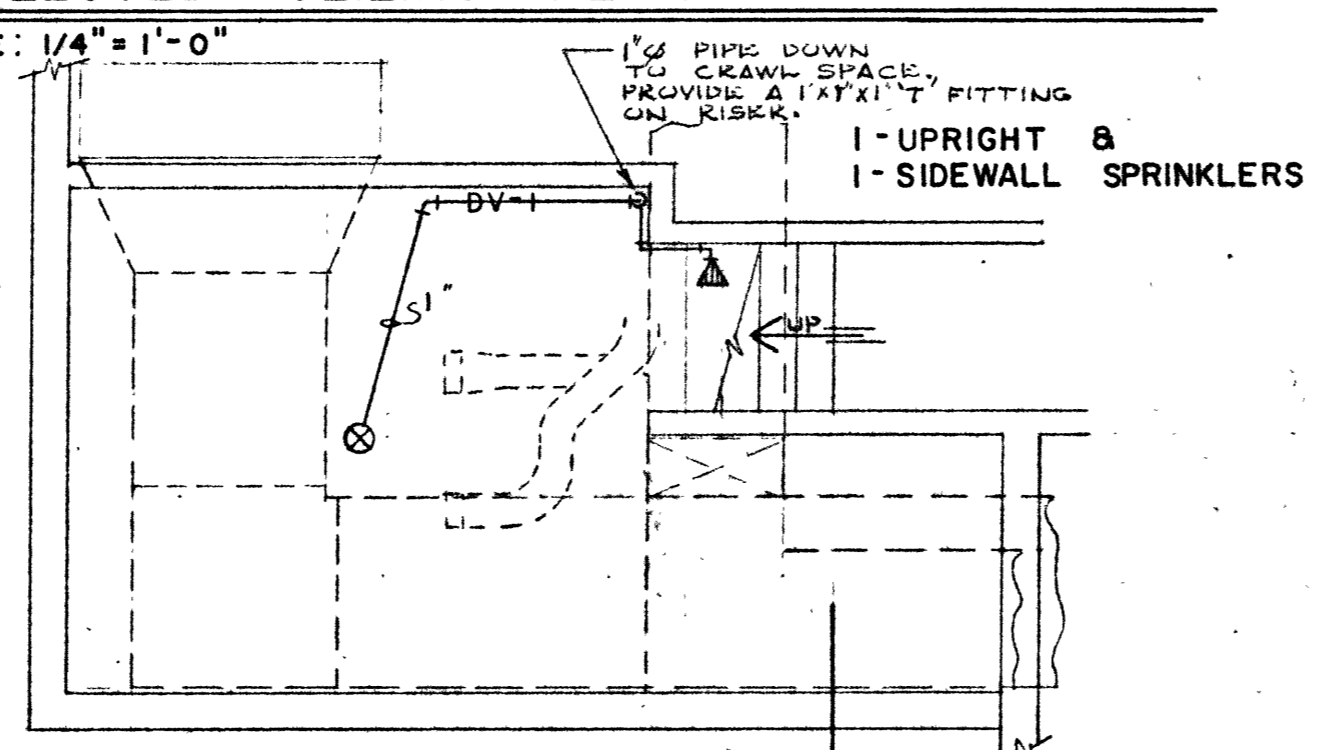



PLAN OF AREA UNDER VESTIBULE & MENS & WOMENS WASHROOMS
SCALE: 1/4" = 1'-0"
NOTE:
DASHED LINES INDICATE LOCATIONS OF DUCTS IN CRAWL SPACES & STORAGE AREA UNDER STAGE. CONTRACTOR TO VERIFY EXACT LOCATIONS & ADJUST THE ROUTING OF THE PIPING OR HEADS TO SUIT.

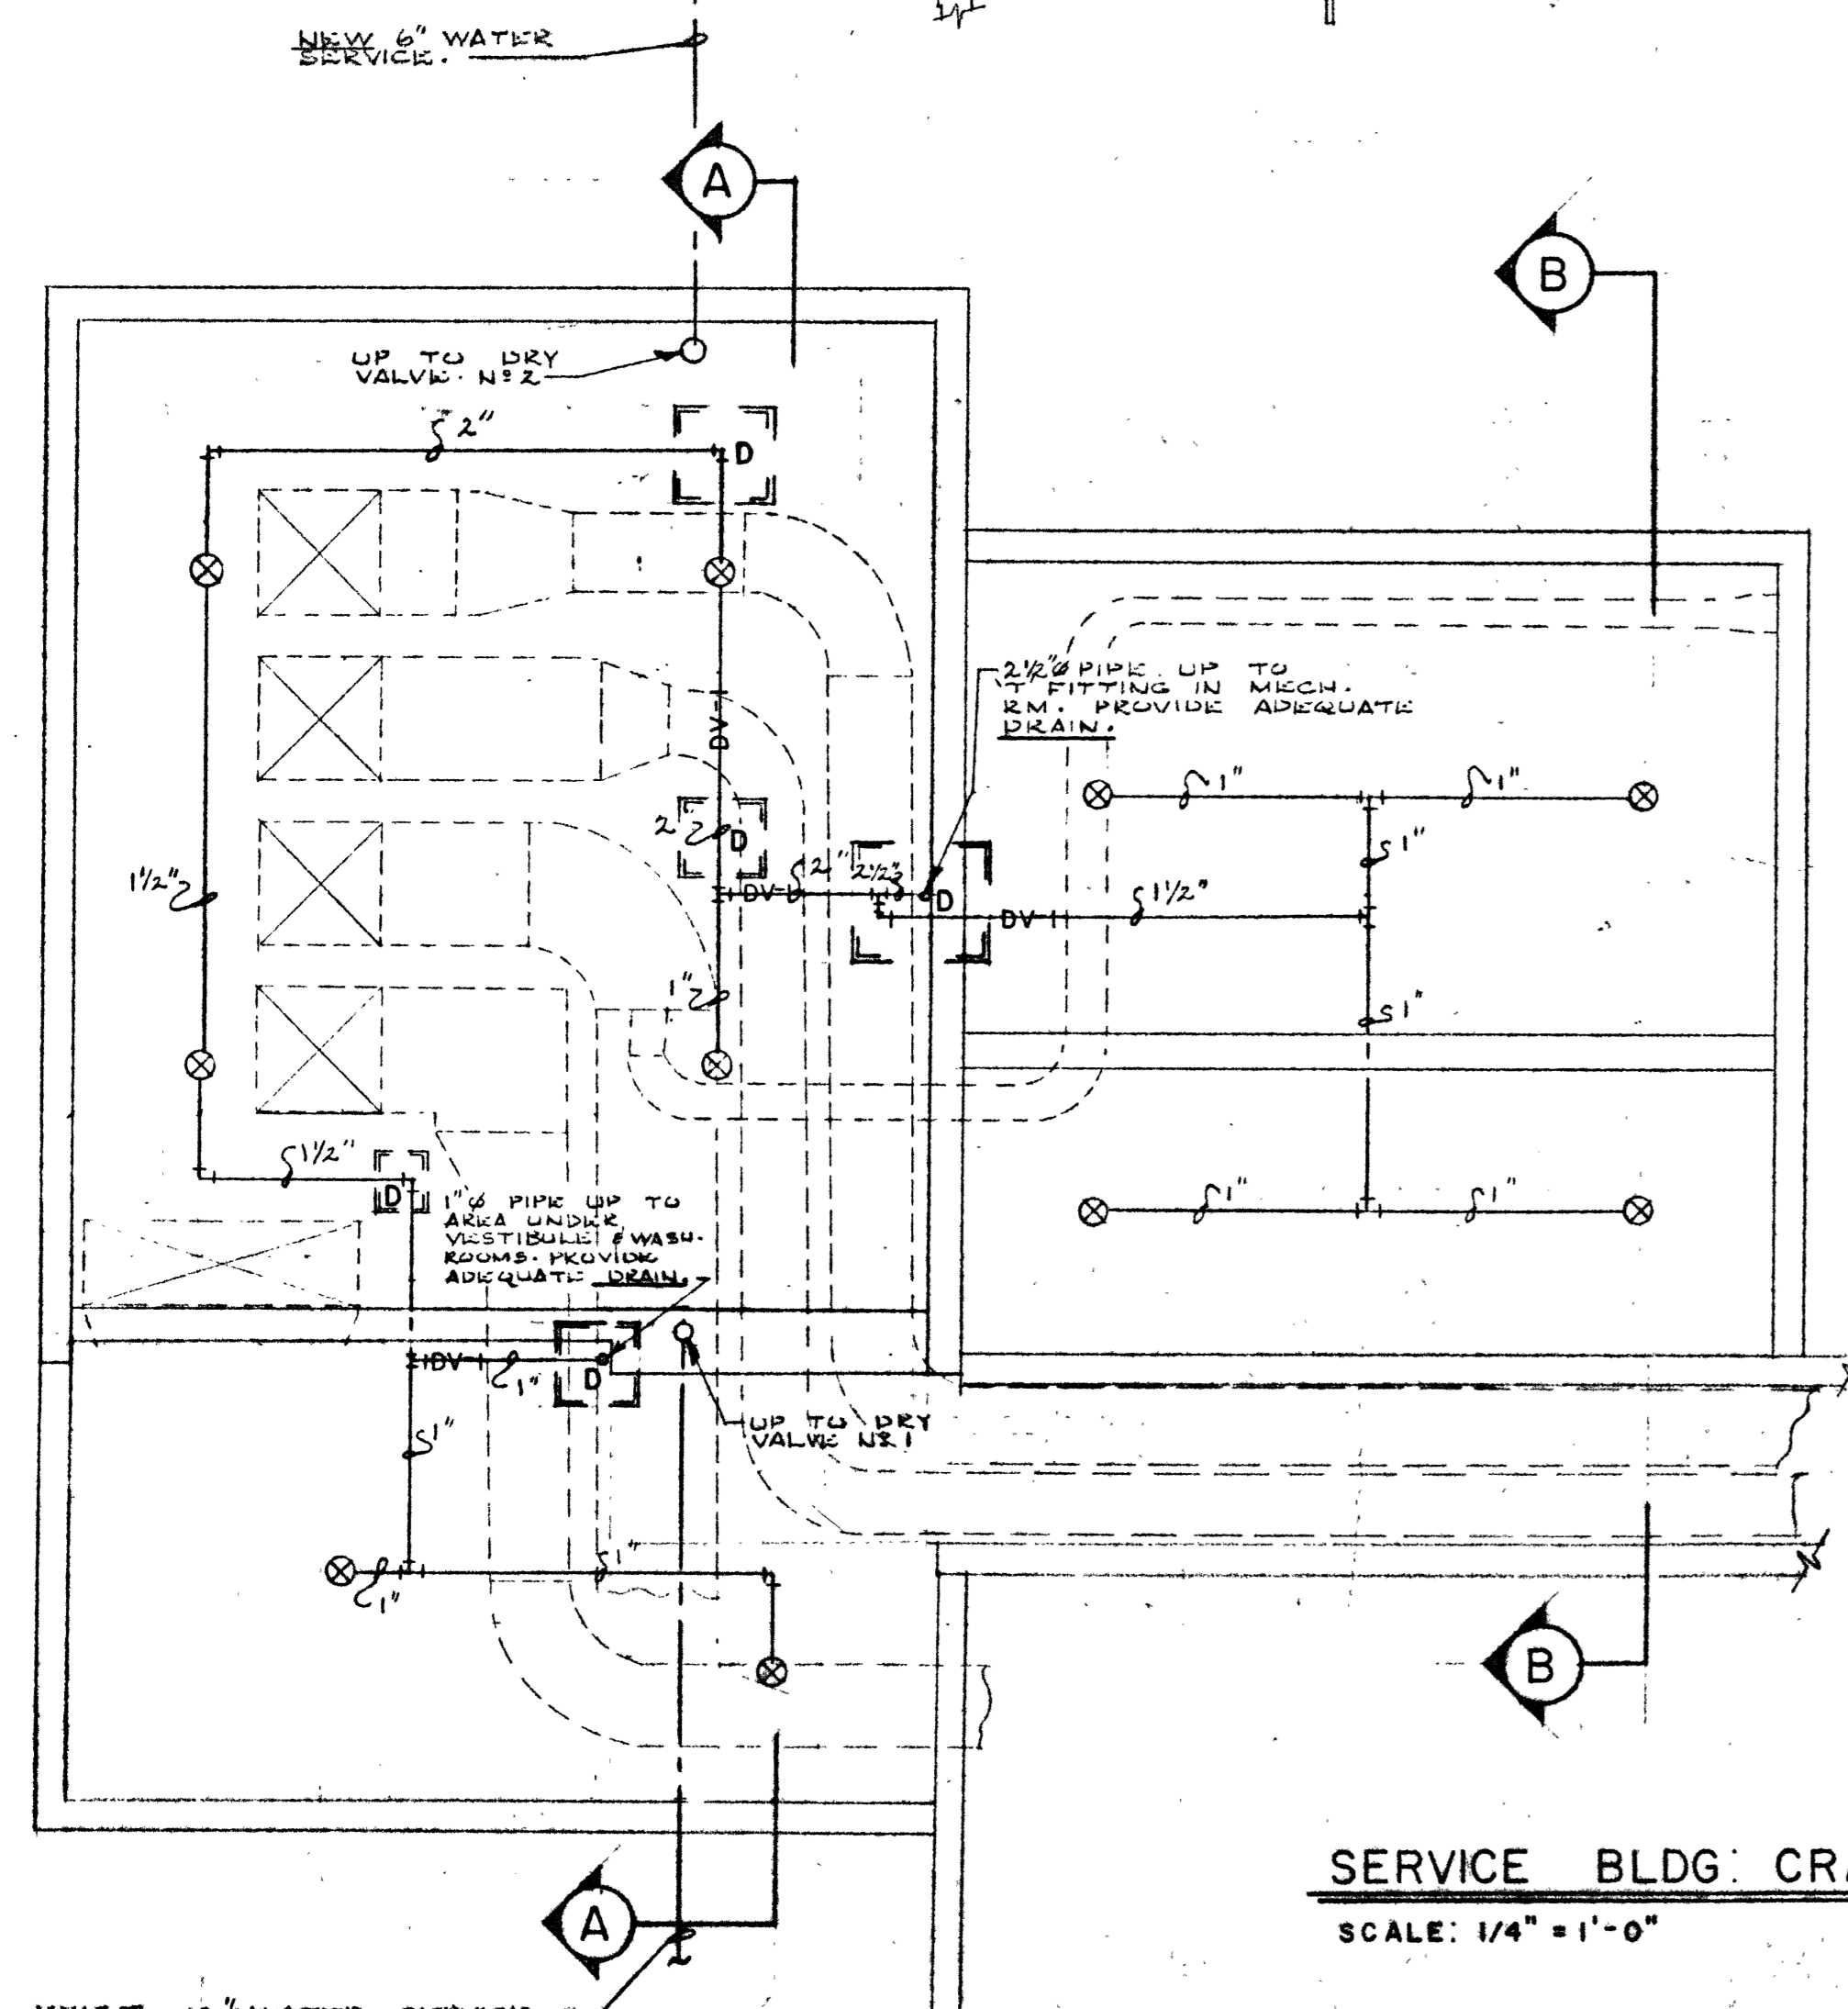

SERVICE BLDG CRAWL SPACE PLAN
SCALE: 1/4" = 1'-0"

CONTRACTOR TO INDICATE TO INSTALL UPRIGHT SPRINKLERS IN THIS AREA. IN SPACE LIMITATIONS PROHIBIT USE OF UPRIGHT SPRINKLERS PENDANT TYPE MAY BE USED.


DETAIL OF DRAIN FITTINGS IN CRAWL SPACE
NOT TO SCALE

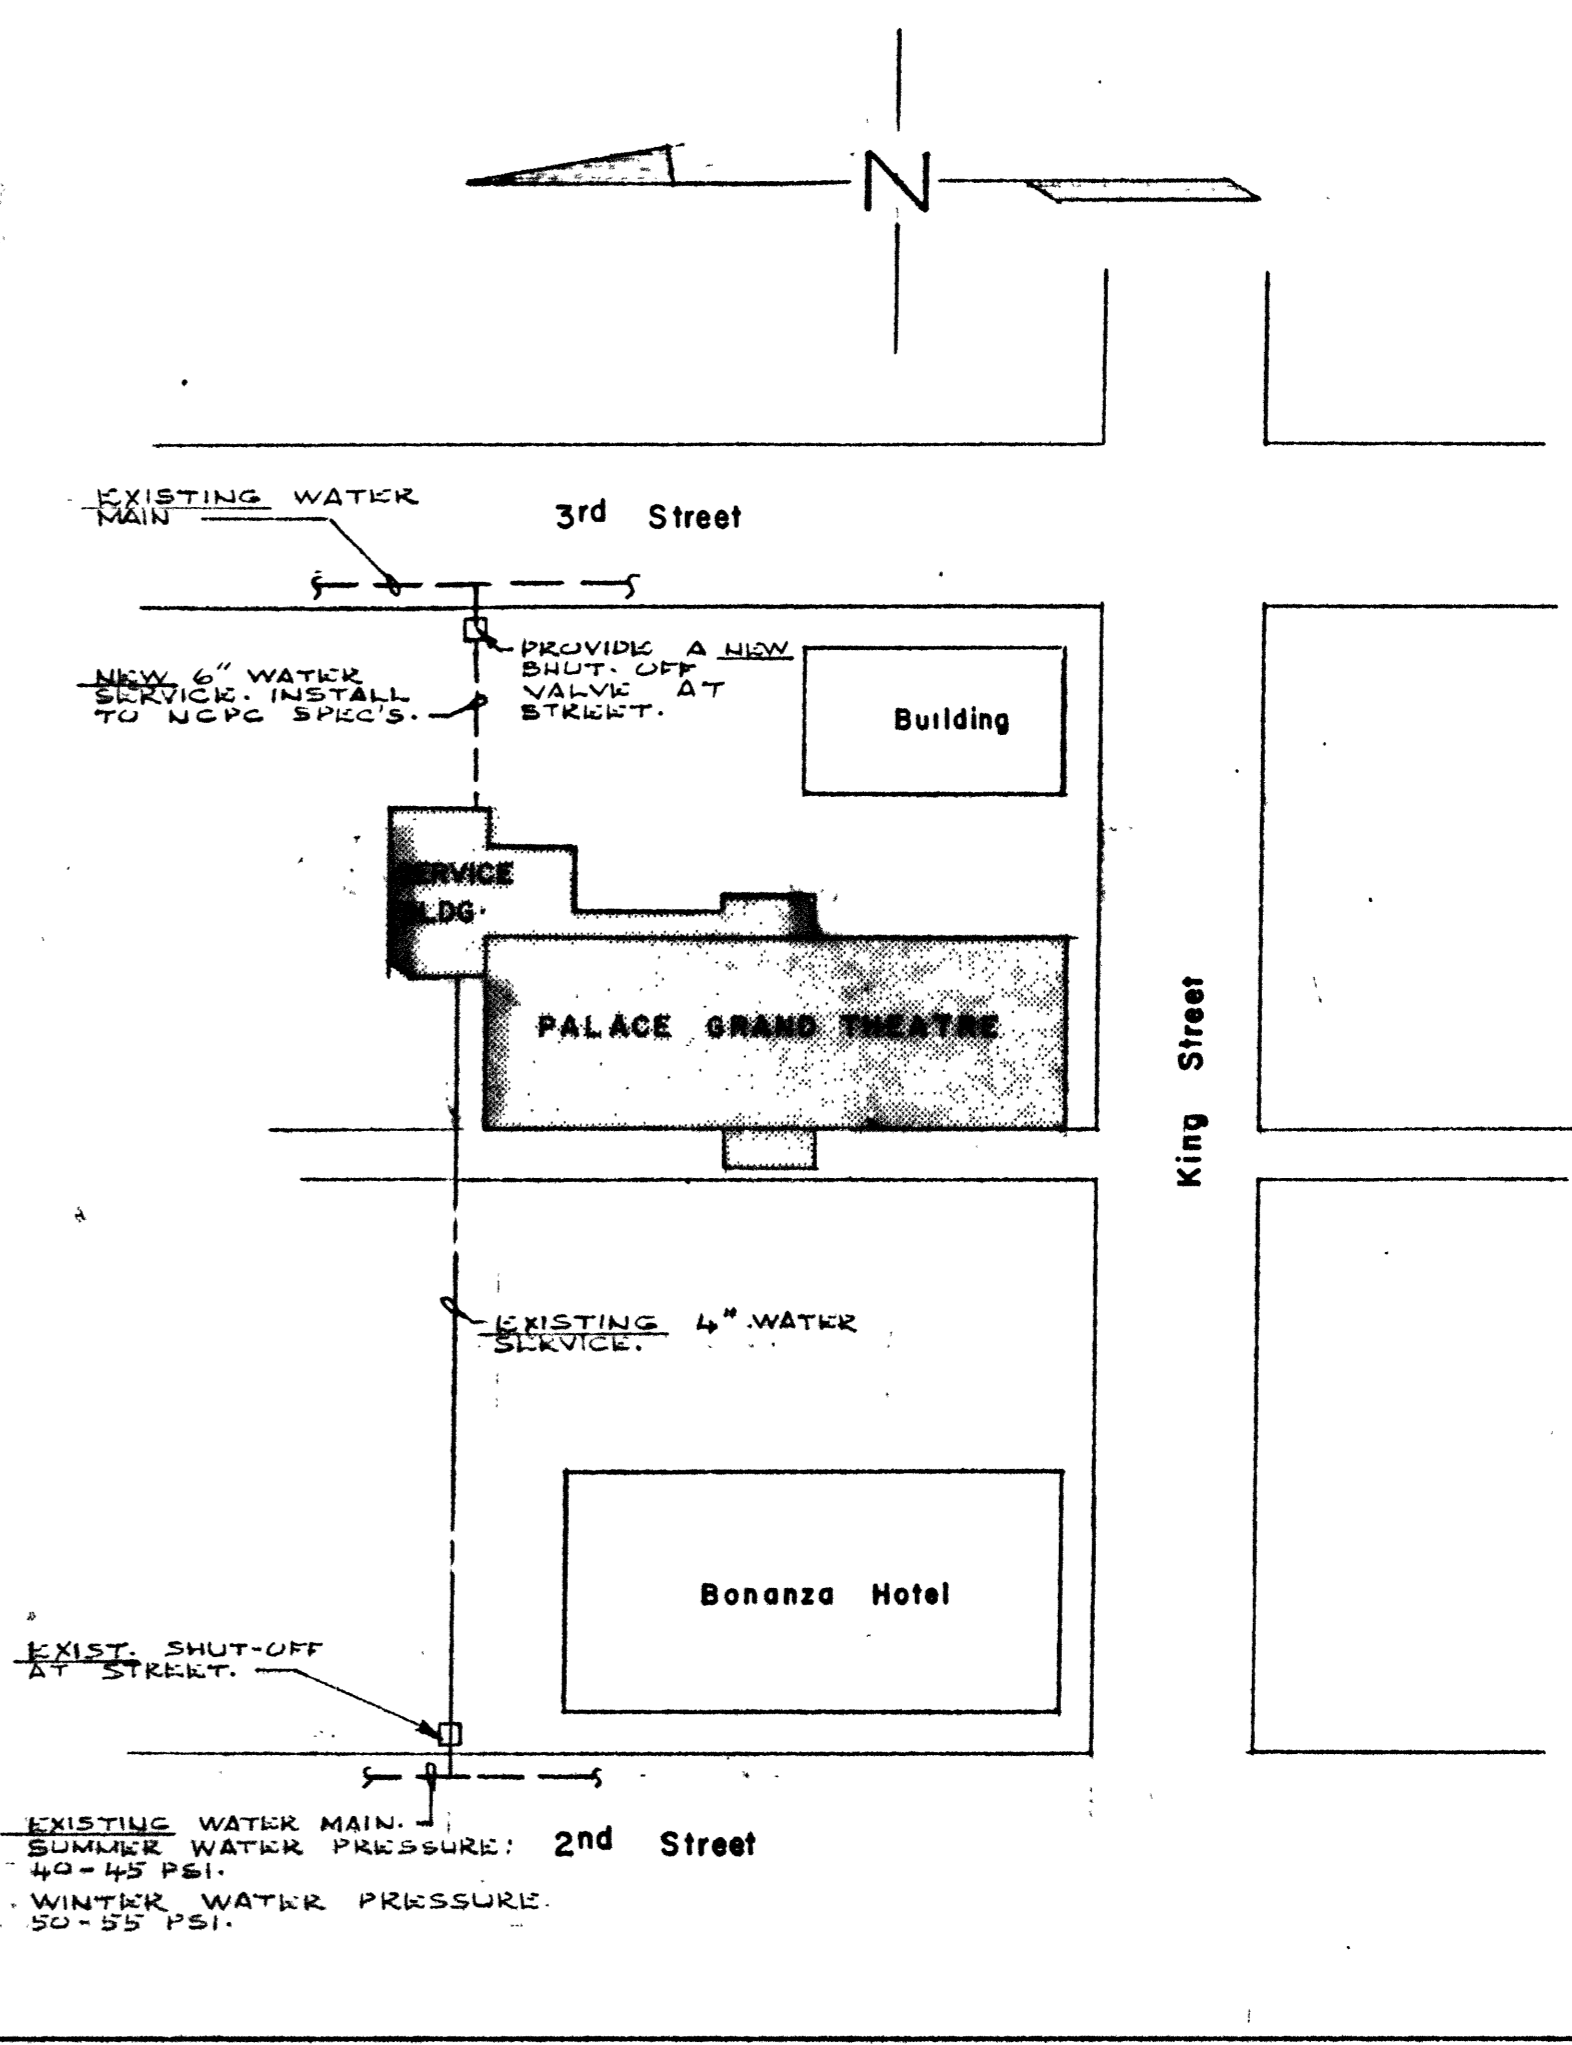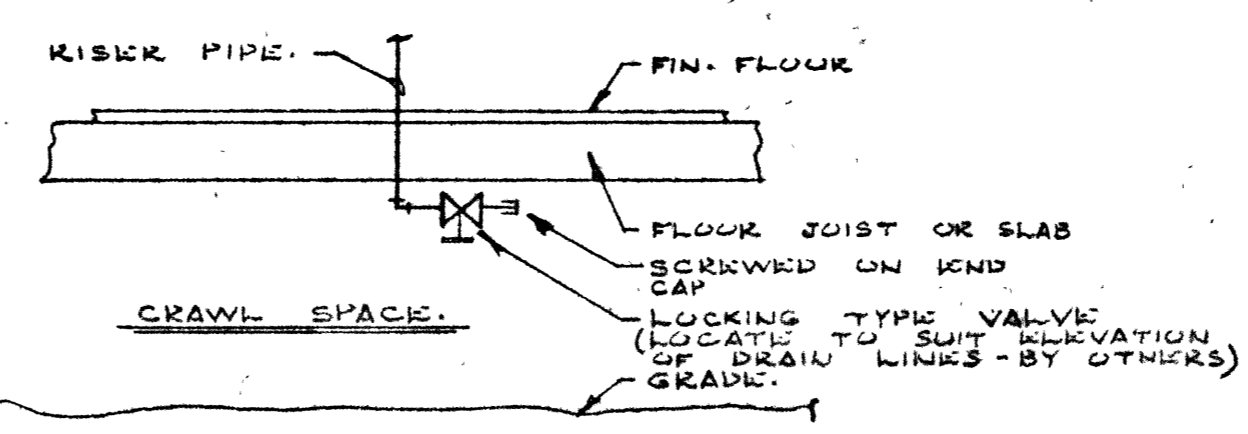

SITE PLAN
SCALE: 1" = 40'-0"

LEGEND

- FEED, BRANCH OR CROSS MAIN PIPING RUN EXPOSED IN AREAS BEHIND PERIMETER WALL, CRAWL SPACES, ROOF SPACES, AND STORAGE AREA UNDER STAGE, ETC. ALL PIPING RUN IN PUBLIC AREAS SHALL BE CONCEALED.
- EXISTING DRY TYPE SPRINKLER HEAD TO REMAIN IN SYSTEM
- STANDARD DRY TYPE PENDANT SPRINKLER HEAD
- FLUSH DRY TYPE PENDANT SPRINKLER HEAD, WITH SPECIAL FINISH - SEE SPEC.
- STANDARD DRY TYPE UPRIGHT SPRINKLER HEAD WITH WIRE GUARD.
- STANDARD DRY TYPE UPRIGHT SPRINKLER HEAD.
- STANDARD DRY TYPE SIDEWALL SPRINKLER HEAD.
- PIPING - TURNED "UP"
- PIPING - TURNED "DOWN"
- LOCKING TYPE GLOBE VALVE.
- GATE VALVE.
- CHECK VALVE.
- PRESSURE RELIEF VALVE.
- INDICATES THAT A DRAIN LINE WILL BE RUN FROM THE DRAIN VALVE TO THE BUILDING SANITARY SEWER LINE BY OTHERS.
- ON PIPING RUNS, INDICATES THE TYPE OF DRY VALVE, EITHER EXISTING OR NEW DRY VALVE NEI, THAT CONTROLS THE PARTICULAR FEED, BRANCH OR CROSS MAIN, THAT IS LABELLED.

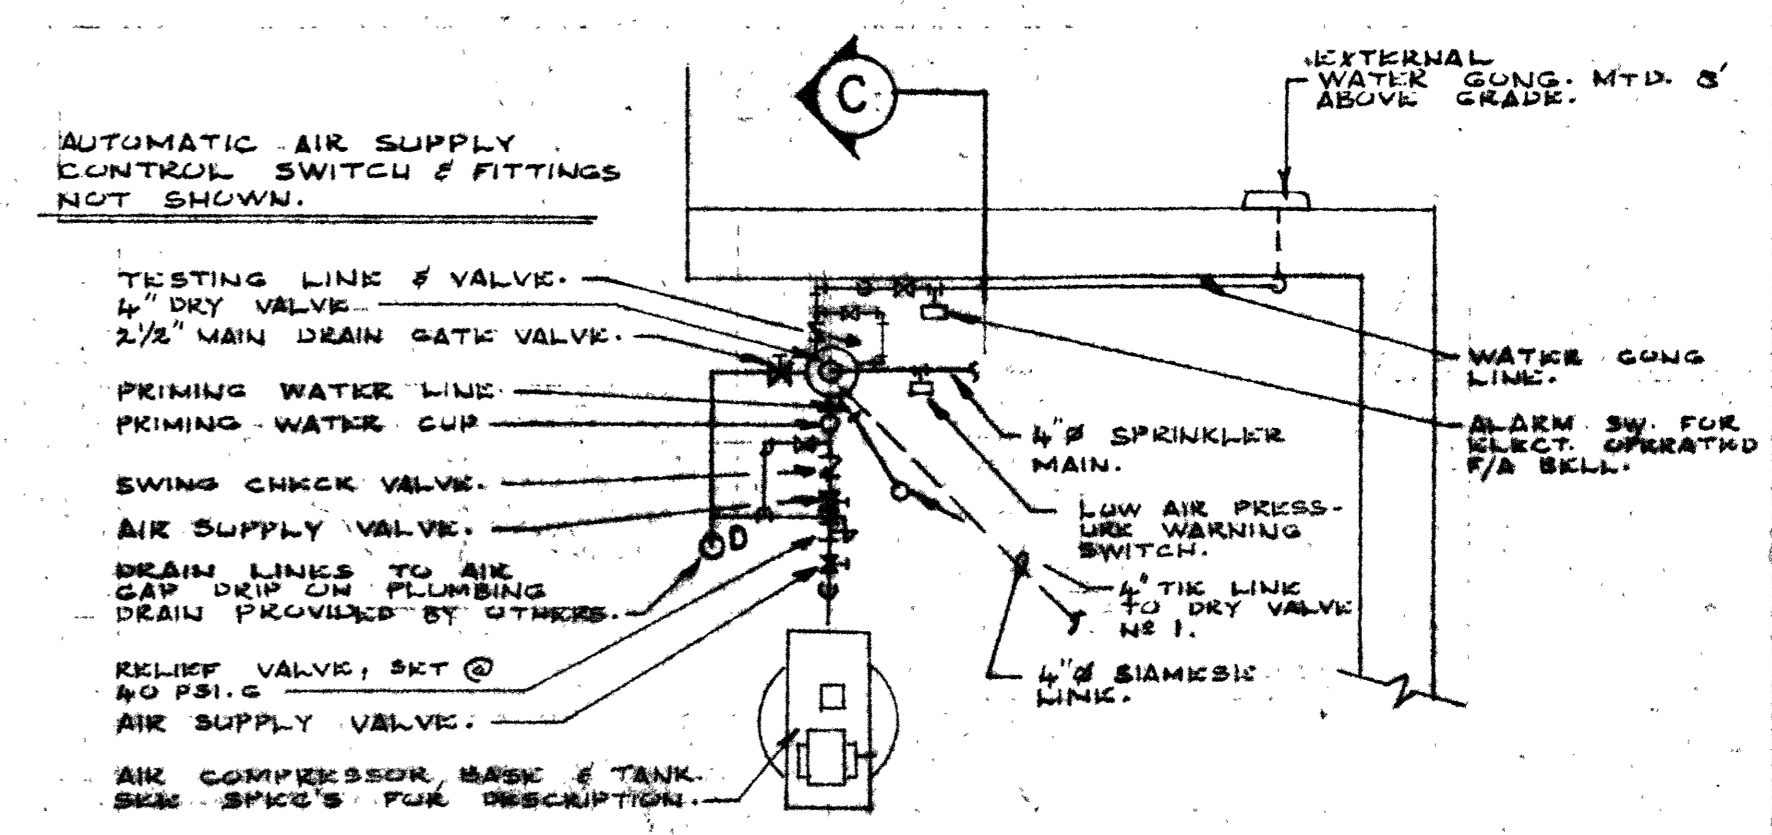

PLAN NEW 4 INCH DRY VALVE IN MECH & ELECT Rm
NOT TO SCALE

A	A detail no.	détail no.
B	B location dwg. no.	sur dessin no.
C	C drawing no.	dessin no.

drawn by / tracé par
R-J SWEET
scale / échelle
AS SHOWN

designed by / établi par
R-J S

checked by / vérifié par

Job captain / chef de projet
G-W RICHARDS

responsible officer / officier responsable
G-B ALLEN
CHIEF OF DIVISION

project title
SPRINKLER and EMERGENCY ELECTRICAL SYSTEMS

titre du projet
PALACE GRAND THEATRE

DAWSON Y-T

drawing title
SPRINKLER SYSTEM

titre du dessin
SERVICE BUILDING, & SITE PLANS

LEGEND & DETAILS

reference no.
HWDC 76/H7

sheet no.
MI of 6