


THEATRE: SECOND FLOOR REFLECTED CEILING PLAN
SCALE: 1/4" = 1'-0"

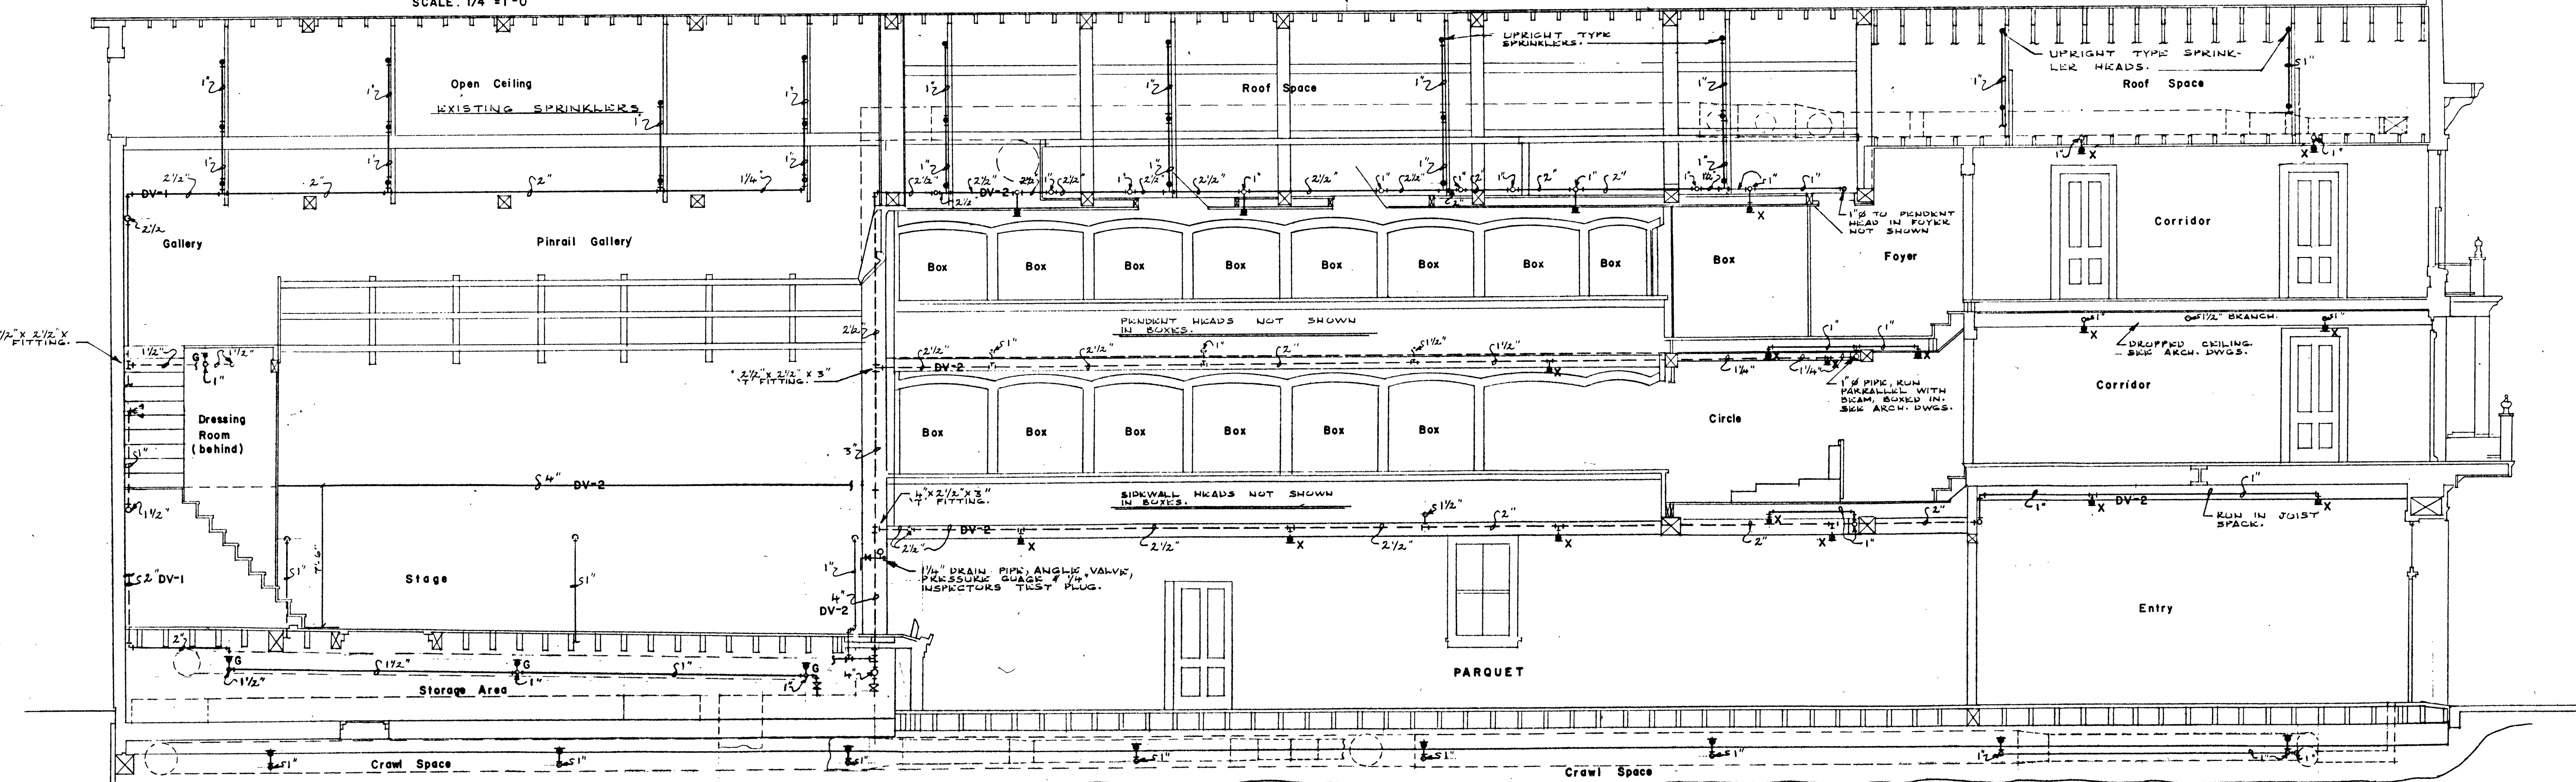

LONGITUDINAL SECTION: 'D - D' SCALE: 1/4" = 1'-0"

A	A detail no.	détail no.
B	B location dwg. no.	sur dessin no.
C	C drawing no.	dessin no.

Drawn by / tracé par: R-J SWEET
 Designed by / établi par: R-J S
 Checked by / vérifié par:

Job captain / chef de projet: G-W RICHARDS
 Responsible officer / officier responsable: CHIEF OF DIVISION G-B ALLEN
 Date: 2/11/74

Project title / titre du projet: **SPRINKLER and EMERGENCY ELECTRICAL SYSTEMS**
PALACE GRAND THEATRE
 DAWSON Y.T.

Drawing title / titre du dessin: **SPRINKLER SYSTEM**
THEATRE: SECOND FLOOR PLAN & LONGITUDINAL SECTION

Reference no. / no de référence: **HWDC 76/H7**
 Drawing no. / dessin no.: **M4 of 6**