




SITE PLAN-PROPOSED WATER DISTRIBUTION SYSTEM
SCALE: 1" = 30'-0"

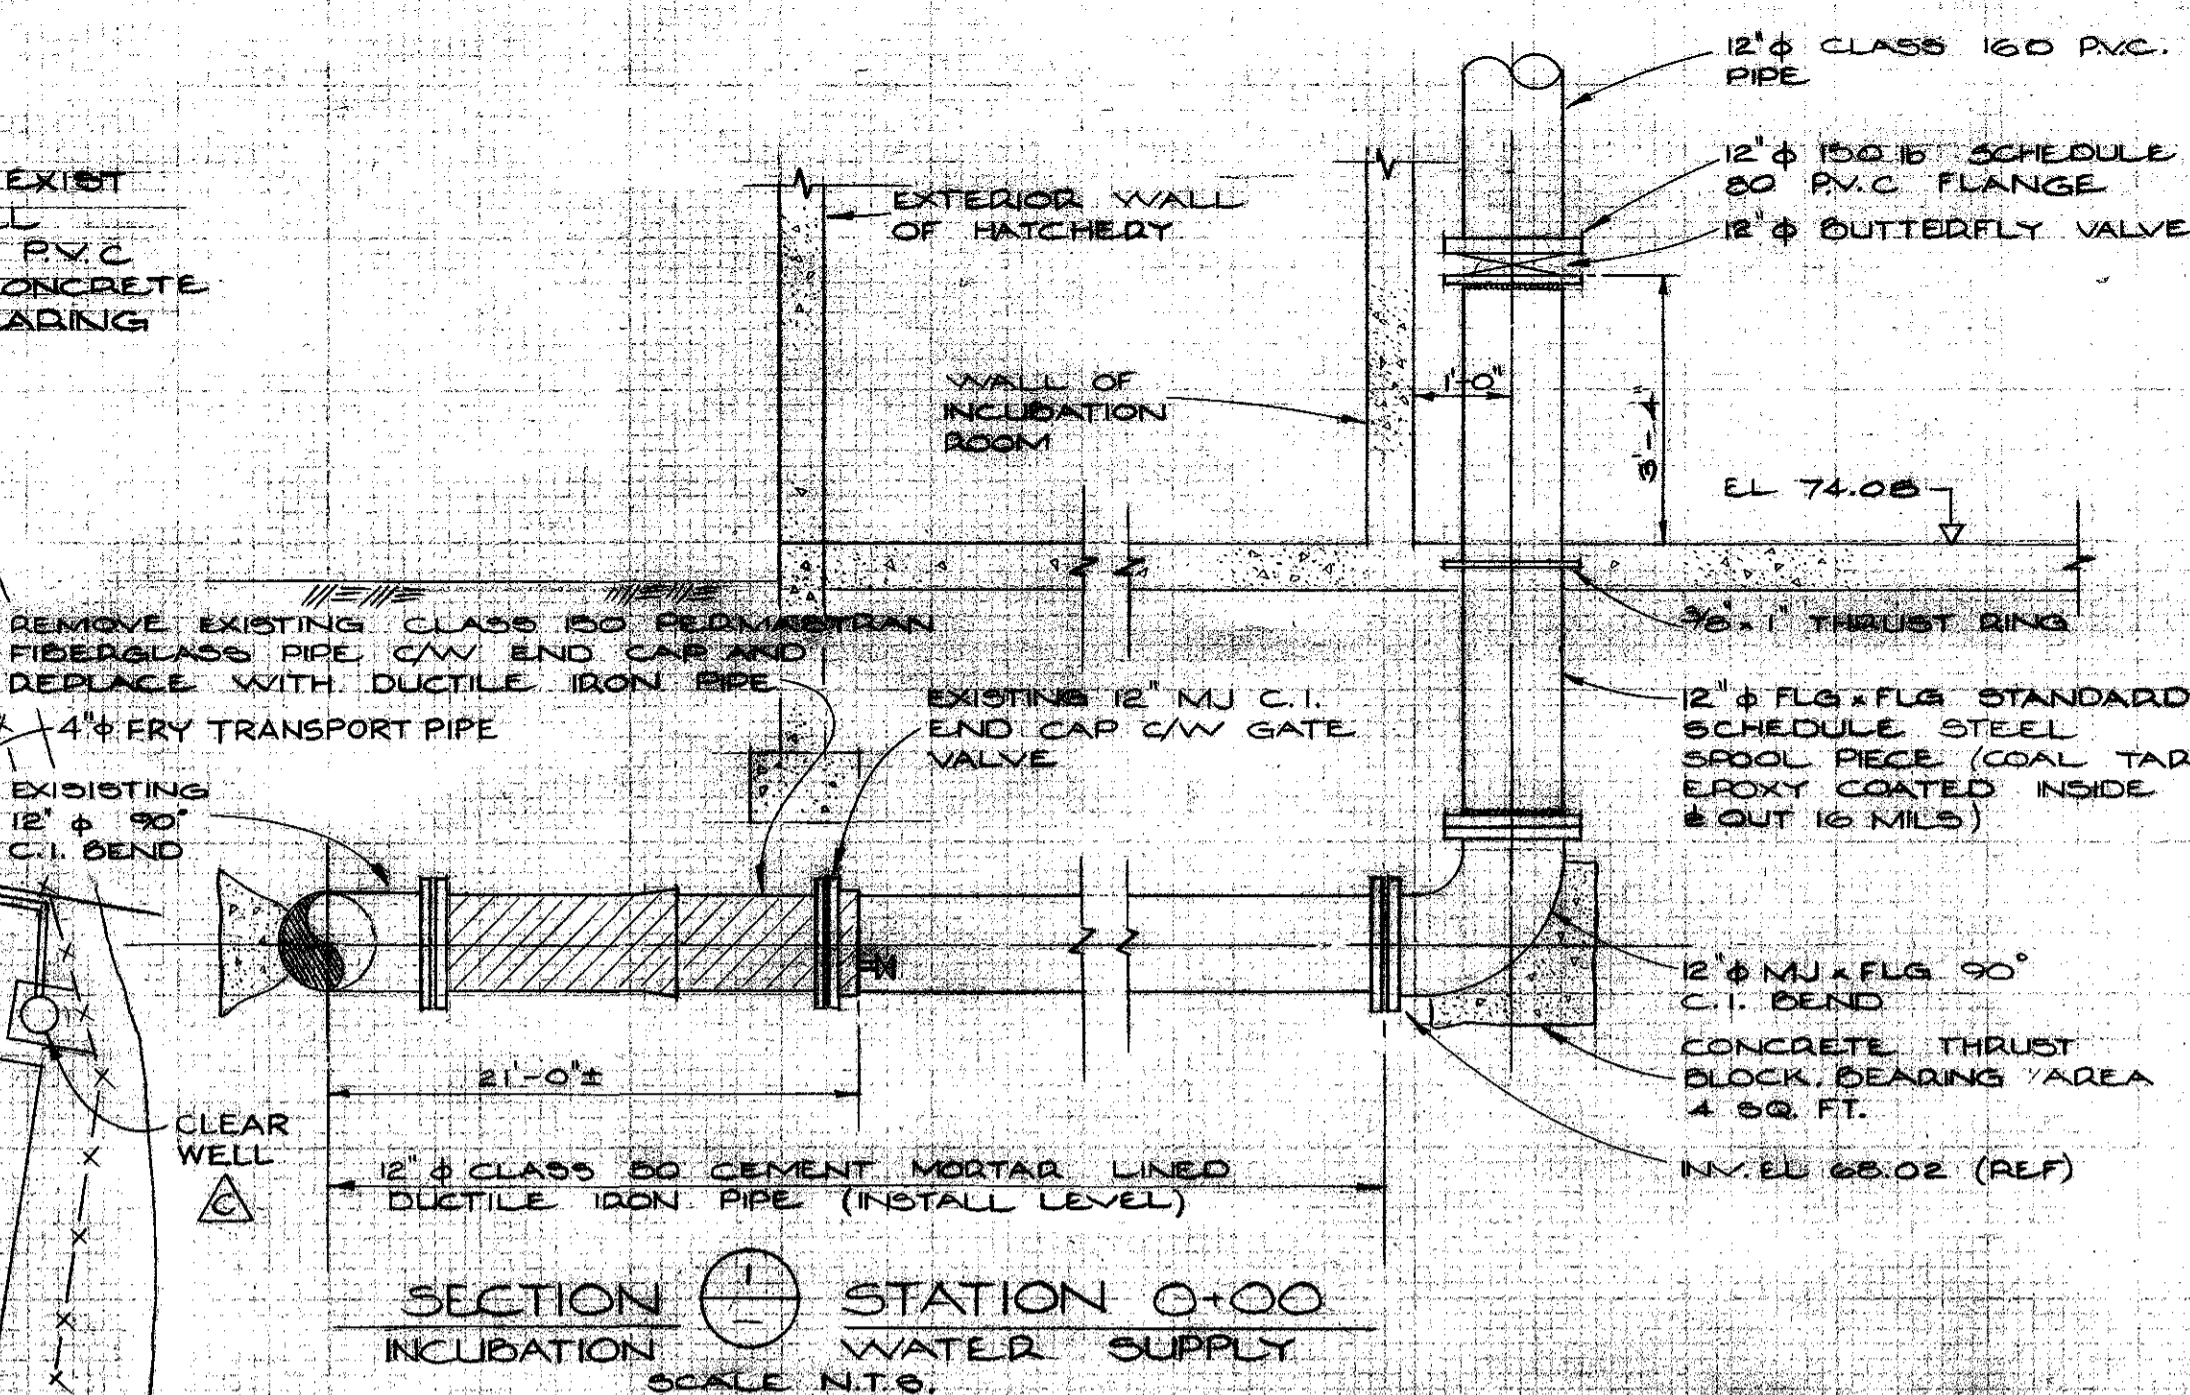


SECTION 1 STATION 0+00
INCUBATION WATER SUPPLY
SCALE: N.T.S.

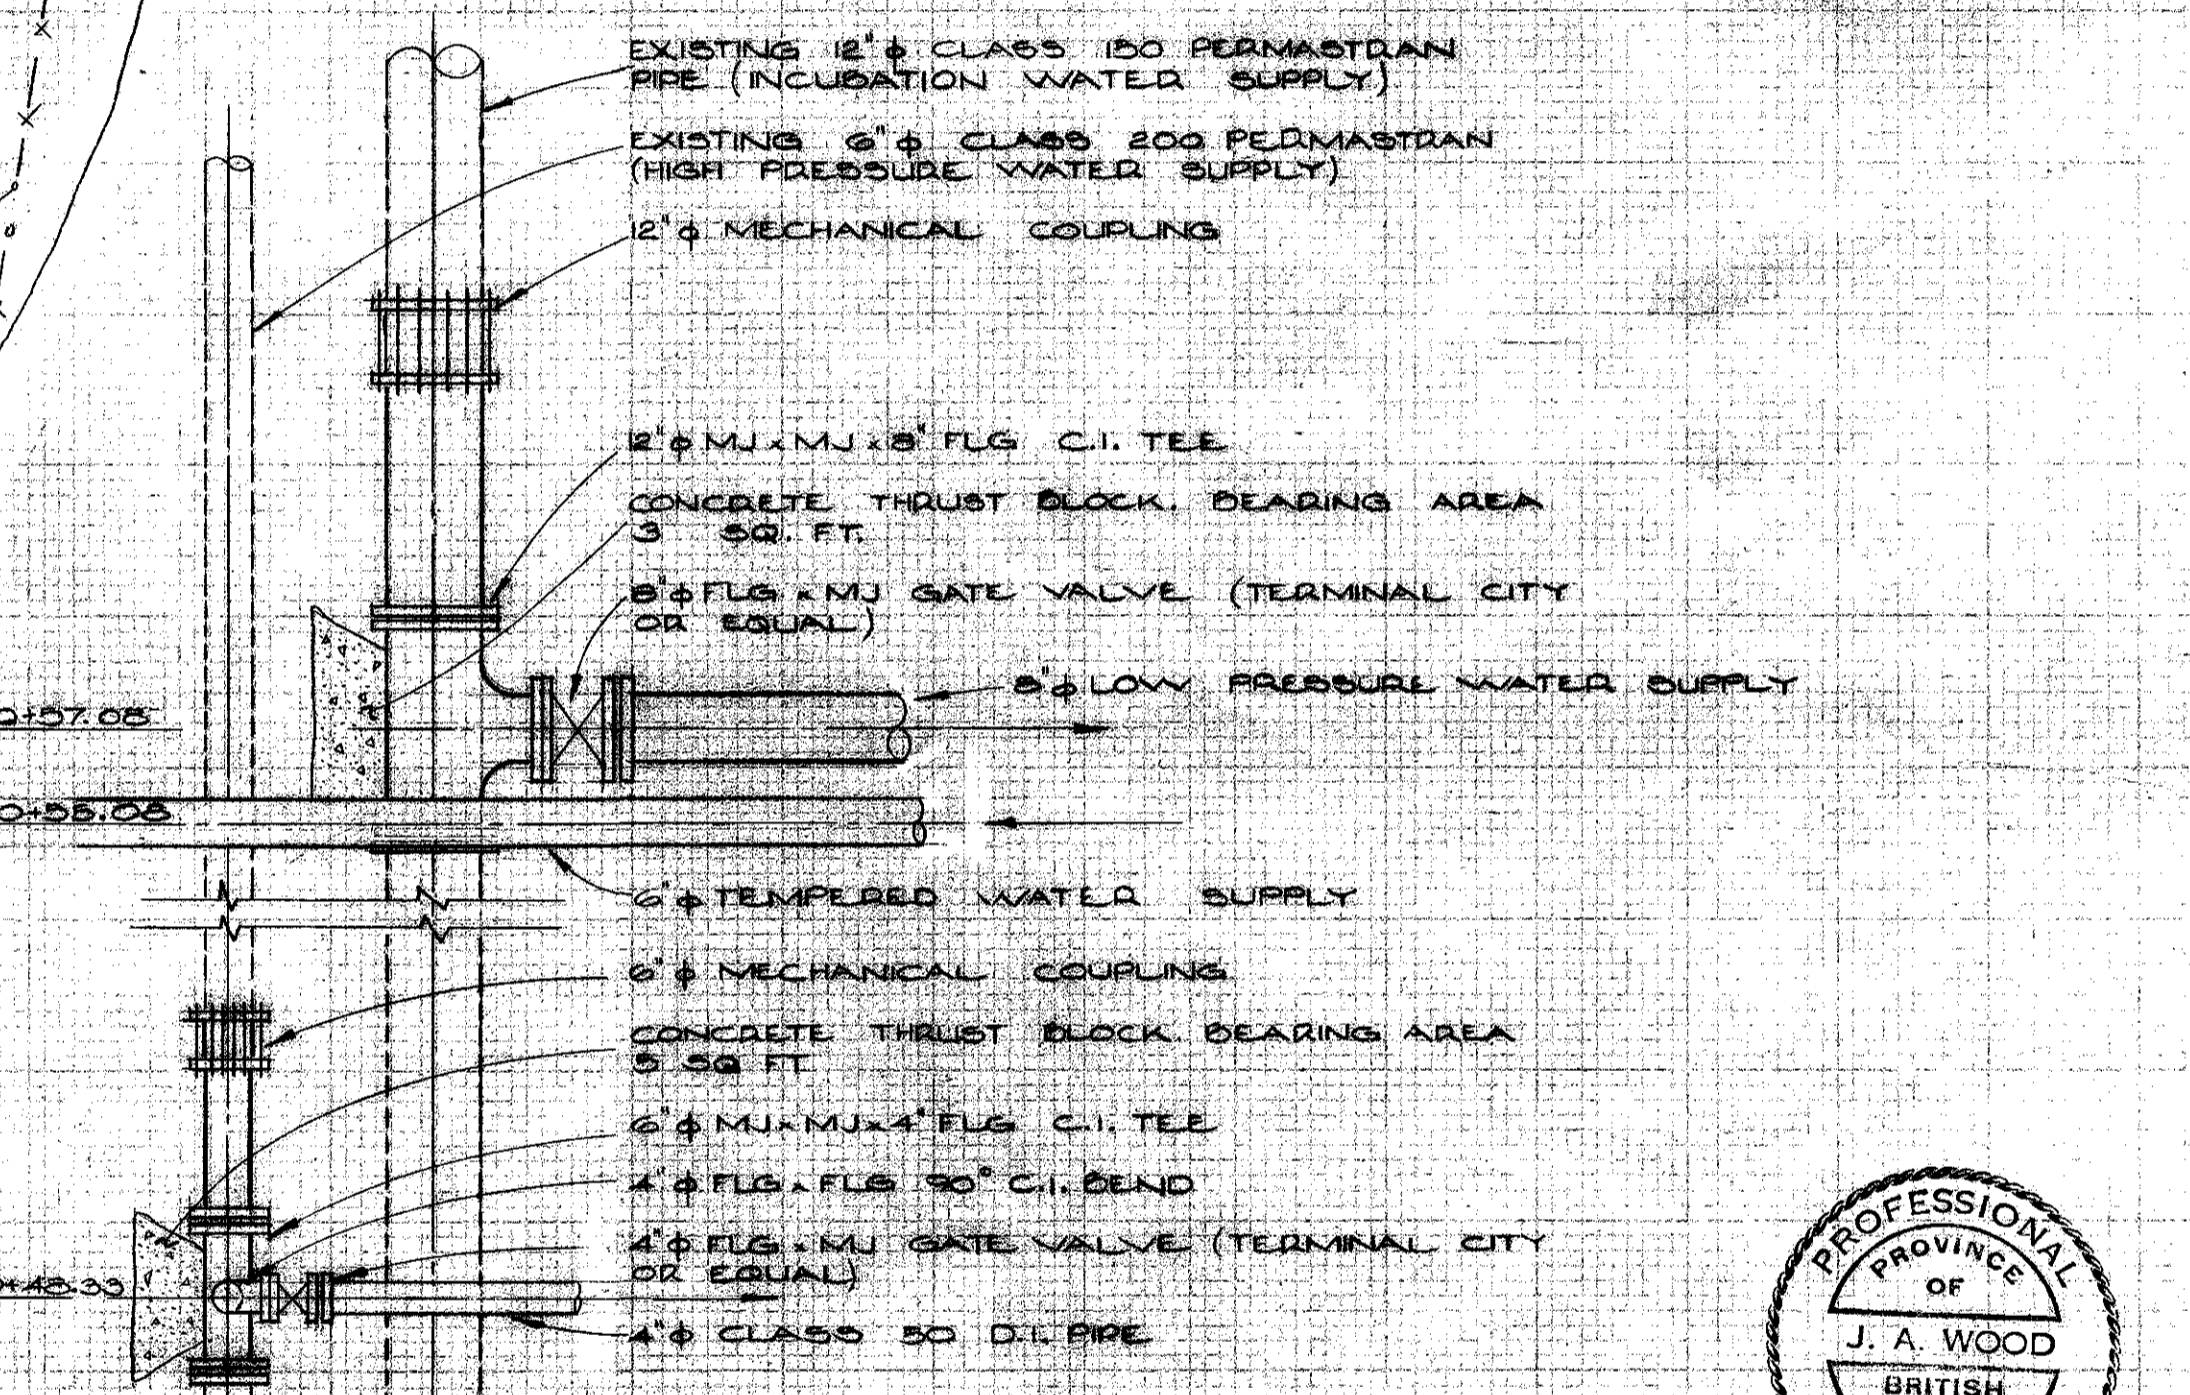


DETAIL A WATER SUPPLY
SCALE: N.T.S.

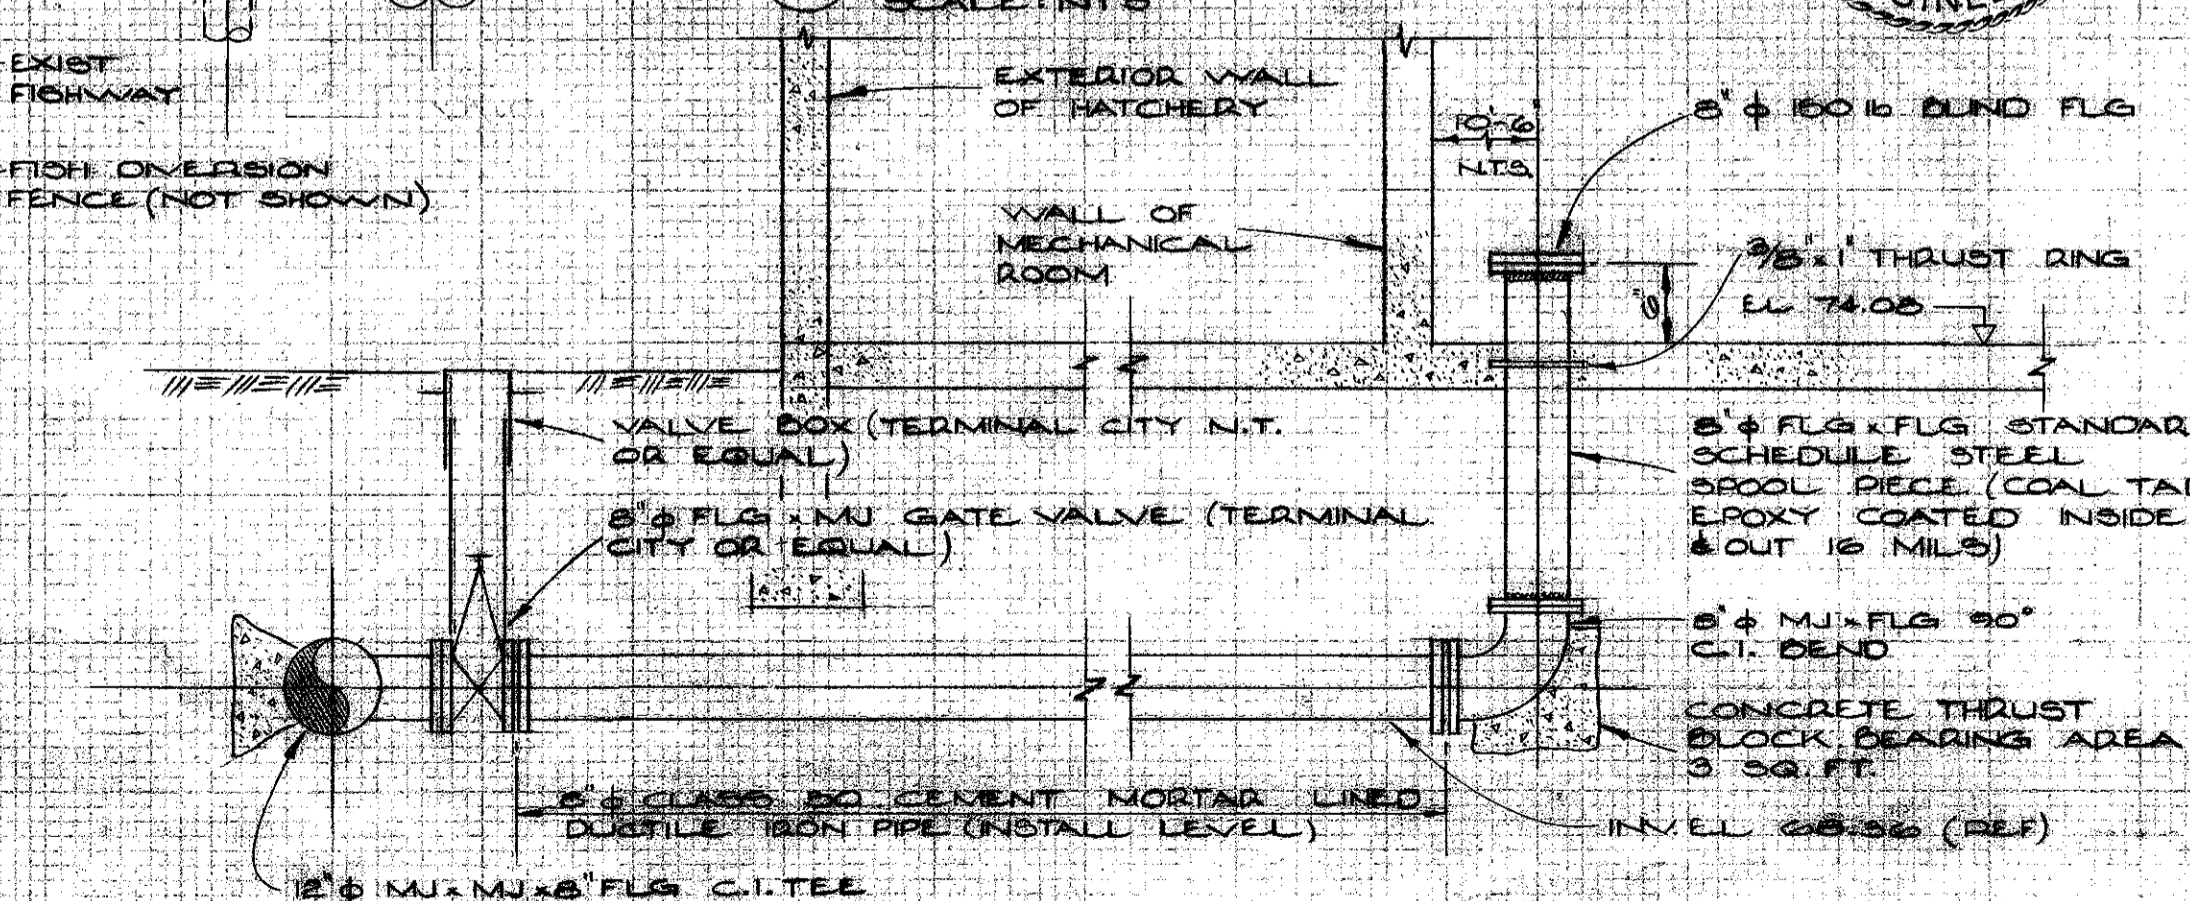

SECTION 2 STATION 0+57.08
SCALE: N.T.S.

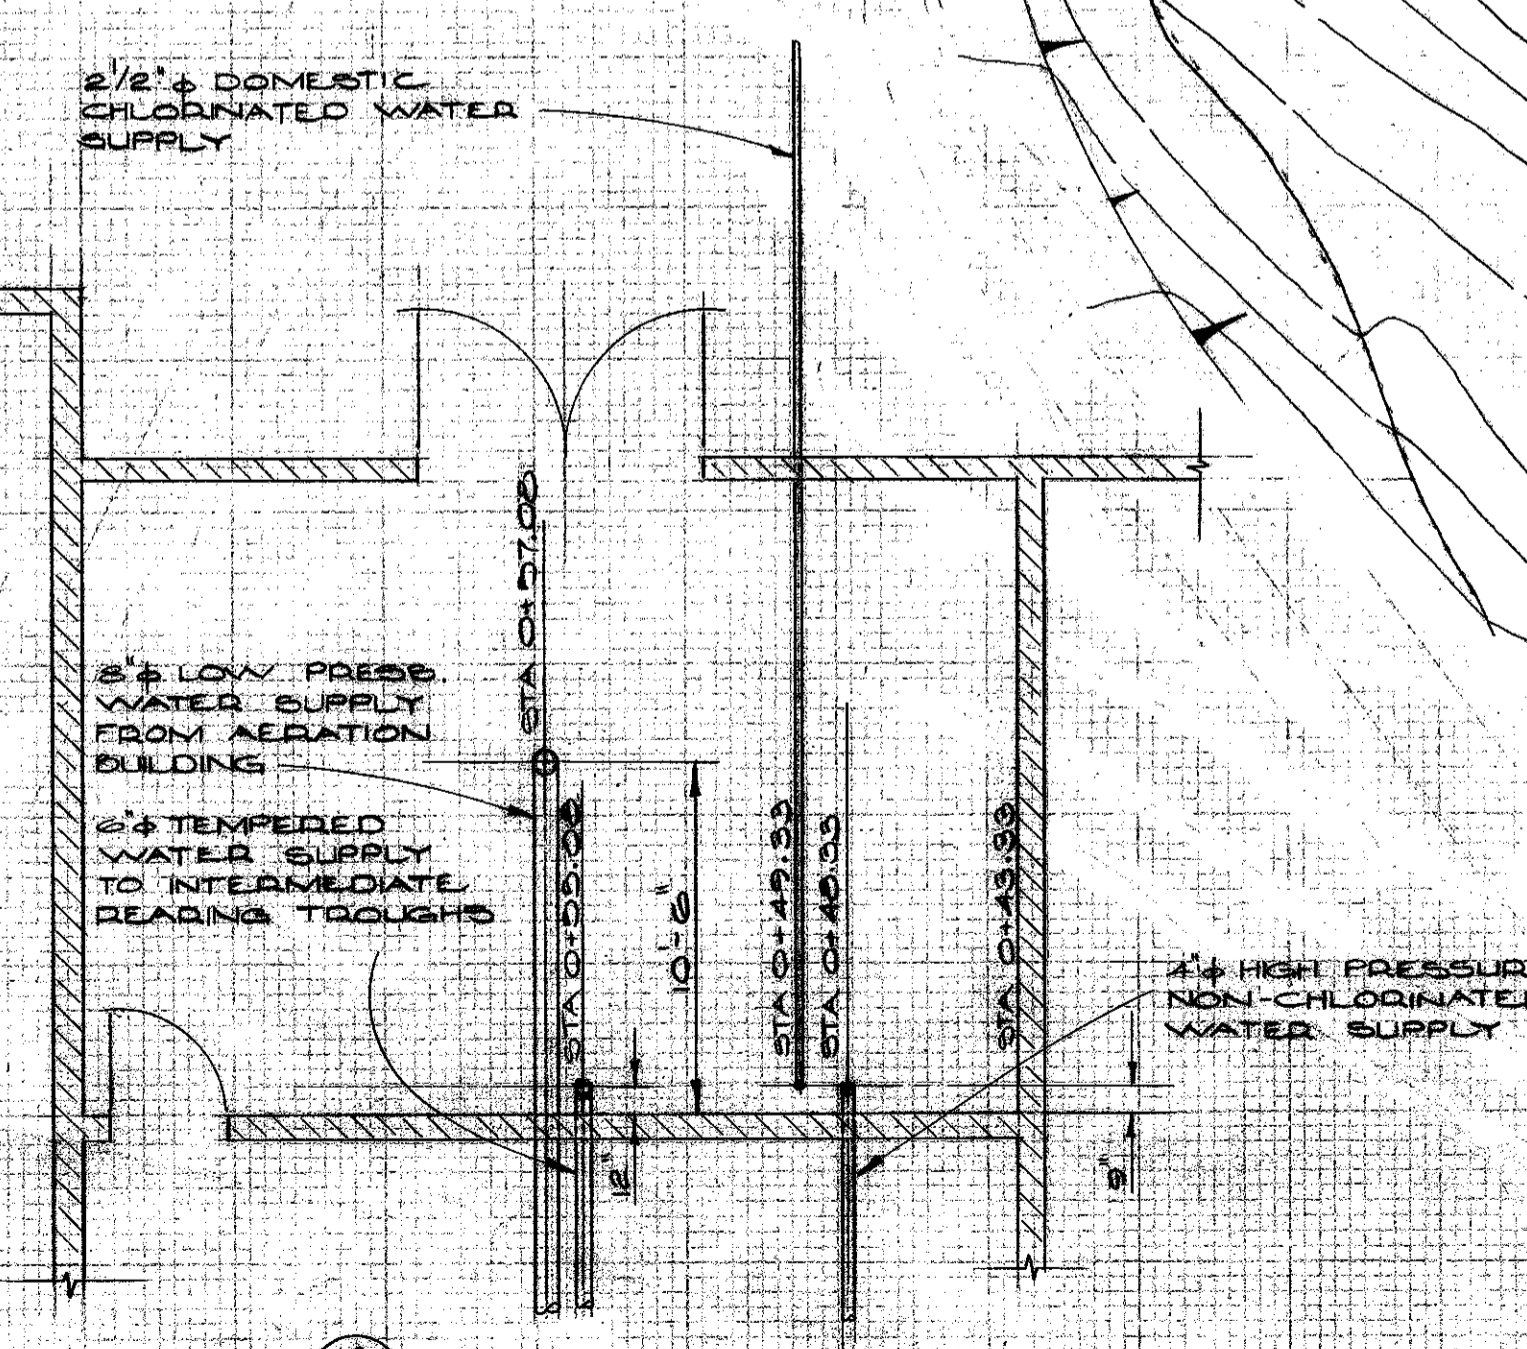

DETAIL B MECHANICAL ROOM PIPE LAYOUT
SCALE: 3/16" = 1'-0"

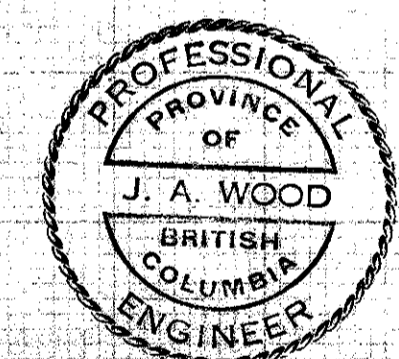

REVISIONS	ISSUE	DATE	DRN	CHD	APPO	DESCRIPTION
1	27	4-79	TS	WJS	WJS	DETAIL B/240 CORRECTED TO 15/242 CLEAR WELL CONSTRUCTED OCT. 1987

**DEPARTMENT OF THE ENVIRONMENT
FISHERIES AND MARINE SERVICE**

DESIGNED: [Signature]
DRAWN: [Signature]
CHECKED: [Signature]

RECOMMENDED: [Signature]
APPROVED: [Signature]
APPROVED: [Signature]

KERR WOOD LEIDAL ASSOCIATES LTD.
CONSULTING ENGINEERS

DESIGNED: [Signature]
DRAWN: [Signature]
CHECKED: [Signature]

APRIL 4, 1979

DEPARTMENT OF THE ENVIRONMENT
PUNTLIDGE RIVER HATCHERY
PLAN: WATER DISTRIBUTION SYSTEM
AND MISC. PIPING DETAILS

K.W.L. DWG. NO: 18-78-7
SCALE: AS SHOWN
DRAWING No. 31-6-240
SHEET 5 OF 68 ISSUE C