



ERIC VACHON
 Director, Security & Facilities
M. FARID, P. Eng.
 Manager, Building Operations & Security

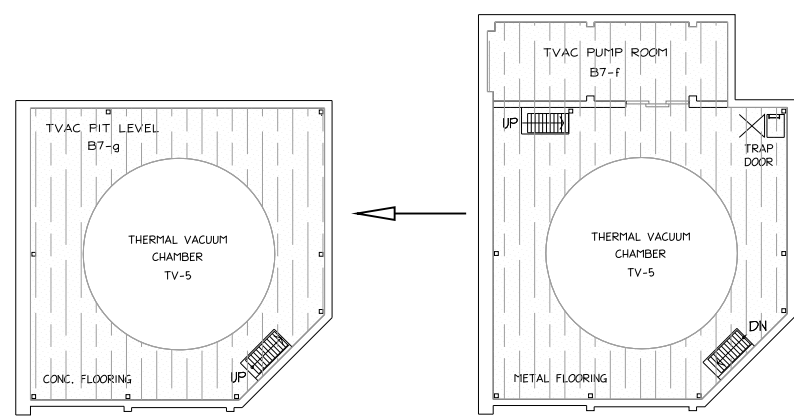


PLAN - PIT LEVEL LEVEL - ELEV. 61.42m


PLAN - PUMP ROOM LEVEL - ELEV. 66.90m

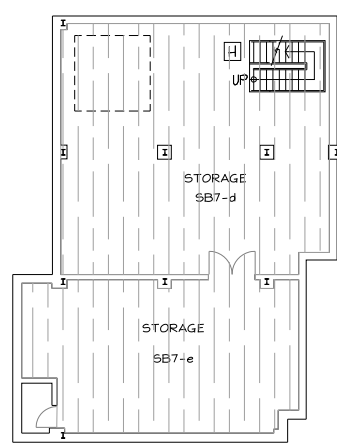

PLAN - SUB BASEMENT LEVEL - ELEV. 65.89m

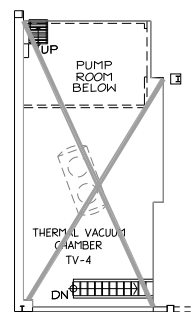

PLAN - MEZZANINE LEVEL - ELEV. 71.51m

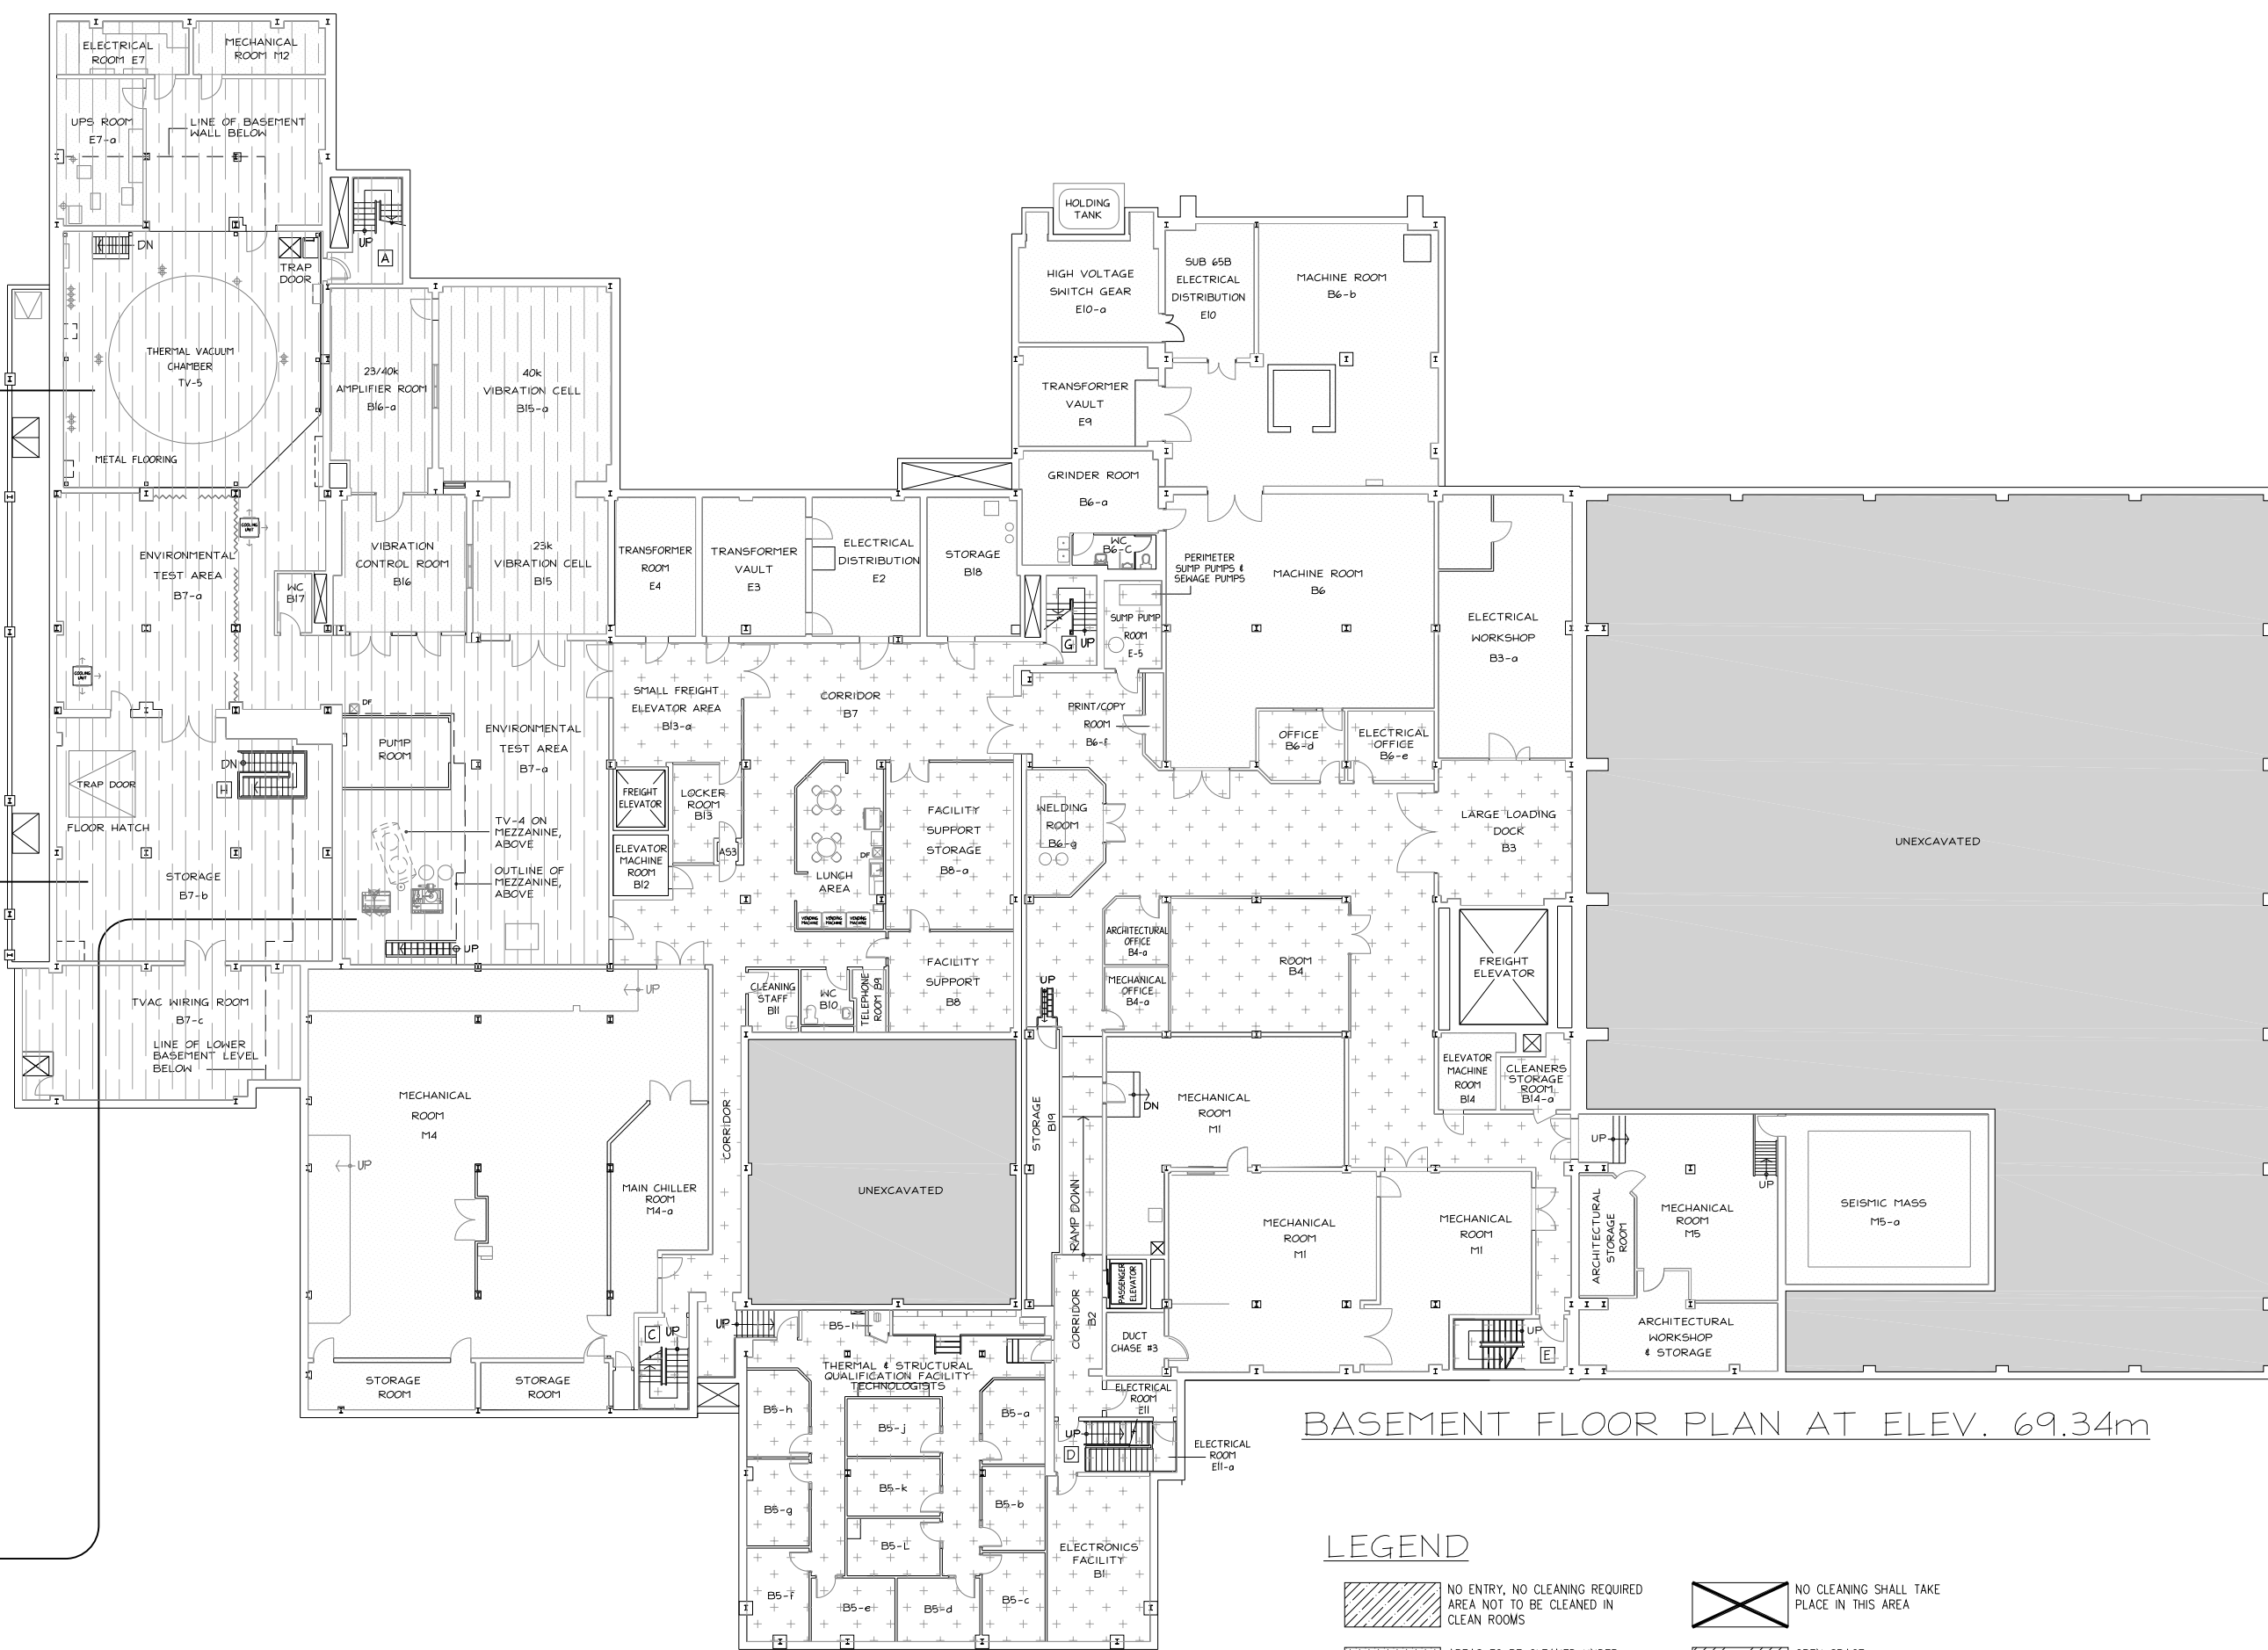

BASEMENT FLOOR PLAN AT ELEV. 69.34m

LEGEND


- NO ENTRY, NO CLEANING REQUIRED. AREA NOT TO BE CLEANED IN CLEAN ROOMS
- AREAS TO BE CLEANED UNDER SUPERVISION OF BUILDING OPERATIONS PERSONNEL
- CLEANROOM CLEANING AREAS
- GENERAL CLEANING AREAS
- NO CLEANING SHALL TAKE PLACE IN THIS AREA
- OPEN SPACE NO FLOOR BELOW (HIGH BAYS)

THIS DRAWING IS THE SOLE PROPERTY OF THE CANADIAN SPACE AGENCY "CSA" AND CAN NOT BE DISTRIBUTED OR REPRODUCED WITHOUT THE EXPRESS WRITTEN PERMISSION OF THE "CSA".

TRANSFER OF THIS DRAWING IN HARD COPY AND/OR ELECTRONIC FORMAT TO ANY OTHER ORGANIZATION MUST BE FOR A SPECIFIC AND LIMITED USE ONLY WITH PRE-AUTHORIZATION FROM THE "CSA" PROJECT AUTHORITY.

UPON COMPLETION OF SUCH USE, ALL HARD COPIES AND ELECTRONIC FILES MUST BE DESTROYED AND/OR RETURNED TO THE "CSA" PROJECT AUTHORITY.

9.		
8.		
7.		
6.		
5.		
4.		
3.		
2.	UPDATED FOR CONTRACT	AUG/16
1.	UPDATED FOR CONTRACT	JUL/10
No.	Revision	Date

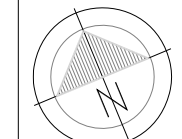

PROFESSIONAL STAMP

A	A detail no. or detail	A
C	B location drawing no. or drawing no.	B/C
	C drawing no. or detail no.	

project
 DAVID FLORIDA LABORATORY
 MID LIFE REFIT PROJECTS - PHASE VIII
 BUILDING No. 65, SHIRLEY'S BAY, ONTARIO
 CLEANING CONTRACT SET

drawing design


BASEMENT LAYOUT PLAN

designed	concu
date	
drawn	desine
date	
reviewed	examine
date	
approved	approve
date	
scale	1 : 300

project no. no. du projet

 drawing no. no. du dessin
A1

ERIC VACHON
Director, Security & Facilities
M. FARID, P. Eng.
Manager, Building Operations & Security

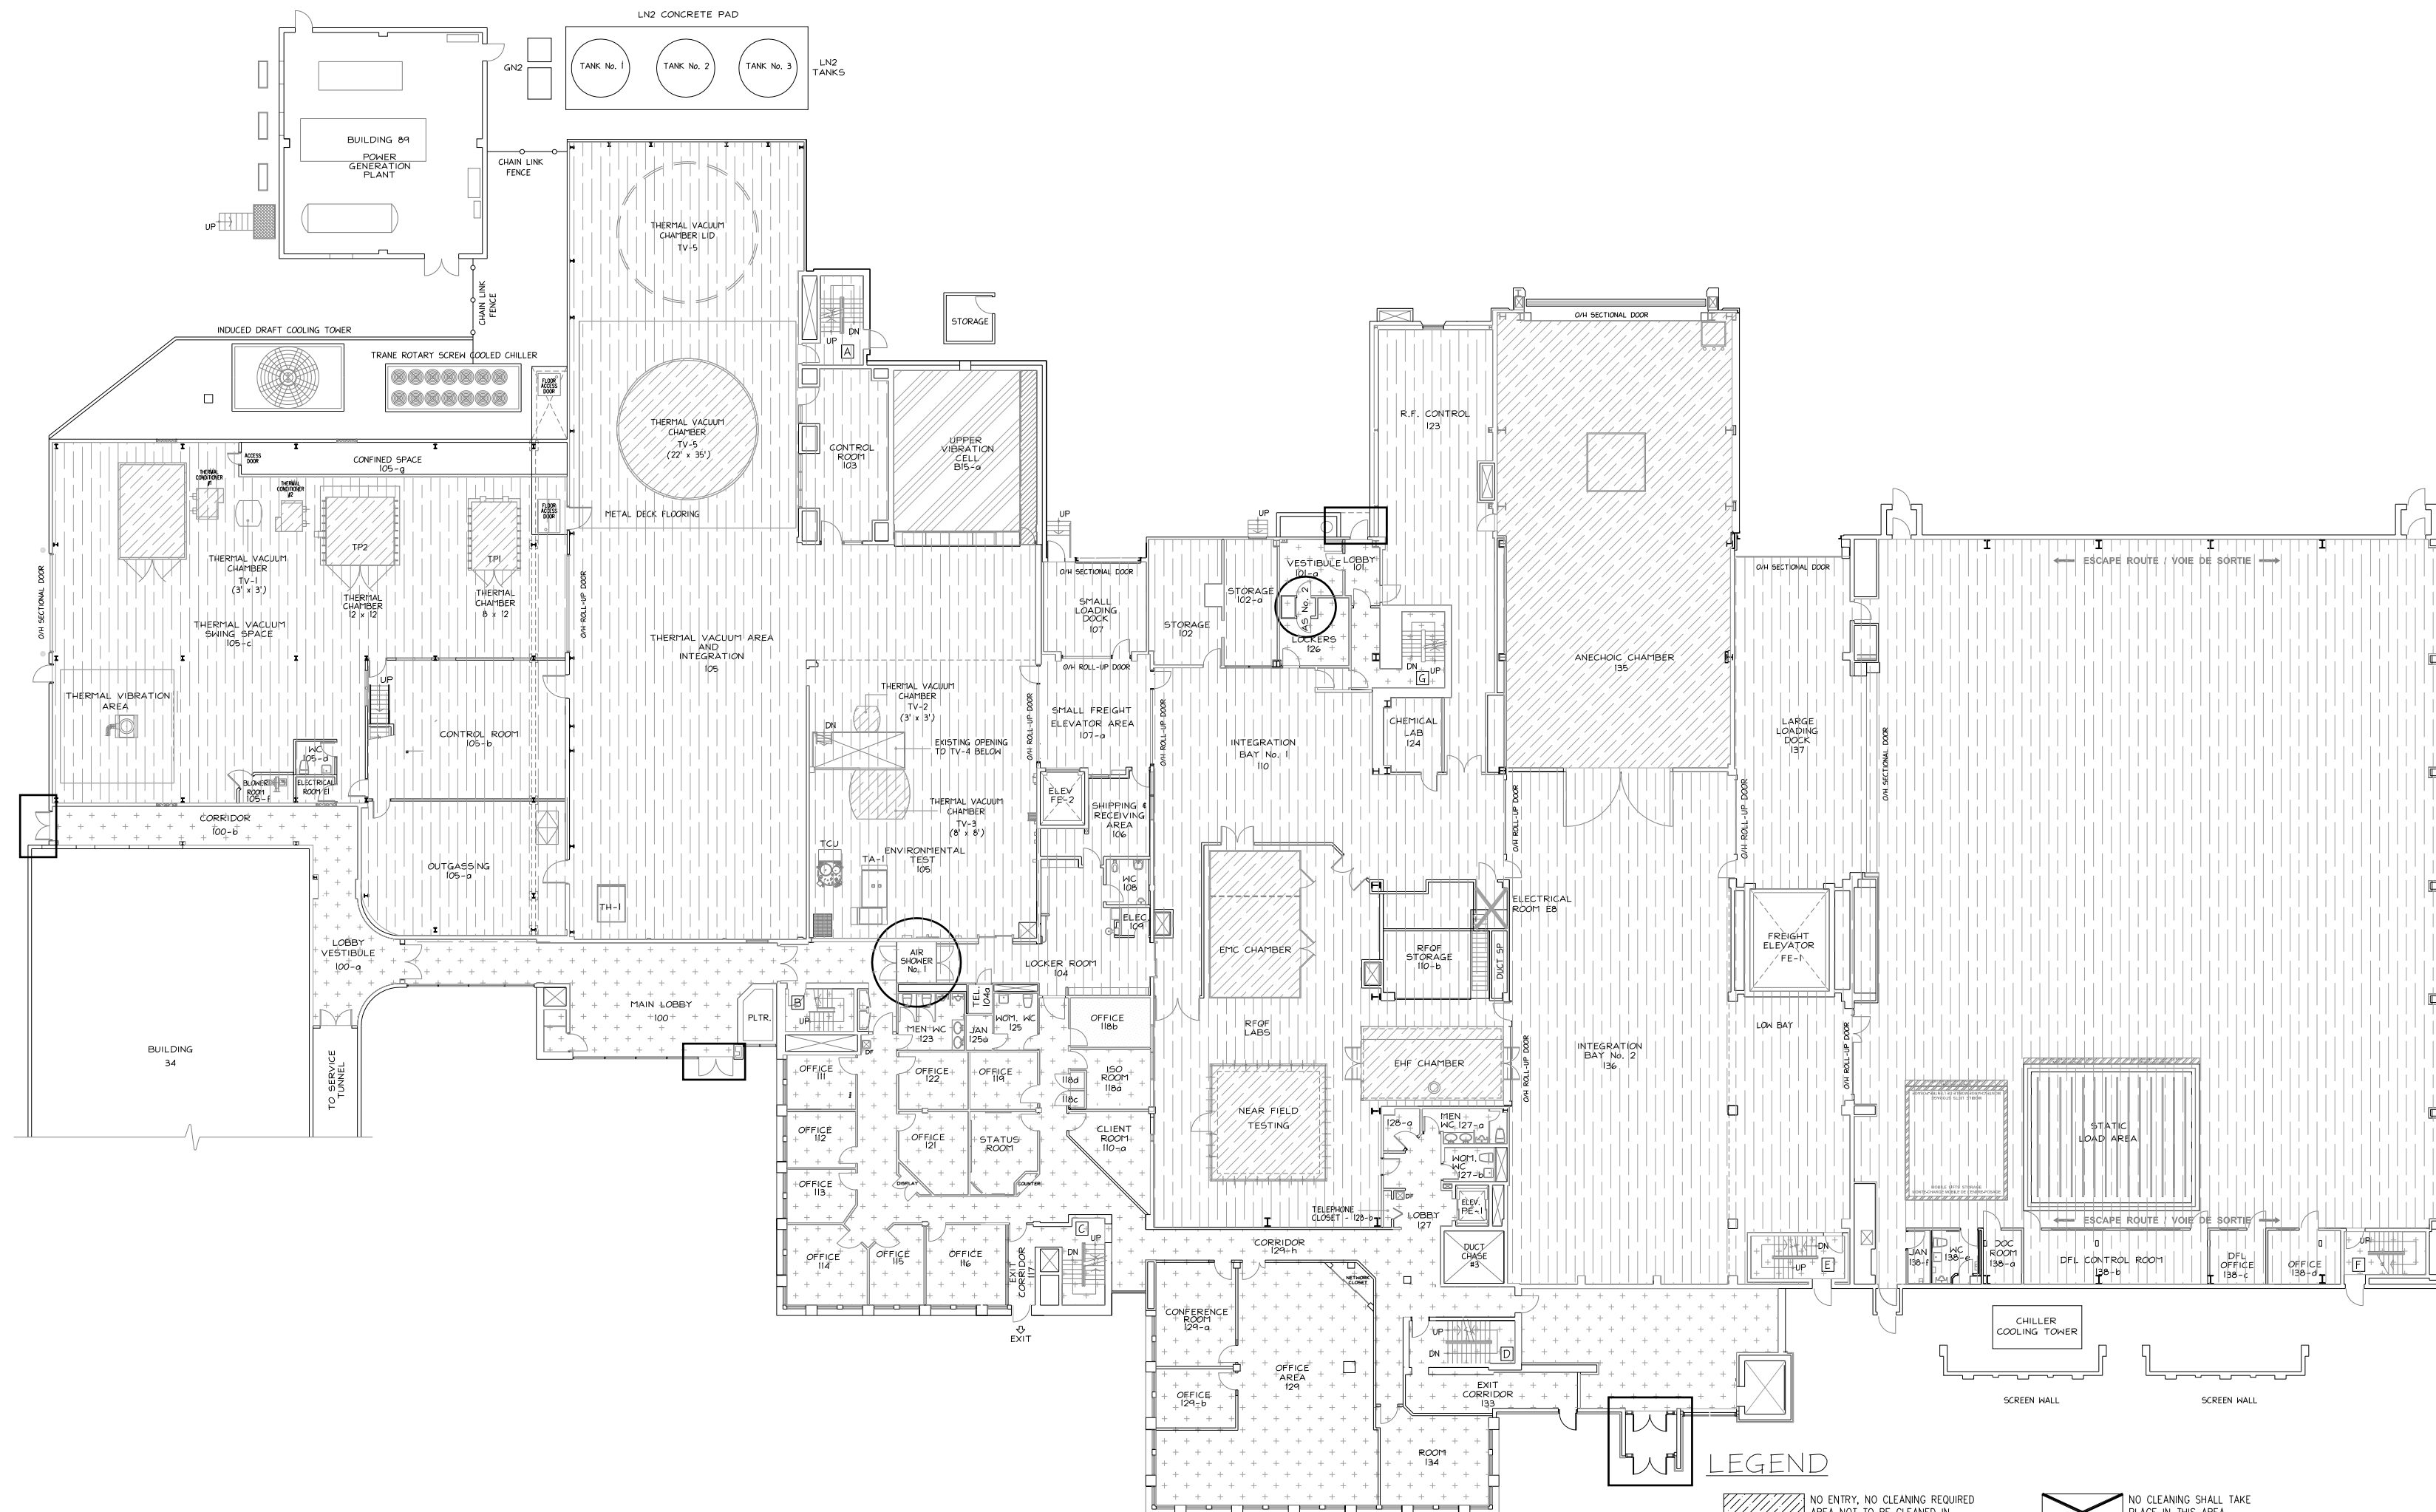

FIRST FLOOR PLAN AT ELEV. 74.22m

THIS DRAWING IS THE SOLE PROPERTY OF THE CANADIAN SPACE AGENCY "CSA" AND CAN NOT BE DISTRIBUTED OR REPRODUCED WITHOUT THE EXPRESS WRITTEN PERMISSION OF THE "CSA".

TRANSFER OF THIS DRAWING IN HARD COPY AND/OR ELECTRONIC FORMAT TO ANY OTHER ORGANIZATION MUST BE FOR A SPECIFIC AND LIMITED USE ONLY WITH PRE-AUTHORIZATION FROM THE "CSA" PROJECT AUTHORITY.

UPON COMPLETION OF SUCH USE, ALL HARD COPIES AND ELECTRONIC FILES MUST BE DESTROYED AND/OR RETURNED TO THE "CSA" PROJECT AUTHORITY.

9.		
8.		
7.		
6.		
5.		
4.		
3.		
2.	UPDATED FOR CONTRACT	AUG/16
1.	UPDATED FOR CONTRACT	JUL/10
No.	Revision	Date

PROFESSIONAL STAMP

A: design no. du dessin
B: location drawing no. sur les plans
C: drawing no. dessin no.

PROJECT

DAVID FLORIDA LABORATORY
MID LIFE REFIT PROJECTS - PHASE VIII
BUILDING No. 65, SHIRLEY'S BAY, ONTARIO
CLEANING CONTRACT SET


drawing

FIRST FLOOR LAYOUT PLAN

designed	
date	
drawn	designe
date	
reviewed	examine
date	
approved	approve
date	
scale	1 : 300
project no.	no. du projet
drawing no.	no. du dessin

A2

ERIC VACHON
Director, Security & Facilities
M. FARID, P. Eng.
Manager, Building Operations & Security

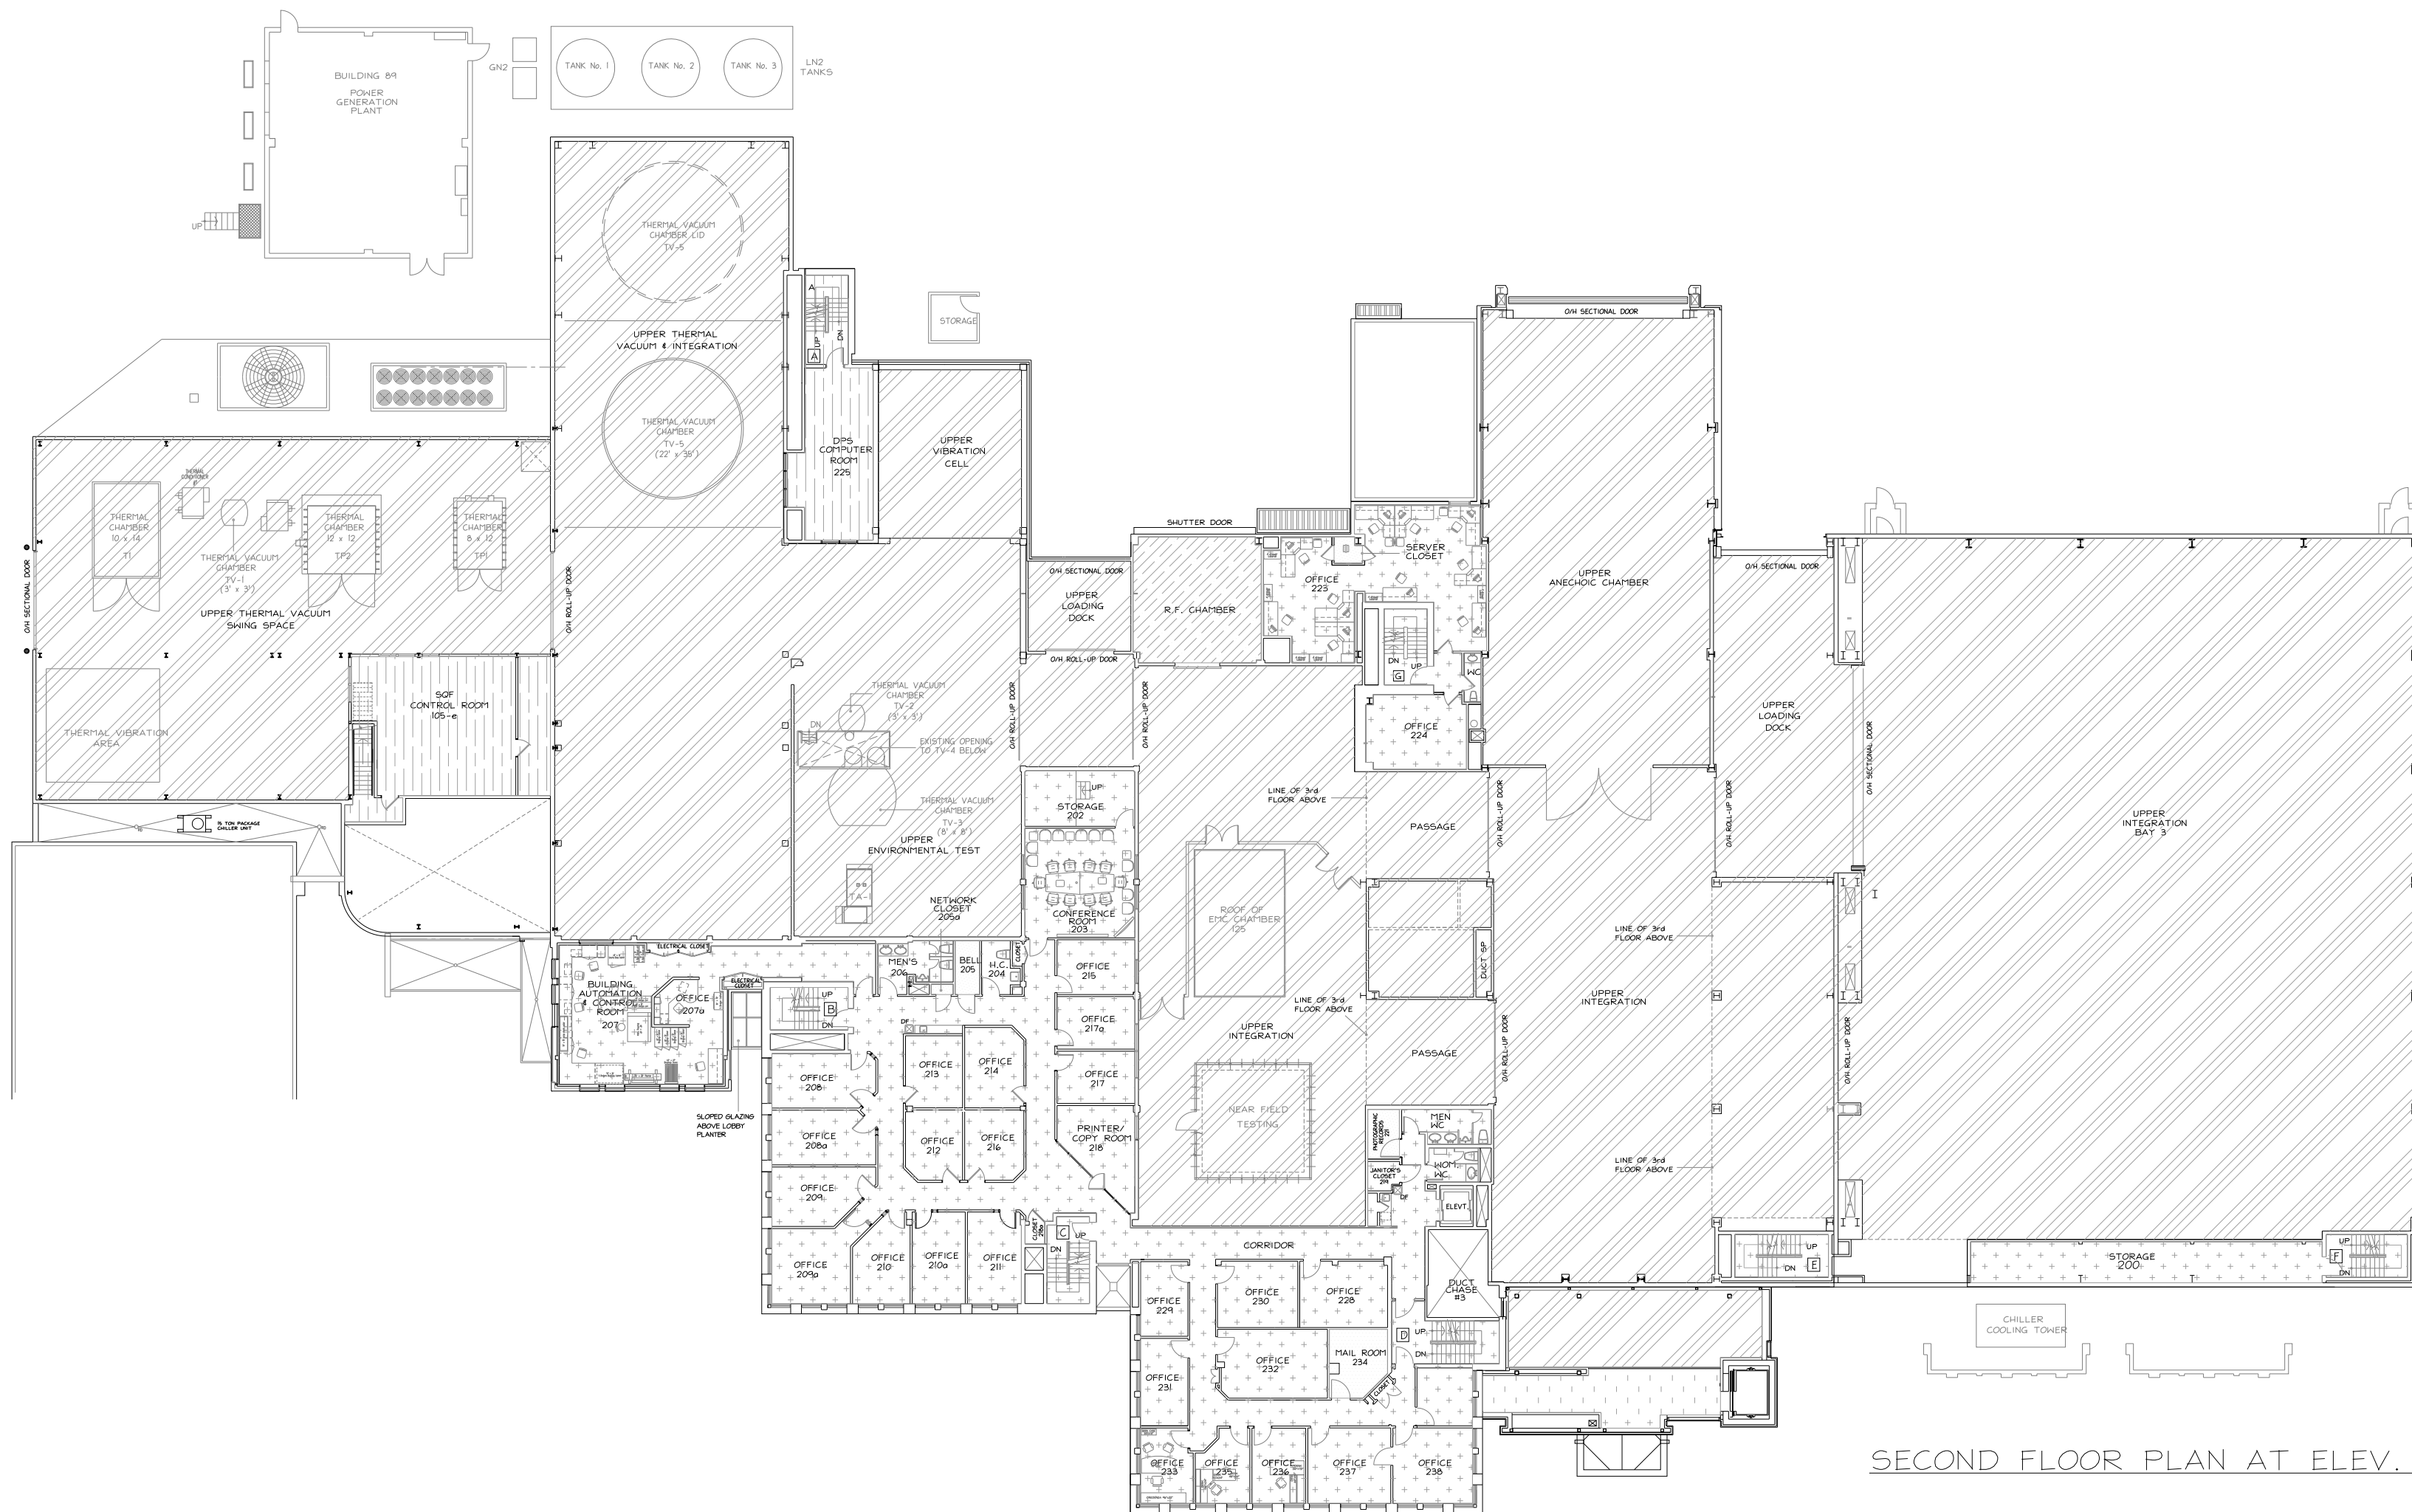

SECOND FLOOR PLAN AT ELEV. 77.88m

LEGEND


- NO ENTRY, NO CLEANING REQUIRED AREA NOT TO BE CLEANED IN CLEAN ROOMS
- AREAS TO BE CLEANED UNDER SUPERVISION OF BUILDING OPERATIONS PERSONNEL
- CLEANROOM CLEANING AREAS
- GENERAL CLEANING AREAS
- NO CLEANING SHALL TAKE PLACE IN THIS AREA
- OPEN SPACE NO FLOOR BELOW (HIGH BAYS)

THIS DRAWING IS THE SOLE PROPERTY OF THE CANADIAN SPACE AGENCY "CSA" AND CAN NOT BE DISTRIBUTED OR REPRODUCED WITHOUT THE EXPRESS WRITTEN PERMISSION OF THE "CSA".


TRANSFER OF THIS DRAWING IN HARD COPY AND/OR ELECTRONIC FORMAT TO ANY OTHER ORGANIZATION MUST BE FOR A SPECIFIC AND LIMITED USE ONLY WITH PRE-AUTHORIZATION FROM THE "CSA" PROJECT AUTHORITY.

UPON COMPLETION OF SUCH USE, ALL HARD COPIES AND ELECTRONIC FILES MUST BE DESTROYED AND/OR RETURNED TO THE "CSA" PROJECT AUTHORITY.

9.		
8.		
7.		
6.		
5.		
4.		
3.		
2.	UPDATED FOR CONTRACT	AUG/16
1.	UPDATED FOR CONTRACT	JUL/10
No.	Revision	Date

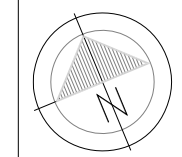

PROFESSIONAL STAMP

 


project
**DAVID FLORIDA LABORATORY
MID LIFE REFIT PROJECTS - PHASE VIII**
BUILDING No. 65, SHIRLEY'S BAY, ONTARIO
CLEANING CONTRACT SET

drawing
**SECOND FLOOR
LAYOUT PLAN**

designed	
date	
drawn	designe
date	
reviewed	examine
date	
approved	approve
date	
scale	1 : 300
project no.	no. du projet
drawing no.	no. du dessin


ERIC VACHON
 Director, Security & Facilities
M. FARID, P. Eng.
 Manager, Building Operations & Security

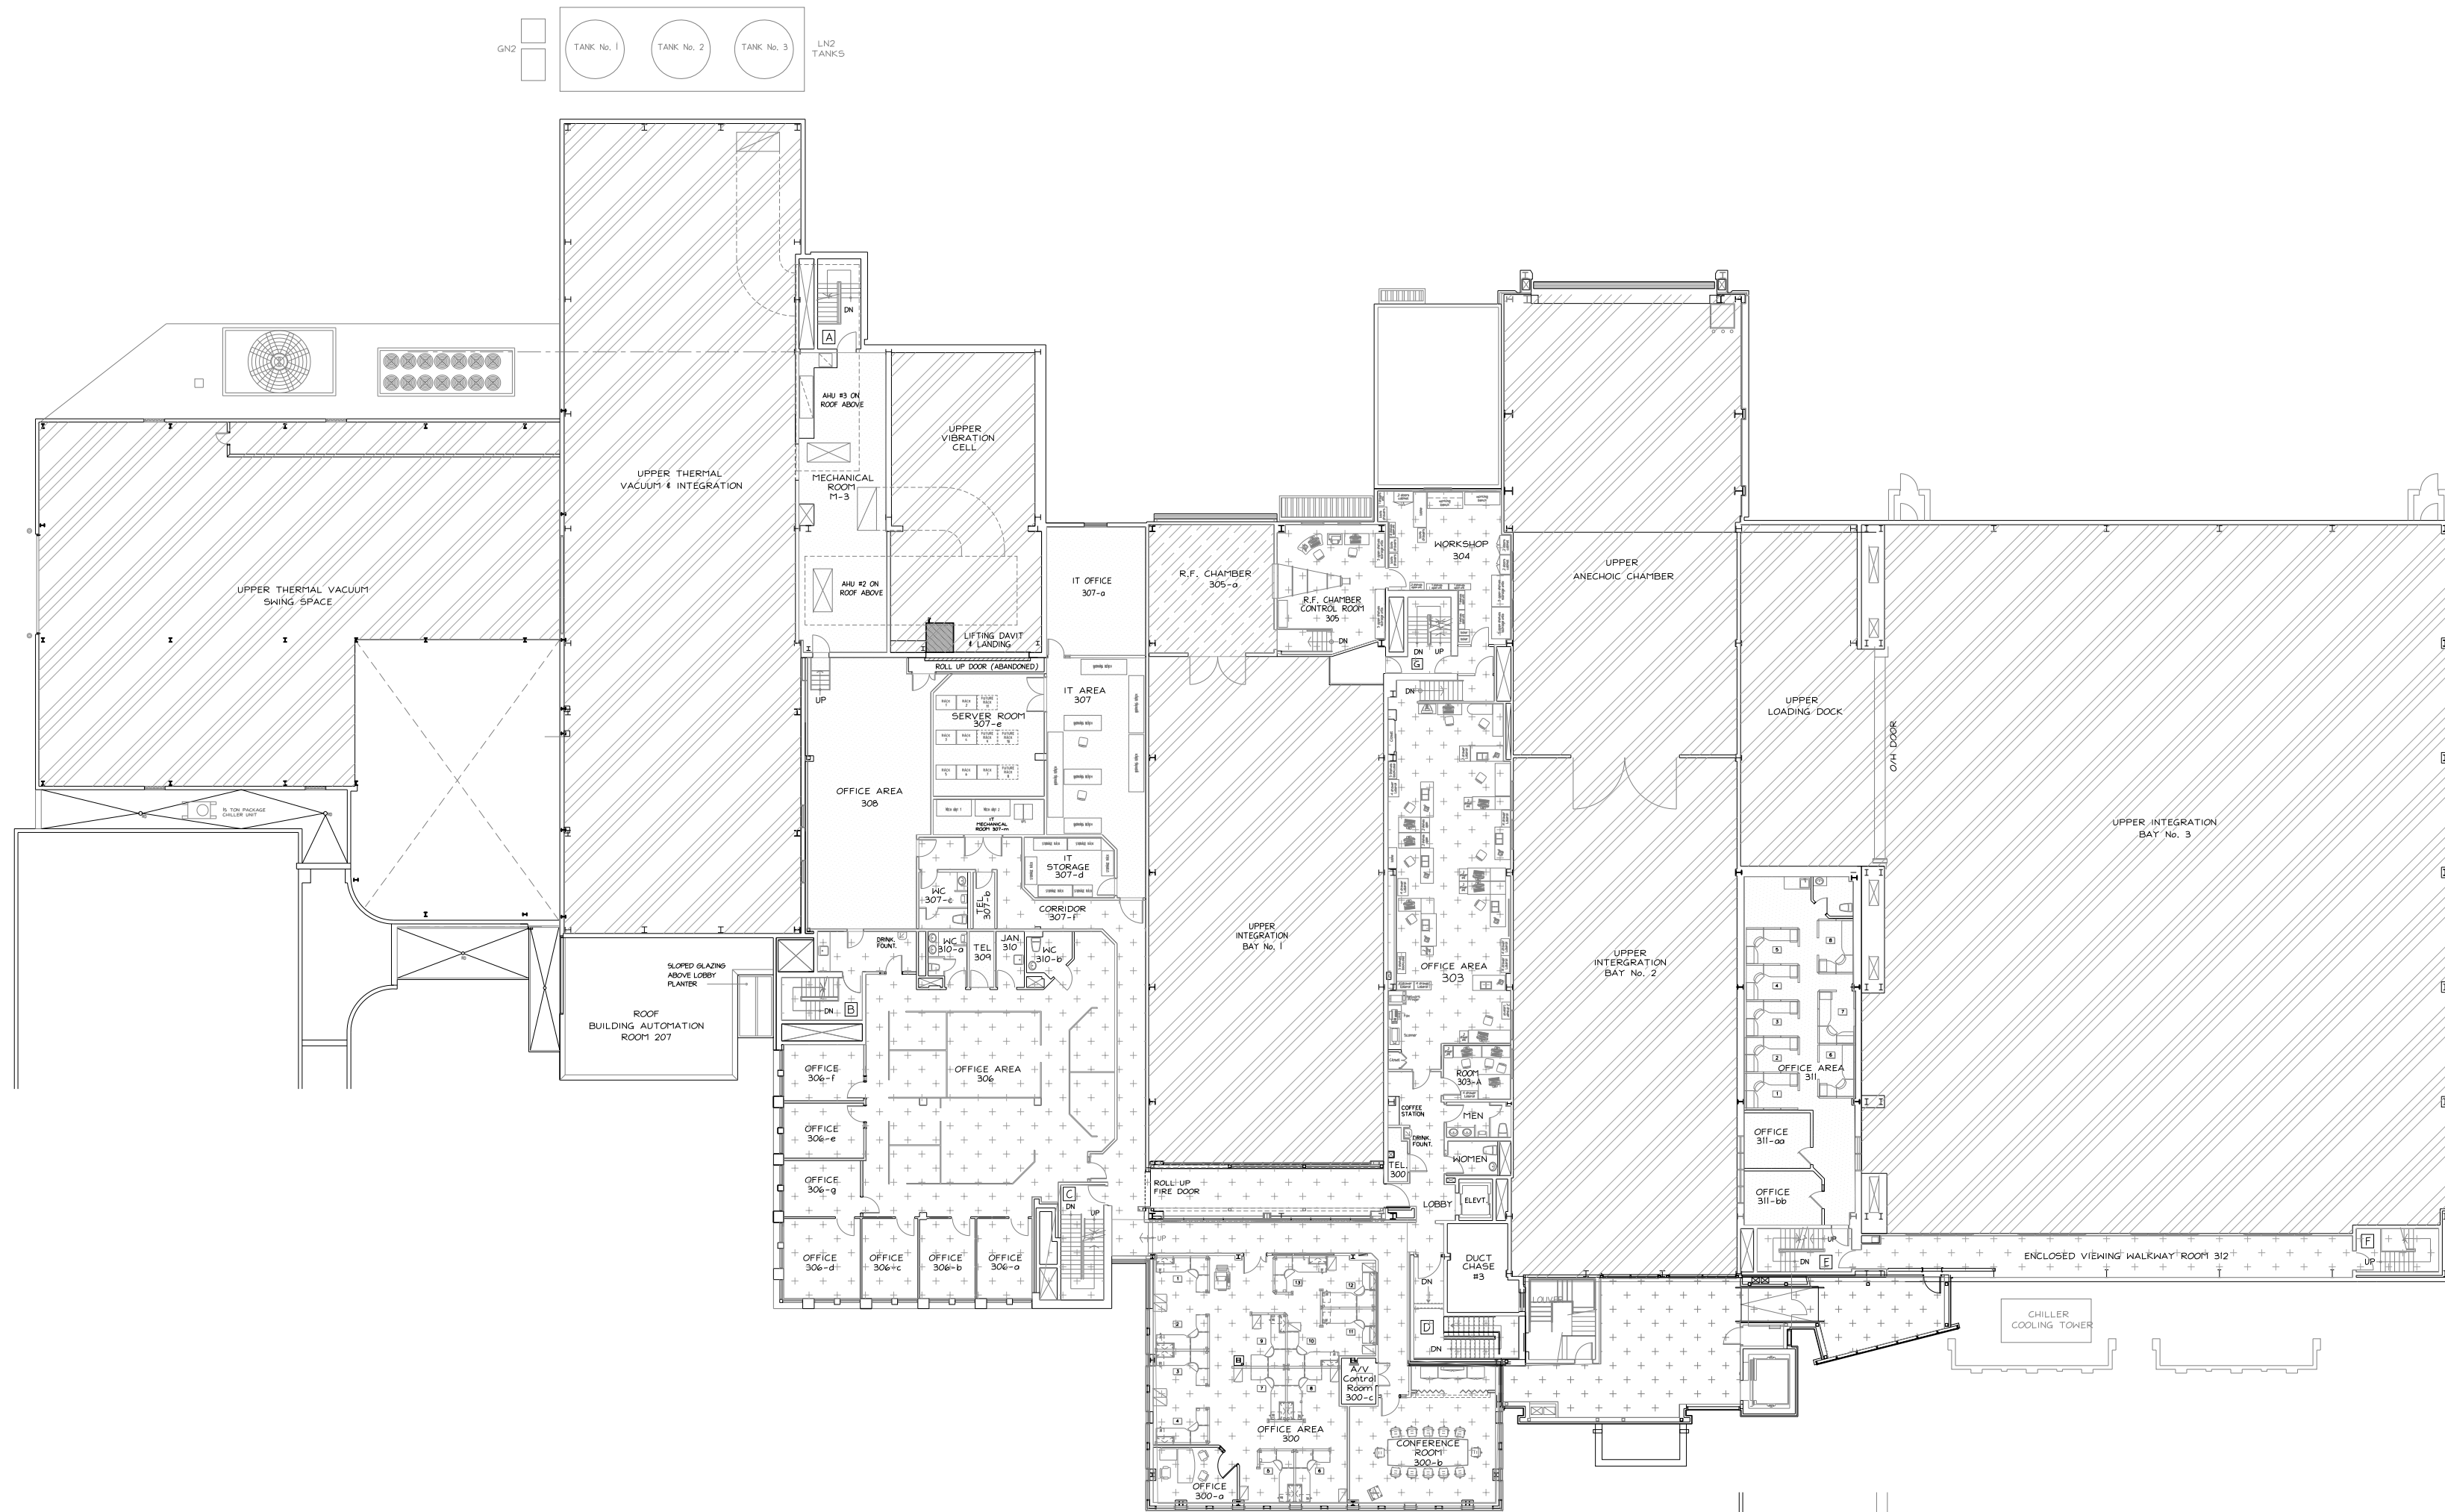

THIRD FLOOR PLAN AT ELEV. 82.8m

LEGEND

- NO ENTRY, NO CLEANING REQUIRED AREA NOT TO BE CLEANED IN CLEAN ROOMS
- NO CLEANING SHALL TAKE PLACE IN THIS AREA
- AREAS TO BE CLEANED UNDER SUPERVISION OF BUILDING OPERATIONS PERSONNEL
- OPEN SPACE NO FLOOR BELOW (HIGH BAYS)
- CLEANROOM CLEANING AREAS
- GENERAL CLEANING AREAS

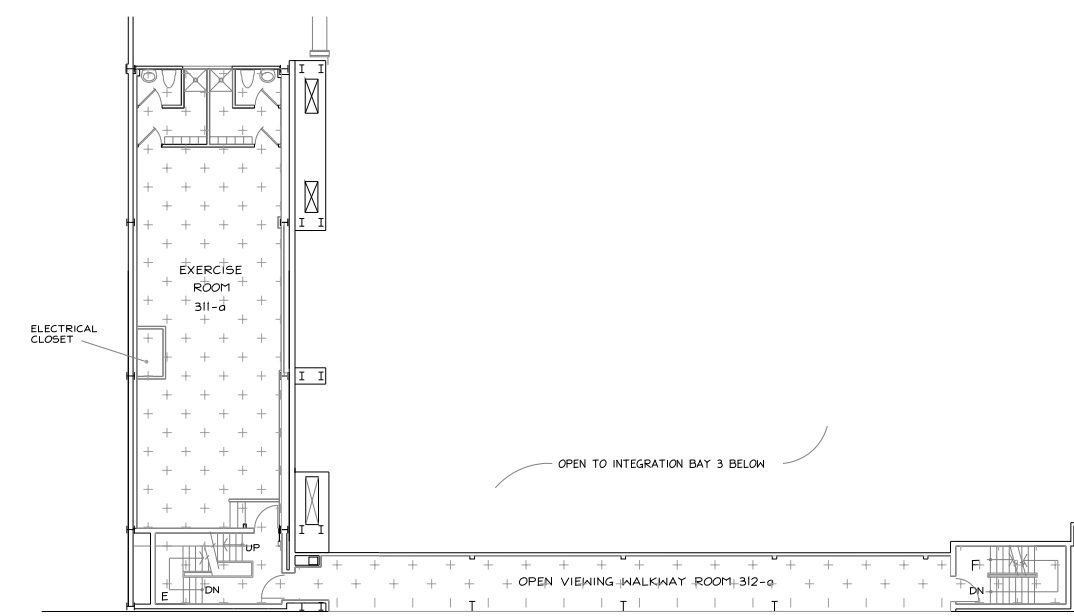

THIRD FLOOR MEZZANINE PART PLAN AT ELEV. 85.8m


THIS DRAWING IS THE SOLE PROPERTY OF THE CANADIAN SPACE AGENCY "CSA" AND CAN NOT BE DISTRIBUTED OR REPRODUCED WITHOUT THE EXPRESS WRITTEN PERMISSION OF THE "CSA".

TRANSFER OF THIS DRAWING IN HARD COPY AND/OR ELECTRONIC FORMAT TO ANY OTHER ORGANIZATION MUST BE FOR A SPECIFIC AND LIMITED USE ONLY WITH PRE-AUTHORIZATION FROM THE "CSA" PROJECT AUTHORITY.

UPON COMPLETION OF SUCH USE, ALL HARD COPIES AND ELECTRONIC FILES MUST BE DESTROYED AND/OR RETURNED TO THE "CSA" PROJECT AUTHORITY.

9.		
8.		
7.		
6.		
5.		
4.		
3.		
2.	UPDATED FOR CONTRACT	AUG/16
1.	UPDATED FOR CONTRACT	JUL/10
No.	Revision	Date

 PROFESSIONAL STAMP



project
 DAVID FLORIDA LABORATORY
 MID LIFE REFIT PROJECTS - PHASE VIII
 BUILDING No. 65, SHIRLEY'S BAY, ONTARIO
 CLEANING CONTRACT SET

drawing desin

THIRD FLOOR LAYOUT PLAN

designed conca
 date
 drawn desine
 date
 reviewed examine
 date
 approved approve
 date
 scale

1 : 300

project no. no. du projet


drawing no. no. du desin

A4

ERIC VACHON
Director, Security & Facilities
M. FARID, P. Eng.
Manager, Building Operations & Security

THIS DRAWING IS THE SOLE PROPERTY OF THE CANADIAN SPACE AGENCY "CSA" AND CAN NOT BE DISTRIBUTED OR REPRODUCED WITHOUT THE EXPRESS WRITTEN PERMISSION OF THE "CSA".
TRANSFER OF THIS DRAWING IN HARD COPY AND/OR ELECTRONIC FORMAT TO ANY OTHER ORGANIZATION MUST BE FOR A SPECIFIC AND LIMITED USE ONLY WITH PRE-AUTHORIZATION FROM THE "CSA" PROJECT AUTHORITY.
UPON COMPLETION OF SUCH USE, ALL HARD COPIES AND ELECTRONIC FILES MUST BE DESTROYED AND/OR RETURNED TO THE "CSA" PROJECT AUTHORITY.

9.		
8.		
7.		
6.		
5.		
4.		
3.		
2.	UPDATED FOR CONTRACT	AUG/16
1.	UPDATED FOR CONTRACT	JUL/10
No.	Revision	Date

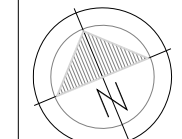

PROFESSIONAL STAMP

A	A detail no. for detail	A
C	B location drawing no. for detail no.	B/C
	C drawing no. detail no.	


project
DAVID FLORIDA LABORATORY
MID LIFE REFIT PROJECTS - PHASE VIII
BUILDING No. 65, SHIRLEY'S BAY, ONTARIO
CLEANING CONTRACT SET

drawing design

FOURTH FLOOR LAYOUT PLAN

designed	concu
date	
drawn	desine
date	
reviewed	examine
date	
approved	approve
date	
scale	1 : 300

project no.	no. du projet
-----	-----
drawing no.	no. du dessin
A5	

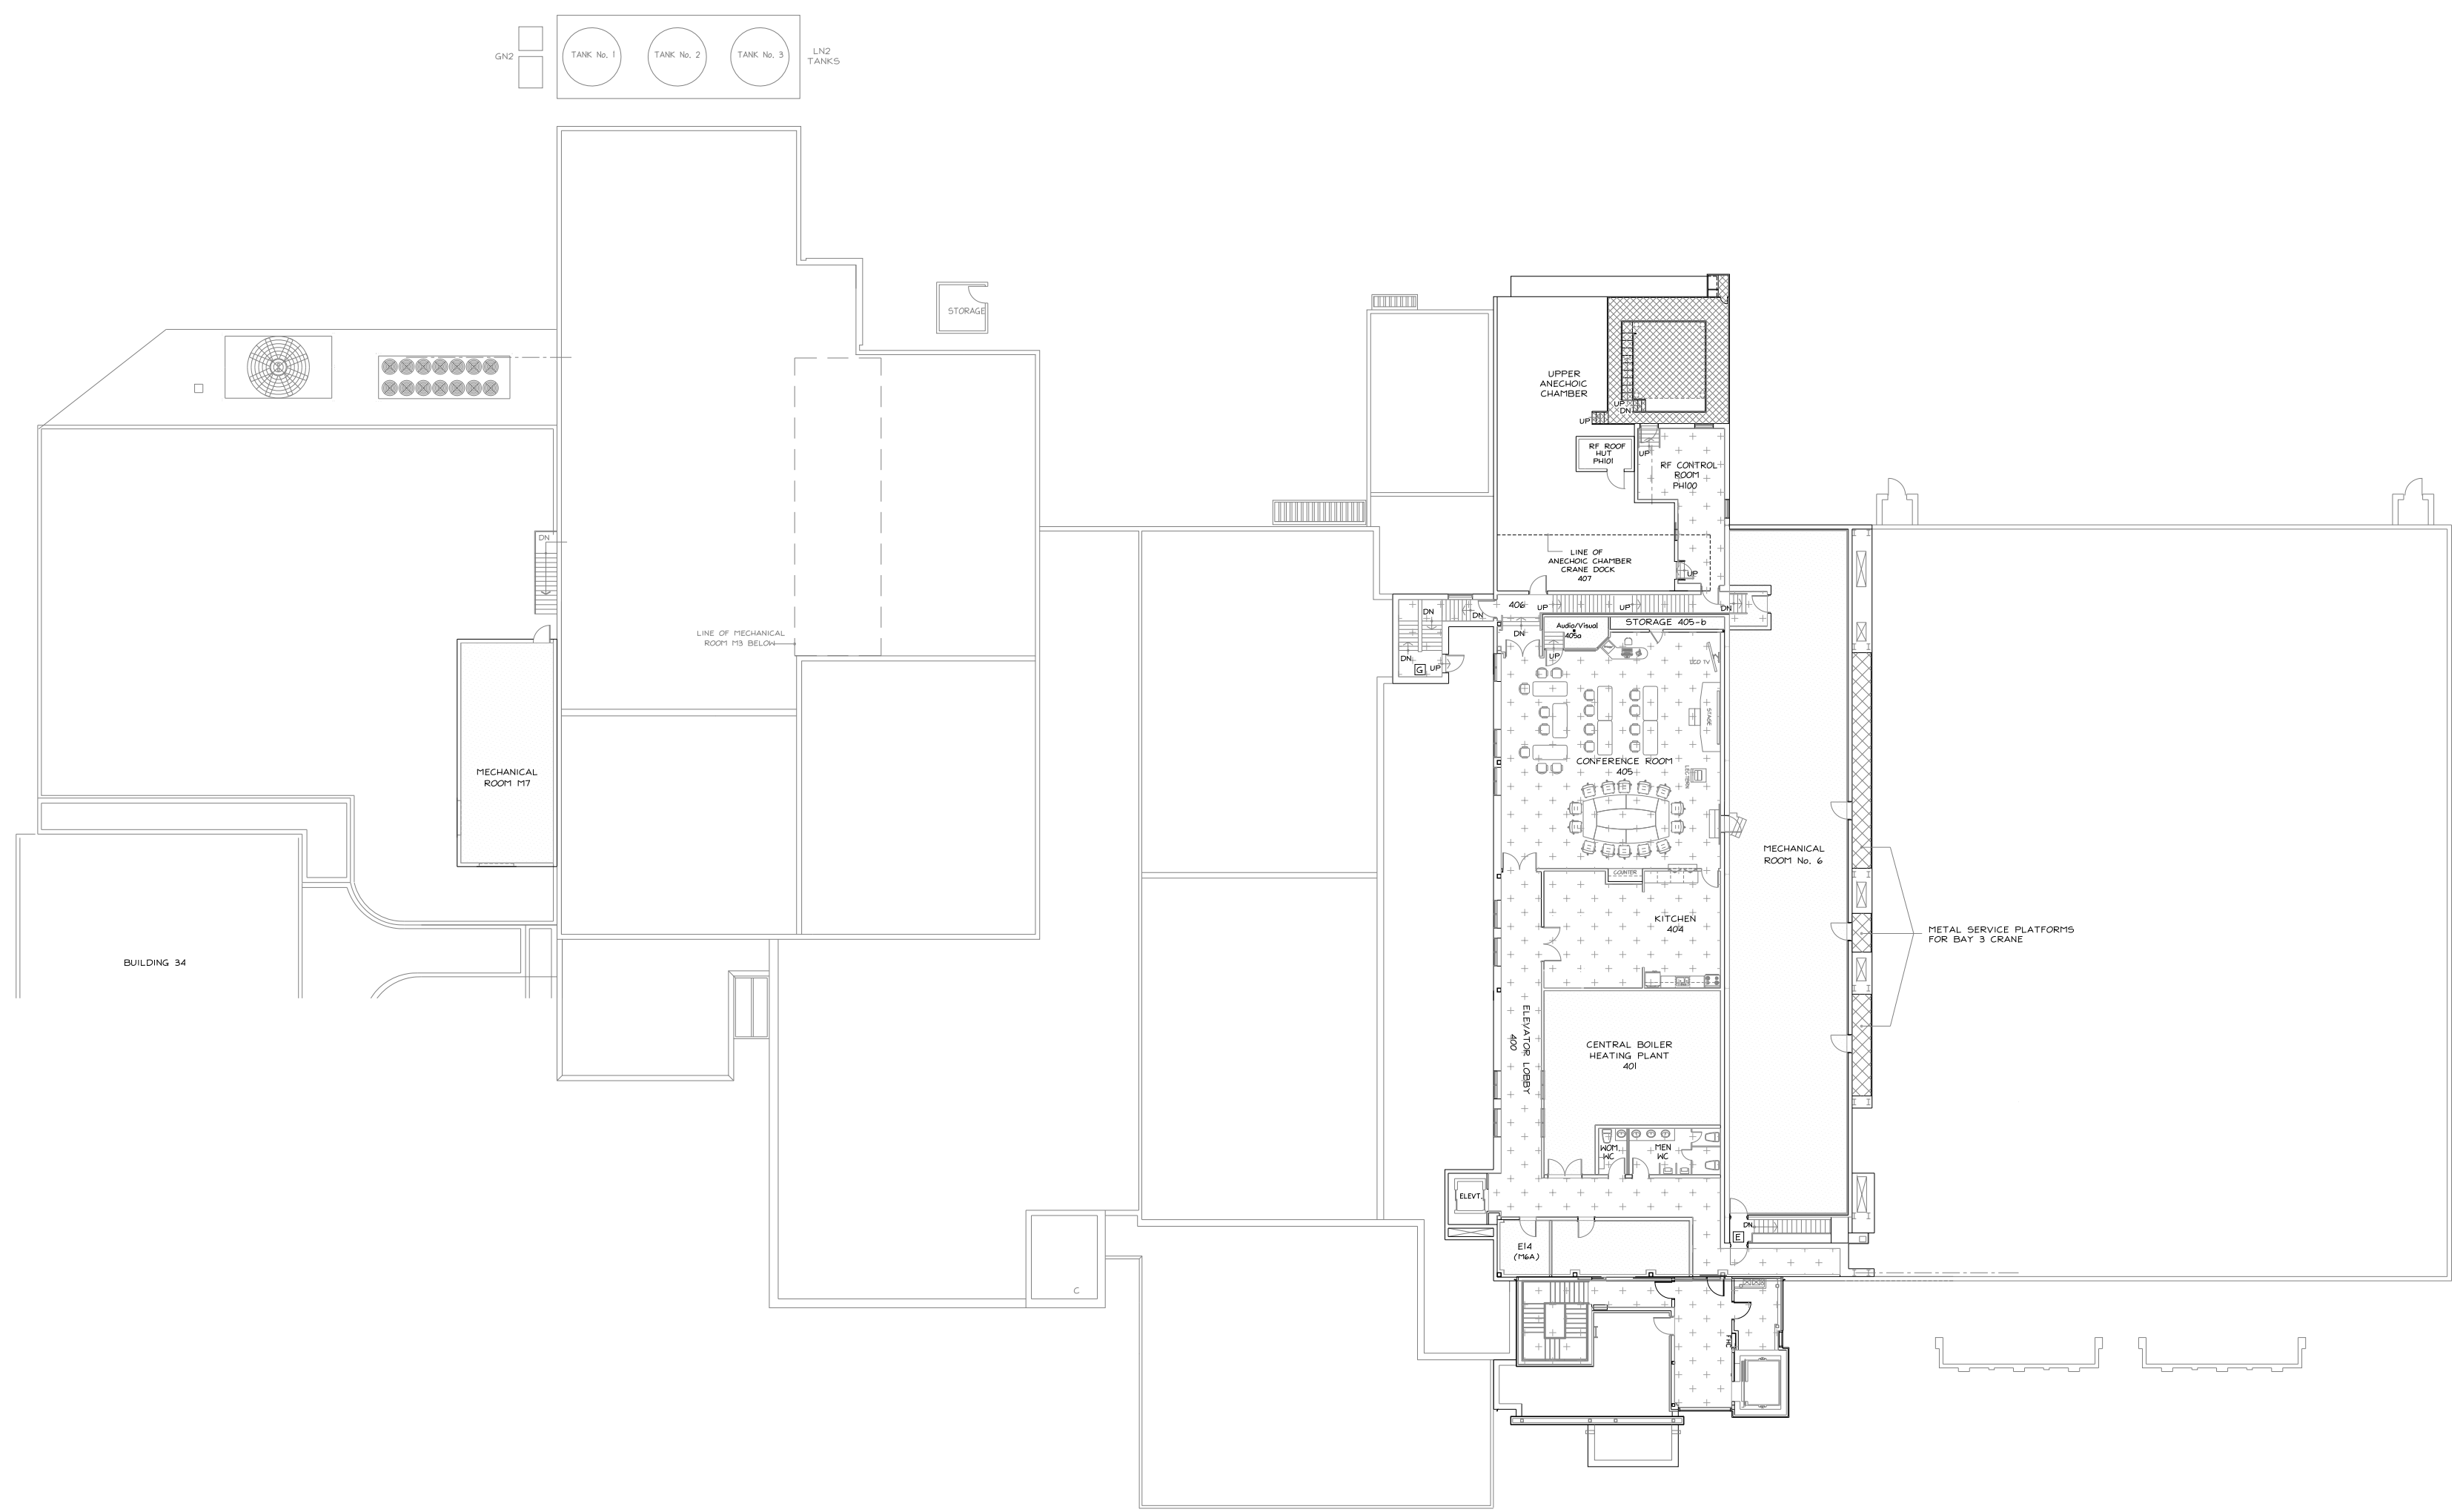

LEGEND

- NO ENTRY, NO CLEANING REQUIRED
AREA NOT TO BE CLEANED IN
CLEAN ROOMS
- AREAS TO BE CLEANED UNDER
SUPERVISION OF BUILDING
OPERATIONS PERSONNEL
- CLEANROOM CLEANING AREAS
- GENERAL CLEANING AREAS
- NO CLEANING SHALL TAKE
PLACE IN THIS AREA
- OPEN SPACE
NO FLOOR BELOW
(HIGH BAYS)

BUILDING 34



LINE OF MECHANICAL ROOM 117 BELOW

STORAGE

UPPER ANECHOIC CHAMBER

RF ROOF ALT. BRN

RF CONTROL ROOM PH20

LINE OF ANECHOIC CHAMBER CRANE DOCK 407

406 UP

STORAGE 405-b

405

405

CONFERENCE ROOM 1

404

404

KITCHEN

404

400

CENTRAL BOILER HEATING PLANT

401

400

ELEVATION LOBBY

400

400

MECHANICAL ROOM No. 6

400

400

METAL SERVICE PLATFORMS FOR BAY 3 CRANE

400

400

ELEVATOR

400

400

ELEVATOR


400

400


ELEVATOR

400


ERIC VACHON
Director, Security & Facilities
M. FARID, P. Eng.
Manager, Building Operations & Security

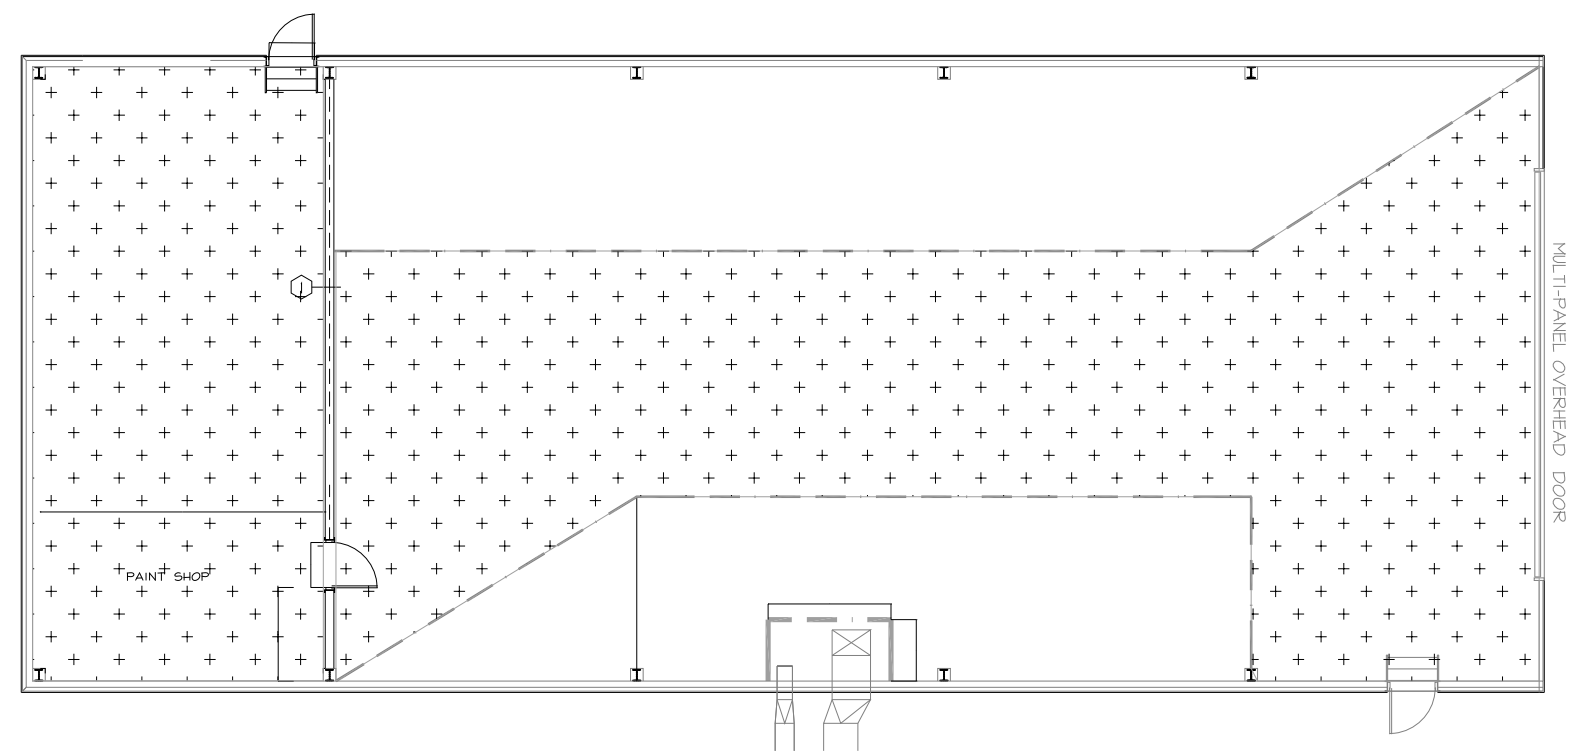

BUILDING 80 FLOOR PLAN

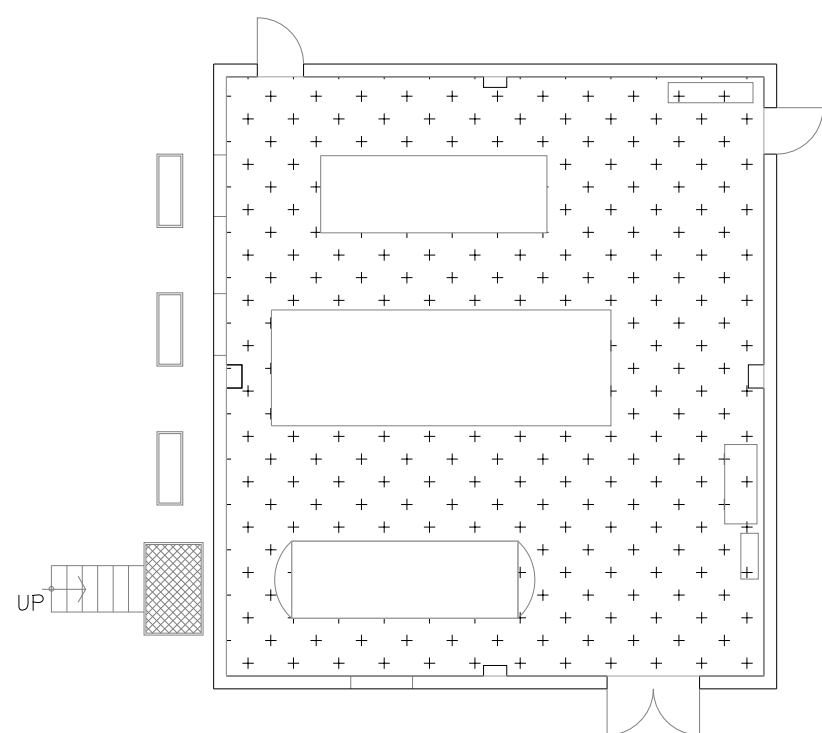

BUILDING 89 FLOOR PLAN

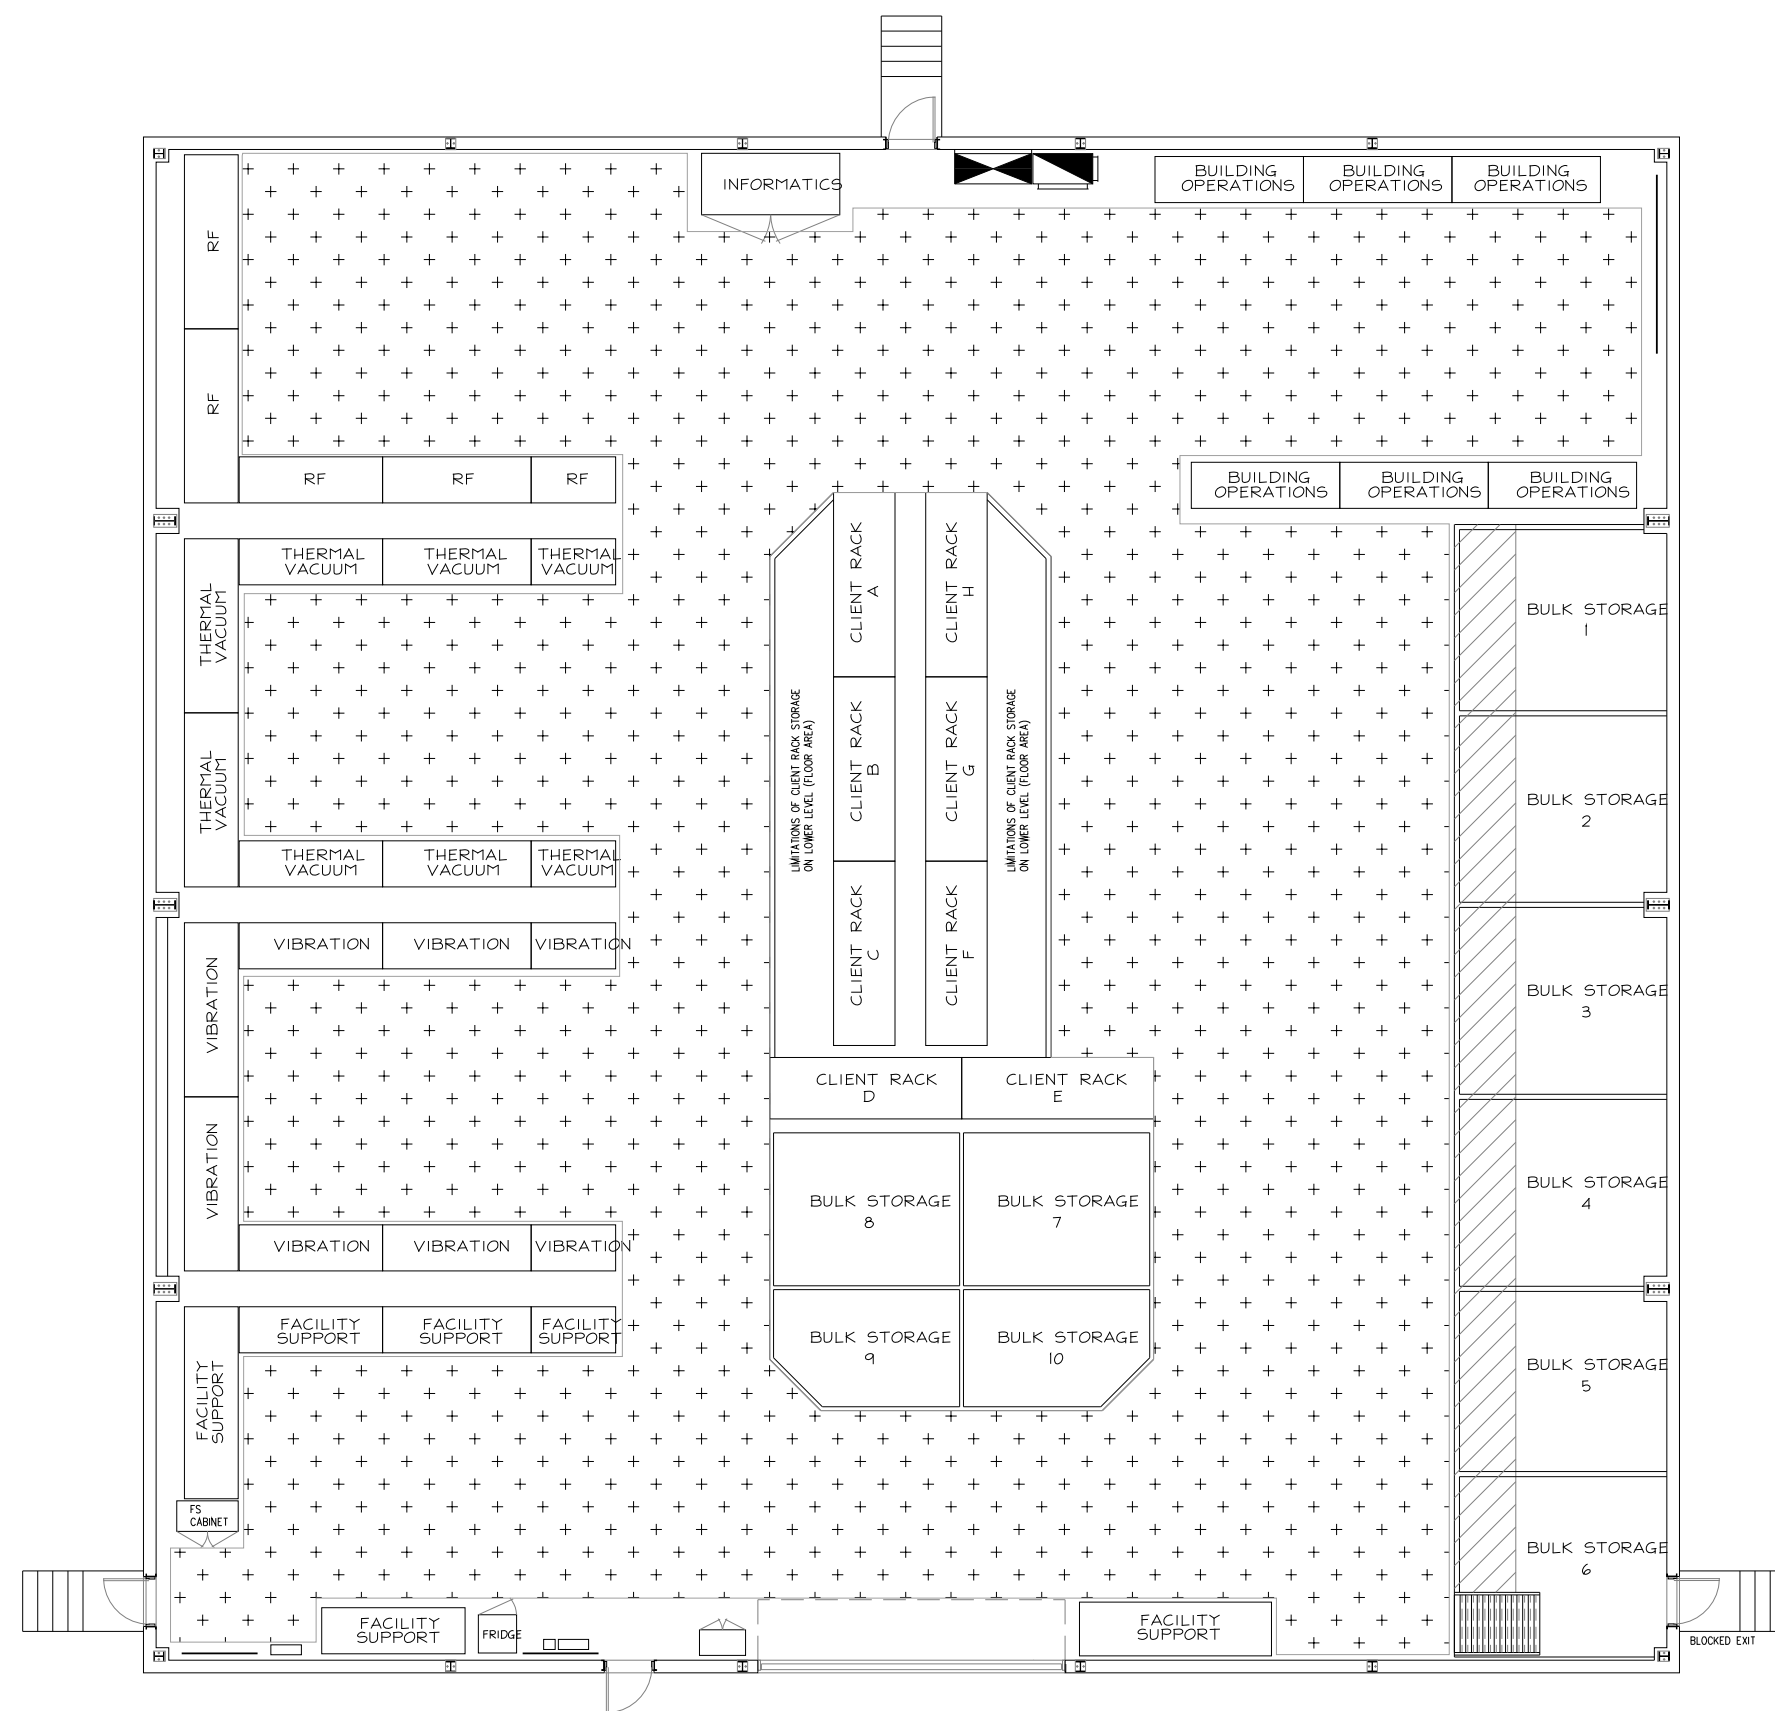

BUILDING 87 FLOOR PLAN

LEGEND


- NO ENTRY, NO CLEANING REQUIRED
AREA NOT TO BE CLEANED IN CLEAN ROOMS
- AREAS TO BE CLEANED UNDER SUPERVISION OF BUILDING OPERATIONS PERSONNEL
- CLEANROOM CLEANING AREAS
- GENERAL CLEANING AREAS
- NO CLEANING SHALL TAKE PLACE IN THIS AREA
- OPEN SPACE
NO FLOOR BELOW (HIGH BAYS)
- ENTRANCE TO CLEANROOMS
- MAIN ENTRANCES
CLEAN ASH URNS AND CLEAN EXCESS DIRT IN LOBBY AREAS

THIS DRAWING IS THE SOLE PROPERTY OF THE CANADIAN SPACE AGENCY "CSA" AND CAN NOT BE DISTRIBUTED OR REPRODUCED WITHOUT THE EXPRESS WRITTEN PERMISSION OF THE "CSA".

TRANSFER OF THIS DRAWING IN HARD COPY AND/OR ELECTRONIC FORMAT TO ANY OTHER ORGANIZATION MUST BE FOR A SPECIFIC AND LIMITED USE ONLY WITH PRE-AUTHORIZATION FROM THE "CSA" PROJECT AUTHORITY.

UPON COMPLETION OF SUCH USE, ALL HARD COPIES AND ELECTRONIC FILES MUST BE DESTROYED AND/OR RETURNED TO THE "CSA" PROJECT AUTHORITY.

9.		
8.		
7.		
6.		
5.		
4.		
3.		
2.	UPDATED FOR CONTRACT	AUG/16
1.	UPDATED FOR CONTRACT	JUL/10
No.	Revision	Date

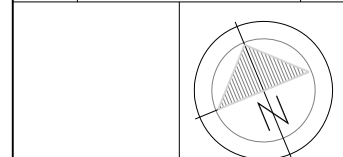

PROFESSIONAL STAMP

	A design no. or. du dessin	
	B location drawing no. sur dessin	
	C drawing no. dessin no.	

project
DAVID FLORIDA LABORATORY
MID LIFE REFIT PROJECTS - PHASE VIII
BUILDING No. 65, SHIRLEY'S BAY, ONTARIO
CLEANING CONTRACT SET

drawing
**BUILDING 80, 87, 89
LAYOUT PLAN**

designed	
date	
drawn	designe
date	
reviewed	examine
date	
approved	approve
date	
scale	1 : 150
project no.	no. du projet
drawing no.	no. du dessin