

FROM L1, BREAKER Q33;  
3x115V; 60Hz  
SEE SH. 4/10

LIGHTING IN FREEZER, GALLEY, DRY FOOD STORE, REFRIGERATOR,  
WET GEAR STORE, TRASH COMPACTOR, EMERGENCY GENERATOR ROOM,  
WASHROOM FR.16 STB, MESS ROOM, PASSAGEWAYS AND STAIRWAY

LIGHTING IN ELECTRONIC EQUIPMENT ROOM, WASHROOM FR.26 STB, CAPTAIN'S CABIN, CHIEF ENGINEER'S CABIN, INCIDENT COMMANDER'S CABIN, HVAC ROOM, AMMUNITION LOCKERS, DECK EQUIPMENT LOCKER AND FUEL OIL SPILL LOCKER

### MIRROR LAMPS ON MAIN DECK & BELOW MAIN DECK

SOCKET - OPEN MAIN DECK FR.28 PS

SOCKET - OPEN MAIN DECK FRS.21 & 12 STB

OPEN MAIN DECK PS & STB LIGHTING

SOCKET - OPEN MAIN DECK FR.28 STB

SOCKET - MESS ROOM PS - FR 23 & FR25

SOCKET - OPEN MAIN DECK FR.33 PS &STB

LINEN/LAUNDRY LOCKER, MCR, 2nd ENGINEER CABIN  
AND 2P CABINS ON BELOW MAIN DECK

WASHROOM FR.29 STB, LOCKER, STEWARD LOCKER,  
WASHROOM FR.29 PS AND BOW THRUSTER ROOM ON BELOW MAIN DECK

MESS ROOM SOCKETS FR.23 STB  
MAIN DECK

BED LAMPS ON BELOW MAIN DECK  
& MAIN DECK

## SOCKETS - LAUNDRY AND PASSAGEWAY BELOW MAIN DECK

SOCKETS - MCR  
BELOW MAIN DECK

## SOCKETS - 2nd ENGINEER AND 2P CABINS BELOW MAIN DECK

SOCKETS - 1P AND 2P CABINS  
BELOW MAIN DECK

SOCKETS - EER AND CAPTAIN'S CABIN  
MAIN DECK

SOCKETS - INCIDENT COMMANDER AND CHIEF ENGINEER CABINS  
MAIN DECK

SOCKETS - PASSAGEWAY, HVAC ROOM AND DECK EQUIPMENT LOCKER  
MAIN DECK

SOCKET FOR WORKBENCH  
EM'CY DG ROOM, MAIN DECK


SOCKETS 2P CABIN PS AND 2P CABIN STB  
BELOW MAIN DECK

SPARE

SOCKET - OPEN MAIN DECK FRS.10-11 STB

SOCKET - OPEN MAIN DECK FRS.21&12 PS

SPARE

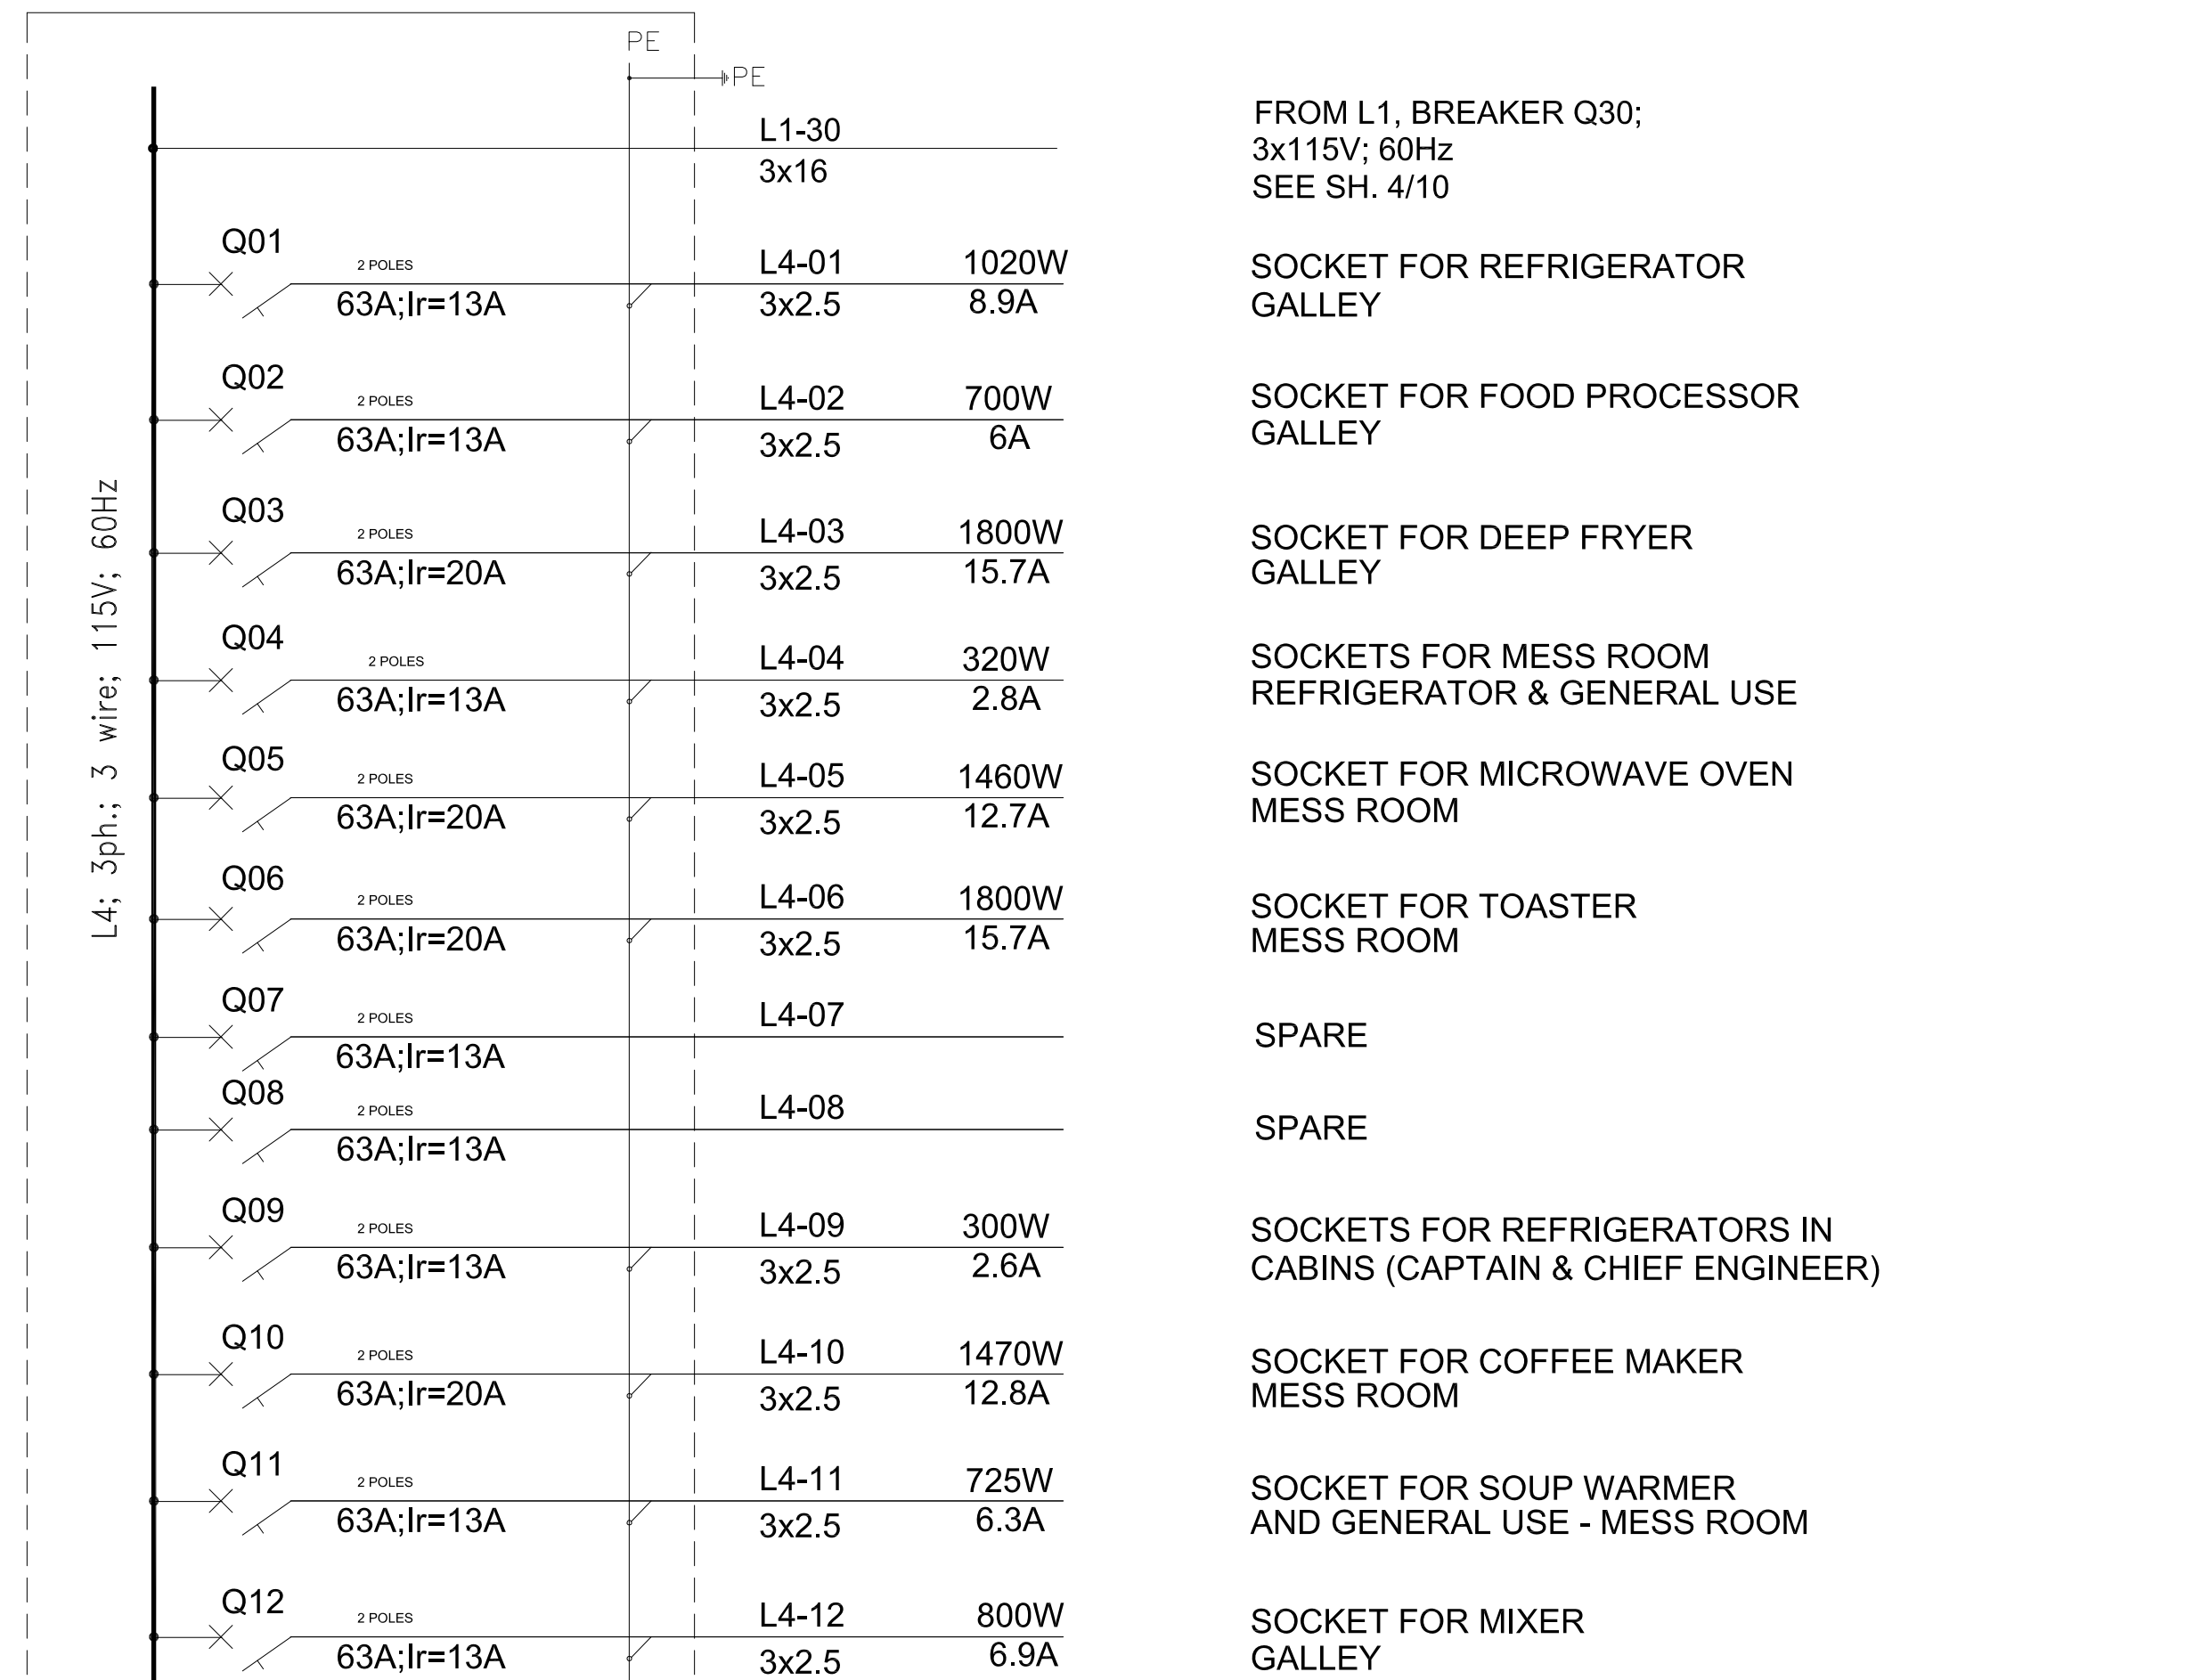

 


MAIN DISTRIBUTION SYSTEM (LIGHTING) 115V; 60Hz  
GALLEY AND MESSROOM DISTRIBUTION SYSTEM 115V; 60Hz

THE GOVERNMENT OF CANADA HAS A LICENCE FOR THIS DRAWING UNDER CONTRACT NO F7045-06001/002NQ. THE INFORMATION AND DATA CONTAINED HEREIN ARE PROPRIETARY TO IRVING SHIPBUILDING INC. AND ARE NOT TO BE USED, COPIED, REPRODUCED, DUPLICATED OR DISCLOSED TO OTHERS, IN WHOLE OR IN PART, WITHOUT PRIOR WRITTEN CONSENT OF IRVING SHIPBUILDING INC. ALL RIGHTS RESERVED.

## CCGS CAPORAL KAEBLE V.C

EM'CY DISTRIBUTION SYSTEM 3~115V; 60Hz

AF	20/11/2012	AS FITTED		AJM	BF	
Rev	Date	Description		Perform	Check	Appr.
Client:			Title:			
CANADIAN COAST GUARD			SINGLE LINE DIAGRAM			
			MID-SHORE PATROL VESSEL			
			Scale: NTS		Size: A2	
P.O. Box 9110, 3099 Barrington Street, Halifax NS, Canada B3K 5M7, Tel: 902.423.9271, Fax: 902.429.4510			Drawn by: G.Frangopol		Project No: 6094	
			Checked by: A. Lepadatu		Dwg. date: 10/06/2011	
Contract No. F7045-06001/002/NQ			Draw.no: AF6095-32000-01		Rev. AF	
Proj. 			© IRVING SHIPBUILDING INC.		Sheet: 8 of 10	