




"P1" BLAST HEATER DISTRIBUTION PANEL; 3 phase; 3 wire; 600V; 60Hz  
ARRANGED IN MMR

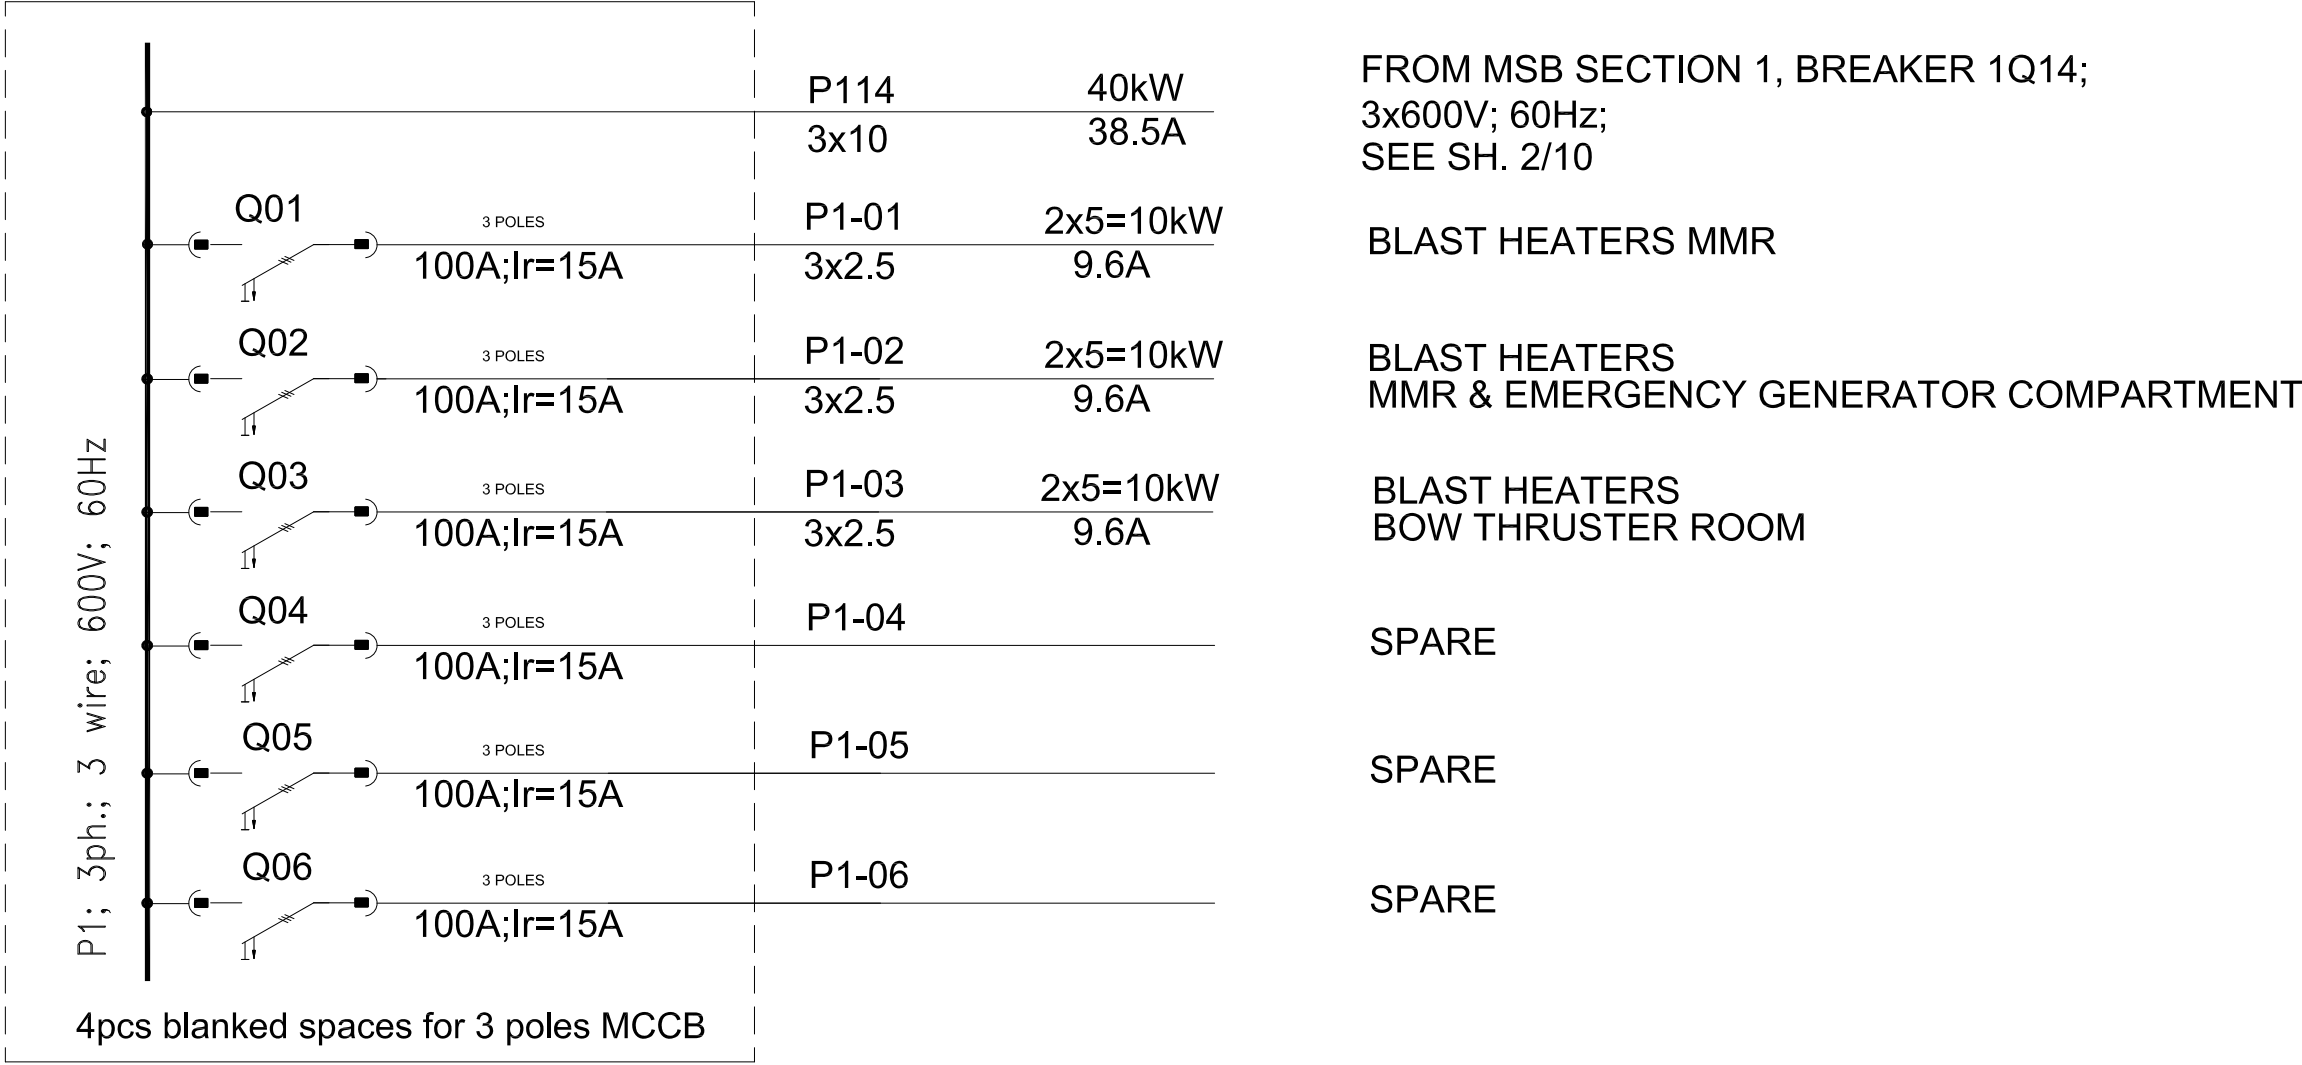

"P2" BLAST HEATER DISTRIBUTION PANEL; 3 phase; 3 wire; 600V; 60Hz  
ARRANGED IN STEERING GEAR COMPARTMENT

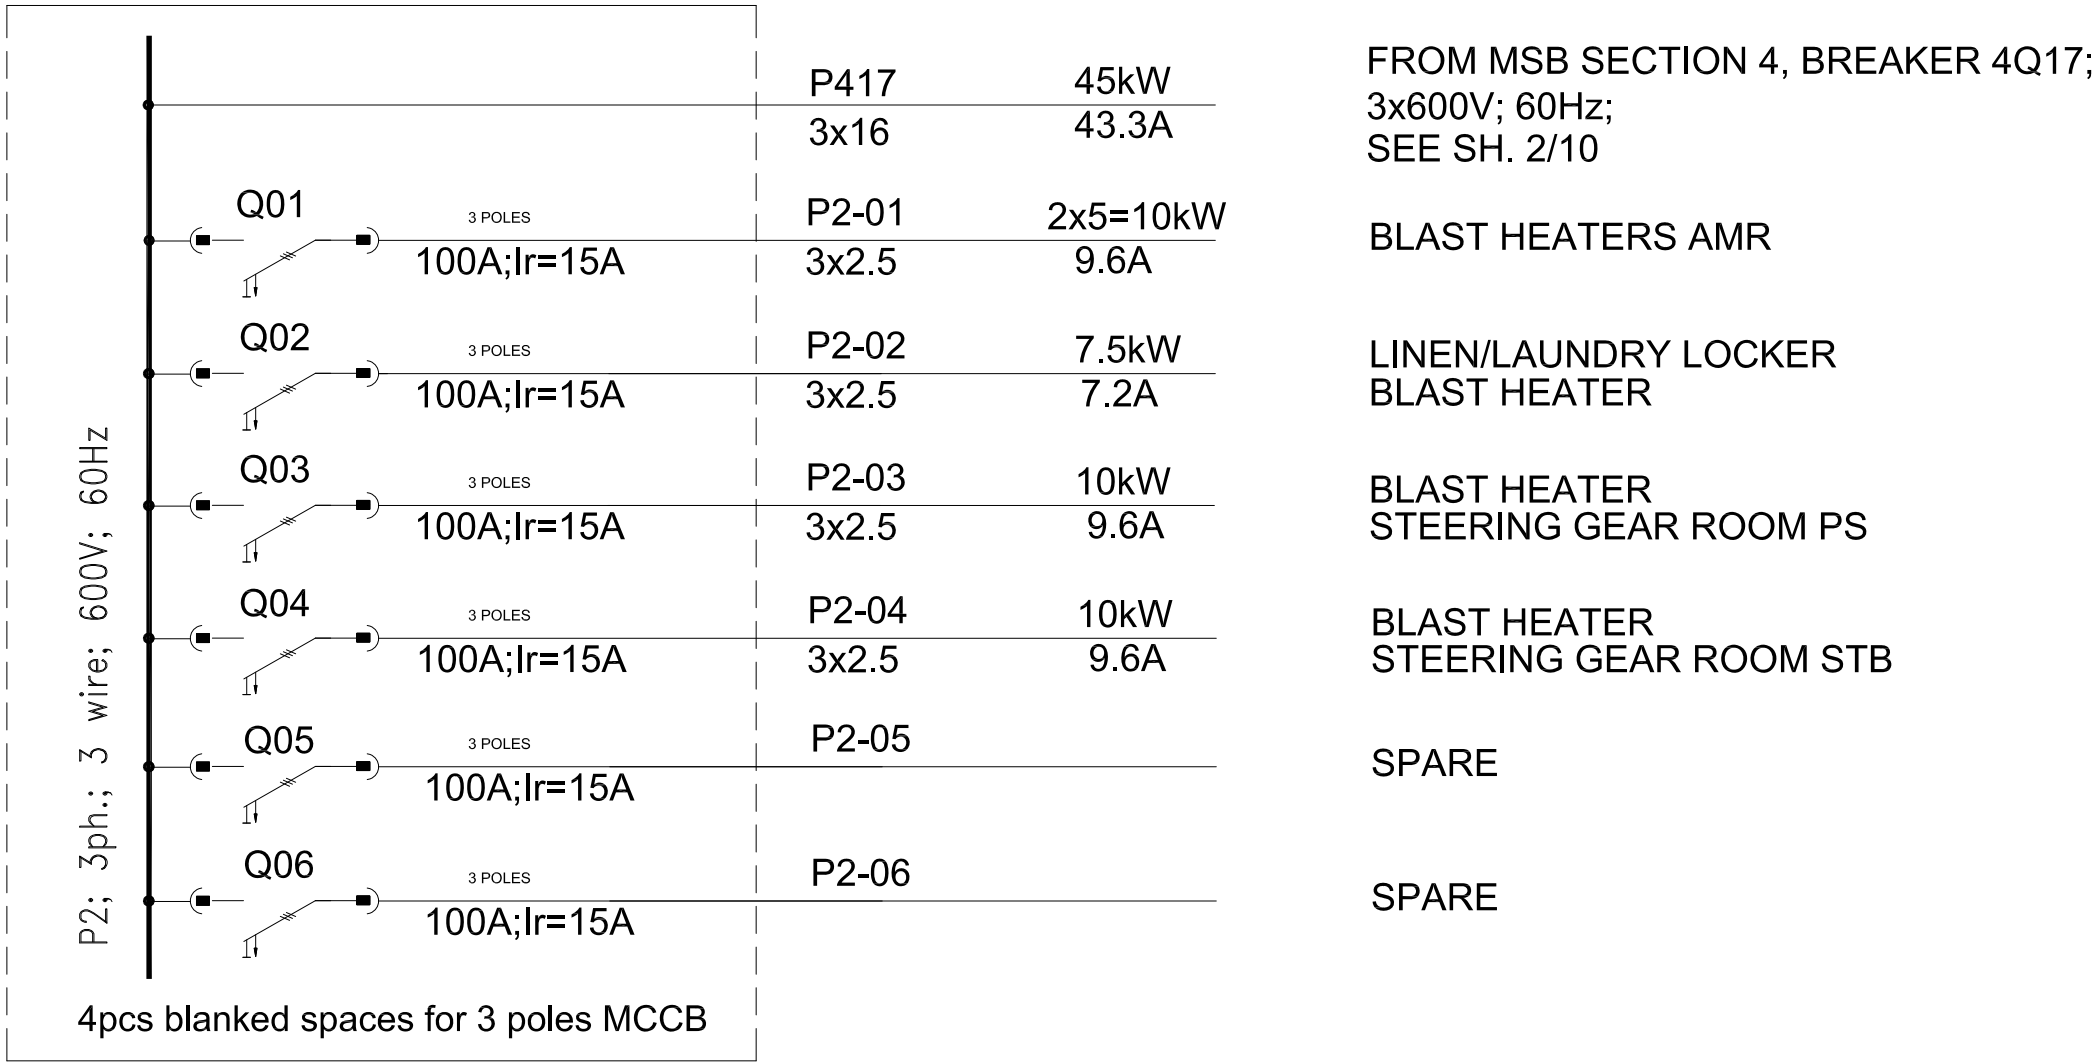

"P5" CONVECTION HEATER DISTRIBUTION PANEL; 3 phase; 3 wire; 230V; 60Hz  
ARRANGED IN HVAC ROOM

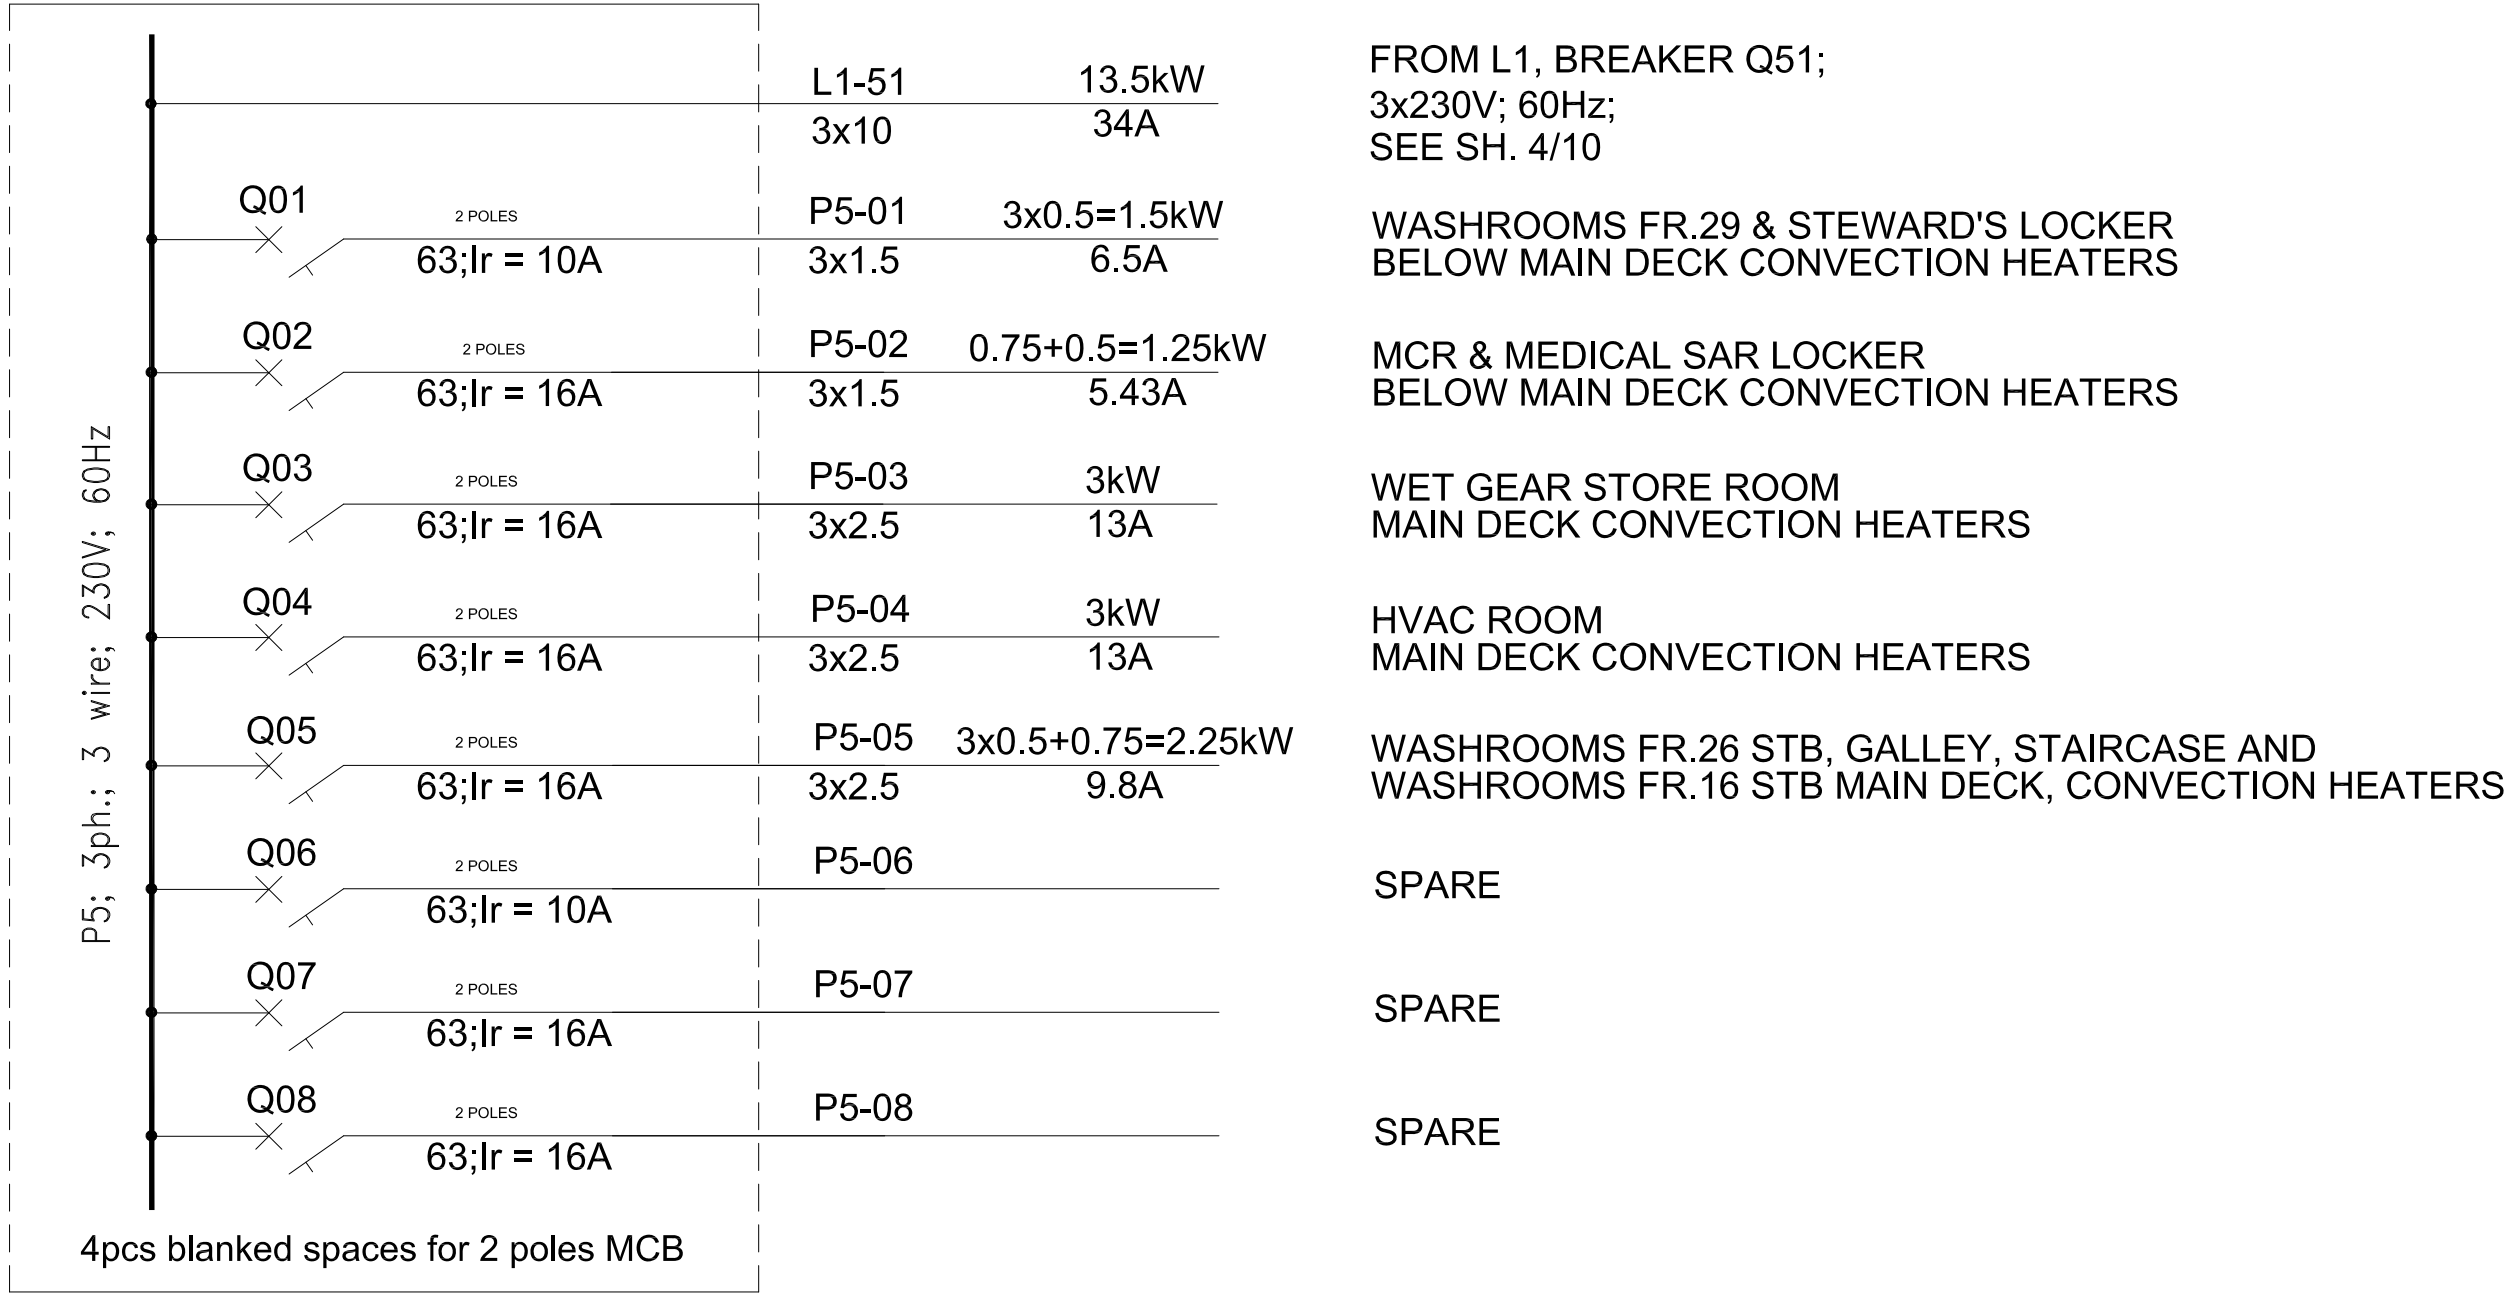

THE GOVERNMENT OF CANADA HAS A LICENCE FOR THIS DRAWING UNDER CONTRACT NO F7045-060001/002NQ. THE INFORMATION AND DATA CONTAINED HEREIN ARE PROPRIETARY TO IRVING SHIPBUILDING INC. AND ARE NOT TO BE USED, COPIED, REPRODUCED, DUPLICATED OR DISCLOSED TO OTHERS, IN WHOLE OR IN PART, WITHOUT PRIOR WRITTEN CONSENT OF IRVING SHIPBUILDING INC. ALL RIGHTS RESERVED.

CCGS CAPORAL KAEBLE V.C

BLAST HEATER DISTRIBUTION PANELS P1 AND P2; 600V; 60Hz  
CONVECTION HEATER DISTRIBUTION PANEL P5; 230V; 60Hz

AF	20/11/2012	AS FITTED			PM	PM	BF
Rev	Date	Description			Perform	Check	Appr.
Client:				Title:			
CANADIAN COAST GUARD				SINGLE LINE DIAGRAM			
				MID-SHORE PATROL VESSEL			
				Scale: NTS	Size: A2	Project No: 6094	
P.O. Box 9110, 3099 Barrington Street, Halifax NS, Canada B3K 5M7, Tel: 902.423.9271, Fax: 902.429.4510				Drawn by: G.Frangopol	Checked by: A. Lepadatu	Dwg. date: 10/06/2011	
Contract No. F7045-06001/002/NQ				Proj.			Rev. AF
				© IRVING SHIPBUILDING INC.			Sheet: 10 of 10