


SMALL CRAFT HARBOURS
CENTRAL AND ARCTIC REGION

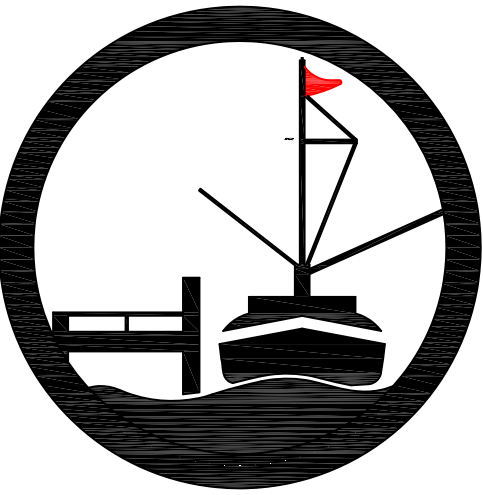



Riggs Engineering Ltd.
1240 Commissioners Rd. W, Suite 205
London, Ontario,
N6K 1C7
Tel: (519) 657-1040
Fax: (519) 657 8631
Website: www.riggsengineering.com

- 1 Detail No.
2 drawing no. - where detail required refers to MA-
3 drawing no. - where detailed refers to MA-

Stamp:



NOTES:

REVISIONS:		DATE:
1	ISSUED FOR TENDER	JUNE/23/2017

SCALE:	CLASS:
AS NOTED	

PROJECT:

2017 EAST HARBOUR WALL
REPAIRS

DESCRIPTION:


2011 EAST SIDE
ELECTRICAL SERVICES

DRAWN:	APPROVED:
AV	PL
DATE:	DATE:
2017-03-31	2017-03-31

LOCATION:

WHEATLEY, ONTARIO

DRAWING NO.:	LOCATOR CODE:
MA-15	F2930-160026

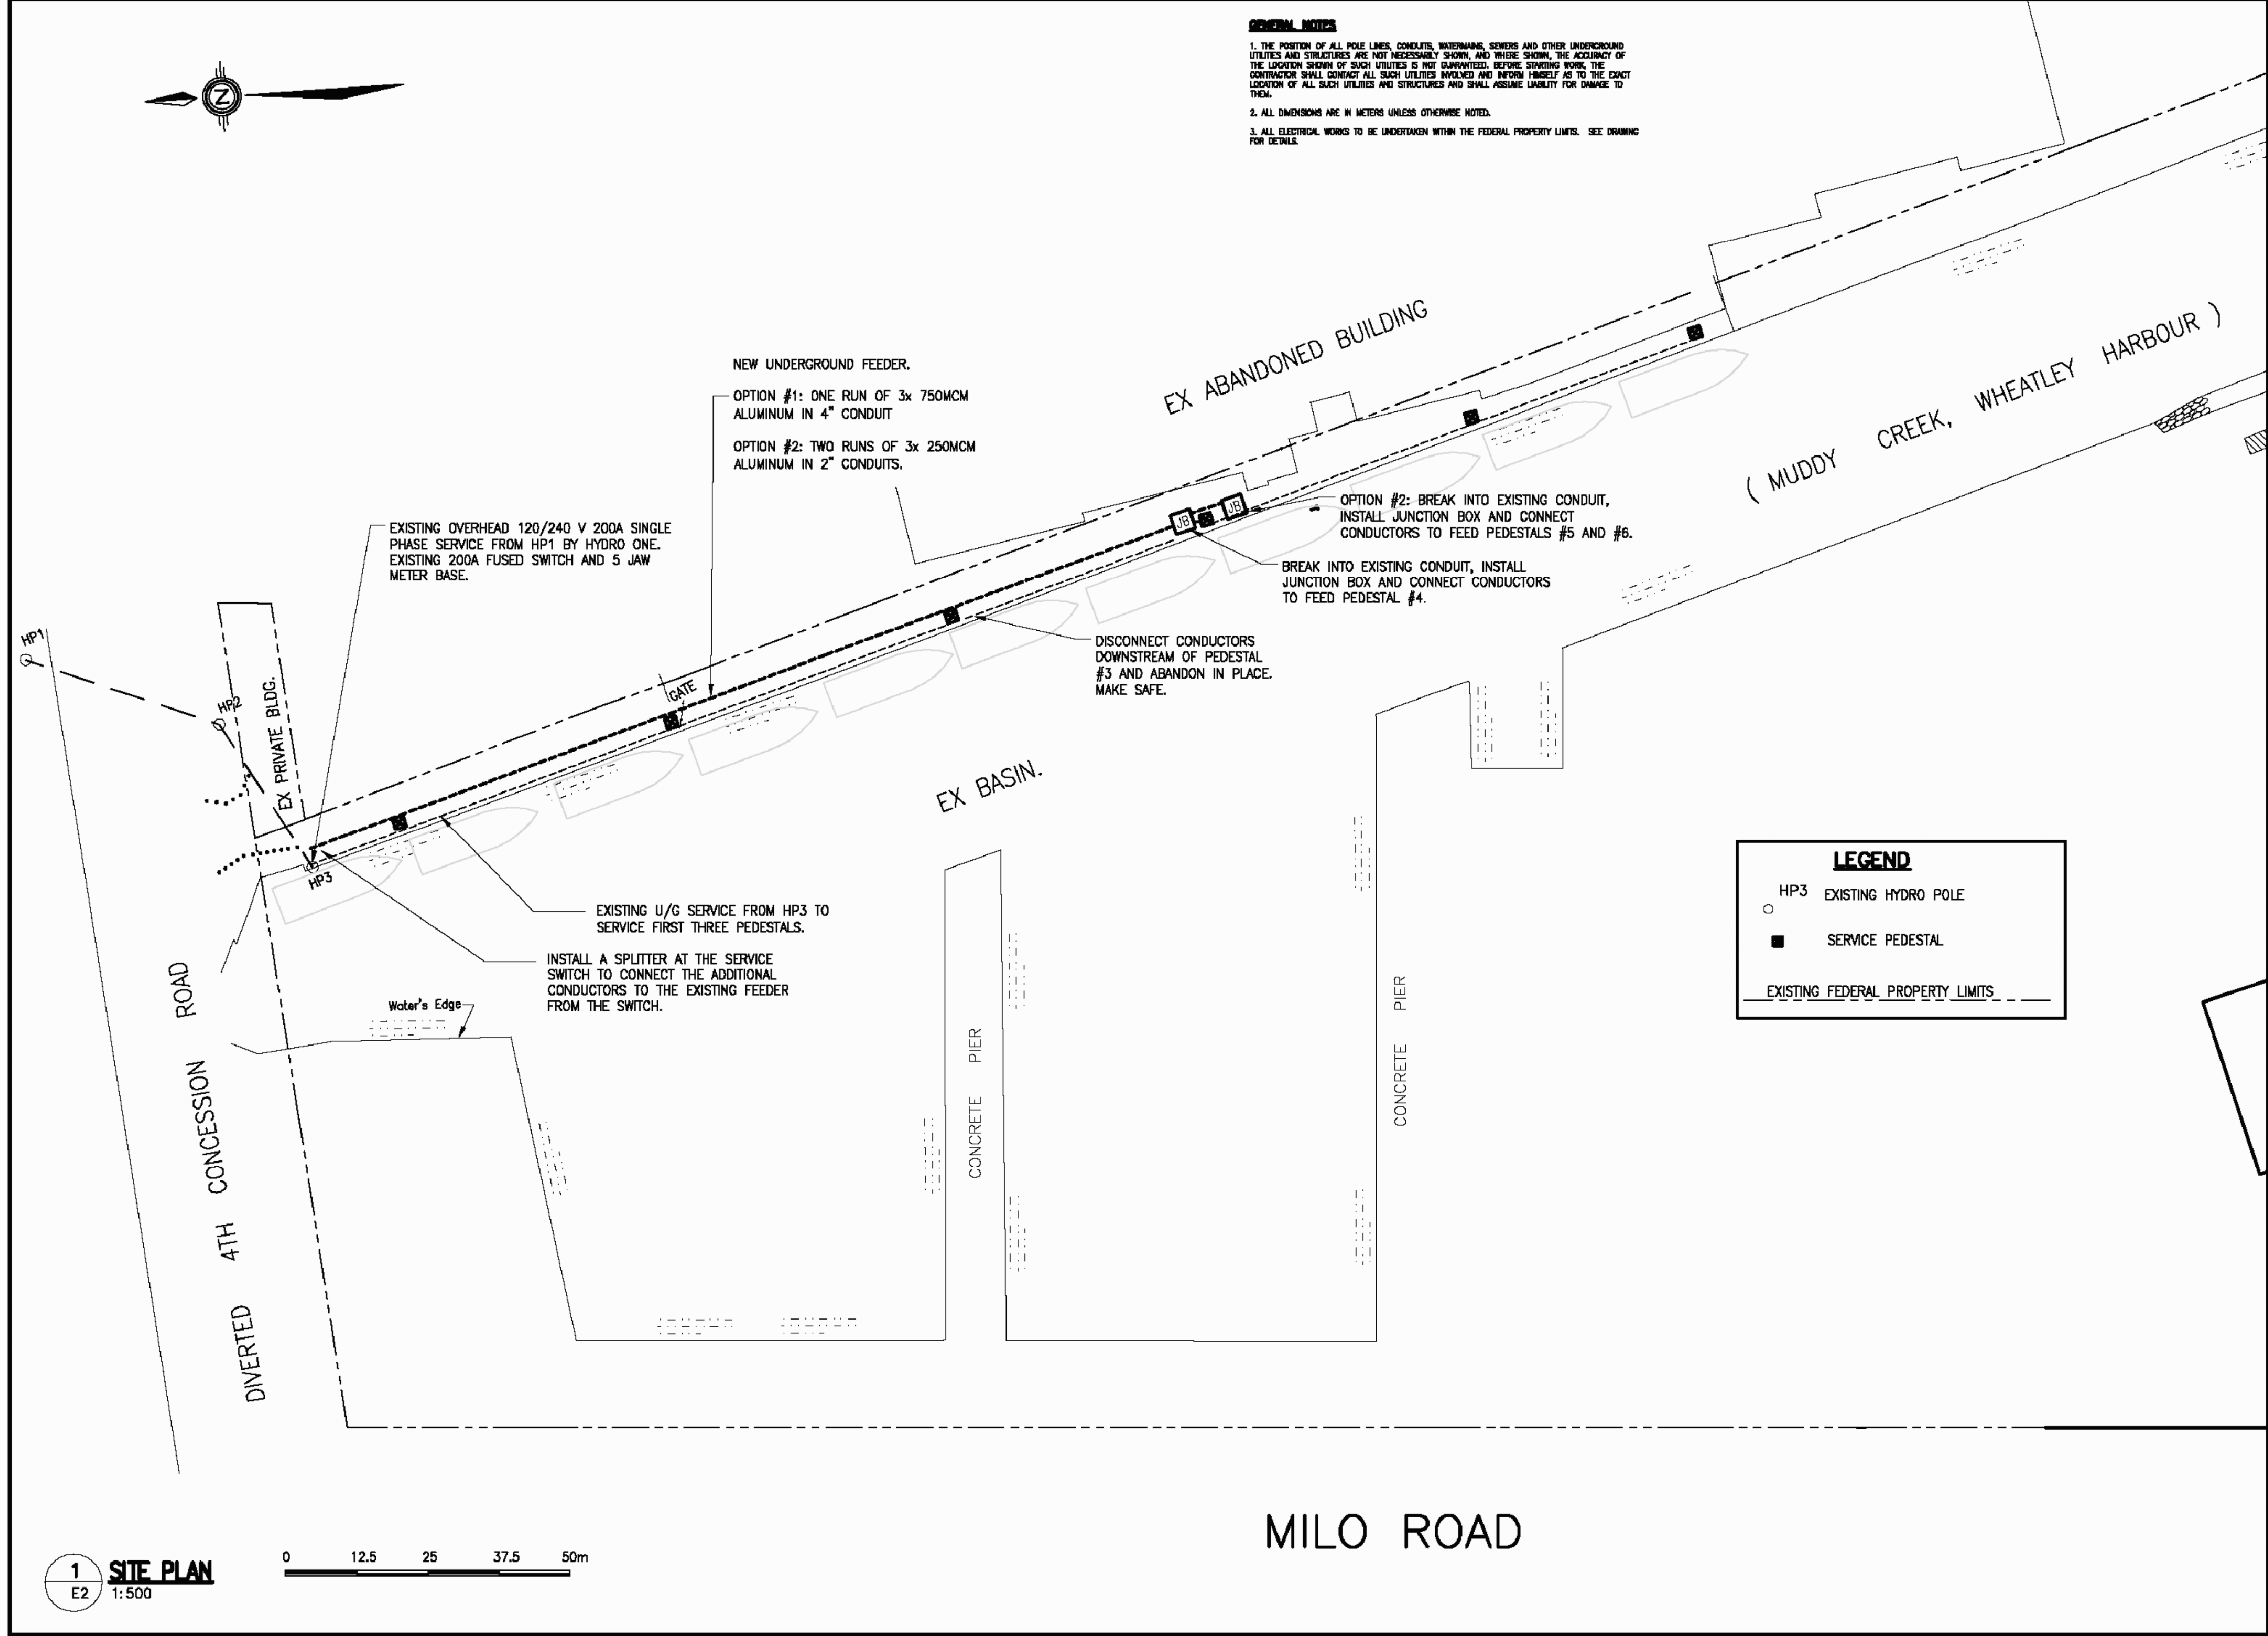

SCALE:	AS SHOWN	FILE:	4484	DATE:	DEC 2011	DESIGN:	TT	CHRG:	TT	DRWN:	TT	E3
EAST SIDE ELECTRICAL SERVICE										WHEATLEY, ONTARIO		ELECTRICAL PLAN
1830 Blue Eileen Drive London, ON N6H 5L9 Tel: 519-472-9688 Fax: 519-472-4922 www.riggsengineering.ca										INTEGRATED engineering		
DO NOT SCALE THE DRAWING THE CONTRACTOR IS RESPONSIBLE TO VERIFY DIMENSIONS ON DRAWINGS TO THE FURNISHED THE CONTENTS OF THE DRAWING REMAINS THE PROPERTY OF INTEGRATED ENGINEERING										ISSUED FOR PRICING		DATE