


This drawing is an instrument of service and is protected by copyright. Copyright for the contents of this drawing is held by the consultant. Copies including electronic copies, may only be used for the purposes of the project and may not be used for any other purpose without the express written consent of the consultant. The consultant is not responsible for any errors or omissions in this drawing. The consultant is not responsible for any errors or omissions in this drawing. The consultant is not responsible for any errors or omissions in this drawing.

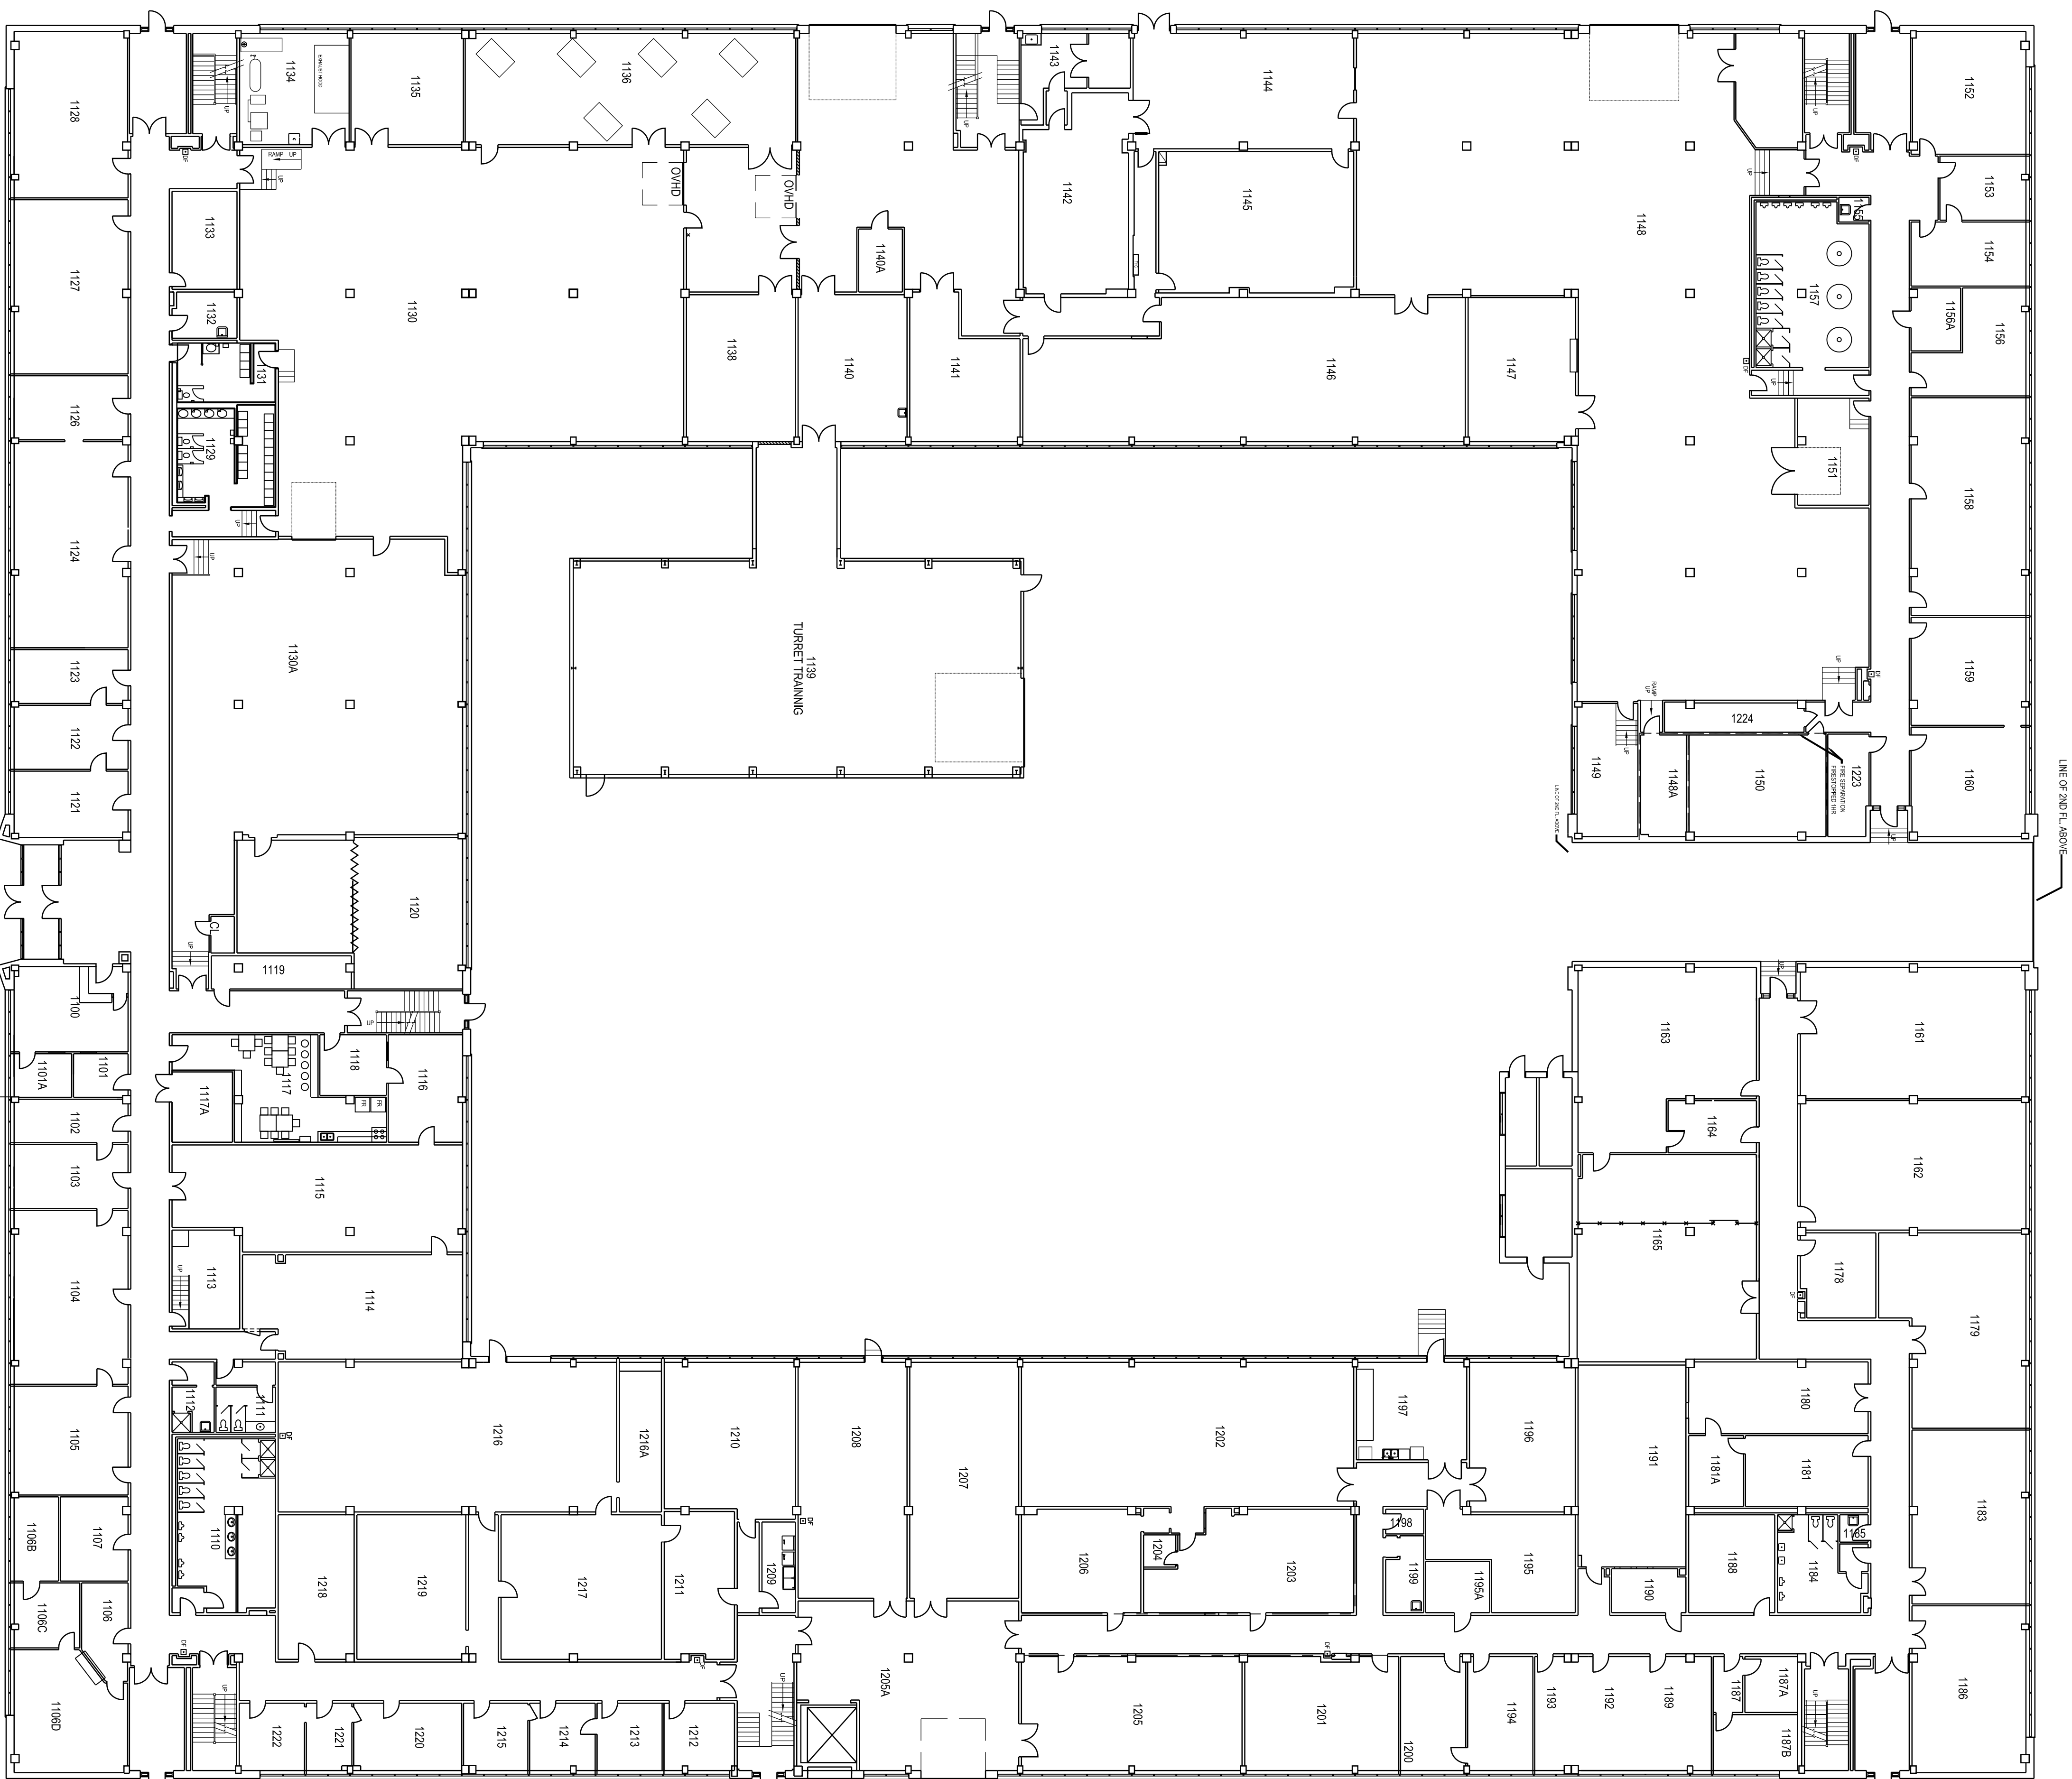

FIRST FLOOR PLAN - BLDG A-142
SCALE 1/320



NO.	DATE	REVISION	APPR.
1	2020/07/23	REWORKED AND UPDATED FLOOR PLAN	JH
2	2020/07/22	UP TO DATE	SS
3	2020/06/07	UP TO DATE	SS
4	2020/05/03	UP TO DATE	SS
5	2020/01/27	911 NUMBER	SS
6	2020/01/02	REMOVED TO PROJ. # 48881	SS
7	2020/06/18	REMOVED TO PROJ. # 48881	SS
8	2020/06/18	REMOVED TO PROJ. # 48881	SS
9	2020/06/10	REMOVED TO PROJ. # 48881	SS
10	2019/04/08	REMOVED TO PROJ. # 48881	SS

LOCATION | EMPACEMENT
264 LUNDY LANE (BLDG A-142)
BORDEN
ONTARIO
PROJECT | PROJET

TRADE METIER	DATE
COMMUNICATION	2013/09/12
SUBJECT SUJET	

FIRST FLOOR PLAN
COMMUNICATION LAYOUT

PRODUCTION	REVIEWED REVU	DESIGNER CONCEPTEUR	DESIGN DATE DATE DE CONCEPTION
DESIGNED ETUDIE	CUSTOMER CLIENT	DESIGNER CONCEPTEUR	
DRAWN DRESSE	COMMS COMM	PROJECT MGR GEST PROJ	
CHECKED VERIFIE	XX	DESIGNER CONCEPTEUR	
COORDINATION		FIRE INCENDIE	
PF NUMBER No DP	DWG. NO. No. DESSIN		
	L-8147-8860-301		

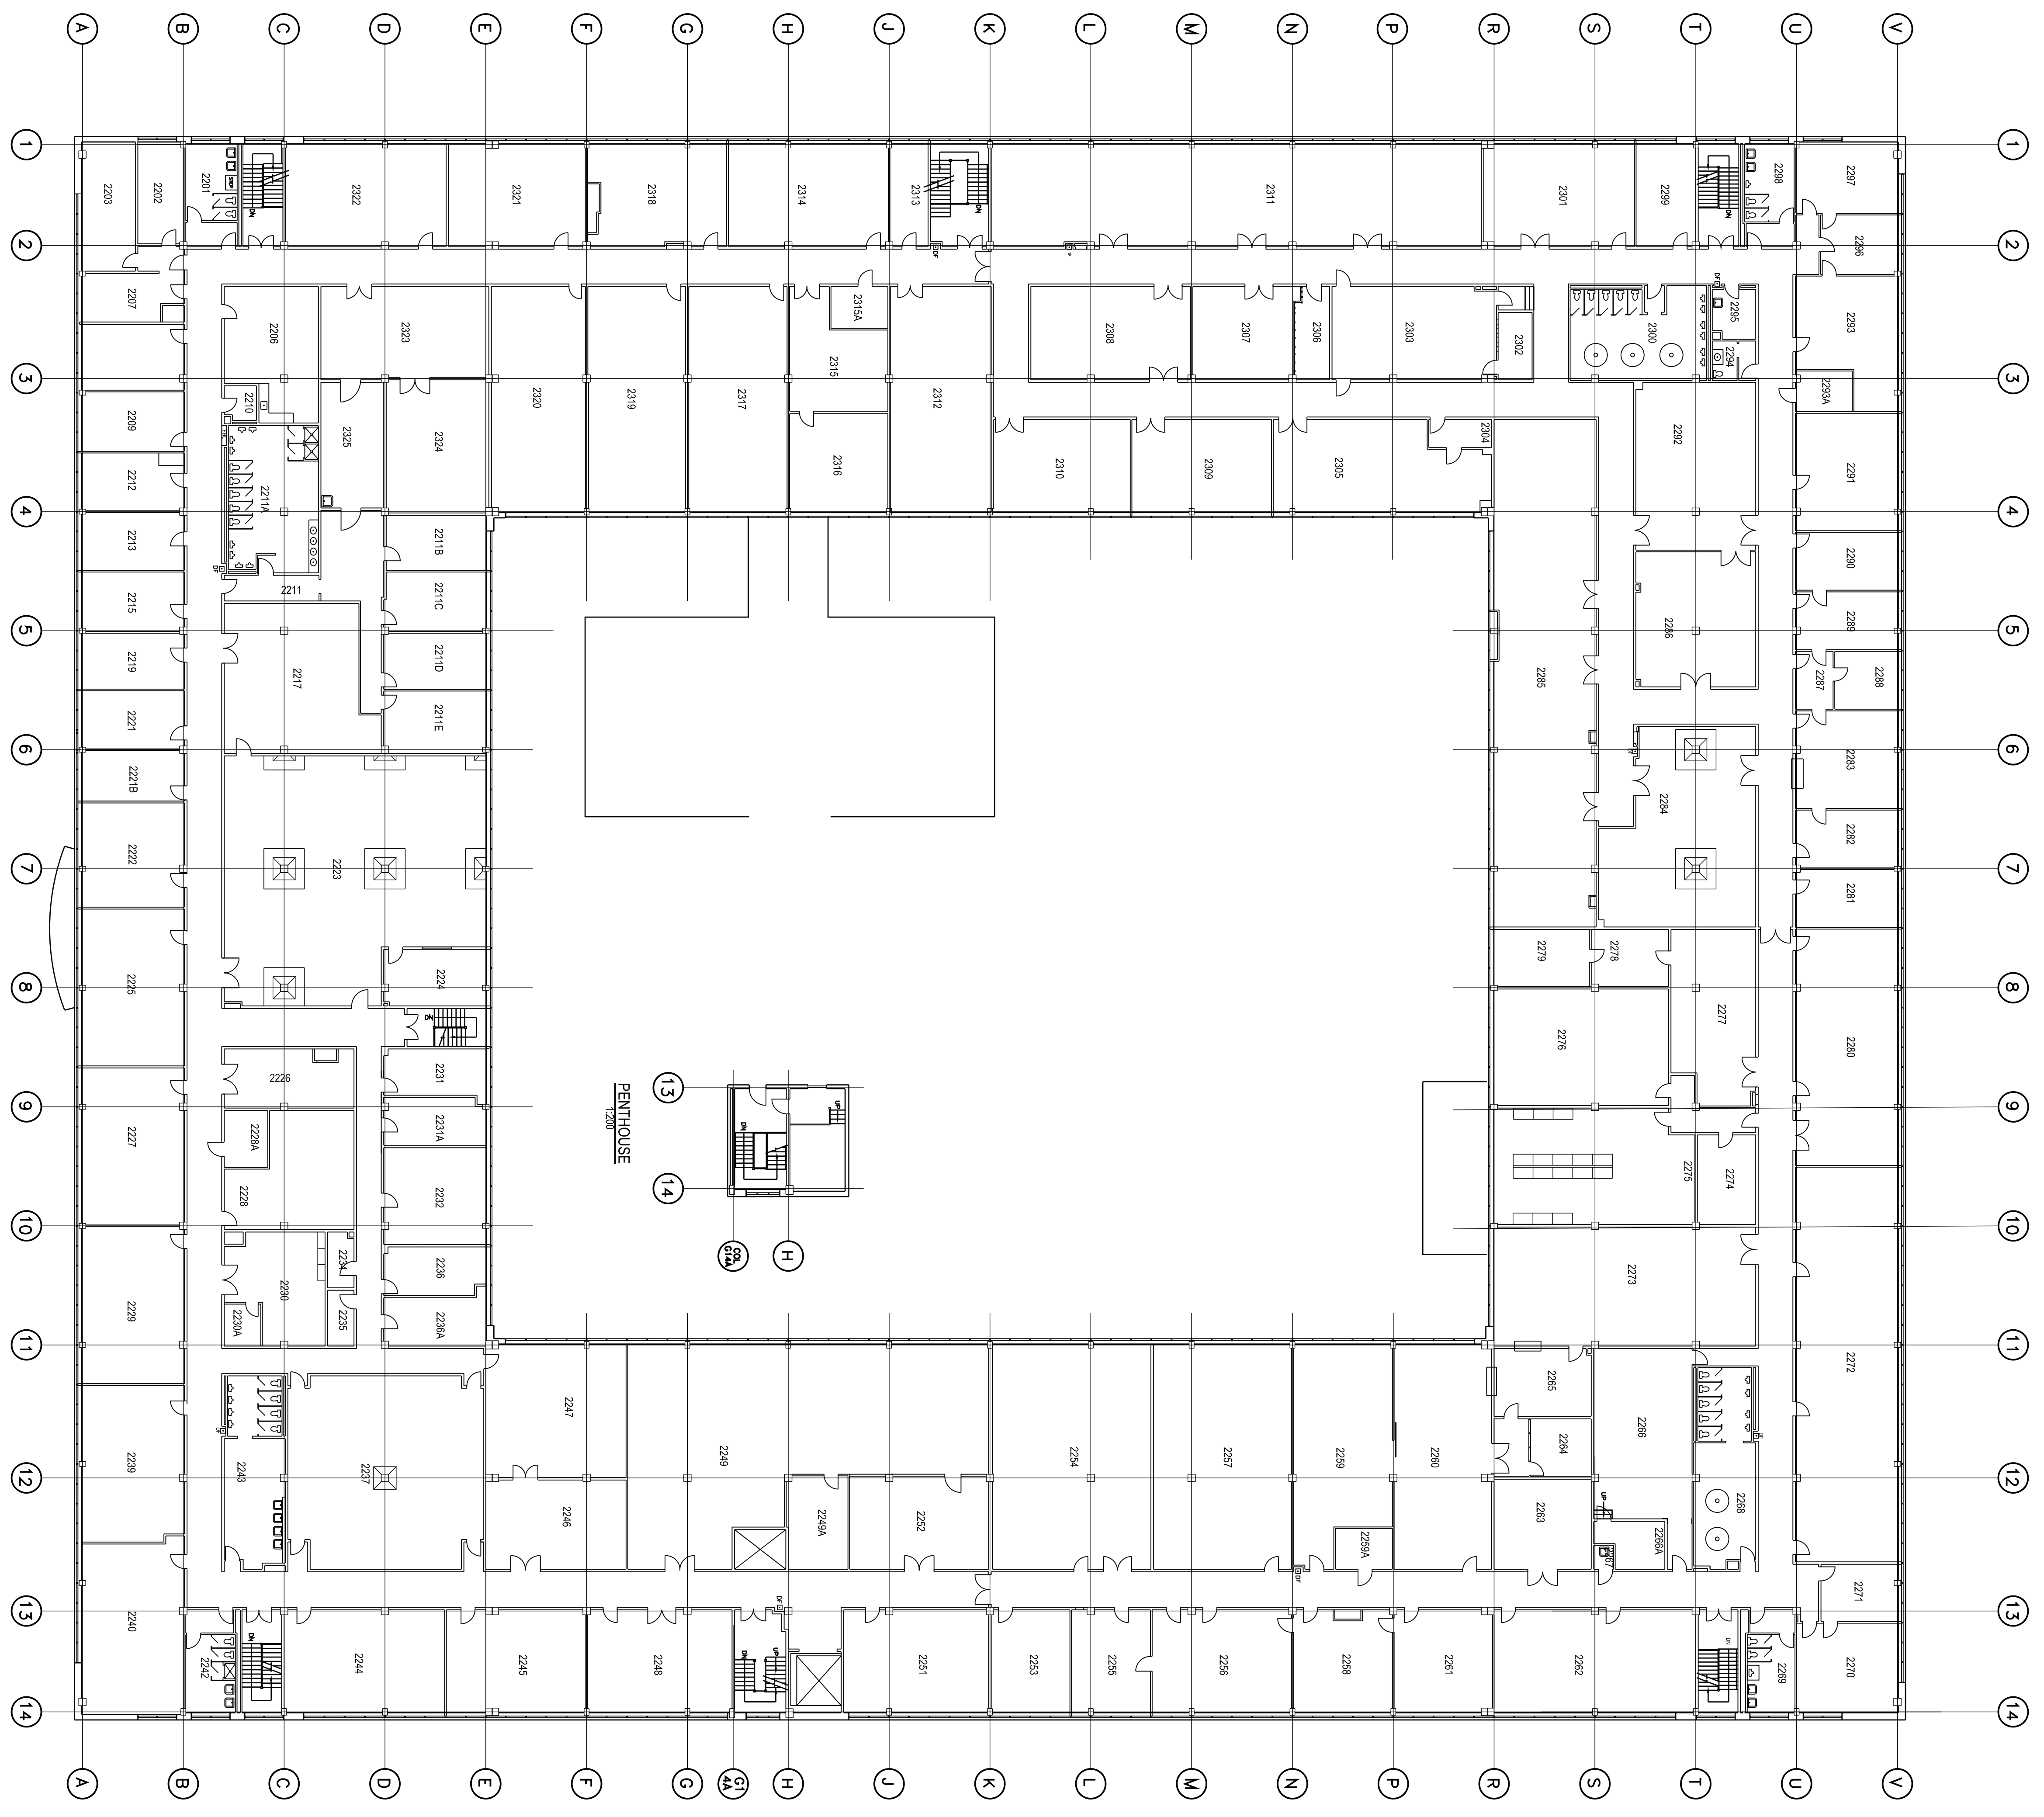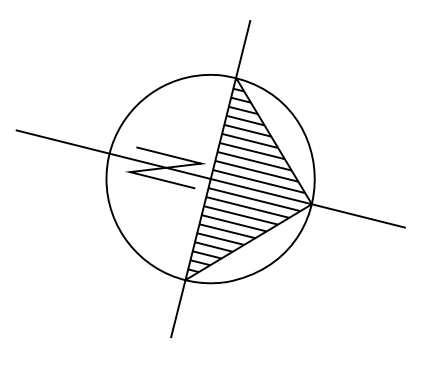

SECOND FLOOR PLAN
SCALE: 1/200

NO.	DATE	REVISION	APPR.
1	08/25/2002	REDESIGNED AND UPDATED FLOOR PLAN	MT
2			
3			
4			
5			

DESIGNED/ETUDE	ARCH	ONIL
XX	XX	XX
DRAWN/DESIGNÉ	MECH	USER
BS	XX	XX
CHECKED/VERIFIÉ	ELECT	PAGE PRIC. CHIEF
XX	XX	XX
COMM	APPROVED/APProuvé	#
XX	XX	4/4
PR. NUMBER	PRIC. NO. - DESIGN. NO.	
XXXXXXXX	L-B147-8860-302	

SCALE - ÉCHELLE	AS SHOWN
LOCATION - EMPLACEMENT	
CFB BORDEN	ON
PROJECT - PROJET	
284 LINDY LANE (BLDG A-142)	
TRADE - MÉTIER	ARCHITECTURAL
DATE	20/02/20
SUBJECT - SUJET	
SECOND FLOOR PLAN	