



RETURN BIDS TO:

RETOURNER LES SOUMISSIONS À:

Bid Receiving Public Works and Government
Services Canada/Réception des soumissions Travaux
publics et Services gouvernementaux Canada
800 Burrard Street, Room 219
800, rue Burrard, pièce 219
Vancouver
British Columbia
V6Z 0B9
Bid Fax: (604) 775-9381

**SOLICITATION AMENDMENT
MODIFICATION DE L'INVITATION**

The referenced document is hereby revised; unless otherwise
indicated, all other terms and conditions of the Solicitation
remain the same.

Ce document est par la présente révisé; sauf indication contraire,
les modalités de l'invitation demeurent les mêmes.

Comments - Commentaires

Vendor/Firm Name and Address
Raison sociale et adresse du
fournisseur/de l'entrepreneur

Issuing Office - Bureau de distribution
Public Works and Government Services Canada - Pacific
Region
800 Burrard Street, Room 219
800, rue Burrard, pièce 219
Vancouver
British C
V6Z 0B9

Title - Sujet Fire Protection Repairs	
Solicitation No. - N° de l'invitation F1571-175061/A	Amendment No. - N° modif. 001
Client Reference No. - N° de référence du client F1571-175061	Date 2017-11-30
GETS Reference No. - N° de référence de SEAG PW-\$PWY-020-8230	
File No. - N° de dossier PWY-7-40261 (020)	CCC No./N° CCC - FMS No./N° VME
Solicitation Closes - L'invitation prend fin at - à 02:00 PM on - le 2017-12-06	
Time Zone Fuseau horaire Pacific Standard Time PST	
F.O.B. - F.A.B. Plant-Usine: <input type="checkbox"/> Destination: <input checked="" type="checkbox"/> Other-Autre: <input type="checkbox"/>	
Address Enquiries to: - Adresser toutes questions à: Ly, Ronny(PWY)	Buyer Id - Id de l'acheteur pwy020
Telephone No. - N° de téléphone (604) 318-5750 ()	FAX No. - N° de FAX (604) 775-6633
Destination - of Goods, Services, and Construction: Destination - des biens, services et construction: DFO - Port Edward Harbour - Port Edward, BC	

Instructions: See Herein

Instructions: Voir aux présentes

Delivery Required - Livraison exigée	Delivery Offered - Livraison proposée
Vendor/Firm Name and Address Raison sociale et adresse du fournisseur/de l'entrepreneur	
Telephone No. - N° de téléphone Facsimile No. - N° de télécopieur	
Name and title of person authorized to sign on behalf of Vendor/Firm (type or print) Nom et titre de la personne autorisée à signer au nom du fournisseur/ de l'entrepreneur (taper ou écrire en caractères d'imprimerie)	
Signature	Date

Solicitation No. - N° de l'invitation

F1571-175061A

Amd. No. - N° de la modif.

001

Buyer ID - Id de l'acheteur

pw020

Client Ref. No. - N° de réf. du client

File No. - N° du dossier

CCC No./N° CCC - FMS No./N° VME

Please find Addendum No. 1 herein

Port Edward – Fire Protection Repairs Addendum #1

The following changes / clarifications in the tender documents are effective immediately. This Addendum will form part of the Contract Documents.

Amendments:

Please find below amendments to the tender.

- 1. The items 1.8.2.1.2, 1.8.2.3.2, 1.8.4.1.2, 1.8.4.2.2, and 1.8.4.3.2 “Supply and install new sprinkler heads” is revised in section 01 11 00 “Summary of Work,” to read as follows,**


Supply and install new sprinkler heads

- Supply and install the following sprinkler head, or owner approved equivalent.
 - Victaulic Firelock Model V2703, Commercial Storage, K 5.6, Upright, Standard Response, 200°F, Approval class cULus, FM, VDS, LPCB, CE, CCCF, Brass 250psi / 17 bar.
 - Sprinklers installed in-line at 3.1m (10') spacing with Victaulic mounts.
- 2. The reference drawing 703411 “Port Edward, BC – Buildings New Fire Exits – Floor Plans – Buildings 1001, 1002, &1003 / Buildings 1004 & 1005” to be replaced with the following drawing,**

Drawing No.
PE-010


Drawing Title
Port Edward, BC - Harbour Buildings Warehouse, Building No
3,4,&5 - Sprinkler Layout (SH 1&2)

END OF ADDENDUM

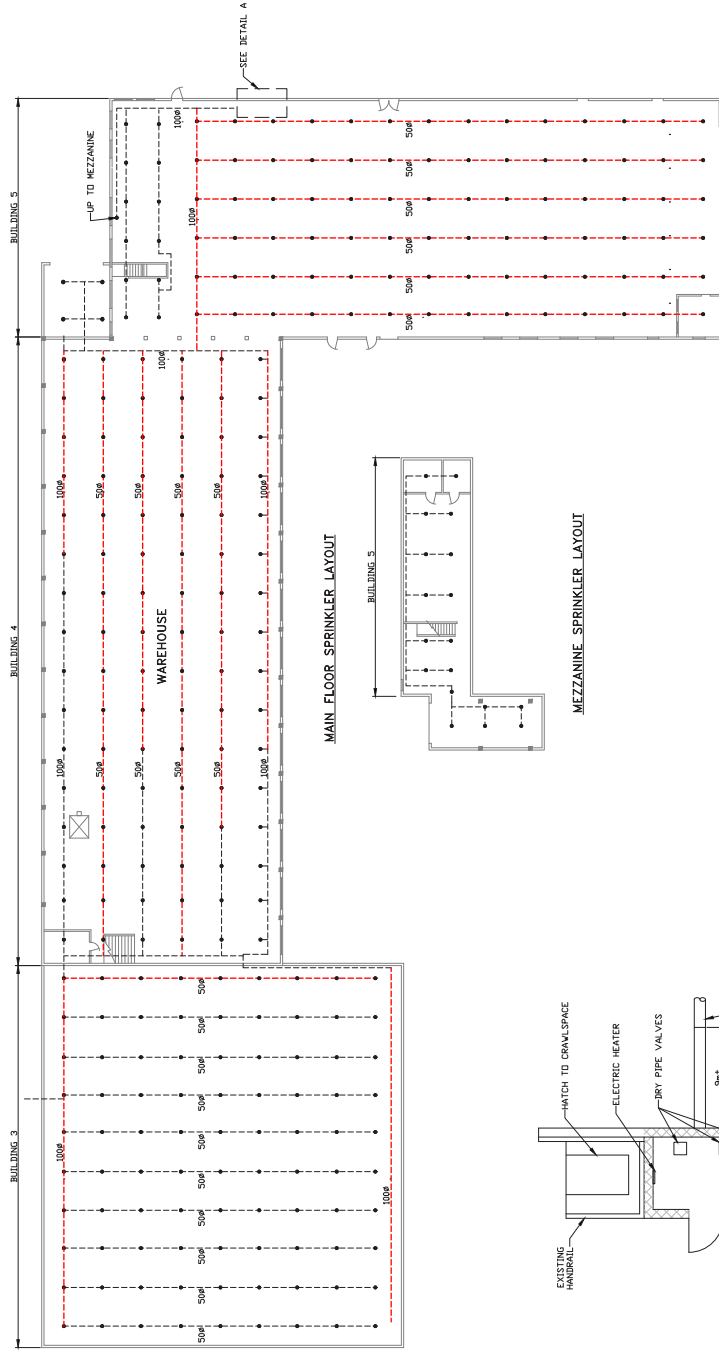

LEGEND

- FIRE LINES
- FIRE LINES - TO BE REPLACED IMMEDIATELY
- SPRINKLER HEAD



Fisheries and Oceans


Pêches et Océans

Small Craft Harbours Branch


SCALE: 1/8" = 1'-0"	APPROVED BY:	DRAWN BY: JAL
DATE: NOV 1, 2017	REVISED	
PORT EDWARD, B.C. - HARBOUR BUILDINGS		
WAREHOUSE, BUILDING NO. 3.4.4.3 - SPRINKLER LAYOUT		
PROJECT NO.		
SH. 1 OF 2		
PE-010		



WestCAD Services Ltd.

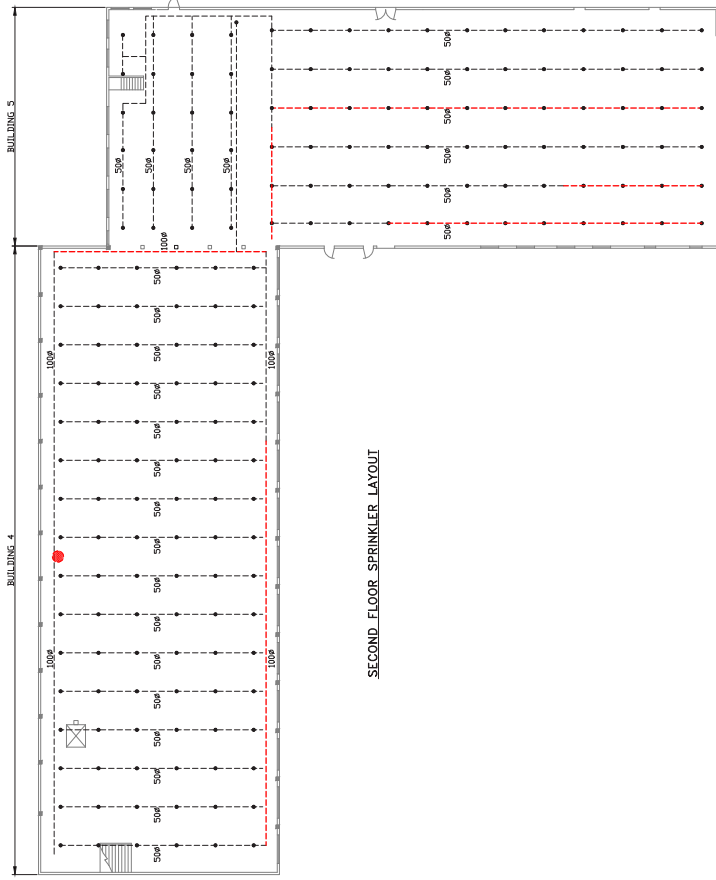

SECOND FLOOR SPRINKLER LAYOUT

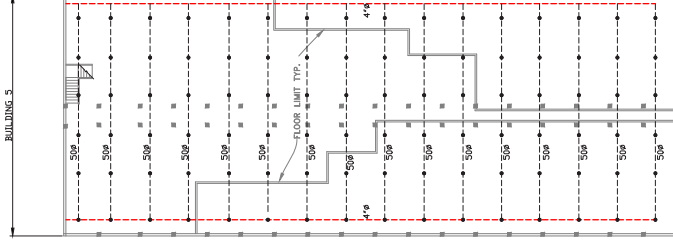

THIRD FLOOR SPRINKLER LAYOUT

- LEGEND
- FIRE LINES
 - FIRE LINES - TO BE REPLACED IMMEDIATELY
 - SPRINKLER HEAD
 - DOWN TO BE INSTALLED



Fisheries and Oceans
Pêches et Océans
Small Craft
Harbours Branch

SCALE: 1/8" = 1'-0"	APPROVED BY:	DRAWN BY: JCL
DATE: NOV 1, 2017	REVISED	
PORT EDWARD, B.C. - HARBOUR BUILDINGS WAREHOUSE, BUILDING NO. 3.4.4.3 - SPRINKLER LAYOUT		
PROJECT NO.		DRAWING NUMBER
SH. 1 OF 2		PE-010

