

1 SITE LIGHTING PLAN  
E1.0 SCALE N.T.S.

KEYNOTES:

1. SPOTLIGHTS MOUNTED AT +1.0m ABOVE GRADE ON A CONCRETE POLE.
2. SPOTLIGHTS MOUNTED ON A 4.0m POLE, REFER TO DETAIL #1/E0.1.
3. CONDUIT AND BELDEN CABLING RUN INTO BUILDING TO LIGHTING CONTROL SYSTEM. EXACT LOCATION IS STILL UNDETERMINED, ALLOW FOR A \$5,000 CASH ALLOWANCE FOR CONDUIT, CABLING AND POWER PROVISIONS.

GENERAL NOTES:

1. THE UNDERGROUND CONDUITS AND POLE BASES ARE EXISTING.
2. ALL WIRING, POLES, LED SPOTLIGHTS AND CONTROL SYSTEM IS INCLUDED IN THIS SCOPE OF WORK.
3. EACH POLE HAS A LUMEN PULSE C-BOX MOUNTED ON POLE TO FEED EACH LUMEN BEAM. A POLE WITH ONE FIXTURE REQUIRES A C-BOX DS, AND A POLE WITH MULTIPLE FIXTURES REQUIRES A C-BOX ST.



MASKELL PIENZIK & PARTNERS ENGINEERING

Suite 206, 610-70th Avenue S.E.  
Calgary, Alberta  
Canada, T2H 2J6  
Phone - (403) 509-2005  
Fax - (403) 509-2006  
Website- www.mppeng.ca

1	ISSUED FOR PRICING	21/03/17
---	--------------------	----------

REVISIONS	DESCRIPTION	DATE
-----------	-------------	------

A	A detail number	A
C	number du detail	B
	B source drawing no.	C
	de dessin no.	
	C detail on drawing no.	
	detail sur dessin no.	

project title  
**BANFF ADMINISTRATION BUILDING  
PARKING LOT REHABILITATION**  
titre du projet

**BANFF TOWN CENTER  
BANFF NATIONAL PARK, BANFF AB**

drawing title  
titre du dessin

SITE LIGHTING PLAN

designed by  
AM  
conçu par

drawn by  
BD  
dessiné par

approved by  
AM  
approuvé par


PWOSC Project Manager  
MATTHEW WHALEN  
Administrateur de Projets TPSGC

scale  
N.T.S.  
échelle

project no.  
160204  
projet no.

date  
21 MARCH 2017  
date

sheet  
E1.0  
feuille

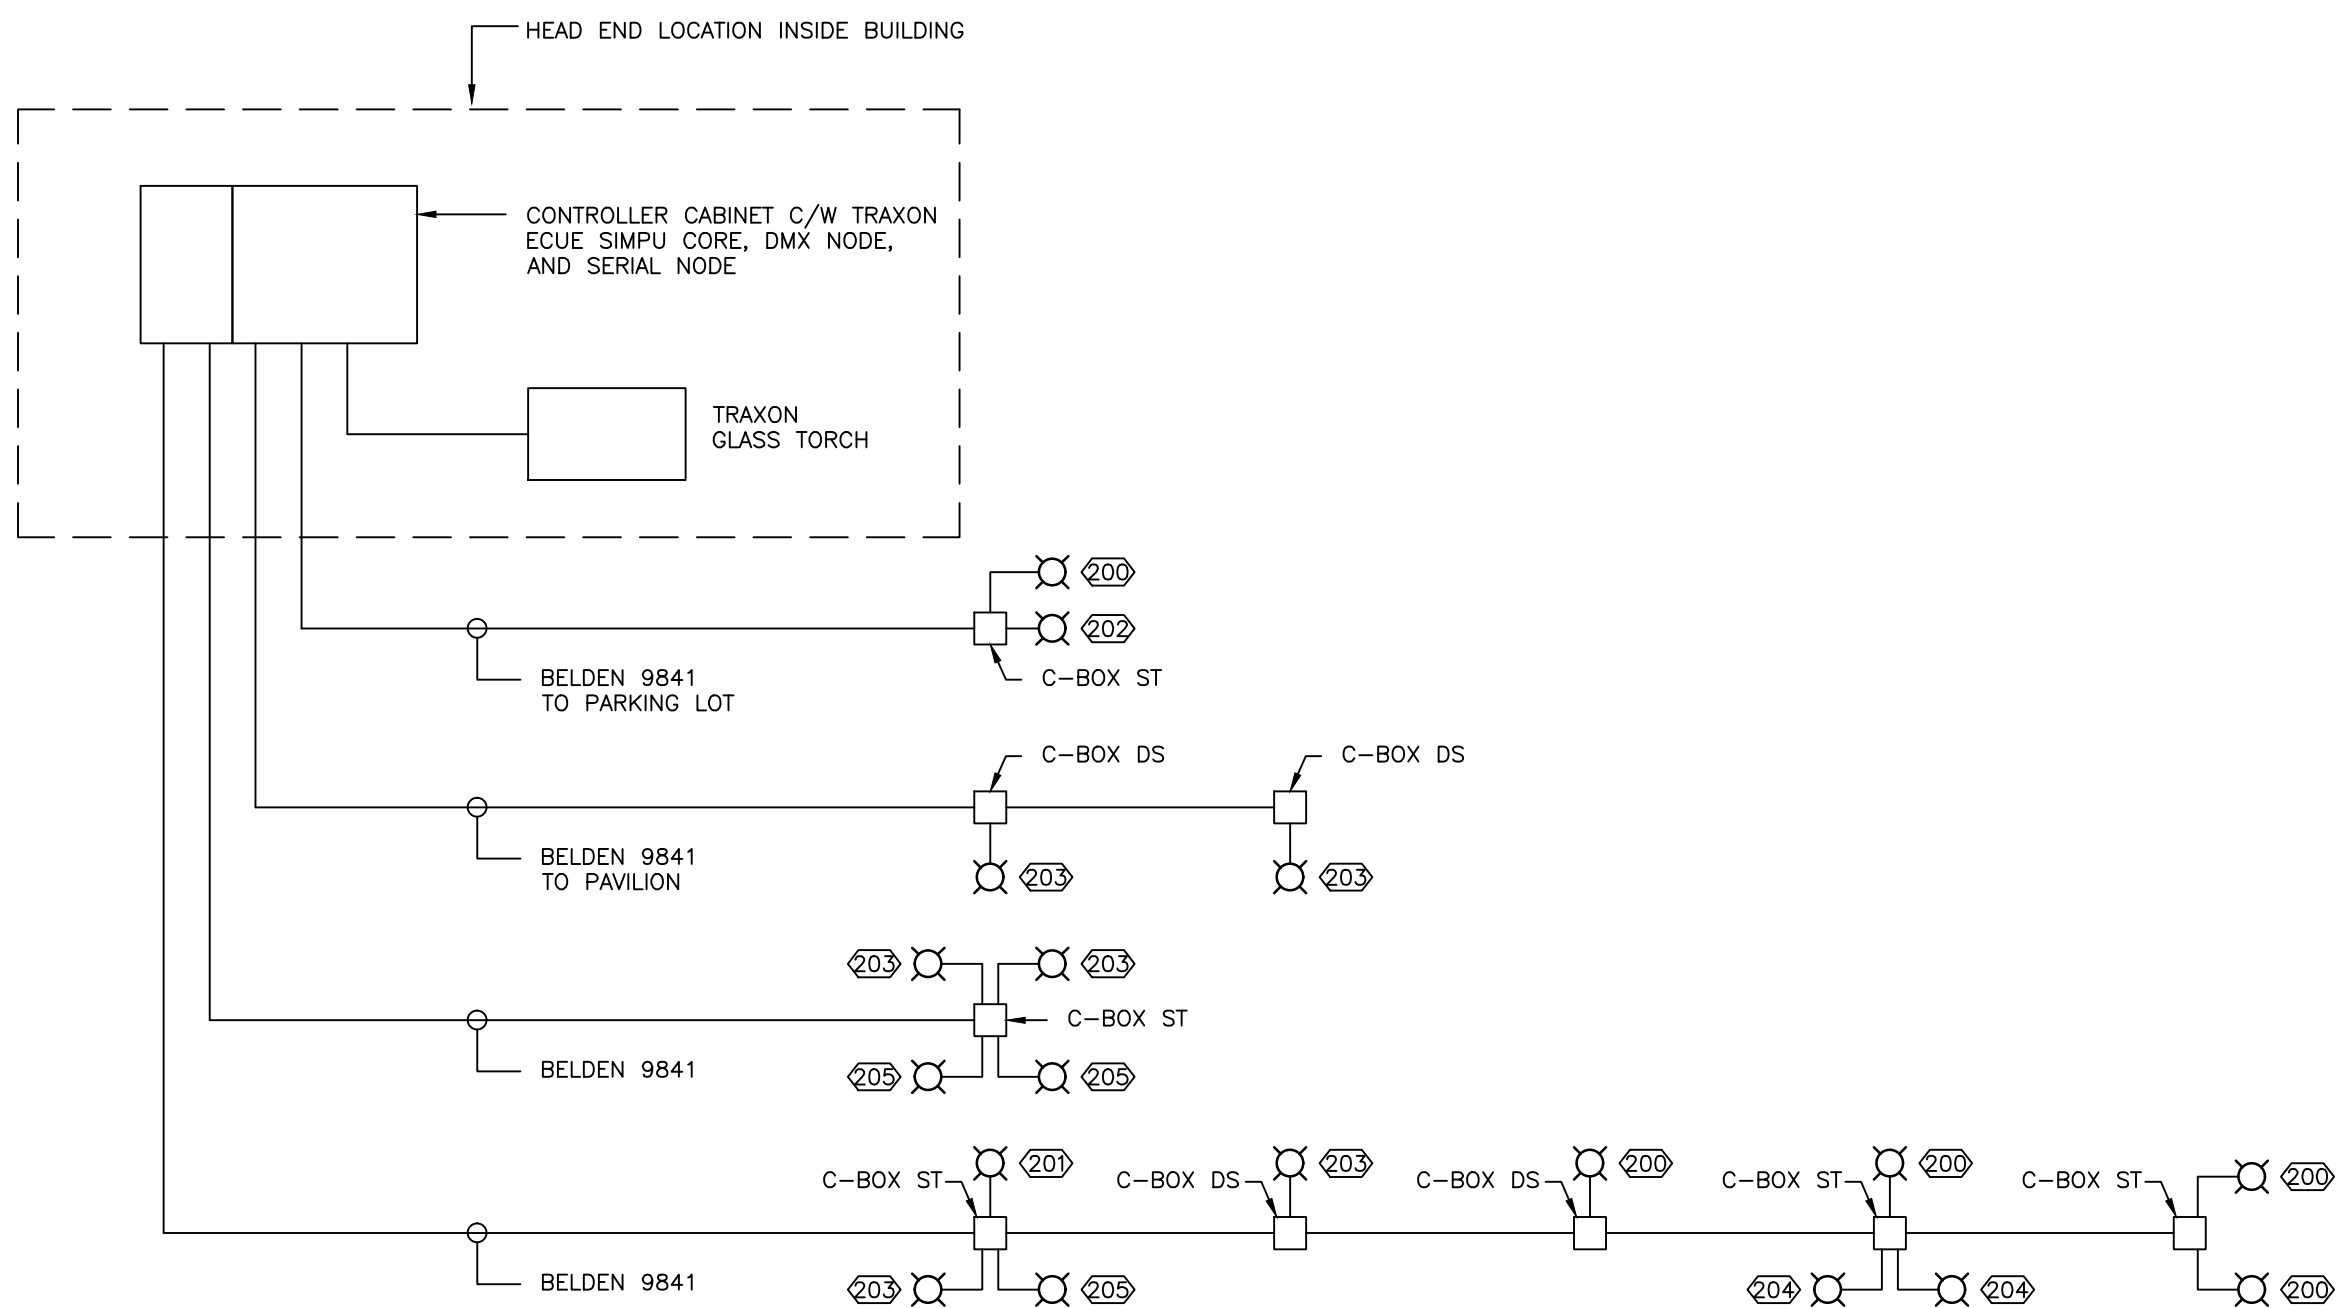

1  
E2.0

DMX LIGHTING CONTROL SCHEMATIC  
SCALE N.T.S.


1	ISSUED FOR PRICING	21/03/17
---	--------------------	----------

REVISIONS	DESCRIPTION	DATE
-----------	-------------	------

A	A detail number	A
B	B source drawing no.	B
C	C detail on drawing no.	C

project title  
**BANFF ADMINISTRATION BUILDING  
PARKING LOT REHABILITATION**

BANFF TOWN CENTER  
BANFF NATIONAL PARK, BANFF AB

drawing title  
**ELECTRICAL DETAILS**

designed by  
AM

drawn by  
BD

approved by  
AM

PWOSC Project Manager  
MATTHEW WHALEN

scale  
N.T.S.

project no.  
160204

date  
21 MARCH 2017

sheet  
E2.0