





LEGEND:

- F/A PULLSTATION
- FIRE ALARM EVACUATION HORN/STROBE COMBINATION
- FIRE ALARM PIEZO (MINI) SOUNDER
- SMOKE DETECTOR
- COMBINATION SMOKE AND CARBON MONOXIDE (CO) DETECTOR
- HEAT DETECTOR (FT DENOTES FIXED TEMPERATURE)
- FIRE ALARM BELL
- CIRCUIT BREAKER PANELBOARD
- FIRE ALARM PANEL
- EXISTING DEVICE TO REMAIN
- DEVICE TO BE MOVED OR RELOCATED
- DEVICE TO BE REMOVED




GENERAL NOTES:

- ALL WIRING IS TO BE CONCEALED. WIREMOLD SHALL BE PERMITTED WHERE ACCESS IS RESTRICTED BY MECHANICAL SYSTEMS.
- CONTRACTOR IS RESPONSIBLE TO PATCH AND PAINT GYPSUM BOARD AND MODIFIED RACEWAY INSTALLATION.
- COORDINATE ALL WORK WITH DEPARTMENTAL REPRESENTATIVE. ENSURE WORK SITE IS KEPT CLEAN DURING INSTALLATION.
- SUPPLY WIRE AND CONNECT COMMUNICATION LINE TO NEW FIRE ALARM PANEL.
- EXISTING FIRE ALARM DEVICES AND WIRING ARE TO BE REMOVED.

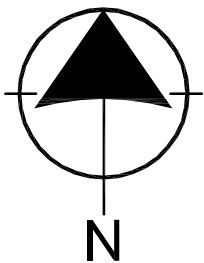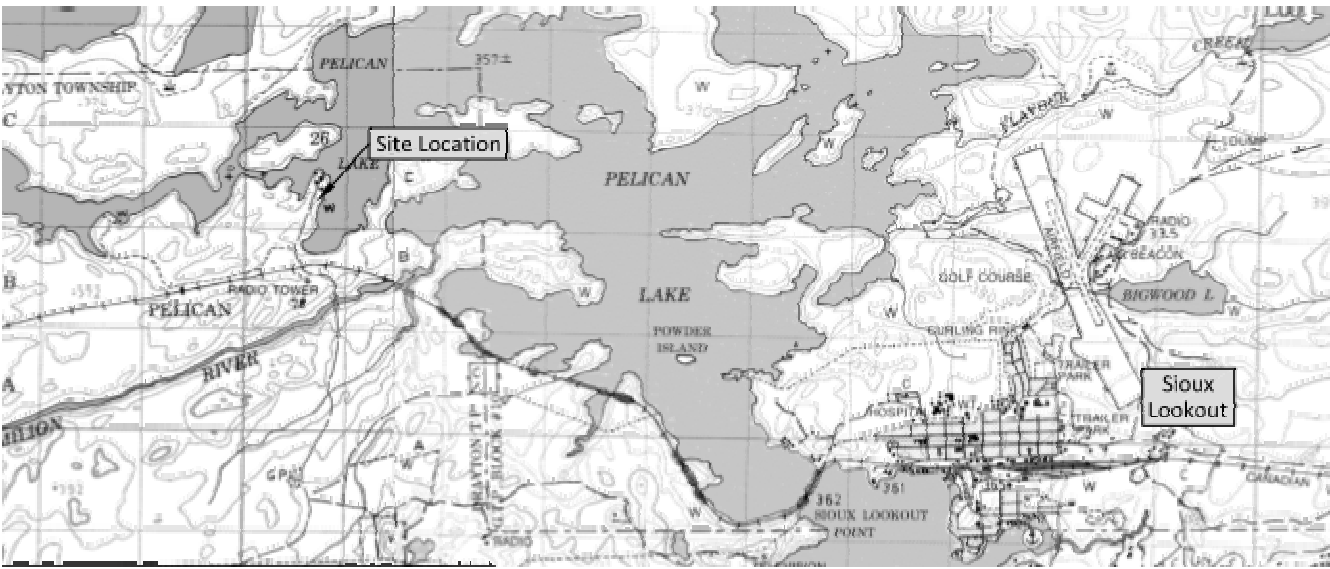

1 KEY PLAN
E-1 SCALE: N.T.S.

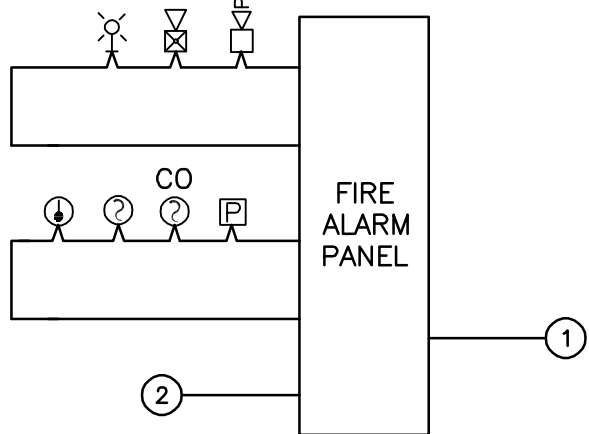

2 FIRE ALARM RISER DIAGRAM
E-1 SCALE: N.T.S.

- ZONING:
- BASEMENT.
 - MAIN FLOOR.

KEY NOTES:

- TO DEDICATED 120V CIRCUIT.
- TO TELEPHONE BACK BOARD.



04		
03		
02	ISSUED FOR TENDER	2018.01.22
01	ISSUED FOR REVIEW	2017.12.15
revision		date

Do not scale drawings.
Verify all dimensions and conditions on site and immediately notify the Departmental Representative of all discrepancies.

- A Detail No.
- B drawing no. - where detail required
- C drawing no. - where detailed

project title
titre du projet
INAC-PELICAN FALLS Ontario
PUBLIC SERVICES
AND PROCUREMENT CANADA

RESIDENCES & STAFF HOUSE
FIRE ALARM UPGRADE

drawing title
titre du dessin
ELECTRICAL SYMBOL LEGEND
AND DETAILS

drawn by
dessiné par T. SHTERENBERG

designed by
conçu par E. SAPACZ


approved by
approuvé par L. KORENBAUM

bid
offre project manager
administrateur de projets


project date
date du projet 2018-01-17

project no.
no. du projet R.087721.001


drawing no.
dessiné no. E-1

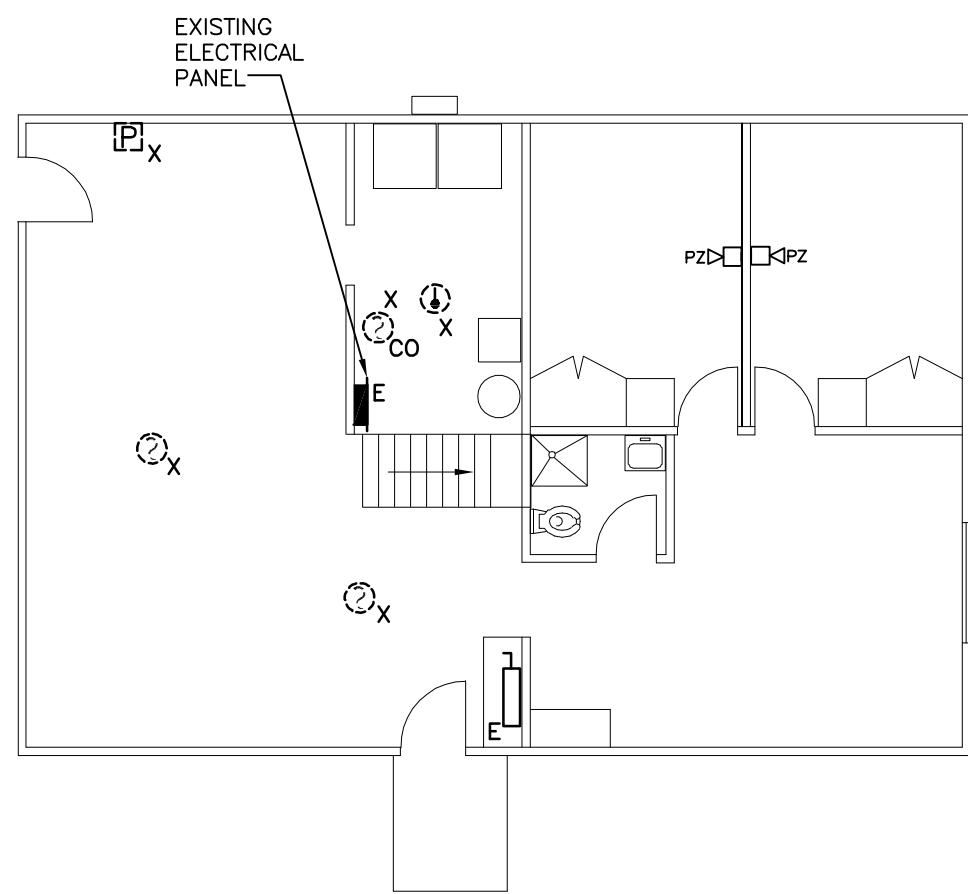


1 UNIT 1-BASEMENT-DEMOLITION-FIRE ALARM SYSTEM
E-2 SCALE: 1/8"=1'-0"

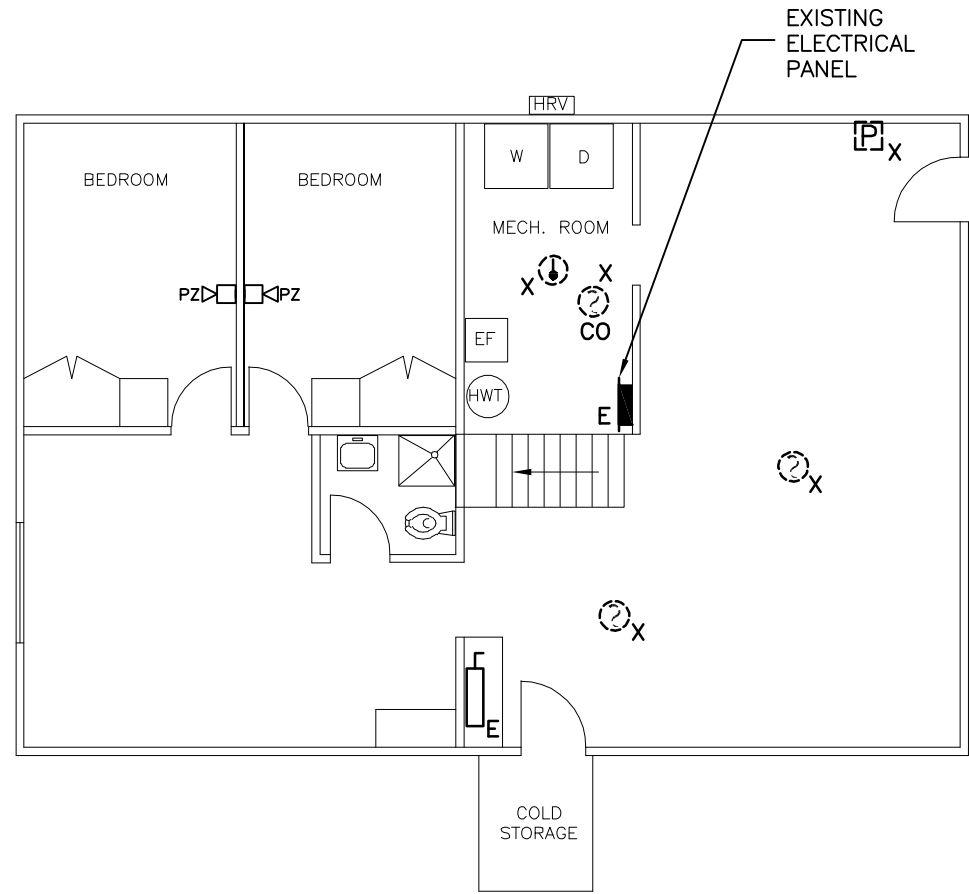

3 UNIT 2-BASEMENT-DEMOLITION-FIRE ALARM SYSTEM
E-2 SCALE: 1/8"=1'-0"

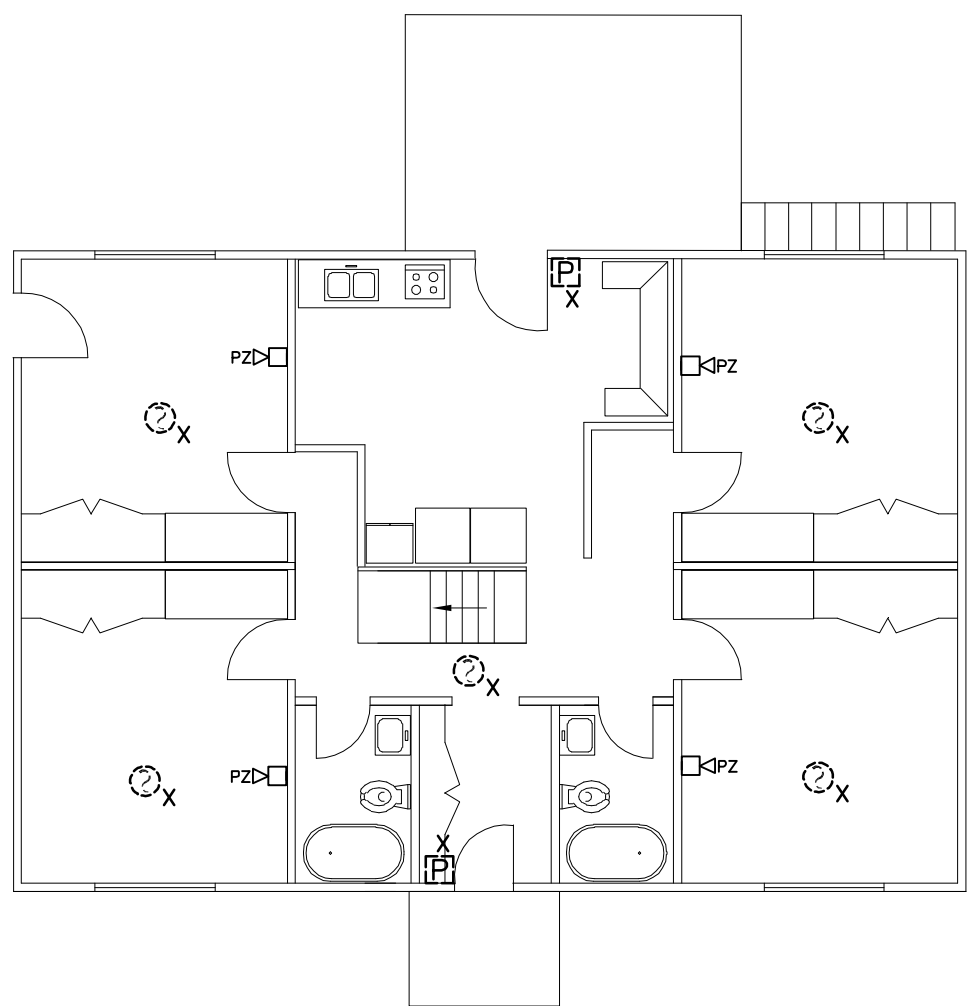

2 UNIT 1-MAIN FLOOR-DEMOLITION-FIRE ALARM SYSTEM
E-2 SCALE: 1/8"=1'-0"

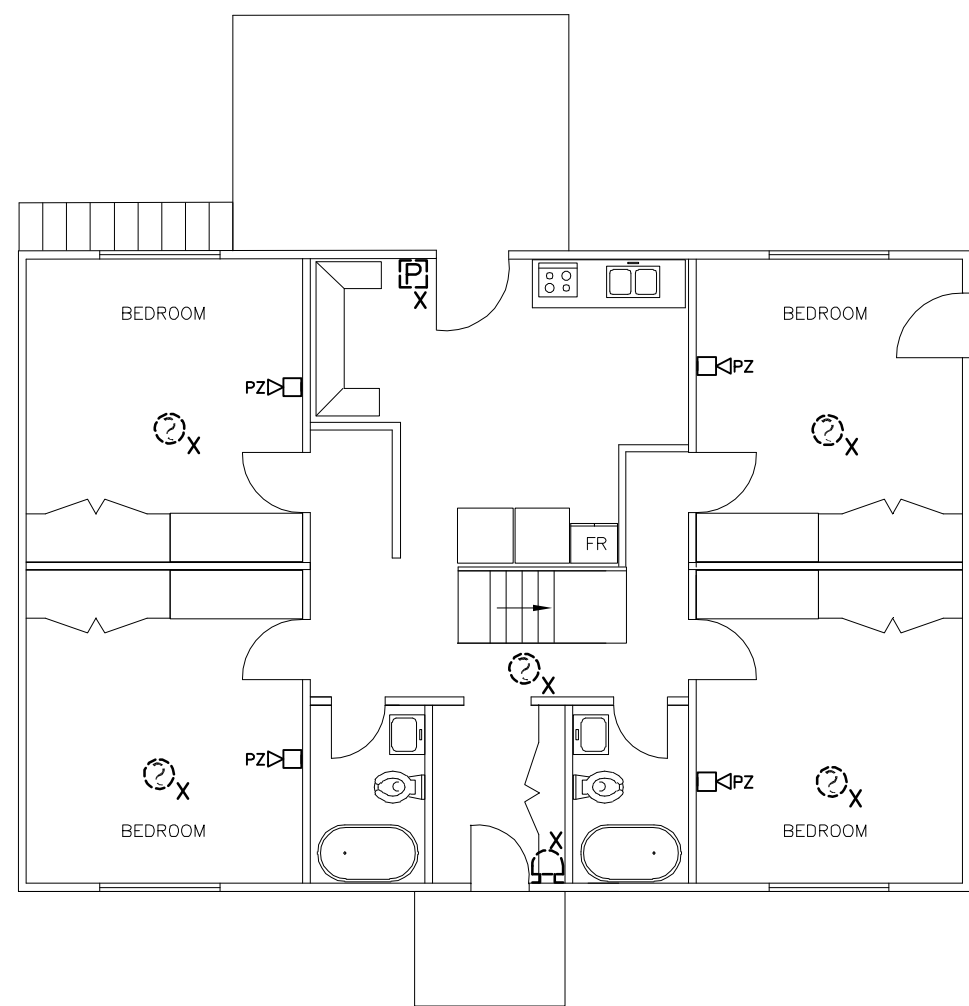

4 UNIT 2-MAIN FLOOR-DEMOLITION-FIRE ALARM SYSTEM
E-2 SCALE: 1/8"=1'-0"



04		
03		
02	ISSUED FOR TENDER	2018.01.22
01	ISSUED FOR REVIEW	2017.12.15
revision		date

Do not scale drawings.
Verify all dimensions and conditions on site and immediately
notify the Departmental Representative of all discrepancies.

A	Detail No.
B	drawing no. - where detail required
C	drawing no. - where detailed

project title
titre du projet
INAC-PELICAN FALLS
PUBLIC SERVICES
AND PROCUREMENT CANADA

RESIDENCES & STAFF HOUSE
FIRE ALARM UPGRADE

drawing title
titre du dessin
UNITS 1,2
BASEMENT AND MAIN FLOOR
DEMOLITION-FIRE ALARM SYSTEM

drawn by
dessiné par
T. SHTERENBERG

designed by
conc par
E. SAPACZ

approved by
approuvé par
L. KORENBAUM

bid
offre
project manager
administrateur
de projets


project date
date du projet
2018-01-17

project no.
no. du projet
R.087721.001


drawing no.
dessiné no.
E-2




1 UNIT 4-BASEMENT-DEMOLITION-FIRE ALARM SYSTEM
E-3 SCALE: 1/8"=1'-0"

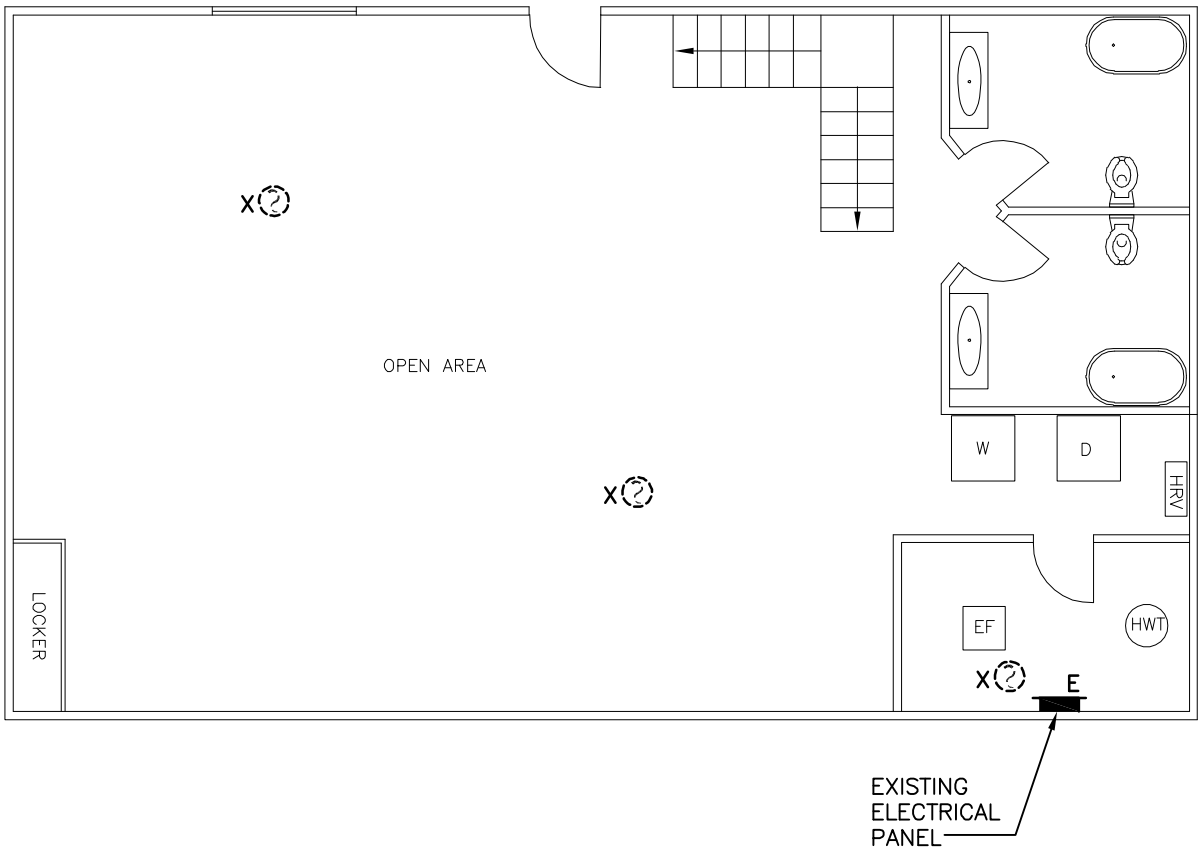

3 UNIT 5-BASEMENT-DEMOLITION-FIRE ALARM SYSTEM
E-3 SCALE: 1/8"=1'-0"

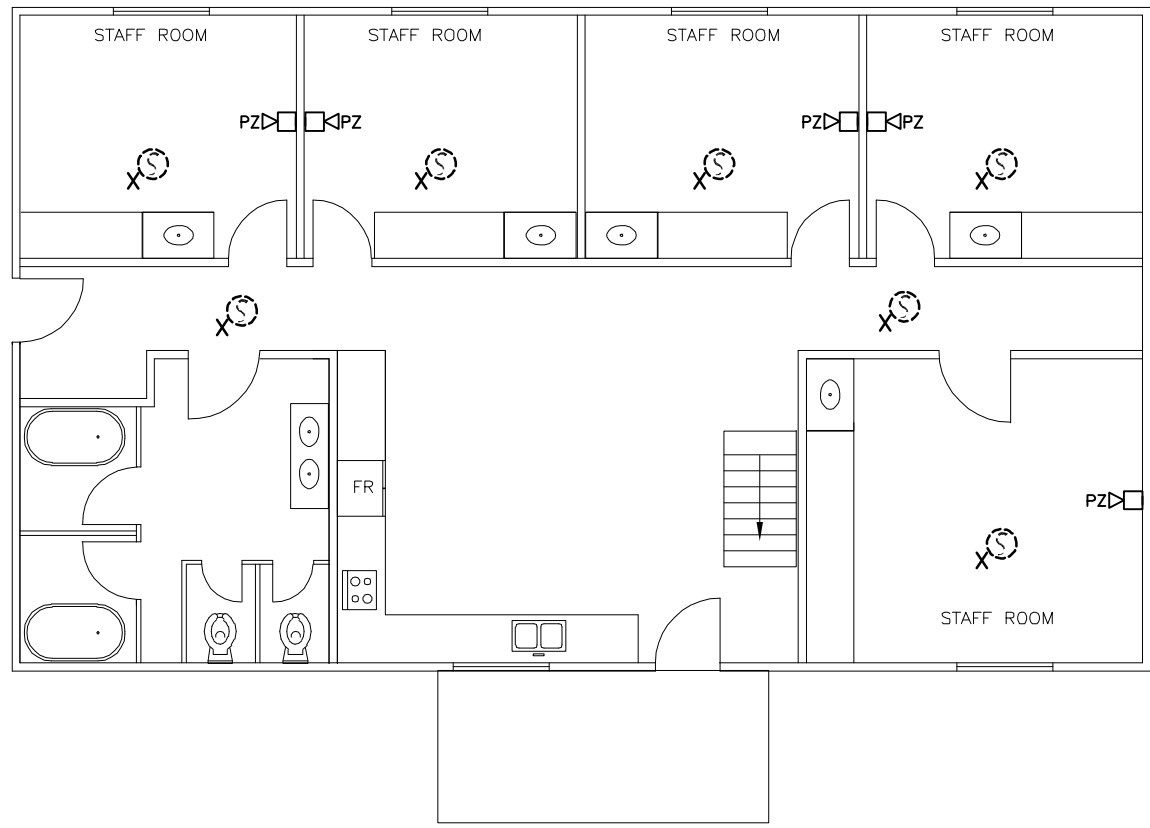

2 UNIT 4-MAIN FLOOR-DEMOLITION-FIRE ALARM SYSTEM
E-3 SCALE: 1/8"=1'-0"

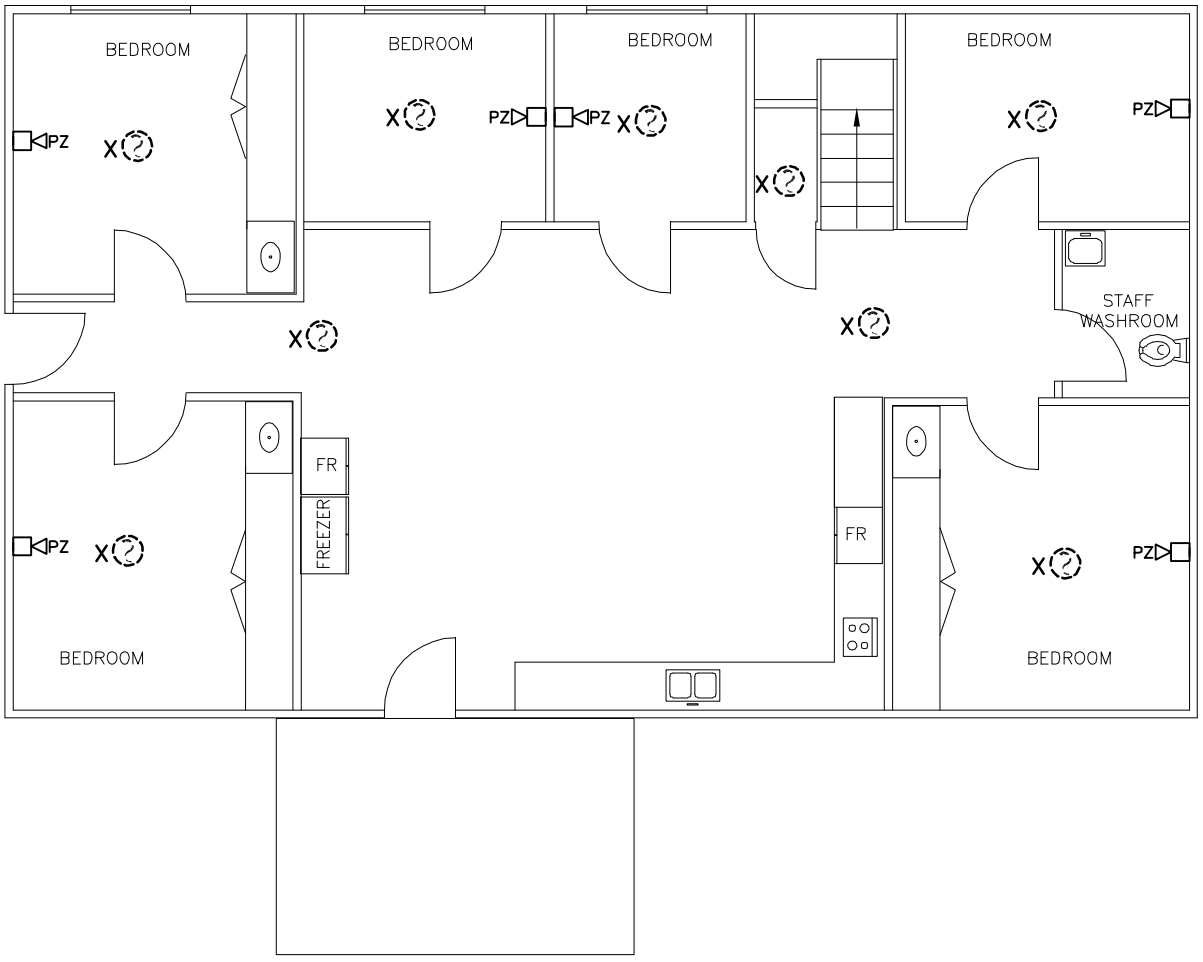

4 UNIT 5-MAIN FLOOR-DEMOLITION-FIRE ALARM SYSTEM
E-3 SCALE: 1/8"=1'-0"



04		
03		
02	ISSUED FOR TENDER	2018.01.22
01	ISSUED FOR REVIEW	2017.12.15
revision		date

Do not scale drawings.
Verify all dimensions and conditions on site and immediately
notify the Departmental Representative of all discrepancies.

A	Detail No.
B	drawing no. - where detail required
C	drawing no. - where detailed

project title
titre du projet
INAC-PELICAN FALLS Ontario
PUBLIC SERVICES
AND PROCUREMENT CANADA

RESIDENCES & STAFF HOUSE
FIRE ALARM UPGRADE

drawing title
titre du dessin
UNITS 4,5
BASEMENT AND MAIN FLOOR
DEMOLITION-FIRE ALARM SYSTEM

drawn by
dessiné par T. SHTERENBERG

designed by
conçu par E. SAPACZ


approved by
approuvé par L. KORENBAUM

bid
offre project manager
administrateur
de projets

project date
date du projet 2018-01-17

project no.
no. du projet R.087721.001


drawing no.
dessiné no. E-3

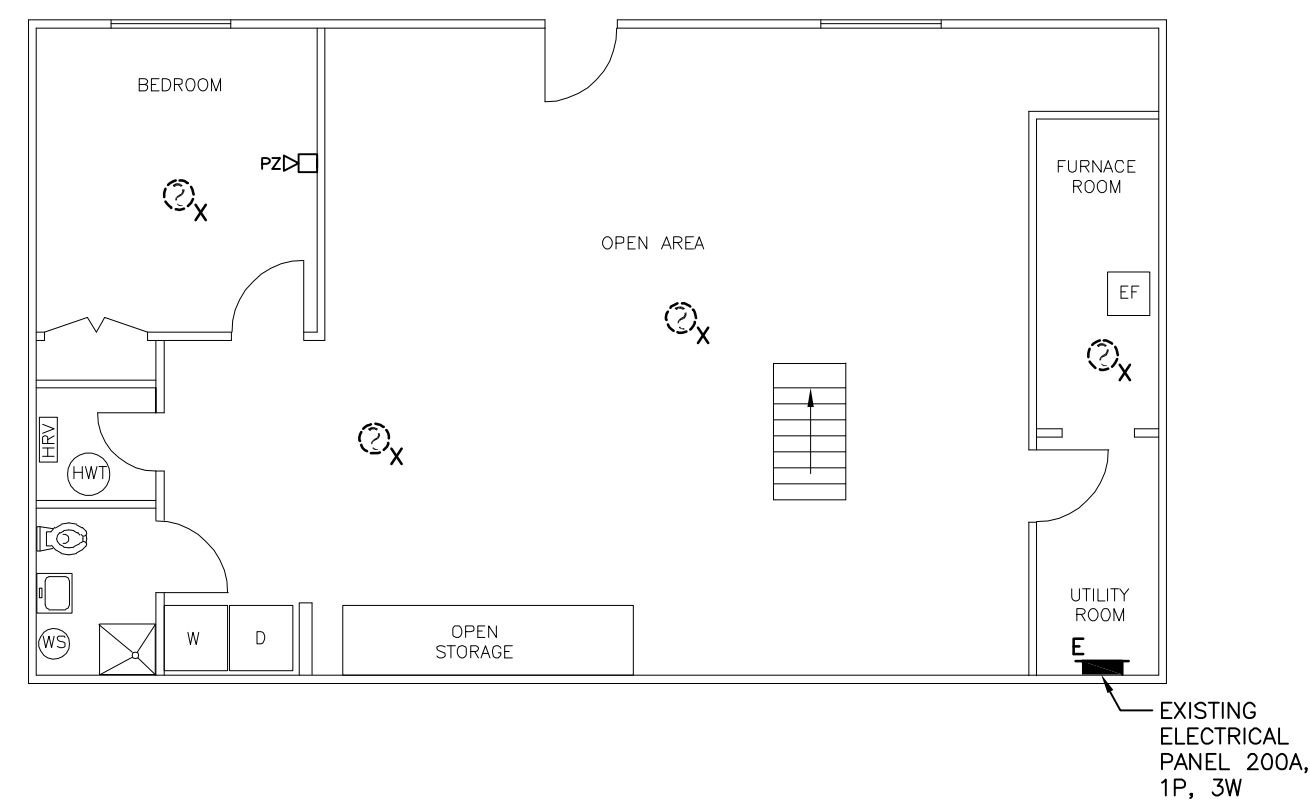


1 UNIT 6-BASEMENT-DEMOLITION-FIRE ALARM SYSTEM
E-4 SCALE: 1/8"=1'-0"



3 UNIT 7-BASEMENT-DEMOLITION-FIRE ALARM SYSTEM
E-4 SCALE: 1/8"=1'-0"

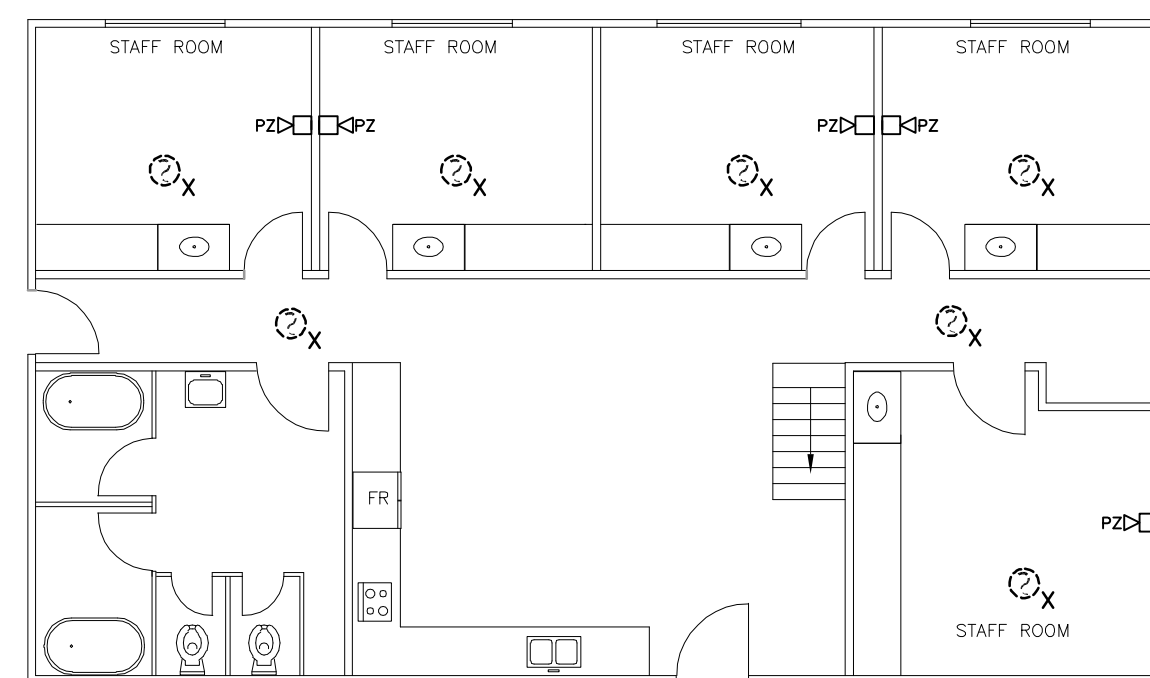

2 UNIT 6-MAIN FLOOR-DEMOLITION-FIRE ALARM SYSTEM
E-4 SCALE: 1/8"=1'-0"

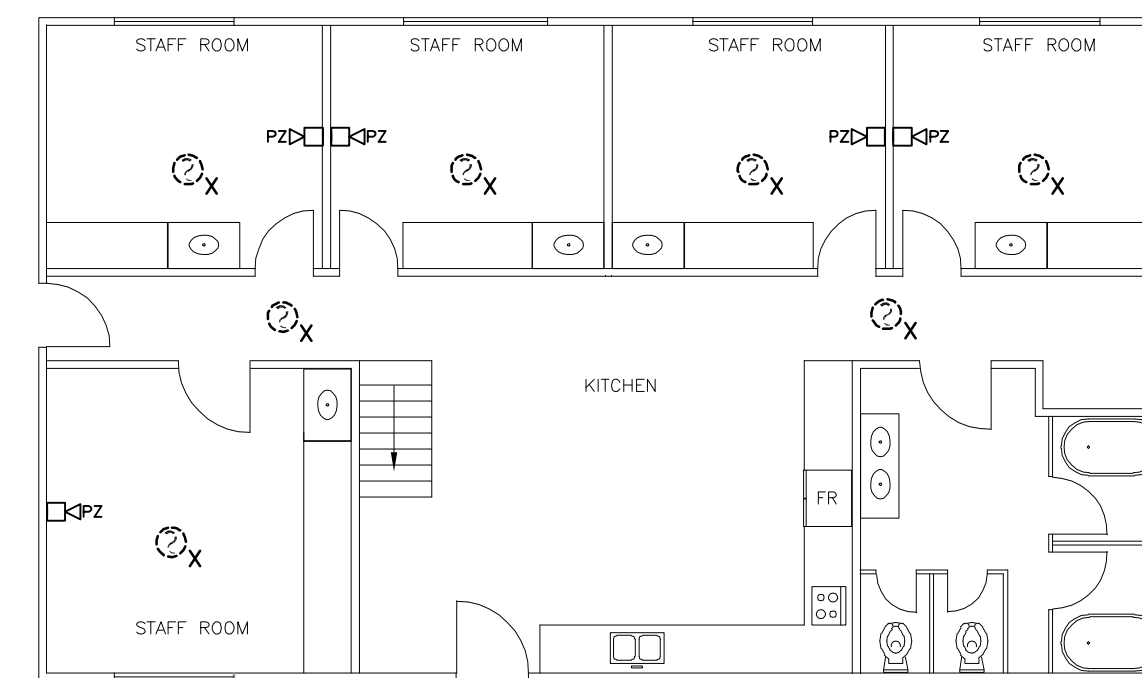

4 UNIT 7-MAIN FLOOR-DEMOLITION-FIRE ALARM SYSTEM
E-4 SCALE: 1/8"=1'-0"



04		
03		
02	ISSUED FOR TENDER	2018.01.22
01	ISSUED FOR REVIEW	2017.12.15
revision		date

Do not scale drawings.
Verify all dimensions and conditions on site and immediately
notify the Departmental Representative of all discrepancies.

A	Detail No.
B	drawing no. - where detail required
C	drawing no. - where detailed

project title
titre du projet
INAC-PELICAN FALLS Ontario
PUBLIC SERVICES
AND PROCUREMENT CANADA

RESIDENCES & STAFF HOUSE
FIRE ALARM UPGRADE

drawing title
titre du dessin
UNITS 6,7
BASEMENT AND MAIN FLOOR
DEMOLITION-FIRE ALARM SYSTEM

drawn by
dessiné par T. SHTERENBERG

designed by
conçu par E. SAPACZ


approved by
approuvé par L. KORENBAUM

bid
offre project manager
administrateur
de projets


project date
date du projet 2018-01-17

project no.
no. du projet R.087721.001


drawing no.
dessiné no. E-4

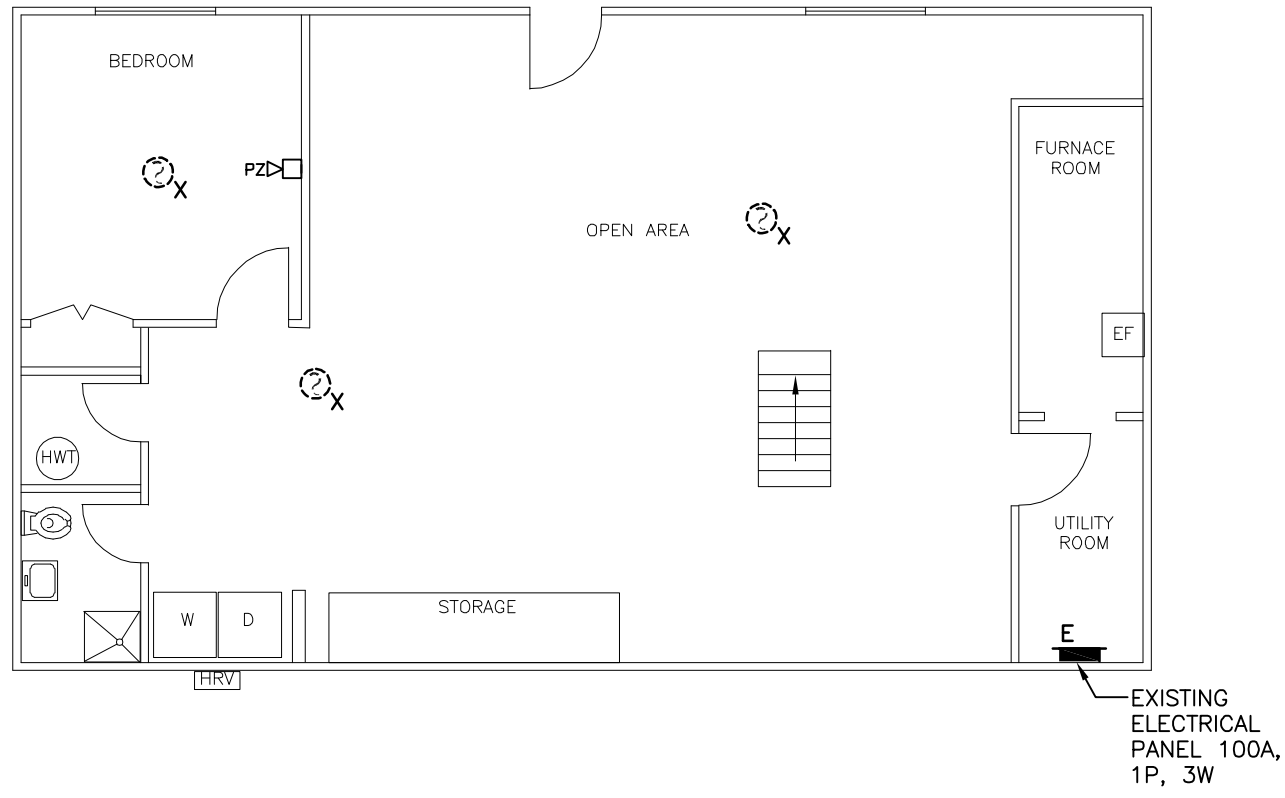


1 UNIT 8-BASEMENT-DEMOLITION-FIRE ALARM SYSTEM
E-5 SCALE: 1/8"=1'-0"

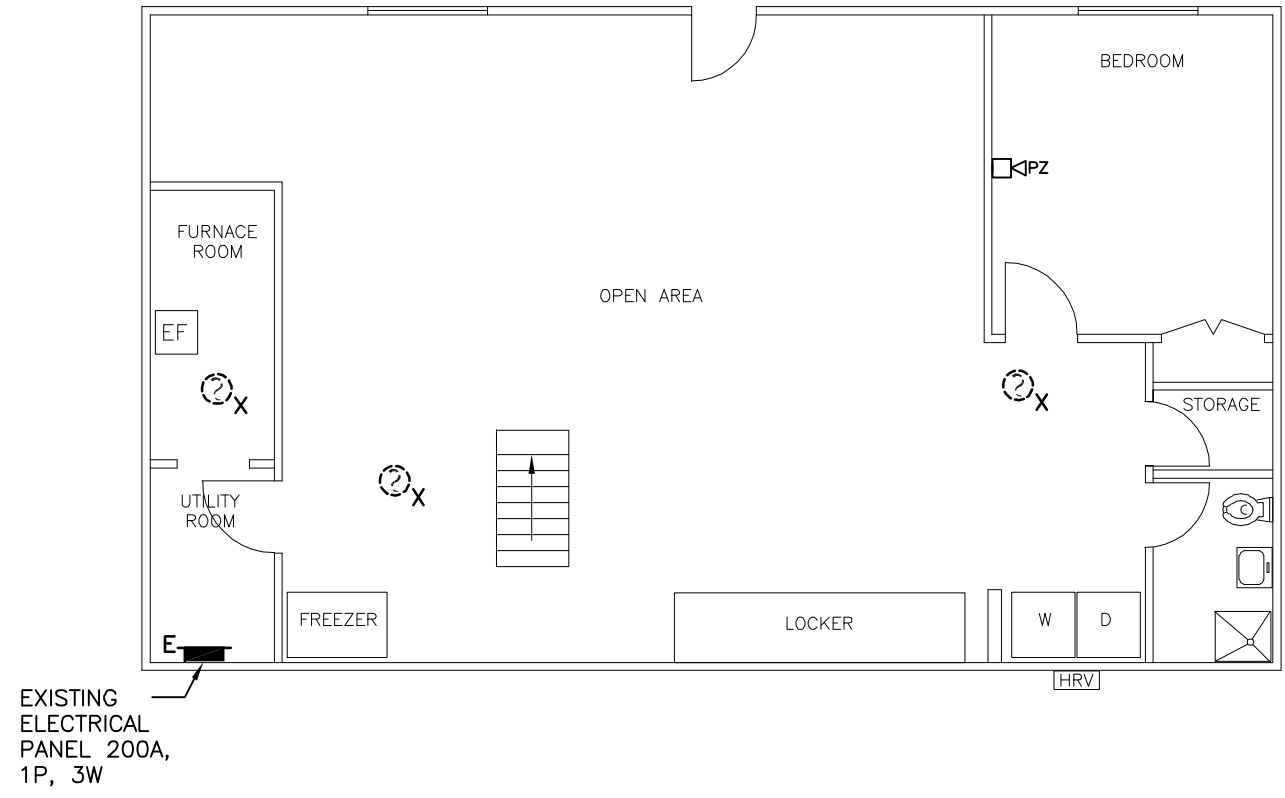

3 UNIT 9-BASEMENT-DEMOLITION-FIRE ALARM SYSTEM
E-5 SCALE: 1/8"=1'-0"

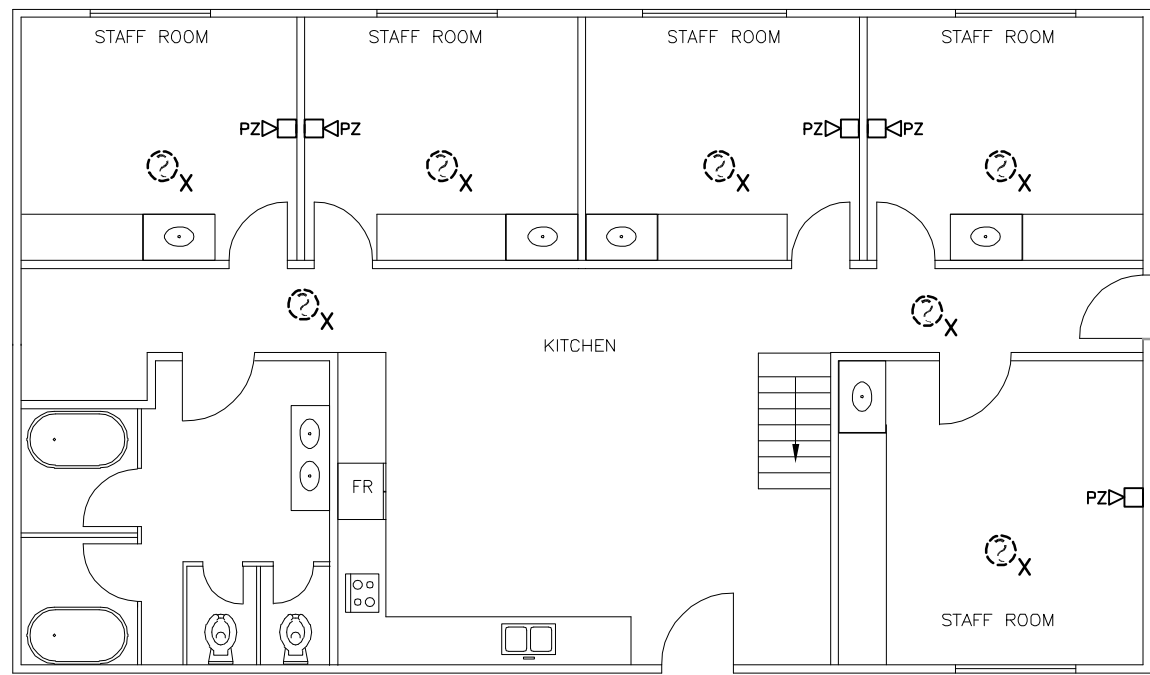

2 UNIT 8-MAIN FLOOR-DEMOLITION-FIRE ALARM SYSTEM
E-5 SCALE: 1/8"=1'-0"

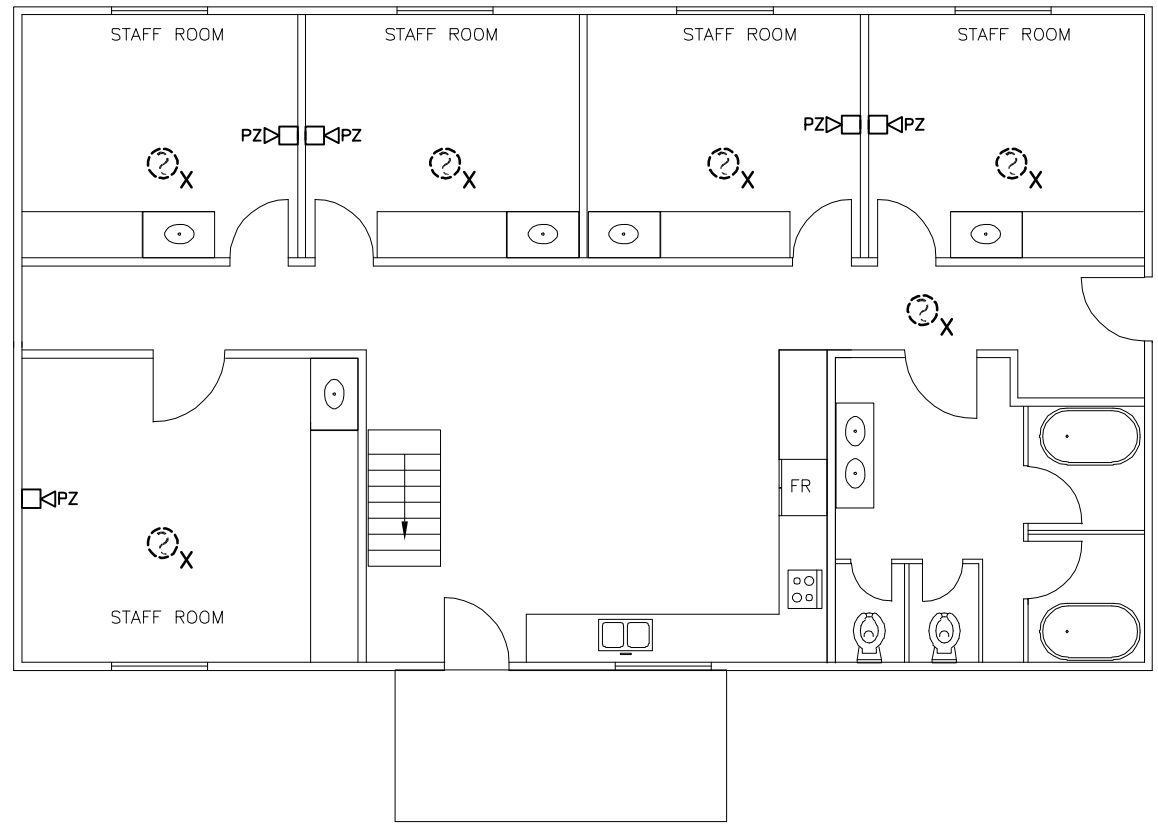

4 UNIT 9-MAIN FLOOR-DEMOLITION-FIRE ALARM SYSTEM
E-5 SCALE: 1/8"=1'-0"



04		
03		
02	ISSUED FOR TENDER	2018.01.22
01	ISSUED FOR REVIEW	2017.12.15
revision		date

Do not scale drawings.
Verify all dimensions and conditions on site and immediately
notify the Departmental Representative of all discrepancies.

A	Detail No.
B	No. du détail
C	drawing no. - where detail required dessin no. - où détail exigé
	drawing no. - where detailed dessin no. - où détaillé

project title
titre du projet
INAC-PELICAN FALLS Ontario
PUBLIC SERVICES
AND PROCUREMENT CANADA

RESIDENCES & STAFF HOUSE
FIRE ALARM UPGRADE

drawing title
titre du dessin
UNITS 8,9
BASEMENT AND MAIN FLOOR
DEMOLITION-FIRE ALARM SYSTEM

drawn by
dessiné par T. SHTERENBERG

designed by
conçu par E. SAPACZ


approved by
approuvé par L. KORENBAUM

bid
offre project manager
administrateur de projets


project date
date du projet 2018-01-17

project no.
no. du projet R.087721.001


drawing no.
dessiné no. E-5

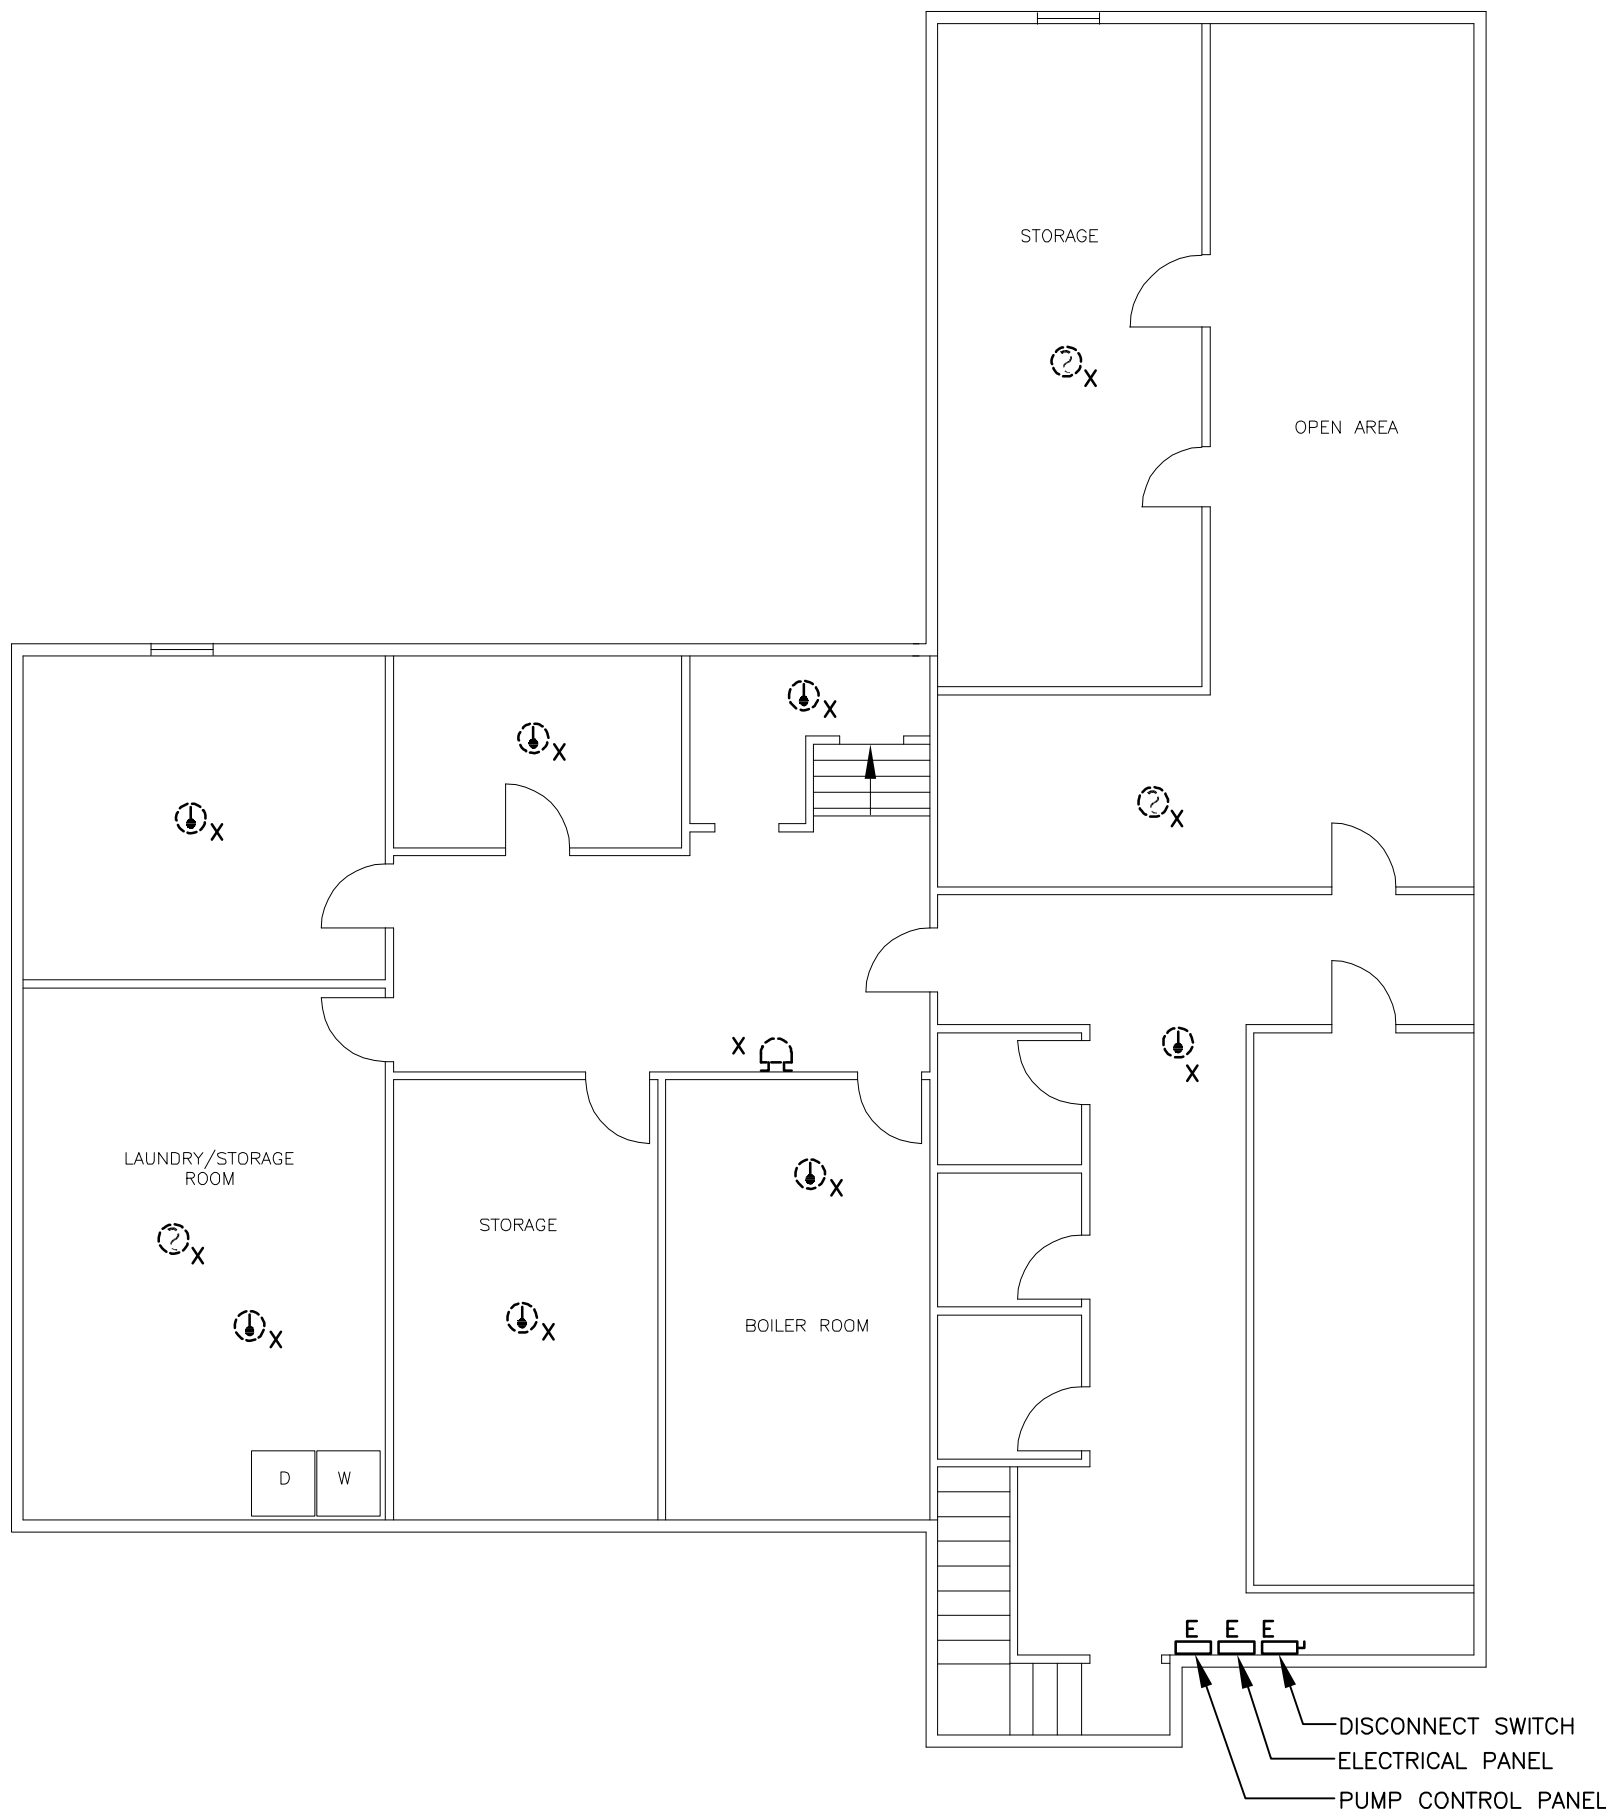


1 UNIT 3-BASEMENT-DEMOLITION-FIRE ALARM SYSTEM
E-6 SCALE: 1/8"=1'-0"

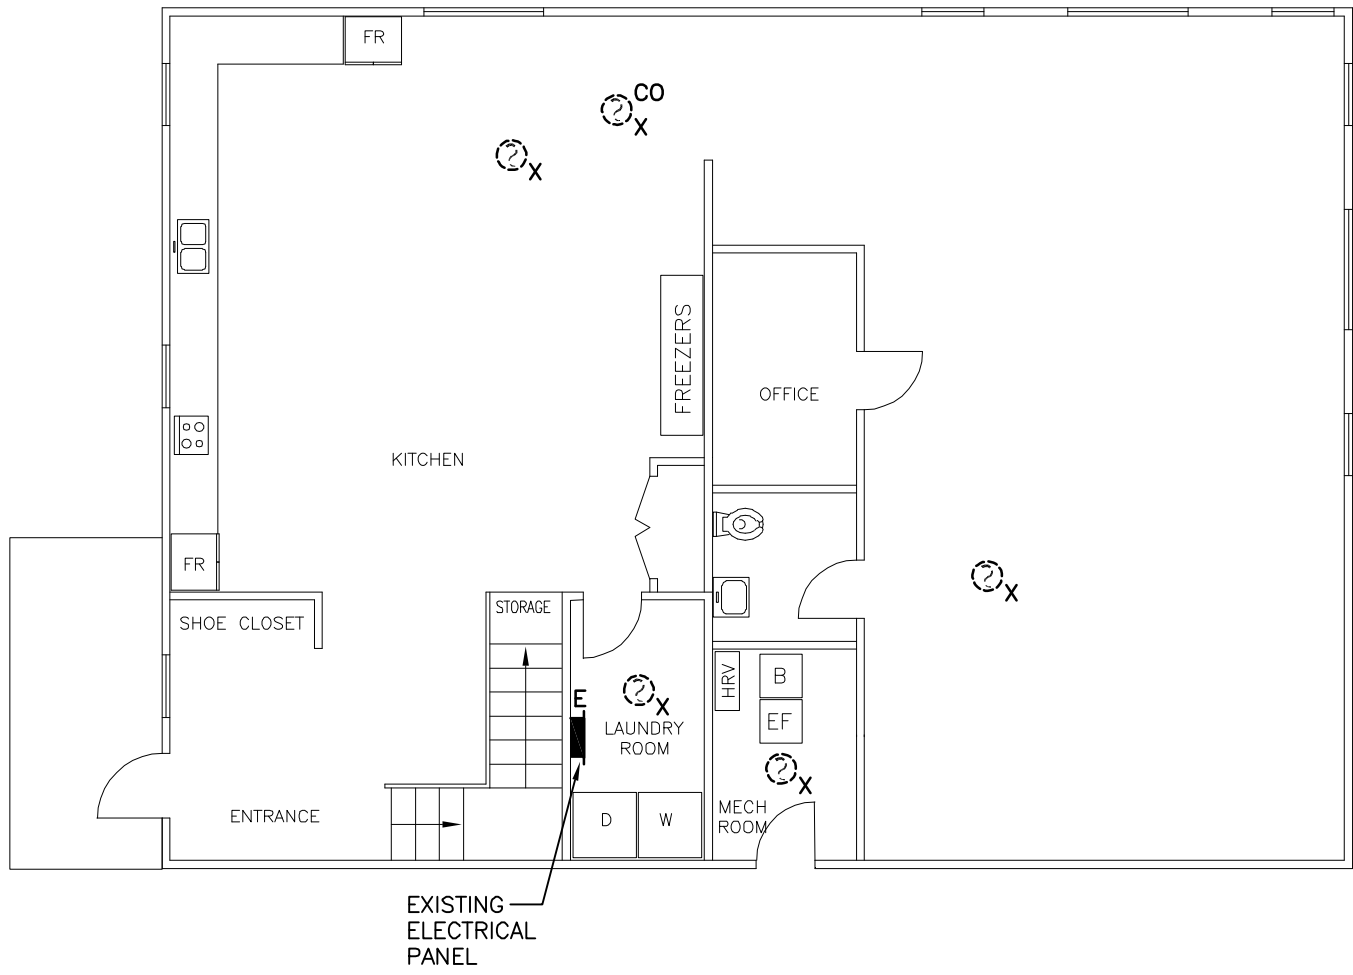

3 UNITS 11-14 (TYPICAL)-MAIN FLOOR-DEMOLITION-FIRE ALARM SYSTEM
E-6 SCALE: 1/8"=1'-0"

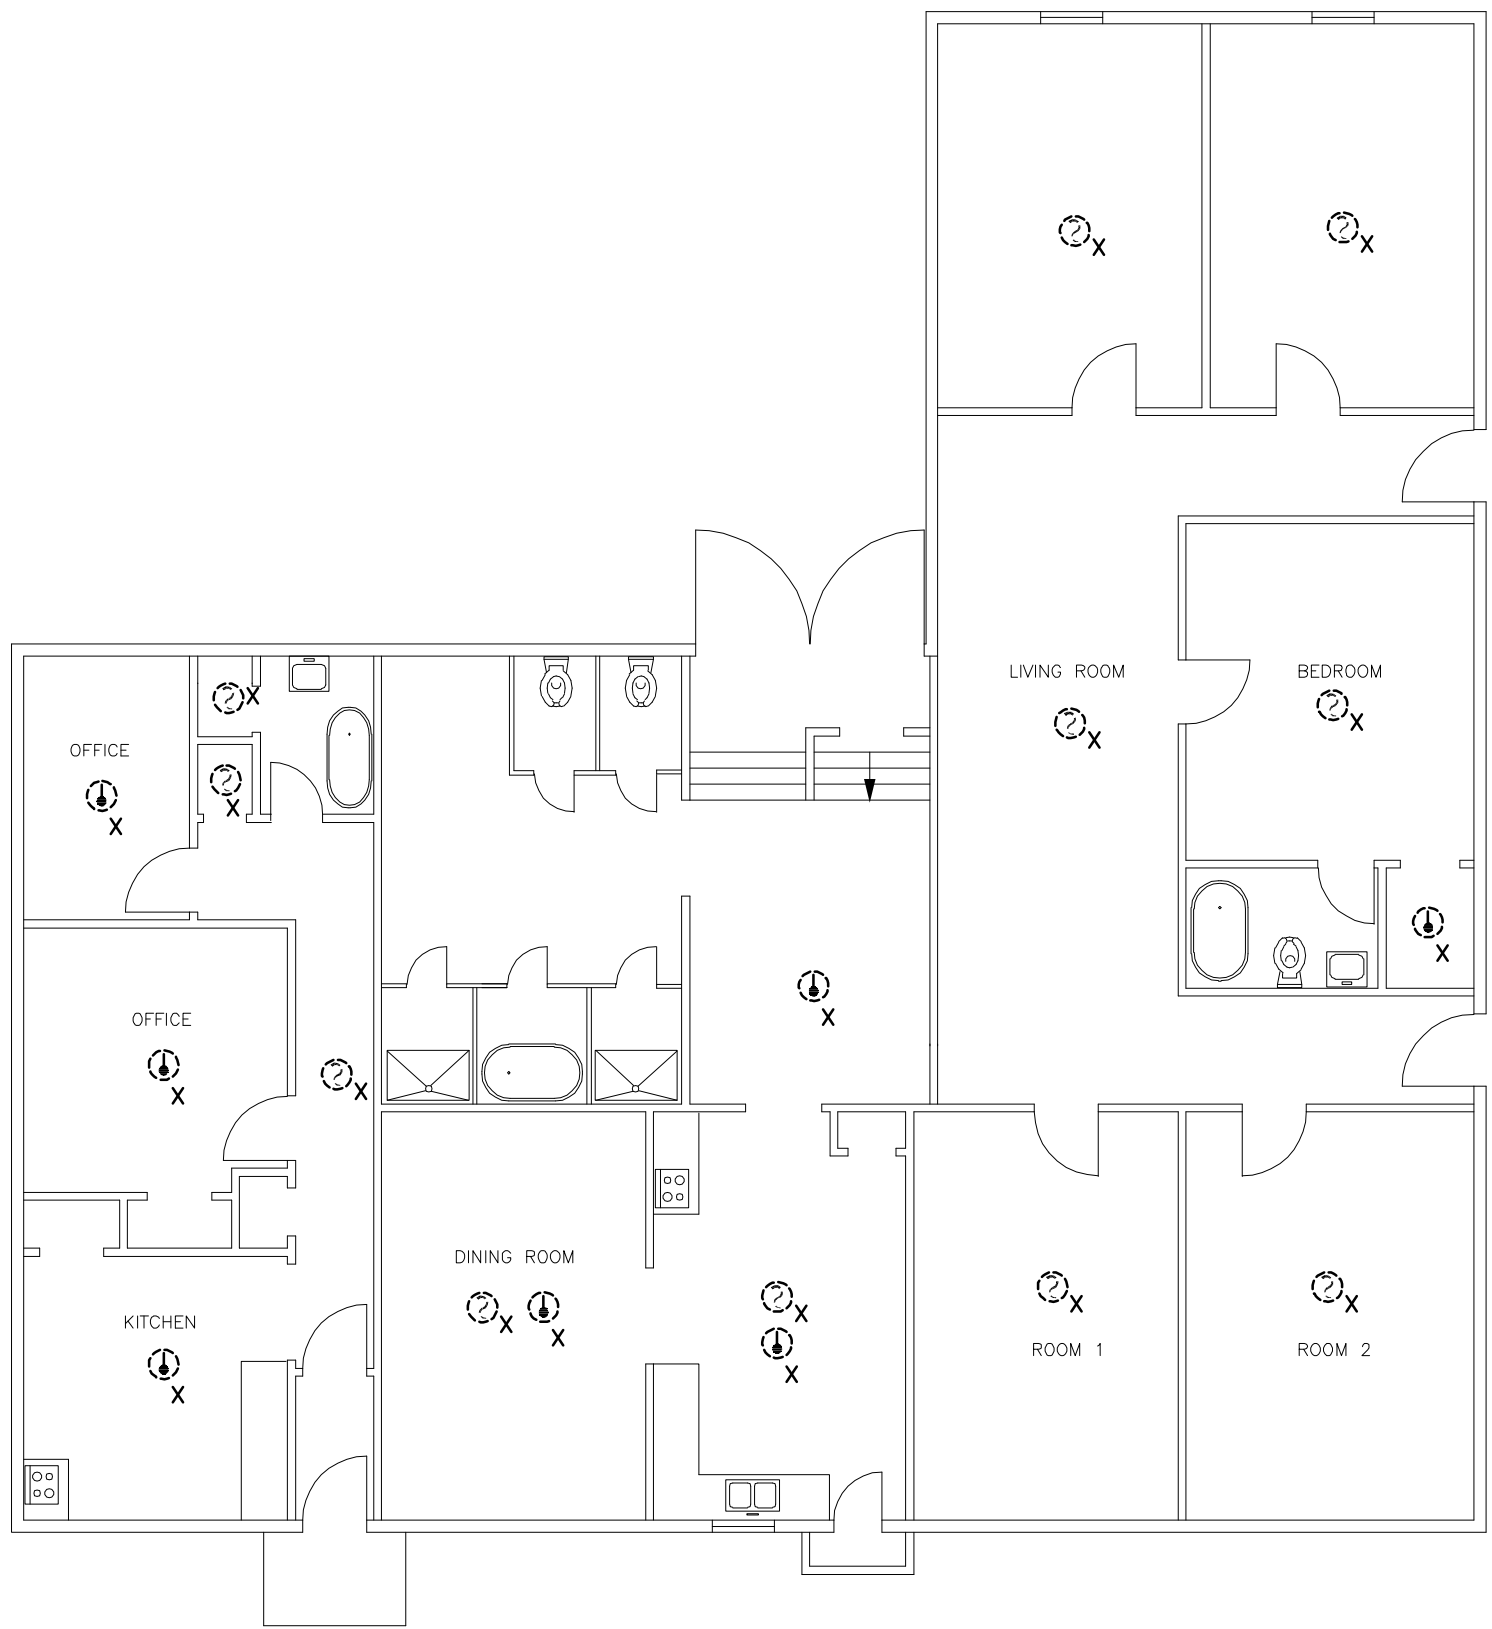

2 UNIT 3-MAIN FLOOR-DEMOLITION-FIRE ALARM SYSTEM
E-6 SCALE: 1/8"=1'-0"

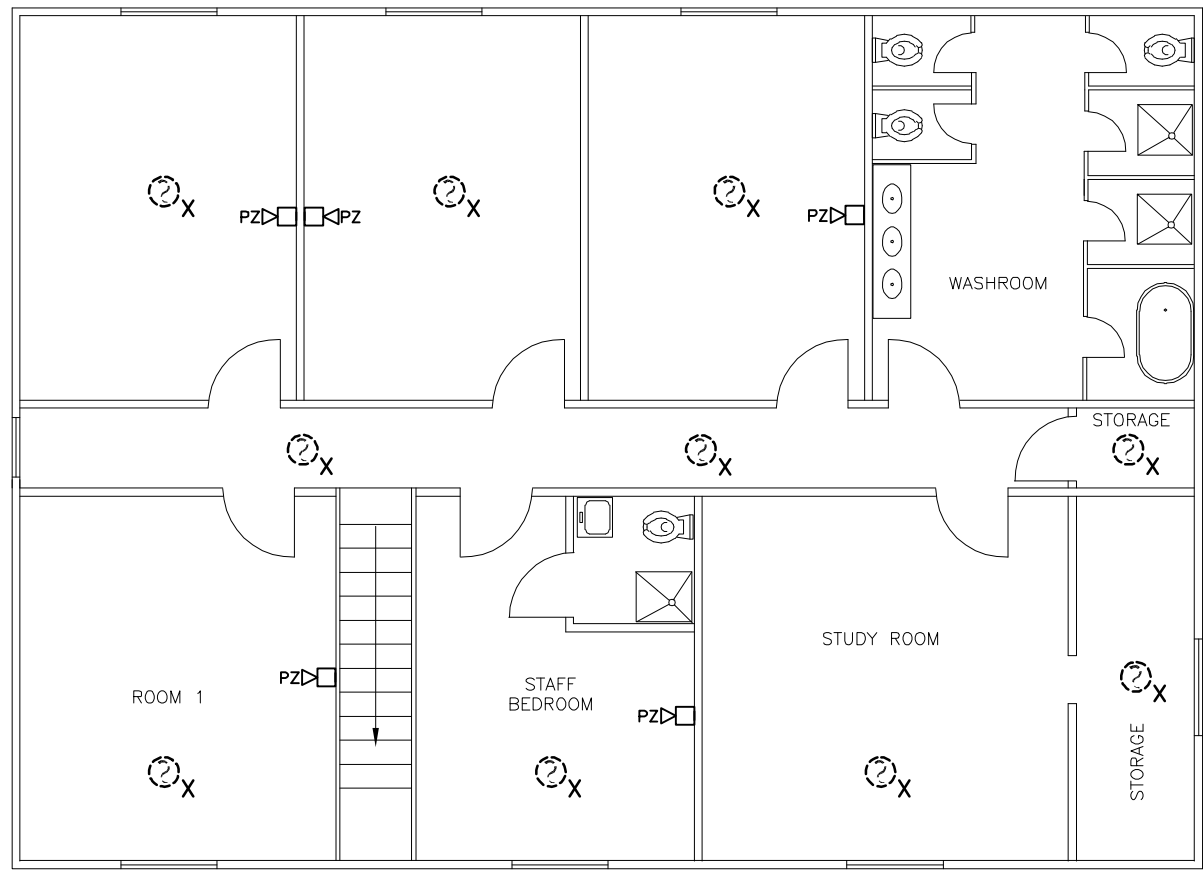

4 UNITS 11-14 (TYPICAL)-SECOND FLOOR-DEMOLITION-FIRE ALARM SYSTEM
E-6 SCALE: 1/8"=1'-0"



04		
03		
02	ISSUED FOR TENDER	2018.01.22
01	ISSUED FOR REVIEW	2017.12.15
revision		date

Do not scale drawings.
Verify all dimensions and conditions on site and immediately
notify the Departmental Representative of all discrepancies.

- A Detail No.
No. du détail
B drawing no. - where detail required
dessin no. - où détail exigé
C drawing no. - where detailed
dessin no. - où détaillé

project title
titre du projet
INAC-PELICAN FALLS Ontario
PUBLIC SERVICES
AND PROCUREMENT CANADA

RESIDENCES & STAFF HOUSE
FIRE ALARM UPGRADE

drawing title
titre du dessin
UNIT 3, UNITS 11-14 (TYPICAL)
DEMOLITION-FIRE ALARM SYSTEM

drawn by
dessiné par T. SHTERENBERG

designed by
conçu par E. SAPACZ


approved by
approuvé par L. KORENBAUM

bid
offre project manager
administrateur
de projets


project date
date du projet 2018-01-17

project no.
no. du projet R.087721.001


drawing no.
dessiné no. E-6

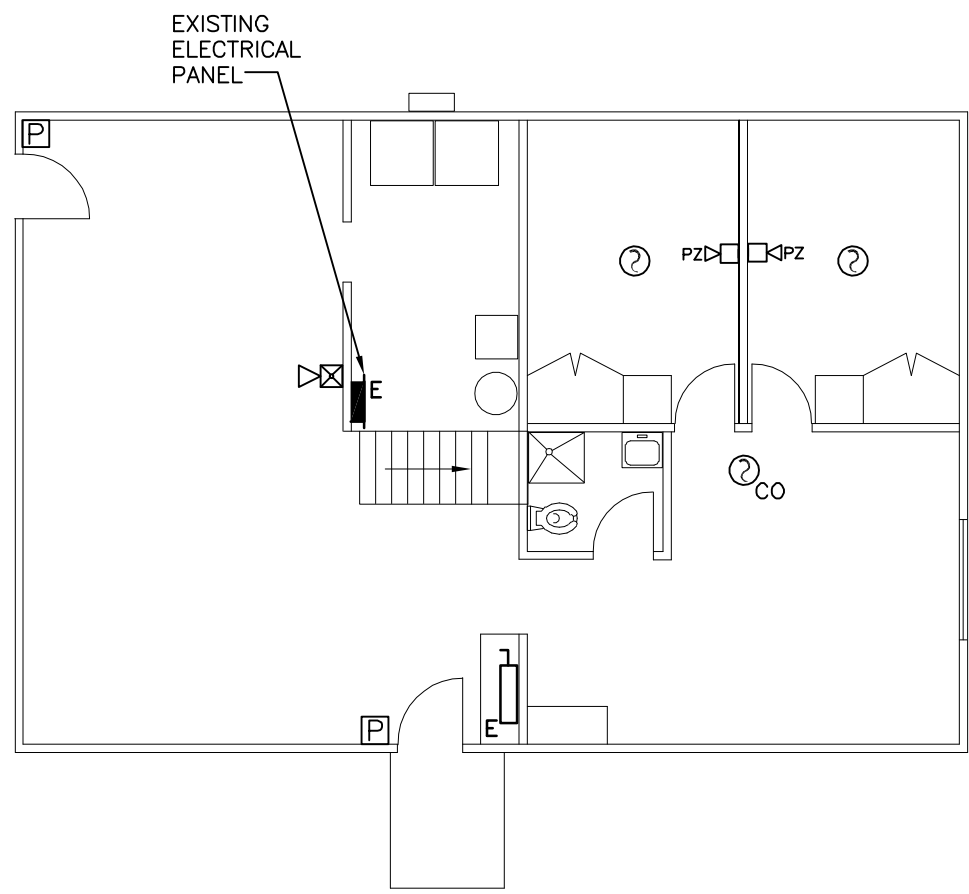


1 UNIT 1-BASEMENT-RENOVATION-FIRE ALARM SYSTEM
E-7 SCALE: 1/8"=1'-0"

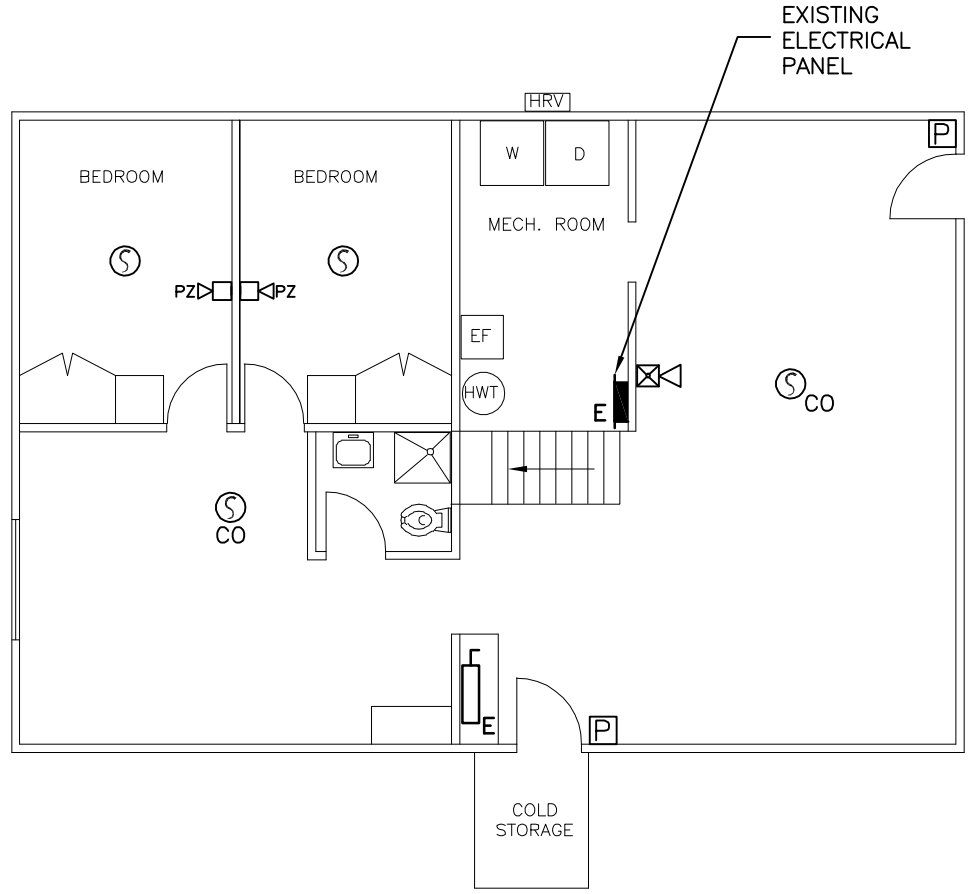

3 UNIT 2-BASEMENT-RENOVATION-FIRE ALARM SYSTEM
E-7 SCALE: 1/8"=1'-0"

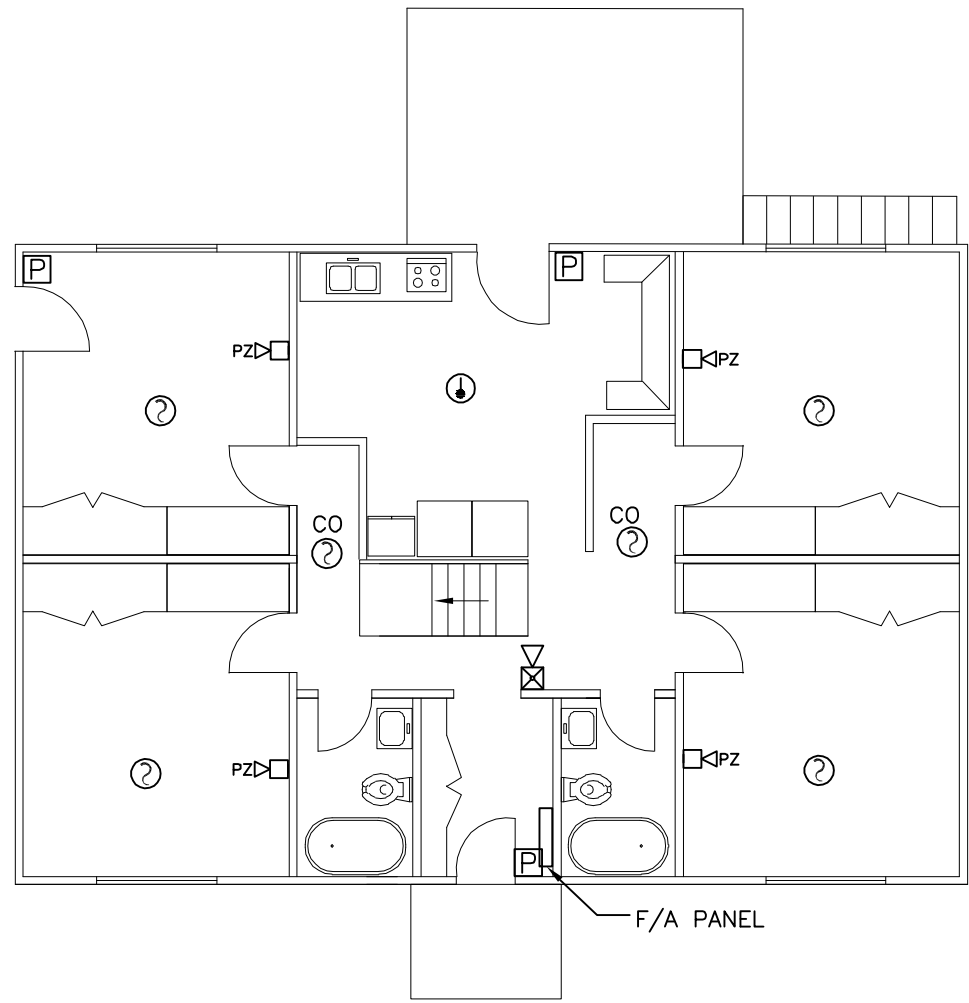

2 UNIT 1-MAIN FLOOR-RENOVATION-FIRE ALARM SYSTEM
E-7 SCALE: 1/8"=1'-0"

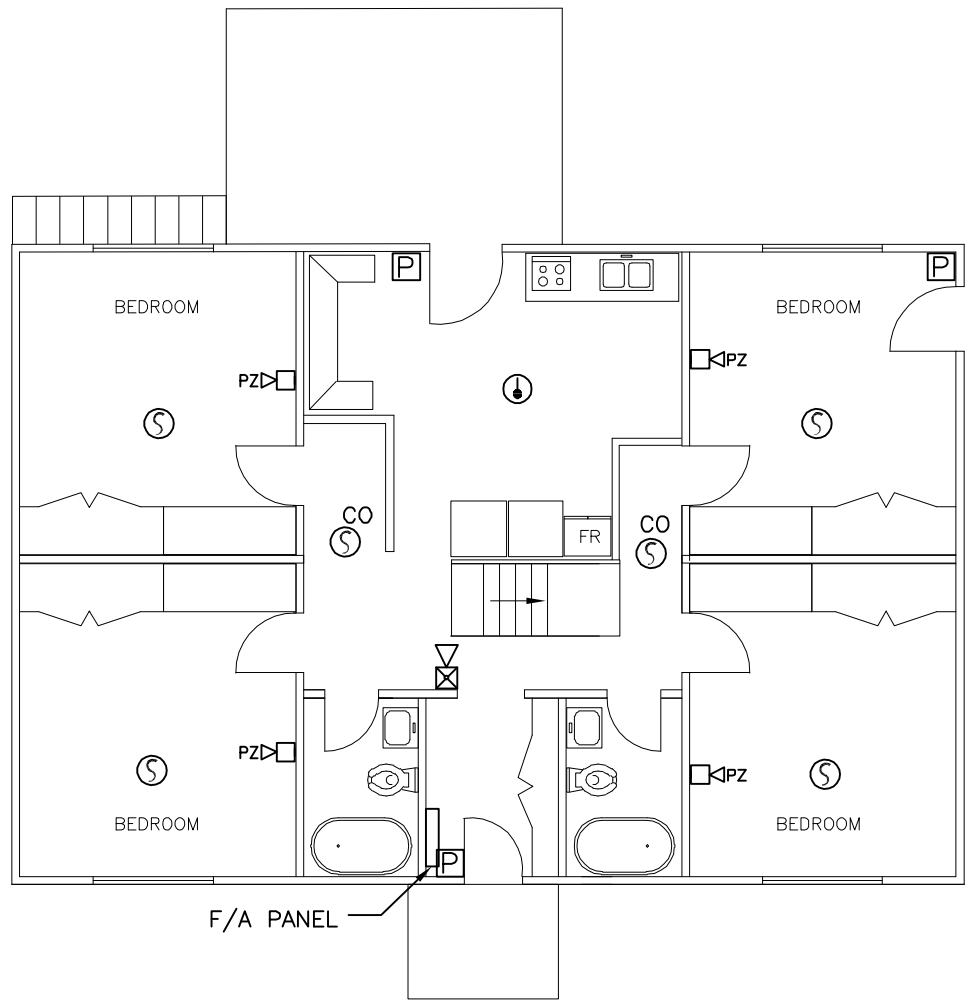

4 UNIT 2-MAIN FLOOR-RENOVATION-FIRE ALARM SYSTEM
E-7 SCALE: 1/8"=1'-0"



04		
03		
02	ISSUED FOR TENDER	2018.01.22
01	ISSUED FOR REVIEW	2017.12.15
revision		date

Do not scale drawings.
Verify all dimensions and conditions on site and immediately
notify the Departmental Representative of all discrepancies.

- A Detail No.
No. du détail
B drawing no. - where detail required
dessin no. - où détail exigé
C drawing no. - where detailed
dessin no. - où détaillé

project title
titre du projet
INAC-PELICAN FALLS Ontario
PUBLIC SERVICES
AND PROCUREMENT CANADA

RESIDENCES & STAFF HOUSE
FIRE ALARM UPGRADE

drawing title
titre du dessin
UNITS 1,2
BASEMENT AND MAIN FLOOR
RENOVATION-FIRE ALARM SYSTEM

drawn by
dessiné par T. SHTERENBERG

designed by
conçu par E. SAPACZ


approved by
approuvé par L. KORENBAUM

bid
offre project manager
administrateur
de projets


project date
date du projet 2018-01-17

project no.
no. du projet R.087721.001


drawing no.
dessiné no. E-7

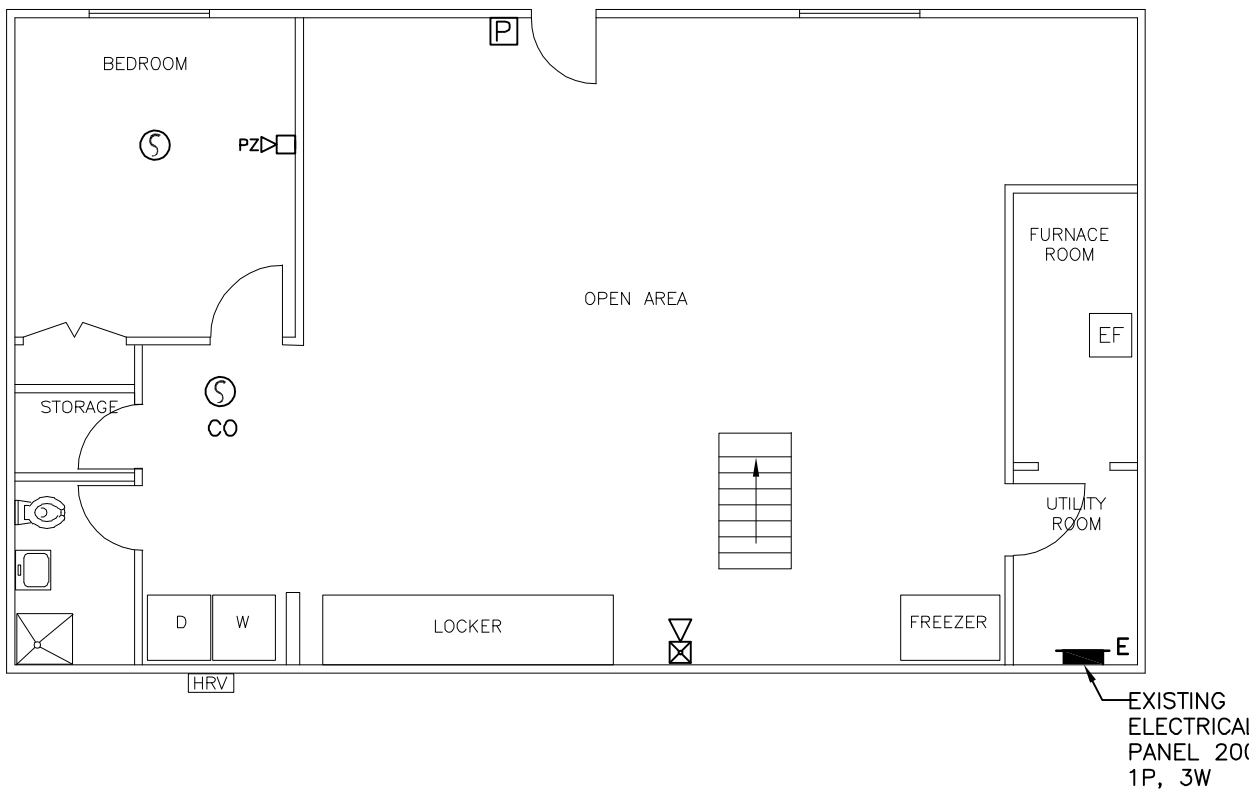


1 UNIT 4-BASEMENT-RENOVATION-FIRE ALARM SYSTEM
E-8 SCALE: 1/8"=1'-0"

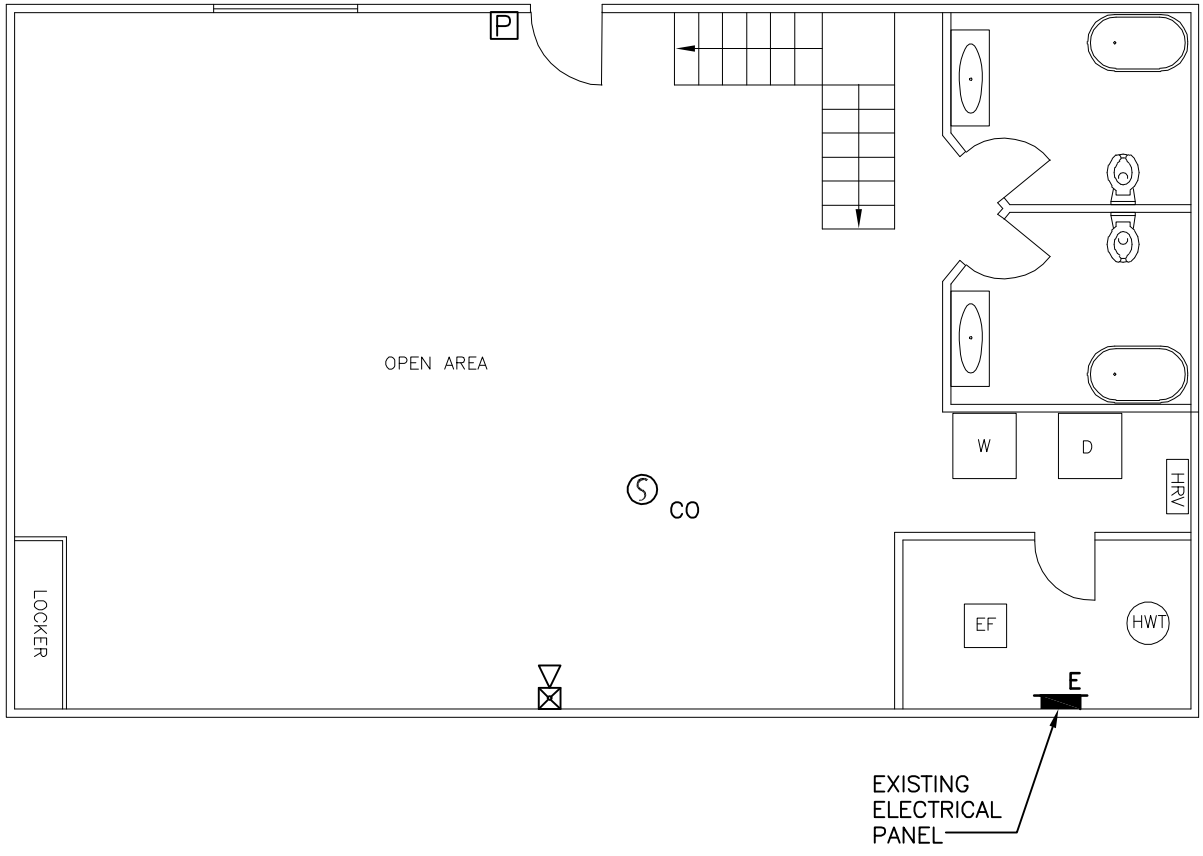

3 UNIT 5-BASEMENT-RENOVATION-FIRE ALARM SYSTEM
E-8 SCALE: 1/8"=1'-0"

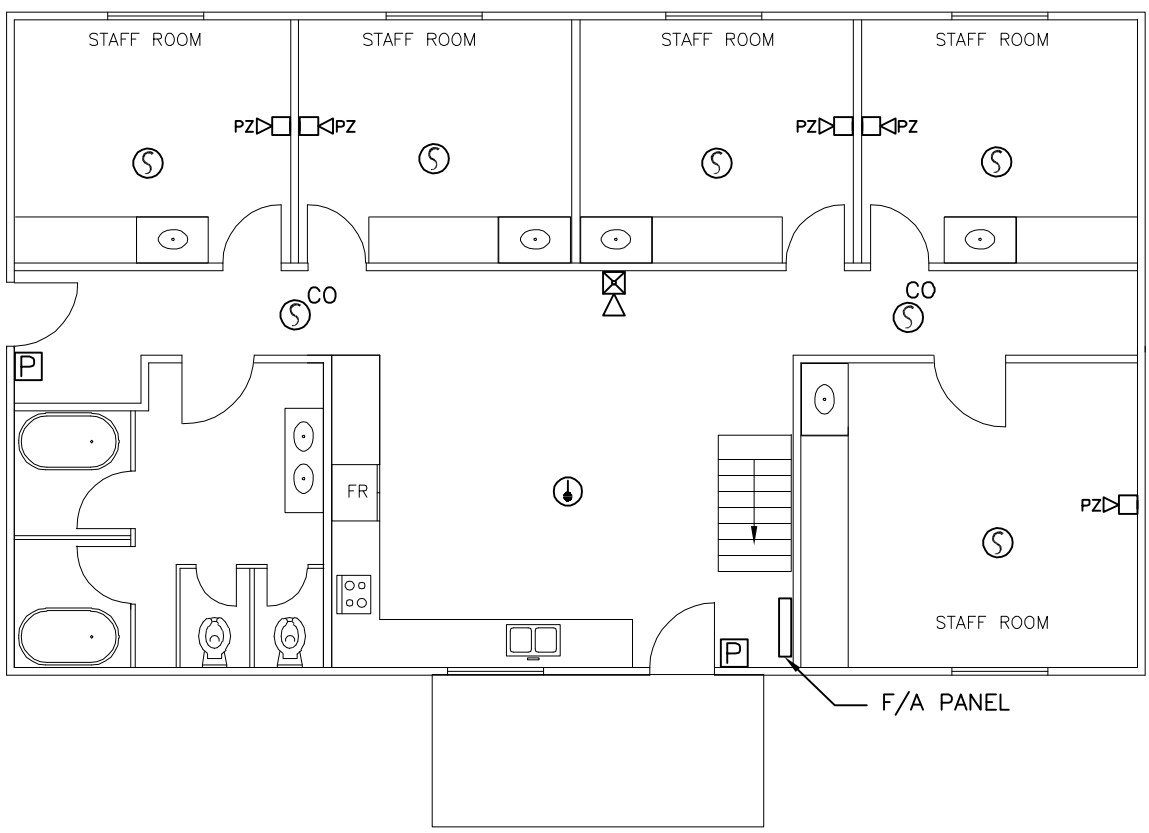

2 UNIT 4-MAIN FLOOR-RENOVATION-FIRE ALARM SYSTEM
E-8 SCALE: 1/8"=1'-0"

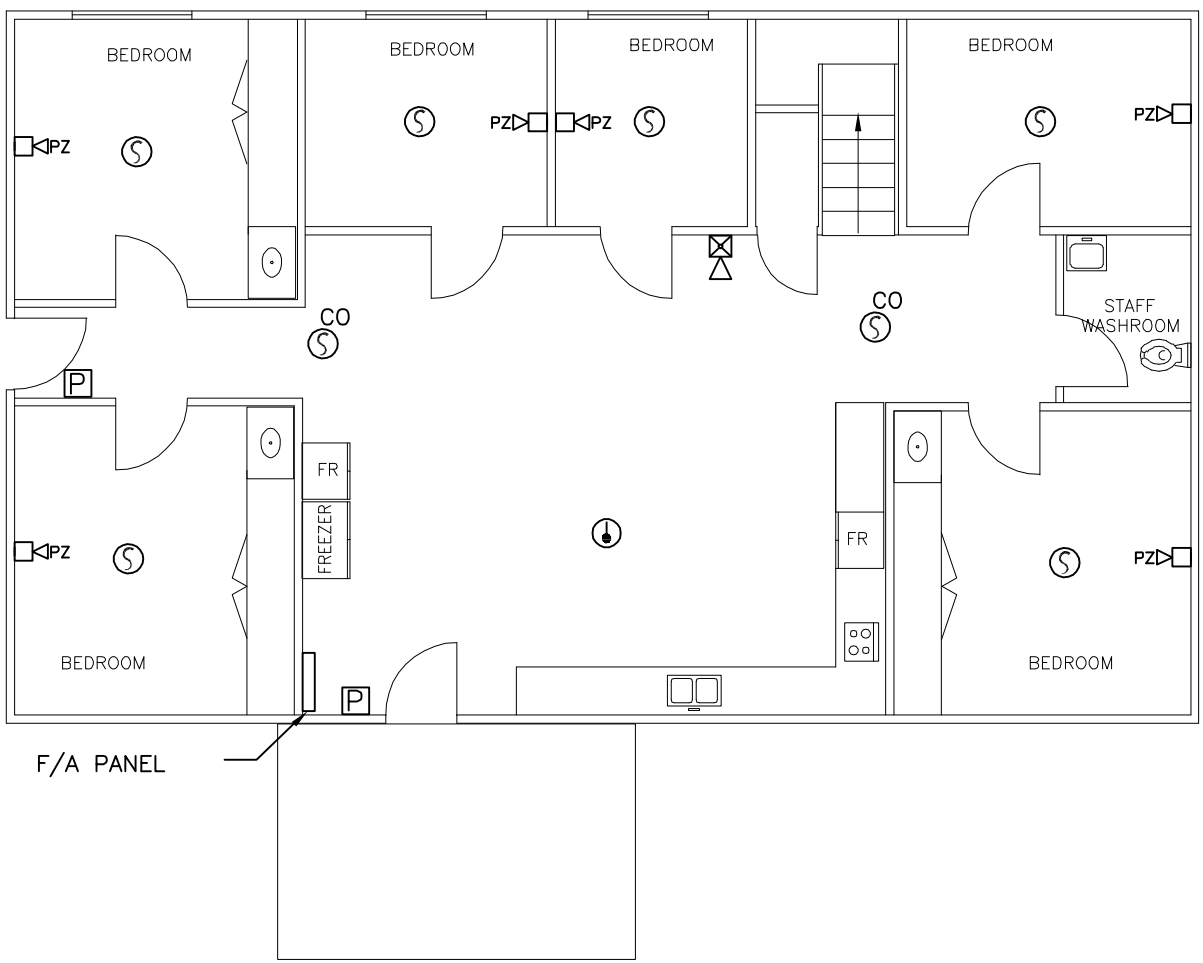

4 UNIT 5-MAIN FLOOR-RENOVATION-FIRE ALARM SYSTEM
E-8 SCALE: 1/8"=1'-0"



04		
03		
02	ISSUED FOR TENDER	2018.01.22
01	ISSUED FOR REVIEW	2017.12.15
revision		date

Do not scale drawings.
Verify all dimensions and conditions on site and immediately
notify the Departmental Representative of all discrepancies.

A B C	A Detail No.
	B drawing no. - where detail required dessin no. - où détail exigé
	C drawing no. - where detailed dessin no. - où détaillé

project title
titre du projet
INAC-PELICAN FALLS Ontario
PUBLIC SERVICES
AND PROCUREMENT CANADA

RESIDENCES & STAFF HOUSE
FIRE ALARM UPGRADE

drawing title
titre du dessin
UNITS 4,5
BASEMENT AND MAIN FLOOR
RENOVATION-FIRE ALARM SYSTEM

drawn by
dessiné par T. SHTERENBERG

designed by
conçu par E. SAPACZ


approved by
approuvé par L. KORENBAUM

bid
offre project manager
administrateur
de projets


project date
date du projet 2018-01-17

project no.
no. du projet R.087721.001


drawing no.
dessiné no. E-8

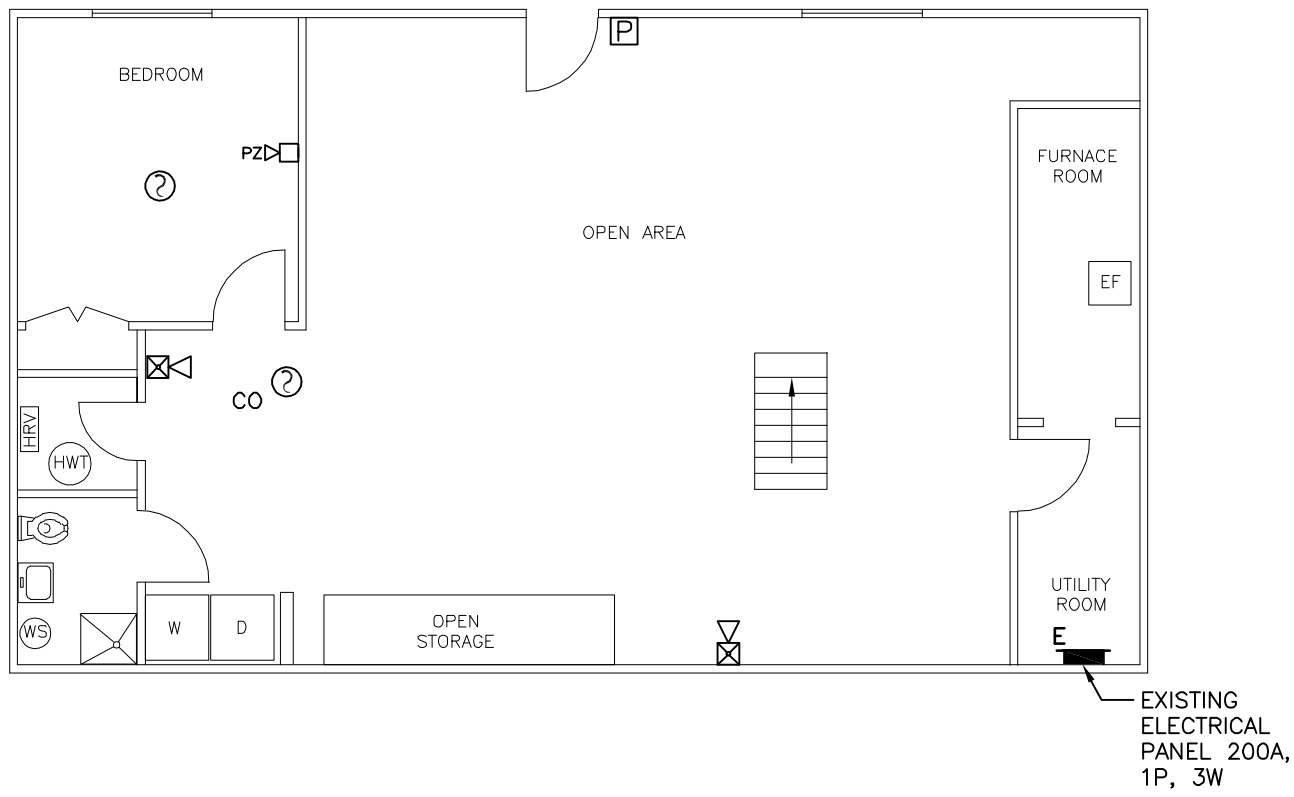


1 UNIT 6-BASEMENT-RENOVATION-FIRE ALARM SYSTEM
E-9 SCALE: 1/8"=1'-0"

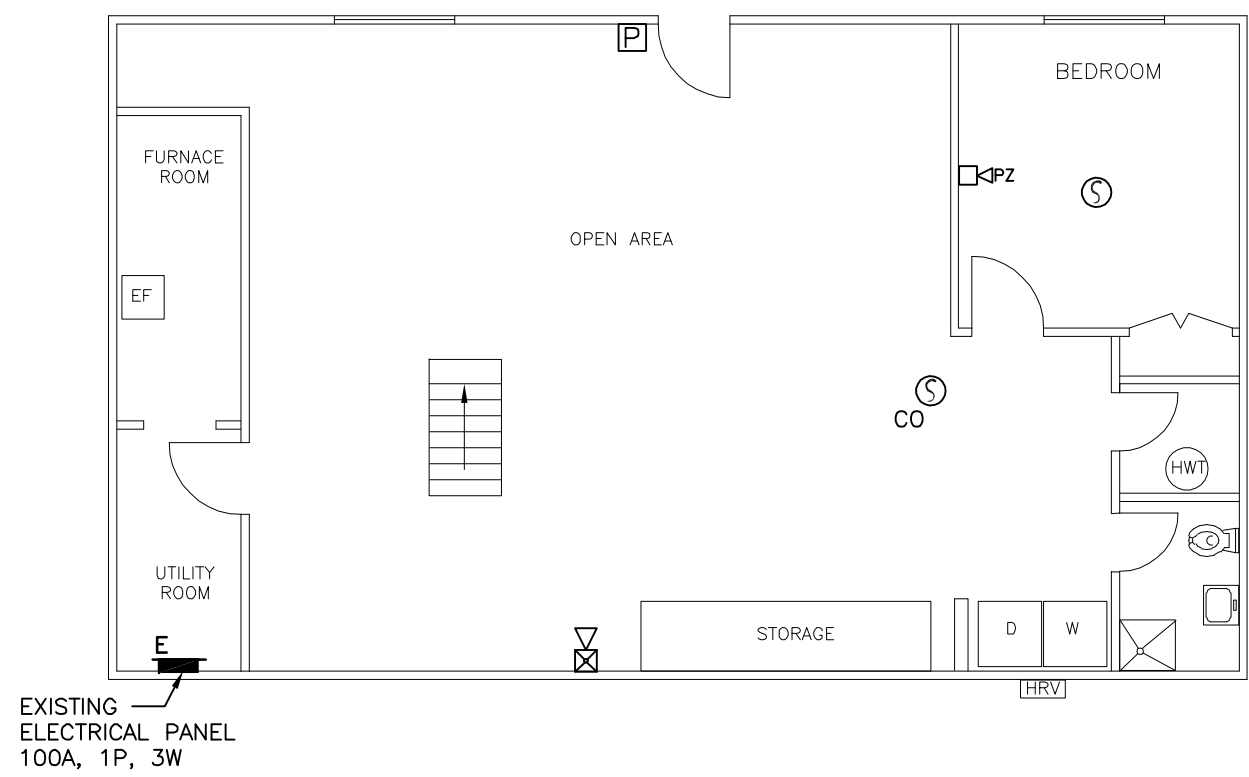

3 UNIT 7-BASEMENT-RENOVATION-FIRE ALARM SYSTEM
E-9 SCALE: 1/8"=1'-0"

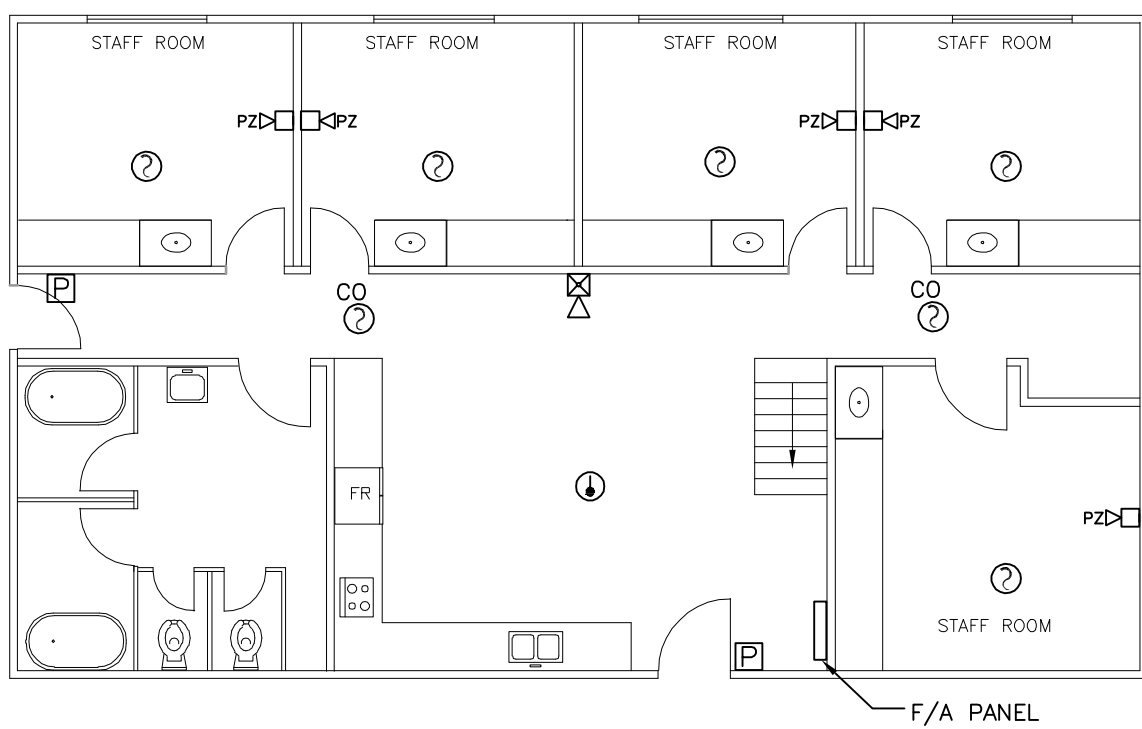

2 UNIT 6-MAIN FLOOR-RENOVATION-FIRE ALARM SYSTEM
E-9 SCALE: 1/8"=1'-0"

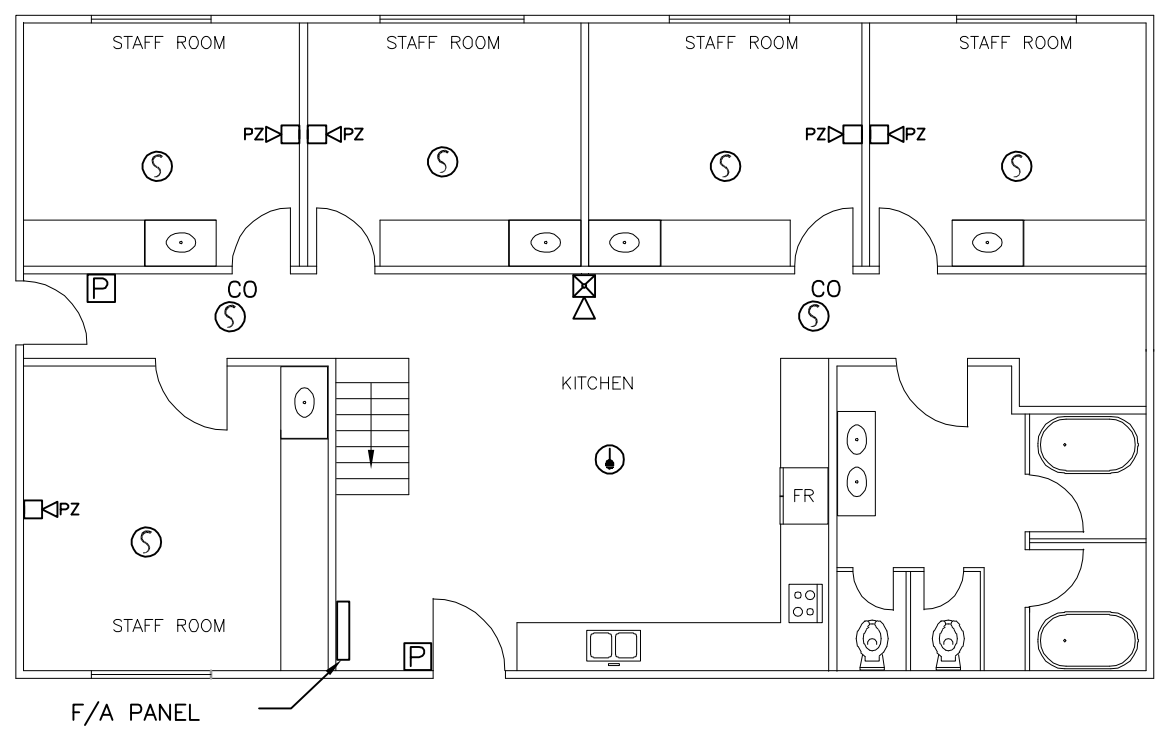

4 UNIT 7-MAIN FLOOR-RENOVATION-FIRE ALARM SYSTEM
E-9 SCALE: 1/8"=1'-0"



04		
03		
02	ISSUED FOR TENDER	2018.01.22
01	ISSUED FOR REVIEW	2017.12.15
revision		date

Do not scale drawings.
Verify all dimensions and conditions on site and immediately
notify the Departmental Representative of all discrepancies.

A	Detail No.
B	drawing no. - where detail required
C	drawing no. - where detailed

project title
titre du projet
INAC-PELICAN FALLS Ontario
PUBLIC SERVICES
AND PROCUREMENT CANADA

RESIDENCES & STAFF HOUSE
FIRE ALARM UPGRADE

drawing title
titre du dessin
UNITS 6,7
BASEMENT AND MAIN FLOOR
RENOVATION-FIRE ALARM SYSTEM

drawn by
dessiné par T. SHTERENBERG

designed by
conçu par E. SAPACZ


approved by
approuvé par L. KORENBAUM

bid
offre project manager
administrateur
de projets


project date
date du projet 2018-01-17

project no.
no. du projet R.087721.001


drawing no.
dessiné no. E-9

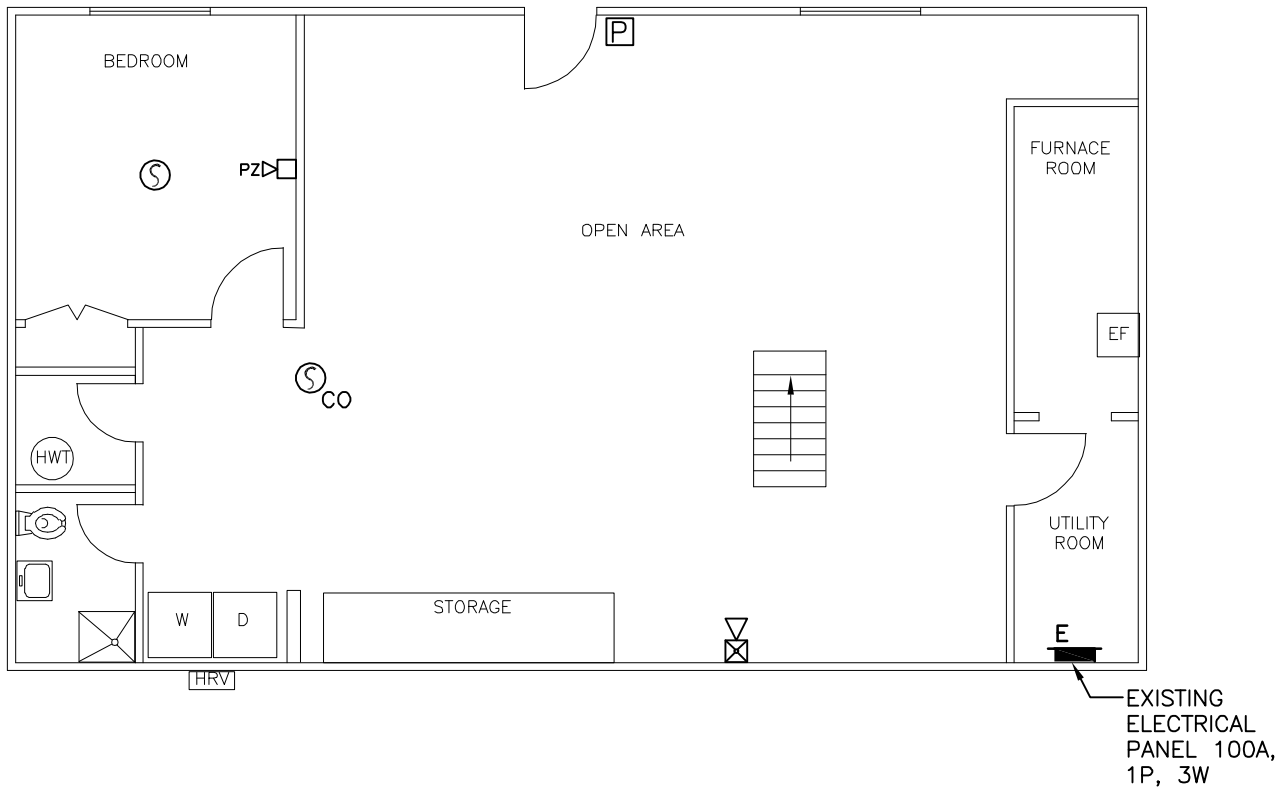


1 UNIT 8-BASEMENT-RENOVATION-FIRE ALARM SYSTEM
E-10 SCALE: 1/8"=1'-0"

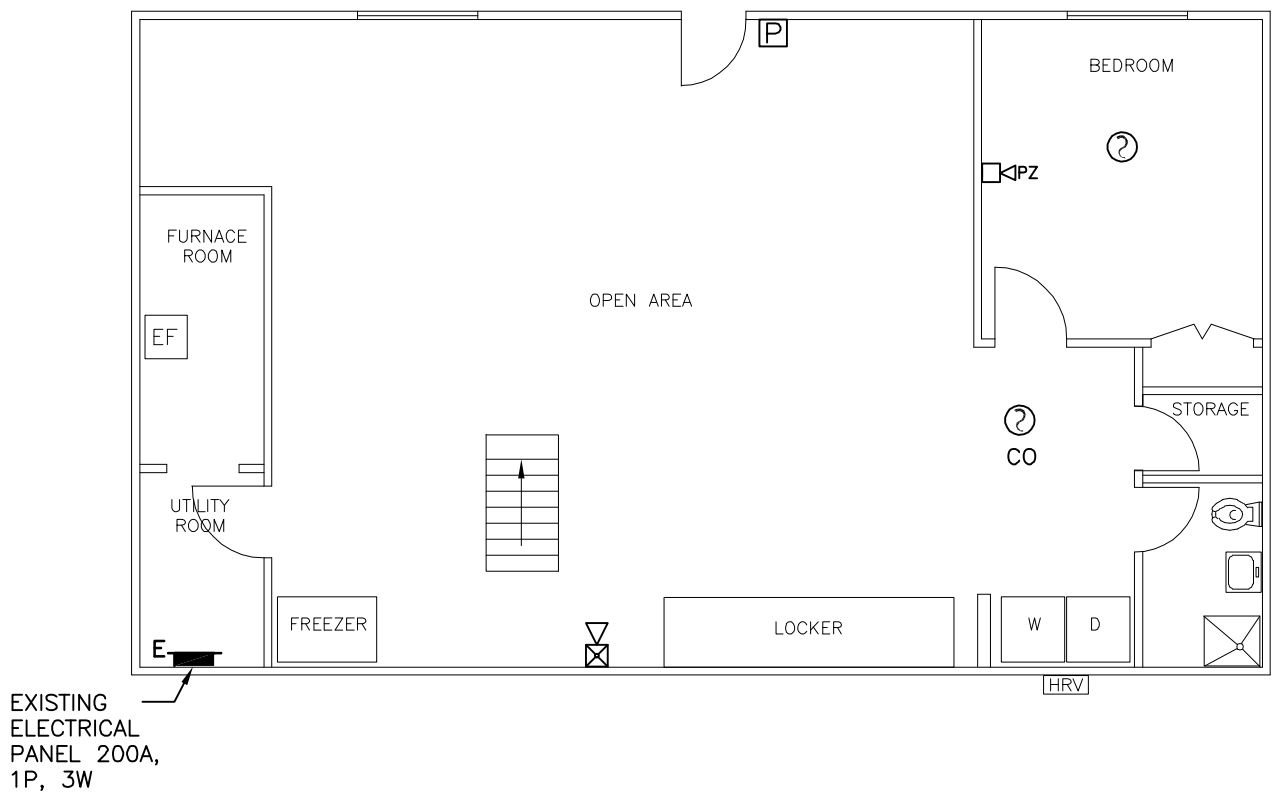

3 UNIT 9-BASEMENT-RENOVATION-FIRE ALARM SYSTEM
E-10 SCALE: 1/8"=1'-0"

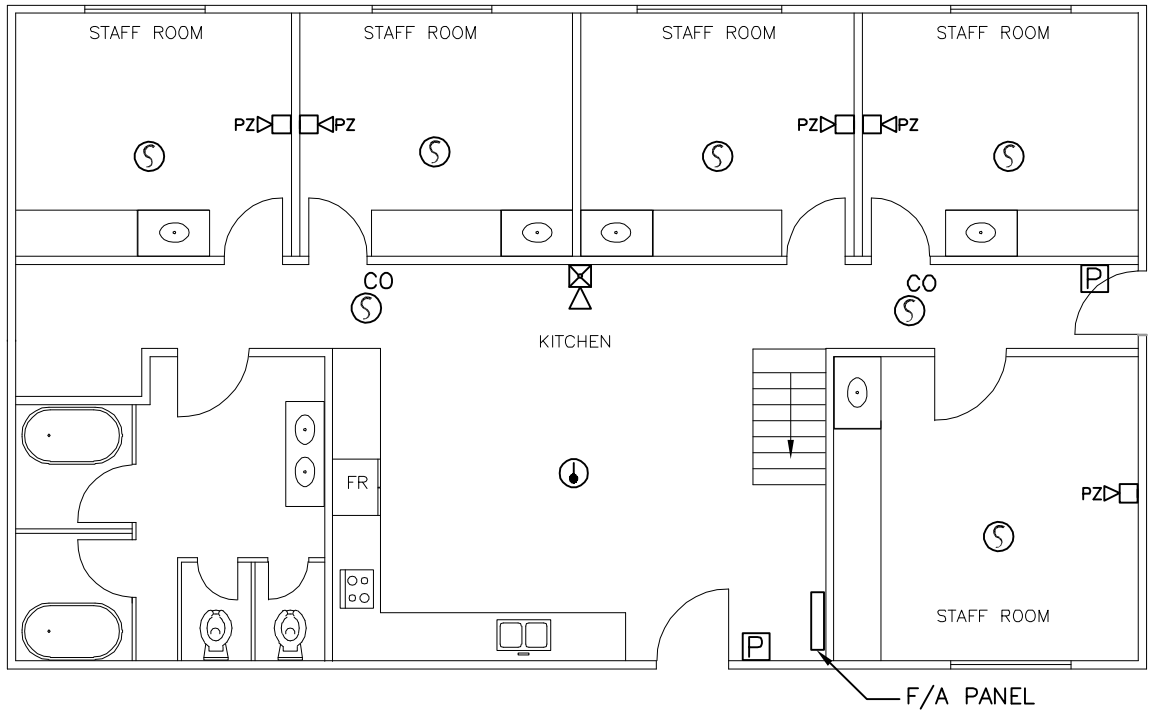

2 UNIT 8-MAIN FLOOR-RENOVATION-FIRE ALARM SYSTEM
E-10 SCALE: 1/8"=1'-0"

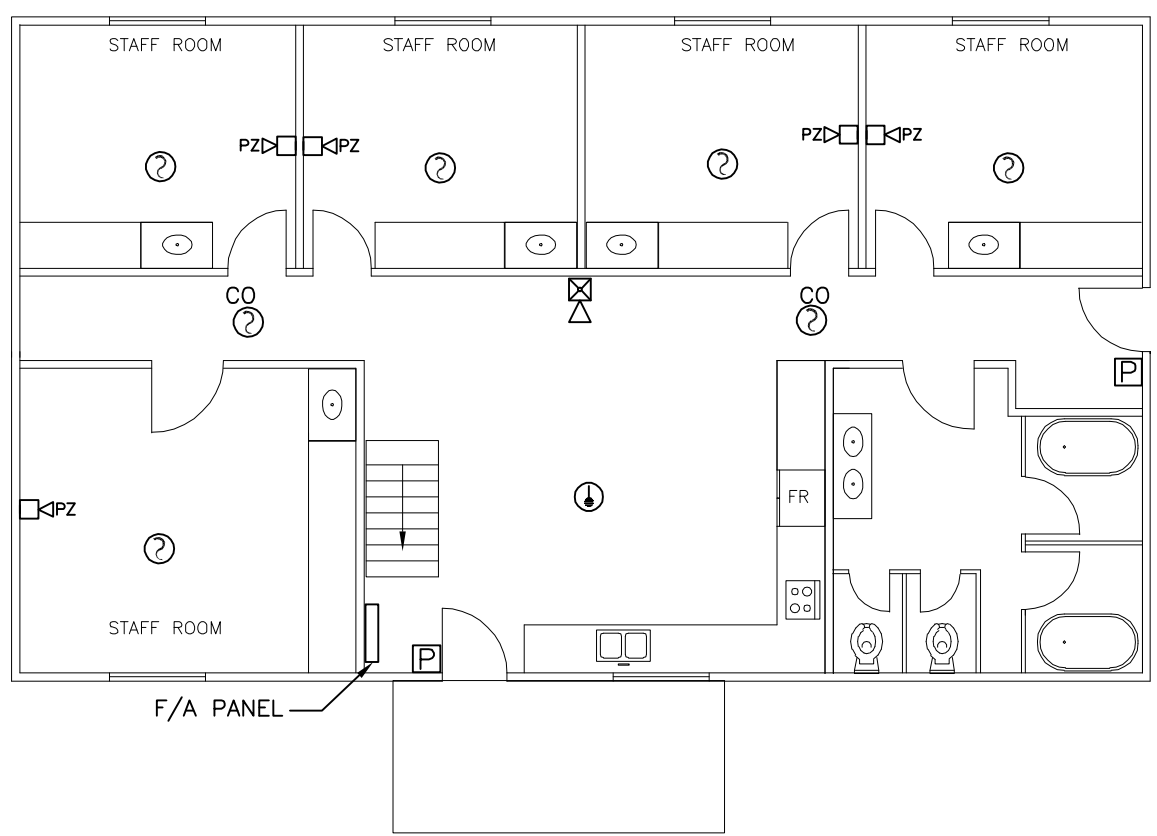

4 UNIT 9-MAIN FLOOR-RENOVATION-FIRE ALARM SYSTEM
E-10 SCALE: 1/8"=1'-0"



04		
03		
02	ISSUED FOR TENDER	2018.01.22
01	ISSUED FOR REVIEW	2017.12.15
revision		date

Do not scale drawings.
Verify all dimensions and conditions on site and immediately
notify the Departmental Representative of all discrepancies.

A	Detail No.
B	drawing no. - where detail required
C	drawing no. - where detailed

project title
titre du projet
INAC-PELICAN FALLS Ontario
PUBLIC SERVICES
AND PROCUREMENT CANADA

RESIDENCES & STAFF HOUSE
FIRE ALARM UPGRADE

drawing title
titre du dessin
UNITS 8,9
BASEMENT AND MAIN FLOOR
RENOVATION-FIRE ALARM SYSTEM

drawn by
dessiné par T. SHTERENBERG

designed by
conçu par E. SAPACZ


approved by
approuvé par L. KORENBAUM

bid
offre project manager
administrateur de projets


project date
date du projet 2018-01-17

project no.
no. du projet R.087721.001


drawing no.
dessiné no. E-10

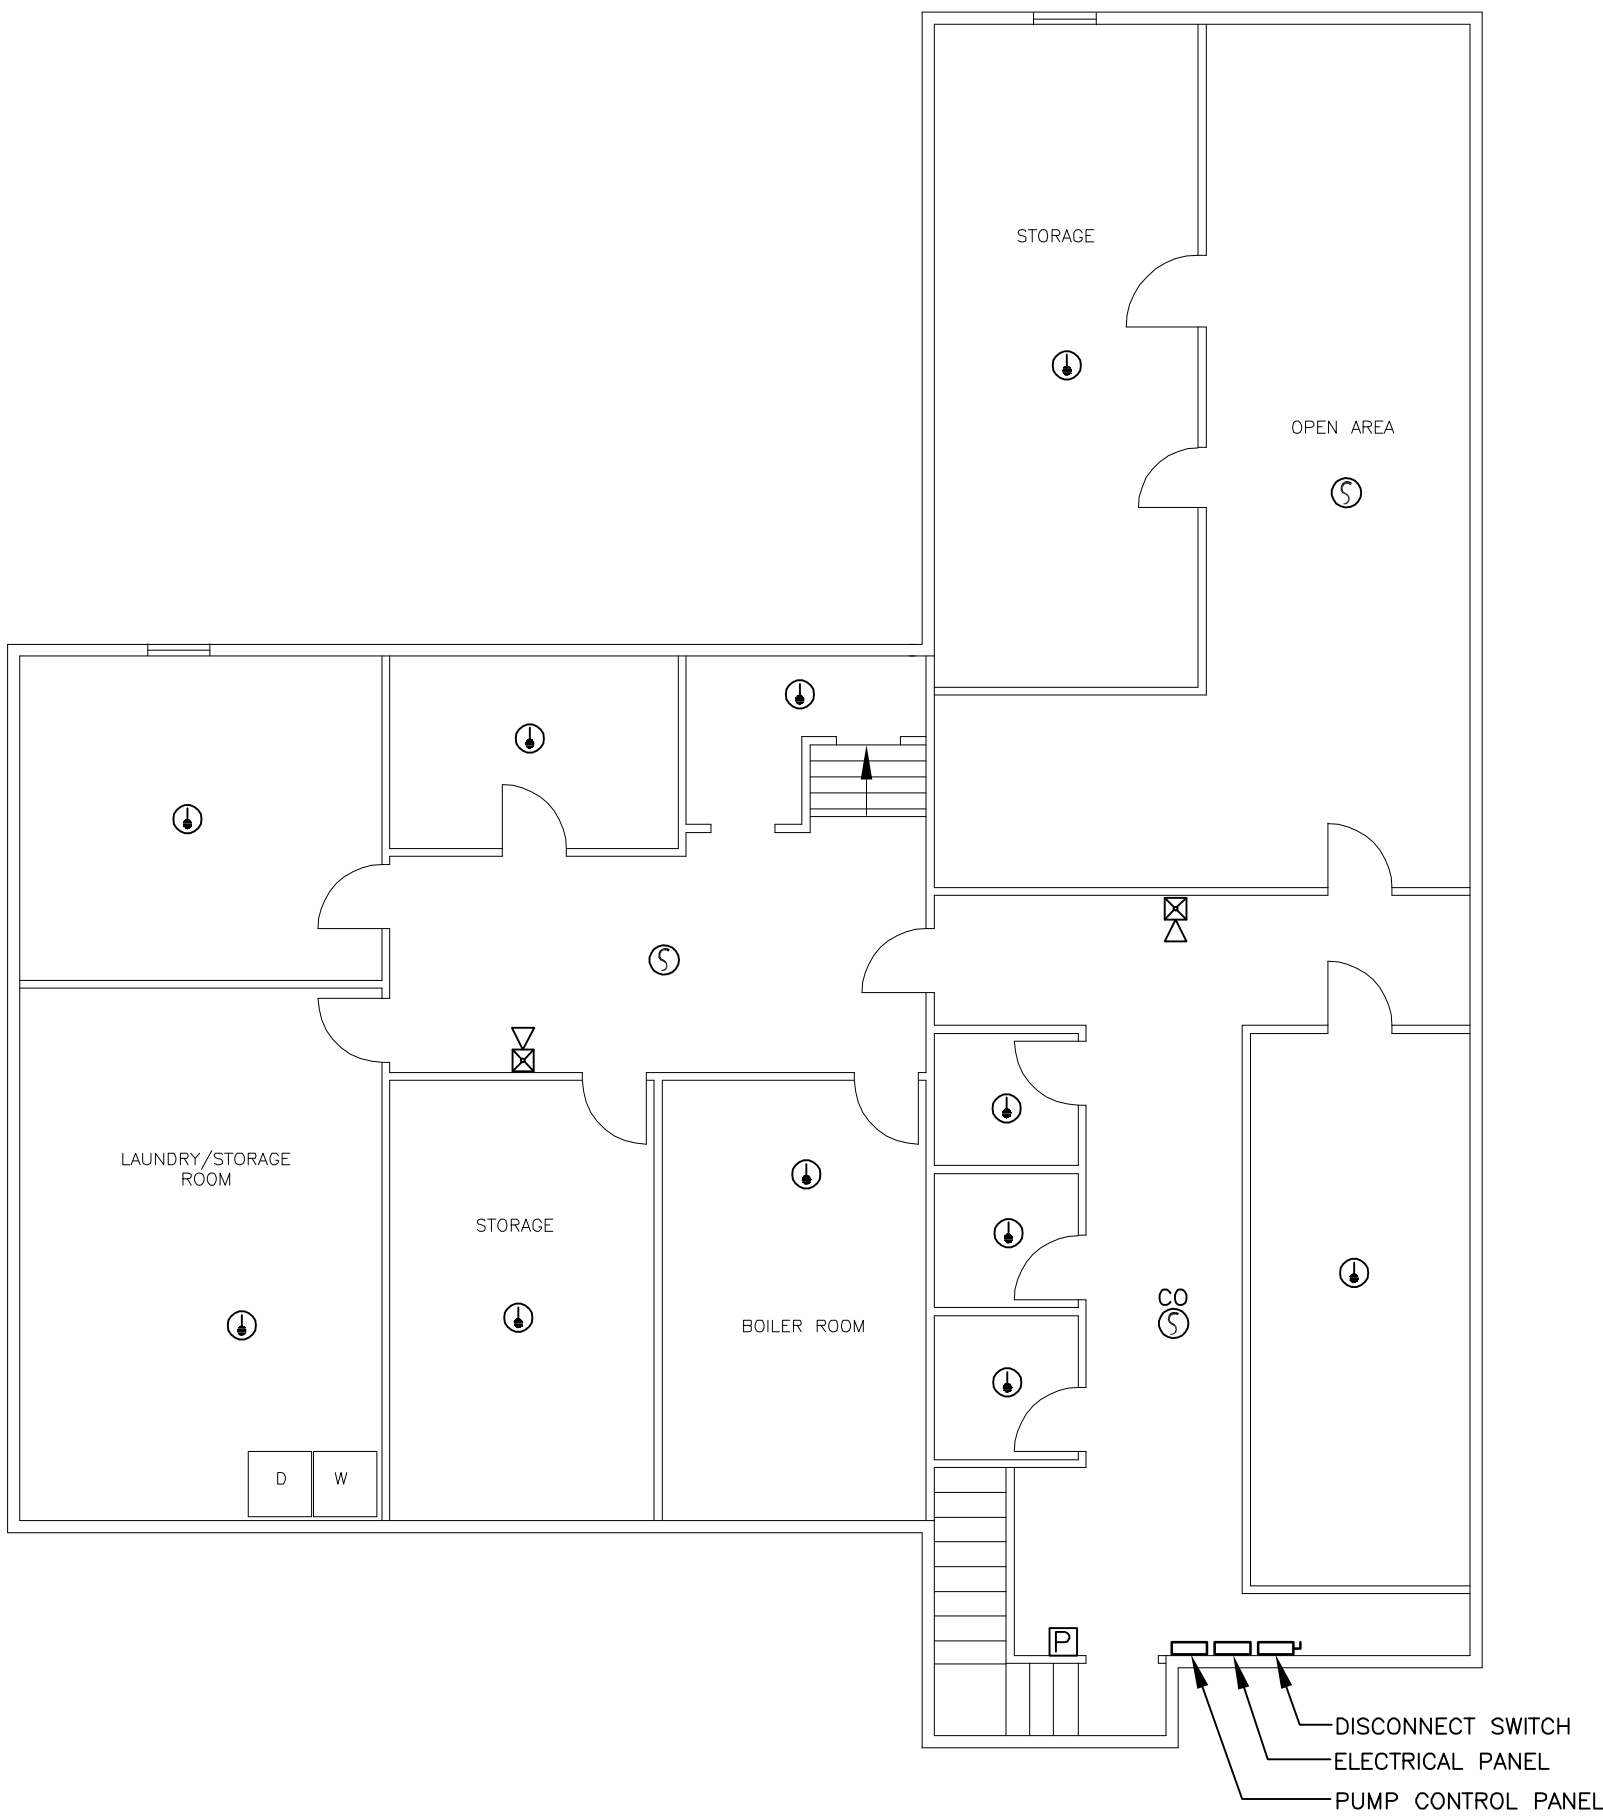


1 UNIT 3-BASEMENT-RENOVATION-FIRE ALARM SYSTEM
E-11 SCALE: 1/8"=1'-0"

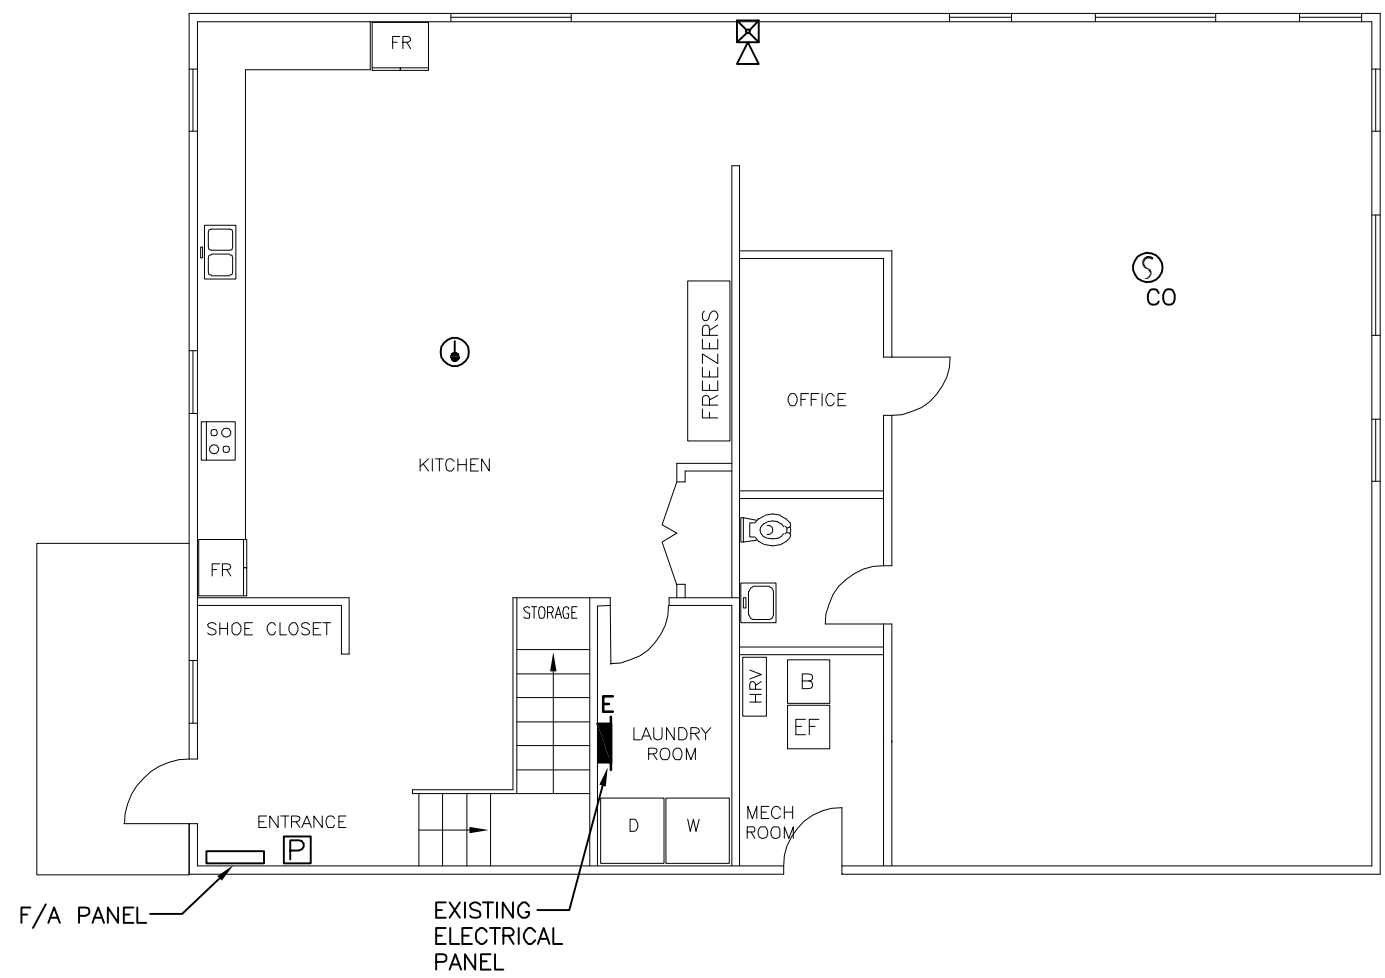

3 UNITS 11-14 (TYPICAL)-MAIN FLOOR-RENOVATION-FIRE ALARM SYSTEM
E-11 SCALE: 1/8"=1'-0"

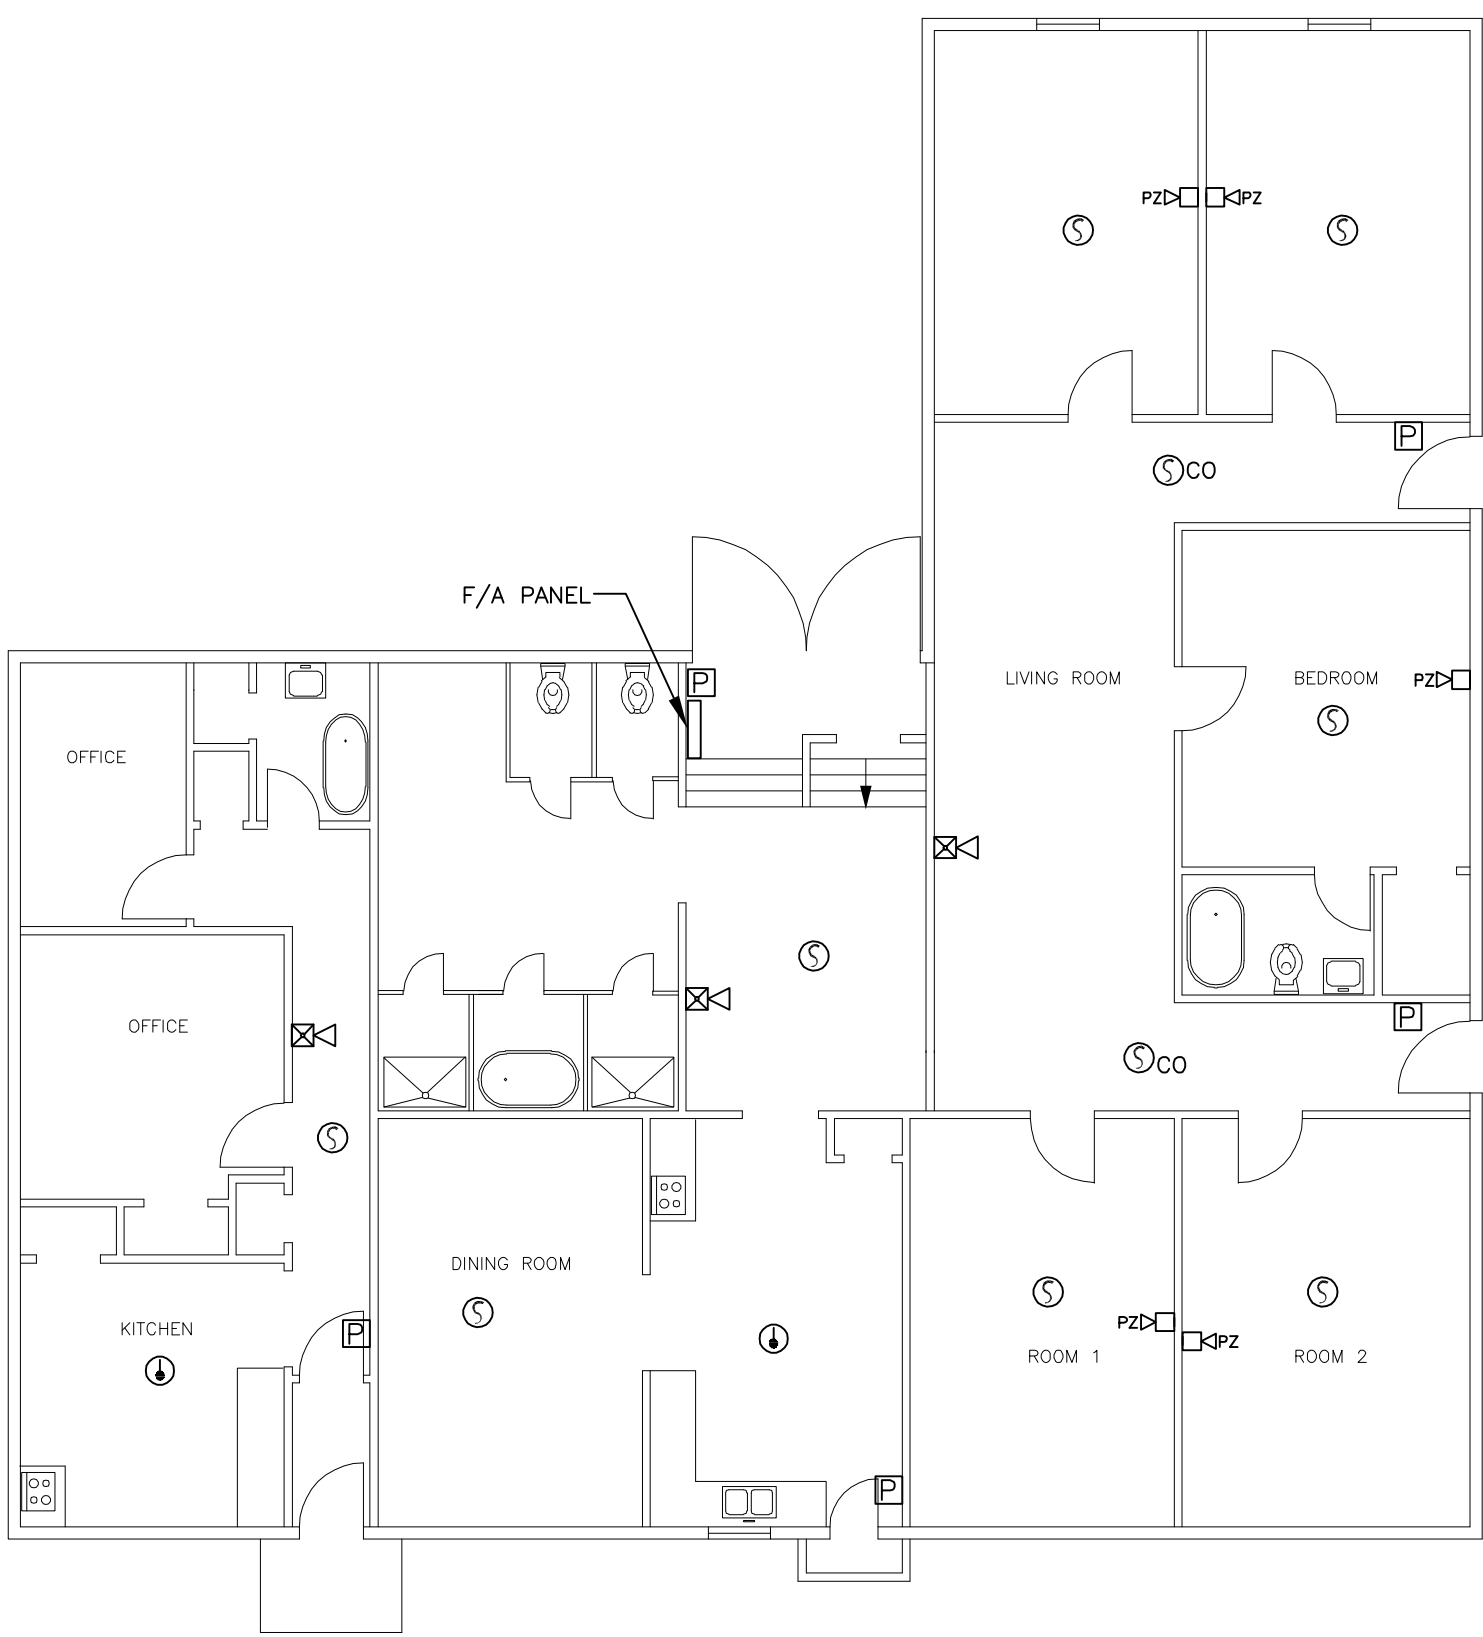

2 UNIT 3-MAIN FLOOR-RENOVATION-FIRE ALARM SYSTEM
E-11 SCALE: 1/8"=1'-0"

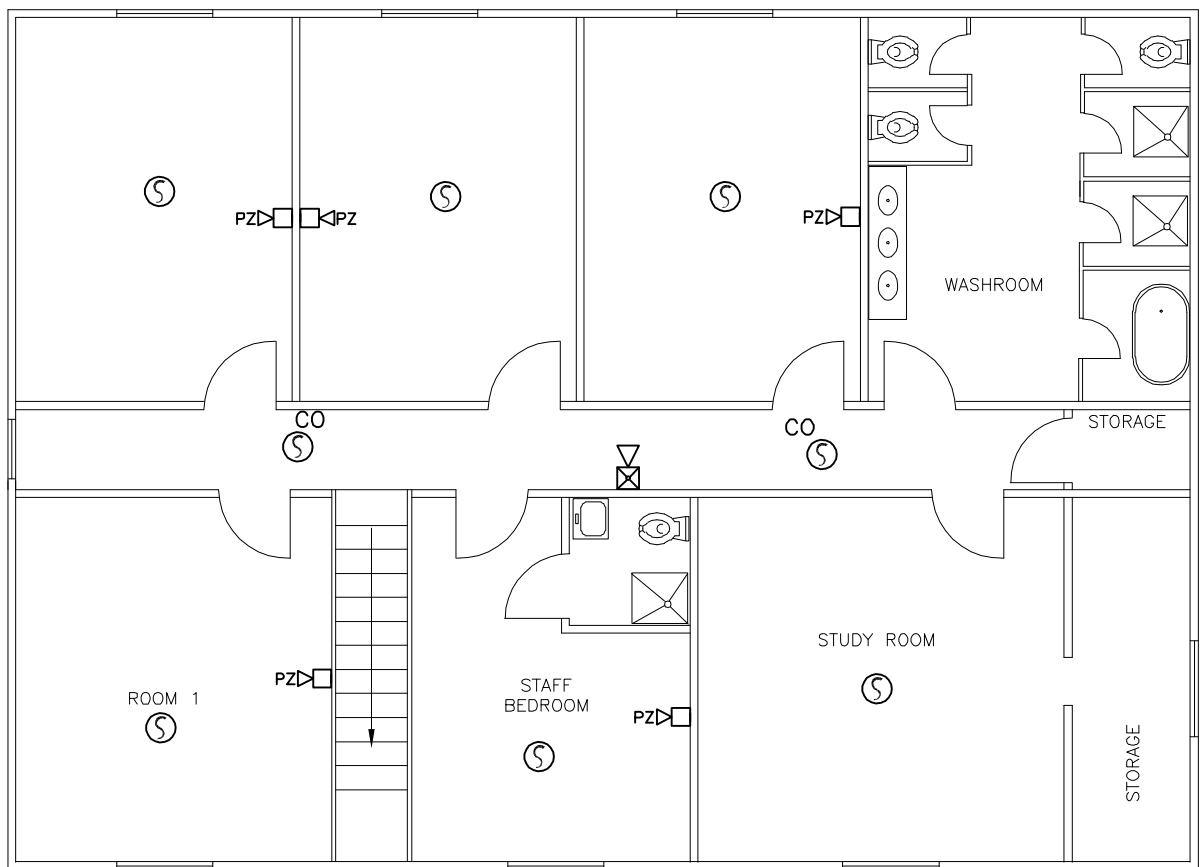

4 UNITS 11-14 (TYPICAL)-SECOND FLOOR-RENOVATION-FIRE ALARM SYSTEM
E-11 SCALE: 1/8"=1'-0"



04		
03		
02	ISSUED FOR TENDER	2018.01.22
01	ISSUED FOR REVIEW	2017.12.15
revision		date

Do not scale drawings.
Verify all dimensions and conditions on site and immediately
notify the Departmental Representative of all discrepancies.

A	Detail No.
B	No. du détail
C	drawing no. - where detail required dessin no. - où détail exigé
	drawing no. - where detailed dessin no. - où détaillé

project title
titre du projet
INAC-PELICAN FALLS Ontario
PUBLIC SERVICES
AND PROCUREMENT CANADA

RESIDENCES & STAFF HOUSE
FIRE ALARM UPGRADE

drawing title
titre du dessin
UNIT 3, UNITS 11-14 (TYPICAL)
RENOVATION-FIRE ALARM SYSTEM

drawn by
dessiné par T. SHTERENBERG

designed by
conçu par E. SAPACZ

approved by
approuvé par L. KORENBAUM

bid
offre project manager
administrateur de projets

project date
date du projet 2018-01-17

project no.
no. du projet R.087721.001

drawing no.
dessiné no. E-11