



**RETURN BIDS TO:**

**RETOURNER LES SOUMISSIONS À:**

**Bid Receiving Public Works & Government Services  
Canada/Réception des soumissions Travaux publics et  
Services gouvernementaux Canada**

**1713 Bedford Row**

**Halifax, N.S./Halifax, (N.E.)**

**Halifax**

**Nova Scotia**

**B3J 1T3**

**Bid Fax: (902) 496-5016**

**SOLICITATION AMENDMENT  
MODIFICATION DE L'INVITATION**

The referenced document is hereby revised; unless otherwise indicated, all other terms and conditions of the Solicitation remain the same.

Ce document est par la présente révisé; sauf indication contraire, les modalités de l'invitation demeurent les mêmes.

**Comments - Commentaires**

**Vendor/Firm Name and Address**

**Raison sociale et adresse du  
fournisseur/de l'entrepreneur**

**Issuing Office - Bureau de distribution**

**Atlantic Region Acquisitions/Région de l'Atlantique  
Acquisitions**

**1713 Bedford Row**

**Halifax, N.S./Halifax, (N.E.)**

**Halifax**

**Nova Scot**

**B3J 1T3**

<b>Title - Sujet</b> CCG WP 2.0 Construction	
<b>Solicitation No. - N° de l'invitation</b> EB144-182527/A	<b>Amendment No. - N° modif.</b> 001
<b>Client Reference No. - N° de référence du client</b> EB144-18-2527	<b>Date</b> 2018-02-14
<b>GETS Reference No. - N° de référence de SEAG</b> PW-\$PWA-405-5718	
<b>File No. - N° de dossier</b> PWA-7-78131 (405)	<b>CCC No./N° CCC - FMS No./N° VME</b>
<b>Solicitation Closes - L'invitation prend fin at - à 02:00 PM on - le 2018-02-27</b>	<b>Time Zone</b> <b>Fuseau horaire</b> Atlantic Standard Time AST
<b>F.O.B. - F.A.B.</b> <b>Plant-Usine:</b> <input type="checkbox"/> <b>Destination:</b> <input checked="" type="checkbox"/> <b>Other-Autre:</b> <input type="checkbox"/>	
<b>Address Enquiries to: - Adresser toutes questions à:</b> Kendell (PWA), Byron	<b>Buyer Id - Id de l'acheteur</b> pwa405
<b>Telephone No. - N° de téléphone</b> (902) 402-9436 ( )	<b>FAX No. - N° de FAX</b> (902) 496-5016
<b>Destination - of Goods, Services, and Construction:</b> <b>Destination - des biens, services et construction:</b>	

**Instructions: See Herein**

**Instructions: Voir aux présentes**

<b>Delivery Required - Livraison exigée</b>	<b>Delivery Offered - Livraison proposée</b>
<b>Vendor/Firm Name and Address</b> <b>Raison sociale et adresse du fournisseur/de l'entrepreneur</b>	
<b>Telephone No. - N° de téléphone</b> <b>Facsimile No. - N° de télécopieur</b>	
<b>Name and title of person authorized to sign on behalf of Vendor/Firm (type or print)</b> <b>Nom et titre de la personne autorisée à signer au nom du fournisseur/ de l'entrepreneur (taper ou écrire en caractères d'imprimerie)</b>	
<b>Signature</b>	<b>Date</b>

Solicitation No. - N° de l'invitation  
EB144-182527

Amd. No. - N° de la modif.  
001

Buyer ID - Id de l'acheteur  
PWA405

Client Ref. No. - N° de réf. du client

File No. - N° du dossier

CCC No./N° CCC - FMS No./N° VME

---

**Amendment 001 is raised for the following:**


Revised Level 300 layout as per attached sketches.

***All other terms and conditions remain the same.***

Move Cubicle 14 here.

Shift storage room down to this space.


C

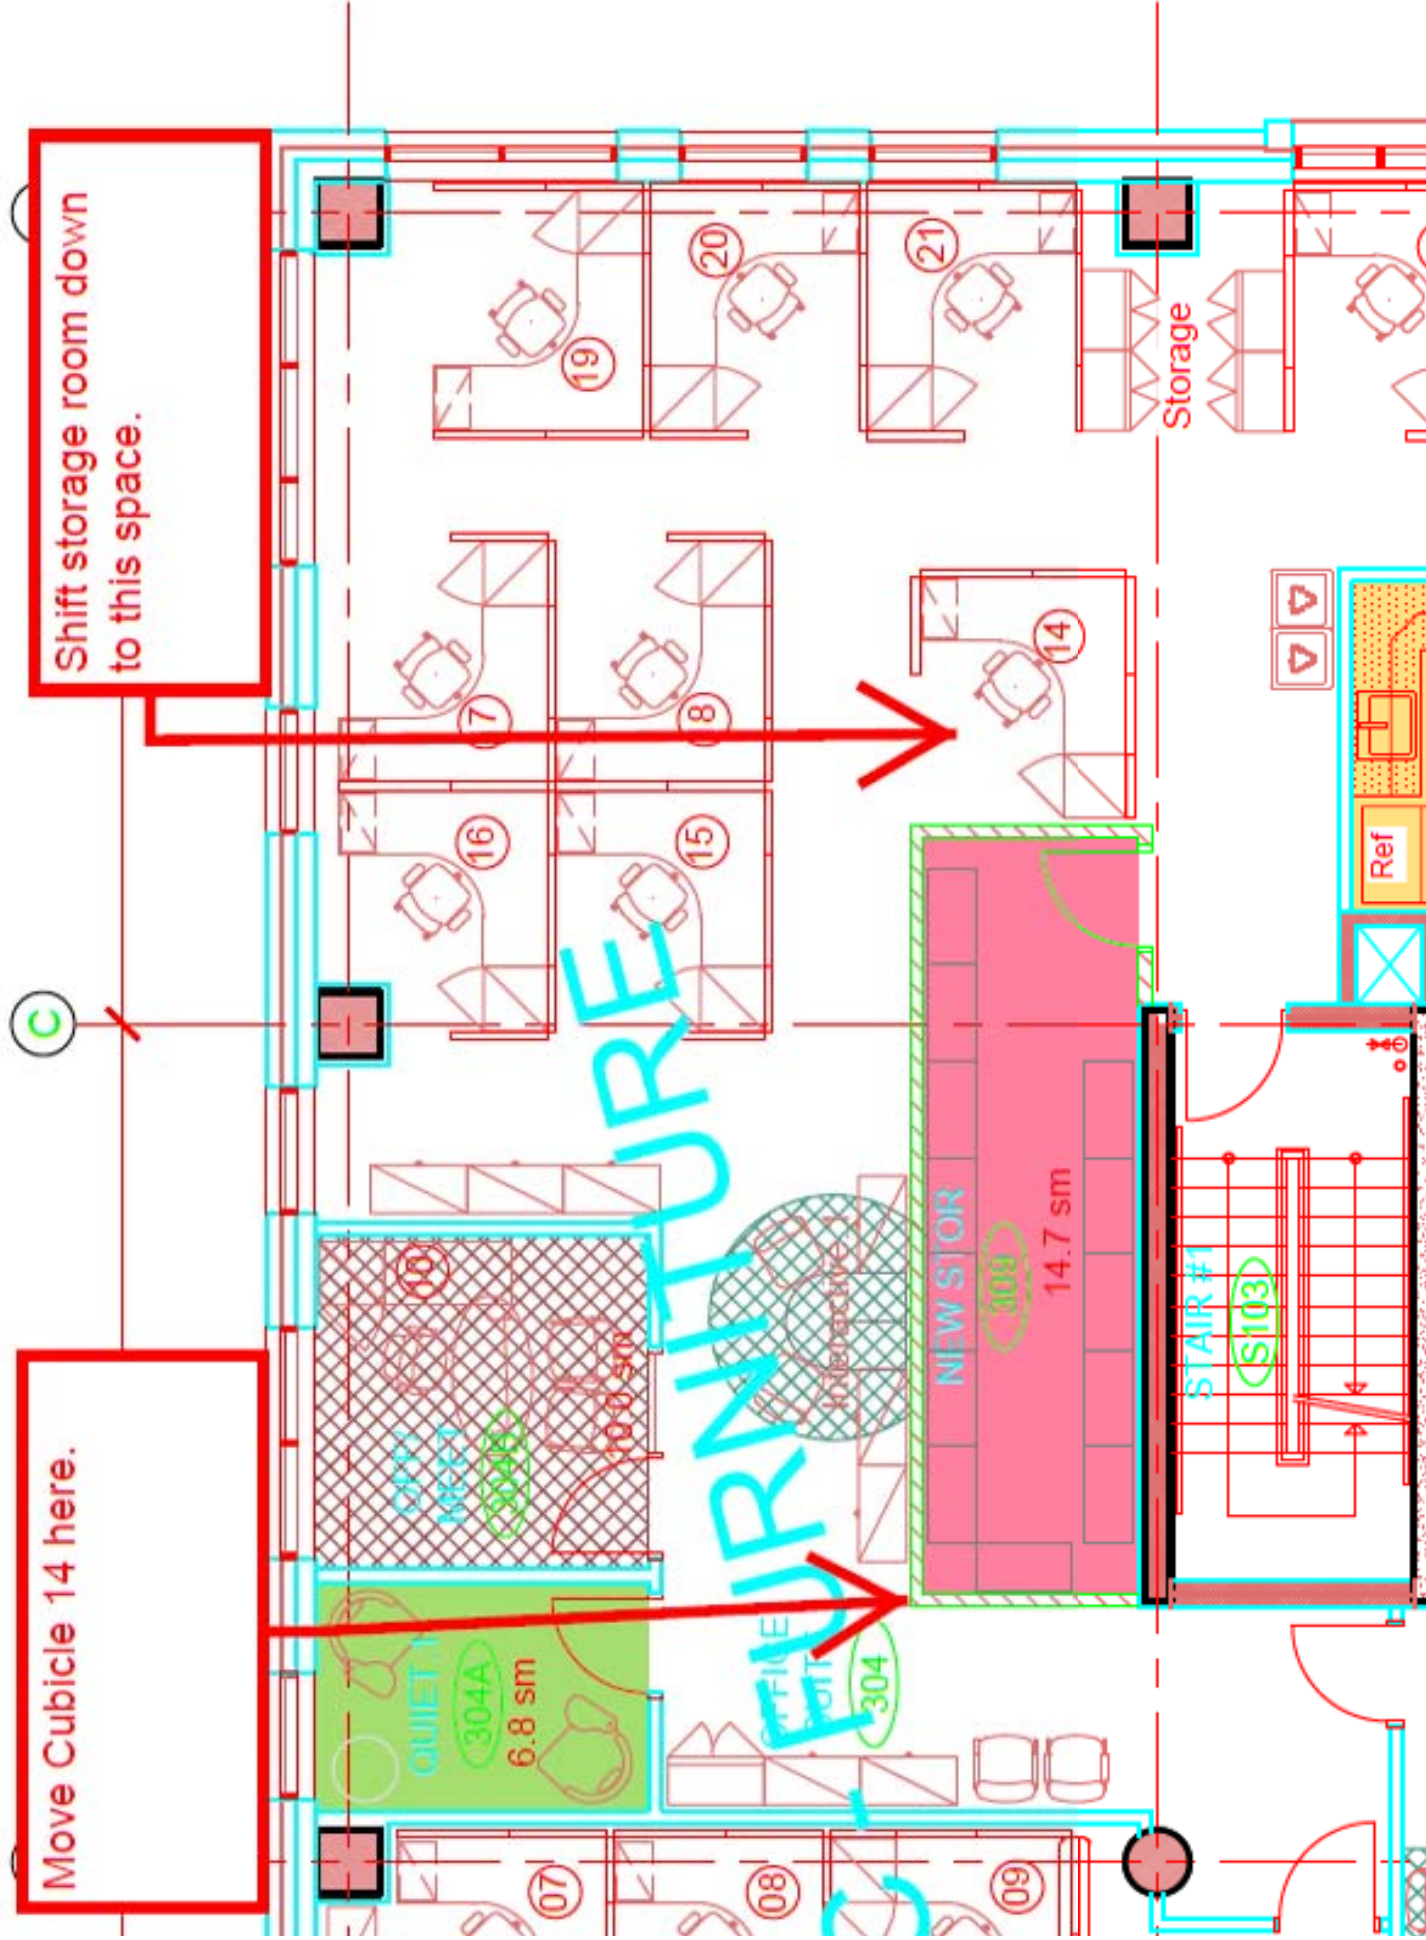


**NOTE TO FURNITURE:**

A) WORKSTATIONS # 11, 12 AND 13 ON LEVEL 300 AT GRID LINE C2 ARE TO BE DISMANTLED AND STORED IN A SECURE PLACE. WORKSTATIONS ARE TO BE REASSEMBLED. FINAL FLOOR/POSITION TO BE DETERMINED.

B) WORKSTATION #11 IS TO BE DISMANTLED AND STORED IN A SECURE PLACE DURING CONSTRUCTION OF THE NEW 308 STORAGE ROOM. ONCE THE LEASEHOLDS ARE COMPLETE THE WORKSTATION IS TO BE REASSEMBLED IN THE SAME LOCATION BY THE FURNITURE INSTALLER.

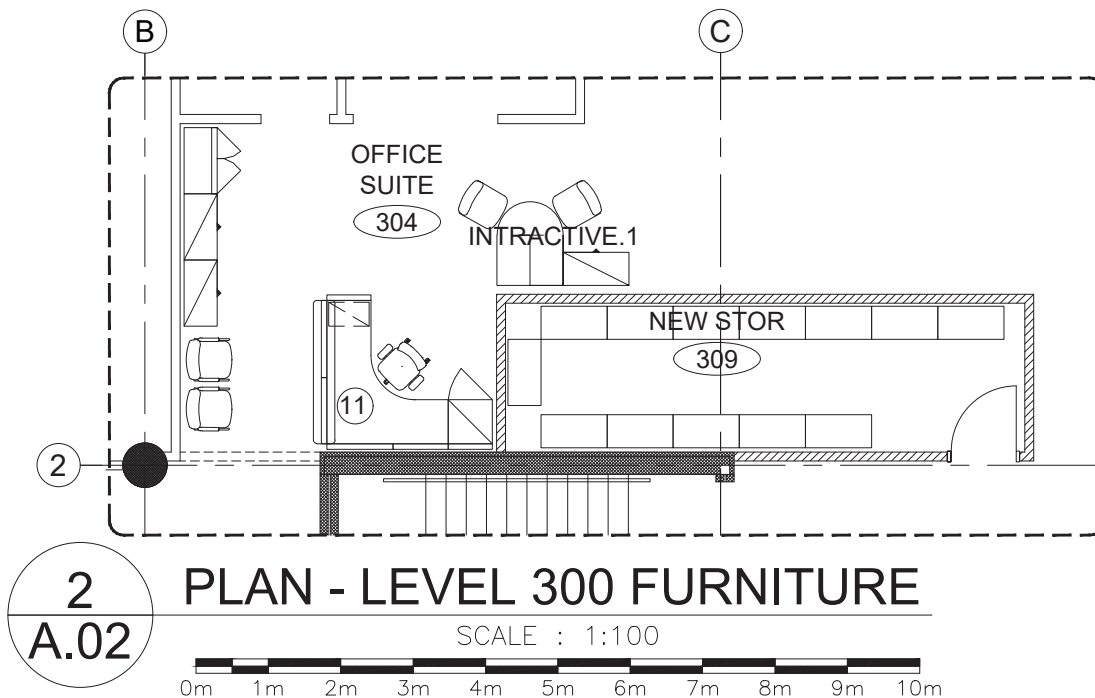



	Public Works and Government Services Canada	Travaux publics et Services gouvernementaux Canada	Drawing title  ADDENDUM # 1 LEVEL 300 FURNITURE PLAN		designed KAD		conçu		date FEB.13.2018		
project CCG WP2.0 FIT-UP MARITIME HEADQUARTERS BEDFORD INSTITUTE OF OCEANOGRAPHY DARTMOUTH, N.S.			projet			drawn		dessiné		date	
						approved		approuvé		date	
			Tender IAN SCELES PWGSC Project Manager			Soumission					
						Administrateur de projets TPSGC					
project number			no. du projet			drawing no.		no. du dessin			
R.082156.001						ASK.1A					

**NOTE TO PARTITION:**

RELOCATE NEW STORAGE ROOM 2463mm  
EASTWARD AS INDICATED.

EAST WALL TO ALIGNED WITH EAST CORRIDOR  
WALLS DEFINING SERVERY AND NEW MEETING  
ROOMS.

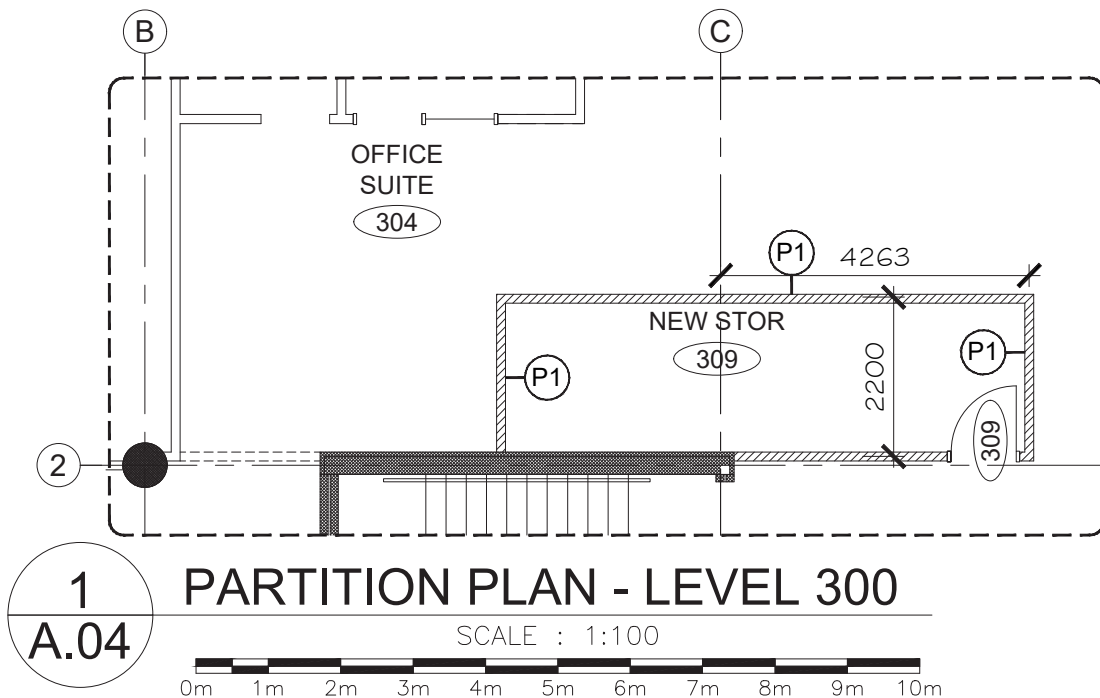



 Public Works and Government Services Canada	Travaux publics et Services gouvernementaux Canada	Drawing title Titre du dessin  ADDENDUM # 1 LEVEL 300 PARTITION PLAN	designed KAD	conçu 	date FEB.13.2018
			drawn 	dessiné 	date 
project CCG WP2.0 FIT-UP MARITIME HEADQUARTERS BEDFORD INSTITUTE OF OCEANOGRAPHY DARTMOUTH, N.S.	projet 	Tender IAN SCELES PWGSC Project Manager	approved 	approuvé 	date 
			project number R.082156.001	no. du projet 	Soumission Administrateur de projets TPSGC drawing no. ASK.1B no. du dessin


NOTE TO REFLECTED CEILING:

RELOCATE / REUSE LUMINAIRES AFFECTED BY THE  
RELOCATION OF THE NEW STORAGE ROOM  
EASTWARD.

REFER TO ELECTRICAL DRAWINGS FOR SPECIFICS.

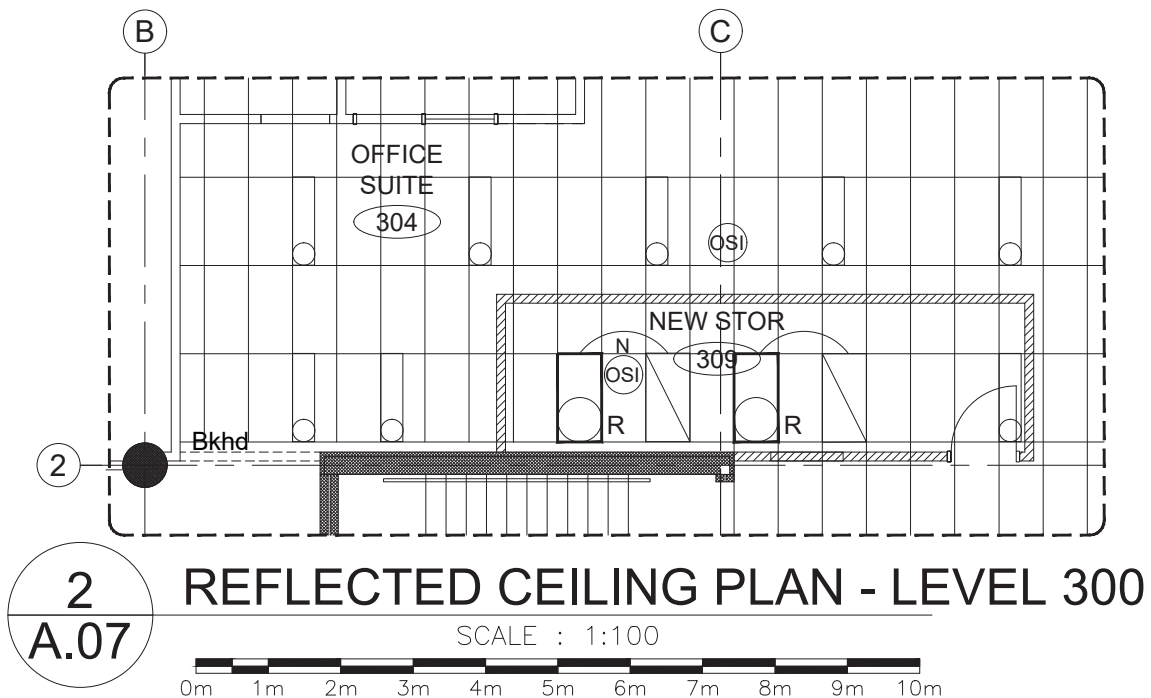

 <div>Public Works and Government Services Canada</div>	<div>Travaux publics et Services gouvernementaux Canada</div>	Drawing title		Titre du dessin		designed KAD	conçu	date FEB.13.2018	
		ADDENDUM # 1 LEVEL 300 REFLECTED CEILING				drawn	dessiné	date	
						approved	approuvé	date	
						Tender IAN SCELES PWGSC Project Manager			
project		project	project number		no. du projet		drawing no.	no. du dessin	
CCG WP2.0 FIT-UP MARITIME HEADQUARTERS BEDFORD INSTITUTE OF OCEANOGRAPHY DARTMOUTH, N.S.			R.082156.001				ASK.1C		

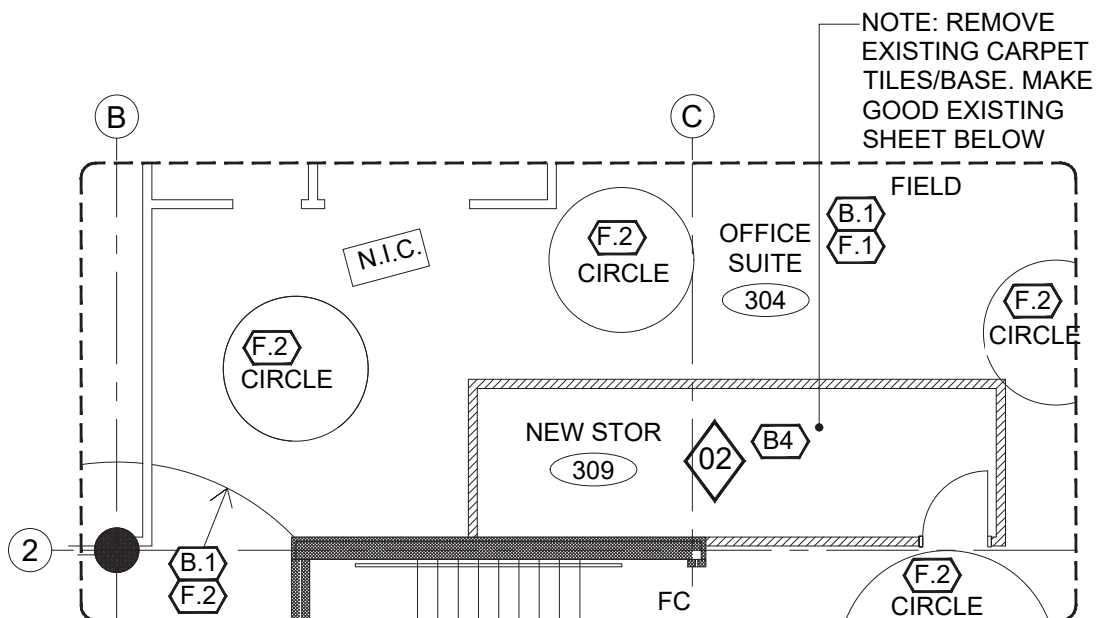

2  
A.11

## PLAN - FLOOR FINISH LEVEL 300

SCALE : 1:100



Public Works and  
Government Services  
Canada

Travaux publics et  
Services gouvernementaux  
Canada

project

CCG WP2.0 FIT-UP  
MARITIME HEADQUARTERS  
BEDFORD INSTITUTE OF OCEANOGRAPHY  
DARTMOUTH, N.S.

projet

Drawing title

Titre du dessin

ADDENDUM # 1  
LEVEL 300  
FLOOR FINISH PLAN

designed

conçu

date

KAD

FEB.13.2018

drawn

dessiné

date

approved

approuvé

date

Tender

Soumission

IAN SCELES  
PWGSC Project Manager

Administrateur de projets TPSGC

project number

no. du projet

drawing no.


no. du dessin

R.082156.001

ASK.1D



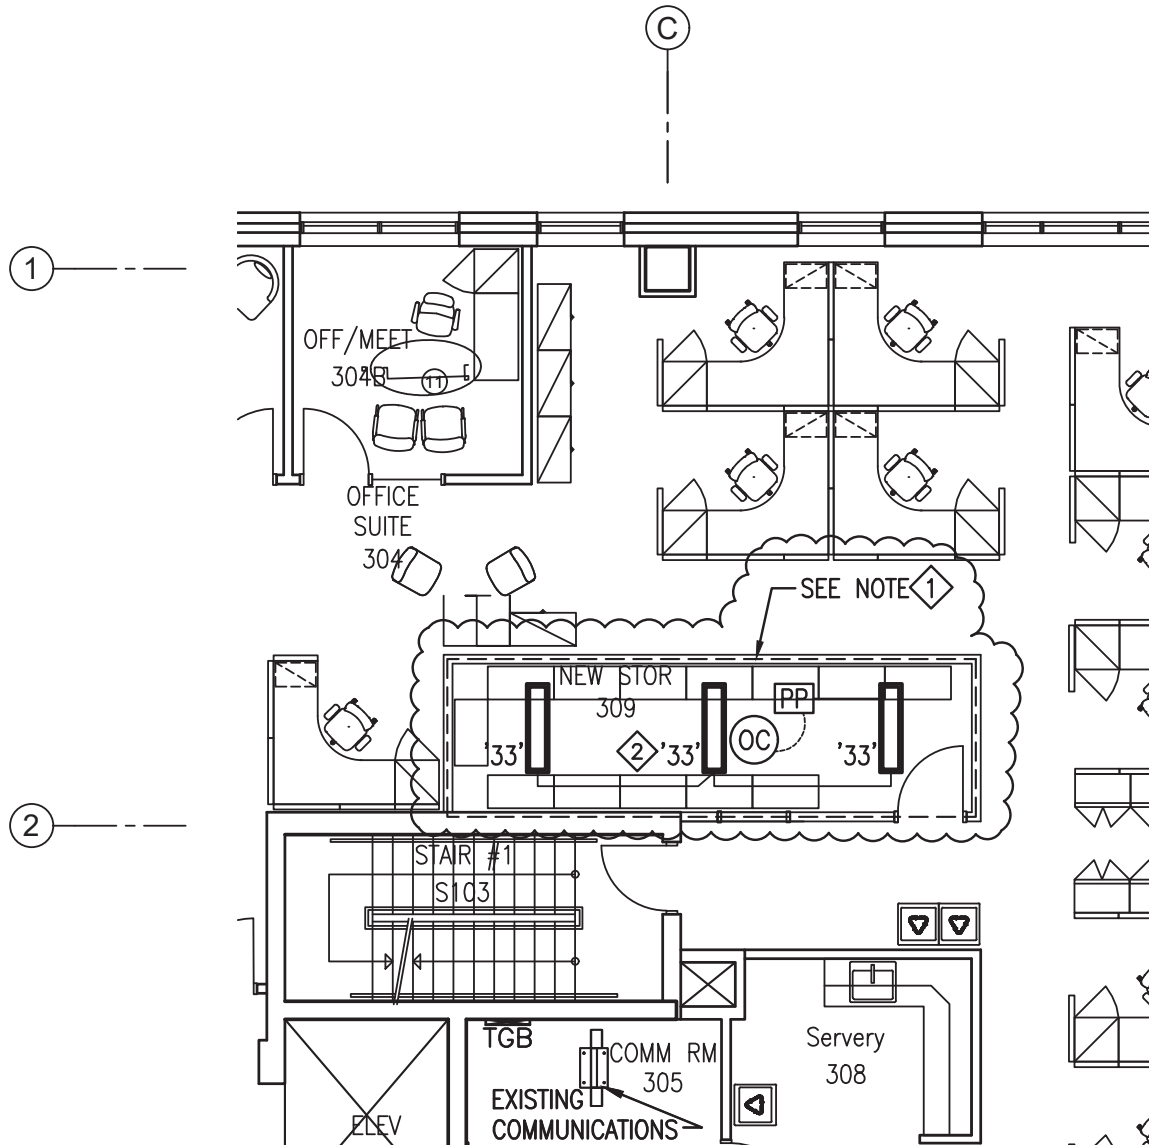


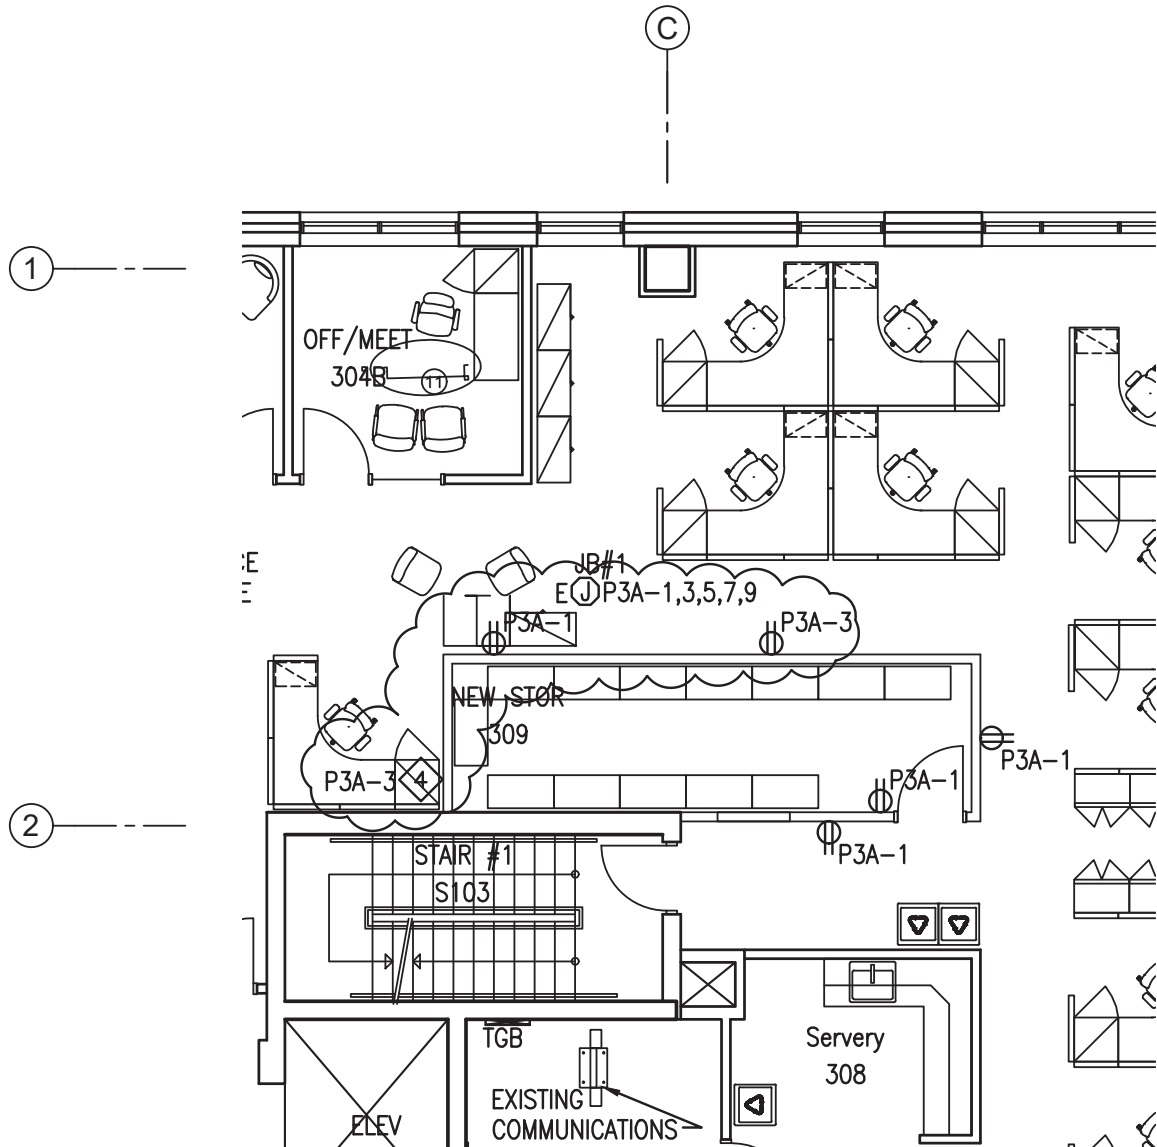


**1 PARTIAL LEVEL 300 FLOOR PLAN - LIGHTING**  
**ESK.1A**  
 SCALE : 1:100  
 0m 1m 2m 3m 4m 5m 6m 7m 8m 9m 10m

**NOTE:**

- 1 DISCONNECT AND REMOVE EXISTING LIGHTING WITHIN DASHED IN AREA.  
 MAINTAIN CIRCUIT CONTINUITY TO ALL REMAINING DEVICES.

	Public Works and Government Services Canada	Travaux publics et Services gouvernementaux Canada	Drawing title		Titre du dessin		designed BAM	conçu	date FEB.13.2018		
	project	CCG WP2.0 FIT-UP MARITIME HEADQUARTERS BEDFORD INSTITUTE OF OCEANOGRAPHY DARTMOUTH, N.S.	project	ADDENDUM # 1 LEVEL 300 PARTIAL FLOOR PLAN – LIGHTING		drawn STAFF		dessiné	date FEB.13.2018		
						approved BAM		approuvé	date FEB.13.2018		
				Tender IAN SCELES PWGSC Project Manager						Soumission	
				project number R.082156.001		no. du projet		drawing no. ESK.1A		no. du dessin	




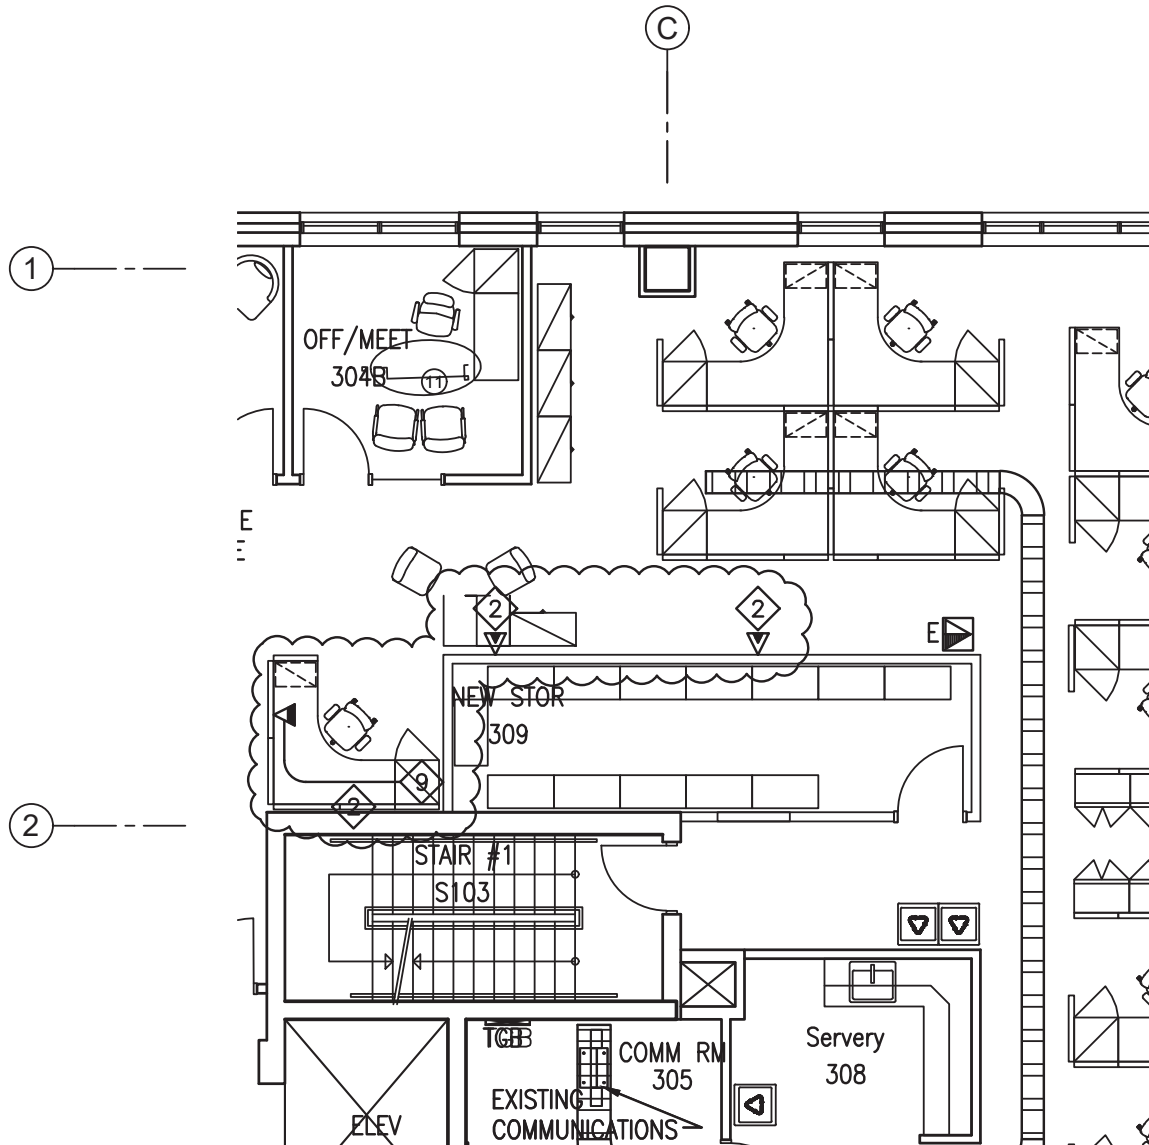
1  
ESK.1B

## PARTIAL LEVEL 300 FLOOR PLAN - POWER

SCALE : 1:100



	Public Works and Government Services Canada	Travaux publics et Services gouvernementaux Canada	Drawing title		Titre du dessin		designed	conçu	date		
			ADDENDUM # 1		LEVEL 300		BAM		FEB.13.2018		
project	CCG WP2.0 FIT-UP MARITIME HEADQUARTERS BEDFORD INSTITUTE OF OCEANOGRAPHY DARTMOUTH, N.S.	project	PARTIAL FLOOR PLAN – POWER				drawn	dessiné	date		
							STAFF		FEB.13.2018		
			Tender				approved	approuvé	date		
			IAN SCELES				BAM		FEB.13.2018		
PWGSC Project Manager			Administrateur de projets TPSGC			Soumission					
project number			no. du projet			drawing no.		no. du dessin			
R.082156.001						ESK.1B					




1  
ESK.1C

## PARTIAL LEVEL 300 FLOOR PLAN - SYSTEMS

SCALE : 1:100


0m 1m 2m 3m 4m 5m 6m 7m 8m 9m 10m

	Public Works and Government Services Canada	Travaux publics et Services gouvernementaux Canada	Drawing title		Titre du dessin		designed	conçu	date	
			ADDENDUM # 1		BAM			FEB.13.2018		
project	CCG WP2.0 FIT-UP MARITIME HEADQUARTERS BEDFORD INSTITUTE OF OCEANOGRAPHY DARTMOUTH, N.S.	projet	LEVEL 300		dessiné		drawn	date		
			PARTIAL FLOOR PLAN – SYSTEMS		STAFF		FEB.13.2018			
					approved		approuvé	date		
					BAM			FEB.13.2018		
			Tender						Soumission	
			IAN SCELES							
			PWGSC Project Manager						Administrateur de projets TPSGC	
			project number		no. du projet		drawing no.		no. du dessin	
			R.082156.001				ESK.1C			

THE BID DOCUMENTS SHALL BE AMENDED AND NEW DRAWINGS AND CLAUSES ADDED, AND SHALL BECOME PART OF THE CONTRACT DOCUMENTS AS FOLLOWS:

# **DRAWINGS**

1. REFERENCE DRAWING M.01
1. LEVEL 300: PROVIDE TWO ADDITIONAL SPRINKLER HEADS FOR NEW STORAGE 309.
2. REFERENCE DRAWING M.02
1. LEVEL 400:
  1. OFFICE 408 AND ADJACENT WORK STATION: RELOCATE EXISTING SPRINKLER TO SUIT NEW PARTITIONS AND LIGHTING.
  2. QUIET 411: RELOCATE FOUR EXISTING SPRINKLERS TO SUIT NEW PARTITIONS.
  3. QUIET 412: RELOCATE FOUR EXISTING SPRINKLERS TO SUIT NEW PARTITIONS.
  4. PROVIDE AN ADDITIONAL SPRINKLER HEADS FOR NEW MEETING 409
  5. MEETING 409 AND MEETING 410: RELOCATE FOUR EXISTING SPRINKLERS AROUND PERIMETER TO SUIT NEW PARTITIONS.
2. LEVEL 500:
  1. OFFICE 508D AND ADJACENT WORK STATION: RELOCATE EXISTING SPRINKLER AROUND PERIMETER TO SUIT NEW PARTITIONS AND LIGHTING.
  2. QUIET 509: RELOCATE FOUR EXISTING SPRINKLERS TO SUIT NEW PARTITIONS.
  3. PROVIDE AN ADDITIONAL SPRINKLER HEADS FOR NEW COPY 508F
  4. COPY 508F AND STOR 508E: RELOCATE THREE EXISTING SPRINKLERS AROUND PERIMETER TO SUIT NEW PARTITIONS.
3. REFERENCE DRAWING M.03
1. LEVEL 600:
  1. OFFICE 608C AND OFFICE 611: RELOCATE EXISTING SPRINKLER TO SUIT NEW PARTITIONS AND LIGHTING.
  2. SERVERY 608: RELOCATE TWO EXISTING SPRINKLERS TO SUIT NEW PARTITIONS.
  3. QUIET 612: RELOCATE TWO EXISTING SPRINKLERS AROUND PERIMETER TO SUIT NEW PARTITIONS.

 Public Works and Government Services Canada         Travaux publics et Services gouvernementaux Canada	Drawing title                      Titre du dessin  ADDENDUM # 1 LEVEL 300 MECHANICAL NOTES		designed                      conçu KAD drawn                      dessiné  approved                      approuvé	date FEB.13.2018  date   date				
project CCG WP2.0 FIT-UP MARITIME HEADQUARTERS BEDFORD INSTITUTE OF OCEANOGRAPHY DARTMOUTH, N.S.         projet	<table border="1"> <tr> <td data-bbox="735 1843 1157 1906">           Tender            IAN SCELES            PWGSC Project Manager         </td><td data-bbox="1166 1843 1497 1906">           Soumission            Administrateur de projets TPSGC         </td></tr> <tr> <td data-bbox="735 1906 1157 1955">           project number            R.082156.001         </td><td data-bbox="1166 1906 1497 1955">           no. du projet            drawing no.            MSK.1A            no. du dessin         </td></tr> </table>				Tender IAN SCELES PWGSC Project Manager	Soumission Administrateur de projets TPSGC	project number R.082156.001	no. du projet drawing no. MSK.1A no. du dessin
Tender IAN SCELES PWGSC Project Manager	Soumission Administrateur de projets TPSGC							
project number R.082156.001	no. du projet drawing no. MSK.1A no. du dessin							