

revision	description	date
01	ISSUED FOR TENDER	15/03/26

project / projet
CSC MULTI-PURPOSE BUILDING
CBI MINIMUM INSTITUTION (FRONTENAC)
 KINGSTON, ONTARIO


FLOOR PLANS

designed	Mackay-Lyons Sweetapple	compu
date	2012/01/01	(yyyy/mm/dd)
drawn	BML	dessiné
date	2012/11/16	(yyyy/mm/dd)
reviewed	DC / GF	examiné
date	2015/02/23	(yyyy/mm/dd)
approved	RM	approuvé
date	2015/03/12	(yyyy/mm/dd)
Tender	DUNCAN PARKER	Soumission


Project Manager / Administrateur de projets
 project no. / no. du projet
R.055776.001
 drawing no. / no. du dessin
A200

LEGEND

- FIRE RESISTANT RATED ZONE
- EMERGENCY LANE
- FOR INTERIOR PARTITION TYPES REFER TO PARTITION SCHEDULE ON LEGEND / GLOSSARY PAGE
- PLUMBING RISERS TO BE LOCATED WITHIN WALL CAVITY
- BOLLARD
- LOCATION OF IN-FLOOR POST SLEEVES (FENCE N.I.C.)

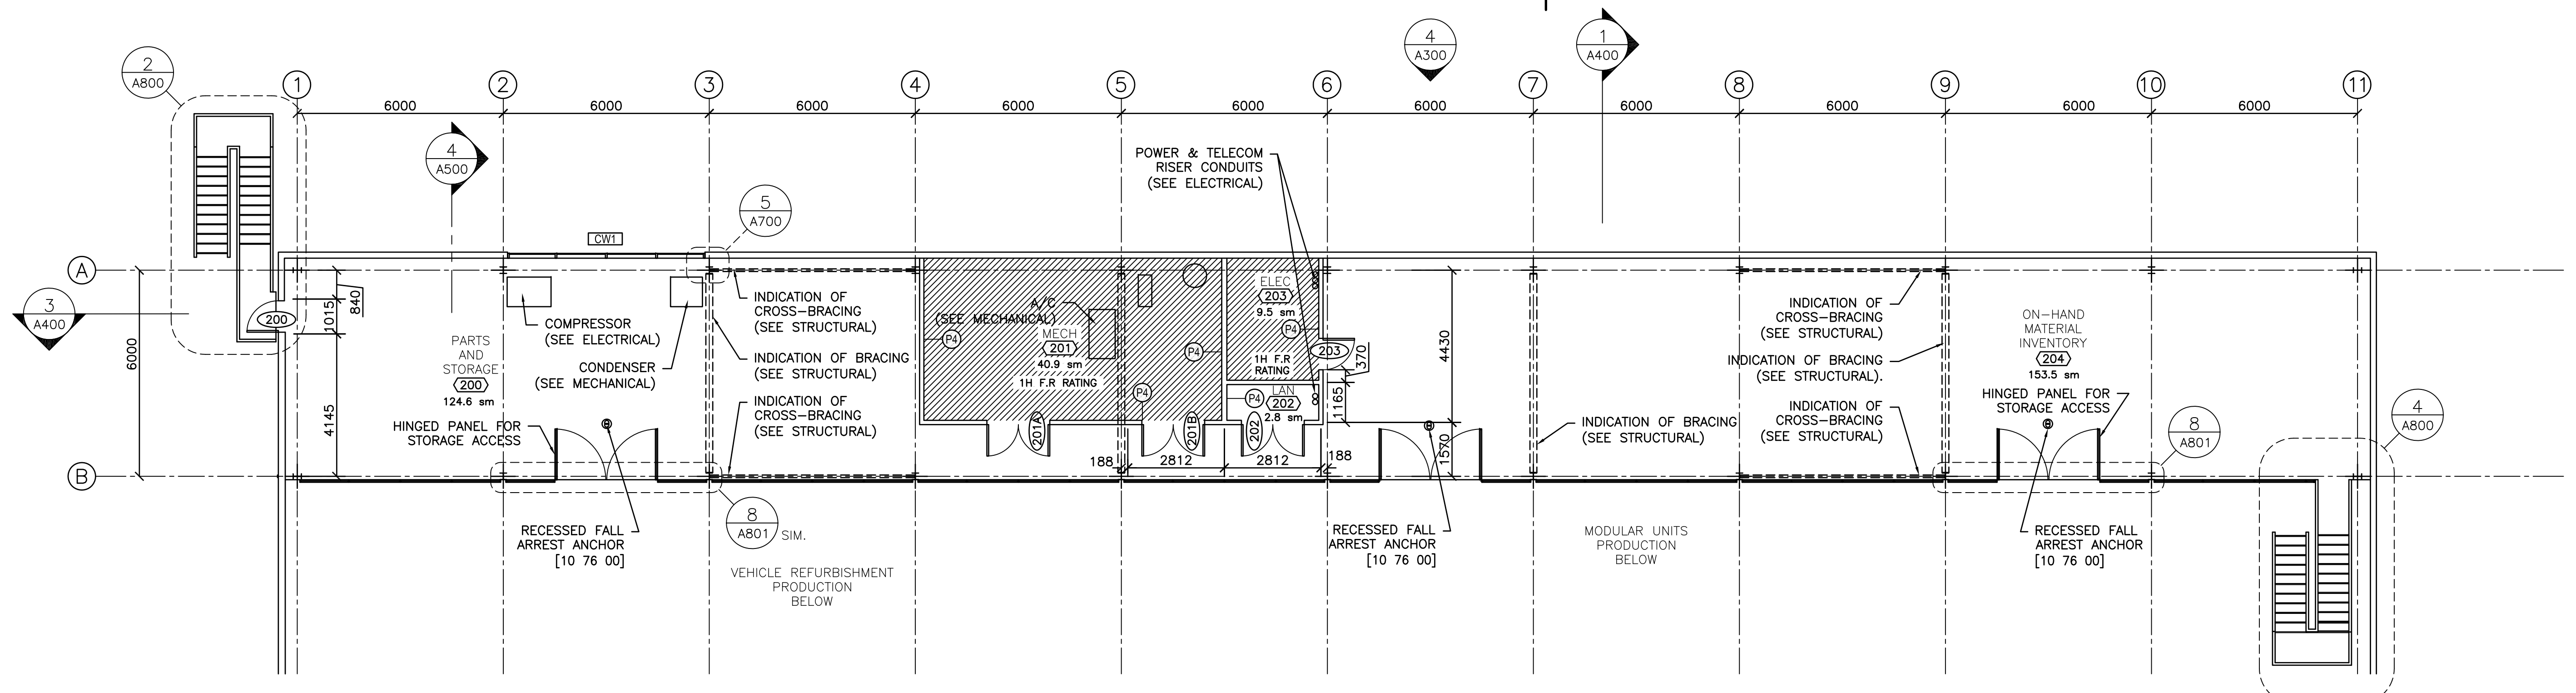

1 MEZZANINE FLOOR PLAN
 SCALE: 1:100
 APPROX. NORTH

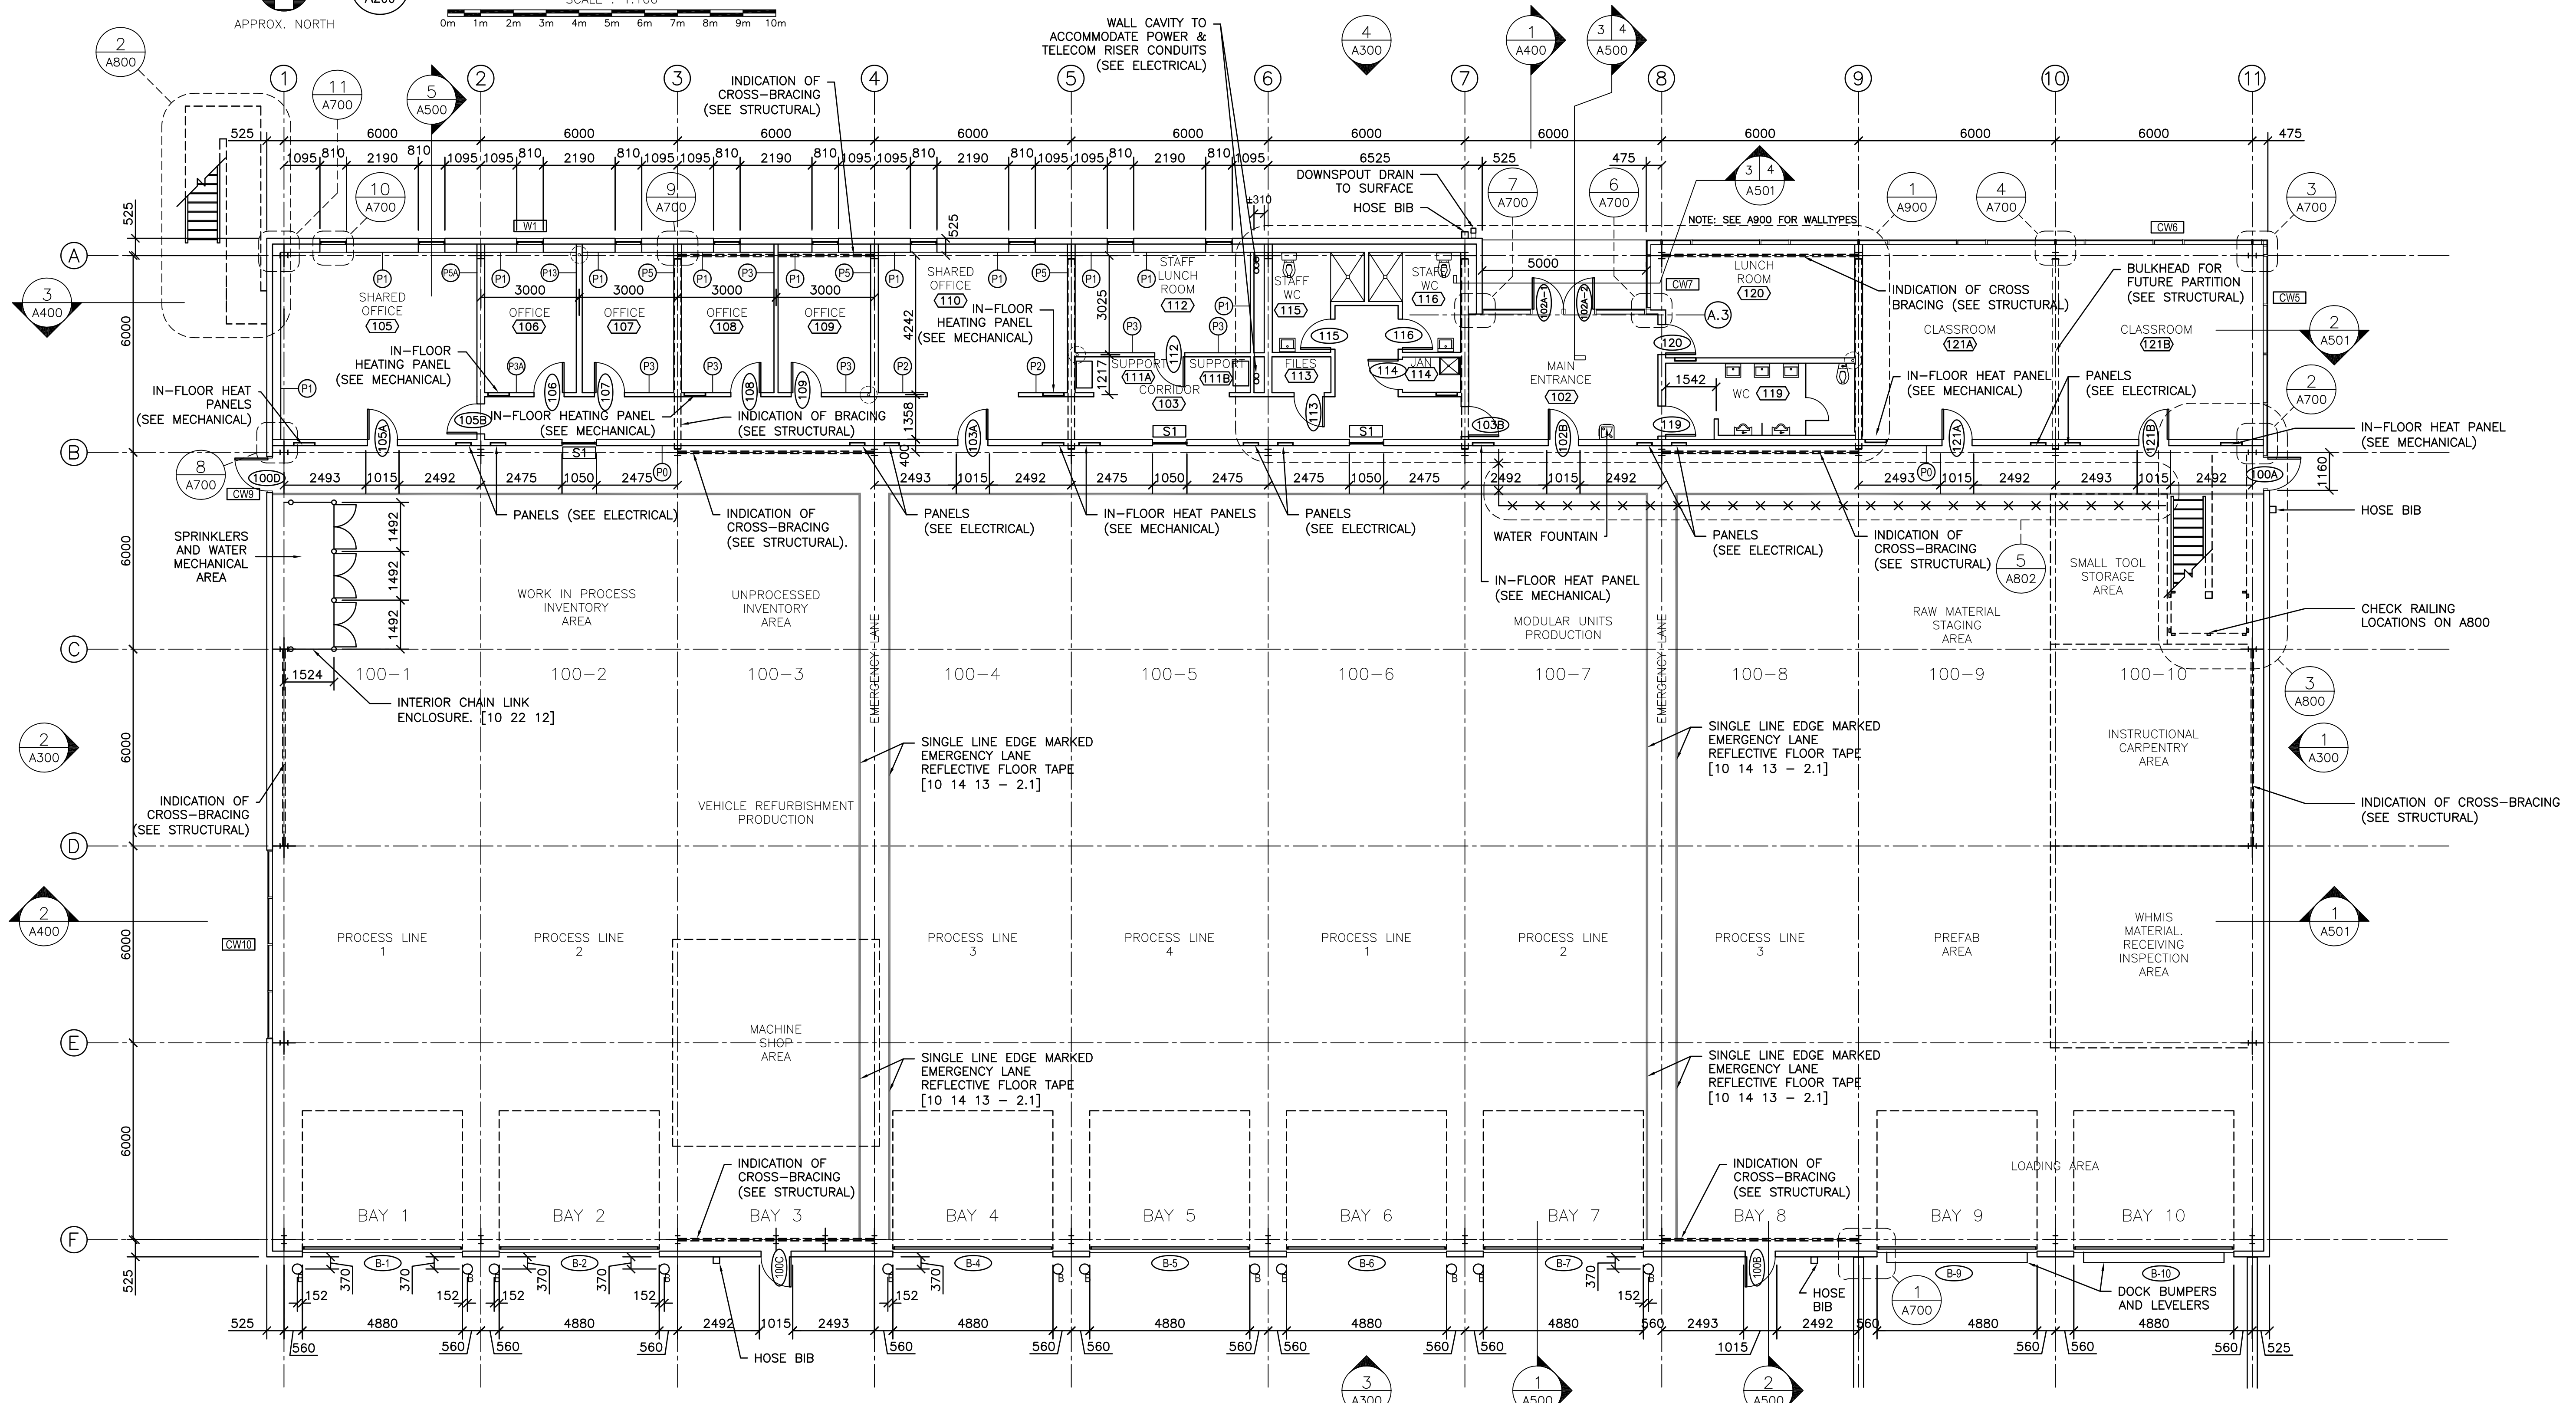

2 MAIN FLOOR PLAN
 SCALE: 1:100
 APPROX. NORTH

08.07.2014 / 1403-A200 FloorPlan-004.dwg / PWGSC B1 (1000x707)