


Fisheries and Oceans
Pêches et Océans
Real Property Services
Services Immobiliers

GREENING GOVERNMENT OPERATIONS
BURIN CCG LIFEBOAT STATION
BURIN
NEWFOUNDLAND AND LABRADOR


PROJECT NO. F6879-189201

Canada

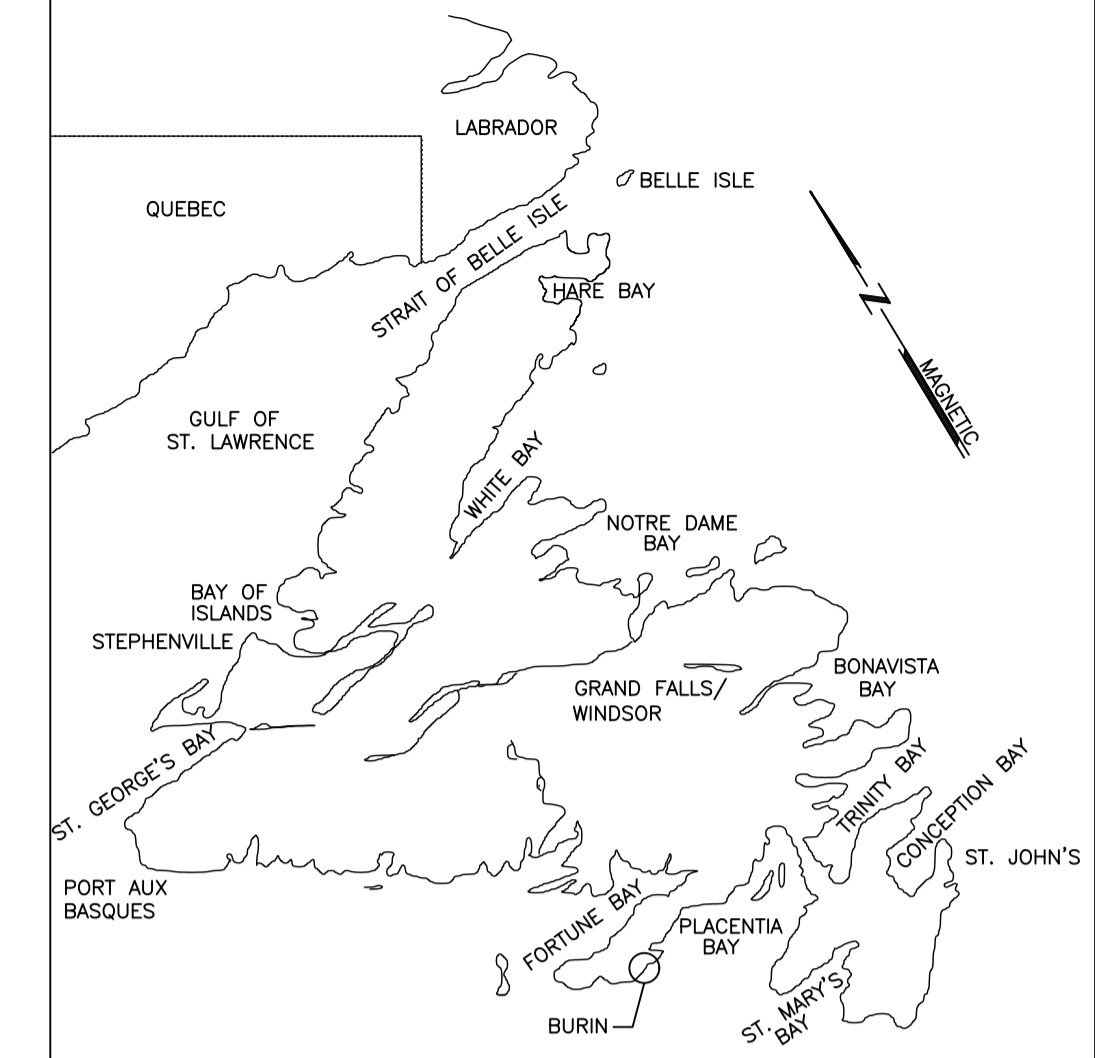

KEY LOCATION PLAN

M. LAWRENCE ENGINEERING LTD

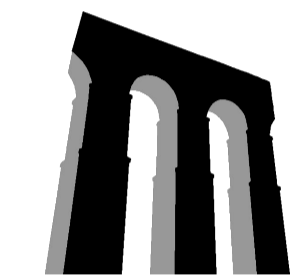


Consulting Engineers

HALIFAX NS
902-222-5364
WWW.MLENGINEERING.CA

CONSULTANT

STAMP

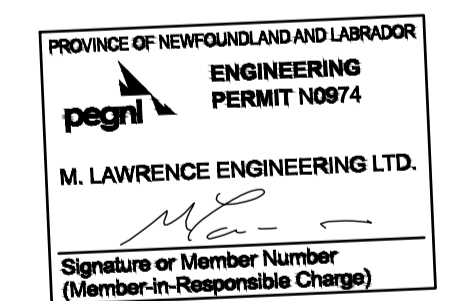

no.	revision	date	by	approved
1	ISSUED FOR TENDER	18/04/09	M.L.	M.L.

Project - projet

BURIN - GREENING
GOVERNMENT OPERATIONS

Drawing - dessin

LEVEL 1 - NEW
LIGHTING LAYOUT

drawn - dessiné par
H. OSBORNE


date - date
FEBRUARY 2018

scale - échelle
AS SHOWN

project no. - projet no.
F6879-189201

drawing no. - no du dessin
01M0302G00

sheet - feuille
ME-2

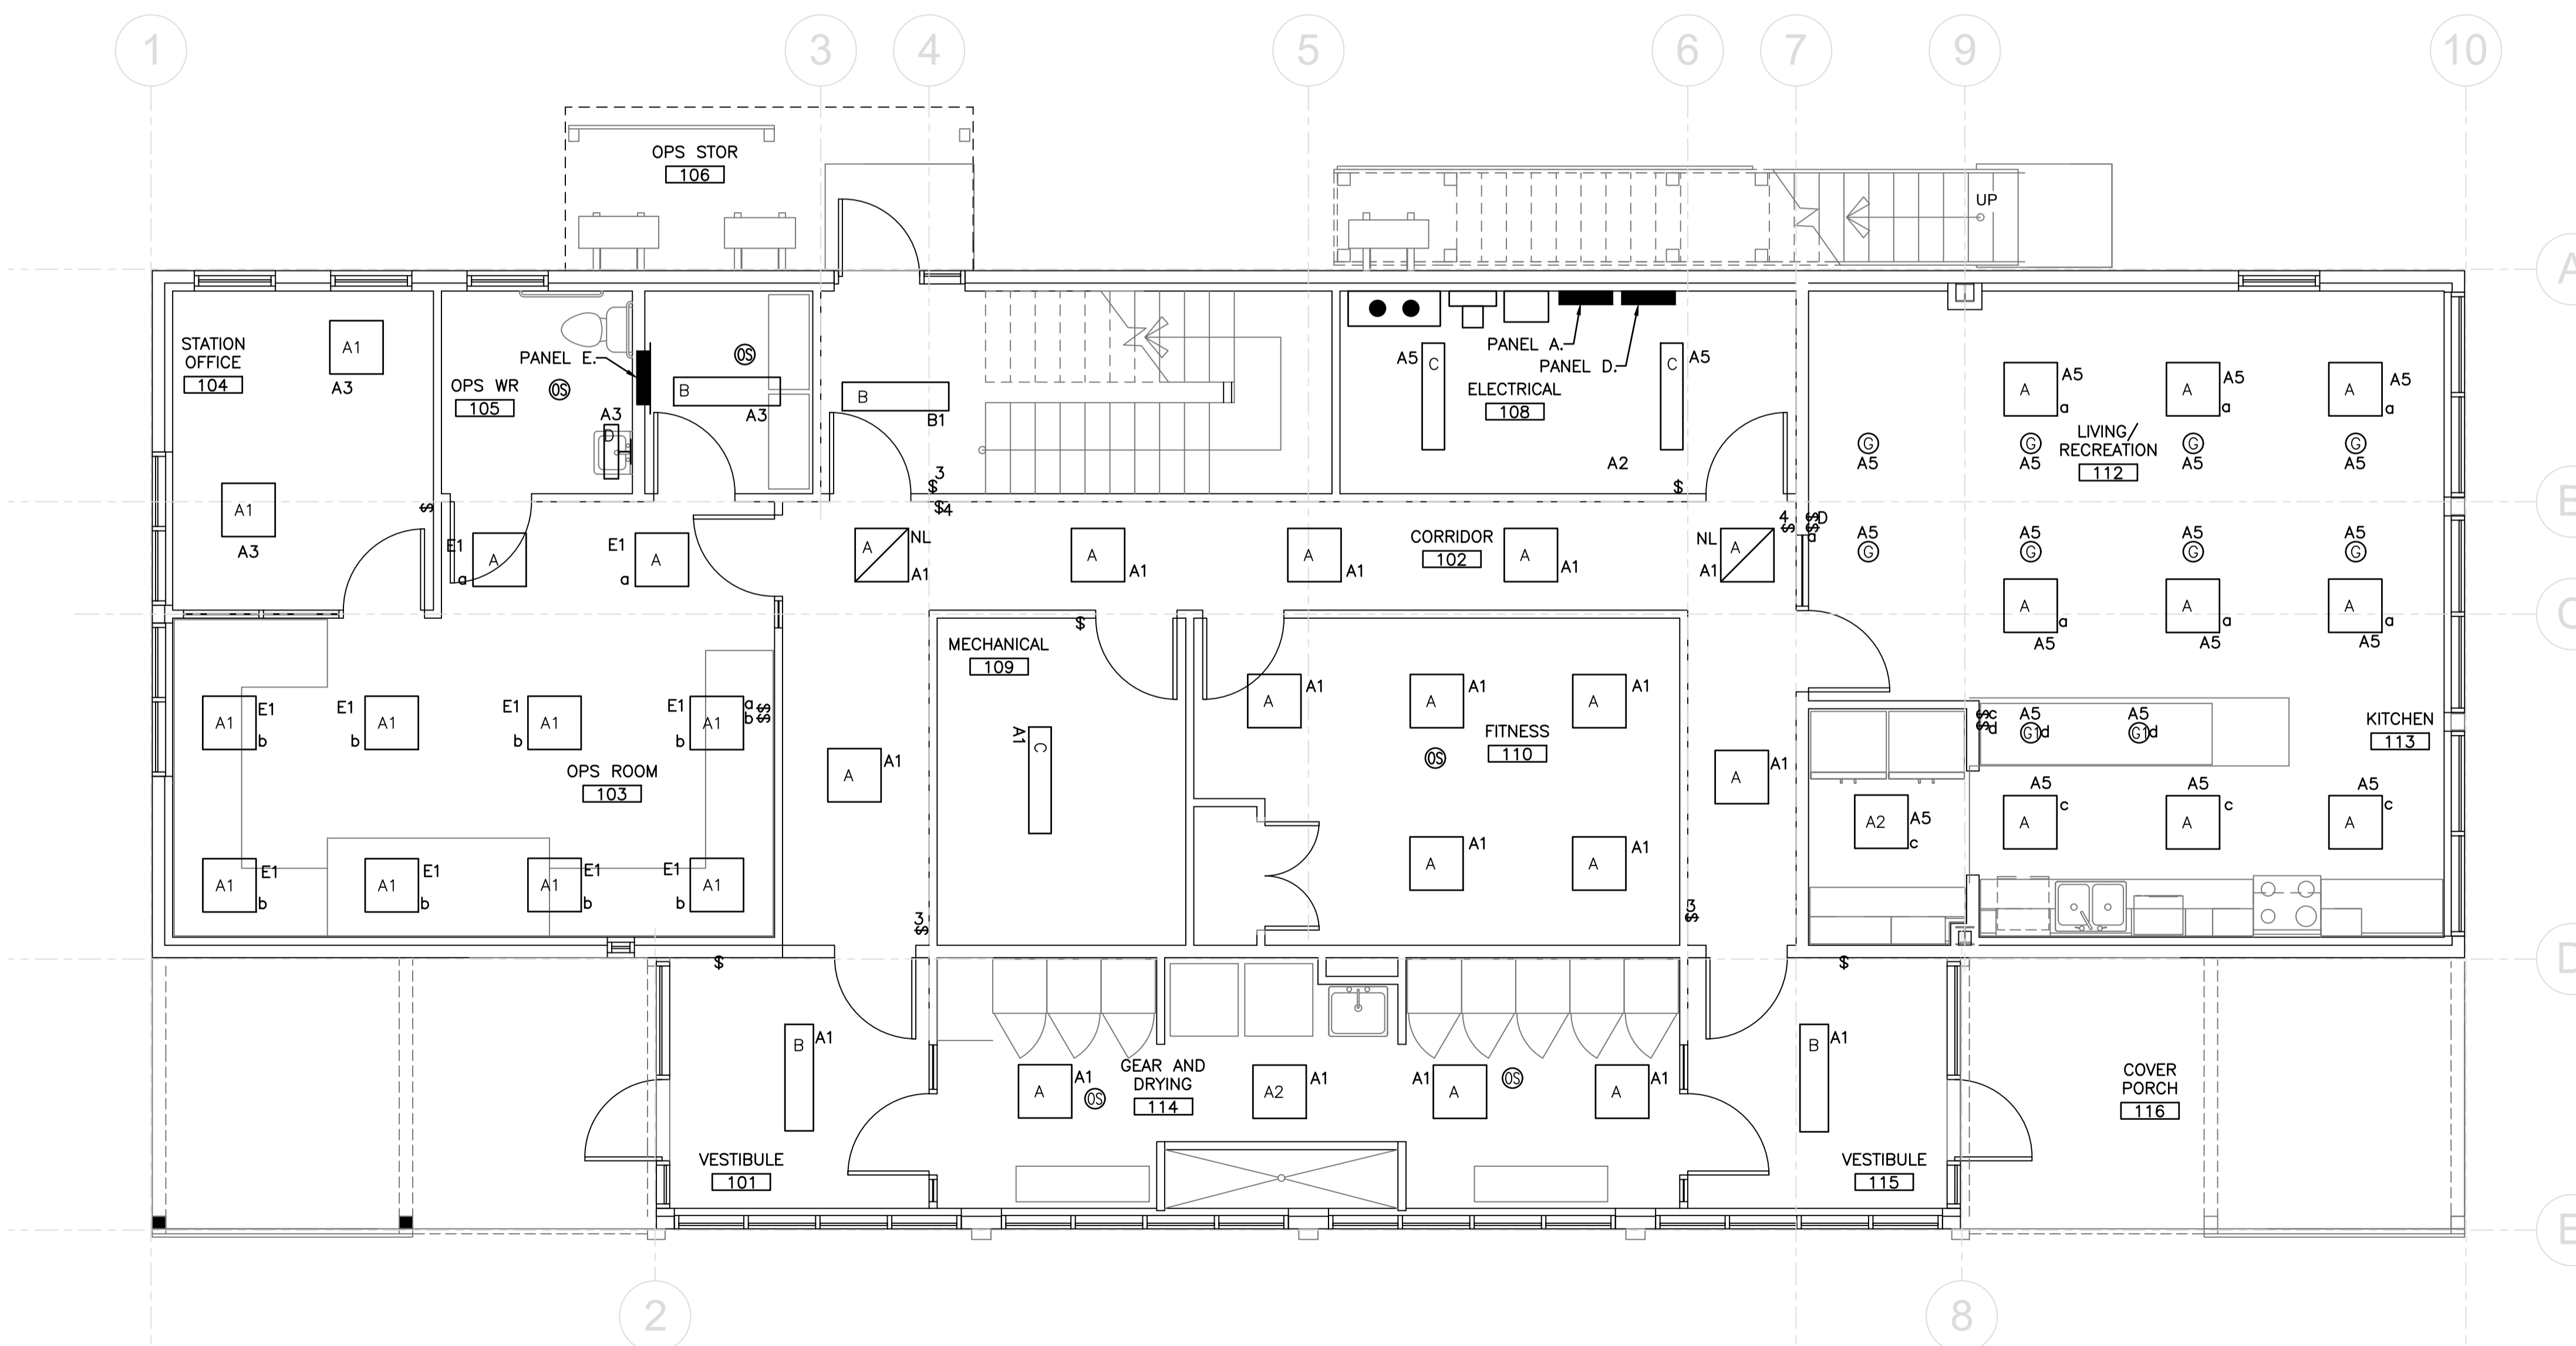

LIGHTING - MAIN BUILDING LEVEL 1

SCALE: 1:50




1
ME2

LIGHT FIXTURE SCHEDULE

SYMBOL	TYPE	EXISTING FIXTURE DESCRIPTION	NEW FIXTURE DESCRIPTION	MANUFACTURER	CAT. NO.	COLOR TEMPERATURE (K)	OUTPUT /LAMP REQUIREMENT	WATTAGE	VOLTAGE
	A	2'x2' FLUORESCENT T8 U-BULB TROFFER, 2-LAMP, FLUSH MOUNTED	2'x2' LED TROFFER c/w ACRYLIC LENS, FLUSH MOUNTED	LITHONIA	2GTL-2-40L-SLD-LP835	3500	LED DRIVER/ 4038 LUM	34W	120V
	A1	2'x2' FLUORESCENT T8 U-BULB TROFFER, 2-LAMP, FLUSH MOUNTED	2'x2' LED TROFFER c/w ACRYLIC LENS, FLUSH MOUNTED	LITHONIA	2GTL-2-40L-SLD-LP835	3500	LED DRIVER/ 4038 LUM	34W	120V
	2A	2'x2' FLUORESCENT T8 TROFFER, 2-LAMP, SURFACE MOUNTED	2'x2' LED TROFFER c/w ACRYLIC LENS, FLUSH MOUNTED	LITHONIA	2GTL-2-33L-SLD-LP835	3500	LED DRIVER/ 3764 LUM	31W	120V
	B	1'x4' FLUORESCENT T8 TROFFER, 2-LAMP, SURFACE MOUNTED	4' LED WRAPAROUND FIXTURE c/w PRISMATIC DIFFUSER, SURFACE MOUNTED	LITHONIA	LBL4-4000LM-80CRI-35K-ZT-MVOLT	3500	LED DRIVER/ 4188 LUM	32W	120V
	C	1'x4' FLUORESCENT T8 LOW-BAY, 2-LAMP, SURFACE MOUNTED	4' LED STRIP c/w WIREGUARD, SURFACE MOUNTED	LITHONIA	ZL1D-L48-SMR-5000LM-FST-MVOLT-35K c/w WGZ48	3500	LED DRIVER/ 5456 LUM	41W	120V
	H	1'x8' FLUORESCENT T8 LOW-BAY, 4-LAMP, SURFACE MOUNTED	8' LED STRIP c/w WIREGUARD, SURFACE MOUNTED	LITHONIA	TZL1D-L96-SMR-10000LM-FST-MVOLT-35K c/w WGZ48x2	3500	LED DRIVER/ 11442 LUM	81W	120V

LIGHTING LEGEND

- EXISTING LIGHTING FIXTURE, WALL MOUNTED.
- EXISTING FLUORESCENT LIGHTING FIXTURE TO BE CHANGED TO LED. LETTER DENOTES TYPE. SEE LIGHTING FIXTURE SCHEDULE & SPECIFICATIONS FOR DESCRIPTION.
- EXISTING SINGLE POLE TOGGLE SWITCH.
- EXISTING THREE WAY SWITCH.
- EXISTING CEILING MOUNTED OCCUPANCY SENOR

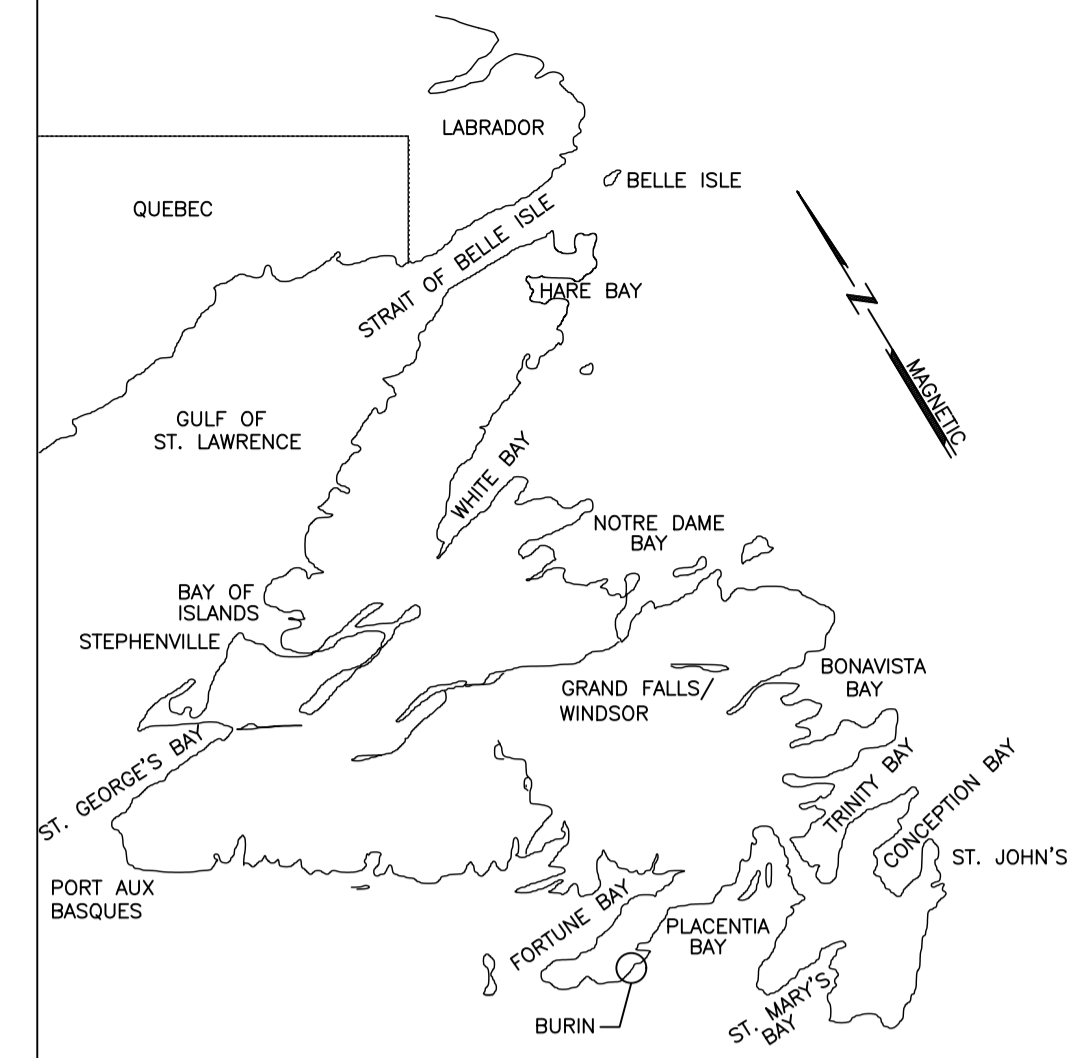



KEY LOCATION PLAN

M. LAWRENCE ENGINEERING LTD


Consulting Engineers
HALIFAX NS
902-222-5364
WWW.MLENGINEERING.CA

CONSULTANT

STAMP

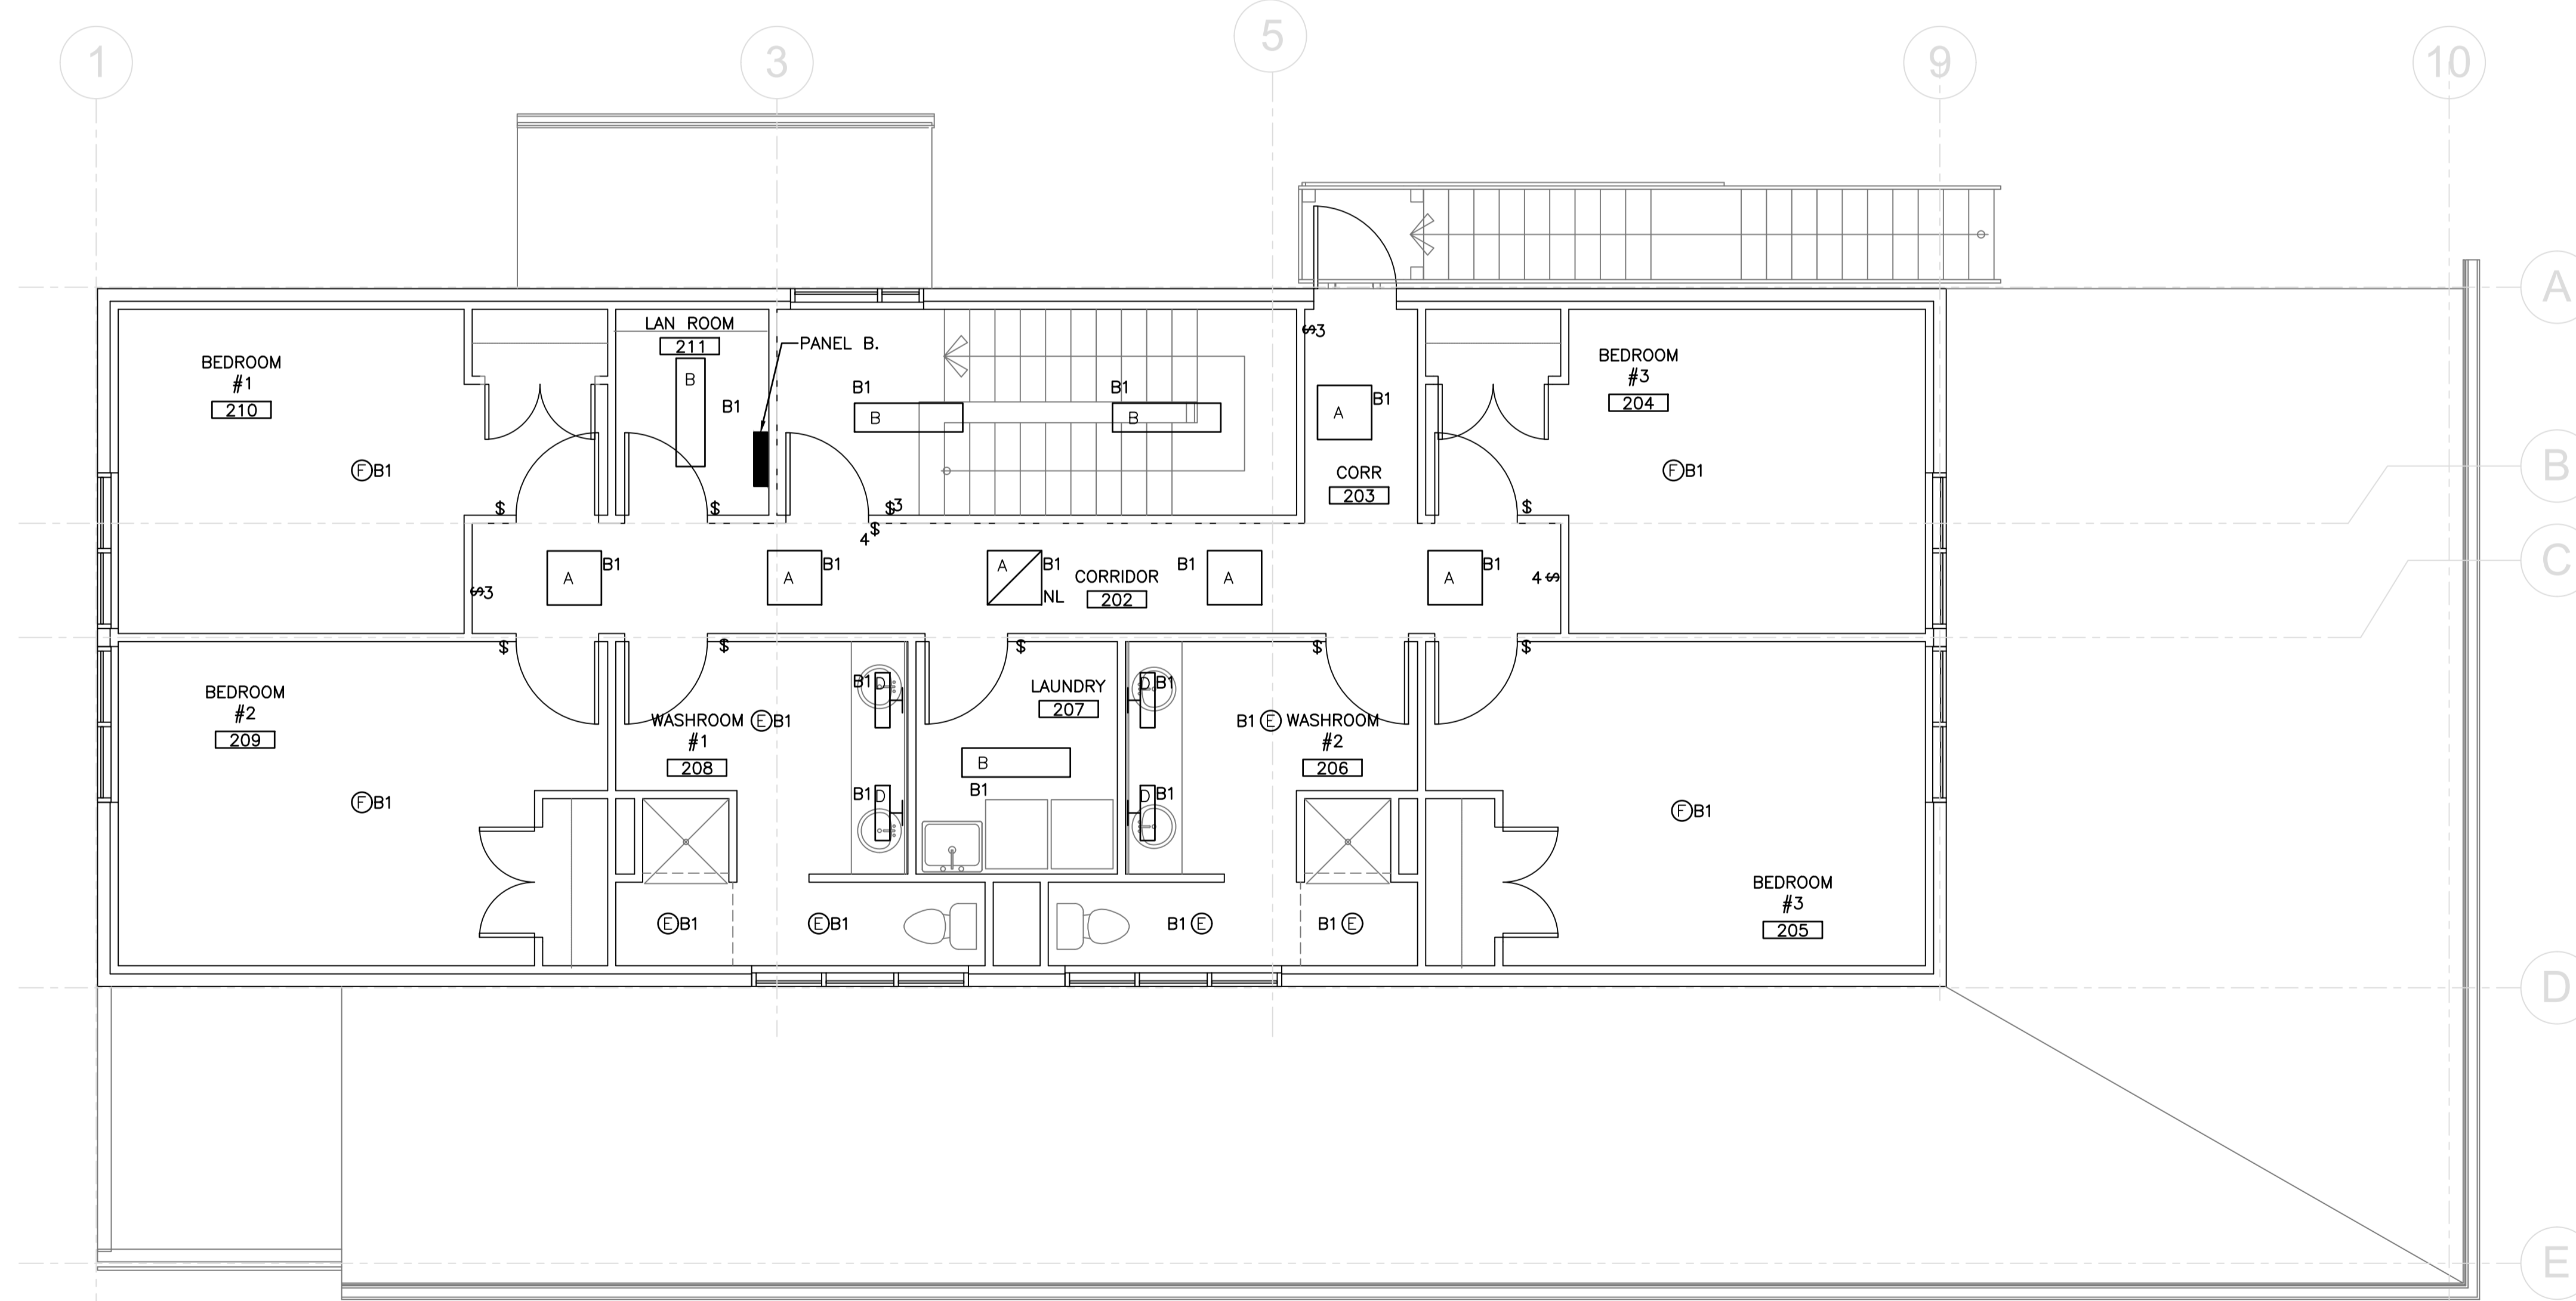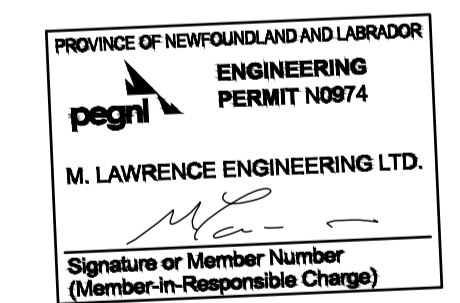

LIGHTING – MAIN BUILDING LEVEL 2

 

1
ME3

1	ISSUED FOR TENDER	18/04/09	M.L.	M.L.
no.	revision	date	by	approved
no.	revision	date	par	approuvé

Project – projet
BURIN – GREENING GOVERNMENT OPERATIONS

Drawing – dessin LEVEL 2 – NEW LIGHTING LAYOUT	
drawn – dessiné H. OSBORNE	designed – dessiné par M. LAWRENCE
date – date FEBRUARY 2018	checked – vérifié M. LAWRENCE
scale – échelle AS SHOWN	approved for tender – approuvé pour l'offre
project no. – projet no. F6879-189201	drawing no. – no du dessin 01M0302G00
	sheet – feuille ME-3