
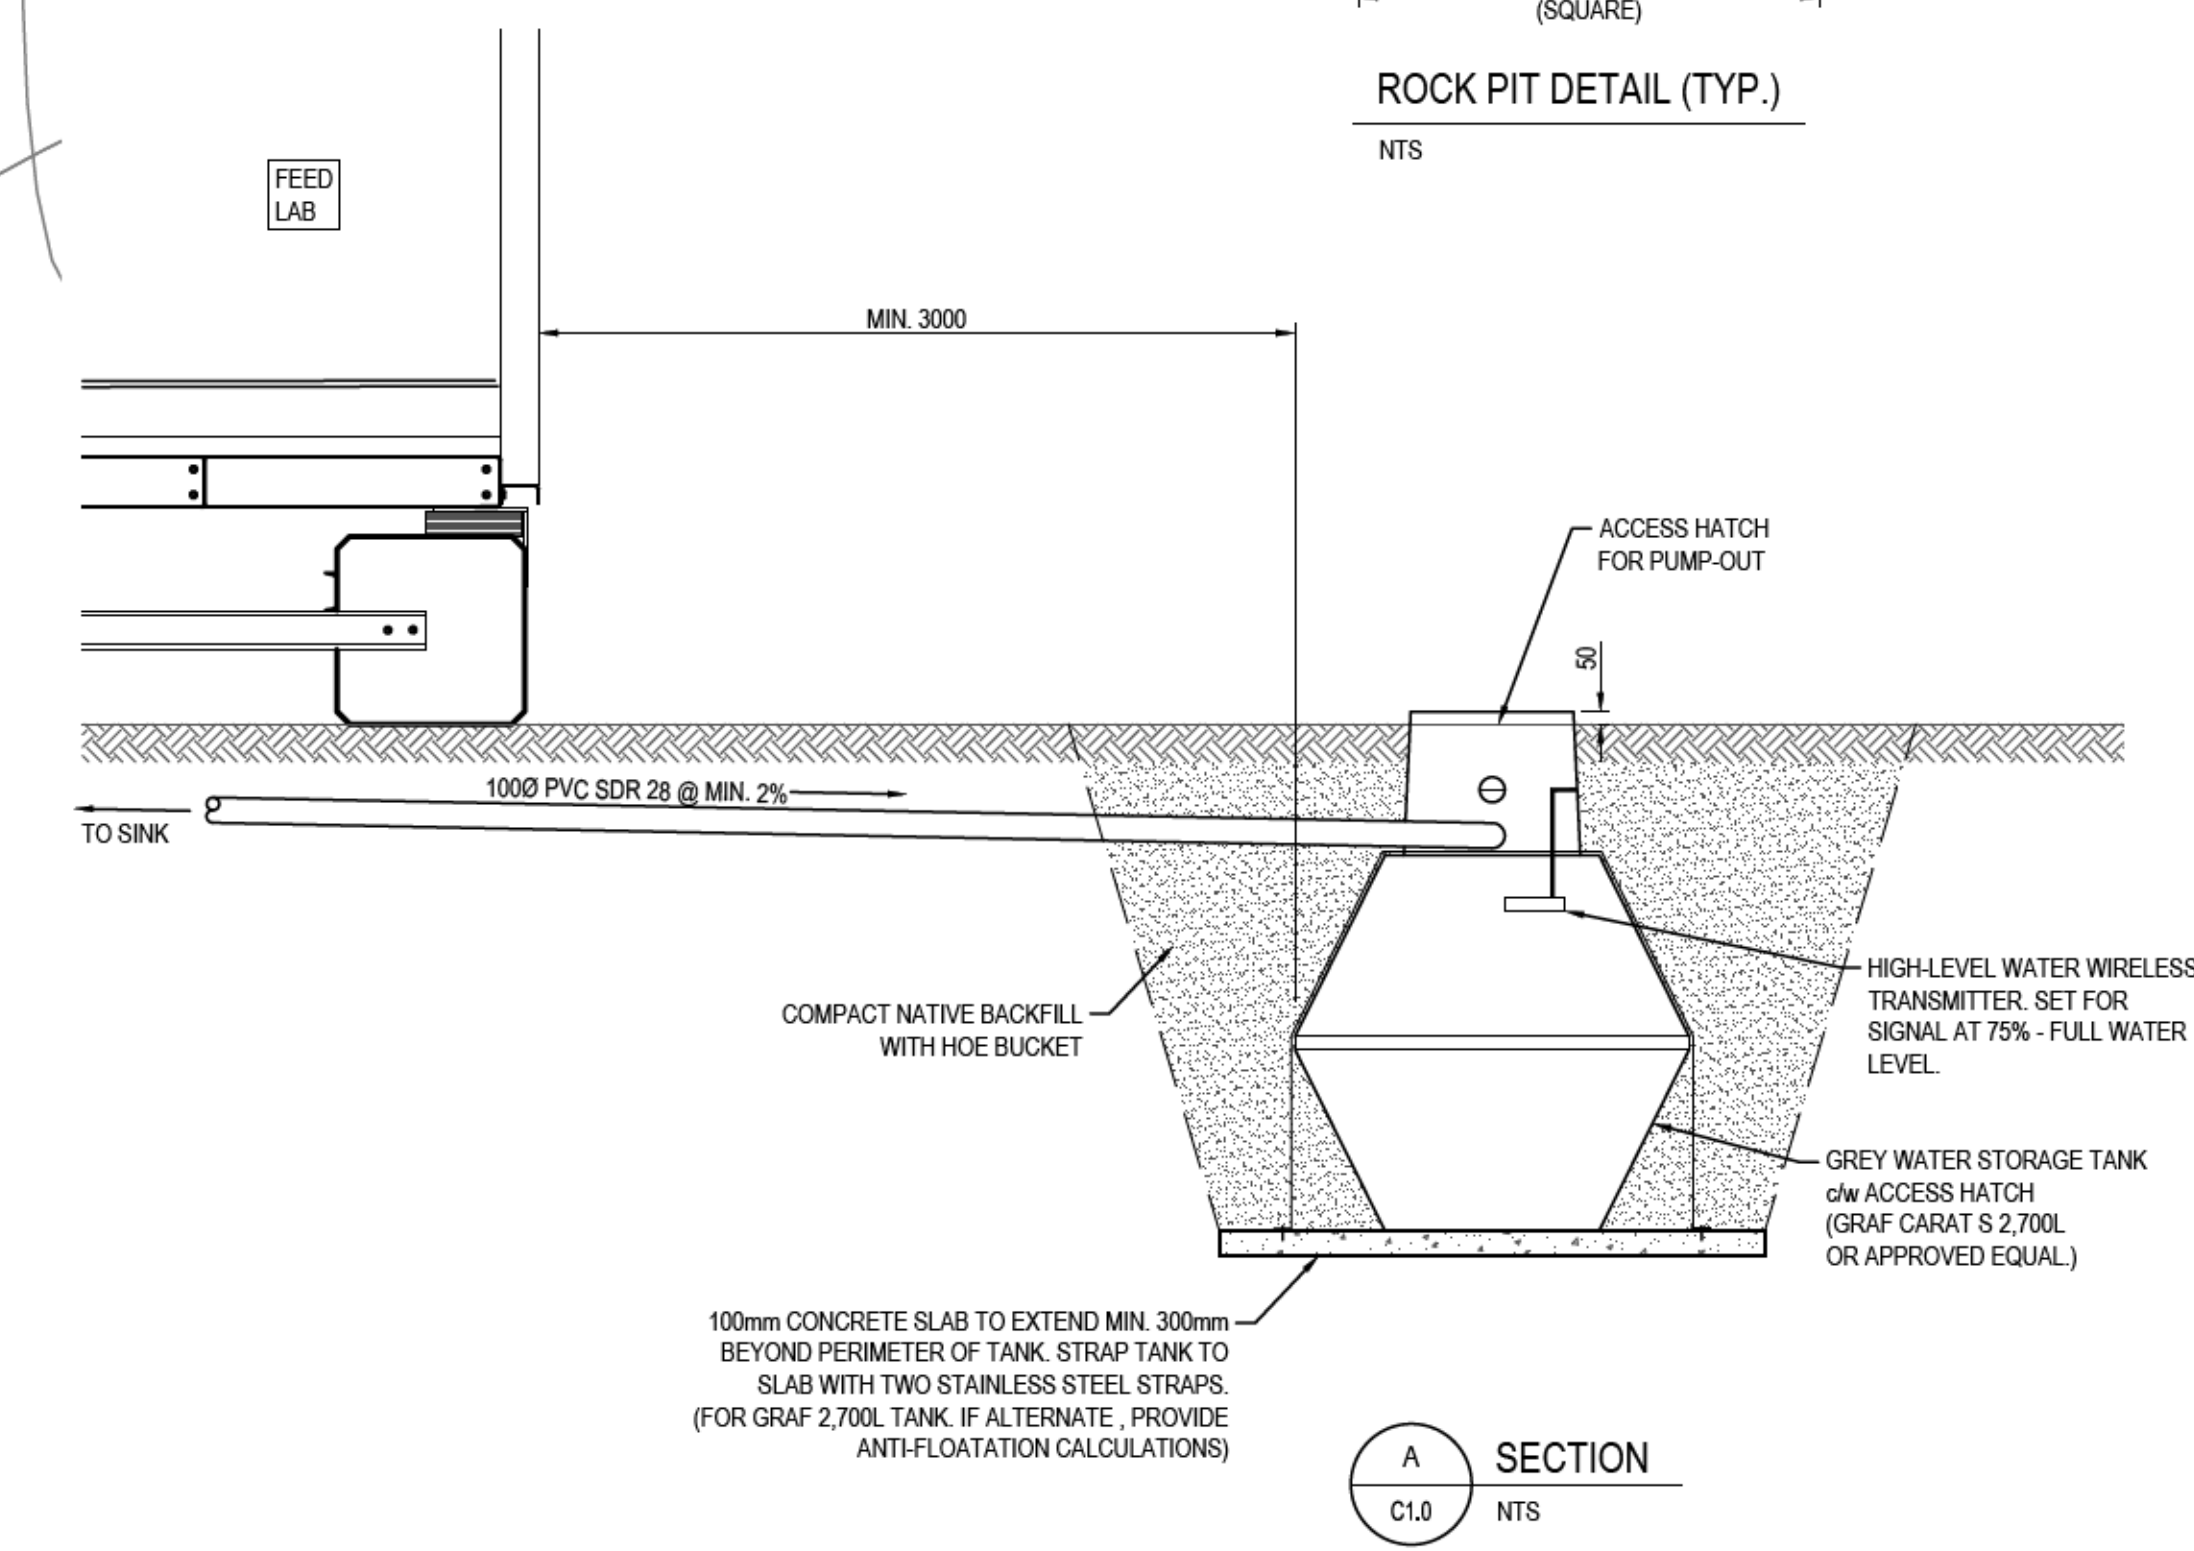
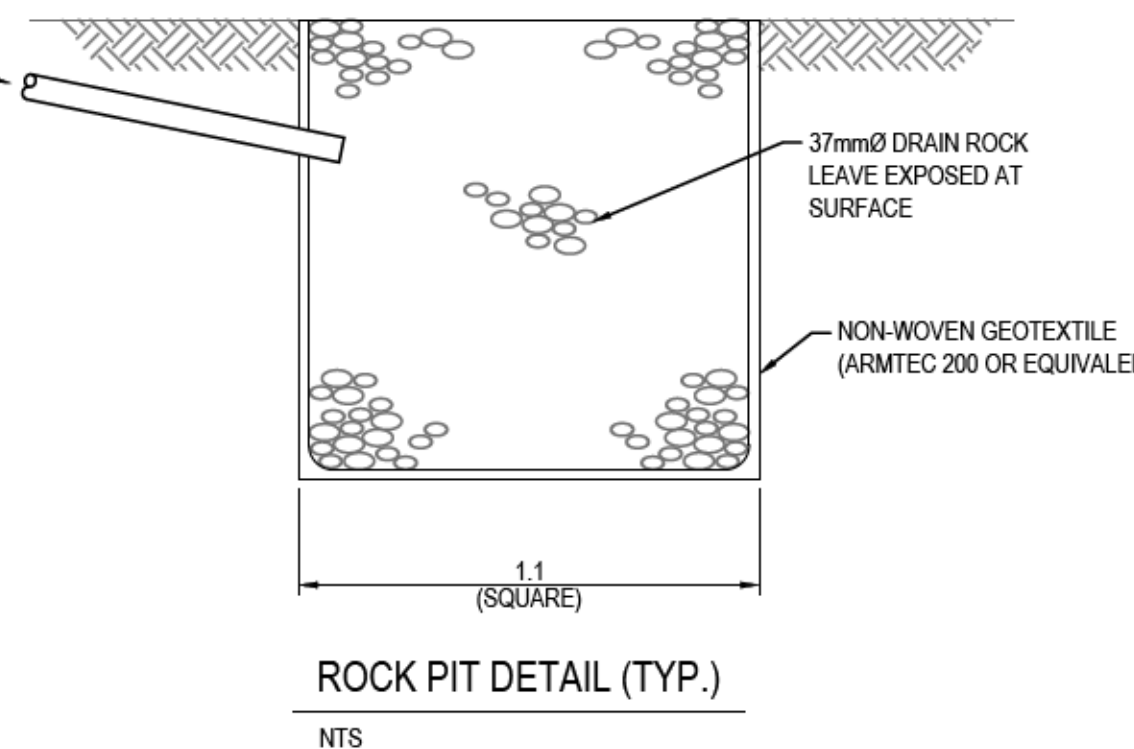


- KEYNOTES:**
- 1. EXTEND 19mm PH10 PE SERVICE TO EXISTING 50mm PVC WATERMAIN. MAINTAIN MINIMUM 3.0m CLEARANCE FROM TRANSFORMER. COUNTERPOISE. INSULATE AND HEAT-TRACE EXPOSED PIPE BELOW NEW FEED LAB (SEE ELECTRICAL AND MECHANICAL).
 - 2. GREY WATER STORAGE TANK c/w ACCESS HATCH. ACCEPTABLE PRODUCT "GRAF CARAT S 2700". TANK TO BE EQUIPPED WITH WIRELESS LEVEL MONITOR WITH ALARM PANEL MOUNTED IN FEED LAB. APPROVED PRODUCT = "MQUATEL D110". FINAL LOCATION TO BE DETERMINED IN FIELD.
 - 3. RAIN WATER LEADER. CONNECT TO ROCK-PIT. SEE DETAIL ON THIS SHEET. (TYPICAL FOR 2)
 - 4. MAKE CONNECTION TO EXISTING PVC MAINLINE UPSTREAM OF EXISTING DCV. INSTALL NEW DCV IN VALVE BOX. ACCEPTABLE PRODUCT = "WATTS 907". DO NOT INCLUDE 2-BALL VALVES AND TEST COCKS. VALVE BOX TO BE INSULATED. ALL JOINTS TO BE WELDED OR MECHANICALLY RESTRAINED.
 - 5. CONTRACTOR TO LOCATE EXISTING ELECTRICAL SERVICES TO FORM TRANSFORMER PRIOR TO CONSTRUCTION.
 - 6. EXISTING SERVICES SHOWN ON THIS DRAWING ARE APPROXIMATE ONLY AND CANNOT BE GUARANTEED FOR ACCURACY. CONTRACTOR TO CONFIRM LOCATION OF ALL EXISTING SERVICES IN THE FIELD PRIOR TO CONSTRUCTION.
 - 7. CONTACT BC-1 (1-800-474-6886), BC HYDRO, SHAW CABLE, AND FORTIS GAS FOR UNDERGROUND UTILITY LOCATIONS PRIOR TO CONSTRUCTION.

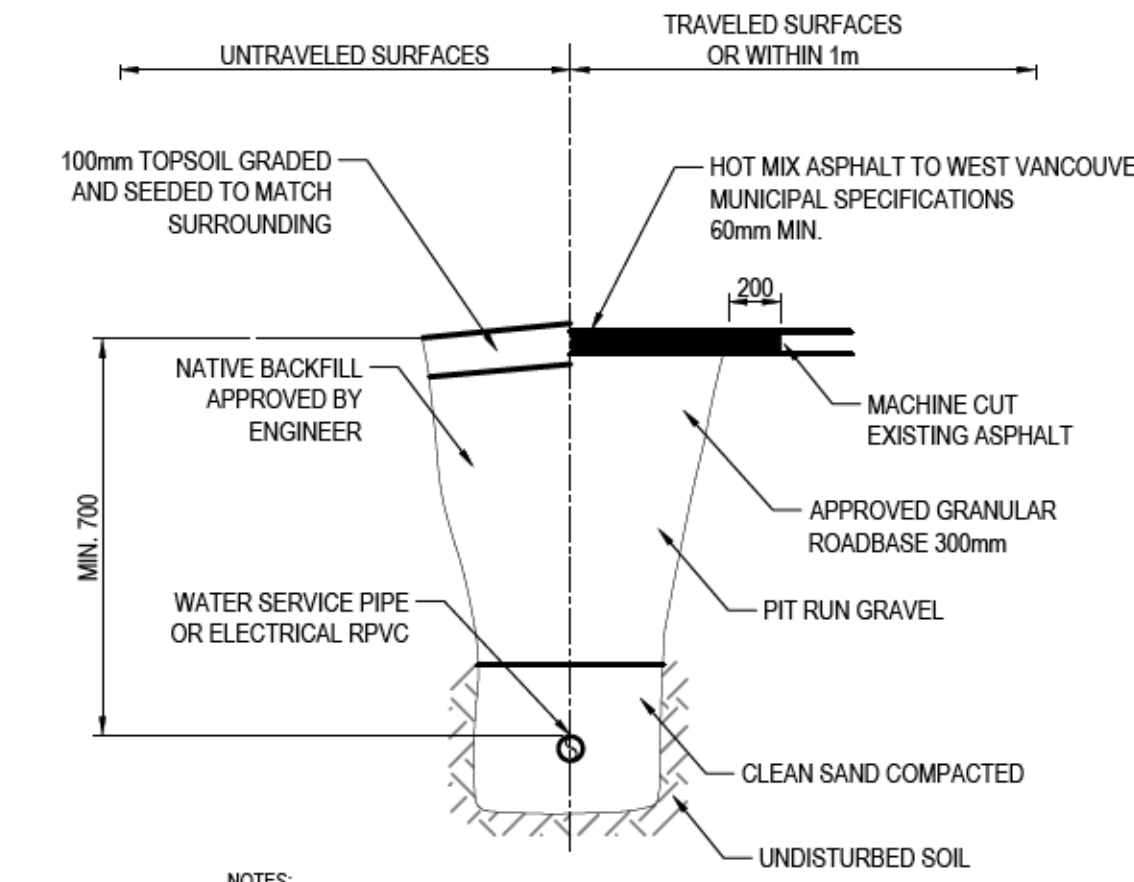

NOTE:
UTILITIES LOCATION COPIED FROM INFORMATION PROVIDED BY OTHERS. LOCATION OF UTILITIES SHOWN SHOULD BE VERIFIED BY UTILITIES LOCATE AND FIELD SURVEY.

4	FOR TENDER	2018/08/16
3	REVIEW	2018/08/10
2	100% REVIEW	2017/11/30
1	INSULATED PANEL ORDER	

Revision/Revision	Description/Description	Date/Date
-------------------	-------------------------	-----------

Client/Client
**FISHERIES AND OCEANS,
REAL PROPERTY,
SAFETY AND SECURITY**

**VANCOUVER, BC
200-401 BURRARD ST.**

Project title/Titre du projet
**CENTER FOR
AQUACULTURE &
ENVIRONMENTAL
RESEARCH**

NEW & RENOVATED LABS
4160 Marine Dr, West Vancouver

Consultant Signature Box Only

Designed by/Concept par
HV

Drawn by/Dessiné par
SG

PWGSC Project Manager/Administrateur de Projets TPSGC
--

PWGSC, Regional Manager, Architectural and Engineering Services/
Gestionnaire régionale, Services d'architecture et de génie, TPSGC
PREETIPAL PAUL

Drawing title/Titre du dessin

**SITE PLAN
AND SERVICING**

Project No./No. du projet	Sheet/ Feuille	Revision no./ La Révision no.
-	C1.0 OF	4

